


ASIAN HEALTH & SERVICE CENTER

SE 91ST AVE & SE FOSTER RD,
PORTLAND OR 97266

JOB NO. 15043.00

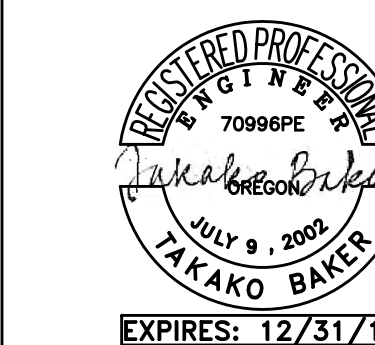

M F A Consulting Engineers
2007 S.E. Ash St.
Portland, OR 97214
PHN: (503) 234-0548
FAX: (503) 234-0877
WWW.MFIA-ENG.COM
CONTACT: TAKAKO BAKER

PERMIT SET

Issue:	date:
100% SD	10.15.15
50% DD	12.09.15
100% DD	02.05.16
50% CD	03.30.16
75% CD	04.27.16
PERMIT SET	07.22.16


revision:	date:
1 PERMIT REV (ADD 1)	01.24.17
2 PERMIT REV 2	02.09.17
3 PERMIT REV 3	03.08.17
4 CONST SET REV 4	03.31.17

title:

FIRST FLOOR MECHANICAL PLAN

sheet:

M2.01

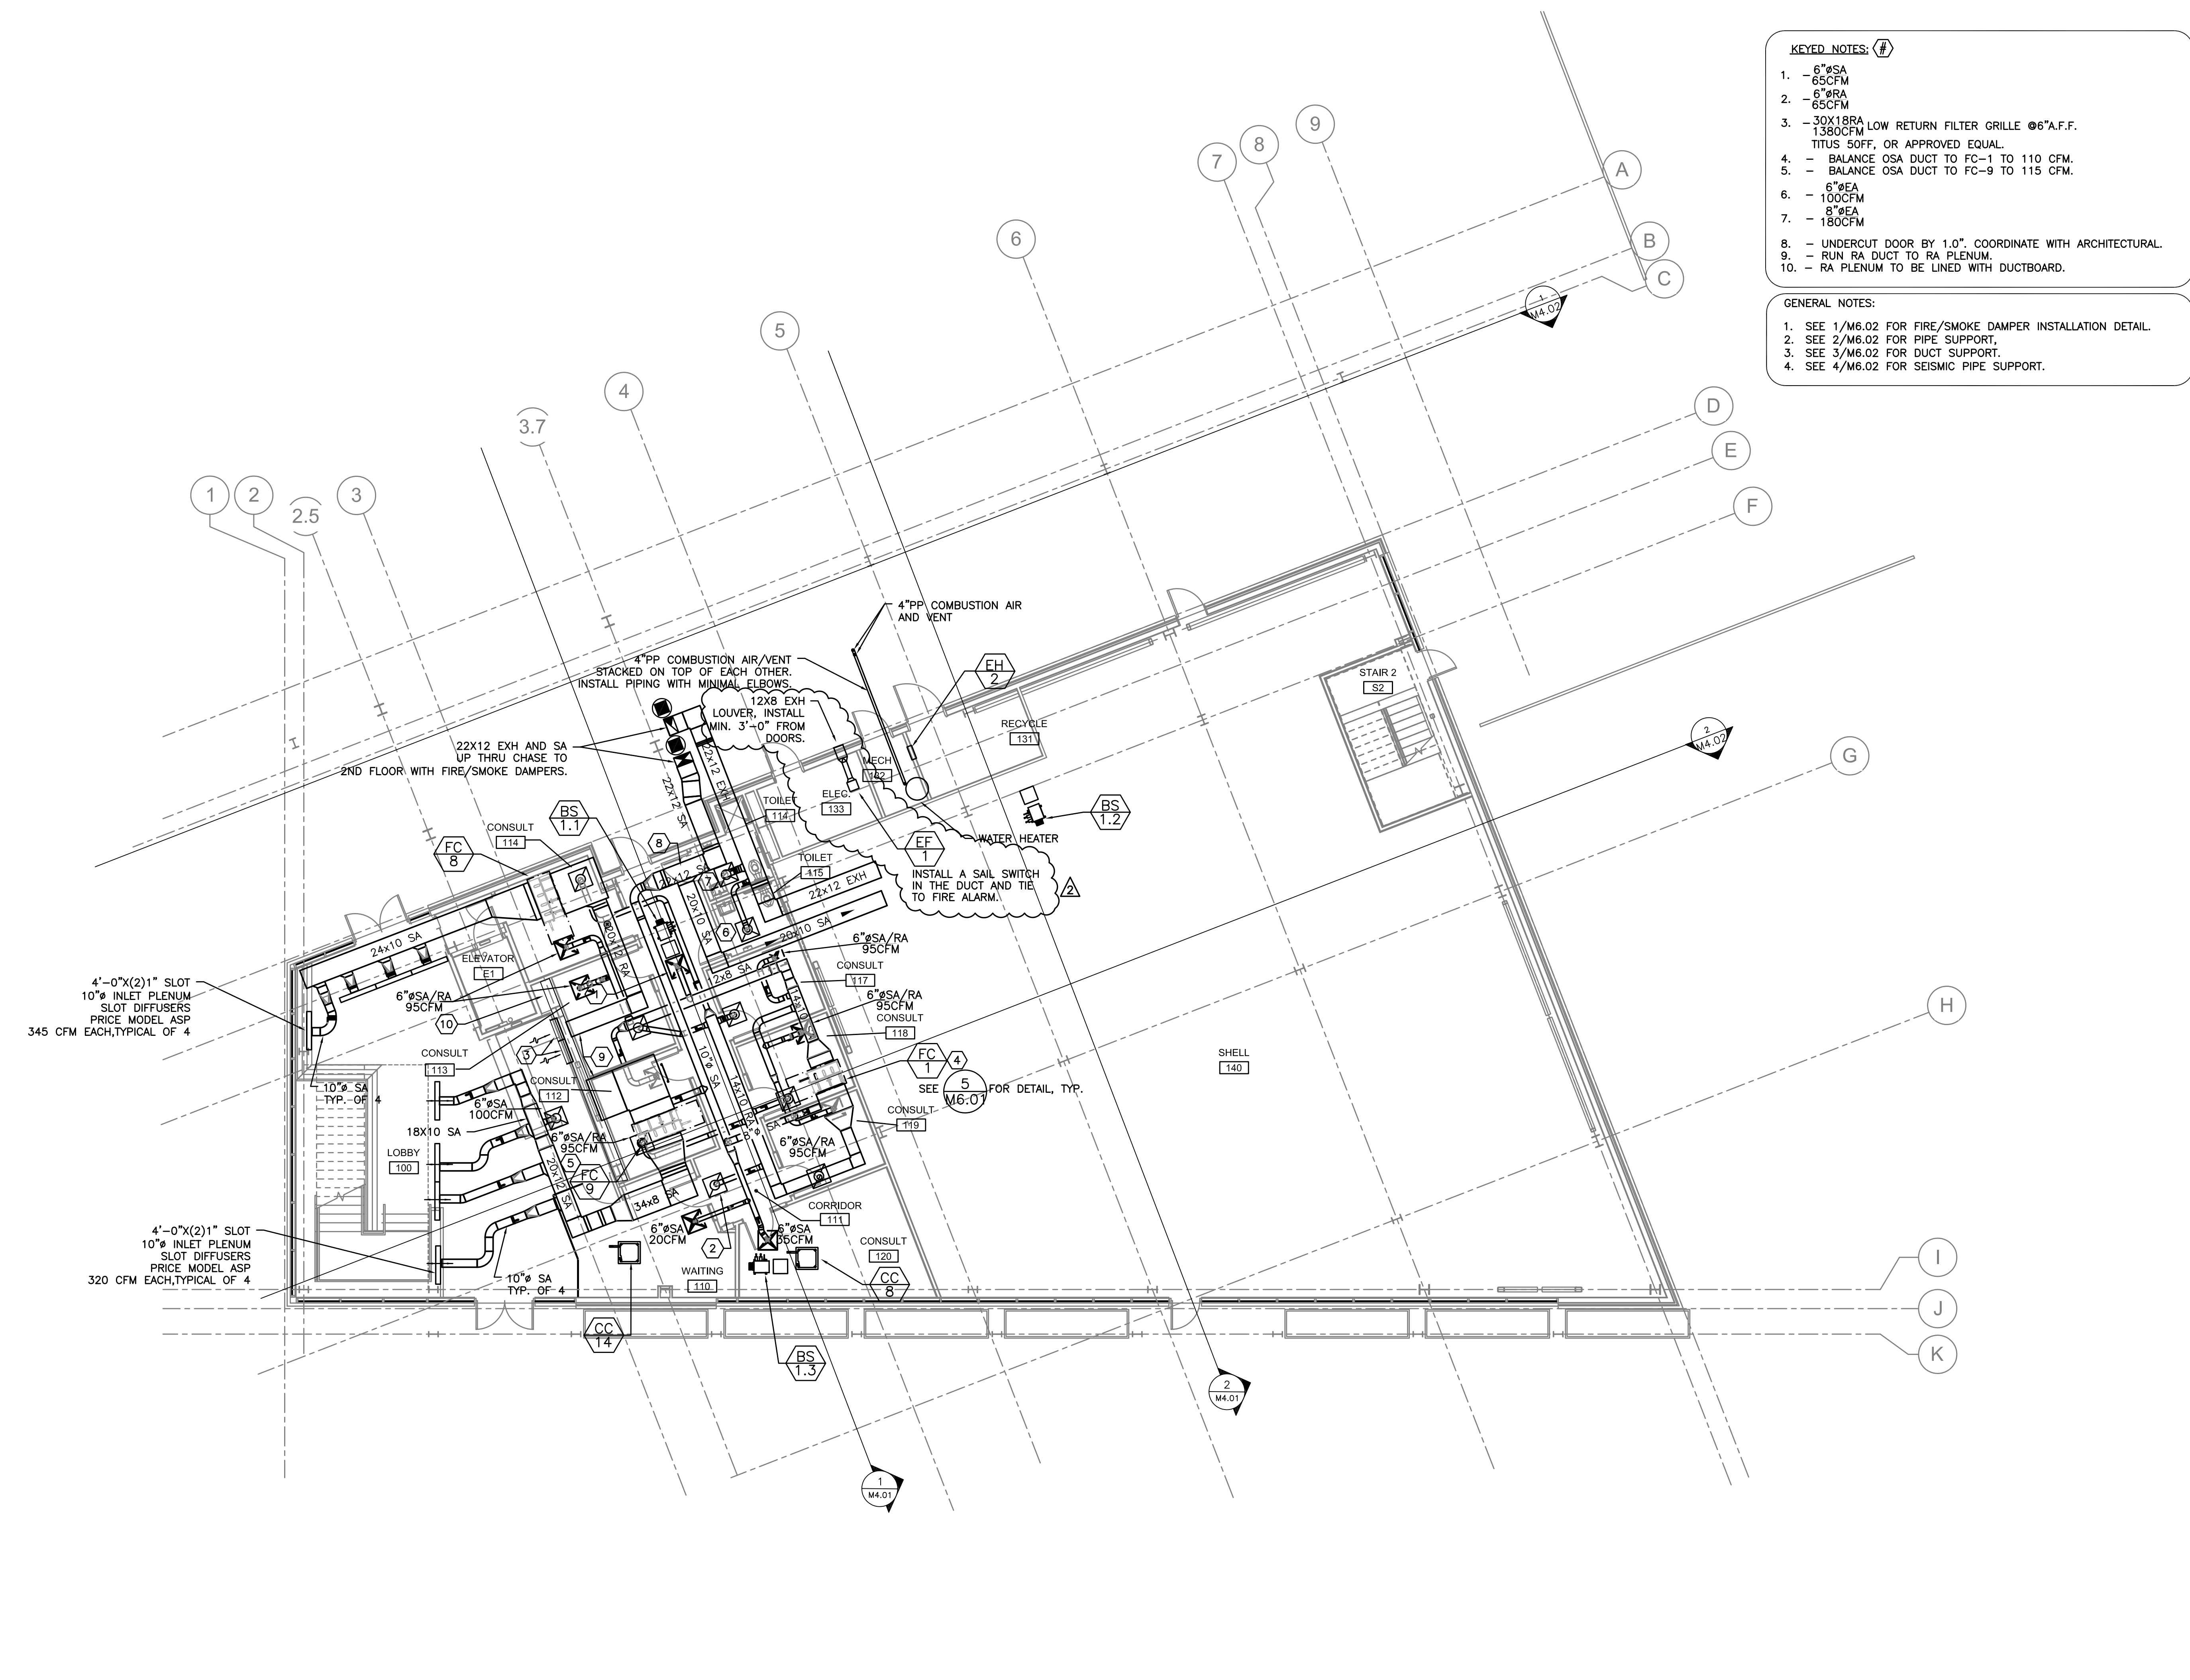

- KEYED NOTES: (#)**
- 6" SA 65CFM
 - 6" RA 65CFM
 - 30X18RA 1350CFM LOW RETURN FILTER GRILLE @6"A.F.F. TITUS SOFF, OR APPROVED EQUAL.
 - BALANCE OSA DUCT TO FC-1 TO 110 CFM.
 - BALANCE OSA DUCT TO FC-9 TO 115 CFM.
 - 6" EA 100CFM
 - 8" EA 180CFM
 - UNDERCUT DOOR BY 1.0". COORDINATE WITH ARCHITECTURAL.
 - RUN RA DUCT TO RA PLENUM.
 - RA PLENUM TO BE LINED WITH DUCTBOARD.

- GENERAL NOTES:**
- SEE 1/M6.02 FOR FIRE/SMOKE DAMPER INSTALLATION DETAIL.
 - SEE 2/M6.02 FOR PIPE SUPPORT.
 - SEE 3/M6.02 FOR DUCT SUPPORT.
 - SEE 4/M6.02 FOR SEISMIC PIPE SUPPORT.

PROJECT NORTH
1 FIRST FLOOR MECHANICAL PLAN
SCALE: 1/8" = 1'-0"
M2.01