


ASIAN HEALTH & SERVICE CENTER

SE 91ST AVE & SE FOSTER RD,
PORTLAND OR 97266

JOB NO. 15043.00

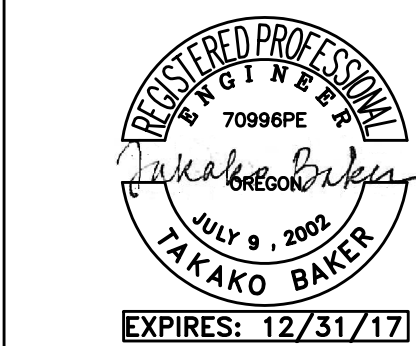

MEI Consulting Engineers
2007 S.E. Ash St.
Portland, OR 97214
PH: (503) 234-0548
FAX: (503) 234-0877
INC. WWW.MEIA-ENG.COM
CONTACT: TAKAKO BAKER

PERMIT SET

07.22.2016

issue:	date:
100% SD	10.15.15
50% DD	12.09.15
100% DD	02.05.16
50% CD	03.30.16
75% CD	04.27.16
PERMIT SET	07.22.16


revision:	date:
1 PERMIT REV (ADD 1)	01.24.17
2 PERMIT REV 2	02.09.17
3 PERMIT REV 3	03.08.17
4 CONST SET REV 4	03.31.17

title:

SECOND FLOOR CD PIPING PLAN

sheet:

P3.02

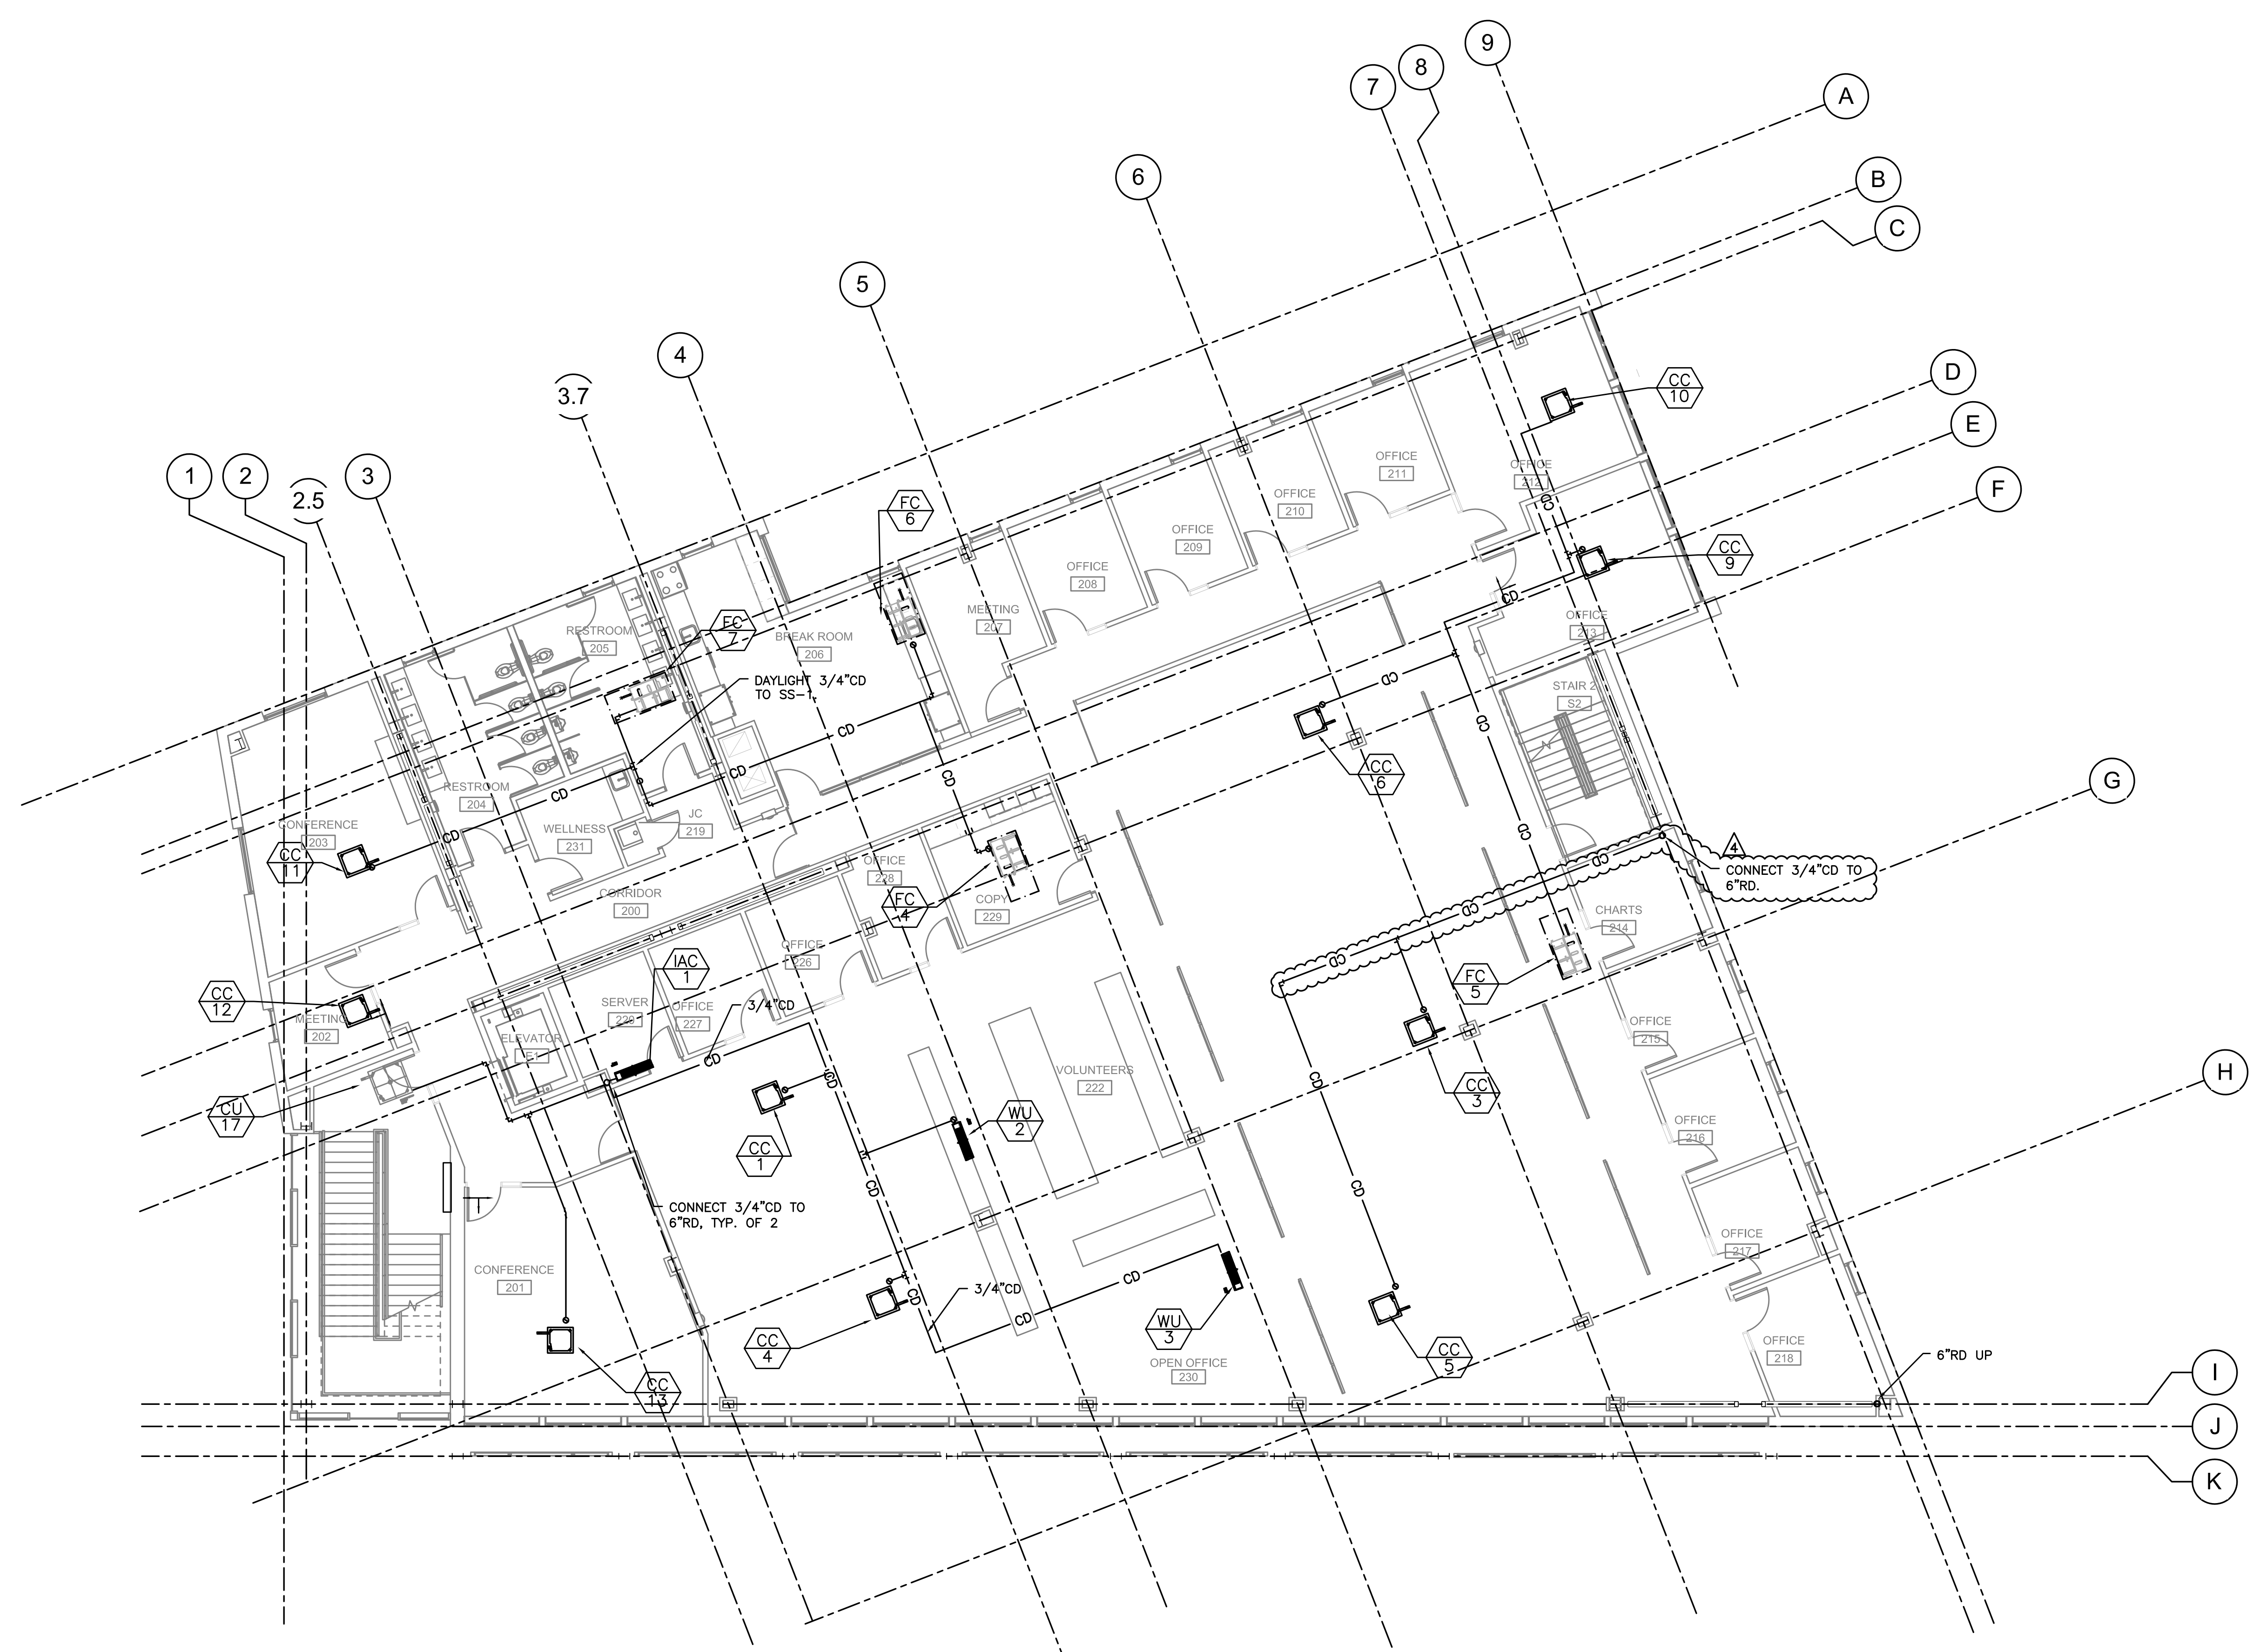

PROJECT NORTH
1 SECOND FLOOR CD PIPING PLAN
SCALE: 1/8" = 1'-0"