


**ASIAN HEALTH & SERVICE CENTER**

SE 91ST AVE & SE FOSTER RD,  
PORTLAND OR 97266

JOB NO. 15043.00

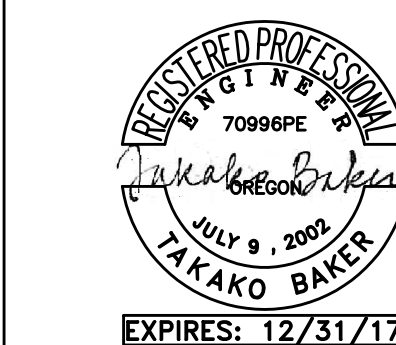

**MFA** Consulting Engineers  
2007 S.E. Ash St.  
Portland, OR 97214  
PH: (503) 234-0548  
FAX: (503) 234-0677  
CONTACT: TAKAKO BAKER

**PERMIT SET**

07.22.2016

| issue:     | date:    |
|------------|----------|
| 100% SD    | 10.15.15 |
| 50% DD     | 12.09.15 |
| 100% DD    | 02.05.16 |
| 50% CD     | 03.30.16 |
| 75% CD     | 04.27.16 |
| PERMIT SET | 07.22.16 |


| revision:            | date:    |
|----------------------|----------|
| 1 PERMIT REV (ADD 1) | 01.24.17 |
| 2 PERMIT REV 2       | 02.09.17 |
| 3 PERMIT REV 3       | 03.08.17 |
| 4 CONST SET REV 4    | 03.31.17 |

title:

**THIRD FLOOR CD PIPING PLAN**

sheet:

**P3.03**

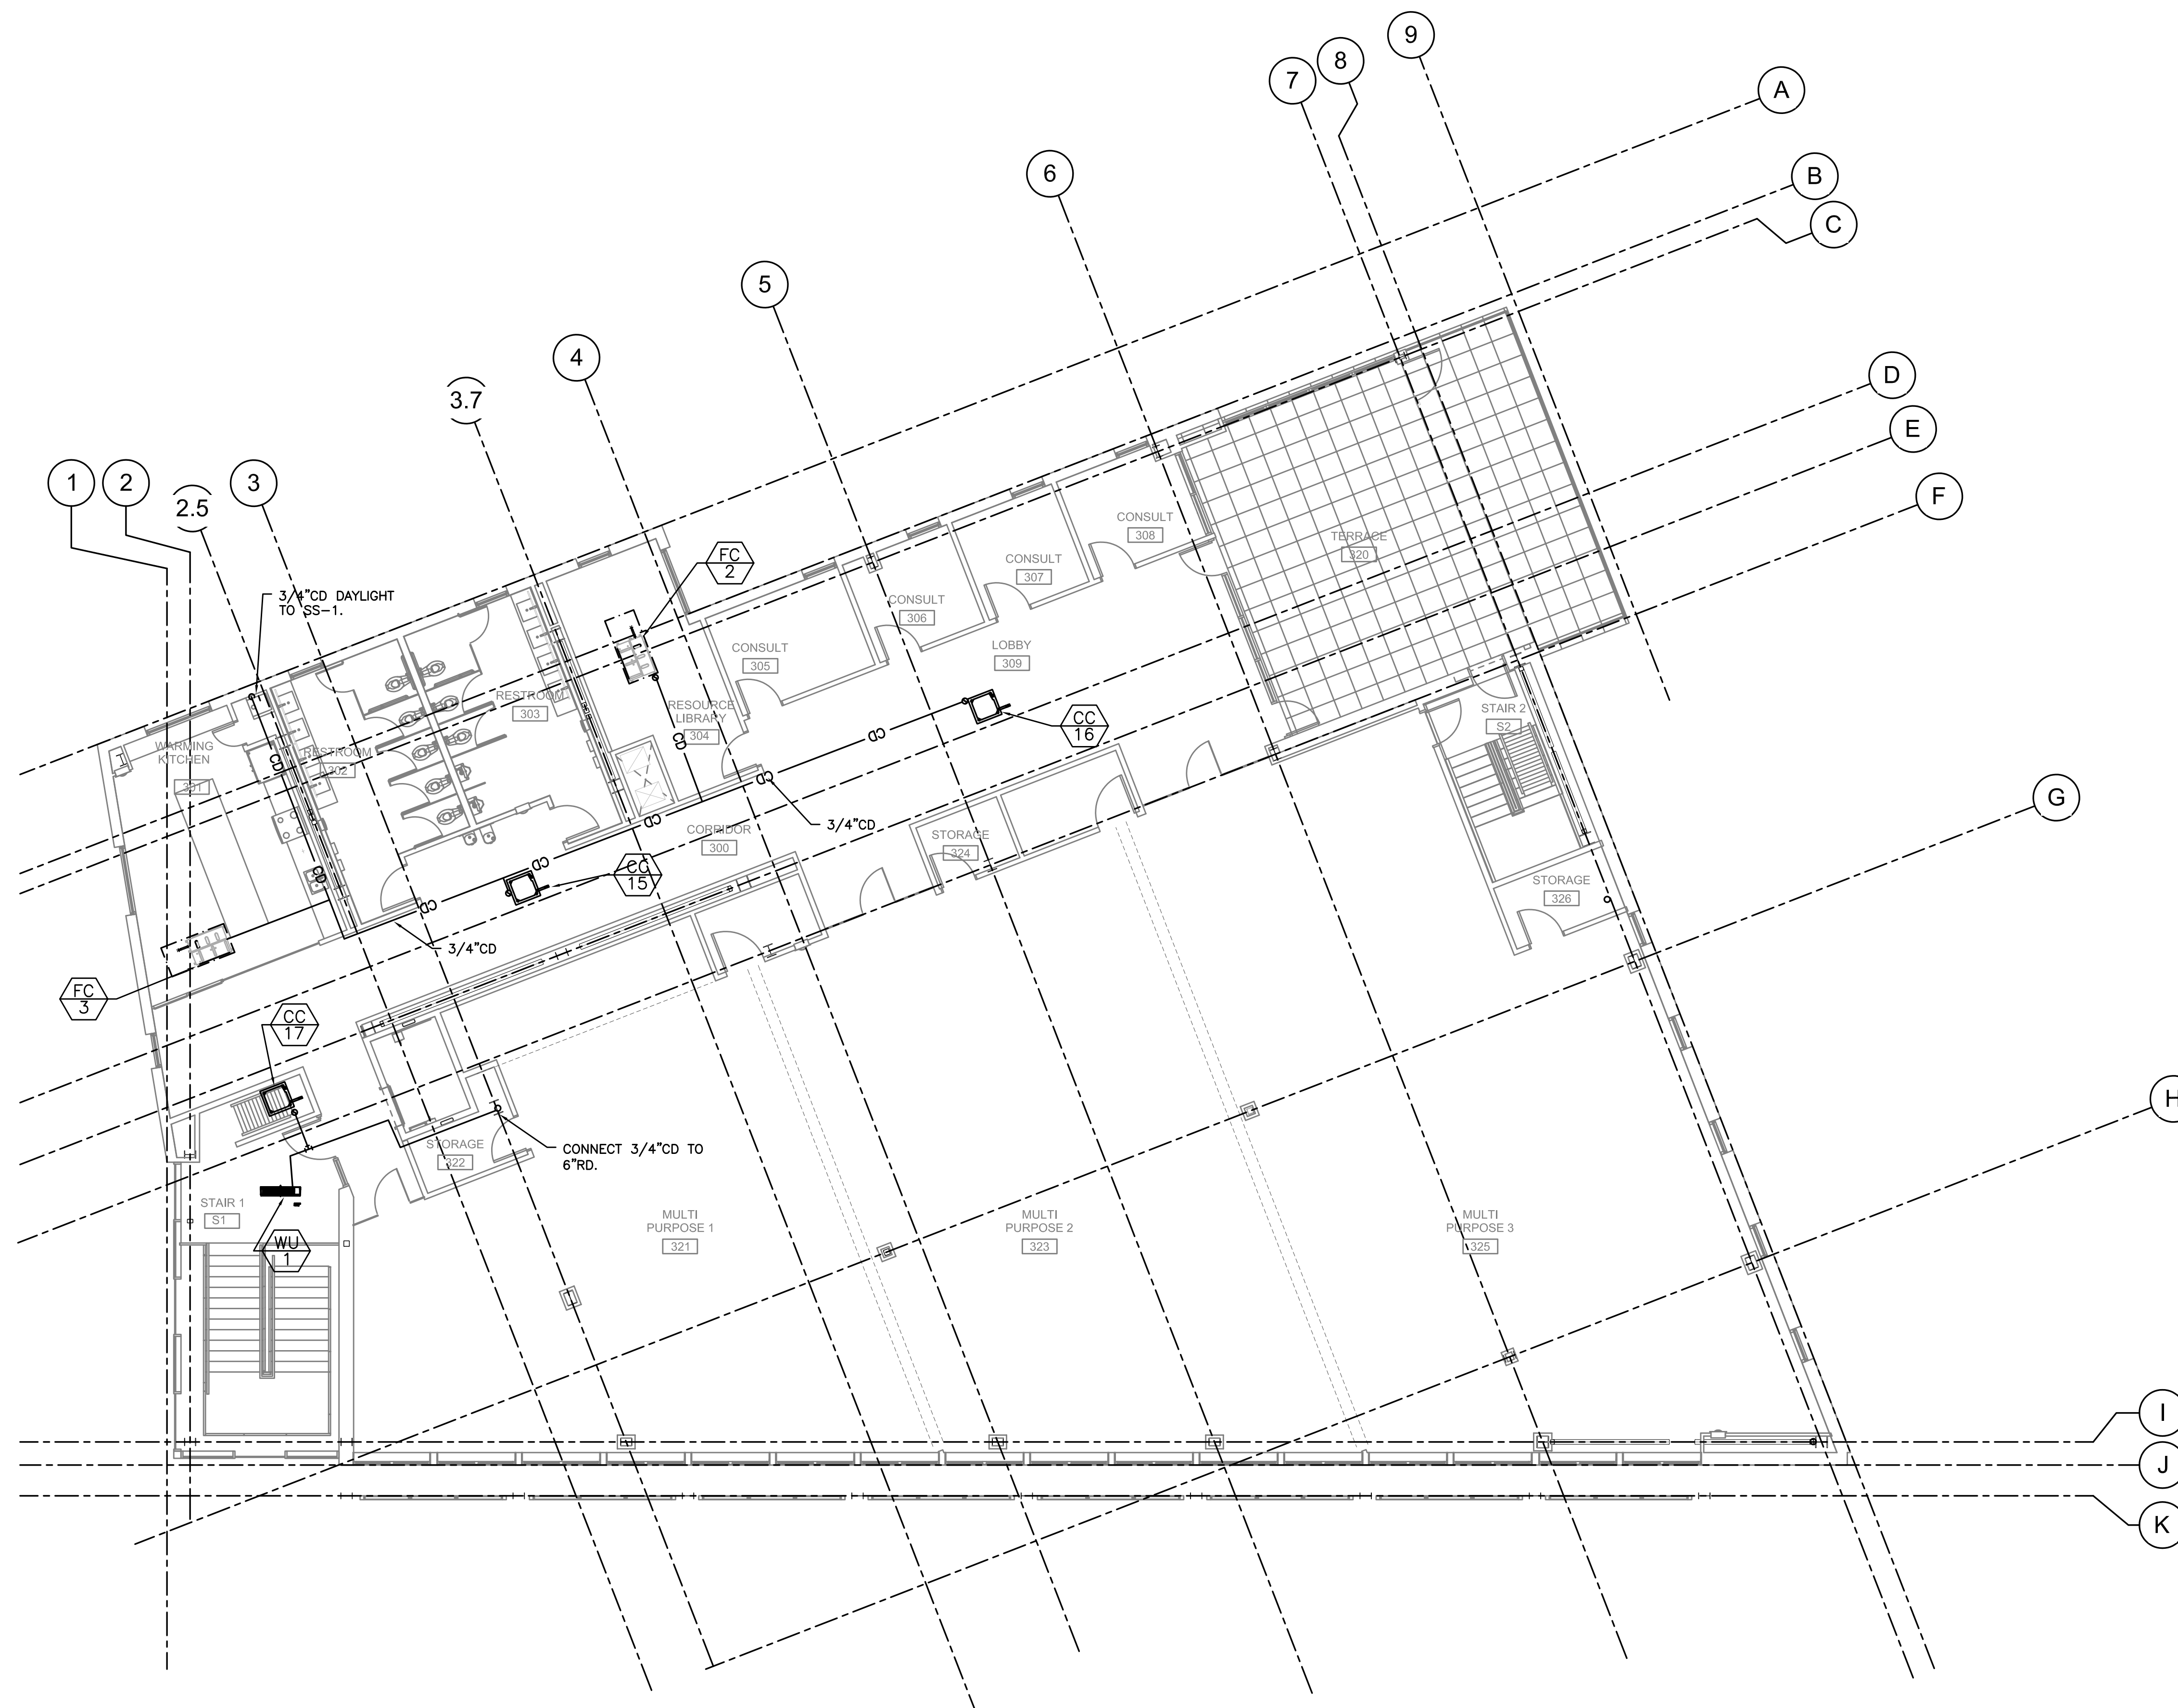

PROJECT NORTH  
1 THIRD FLOOR CD PIPING PLAN  
M3.03 SCALE: 1/8" = 1'-0"