


Copyright protected. See Design Agreement. For use on this project only. Unauthorized reproduction of any part of this material is prohibited.

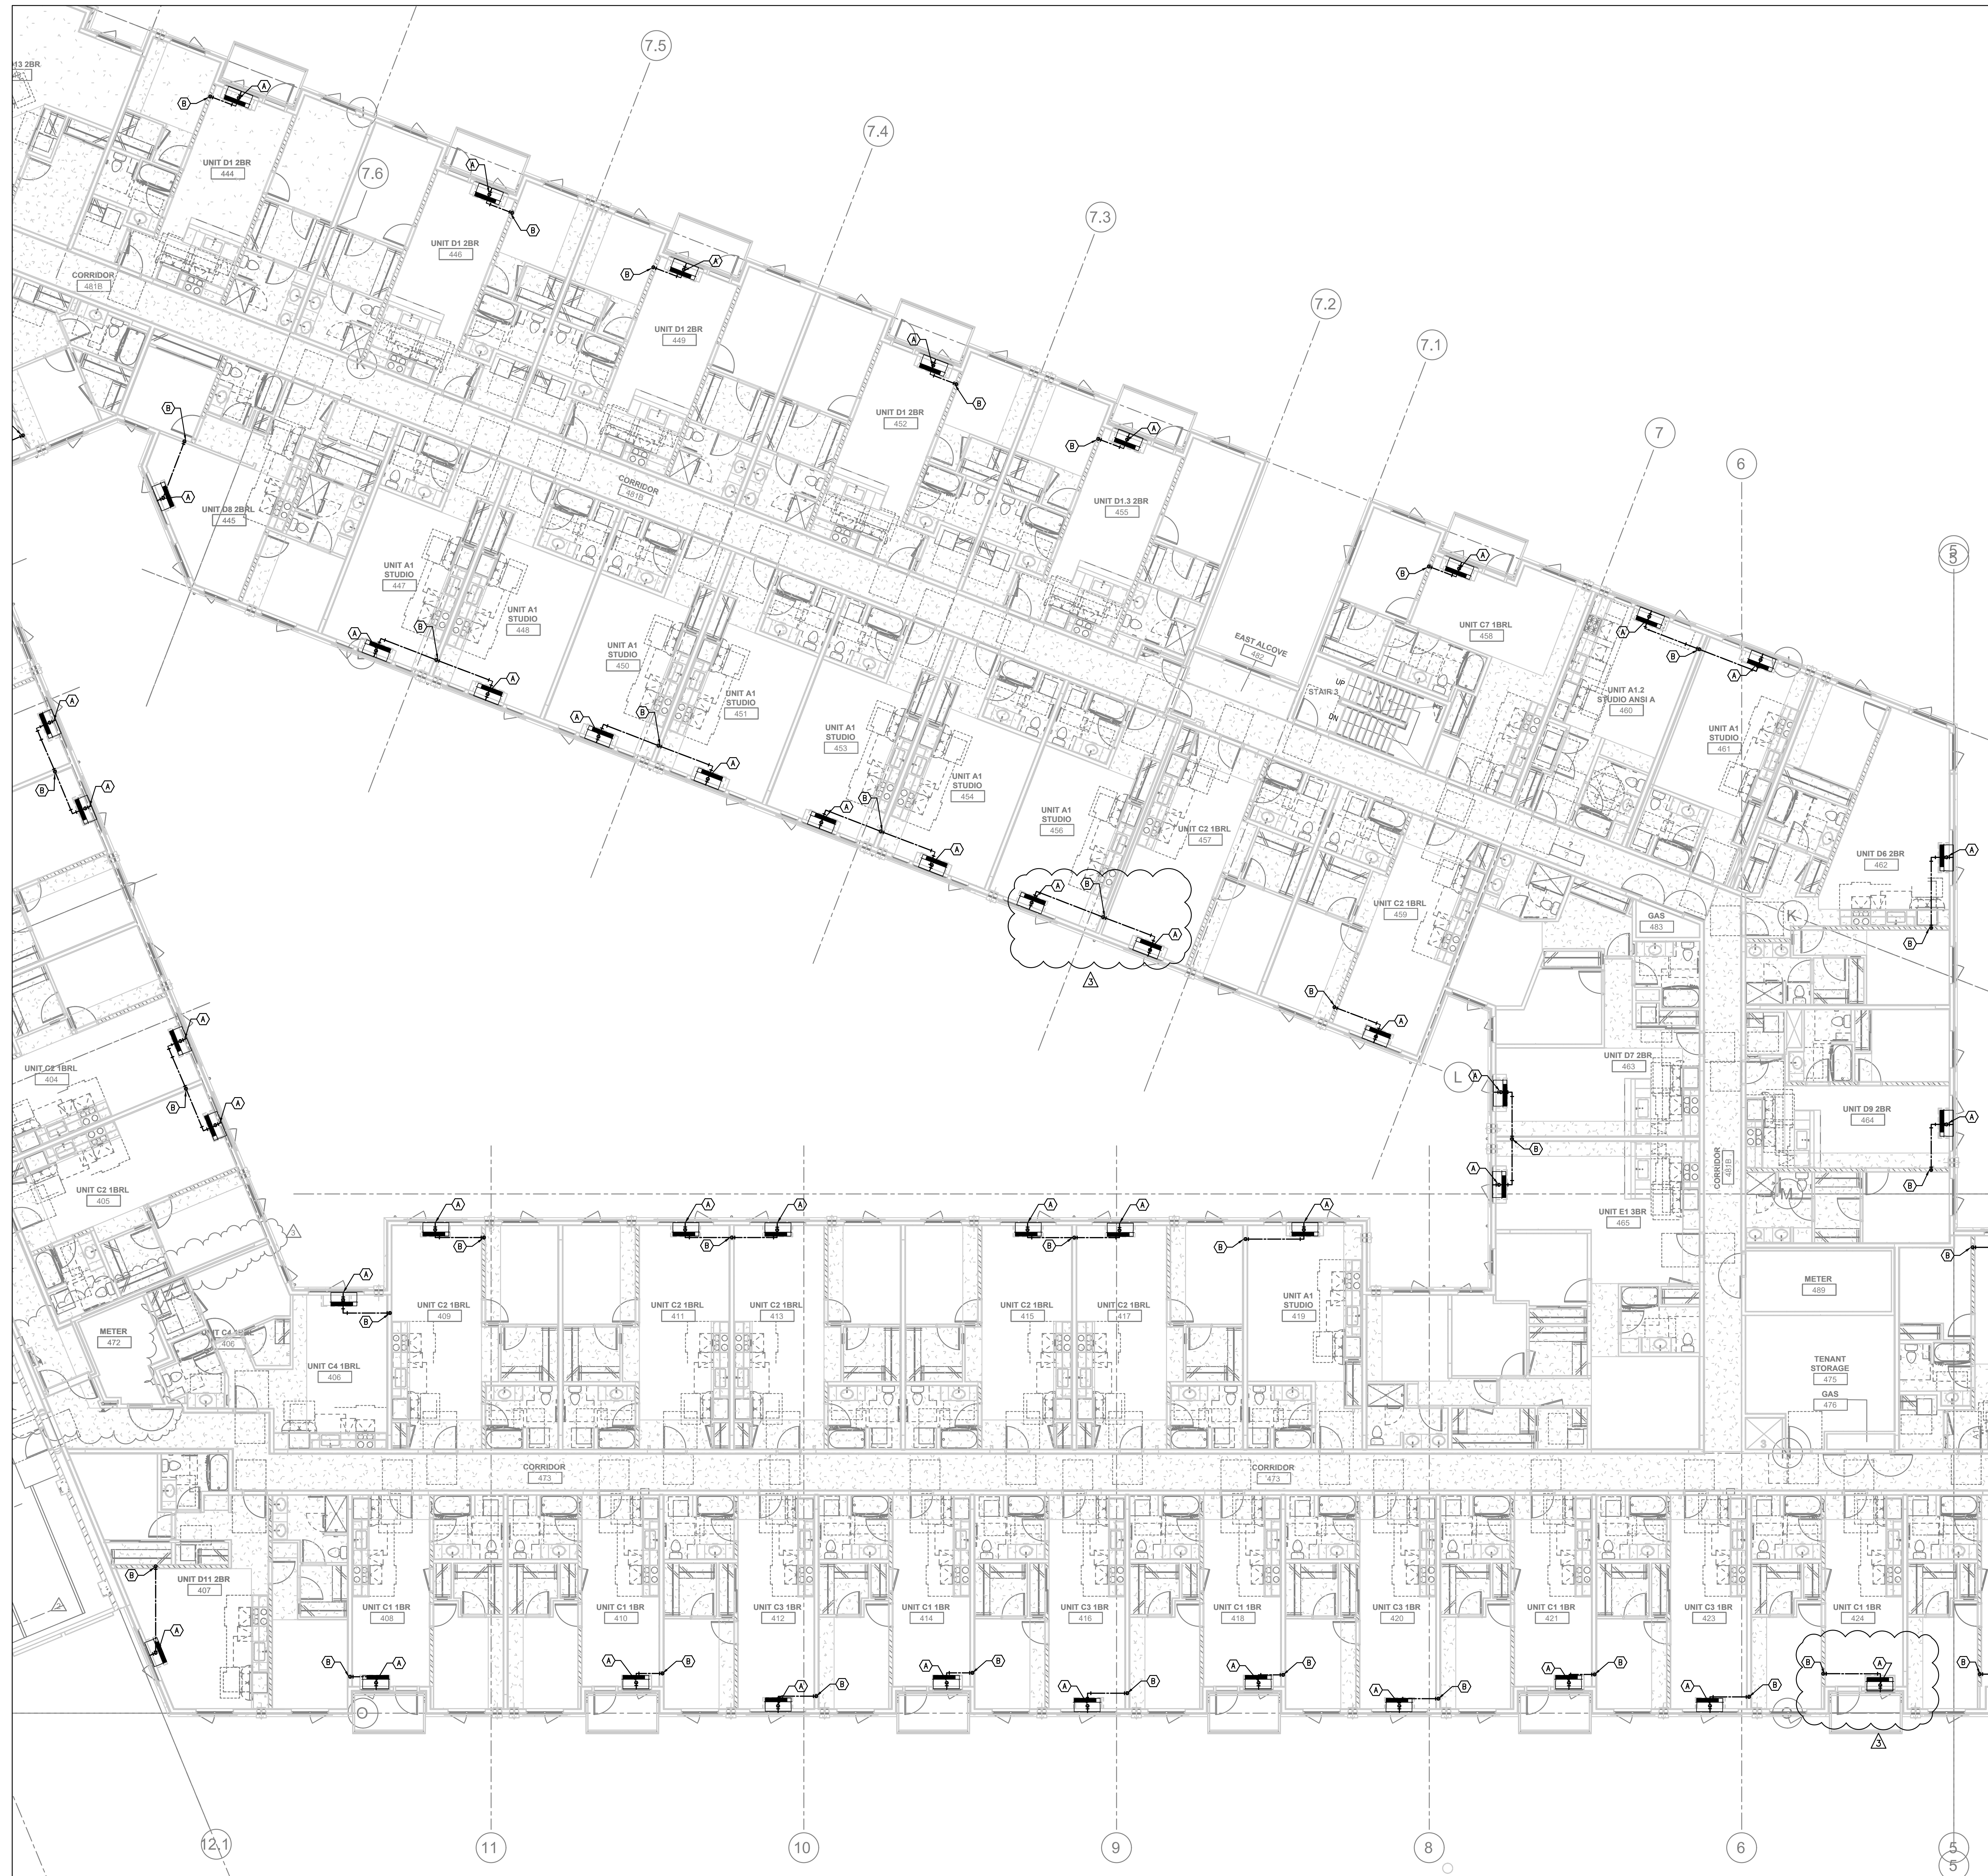

- GENERAL NOTES:**
- (A) — 3/4" CONDENSATE DRAIN FROM PTHP ROUTED DOWN THRU FLOOR ASSEMBLY
  - (B) — 1" CONDENSATE DRAIN RISER DOWN IN INTERIOR WALL TO FIRST FLOOR CEILING SPACE. SEE NOTE 1.
  - (C) — 3/4" CONDENSATE FROM FAN COIL ROUTED THROUGH JOISTS TO CD RISER IN INTERIOR
  - (D) — GROUND FLOOR PTHPS ON PATIOS: —ROUTE CONDENSATE DRAIN OUT BELOW THE PTHP, ELBOW DOWN AND DAYLIGHT TO DRY WELL/OPENING IN PATIO
  - (E) — GROUND FLOOR PTHPS WITHOUT PATIOS: — CONDENSATE TO DRAIN OUT FACE OF PTHP TO LANDSCAPING.
  - (F) — ROUTE CONDENSATE RISER HORIZONTALLY IN 1ST FLOOR CEILING SPACE TO EXTERIOR WALL, ROUTE DOWN IN WALL AND OUT TO LANDSCAPING WITH ELBOW DOWN — CONTRACTOR TO FIELD VERIFY EXACT ROUTING.

**SERA**  
 ARCHITECTURE  
 URBAN DESIGN + PLANNING  
 INTERIOR DESIGN

PORTLAND/OAKLAND  
 SERADESIGN.COM

7-22-22

REGISTERED PROFESSIONAL ENGINEER  
 STATE OF OREGON  
 NO. 44,507  
 MARK DENYER  
 EXPIRES: 31DEC23

Consulting Engineers  
 2007 S.E. Ash St.  
 Portland, OR 97214  
 PHN: (503) 234-0548  
 FAX: (503) 234-0577  
 WWW.MFI-INC.COM  
 CONTACT: MARK DENYER

**JACOBS**

**MODERA BEAVERTON**  
 1220 S.W. BEAVERTON WAY, ST  
 BEAVERTON, OR 97005

REVISIONS

1	AB 01	22 AUG 2022
2	AB 02	18 SEP 2022
3	AB 03	4 NOV 2022

CHECKED BY: [signature] -checker  
 ISSUE DATE: 25 JULY 2022  
 PROJECT NO: 2103053

CONDENSATE FLOOR PLAN - LEVEL 04B  
**M304B**  
 PERMIT SET

**1** CONDENSATE FLOOR PLAN - LEVEL 04B  
 M304B SCALE: 1/8" = 1'-0"

SERA Design and Architecture, Inc.