


Copyright protected. See Design Agreement. For use on this project only. Unauthorized reproduction of any part of this material is prohibited.

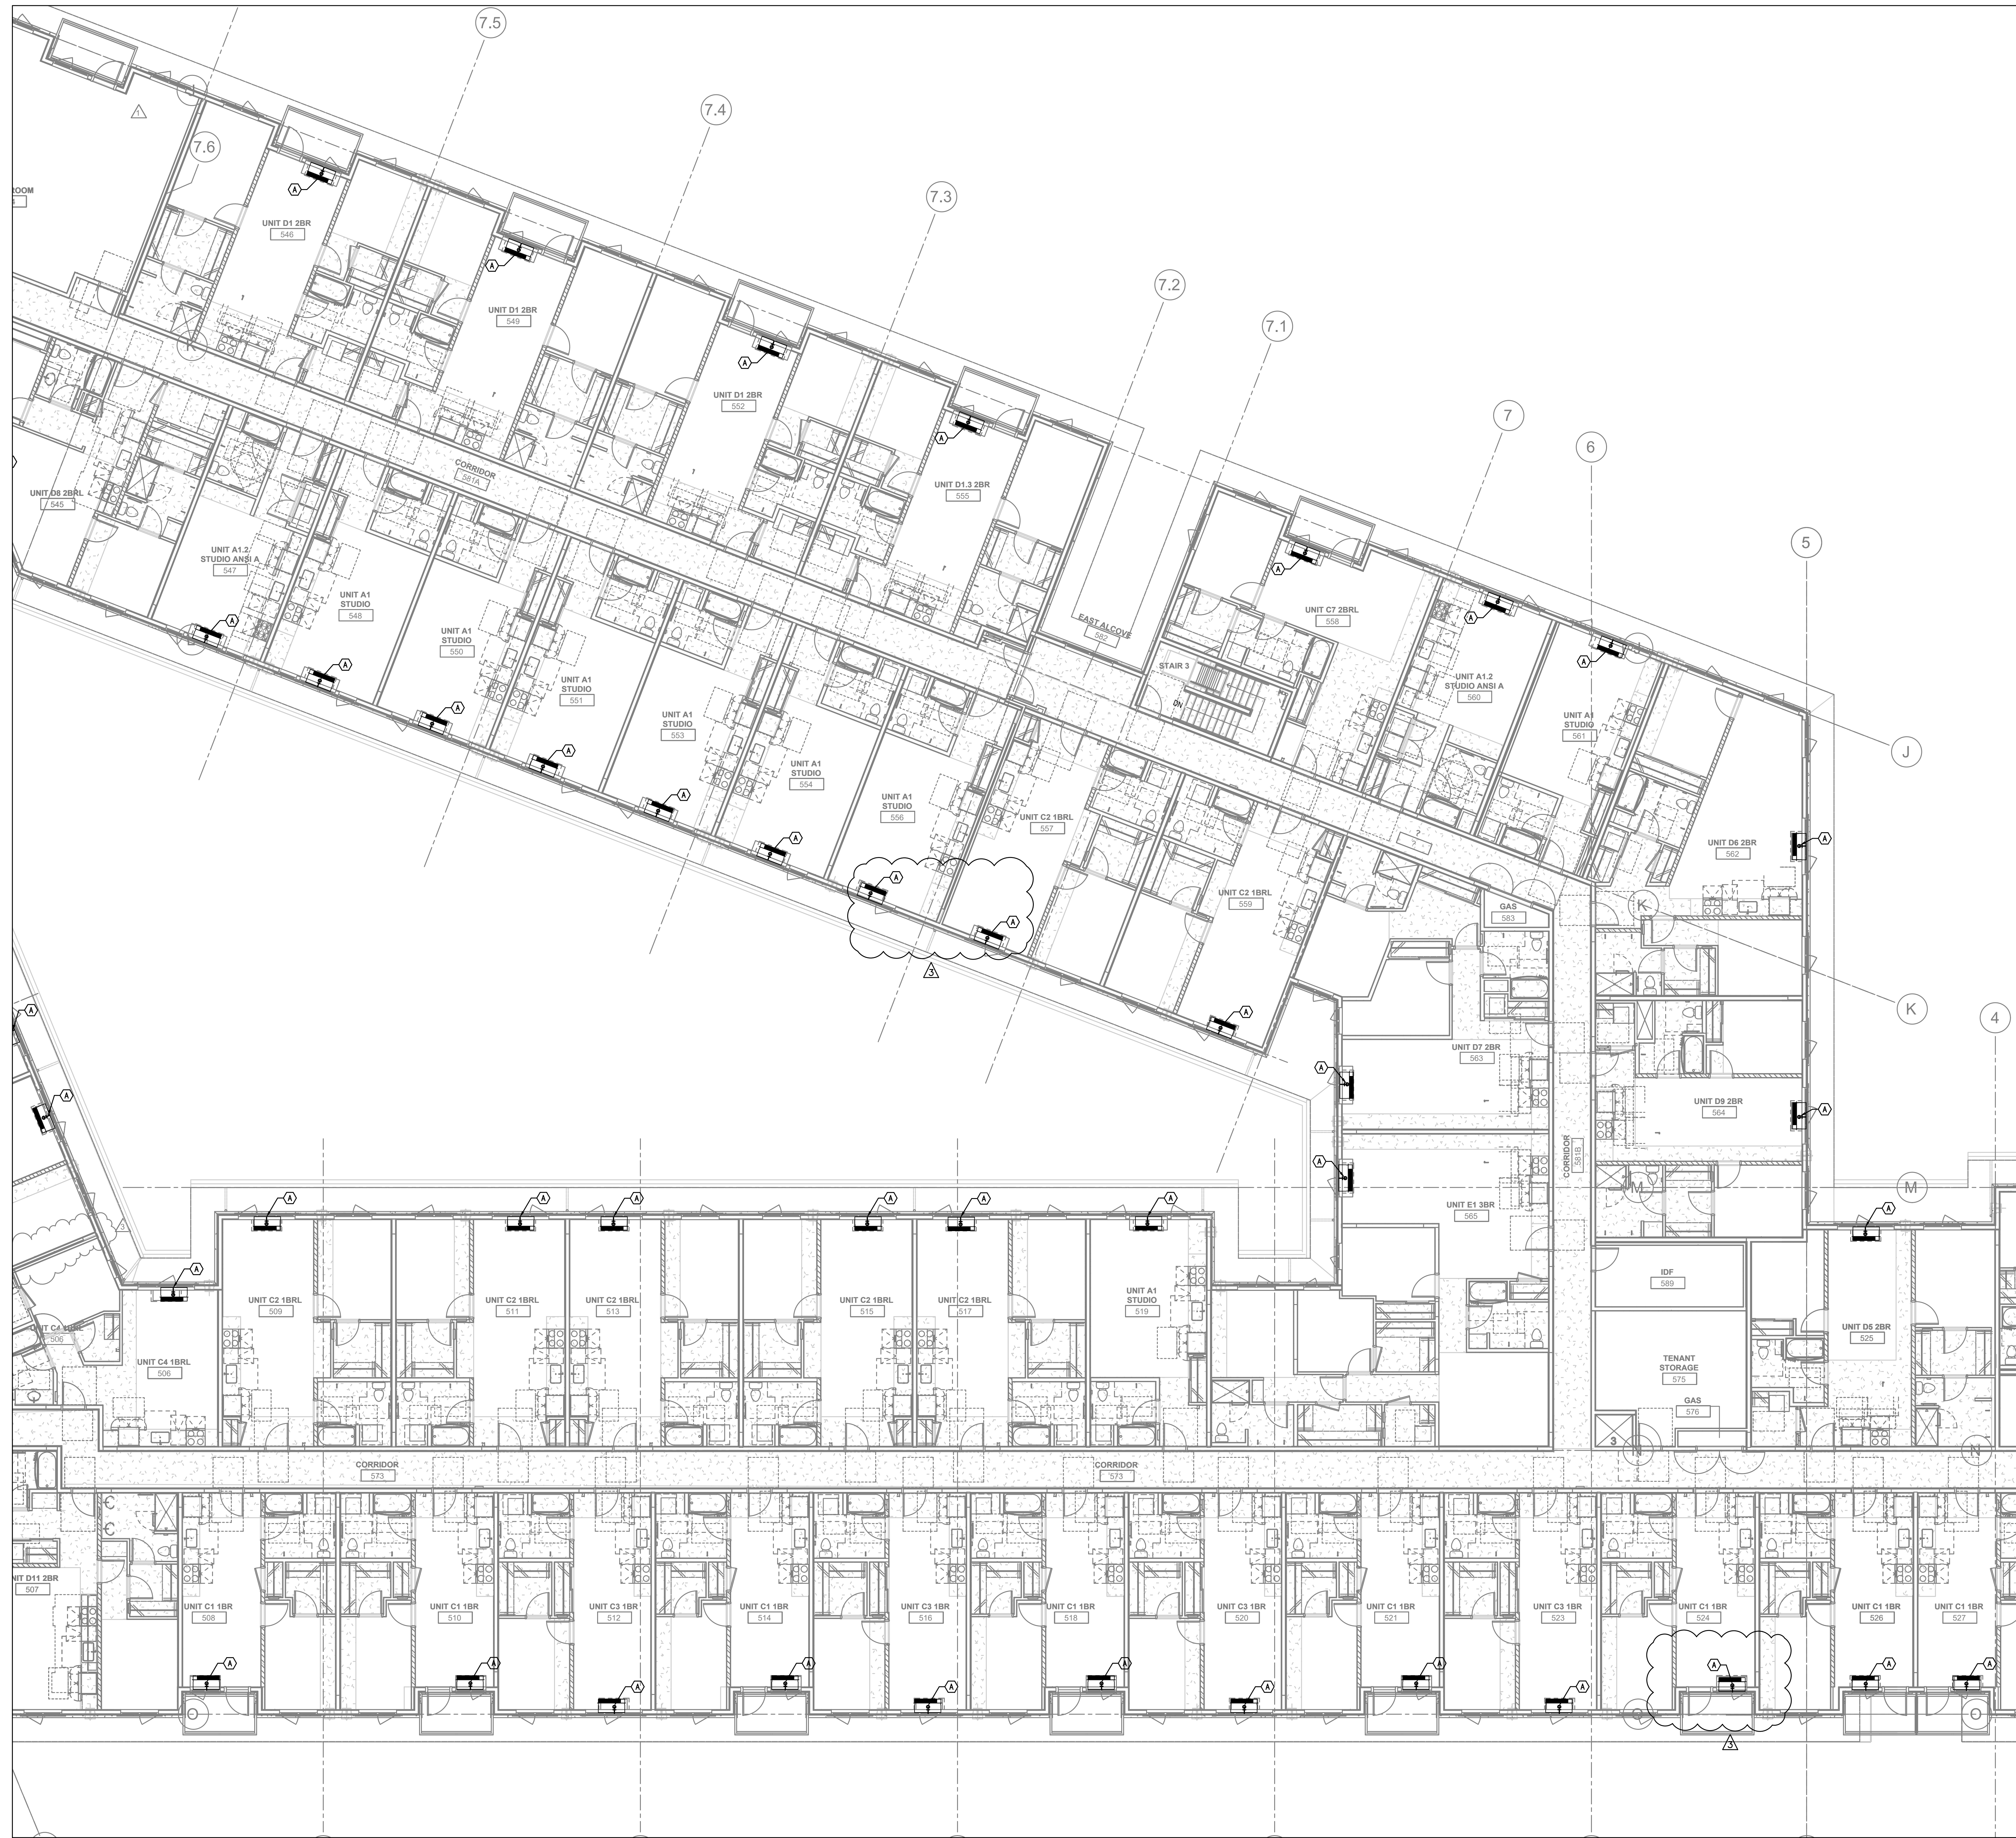

- GENERAL NOTES:**
- (A) — 3/4" CONDENSATE DRAIN FROM PTHP ROUTED DOWN THRU FLOOR ASSEMBLY
 - (B) — 1" CONDENSATE DRAIN RISER DOWN IN INTERIOR WALL TO FIRST FLOOR CEILING SPACE SEE NOTE 1.
 - (C) — 3/4" CONDENSATE FROM FAN COIL ROUTED THROUGH JOISTS TO CD RISER IN INTERIOR
 - (D) — GROUND FLOOR PTHPS ON PATIOS: -ROUTE CONDENSATE DRAIN OUT BELOW THE PTHP, ELBOW DOWN AND DAYLIGHT TO DRY WELL/OPENING IN PATIO
 - (E) — GROUND FLOOR PTHPS WITHOUT PATIOS: - CONDENSATE TO DRAIN OUT FACE OF PTHP TO LANDSCAPING.
 - (F) — ROUTE CONDENSATE RISER HORIZONTALLY IN 1ST FLOOR CEILING SPACE TO EXTERIOR WALL, ROUTE DOWN IN WALL AND OUT TO LANDSCAPING WITH ELBOW DOWN - - CONTRACTOR TO FIELD VERIFY EXACT ROUTING.

SERA
 ARCHITECTURE
 URBAN DESIGN + PLANNING
 INTERIOR DESIGN

PORTLAND/OAKLAND
 SERADESIGN.COM

7-22-22

MARK DENYER ARCHITECTS
 84,507
 2000
 1111 11th Ave
 SUITE 11, 2000
 (EXPIRES: 31DEC23)

Consulting Engineers
 2007 S.E. Ash St.
 Portland, OR 97214
 PHN: (503) 234-0548
 FAX: (503) 234-0577
 WWW.MFA-SNG.COM
 CONTACT: MARK DENYER



MODERA BEAVERTON
 1220 S.W. BEAVERTON WAY, ST
 BEAVERTON, OR 97005

REVISIONS

1	AB 01	22 AUG 2022
2	AB 02	19 SEP 2022
3	AB 03	4 NOV 2022

CHECKED BY: <checker>
 ISSUE DATE: 25 JULY 2022
 PROJECT NO: 2103053

CONDENSATE FLOOR PLAN -LEVEL 05B
M305B
 PERMIT SET

1 CONDENSATE FLOOR PLAN - LEVEL 05B
 M305B SCALE: 1/8" = 1'-0"

SERA Design and Architecture, Inc.