


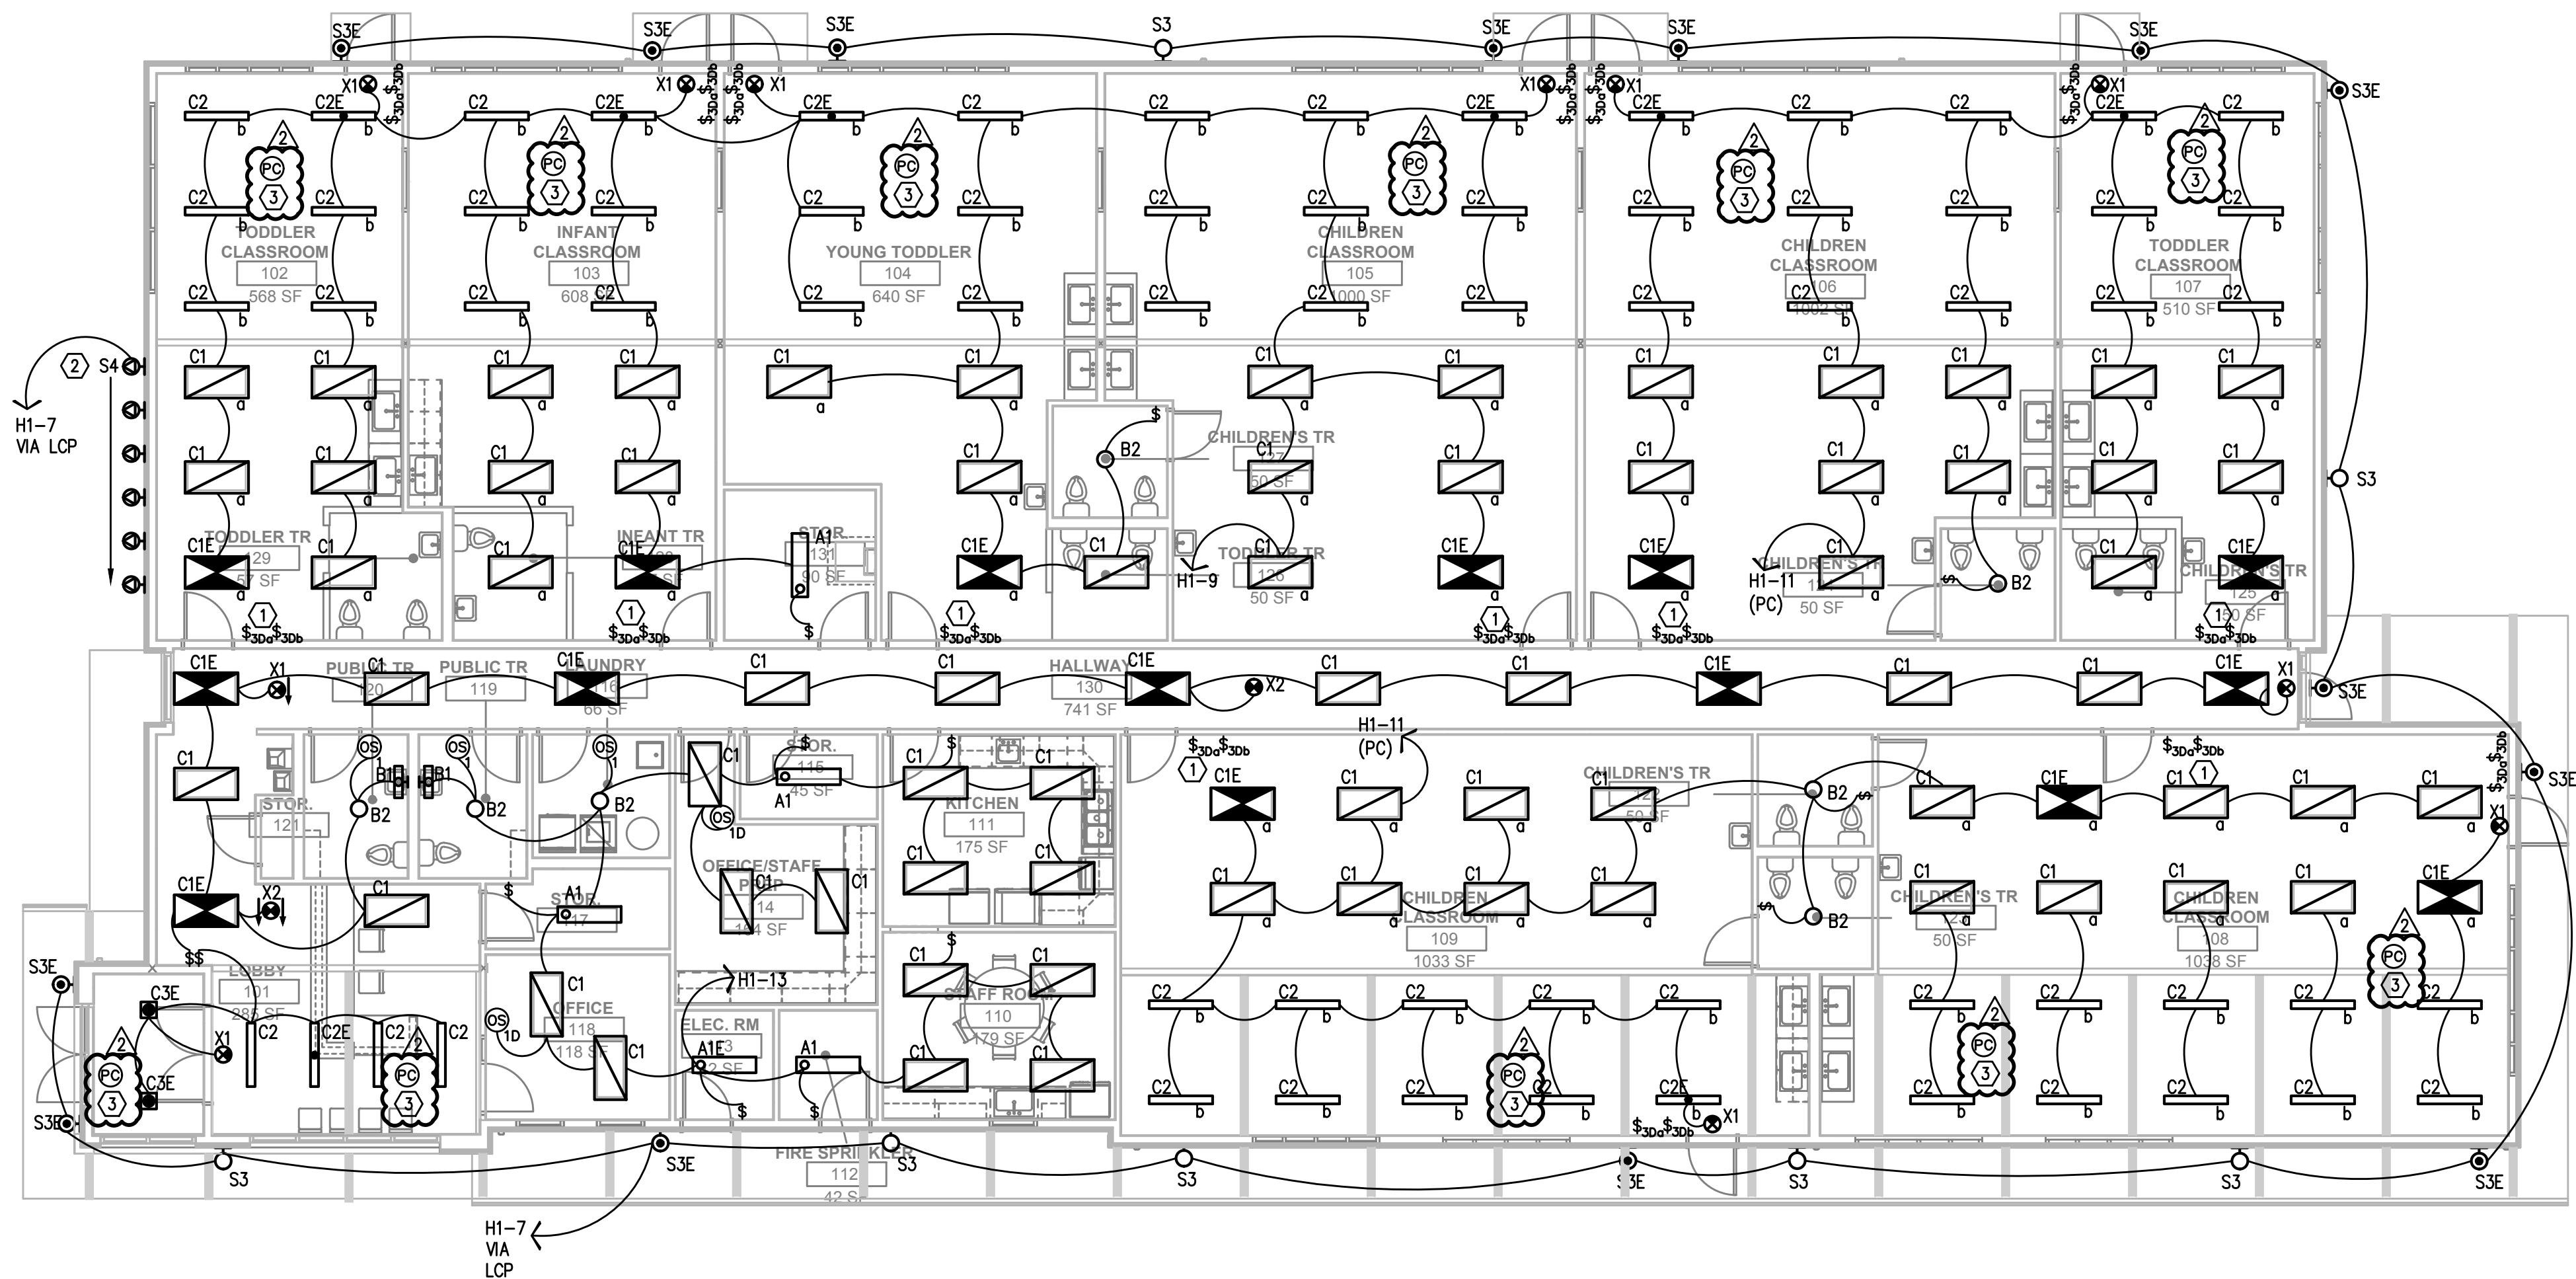

- GENERAL LIGHTING NOTES:
- A. ELECTRICAL DRAWINGS ARE DIAGRAMMATICAL AND MAY NOT ACCURATELY REFLECT ACTUAL CONSTRUCTION CONDITIONS. THE ELECTRICAL CONTRACTOR SHALL BE RESPONSIBLE FOR COORDINATING THE INSTALLATION OF ALL ELECTRICAL EQUIPMENT, WITH ALL TRADES PRIOR TO AND DURING CONSTRUCTION.
 - B. WORK SHALL BE IN ACCORDANCE WITH ALL APPLICABLE LOCAL, STATE AND NATIONAL CODES.
 - C. THE ELECTRICAL CONTRACTOR SHALL REFER TO THE ARCHITECTURAL DRAWINGS FOR ALL MOUNTING HEIGHTS AND FINISHES OF DEVICES AND FIXTURES.
 - D. REFER TO SHEET E1.21 FOR LIGHT FIXTURE SCHEDULE.
 - E. ALL LIGHT SWITCHES SHALL BE ROCKER STYLE, SUCH AS LEVITON DECORA, OR APPROVED EQUAL.
 - F. BUILDING MOUNTED EXTERIOR LIGHTS SHALL BE CIRCUITED FROM THE "HOUSE" BRANCH PANEL, VIA TIME CLOCK UNLESS OTHERWISE NOTED. REFER TO DETAIL 1, SHEET E1.22.
 - G. BUILDING MOUNTED EXTERIOR LIGHTS DESIGNATED AS EGRESS SHALL BE CIRCUITED VIA REMOTE BATTERY BACK-UP. REFER TO DETAIL 2, SHEET E1.21.
 - H. THE ELECTRICAL CONTRACTOR SHALL REFER TO THE MECHANICAL PLAN SHEETS AND COORDINATE WITH THE MECHANICAL INSTALLER TO AVOID CONFLICTS BETWEEN HVAC EQUIPMENT AND LIGHT.
- KEYED NOTES:
- 1. EACH LIGHT FIXTURE IN THIS SPACE, WITH A LOWER CASE LETTER DESIGNATION, TO BE CONTROLLED VIA THE CORRESPONDING LIGHT SWITCH.
 - 2. SIGN LIGHTING FIXTURES TO BE MOUNTED ABOVE SIGN AT 33" APART, CENTERED ON THE WALL. CONSULT WITH THE ARCHITECT AND ARCHITECTURAL ELEVATIONS FOR EXACT MOUNTING HEIGHT AND LOCATIONS, PRIOR TO ROUGH-IN. COORDINATE WORK WITH THE SIGN INSTALLER.
 - 3. LIGHT FIXTURES ADJACENT TO WINDOWS IN THIS SPACE SHALL BE CIRCUITED VIA PHOTOCELL FOR AUTOMATIC DAYLIGHT REDUCTION.

1 LIGHTING PLAN
SCALE: 1/8" = 1'-0"

#	DATE	DESC.
1	12.22.21	ISSUE FOR PERMIT
2	02.16.22	PLAN REVIEW

LIVERMORE ARCHITECTURE & ENGINEERING, INC.
1500 SW First Ave. Suite 240
Portland, Oregon 97201
Phone: 503-892-3002
www.livermoreae.com

Livermore
JOB NO: 221059.00

NEW BUILDING FOR
GUIDEPOST MONTESSORI DAYCARE
SE TUALATIN VALLEY HWY AND SE 70TH AVENUE
HILLSBORO, OREGON

DRAWING TITLE:
ELECTRICAL
POWER PLAN

DRAWN BY: DMT
CHECKED BY: RLC

E2.01

Consulting Engineers
2007 S.E. Ash St.
Portland, OR 97214
PHN: (503) 234-0548
FAX: (503) 234-0877
CONTACT: .