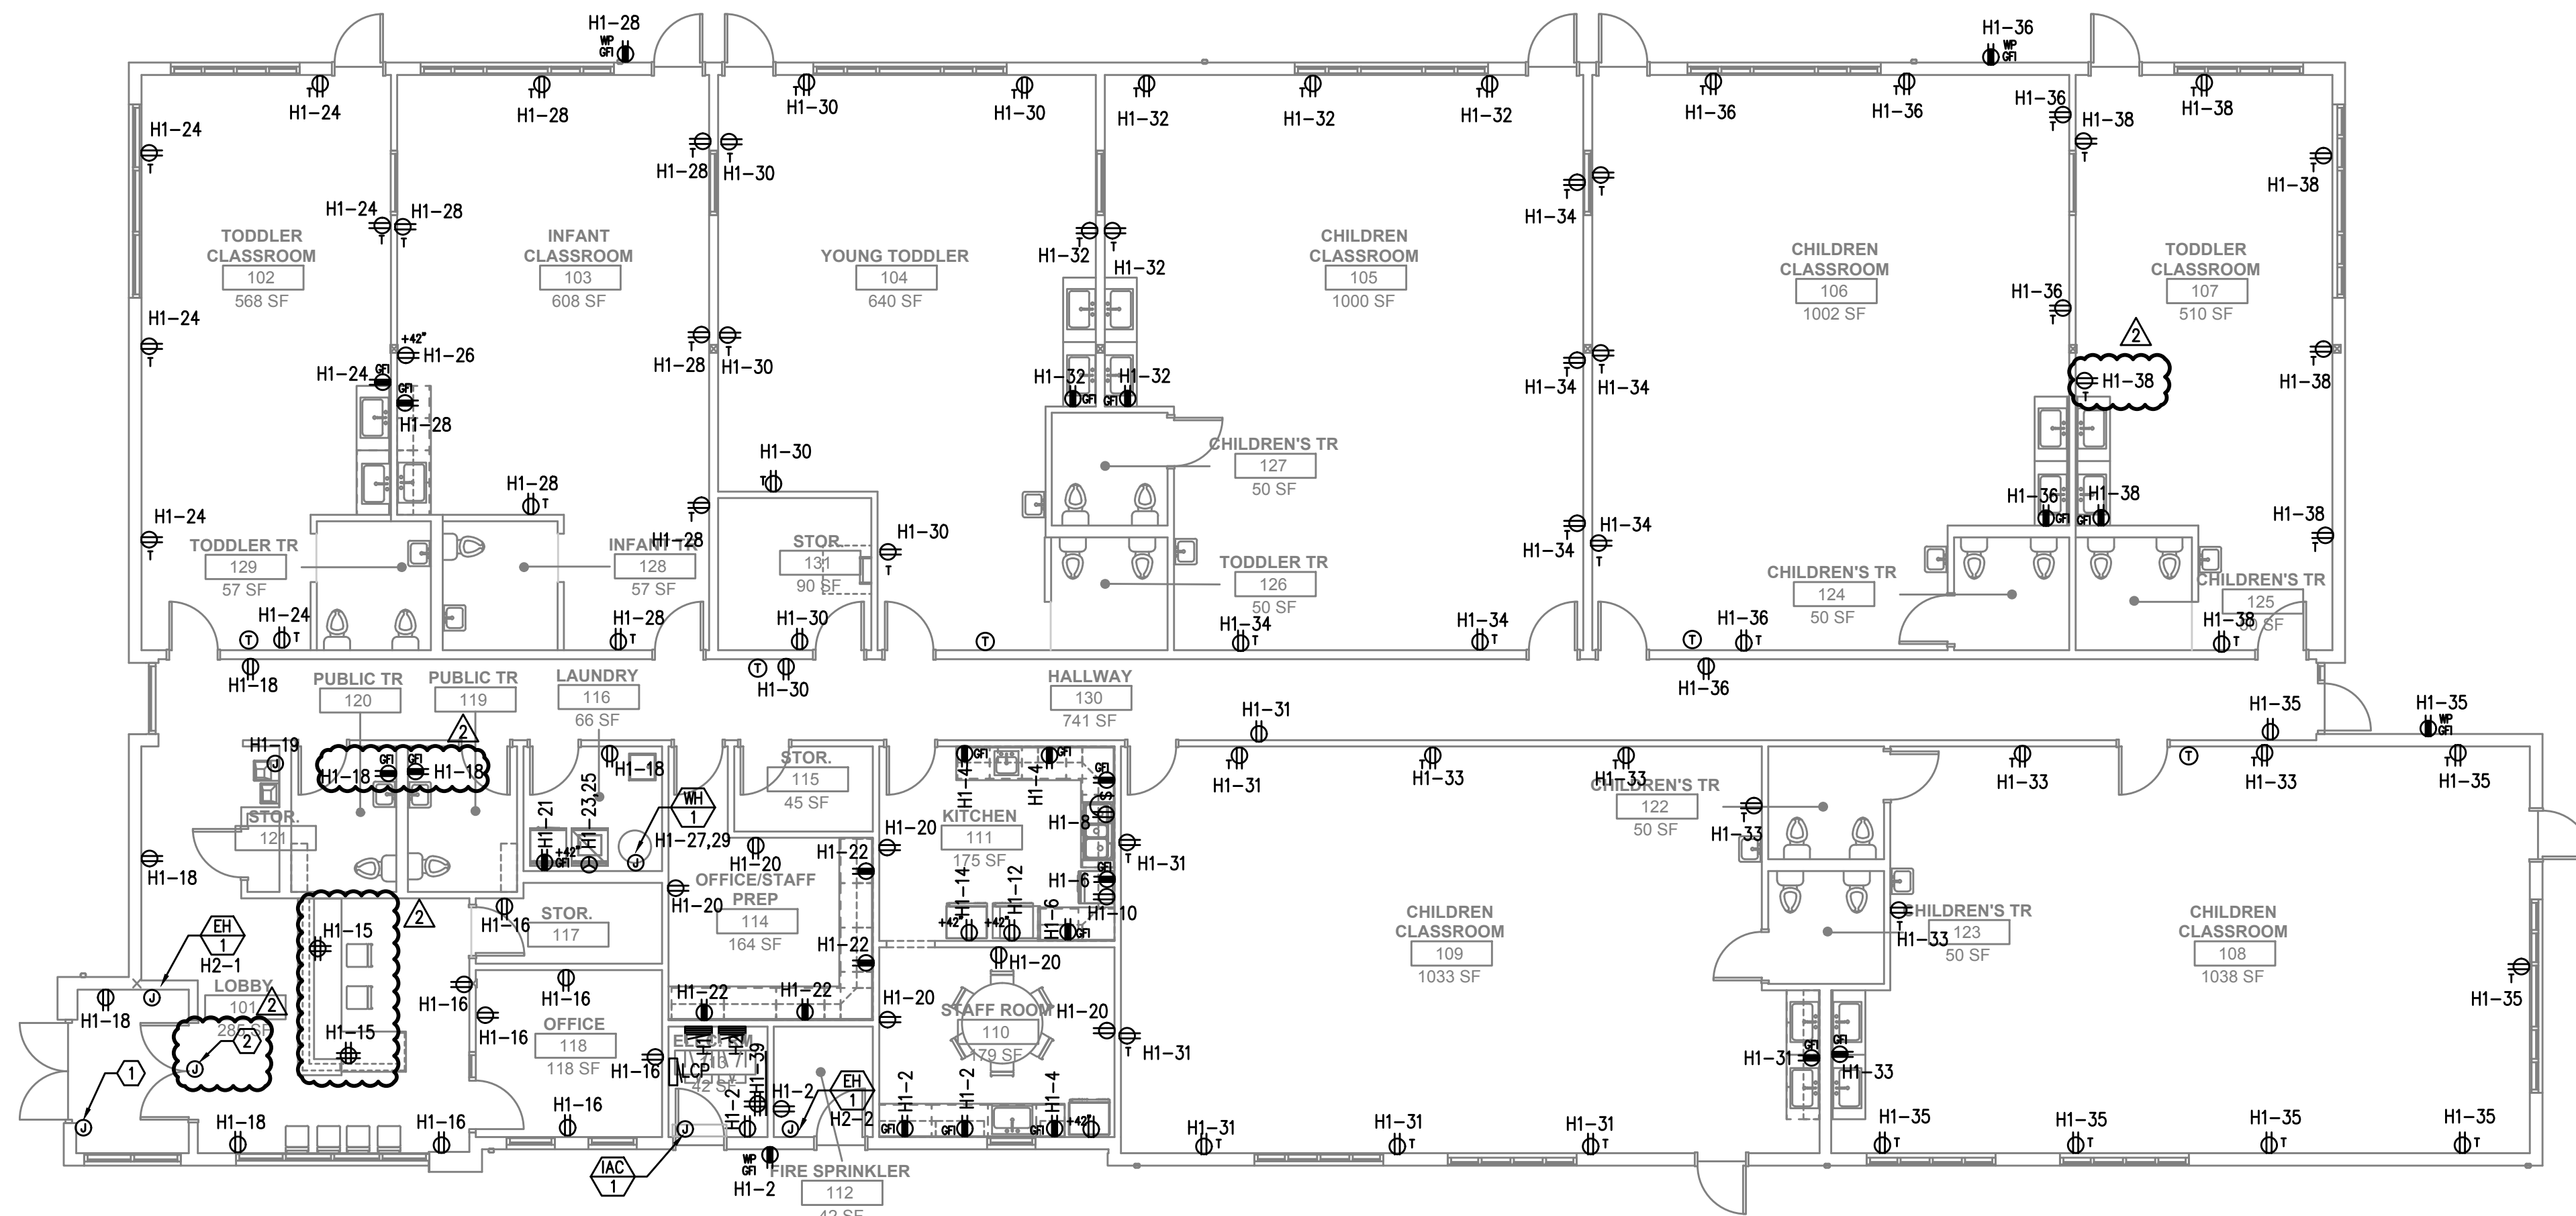


1 POWER PLAN
E3.01 SCALE: 1/8" = 1'-0"


GENERAL NOTES:

- ELECTRICAL DRAWINGS ARE DIAGRAMMATICAL AND MAY NOT ACCURATELY REFLECT ACTUAL CONSTRUCTION CONDITIONS. THE ELECTRICAL CONTRACTOR SHALL BE RESPONSIBLE FOR COORDINATING THE INSTALLATION OF ALL ELECTRICAL EQUIPMENT, WITH ALL TRADES PRIOR TO AND DURING CONSTRUCTION.
- WORK SHALL BE IN ACCORDANCE WITH ALL APPLICABLE LOCAL, STATE AND NATIONAL CODES.
- THE ELECTRICAL CONTRACTOR SHALL REFER TO THE ARCHITECTURAL DRAWINGS FOR ALL MOUNTING HEIGHTS AND FINISHES OF DEVICES AND FIXTURES.
- ELECTRICAL PANELS LOCATED IN PUBLIC OR UNSECURED SPACES SHALL BE PROVIDED WITH A LOCKABLE DOOR PANEL.
- SERVICE ENTRANCE AND METERING EQUIPMENT SHOWN TO APPROXIMATE SCALE. CONTRACTOR SHALL BE RESPONSIBLE FOR ENDURING THAT INSTALLED EQUIPMENT FITS THE SPACE PROVIDED AND THAT ALL REQUIRED WORKING CLEARANCES ARE PROVIDED.
- COORDINATE WITH DIVISION 23 FOR EXACT LOCATION AND POWER REQUIREMENTS OF ALL MECHANICAL EQUIPMENT PRIOR TO ROUGH IN. REFER TO SHEET E1.11 FOR MECHANICAL EQUIPMENT SCHEDULE.
- ELECTRICAL CONTRACTOR SHALL PROVIDE INSTALLATION AND FINAL CONNECTION OF THERMOSTATS AS REQUIRED. CONSULT MECHANICAL CONTRACTOR FOR EXACT REQUIREMENTS PRIOR TO ROUGH IN. VERIFY THAT THE MECHANICAL CONTRACTOR PROVIDES THE THERMOSTAT THEY SPECIFY IN THEIR PROJECT DOCUMENTS.
- FIRE ALARM & DETECTION SYSTEMS ARE TO BE DESIGNED AND INSTALLED BY OTHERS. THE ELECTRICAL CONTRACTOR SHALL COORDINATE WITH THE FIRE ALARM SYSTEM DESIGNER FOR EXACT LOCATIONS AND PROVIDE ROUGH IN ONLY.
- LOW VOLTAGE SYSTEMS ARE TO BE DESIGNED AND INSTALLED BY OTHERS. THE ELECTRICAL CONTRACTOR SHALL COORDINATE WITH THE SERVICE PROVIDER AND/OR SYSTEMS DESIGNER FOR EXACT LOCATIONS AND PROVIDE ROUGH IN ONLY.
- THE ELECTRICAL CONTRACTOR SHALL REFER TO THE MECHANICAL PLAN SHEETS AND COORDINATE WITH THE MECHANICAL INSTALLER TO AVOID CONFLICTS BETWEEN HVAC EQUIPMENT AND LIGHT FIXTURES WITHIN THE APARTMENT UNITS.
- RESTROOM EXHAUST FANS TO BE CONTINUOUS OPERATION AND TIED INTO THE LIGHTING CIRCUIT FOR THAT AREA.

KEYED NOTES:

- PROVIDE ONE 20A, 120V, 1P CIRCUIT FROM PANEL H1 FOR OWNER PROVIDED AND INSTALLED ENTRY ACCESS SYSTEM WITH CAMERA. CONSULT ARCHITECT FOR EXACT POWER REQUIREMENTS AND DEVICE LOCATION(S) PRIOR TO ROUGH IN.
- PROVIDE ONE 20A, 120V, 1P CIRCUIT FROM PANEL H1 FOR OWNER PROVIDED AND INSTALLED ENTRY KEYPAD SYSTEM WITH BUZZ-IN FEATURE. CONSULT ARCHITECT FOR EXACT POWER REQUIREMENTS AND DEVICE LOCATION(S) PRIOR TO ROUGH IN.

#	DATE	DESC.
1	12.22.21	ISSUE FOR PERMIT
2	02.16.22	PLAN REVIEW

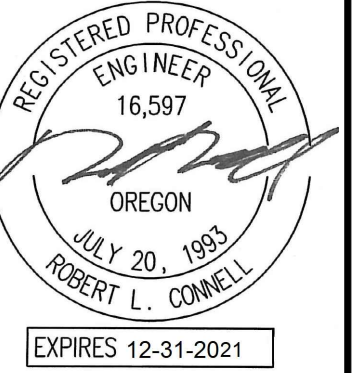

LIVERMORE
ARCHITECTURE &
ENGINEERING, INC.
1500 SW First Ave. Suite 240
Portland, Oregon 97201
Phone: 503-892-3002
www.livormore.com

Livormore
JOB NO: 221059.00

NEW BUILDING FOR
GUIDEPOST MONTESSORI DAYCARE
SE TUALATIN VALLEY HWY AND SE 70TH AVENUE
HILLSBORO, OREGON

DRAWING TITLE:
ELECTRICAL
POWER PLAN
DRAWN BY: DMT
CHECKED BY: RLC

E3.01

MFA
Consulting Engineers
2007 S.E. Ash St.
Portland, OR 97214
PHN: (503) 234-0548
FAX: (503) 234-0877
CONTACT: .