



UNIT HEATER
1/4 H.P. 120V. 1φ
AT CEILING

UNIT HEATER
1/4 H.P. 120V. 1φ
AT CEILING

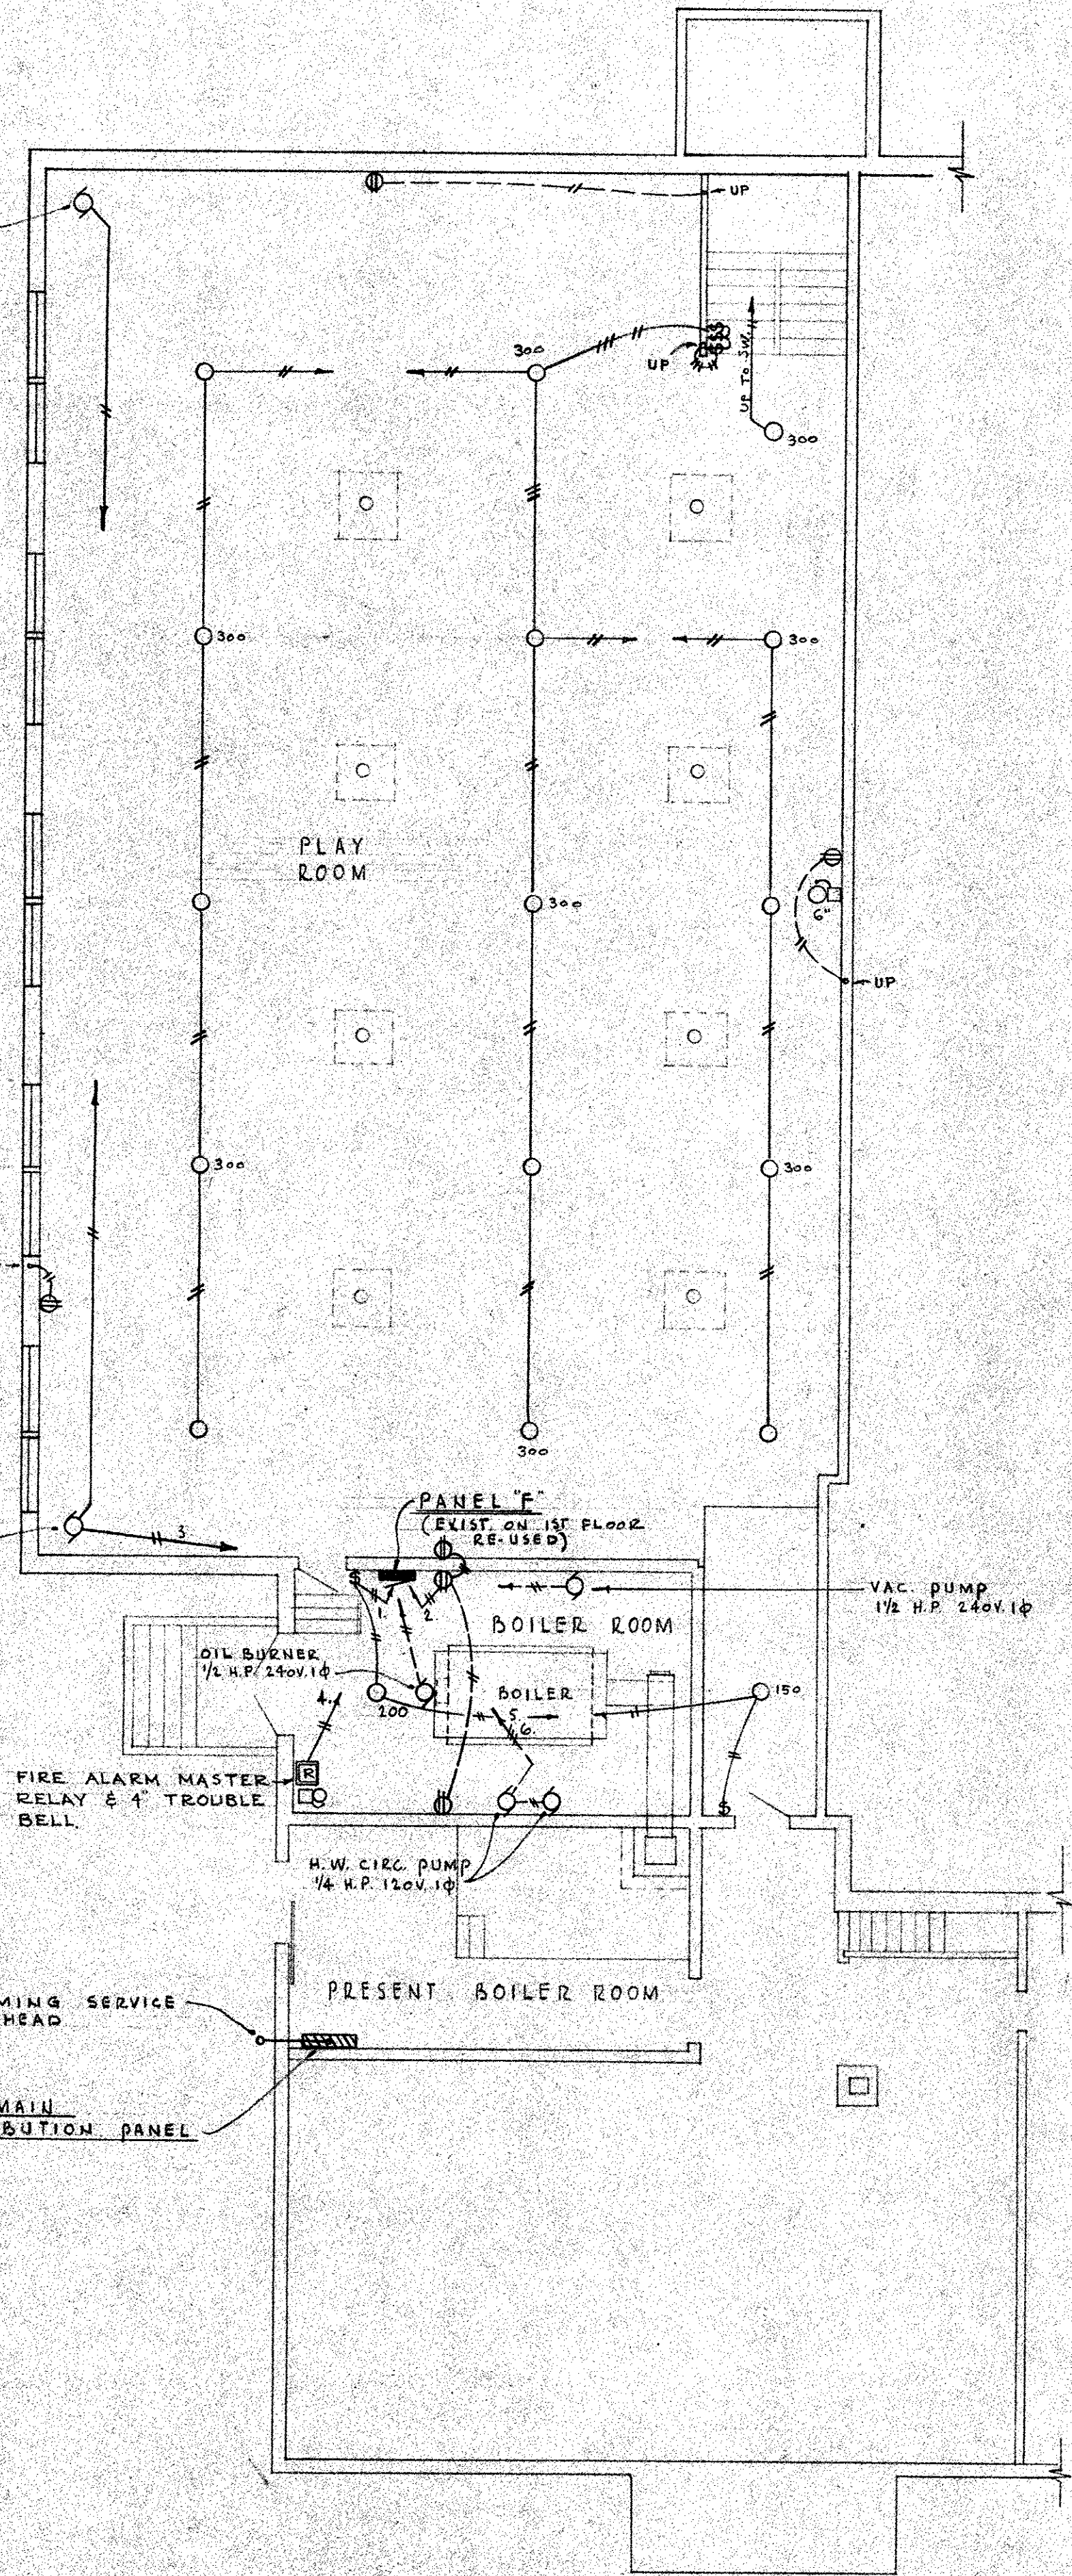

BASEMENT FLOOR PLAN

SCALE 1/8" = 1'-0"

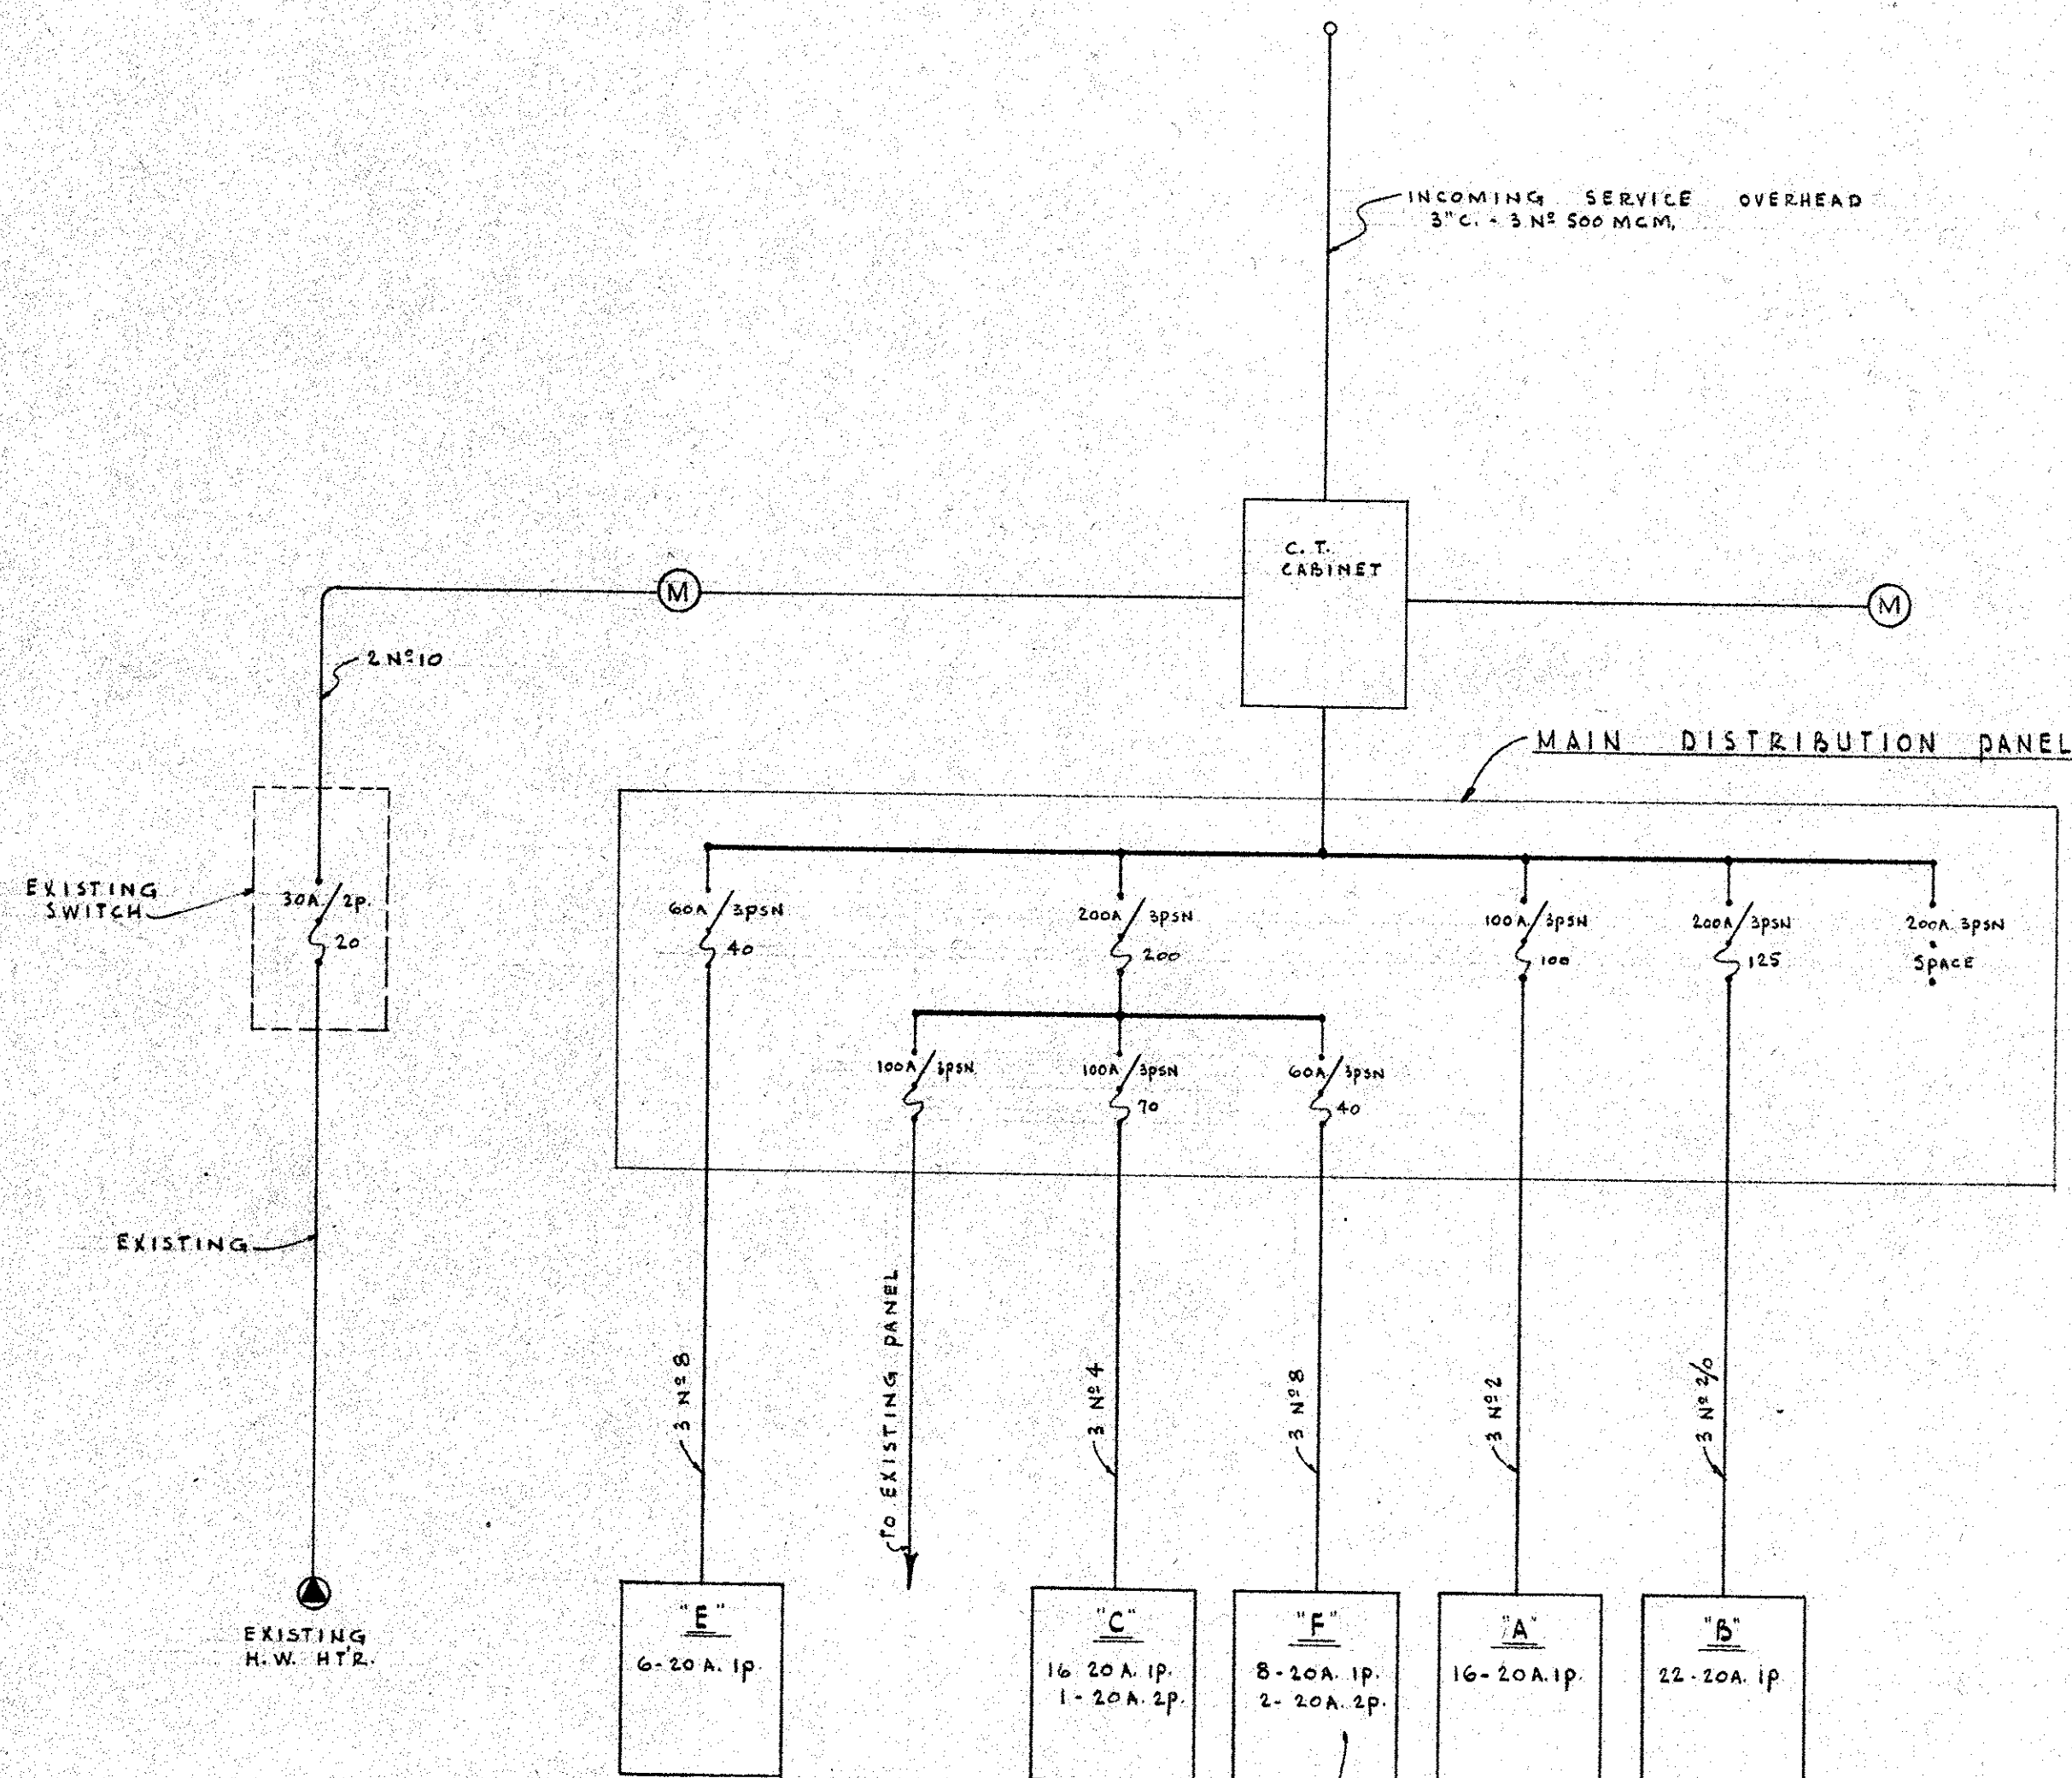


RISER DIAGRAM

120-240 V. 1φ 3WSN

NOT TO SCALE

RE-USE EXISTING MULTI-BRKR.
PANEL IN BOILER ROOM (F) &
PROVIDE TIES FOR 2p. BRKRS

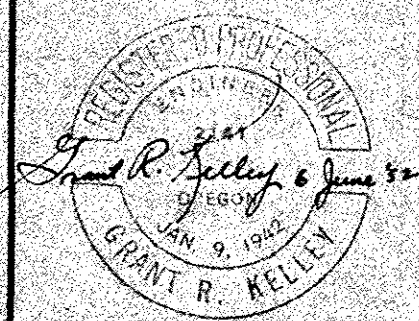

GEORGE PETTINGELL
GRANT KELLEY & CO.
CONSULTING ELECTRICAL
ENGINEERS
PORTLAND OREGON

ELECTRICAL

ADDITION TO BELLVIEW SCHOOL
U. S. 99 & TOLMAN CREEK ROAD
SCHOOL DISTRICT NO. 5
JACKSON COUNTY - ASHLAND, OREGON

DATE 7-15-52	STOKES & ALLYN-ARCHITECTS 205 HUGHES BUILDING PORTLAND, OREGON	DRAWING 13
-----------------	--	---------------