


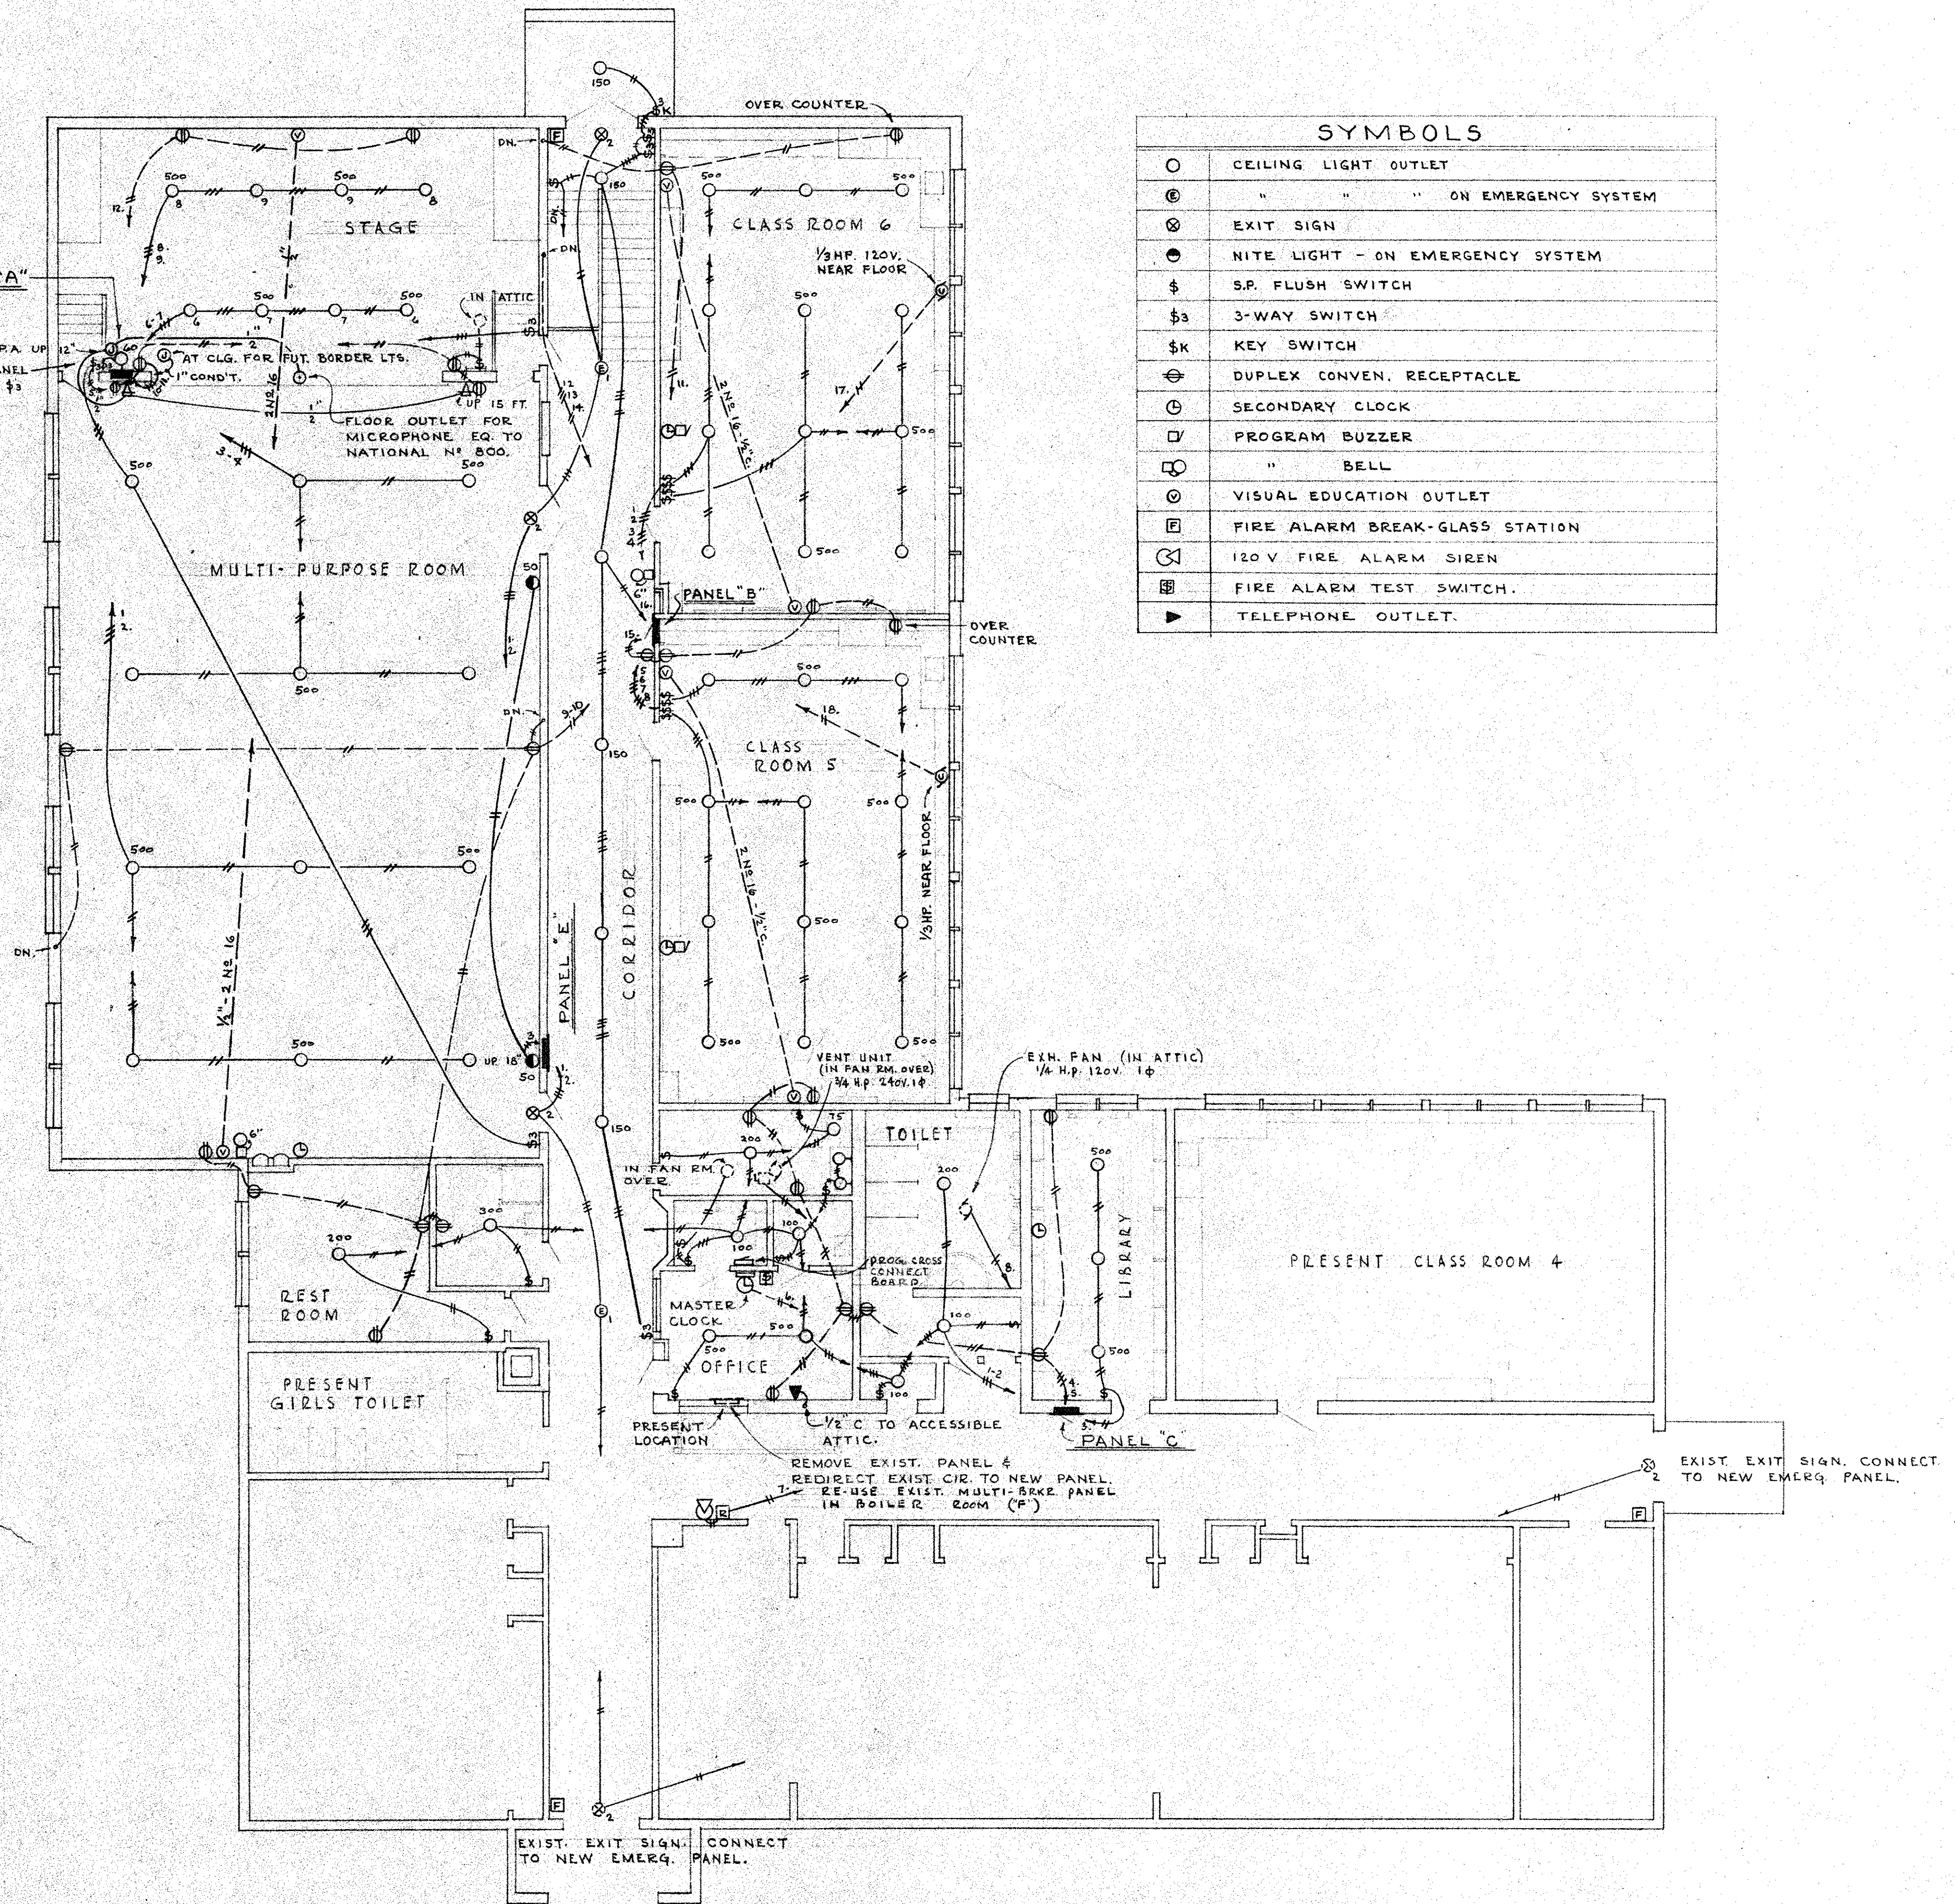


FIRST FLOOR PLAN

SCALE 1/8" = 1'-0"

ELECTRICAL

ADDITION TO BELLVIEW SCHOOL
U.S. 99 & TOLMAN CREEK ROAD
SCHOOL DISTRICT NO. 5
JACKSON COUNTY - ASHLAND, OREGON

DATE 7-15-52	STOKES & ALLYN-ARCHITECTS 205 HUGHES BUILDING PORTLAND, OREGON	DRAWING 14
-----------------	--	---------------

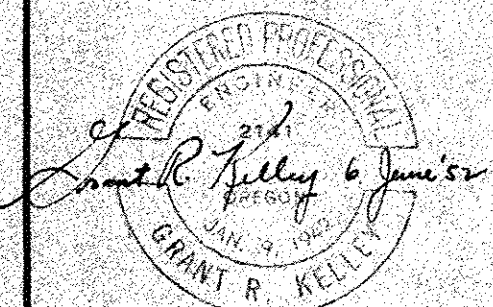

GEORGE PETTINGELL
GRANT KELLEY & CO.
CONSULTING ELECTRICAL
ENGINEERS
PORTLAND OREGON