


SYMBOLS	
⊙	CEILING LIGHT
⊕	DUPLEX CONVEN. RECEPT.
\$	S.P. FLUSH SWITCH
⊙	UNIT VENTILATOR
⊙	VISUAL EDUCATION OUTLET
⊙	SECONDARY CLOCK & BUZZER

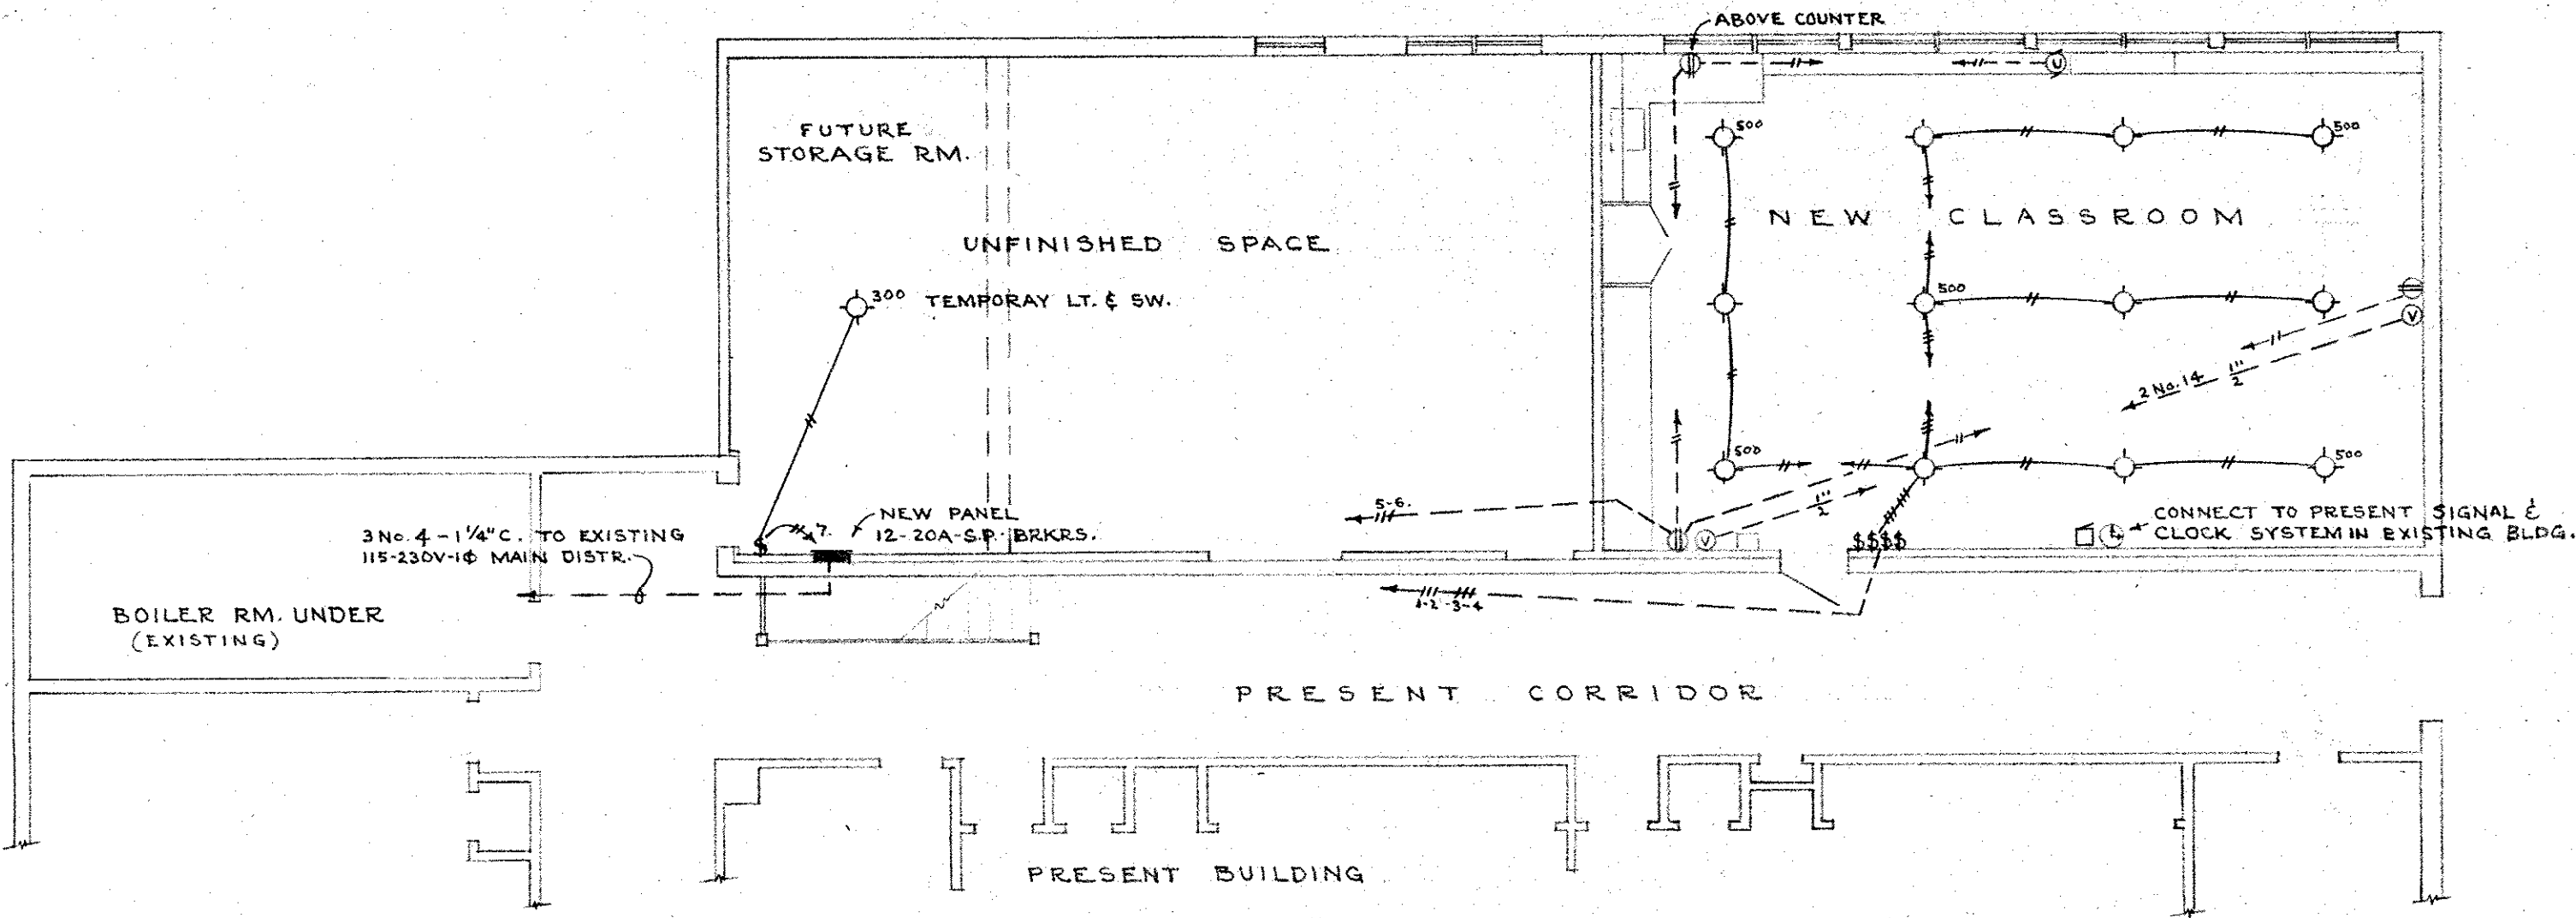

FLOOR PLAN
SCALE 1/8" = 1'-0"

2141
JAN. 9, 1962
GRANT R. KELLEY
ON PLAN
4 Aug. 50

GEORGE PETTINGELL
GRANT KELLEY & CO.
CONSULTING ELECTRICAL
ENGINEERS
PORTLAND, OREGON

ADDITION TO BELLVIEW SCHOOL ASHLAND - OREGON		
DATE 7/31/50	STOKES & ALLYN • ARCHITECTS 203 HUGHES BUILDING PORTLAND • OREGON	DRAWING 8