


PRELIMINARY
NOT FOR
CONSTRUCTION

IN THE EVENT CONFLICTS ARE DISCOVERED
BETWEEN THE ORIGINAL SIGNED AND SEALED
DOCUMENTS PREPARED BY THE ARCHITECTS
AND/OR THEIR CONSULTANTS, AND ANY COPY OF
THE DOCUMENTS TRANSMITTED BY MAIL, FAX,
ELECTRONICALLY OR OTHERWISE, THE ORIGINAL
SIGNED AND SEALED DOCUMENTS SHALL GOVERN.

PROJECT # 20XX-XX
DATE: 09/29/2009

REVISIONS

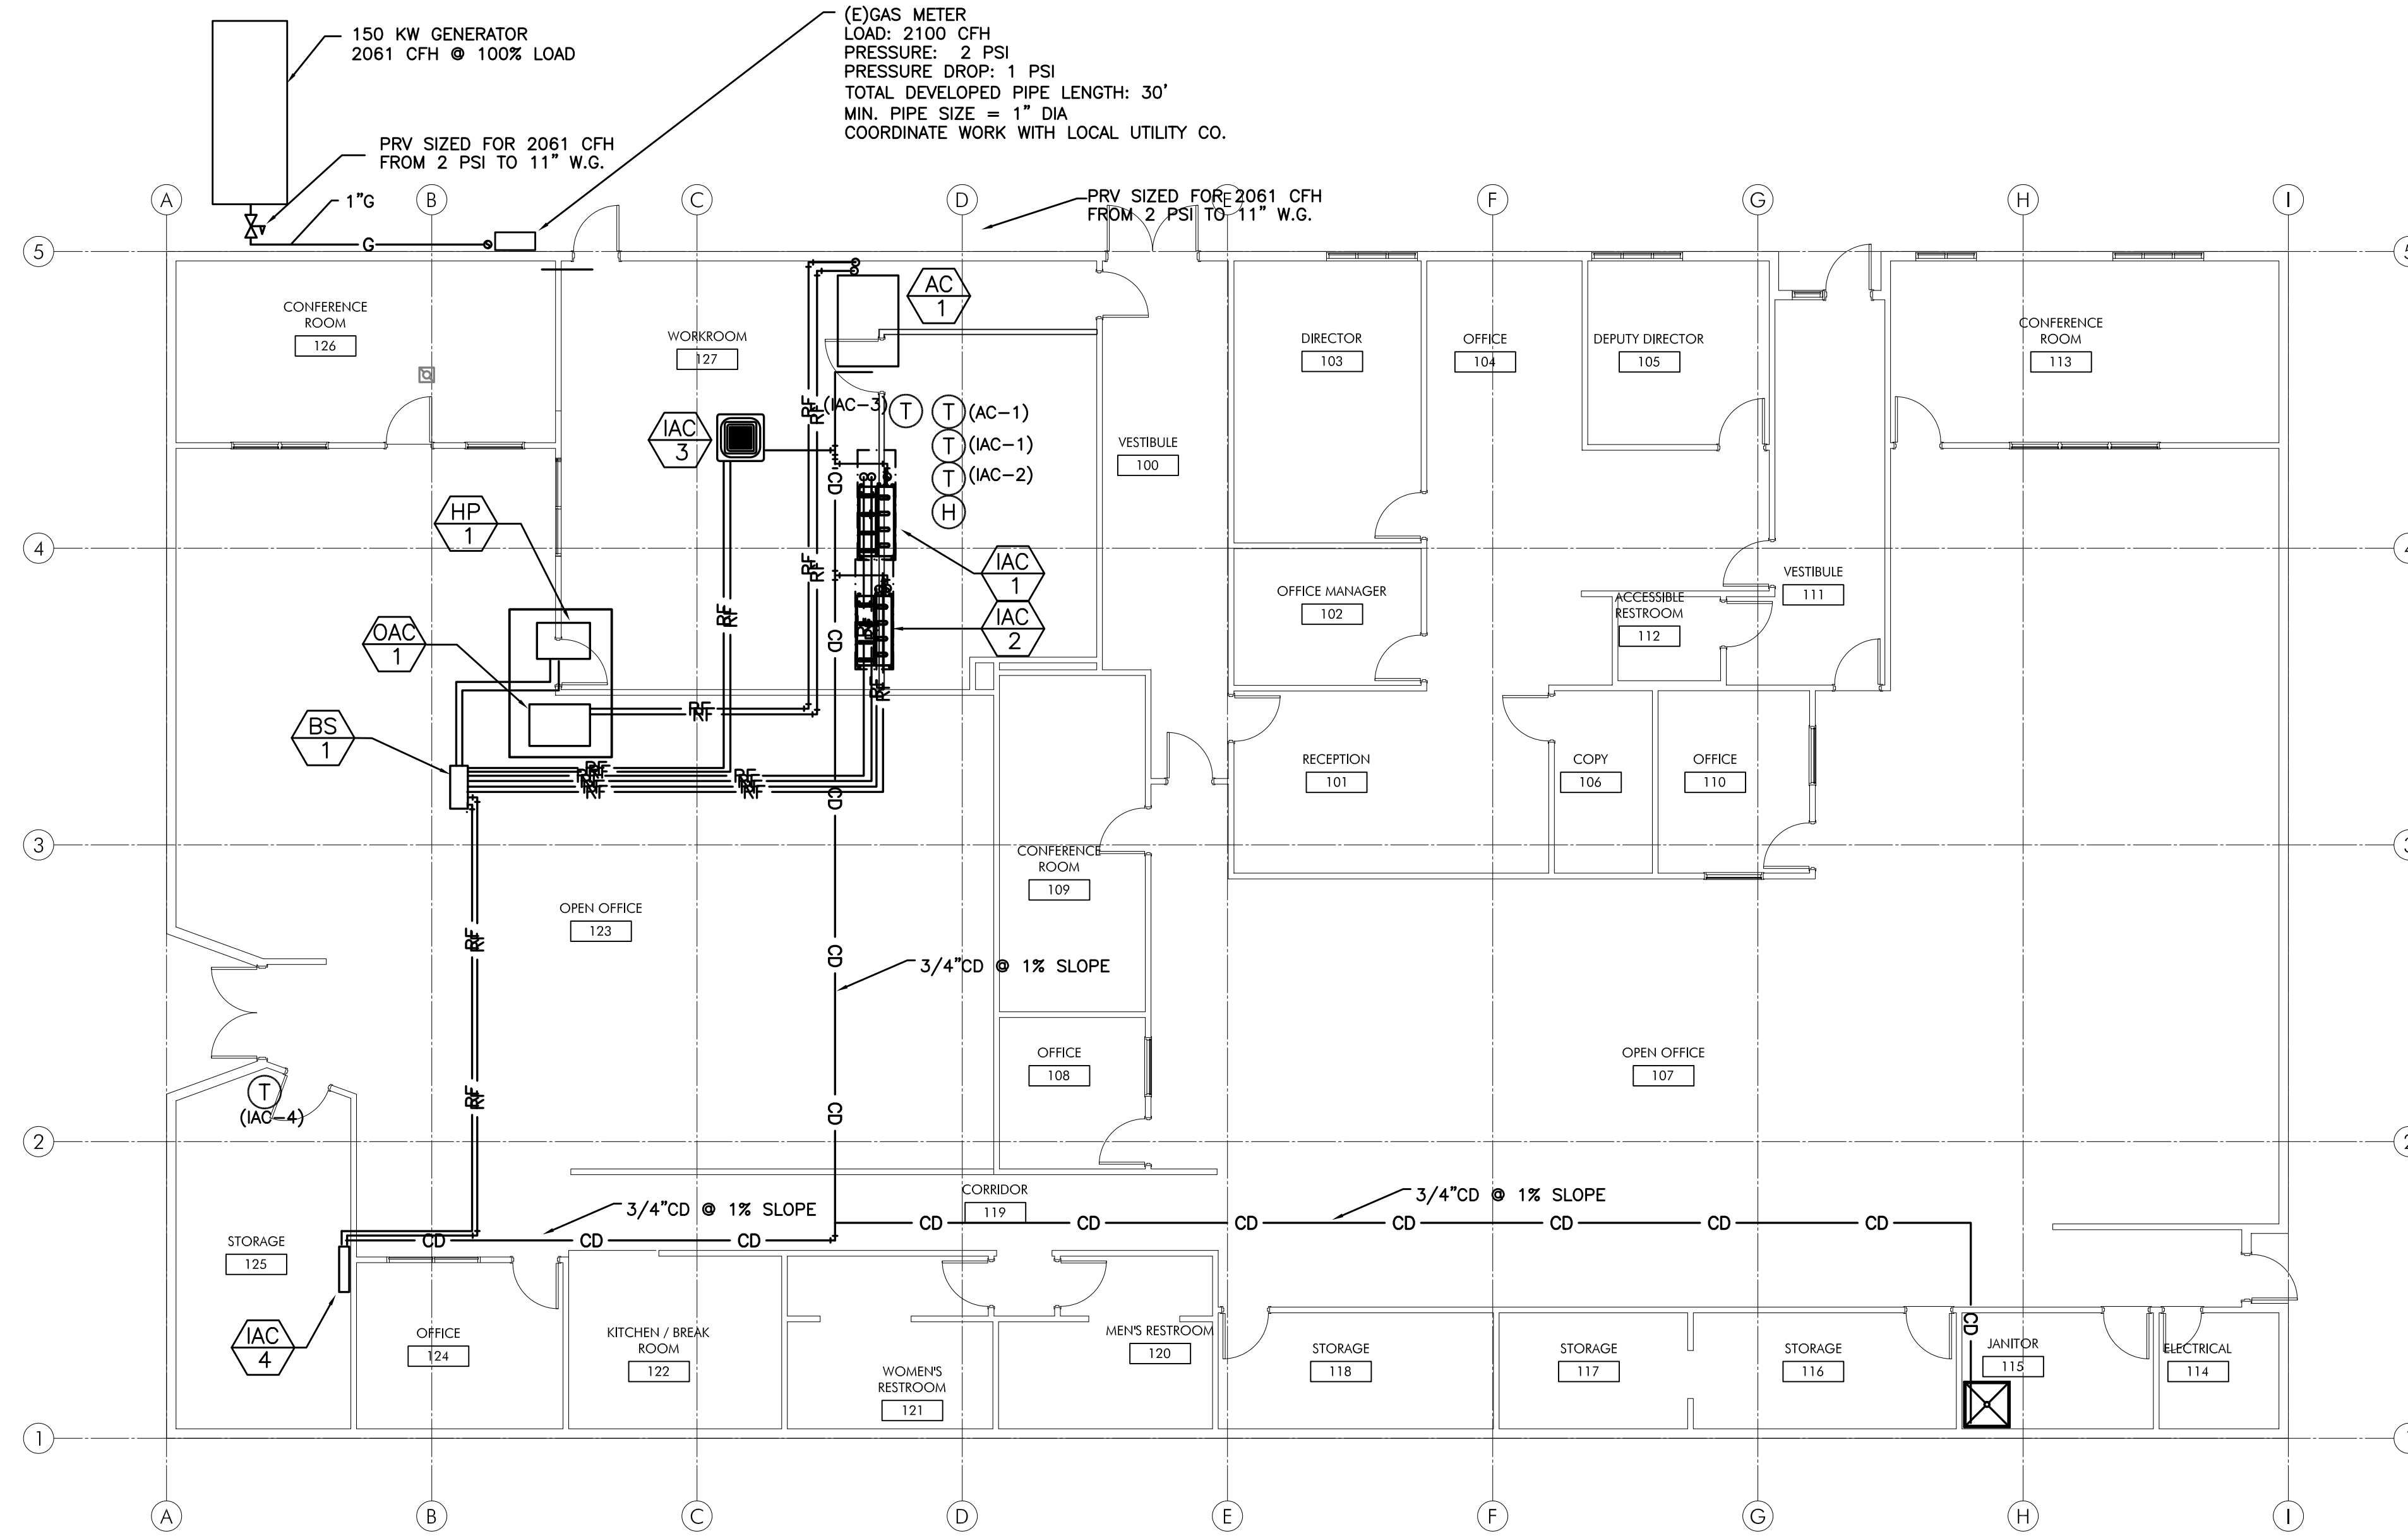

1 MECHANICAL PIPING PLAN
 M2.1 SCALE: 1/8" = 1'-0"

SERVER ROOM UPGRADE FOR:
SALEM-KEIZER SCHOOL DISTRICT
TECHNOLOGY & INFORMATION SERVICES BUILDING
 1340 STATE STREET, SALEM, OREGON 97301

M
E
F
A
INC.
 Consulting Engineers
 2007 S.E. Ash St.
 Portland, OR 97214
 PHN: (503) 234-0548
 FAX: (503) 234-0677
 WWW.MFIA-ENG.COM
 CONTACT: TAKAKO BAKER

SHEET:

M2.1