

PRELIMINARY
NOT FOR
CONSTRUCTION

KING+PARKS MULTI-FAMILY RESIDENCES

PROJECT SITE: NE Martin Luther King Jr. Boulevard & N Rosa Parks Way
OWNER: Portland Community Reinvestment Initiatives Inc. (PCRI)
6329 NE Martin Luther King Jr. Blvd. Portland, Oregon 97211




PROJECT NO. 16-0602
ISSUE DATE 06.23.2017

REVISIONS

SHEET
**MECHANICAL
ROOF PLAN - NORTH**
M2.4A
NOT FOR CONSTRUCTION
PRICING SET
© MERRYMAN BARNES ARCHITECTS, INC.

**M
E
R
R
Y
M
A
N** Consulting Engineers
2007 S.E. Ash St.
Portland, OR 97214
PHN: (503) 234-0548
FAX: (503) 234-0677
WWW.MFIA-ENG.COM
CONTACT: Takako Baker

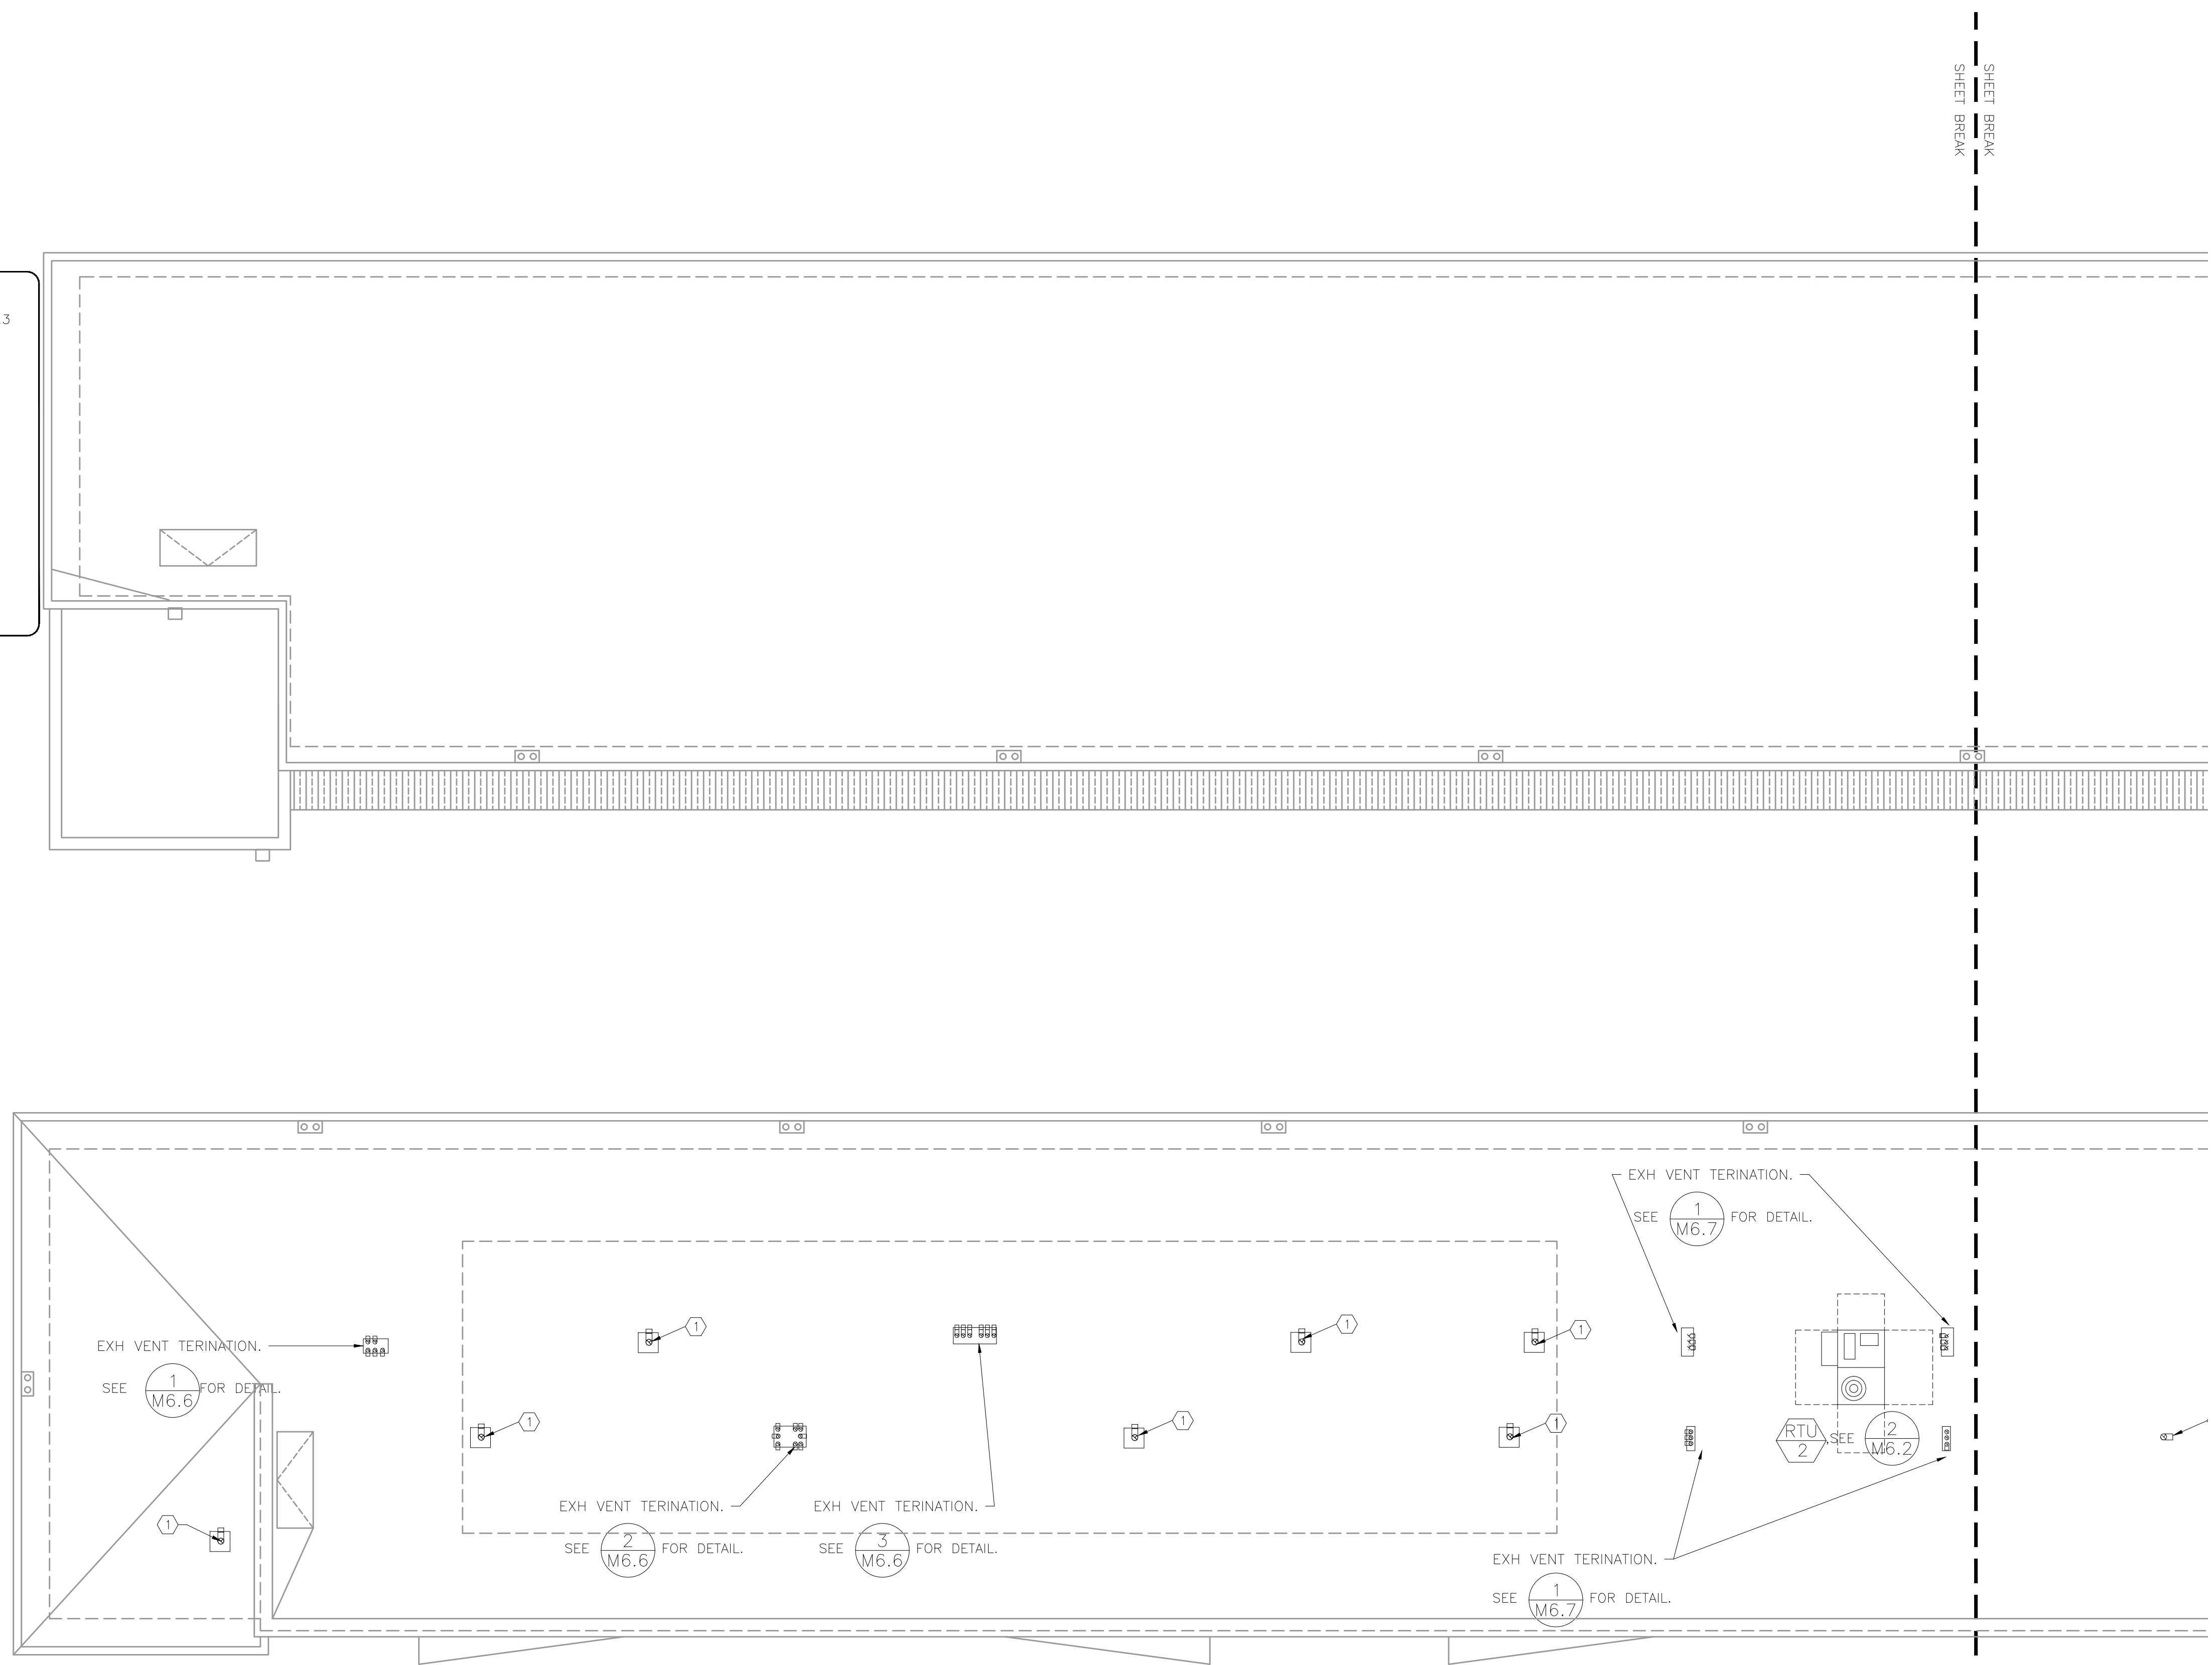

KEYED NOTES:
1. 6"Ø RANGE HOOD VENT TERMINATION AT ROOF. SEE 4/M6.3 FOR DETAIL.

GENERAL NOTES:
1. LIO & SUCTION REF LINES ARE SHOWN AS A SINGLE PIPE FOR THE PURPOSE OF SHOWING ROUTING OF THE PIPING.
2. OSA INTAKES AT RTU'S TO BE LOCATED MINIMUM OF 10'-0" RADIUS FROM ANY EXHAUST VENTS, PLUMBING VENTS OR FLUE TERMINATIONS.

1 MECHANICAL ROOF PLAN - SOUTH
SCALE: 1/8" = 1'-0"

SHEET BREAK