



- GENERAL NOTES:
- A. ELECTRICAL DRAWINGS ARE DIAGRAMMATICAL AND MAY NOT ACCURATELY REFLECT ACTUAL CONSTRUCTION CONDITIONS. THE ELECTRICAL CONTRACTOR SHALL BE RESPONSIBLE FOR COORDINATING THE INSTALLATION OF ALL ELECTRICAL EQUIPMENT, WITH ALL TRADES PRIOR TO AND DURING CONSTRUCTION.
 - B. ALL WORK SHALL BE DONE IN ACCORDANCE WITH ALL APPLICABLE LOCAL, STATE & NATIONAL CODES.
 - C. CONTRACTOR SHALL REVIEW THE DIVISION 26 SPECIFICATIONS AND THE ENTIRE DRAWING PACKAGE FOR THIS PROJECT PRIOR TO THE START OF ANY WORK.
 - D. THE ELECTRICAL CONTRACTOR SHALL CONSULT WITH ALL OTHER TRADES AND PROVIDE THE APPROPRIATE POWER CONNECTION(S) AND COORDINATE EXACT LOCATIONS PRIOR TO ROUGH IN.
 - E. THE ELECTRICAL CONTRACTOR SHALL IMMEDIATELY ADVISE THE ARCHITECT OF ANY DISCREPANCIES DISCOVERED WITHIN THE DOCUMENTS.
 - F. ALL PRODUCT SUBMITTALS AND SUBSTITUTIONS SHALL BE PROVIDED TO THE ARCHITECT FOR REVIEW AND APPROVAL PRIOR TO PLACING ANY ORDERS.
 - G. THE ELECTRICAL CONTRACTOR SHALL REFER TO THE ARCHITECTURAL DRAWINGS FOR ALL MOUNTING HEIGHTS AND FINISHES OF DEVICES AND FIXTURES.
 - H. ELECTRICAL CONTRACTOR SHALL CONSULT ARCHITECTURAL AND INTERIOR DECORATOR'S PLAN DOCUMENTS SUCH AS INTERIOR ELEVATIONS, REFLECTED CEILING PLANS, ETC., FOR FIXTURE AND DEVICE DIMENSIONS NOT OTHERWISE NOTED ON THE ELECTRICAL PLANS.
 - I. REFER TO SHEET E1.21 FOR LIGHT FIXTURE SCHEDULE.
 - J. OCCUPANCY SENSORS SHALL BE FIELD ADJUSTED TO ENSURE COVERAGE AND PROPER CONTROL.
 - K. ALL EGRESS FIXTURES SHALL BE WIRED SUCH THAT IN THE EVENT OF A LIGHTING FAILURE, ALL LIGHTS WILL AUTOMATICALLY RETURN TO FULL LIGHTING. REFER TO SWITCHING DETAILS ON SHEET E1.21.

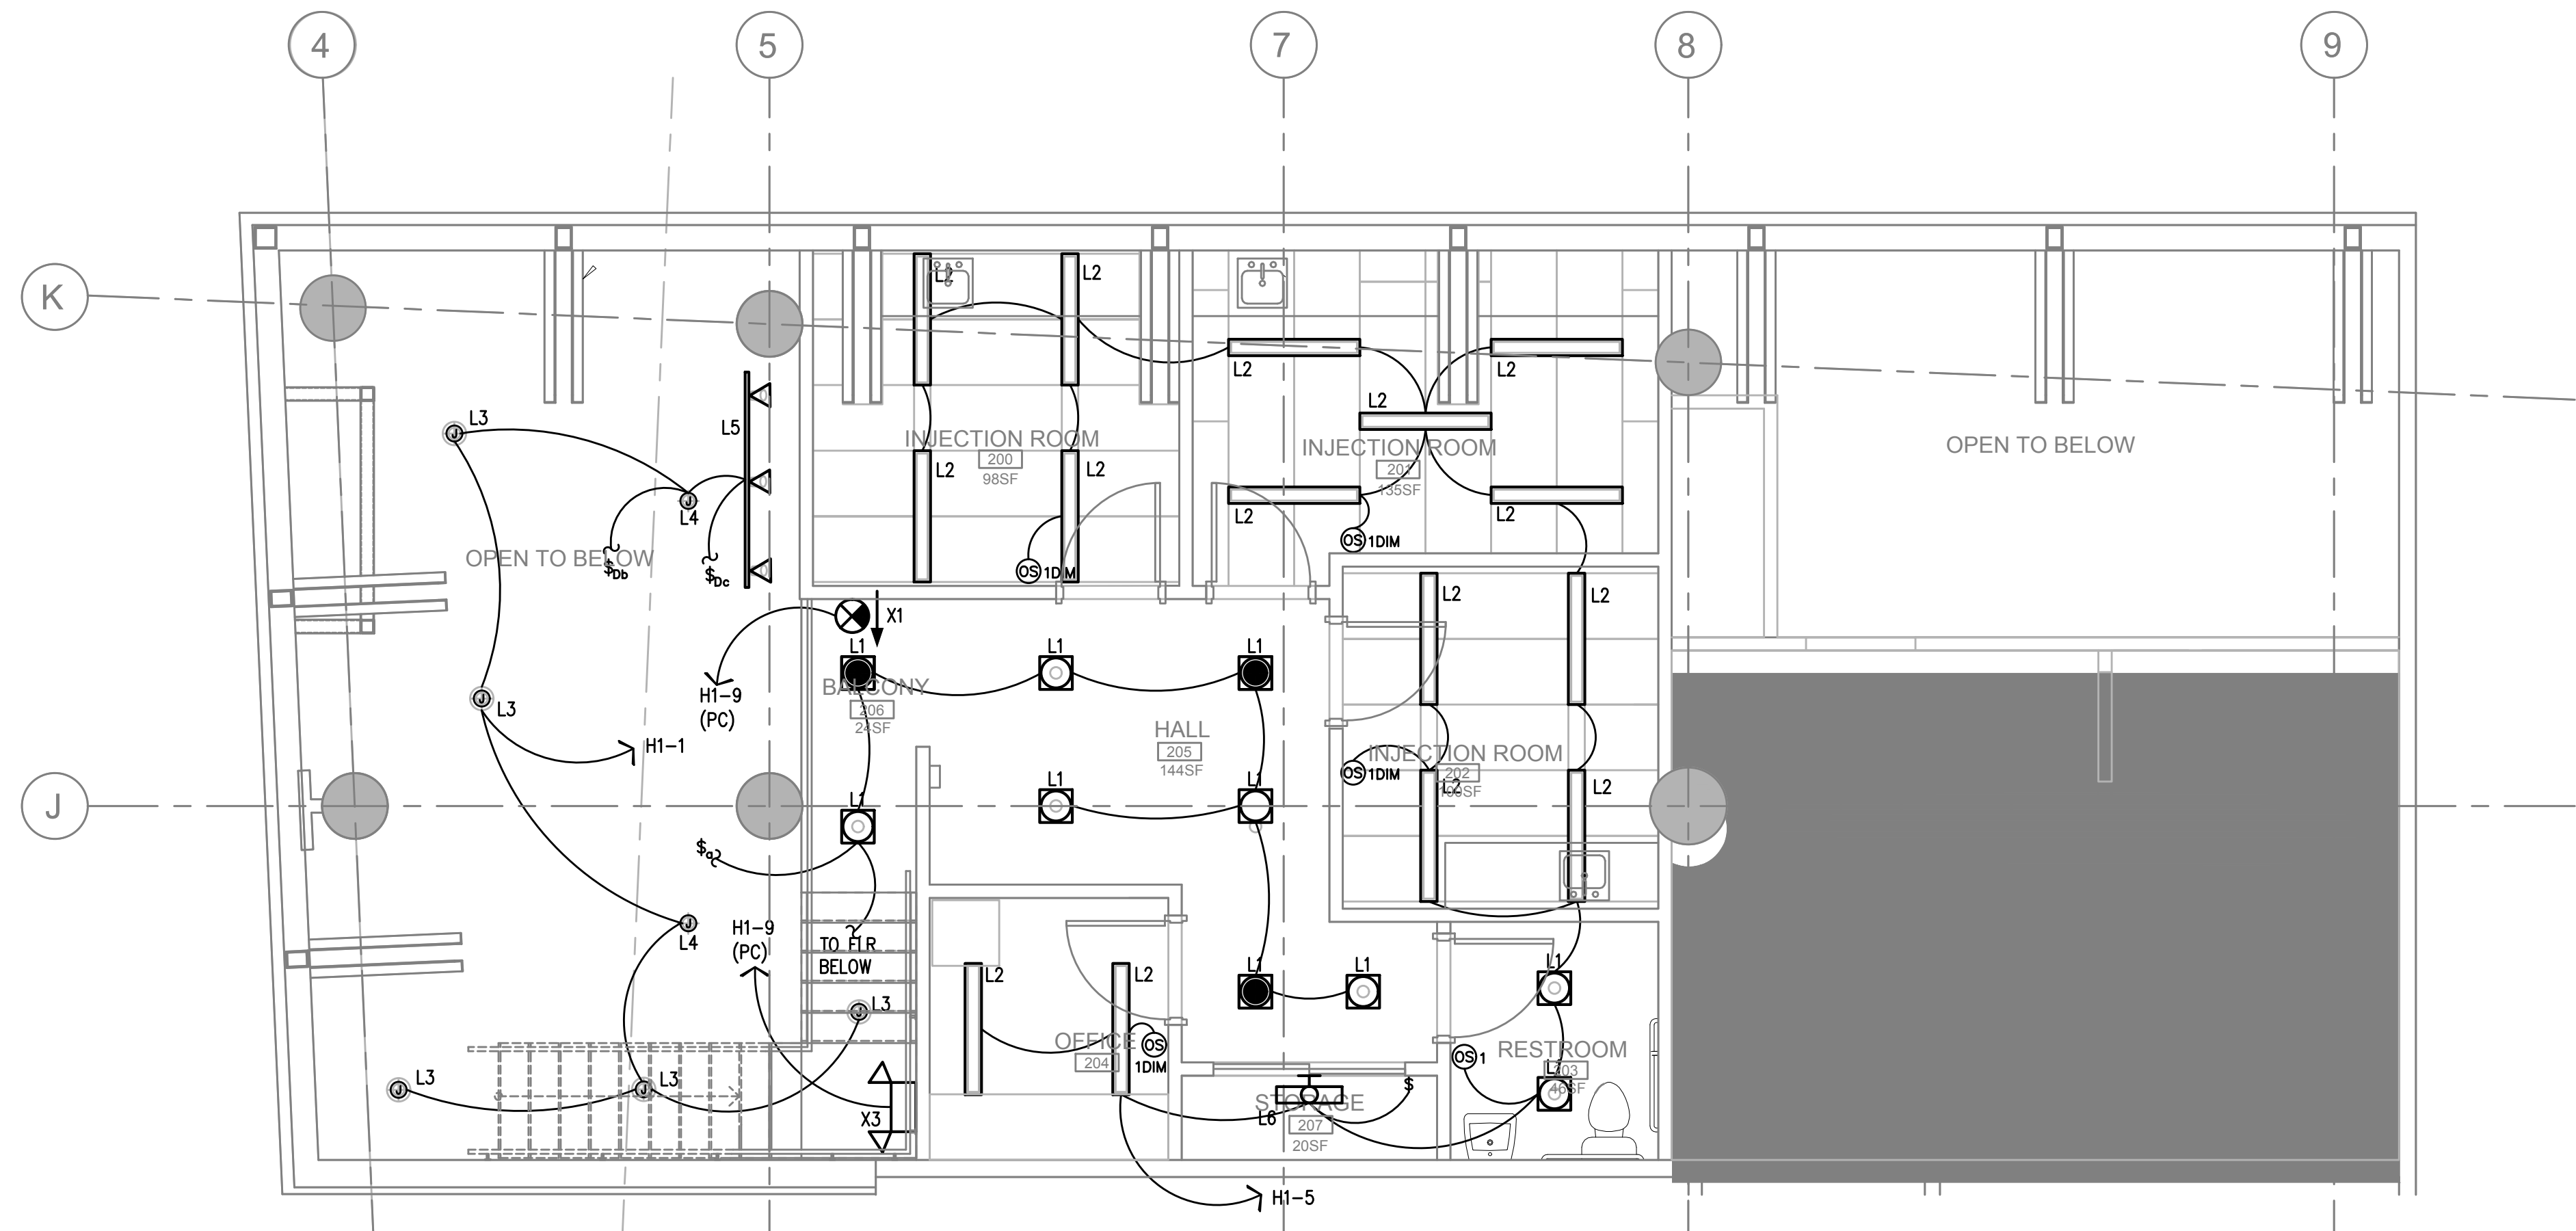

2 LIGHTING PLAN – MEZZANINE LEVEL
E2.01 SCALE: 1/4" = 1'-0"

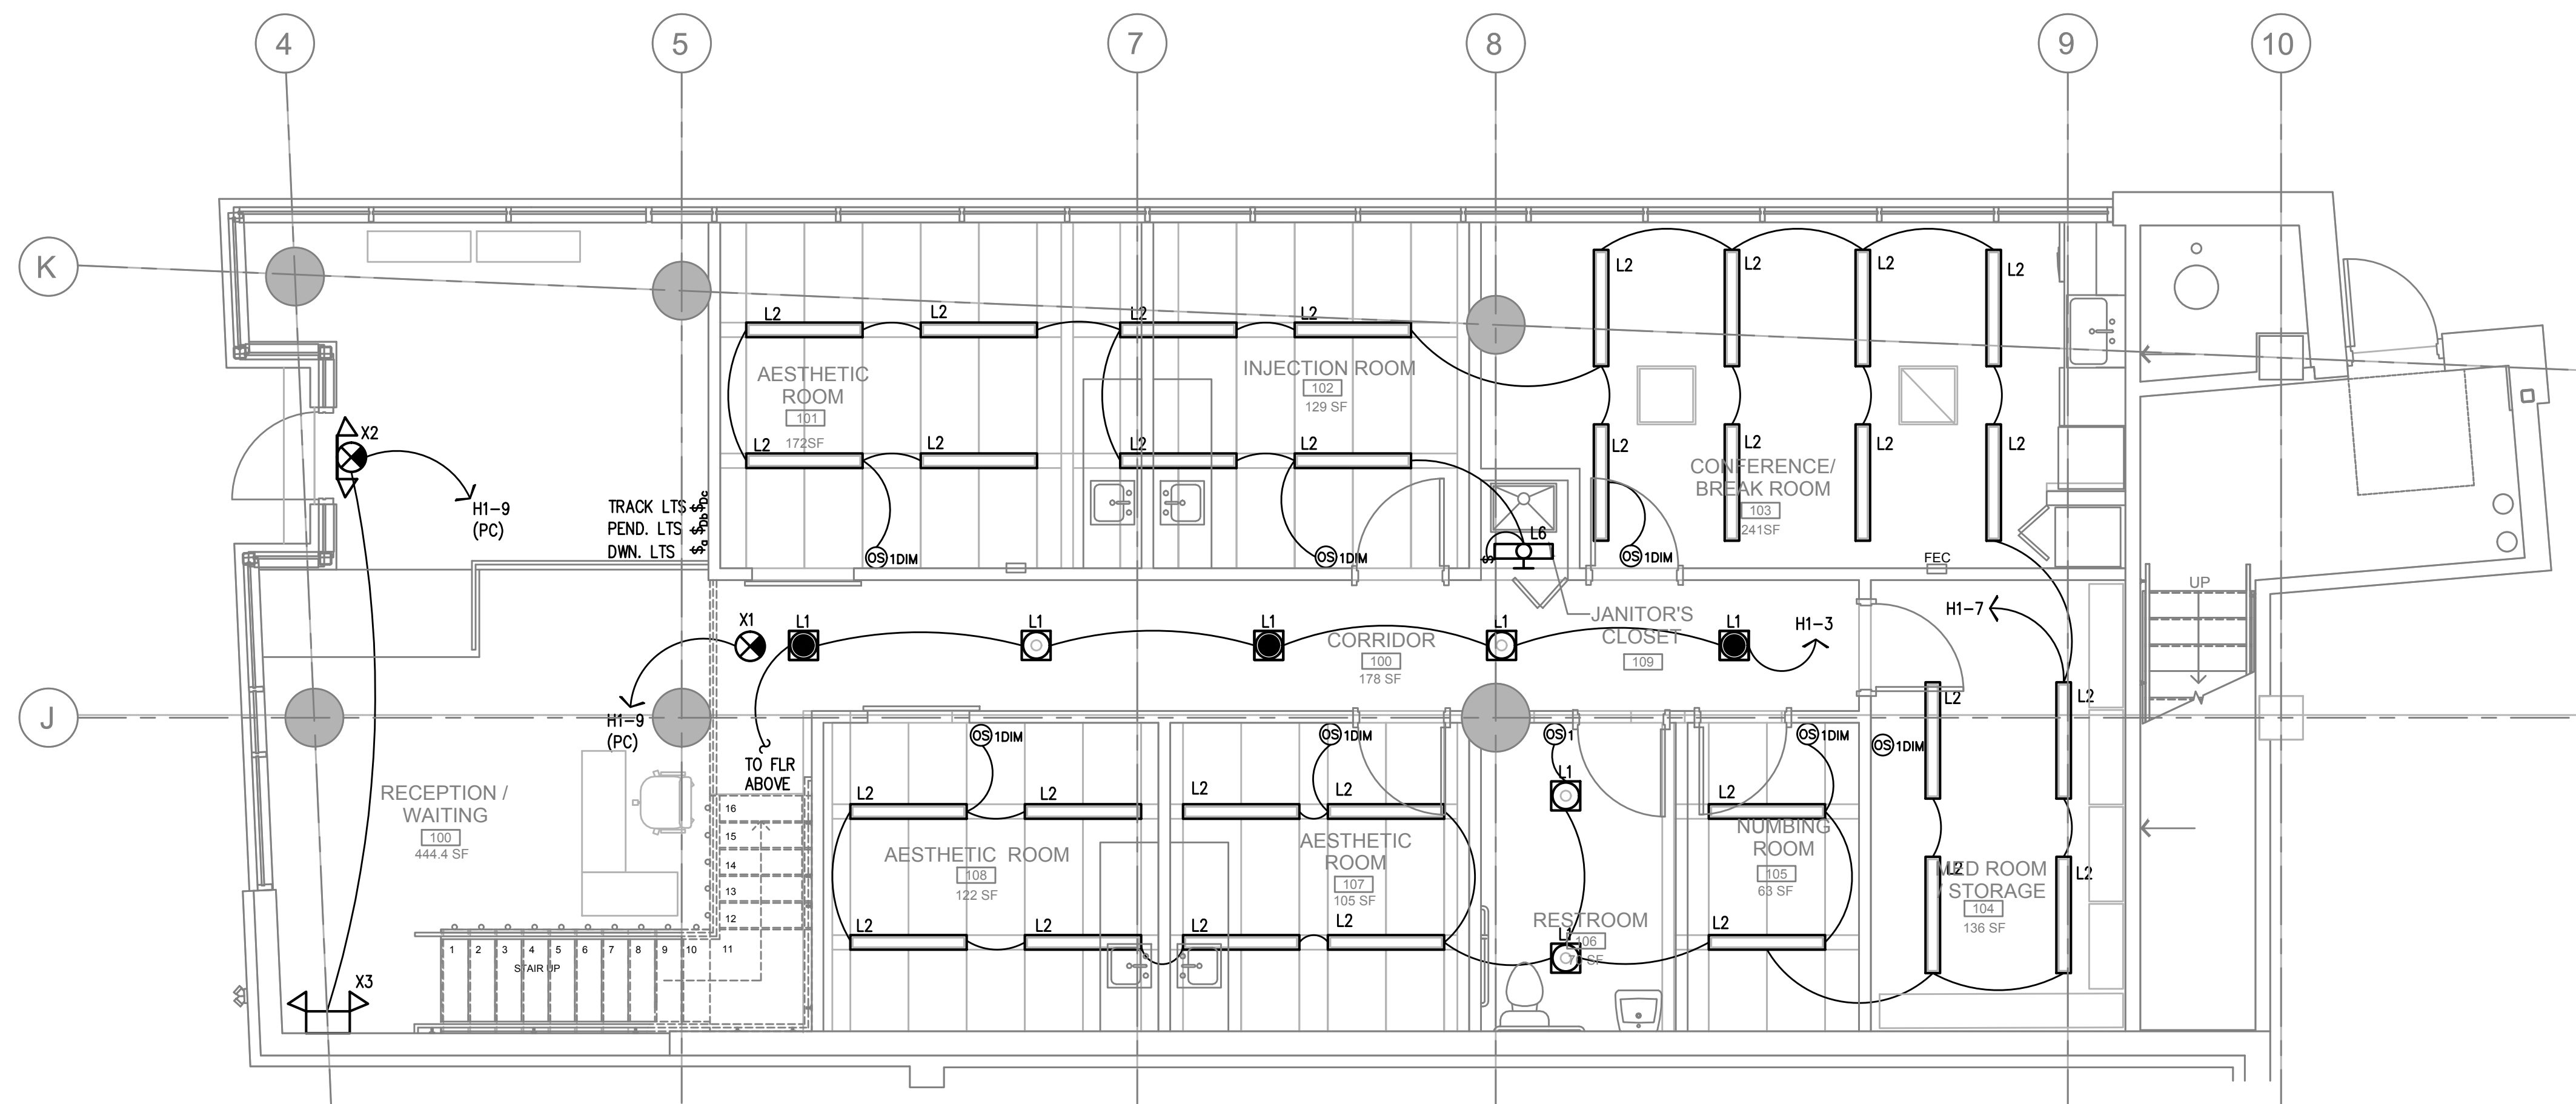

1 LIGHTING PLAN – MAIN LEVEL
E2.01 SCALE: 1/4" = 1'-0"