



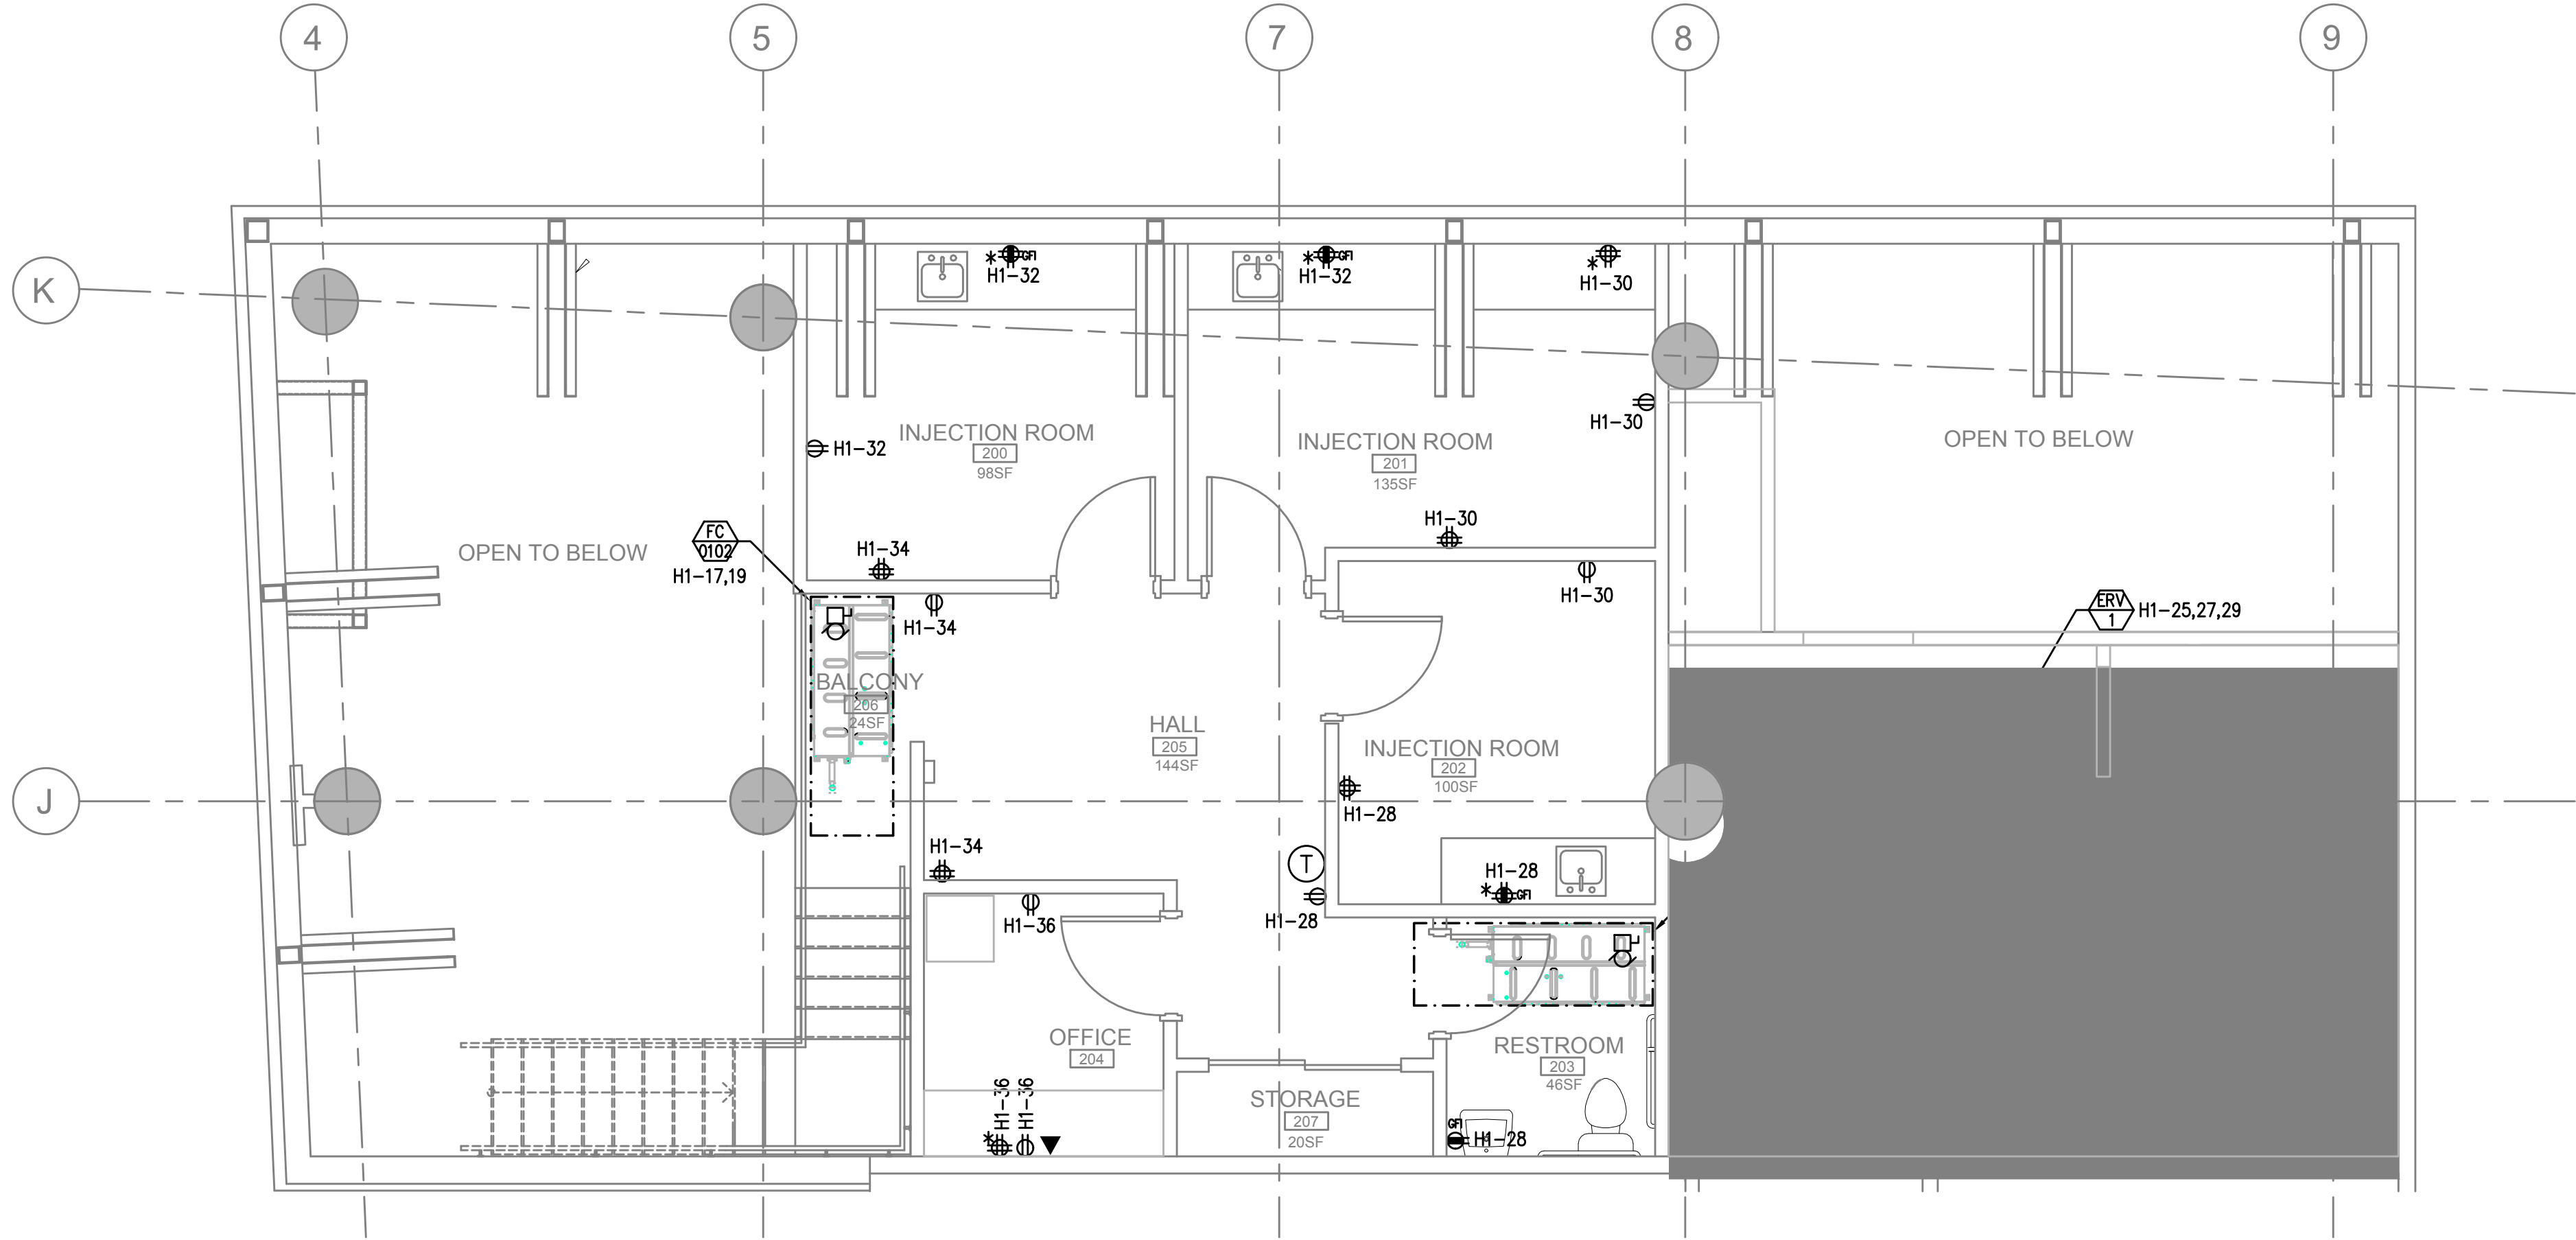

1 POWER PLAN – MEZZANINE LEVEL
 E3.02 SCALE: 1/4" = 1'-0"

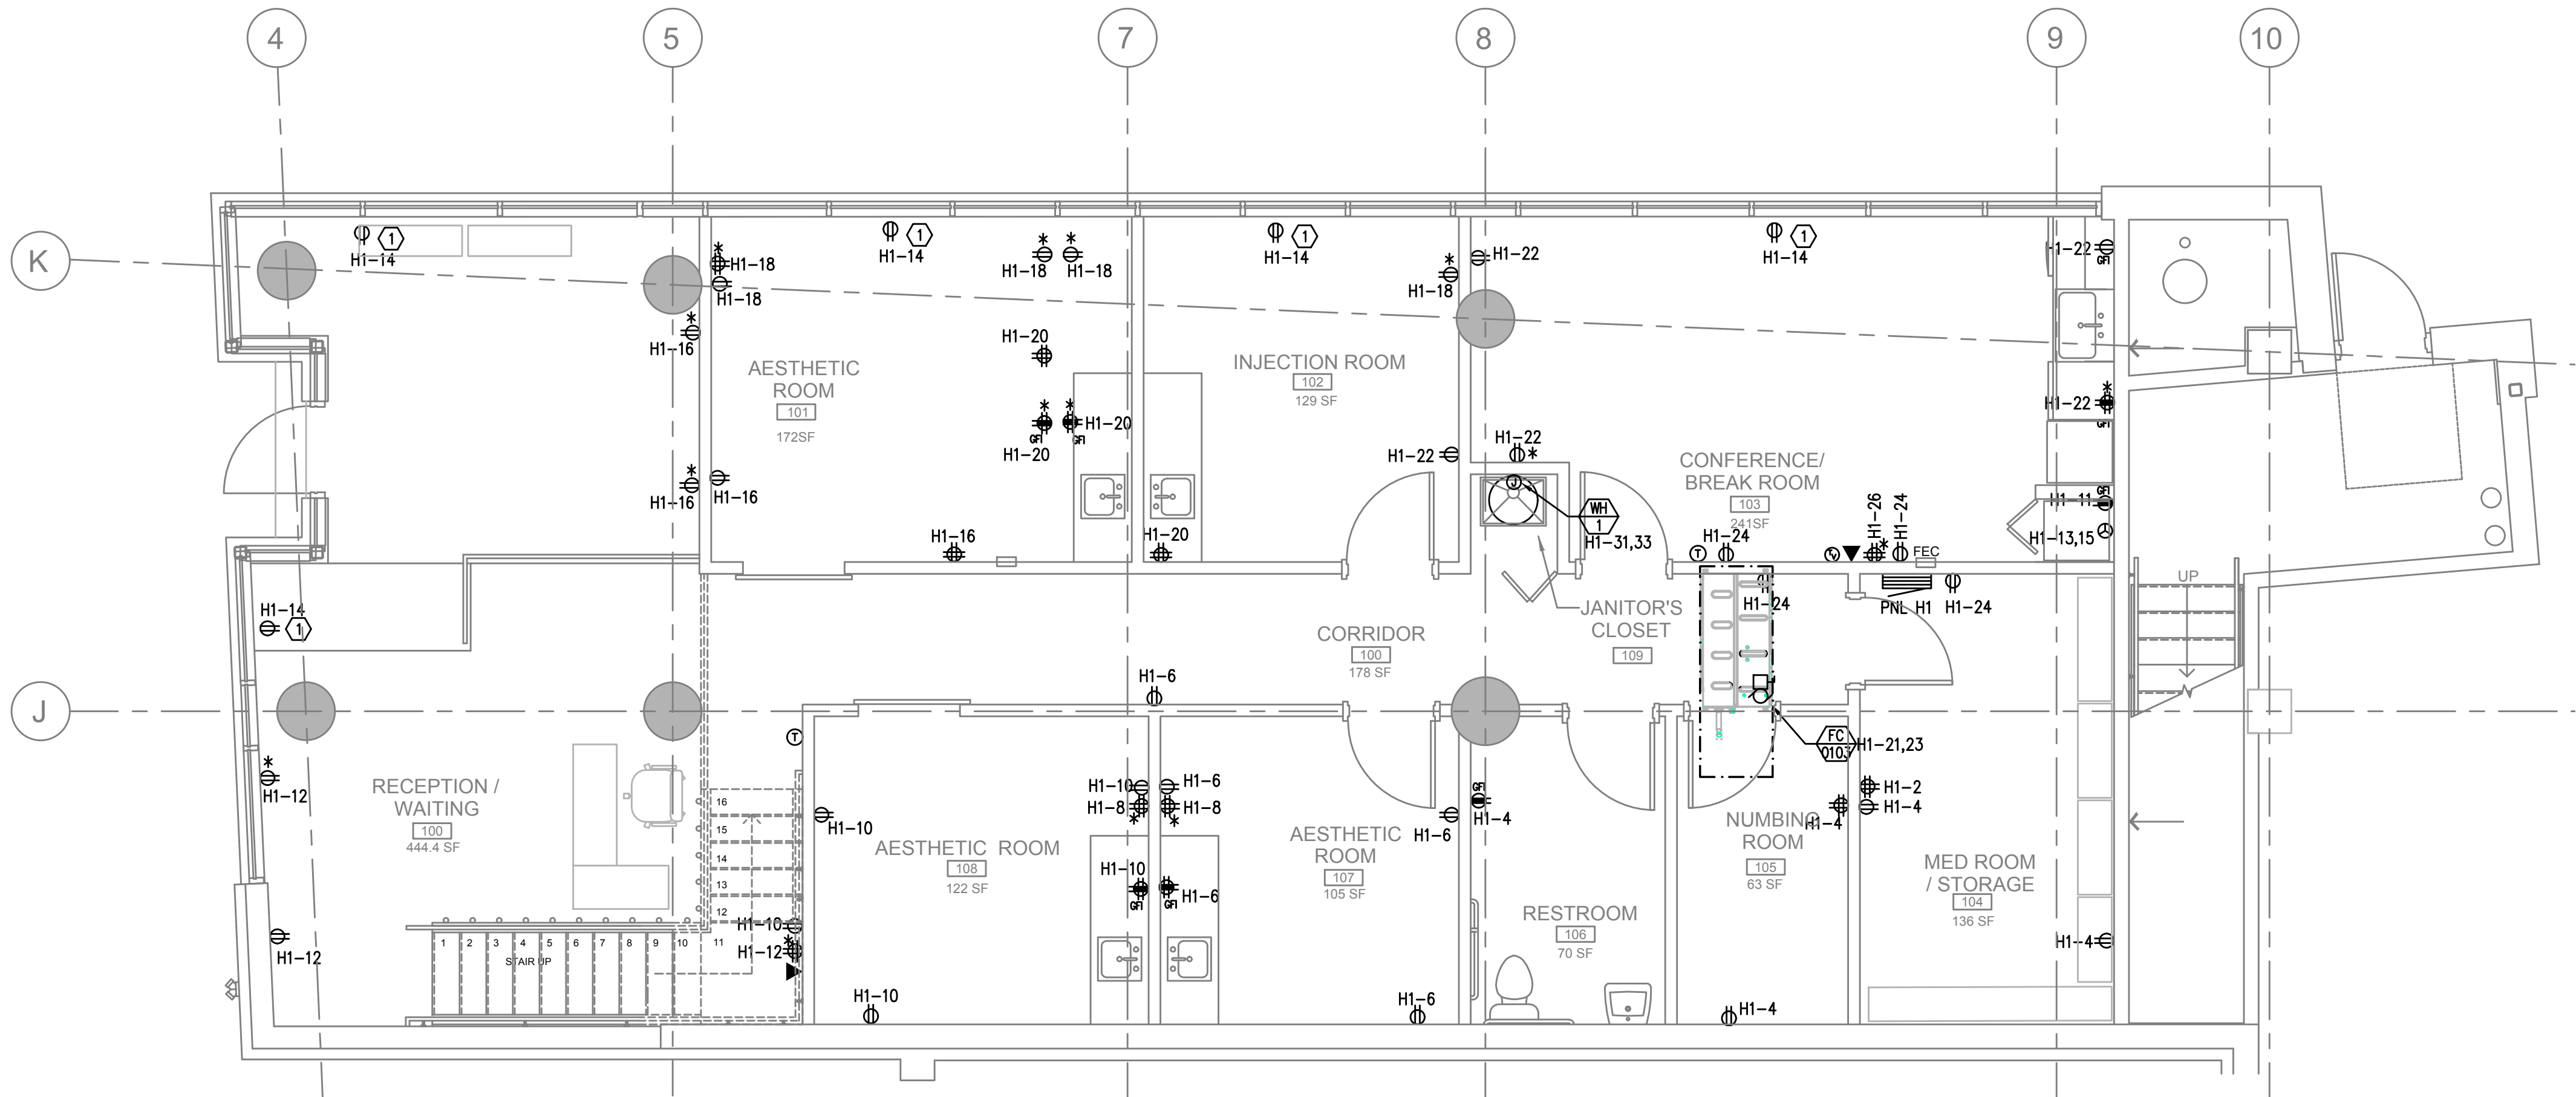

1 POWER PLAN – MAIN LEVEL
 E3.01 SCALE: 1/4" = 1'-0"

GENERAL NOTES:

- ELECTRICAL DRAWINGS ARE DIAGRAMMATICAL AND MAY NOT ACCURATELY REFLECT ACTUAL CONSTRUCTION CONDITIONS. THE ELECTRICAL CONTRACTOR SHALL BE RESPONSIBLE FOR COORDINATING THE INSTALLATION OF ALL ELECTRICAL EQUIPMENT, WITH ALL TRADES PRIOR TO AND DURING CONSTRUCTION.
- ALL WORK SHALL BE DONE IN ACCORDANCE WITH ALL APPLICABLE LOCAL, STATE & NATIONAL CODES.
- CONTRACTOR SHALL REVIEW THE DIVISION 26 SPECIFICATIONS AND THE ENTIRE DRAWING PACKAGE FOR THIS PROJECT PRIOR TO THE START OF ANY WORK.
- THE ELECTRICAL CONTRACTOR SHALL CONSULT WITH ALL OTHER TRADES AND PROVIDE THE APPROPRIATE POWER CONNECTION(S) AND COORDINATE EXACT LOCATIONS PRIOR TO ROUGH IN.
- THE ELECTRICAL CONTRACTOR SHALL IMMEDIATELY ADVISE THE ARCHITECT OF ANY DISCREPANCIES DISCOVERED WITHIN THE DOCUMENTS.
- ALL PRODUCT SUBMITTALS AND SUBSTITUTIONS SHALL BE PROVIDED TO THE ARCHITECT FOR REVIEW AND APPROVAL PRIOR TO PLACING ANY ORDERS.
- THE ELECTRICAL CONTRACTOR SHALL REFER TO THE ARCHITECTURAL DRAWINGS FOR ALL MOUNTING HEIGHTS AND FINISHES OF DEVICES AND FIXTURES.
- REFER TO INTERIOR DECORATOR AND/OR ARCHITECTURAL DRAWINGS FOR EXACT LOCATION(S) AND ELEVATIONS FOR FIXTURES & DEVICES.
- ELECTRICAL CONTRACTOR SHALL CONSULT ARCHITECTURAL AND INTERIOR DECORATOR'S PLAN DOCUMENTS SUCH AS INTERIOR ELEVATIONS, REFLECTED CEILING PLANS, ETC., FOR FIXTURE AND DEVICE DIMENSIONS NOT OTHERWISE NOTED ON THE ELECTRICAL PLANS.
- COORDINATE WITH LOCAL UTILITY PROVIDER FOR METER CONNECTION.
- ALL UTILITY WORK SHALL BE DONE IN ACCORDANCE WITH PGE ELECTRICAL SERVICE REQUIREMENTS.
- ELECTRICAL CONTRACTOR TO PROVIDE THERMOSTATS NOT SUPPLIED BY MECHANICAL CONTRACTOR. CONSULT MECHANICAL PLANS FOR ADDITIONAL INFORMATION.
- ELECTRICAL CONTRACTOR SHALL PROVIDE INSTALLATION AND FINAL CONNECTION OF THERMOSTATS. CONSULT MECHANICAL CONTRACTOR FOR EXACT REQUIREMENTS PRIOR TO ROUGH IN.
- LOW VOLTAGE DEVICES ARE SHOWN FOR REFERENCE ONLY. THE ELECTRICAL CONTRACTOR SHALL COORDINATE WITH THE SYSTEMS DESIGNER FOR EXACT LOCATION(S) AND PROVIDE ROUGH IN ONLY.

PER WASHINGTON STATE ENERGY CODE C405.10, AT LEAST 50% OF THE RECEPTACLES IN THIS SPACE SHALL BE 'CONTROLLED'. RECEPTACLES NOTED WITH '*' SHALL BE CONTROLLED VIA CEILING MOUNTED OCCUPANCY SENSOR AND SHALL 'TURN OFF' AFTER A MINIMUM OF 30 MINUTES OF IN-ACTIVITY WITHIN THE SPACE. PROVIDE APPROPRIATE IDENTIFICATION OF EACH CONTROLLED RECEPTACLE. REFER TO THE PANEL SCHEDULES ON E1.12 FOR ADDITIONAL INFORMATION ON WHICH CIRCUIT IS TO BE THE CONTROLLED CIRCUIT.

○ KEYED NOTES:

- RECEPTACLE TO BE MOUNTED ABOVE SHOW WINDOW AS REQUIRED BY CODE.