

Oregon State Correctional Institution (OSCI)

Oregon Department of Corrections

3405 Deer Park Dr. SE, Salem, Oregon
97310

FIRE SPRINKLER UPGRADES




Date:	1-27-20
Proj. No.:	9835
Drawn By:	MD
Chkd By:	MD
DSGN By:	MD
Acad File:	9835-5M10

Drawing Index:

M1.0 Cover Sheet/Scope of Work
M1.1 Site plan - overall key plan

REFERENCE PDFS.

- 000 OSCI FIRE SPRINKLER DRAWINGS-FINAL DESIGN 05-24-13.PDF
- OSCI SITE FIRE LINE AS-BUILT 05-24-13.PDF
- CLASSROOM REMODEL:
APPROVED PLANS 19-110774-BP-REV1.PDF

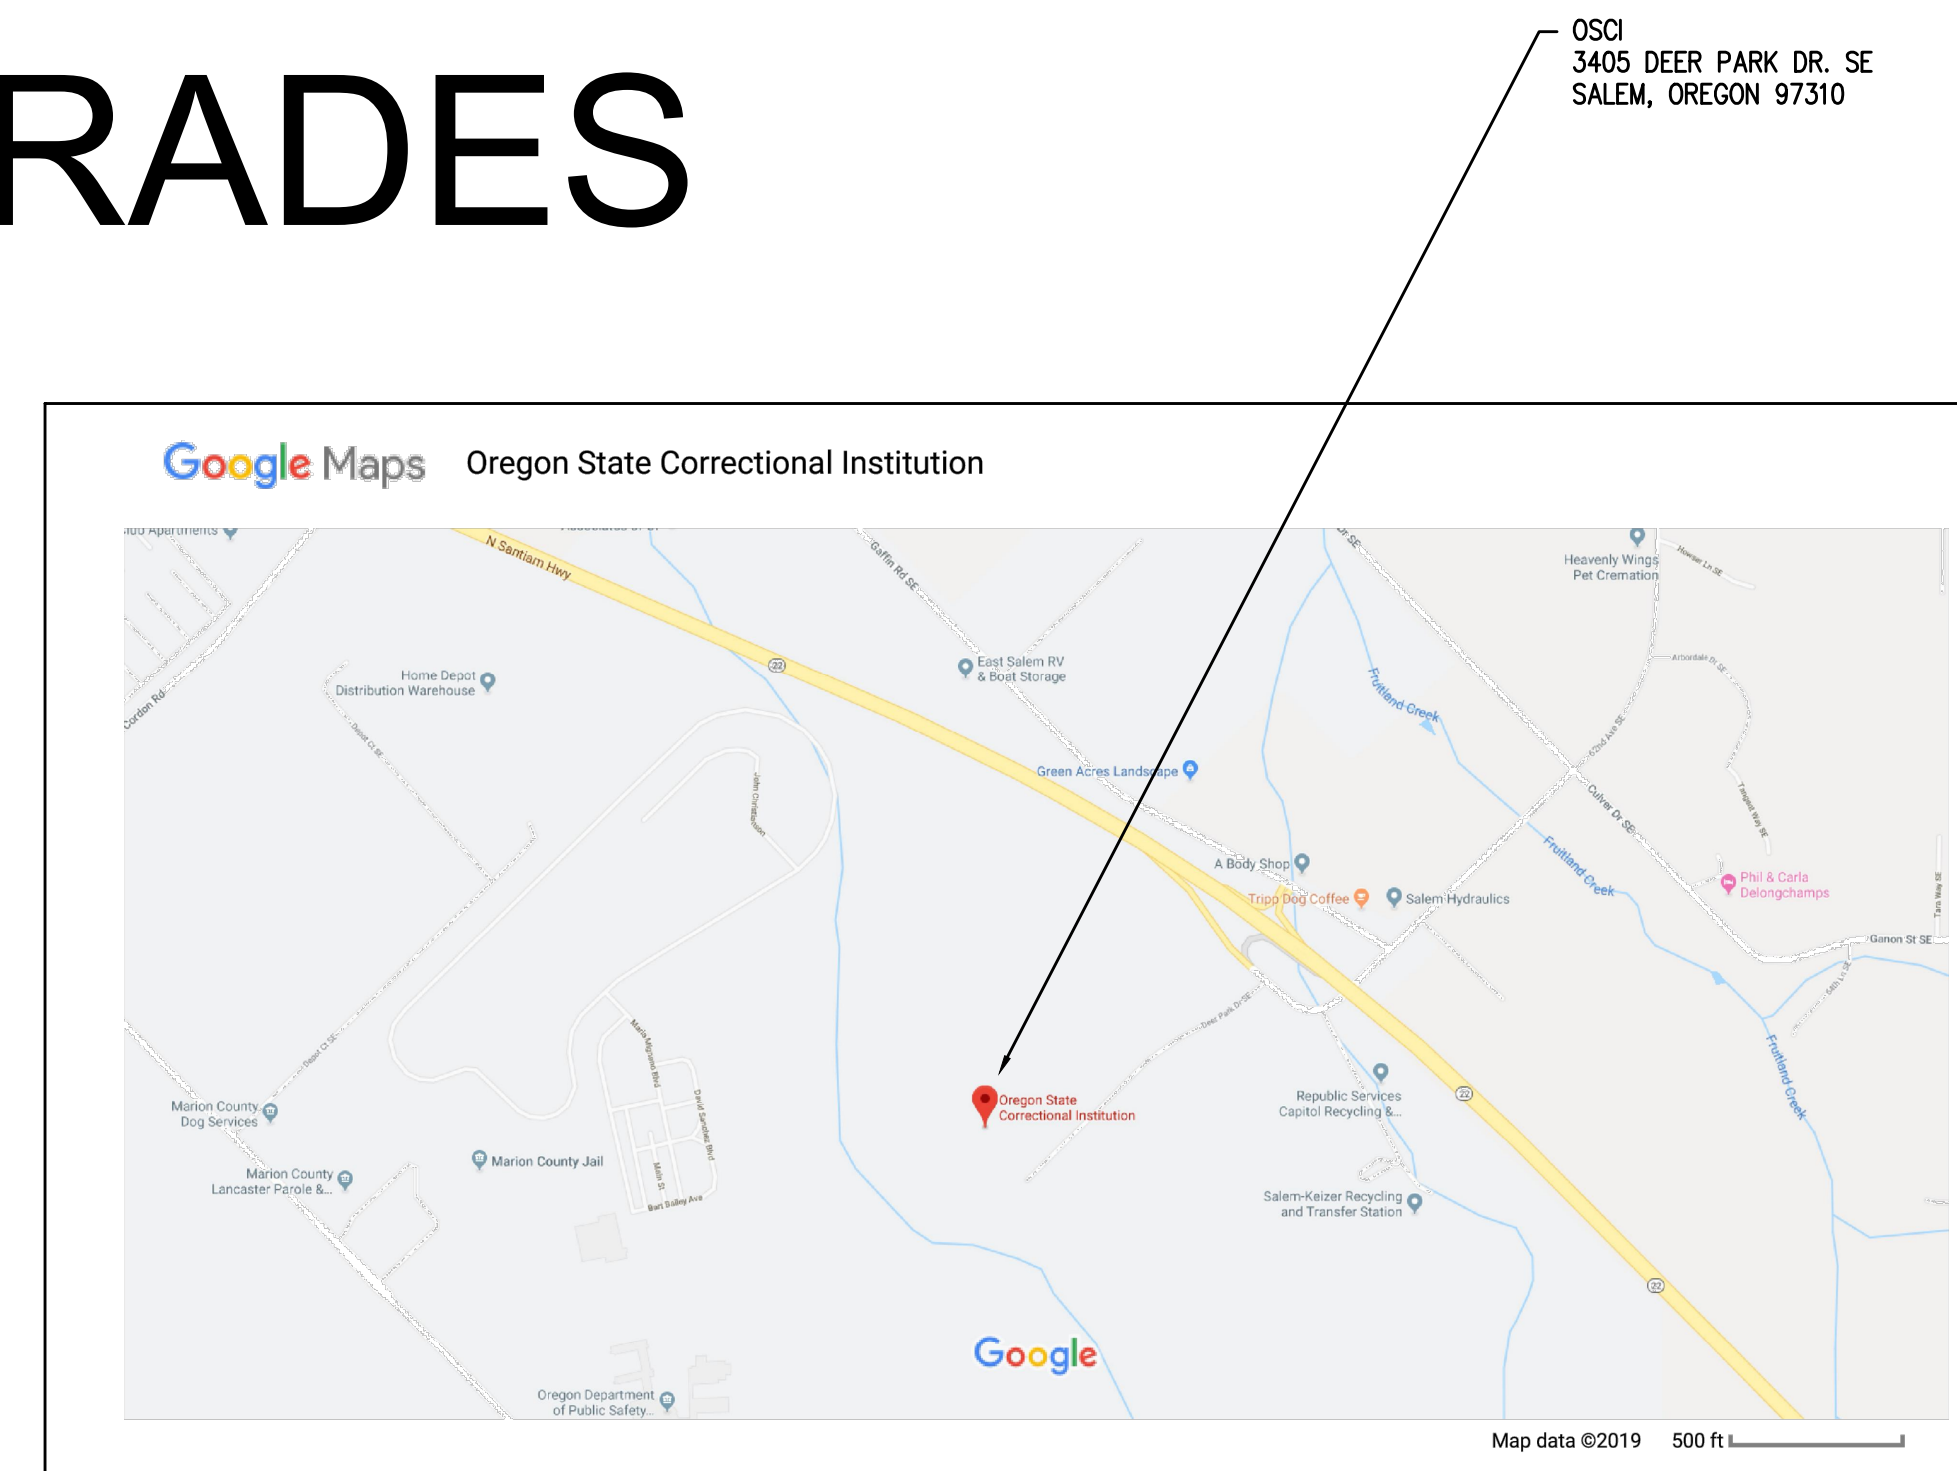

OREGON STATE CORRECTIONAL INSTITUTION
FIRE SPRINKLER UPGRADES
OREGON DEPT OF CORRECTIONS
 OREGON
 SALEM
 COVER SHEET

PROJECT SCOPE OF WORK:

FIRE SPRINKLERS UPGRADES & MODIFICATION:

- INSTALL FIRE SPRINKLERS IN ALL BUILDINGS AS SHOWN ON THE SITE PLAN.
- CONNECT TO EXISTING BUILDING RISER CONNECTION POINTS AS SHOWN ON THE REFERENCE DRAWINGS.
- SEE WESTECH AND FIRE SYSTEMS WEST REFERENCE DRAWINGS AND WESTECH AS-BUILT SITE DRAWINGS FOR UNDERGROUND FIRE MAINS.
- CONTRACTOR RESPONSIBLE FOR DESIGN AND INSTALLATION OF ALL FIRE SPRINKLER SYSTEMS. DESIGN TO BE COMPLETED UNDER A P.E.
- REFERENCE DRAWING ARE SUPPLIED FOR GENERAL SYSTEM REFERENCE ONLY, DESIGN BUILD CONTRACTOR RESPONSIBLE FOR ALL DESIGN AND INSTALLATION.

PROJECT NOTES AND BID ALTERNATES:

FIRE SPRINKLERS UPGRADES & MODIFICATION:

- SITE WORK IS COMPLETE, TO THE POINT OF FIRE MAIN ENTERING THE BUILDING.
- PHASE I WORK OF SPRINKLER RISER AND SPRINKLER MAIN DOWN HALLWAY IS NOT COMPLETE.
- CONTRACTOR TO BID EACH PHASE SHOWN ON THE G2 DRAWINGS AS BID ALTERNATES:
 - BASE BID =
 - PHASE I (HALLWAY AND RISER)
 - PHASE X (UNIT 6-HEALTH)
 - PHASE XIV (UNIT 13-IMPAIRED MOBILITY)
- DESIGN CLASSROOM FIRE SPRINKLERS PER THE BUILDING LAYOUT IN THE ATTACHED REFERENCE CLASSROOM UPGRADES PROJECT.



Consulting Engineers
 2007 S.E. Ash St.
 Portland, OR 97214
 (503) 234-0548

SHEET
M1.0
 OF 0000