
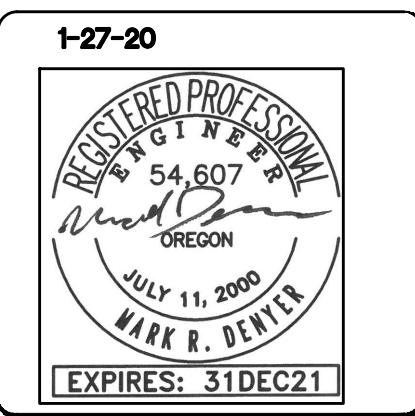


**SHEET NOTES:**

- (A) — PROVIDE FIRE SPRINKLERS FOR ALL BUILDINGS SHOWN WITH A HATCHED BOUNDARY. SEE REFERENCE AS-BUILT DRAWINGS FOR COMPLETED SITE WORK.
- (B) — BASE BID WORK TO INCLUDE
  - MAIN BUILDING RISER
  - HALLWAY SUPPLY MAIN WITH SIDE WALL HEADS
  - UNIT 6 HEALTH DEPARTMENT
  - UNIT 13 IMPAIRED MOBILITY UNIT.

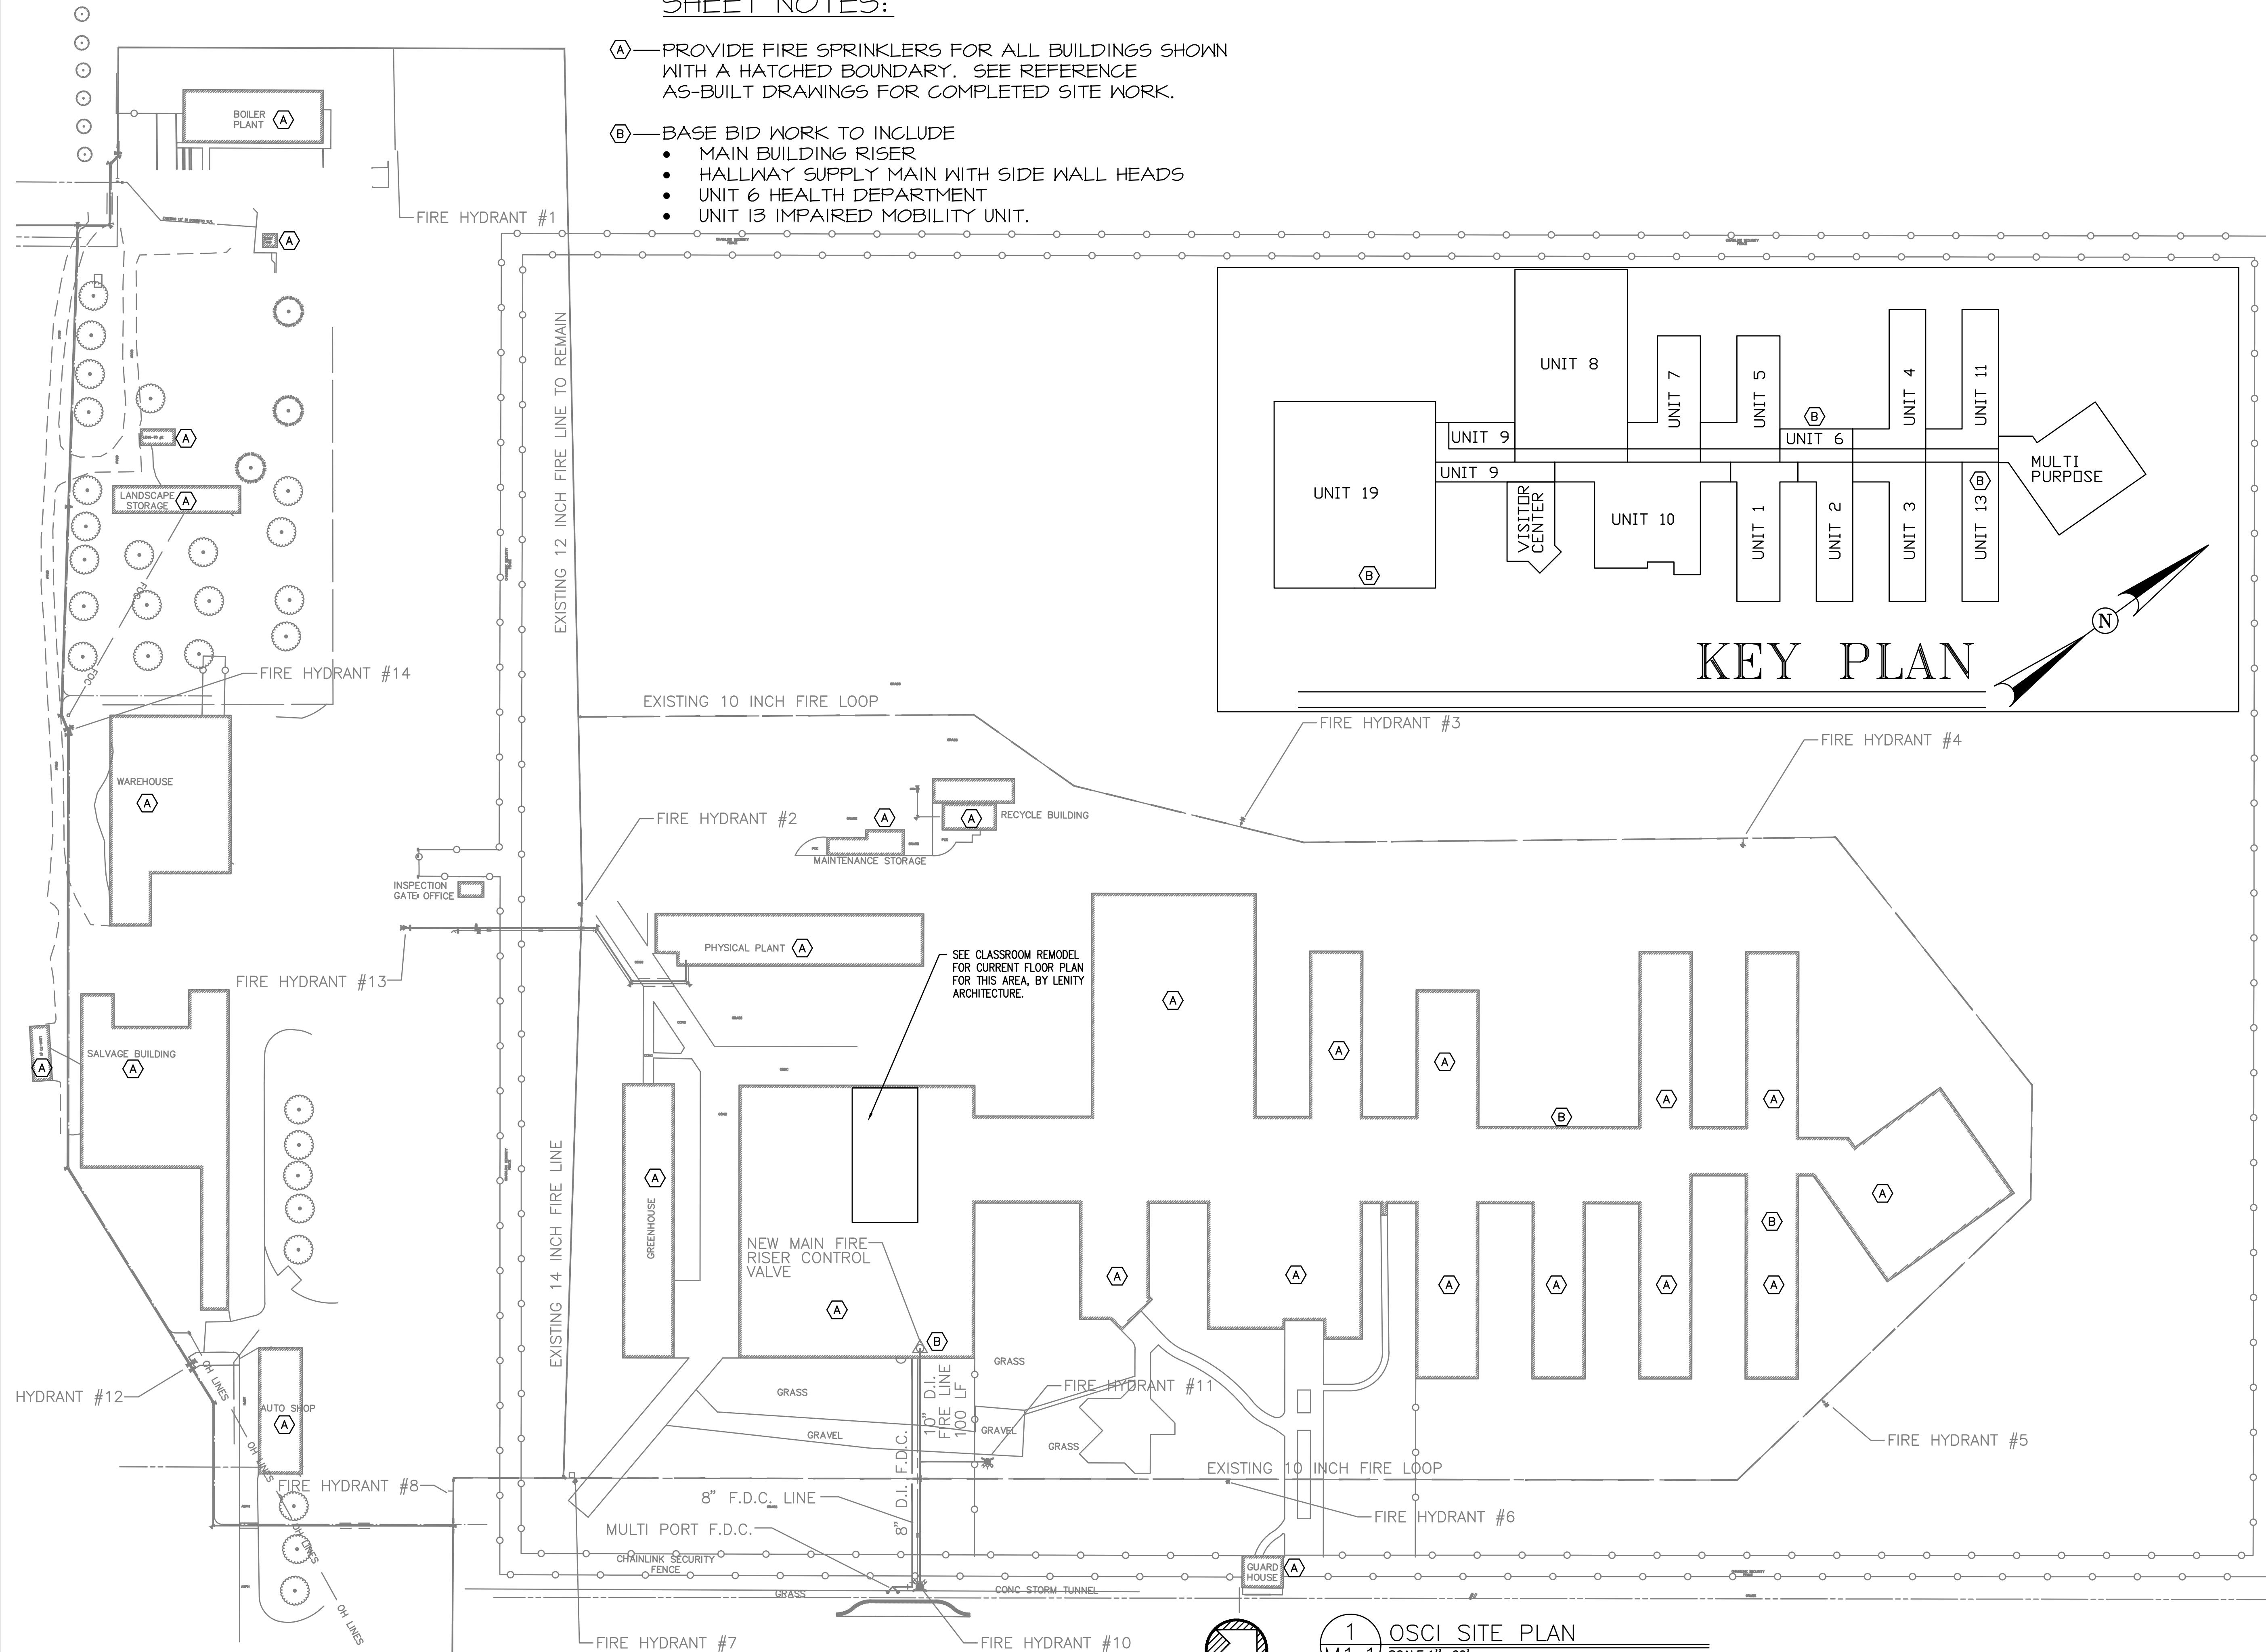

Date:	1-27-20
Proj No:	9835-5
Drawn By:	MD
Chkd By:	MD
DSGN By:	MD
Acad File:	9835-5M11

**OREGON STATE CORRECTIONAL INSTITUTION**  
**FIRE SPRINKLER UPGRADES**  
**OREGON DEPT OF CORRECTIONS**

OREGON  
SALEM

SITE PLAN



Consulting Engineers  
 2007 S.E. Ash St.  
 Portland, OR 97214  
 (503) 234-0548

SHEET  
**M1.1**  
 OF 8