


1 HVAC ROOF DEMO PLAN - SECTOR A
 DM2.1 SCALE: 1/16"=1'-0"

1
 SHEET IS REVISED PER ADDENDUM #2

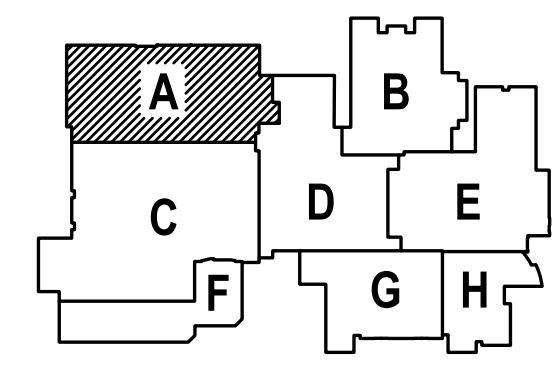

1 -ADDENDUM #2
 2/22/2018

MFA Consulting Engineers
 2007 S.E. Ash St.
 Portland, OR 97214
 PHN: (503) 234-0548
 FAX: (503) 234-0677
 WWW.MFA-ENG.COM
 CONTACT: Elena von Kamens

A NEW REMODEL PROJECT FOR:

SHERWOOD HIGH SCHOOL

16956 SW MEINCKE ROAD SHERWOOD, OR

REGISTERED PROFESSIONAL
 ARCHITECT
 1788
 SCOTT W. MILLER
 EXPIRES: 31DEC18

DRAWN BY:	EVK
CHECKED BY:	SWM
DATE:	1-30-18
TITLE:	HVAC ROOF DEMO PLAN- SECTOR A
SCALE:	1/16" = 1'-0"

SHEET NO:	DM-2.1
OF	7




615 SE JACKSON STREET
PORTLAND, OR 97214
503.472.8273 OFFICE
503.472.7560 FAX
P.L.B. @ PAULBENTLEYARCHITECT.COM

PAUL L BENTLEY Architect A.I.A. P.C.

▲ -ADDENDUM #2
2/22/2018


MFI Consulting Engineers
2007 S.E. Ash St.
Portland, OR 97214
PHN: (503) 234-0548
FAX: (503) 234-0677
INC. WWW.MFI-ENG.COM
CONTACT: Elena von Kamens

A NEW REMODEL PROJECT FOR:
SHERWOOD HIGH SCHOOL
16956 SW MEINCKE ROAD
SHERWOOD, OR

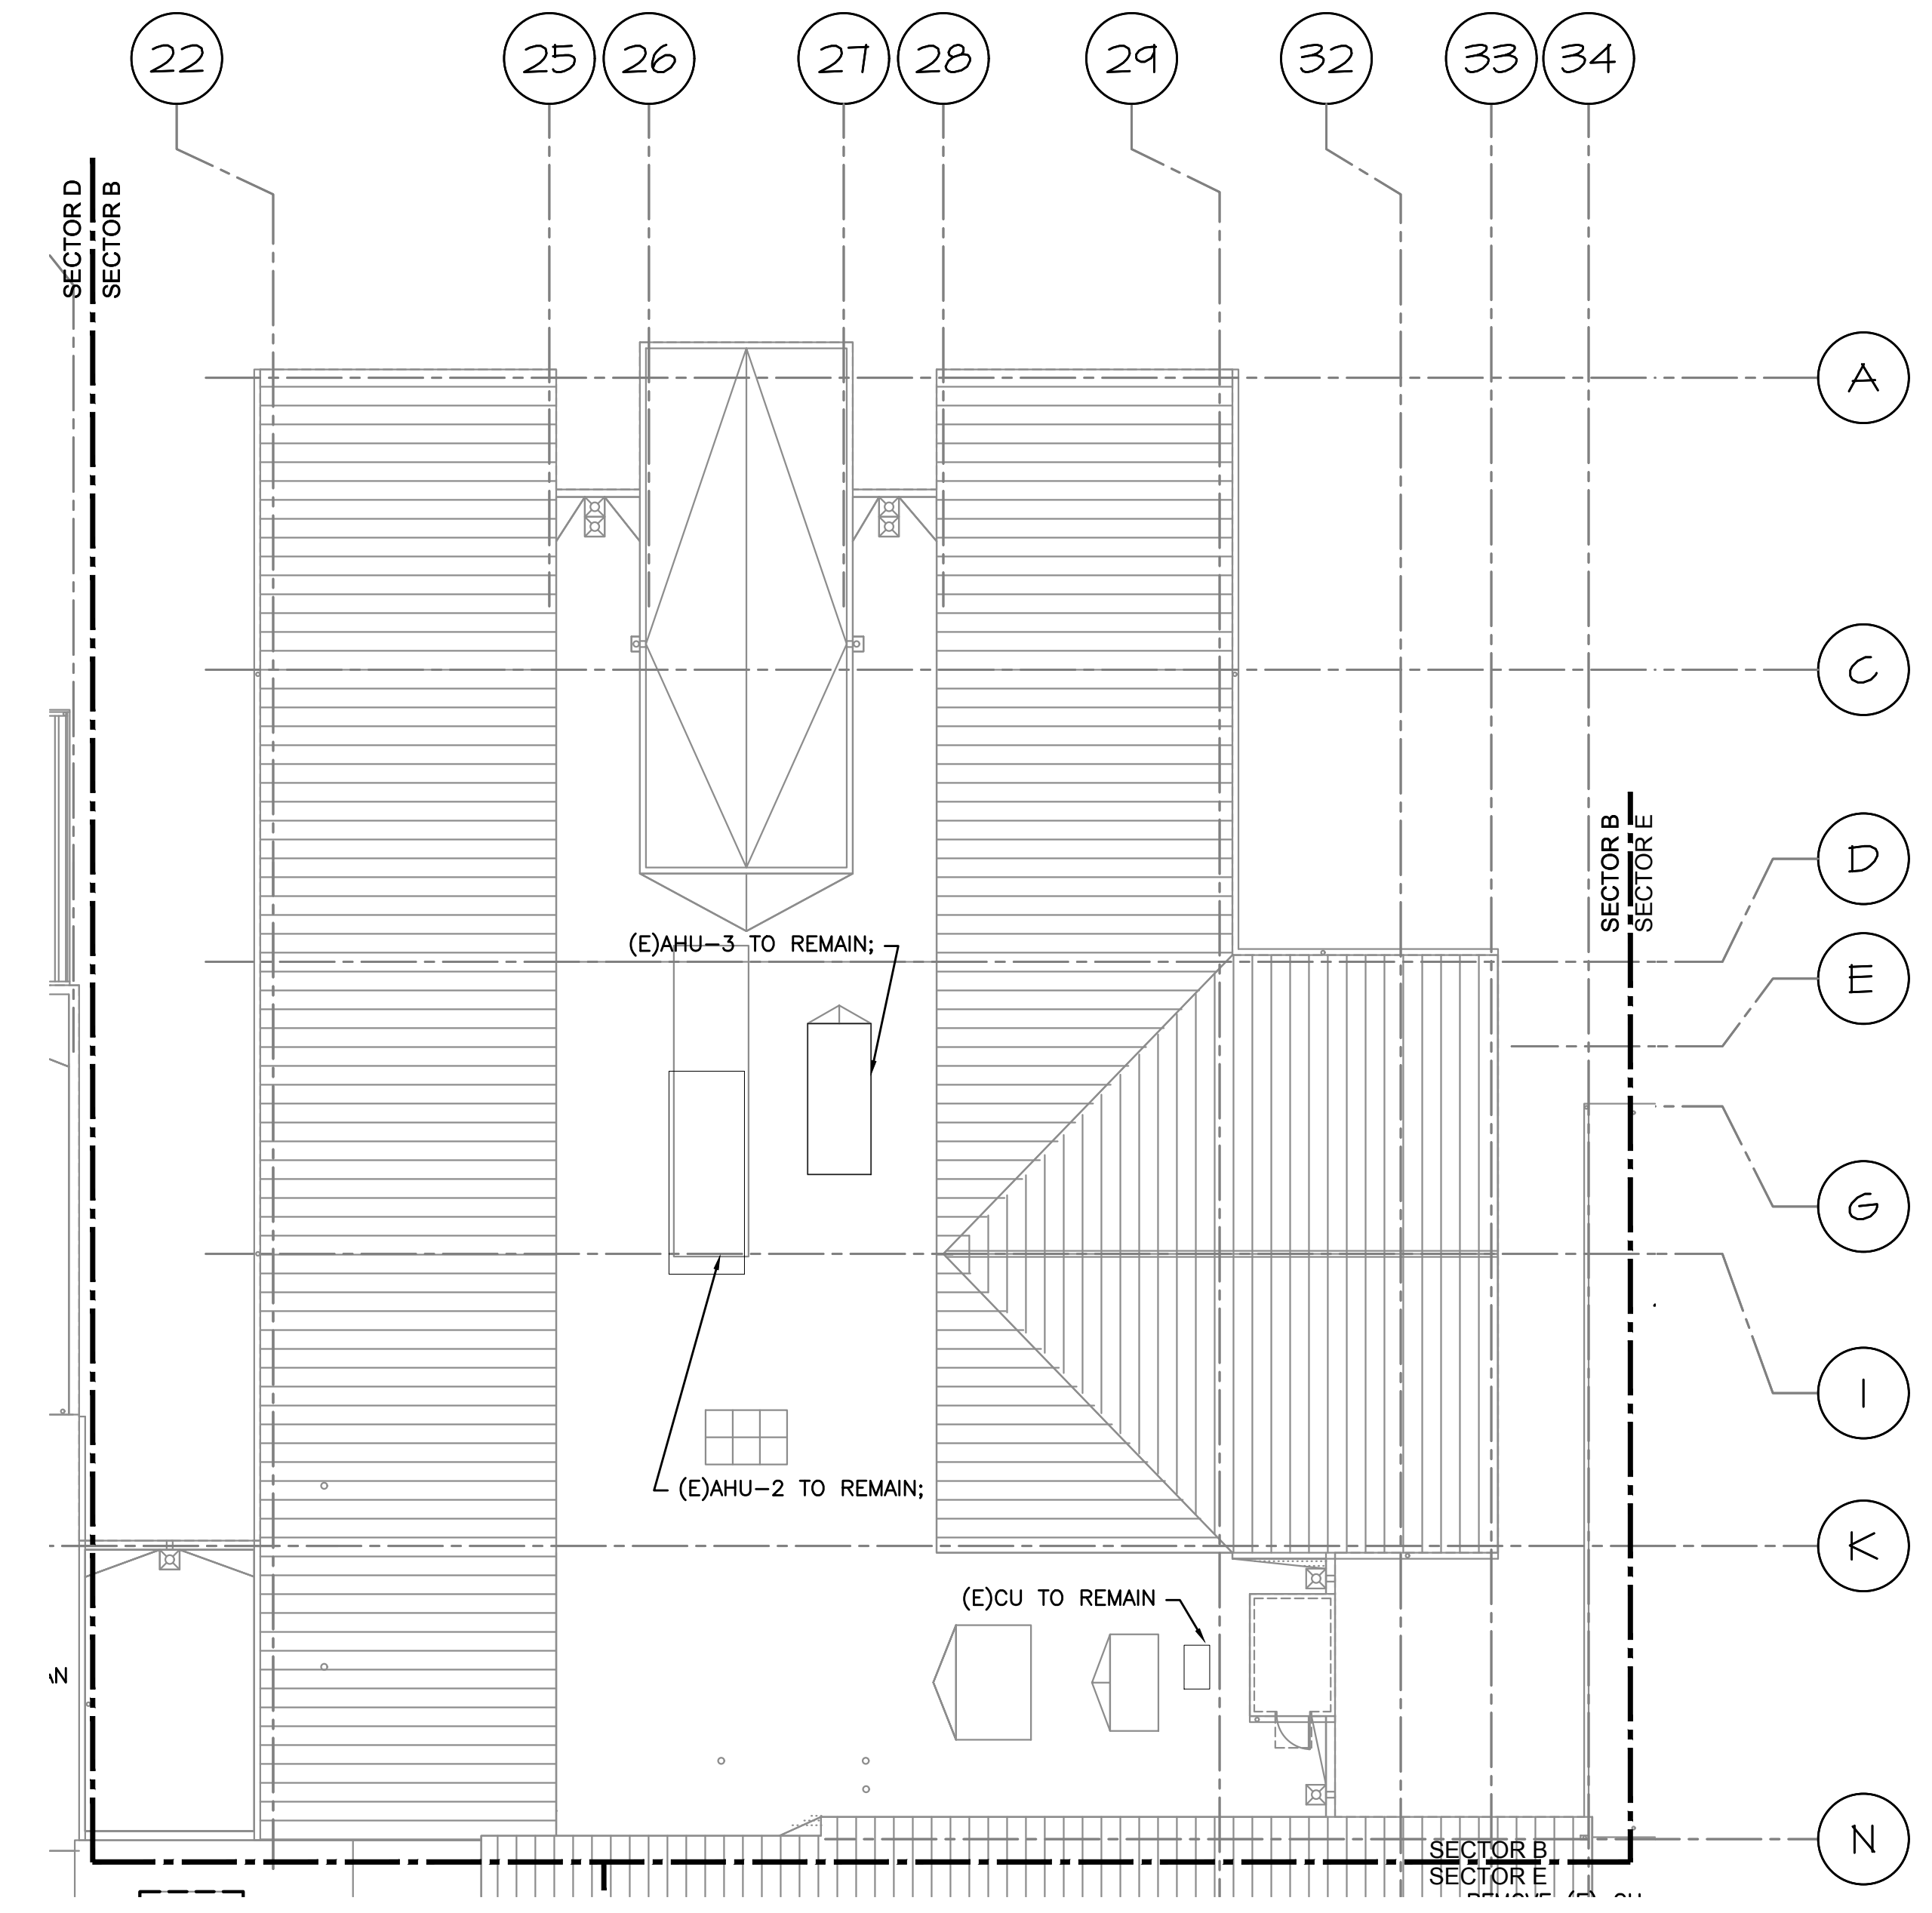


1 HVAC ROOF PLAN-SECTOR B
DM2.2 SCALE: 1/16"=1'-0"

▲
SHEET IS REVISED PER ADDENDUM #2

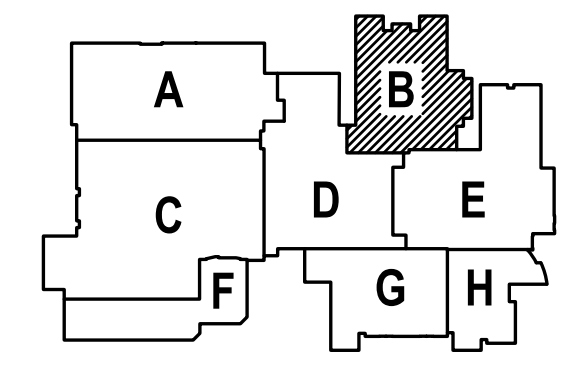

DRAWN BY:	EVK
CHECKED BY:	SWM
DATE:	1-30-18
TITLE:	HVAC ROOF DEMO PLAN-SECTOR B
SCALE:	1/16 = 1'-0"

SHEET NO:	DM-2.2
OF	7

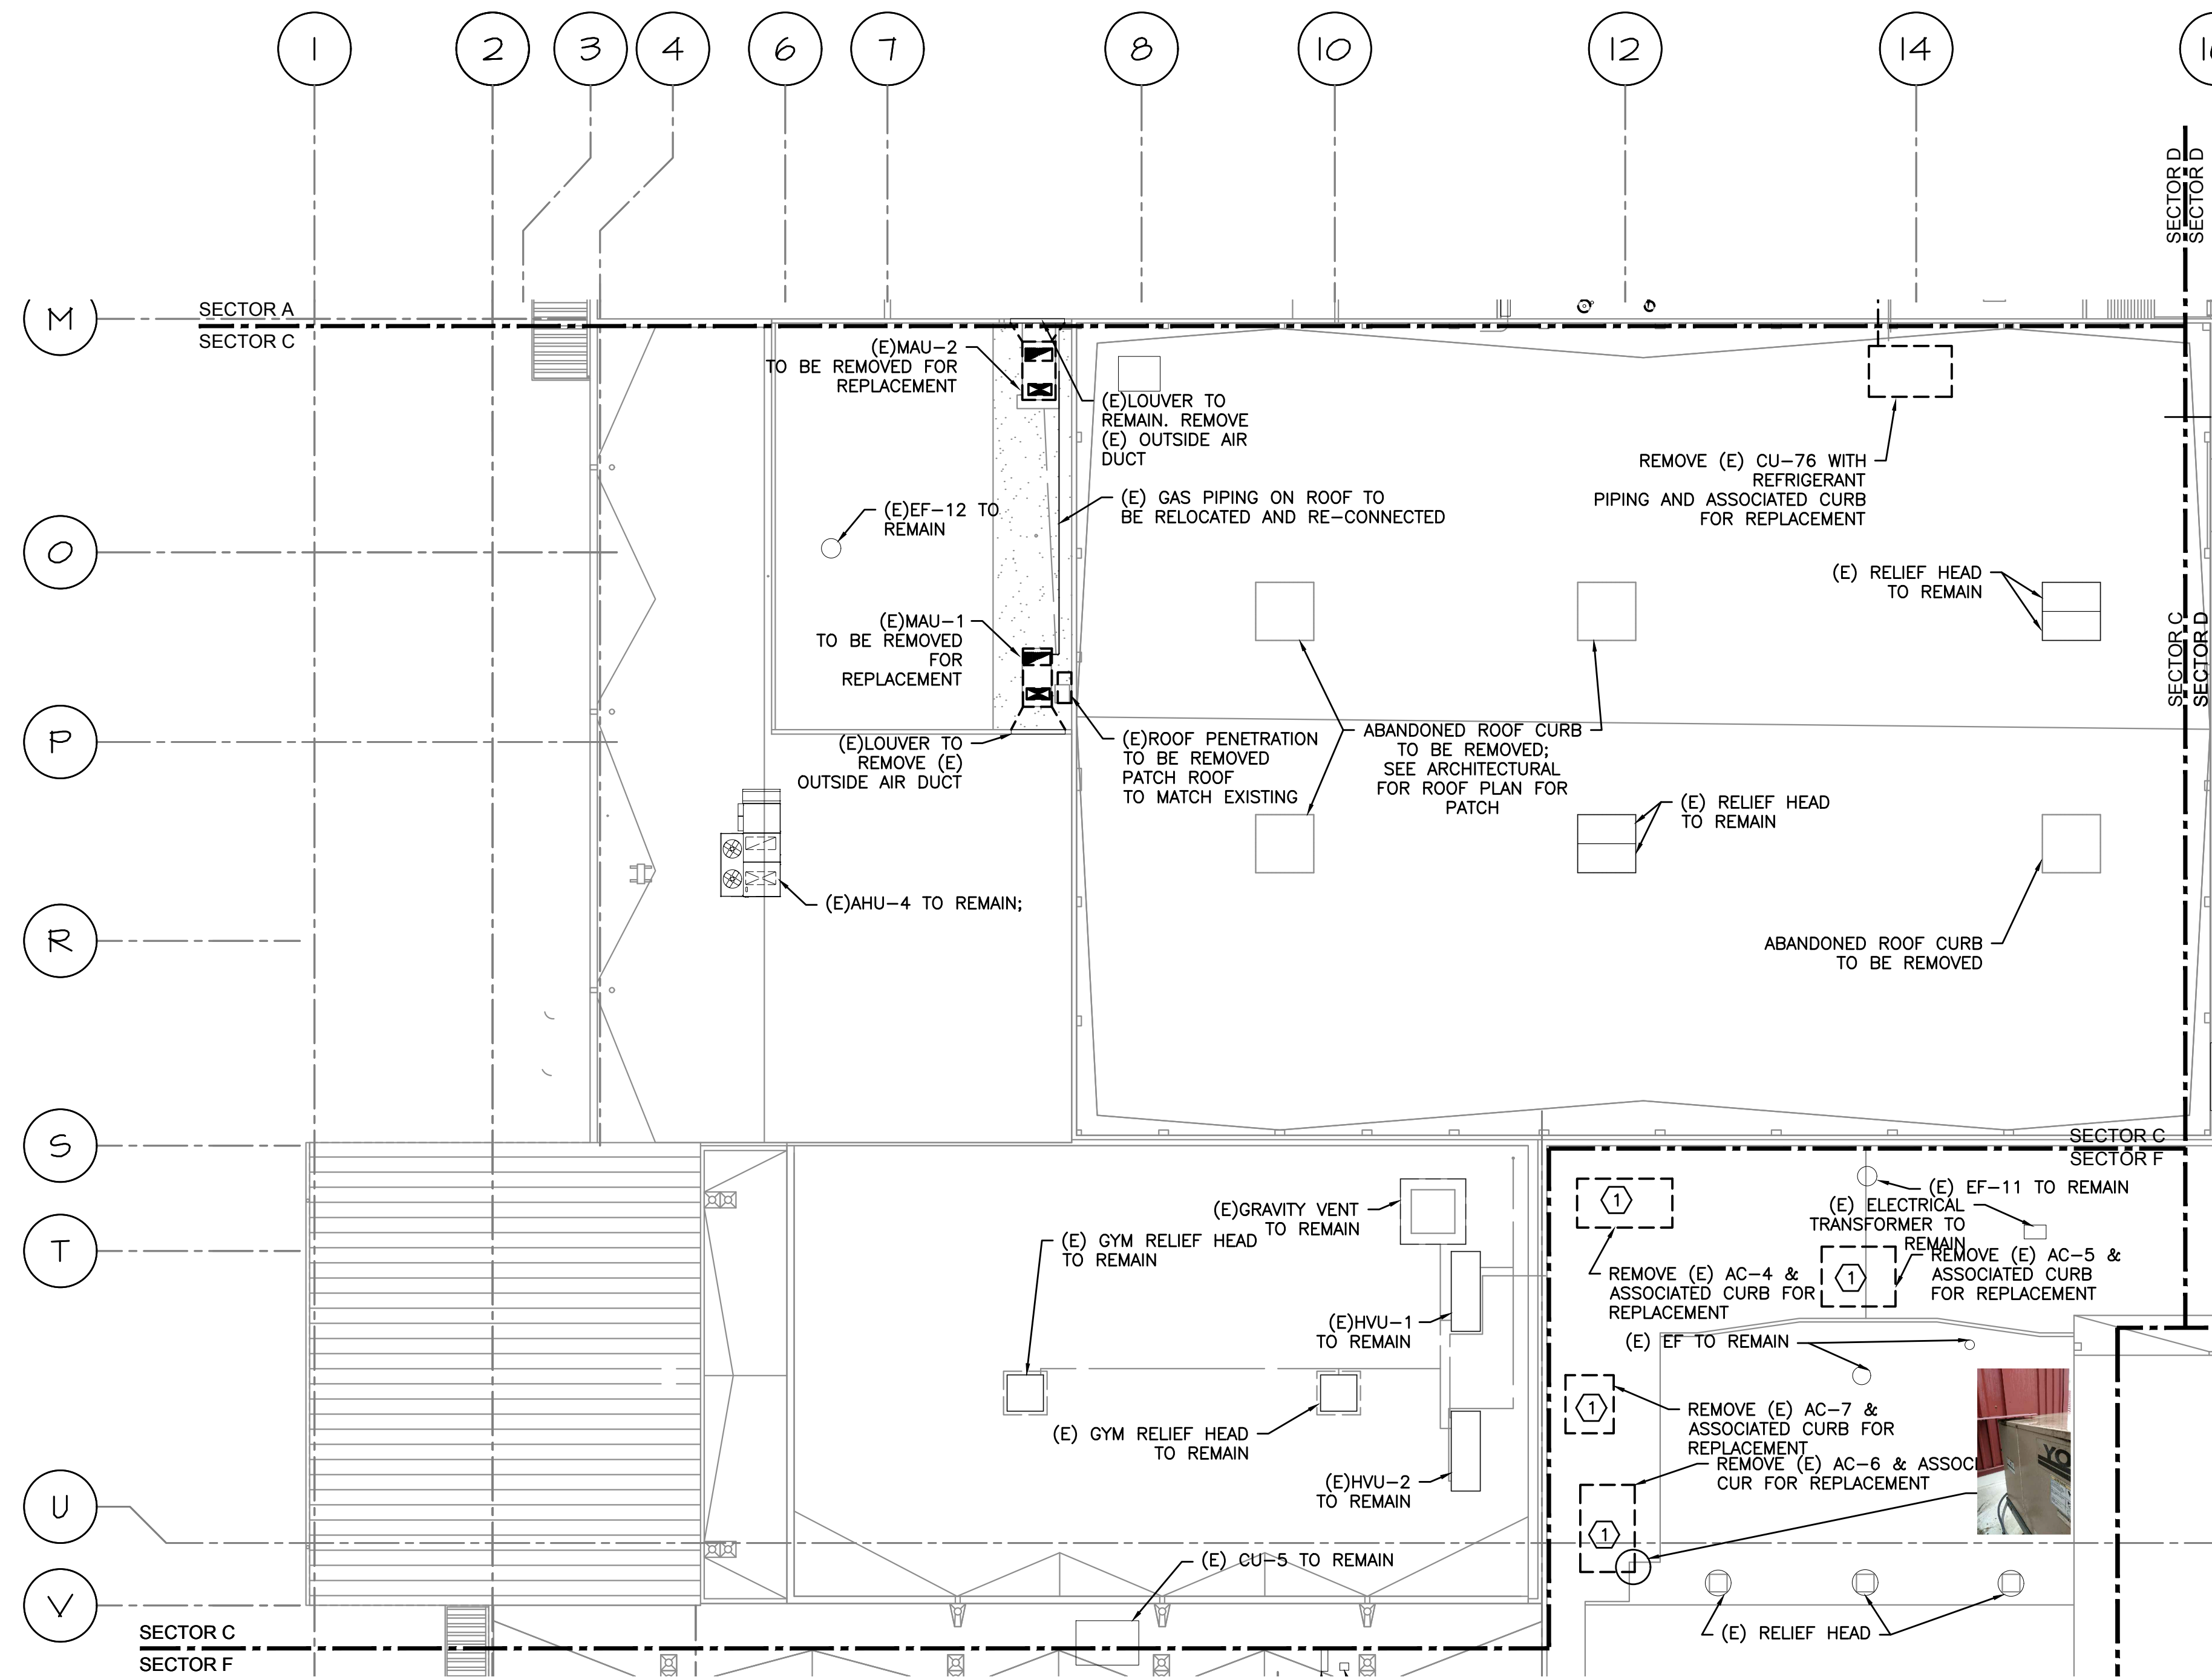


1 HVAC ROOF DEMO PLAN-SECTOR C
DM2.3 SCALE: 1/16"=1'-0"

KEYED NOTES:

① - SALVAGE AUTOMATED LOGIC CONTROLLER FOR RE-USE IN NEW UNIT.

△ SHEET IS REVISED PER ADDENDUM #2

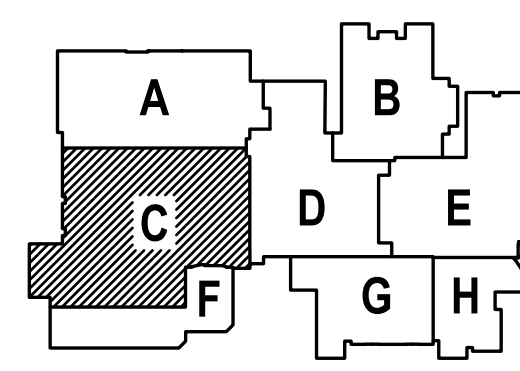

A NEW REMODEL PROJECT FOR:
SHERWOOD HIGH SCHOOL
16956 SW MEINCKE ROAD
SHERWOOD, OR



DRAWN BY:	EVK
CHECKED BY:	SWM
DATE:	1-30-18
TITLE:	HVAC ROOF DEMO PLAN- SECTOR C
SCALE:	1/16" = 1'-0"

SHEET NO:	DM-2.3
OF	7



615 SE JACKSON STREET
 PORTLAND, OR 97214
 503.234.8273 OFFICE
 503.234.7560 FAX
 paul@paulbentleyarchitect.com

PAUL L BENTLEY Architect A.I.A. P.C.

▲ -ADDENDUM #2
 2/22/2018

M
 FIA
 INC. Consulting Engineers
 2007 S.E. Ash St.
 Portland, OR 97214
 PHN: (503) 234-0548
 FAX: (503) 234-0677
 WWW.MFIA-ENG.COM
 CONTACT: Elenc von Kamens


A NEW REMODEL PROJECT FOR:
SHERWOOD HIGH SCHOOL

16956 SW MEINECKE ROAD SHERWOOD, OR




DRAWN BY: EVK
 CHECKED BY: SWM
 DATE: 1-30-18
 TITLE: HVAC ROOF DEMO PLAN-SECTOR D
 SCALE: 1/16" = 1'-0"


SHEET NO:
DM-2.4
 OF 7

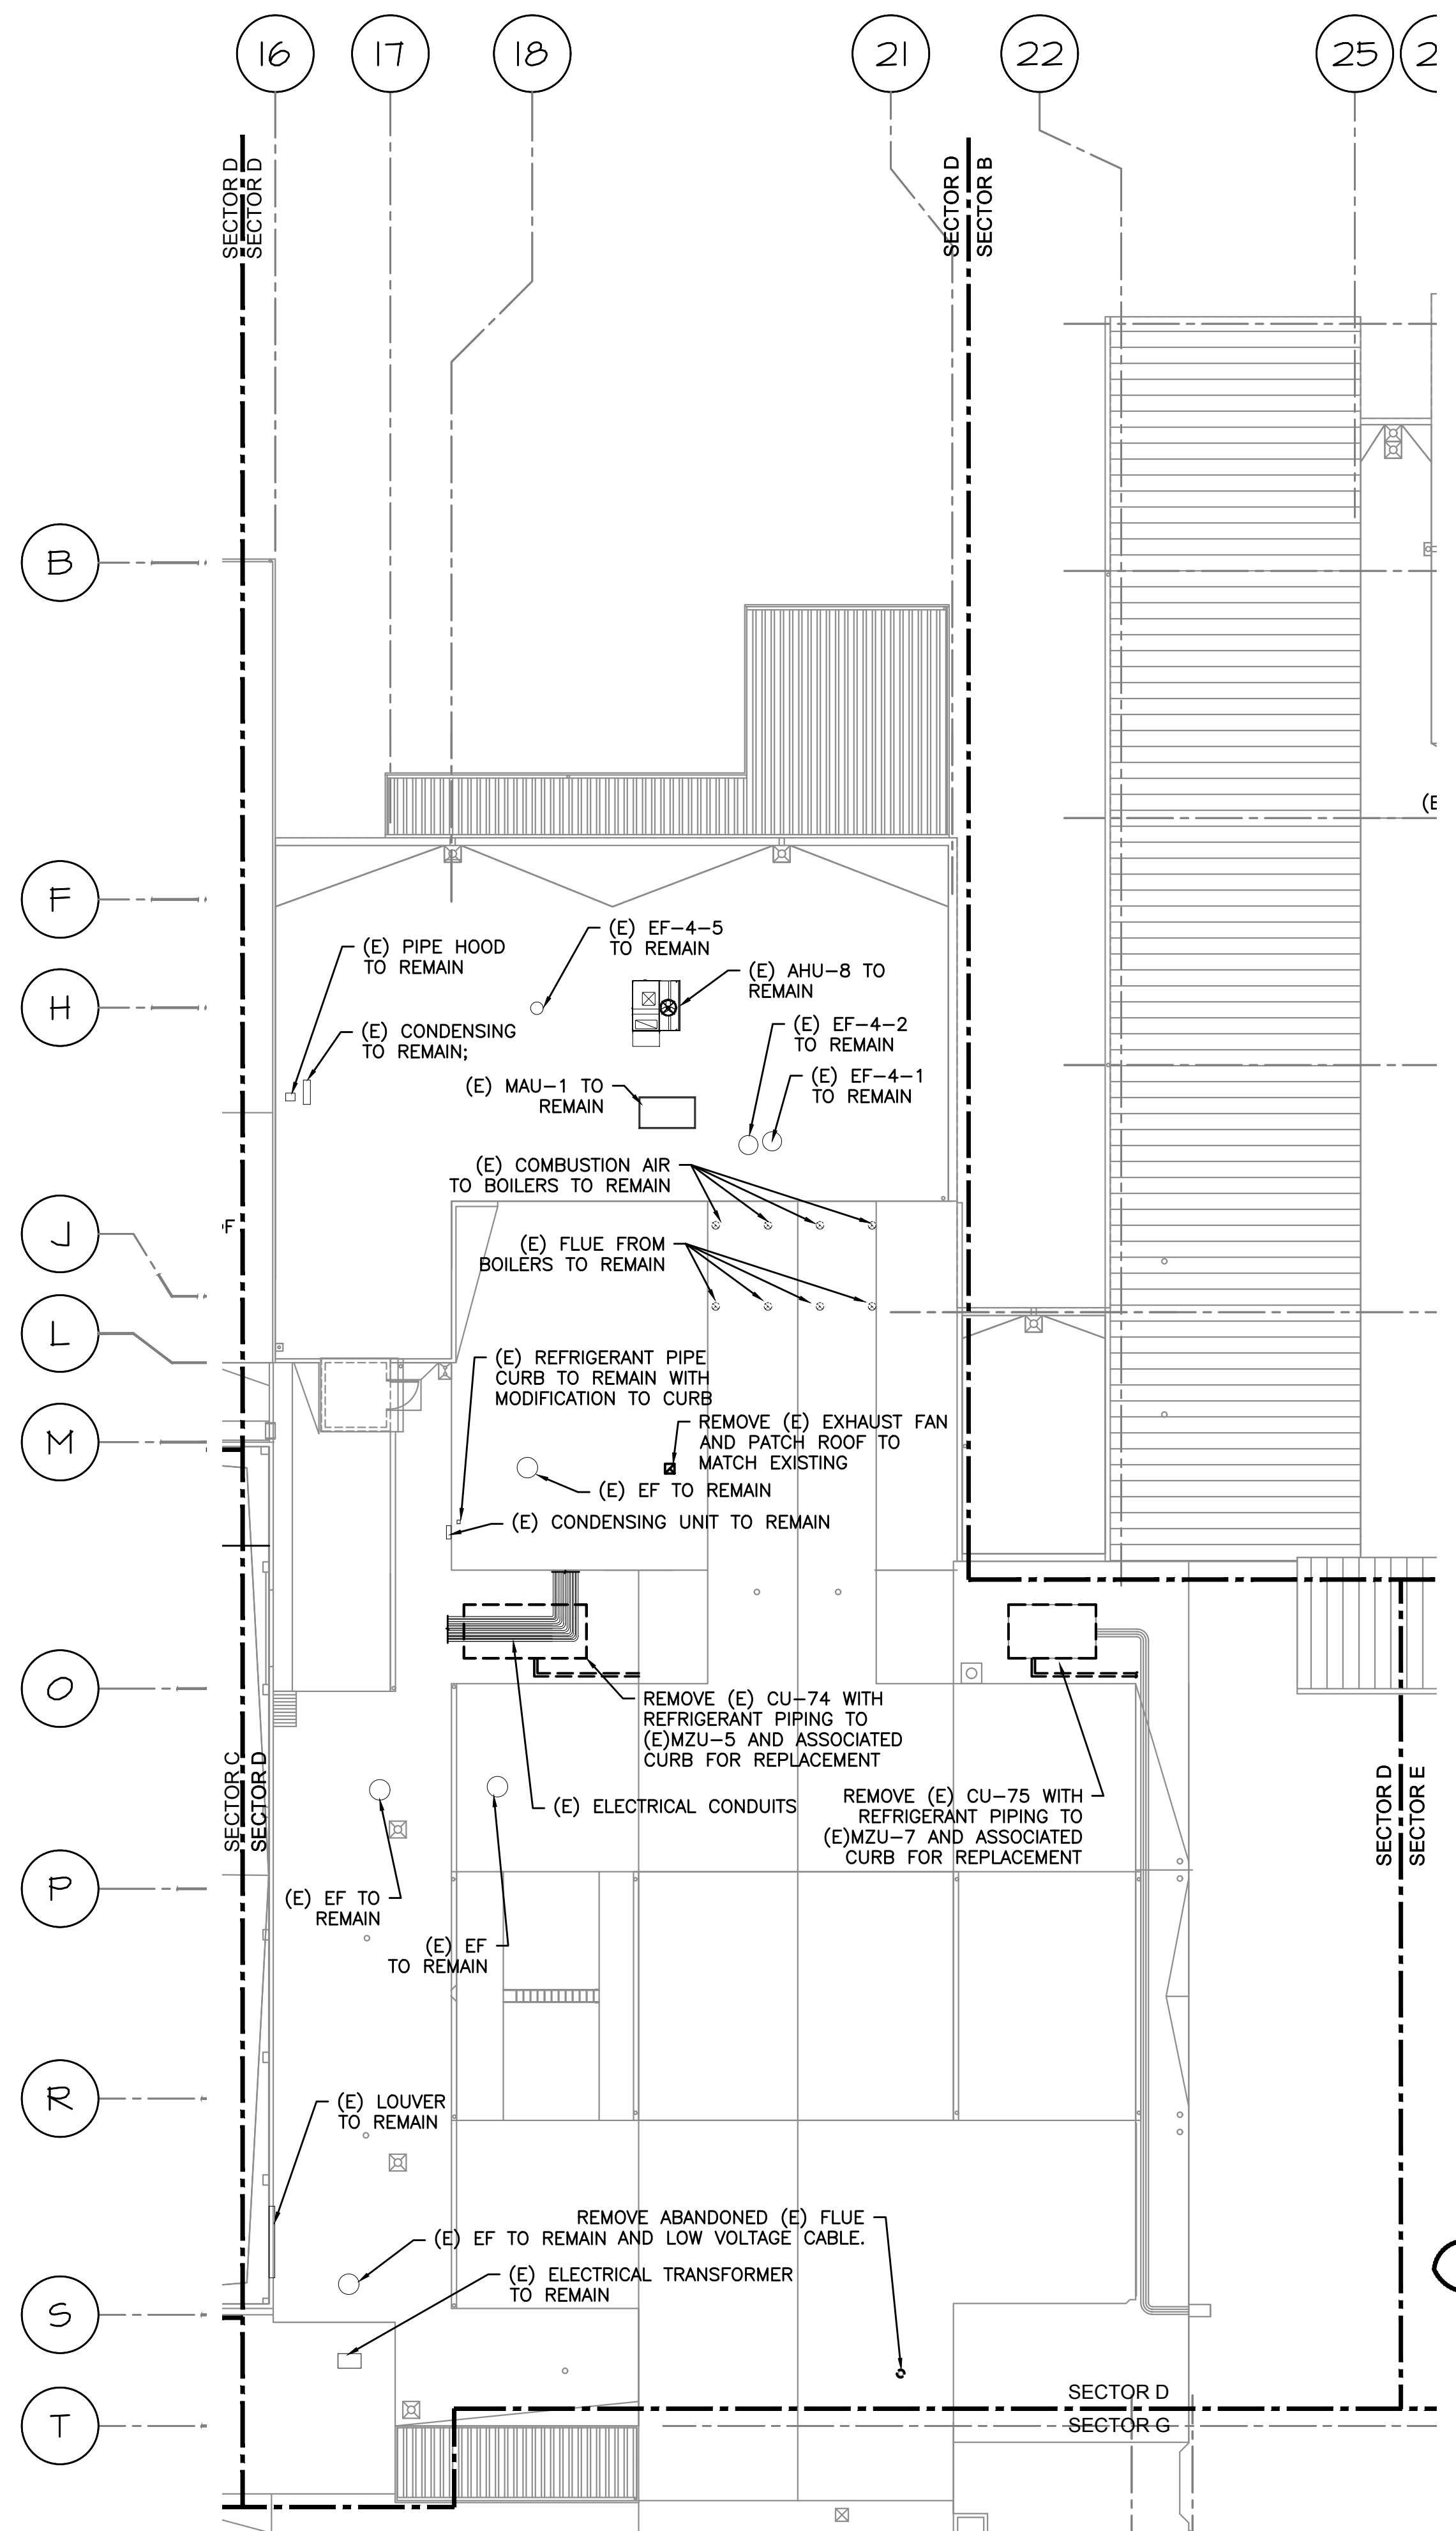

▲ SHEET IS REVISED PER ADDENDUM #2

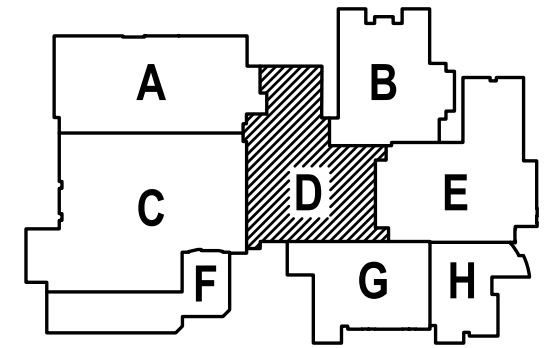


1 HVAC ROOF DEMO PLAN-SECTOR D
 DM2.4 SCALE: 1/16"=1'-0"

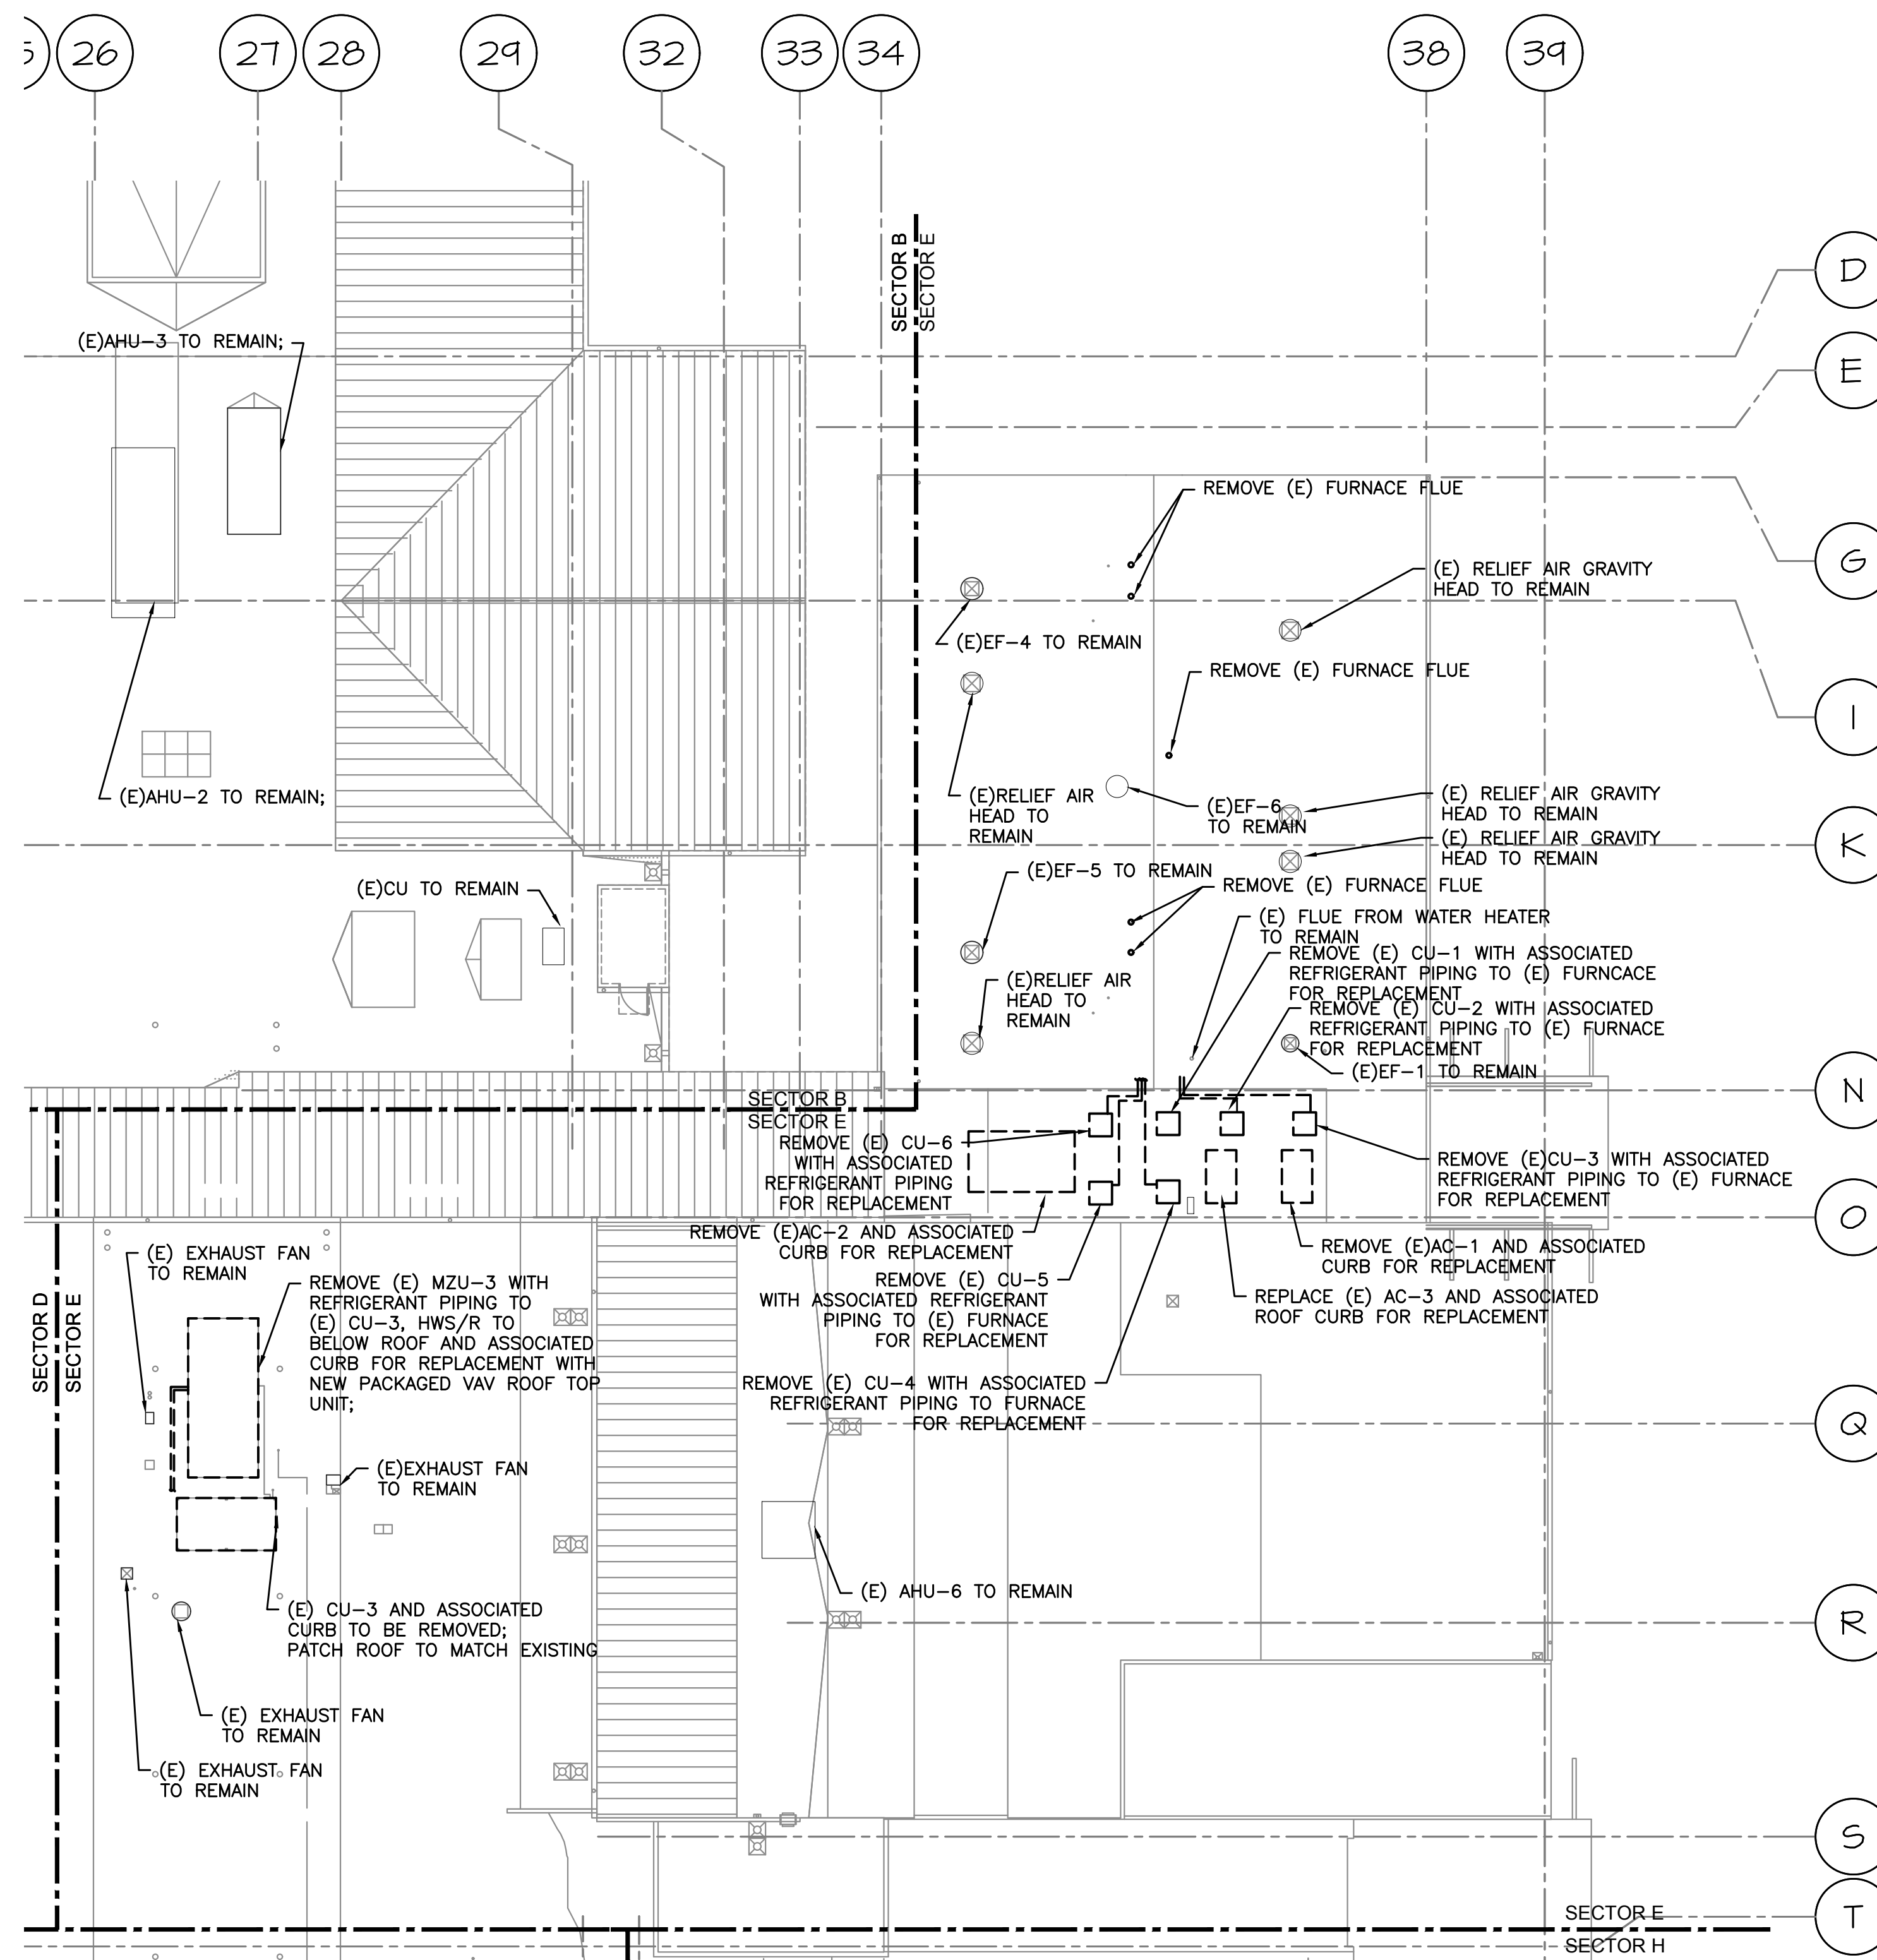

1 HVAC ROOF DEMO PLAN-SECTOR E
 DM-2.5 SCALE: 1/16" = 1'-0"

△ SHEET IS REVISED PER ADDENDUM #2

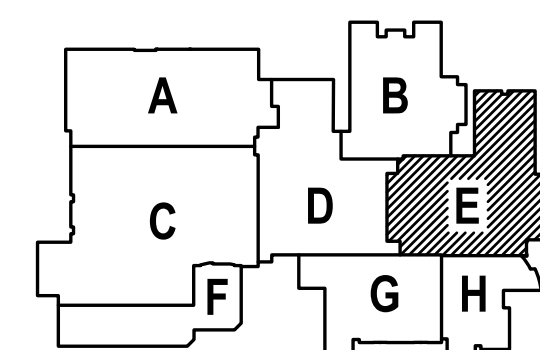

△ -ADDENDUM #2
 2/22/2018

MEI Consulting Engineers
 2007 S.E. Ash St.
 Portland, OR 97214
 PHN: (503) 234-0548
 FAX: (503) 234-0877
 INC. WWW.MFIA-ENG.COM
 CONTACT: Elena von Kamens

A NEW REMODEL PROJECT FOR:


SHERWOOD HIGH SCHOOL

16956 SW MEINCKE ROAD SHERWOOD, OR

REGISTERED PROFESSIONAL ENGINEER
 STATE OF OREGON
 17887
 SCOTT W. MILLER
 EXPIRES: 31DEC18

DRAWN BY:	EVK
CHECKED BY:	SWM
DATE:	1-30-18
TITLE:	HVAC ROOF DEMO PLAN - SECTOR E
SCALE:	1/16" = 1'-0"

SHEET NO:	DM-2.5
OF	7

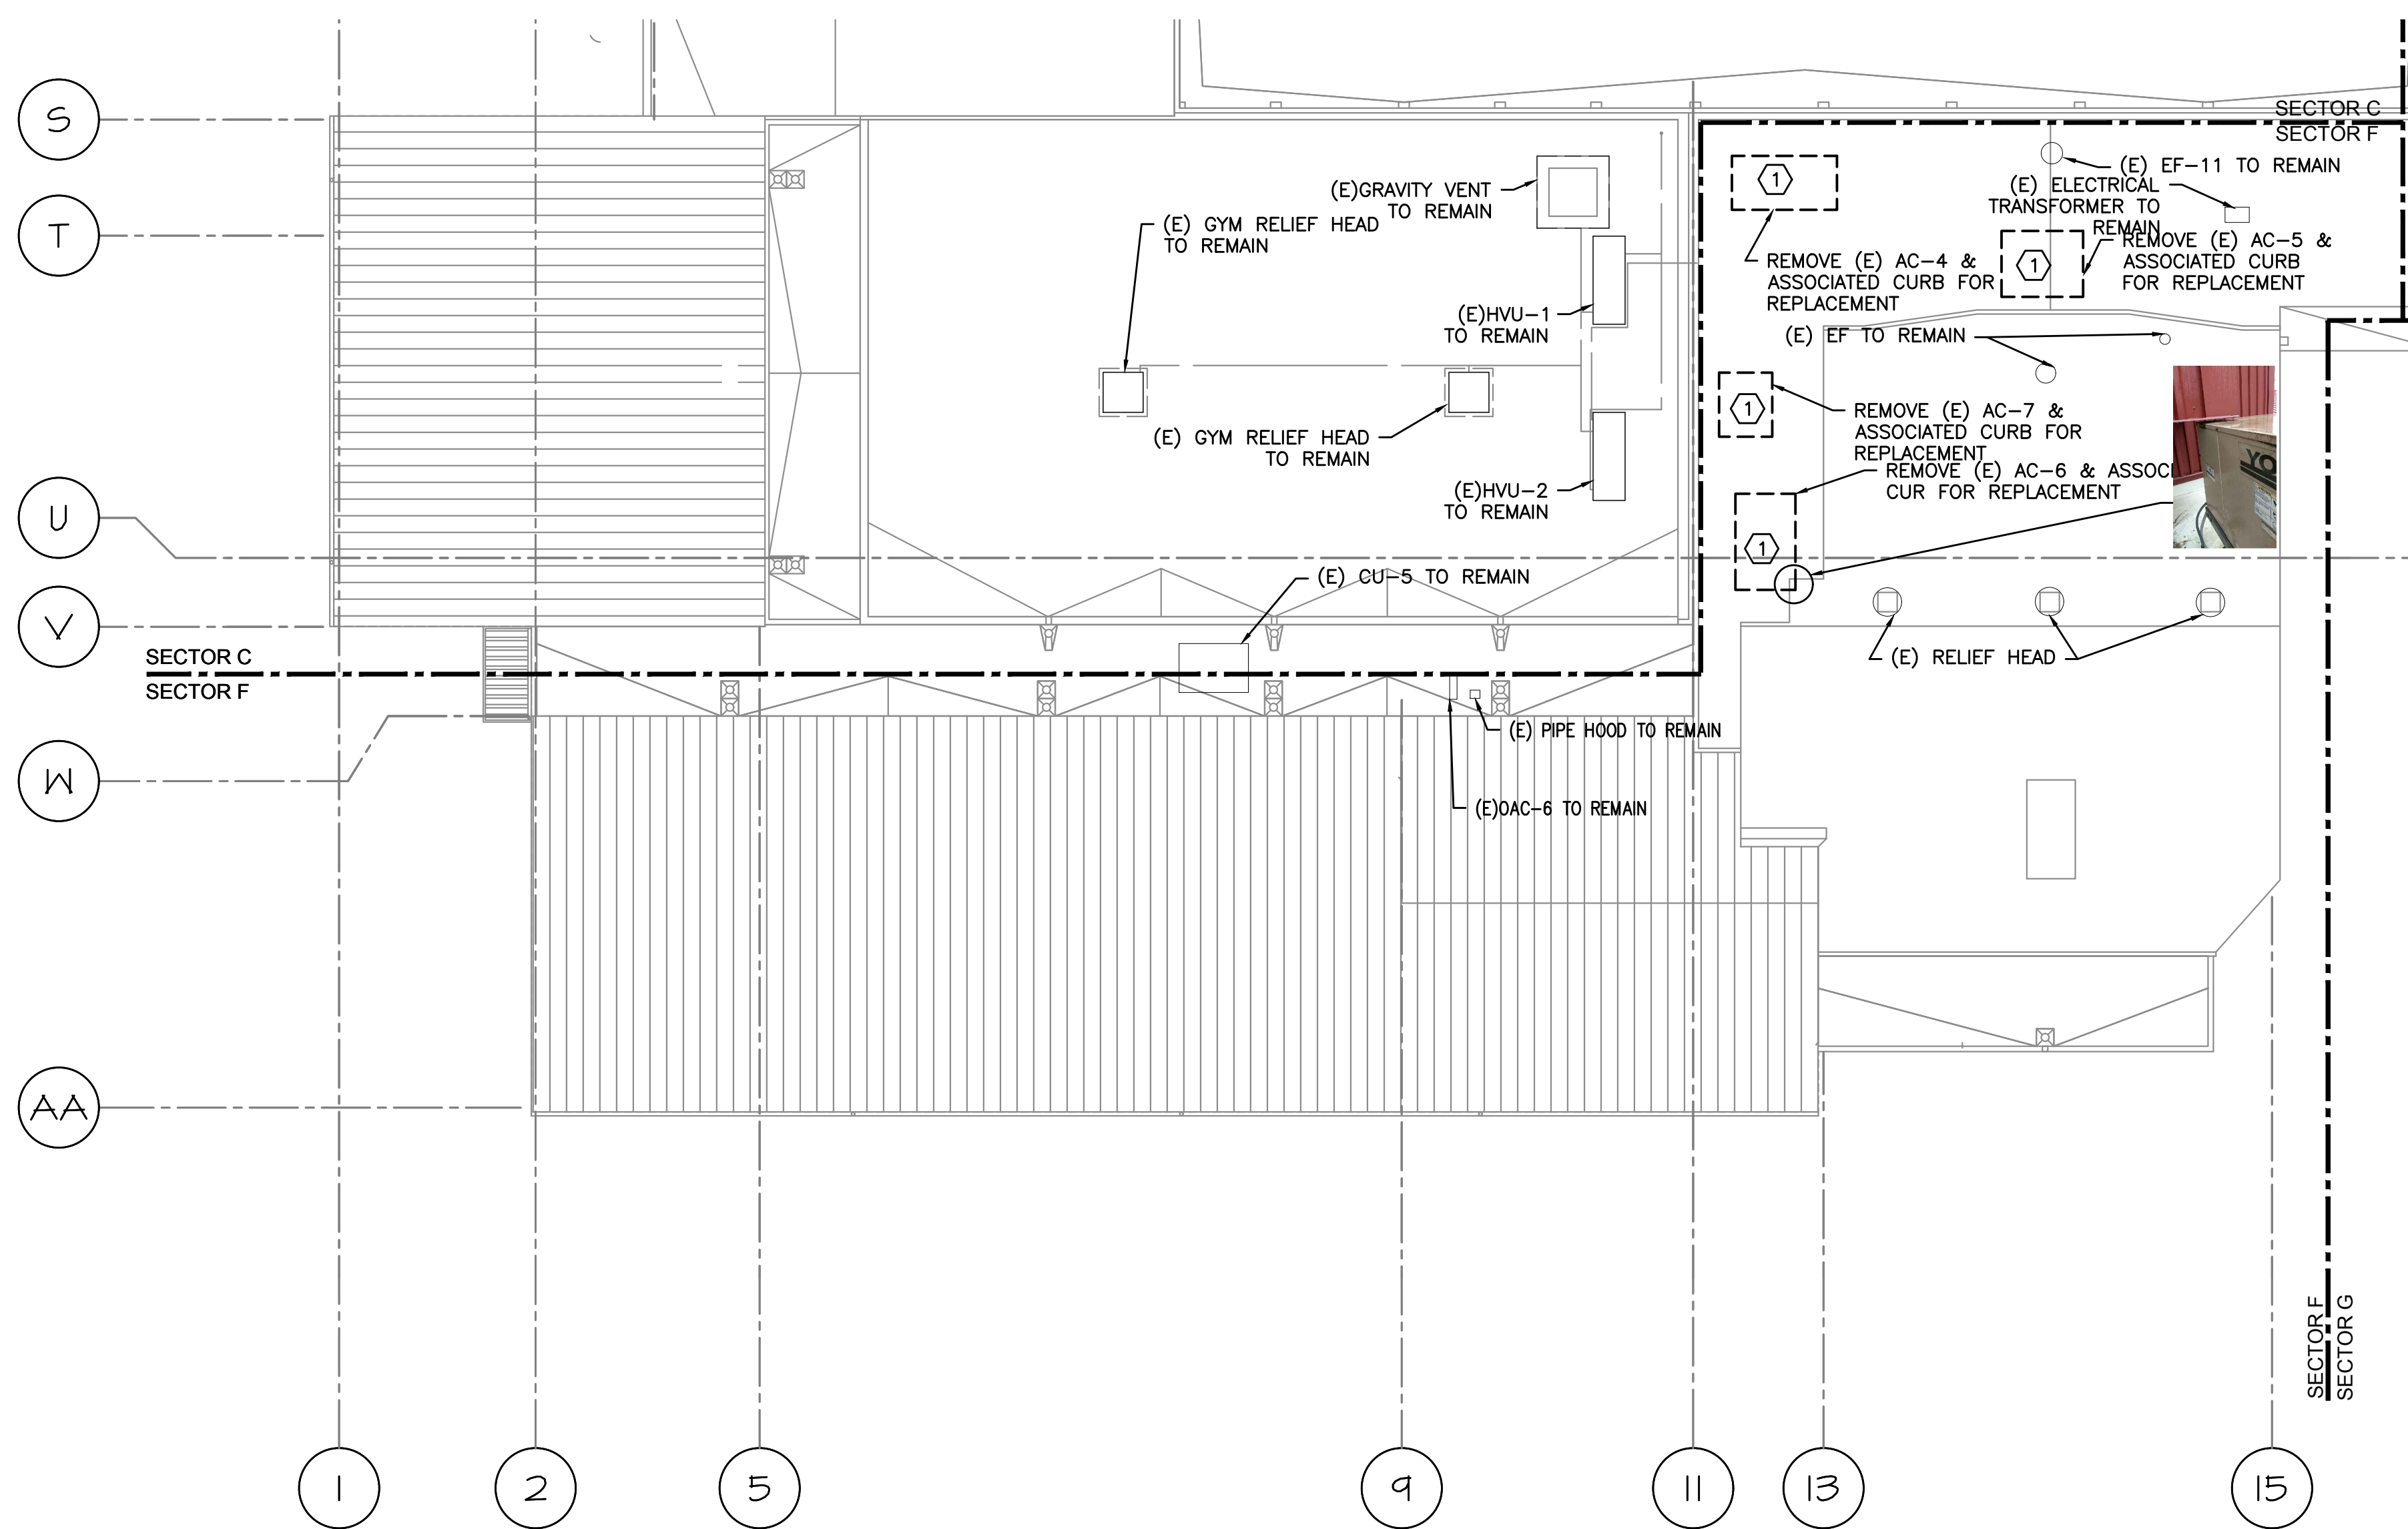

1 HVAC ROOF DEMO PLAN-SECTOR F
 DM2.6 SCALE: 1/16" = 1'-0"

1 -ADDENDUM #2
 2/22/2018

MFA Consulting Engineers
 2007 S.E. Ash St.
 Portland, OR 97214
 PHN: (503) 234-0548
 FAX: (503) 234-0677
 INC. WWW.MFA-ENG.COM
 CONTACT: Elena von Kaments

A NEW REMODEL PROJECT FOR:


SHERWOOD HIGH SCHOOL

16956 SW MEINECKE ROAD SHERWOOD, OR


REGISTERED PROFESSIONAL
 ENGINEER
 17887
 SCOTT W. MILLER
 EXPIRES: 31DEC18

1
 SHEET IS REVISED PER ADDENDUM #2

DRAWN BY:	EVK
CHECKED BY:	SWM
DATE:	1-30-18
TITLE:	HVAC ROOF DEMO PLAN - SECTOR F
SCALE:	1/16" = 1'-0"

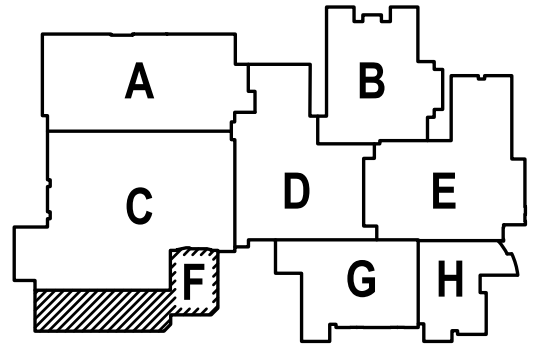

SHEET NO:	DM-2.6
OF	7

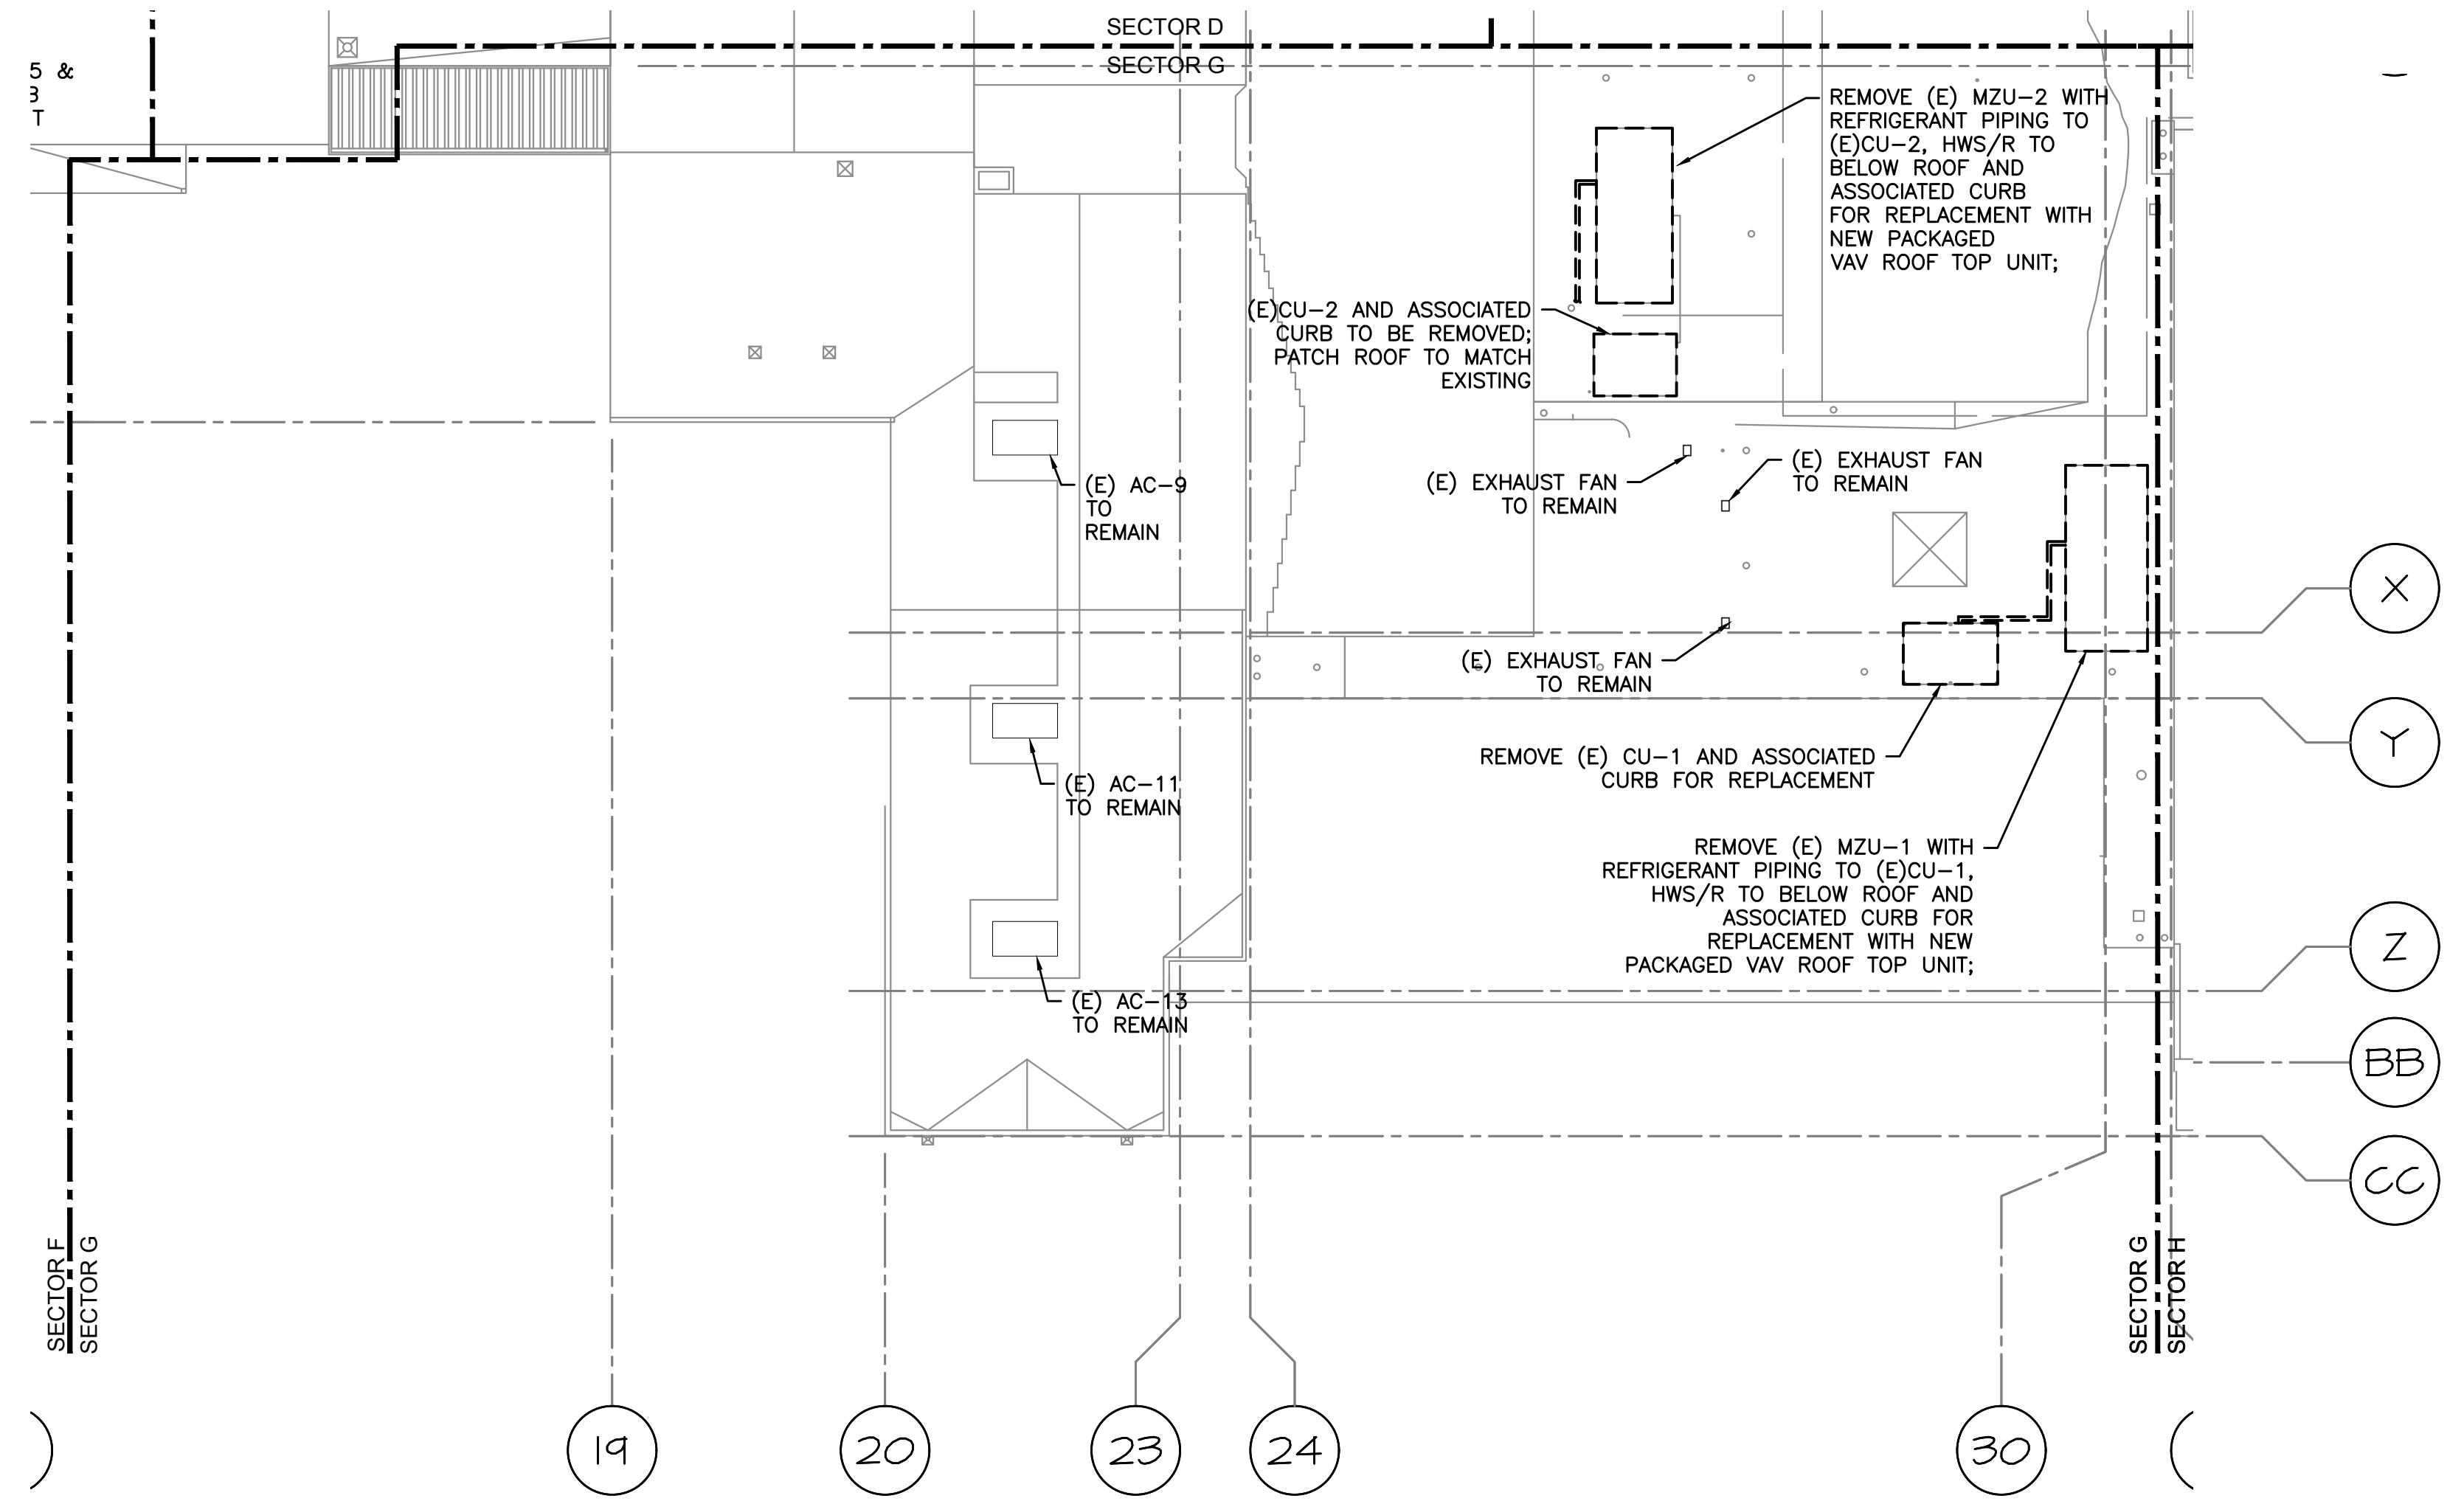

1 HVAC ROOF DEMO PLAN-SECTOR G
 DM2.7 SCALE: 1/16"=1'-0"



615 SE JACOBSON STREET
 PORTLAND, OR 97214
 503.223.8273 OFFICE
 503.223.7560 FAX
 paul@paulbentleyarchitect.com

PAUL L BENTLEY Architect A.I.A. P.C.

▲ -ADDENDUM #2
 2/22/2018

MFI Consulting Engineers
 2007 S.E. Ash St.
 Portland, OR 97214
 PHN: (503) 234-0548
 FAX: (503) 234-0677
 WWW.MFI-ENG.COM
 CONTACT: Elena von Kaments


A NEW REMODEL PROJECT FOR:

SHERWOOD HIGH SCHOOL

16956 SW MEINCKE ROAD SHERWOOD, OR



▲
 SHEET IS REVISED PER ADDENDUM #2

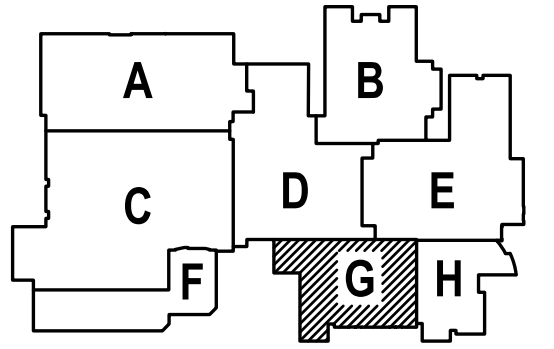

DRAWN BY:	EVK
CHECKED BY:	SWM
DATE:	1-30-18
TITLE:	ROOF HVAC DEMO PLAN- SECTOR G
SCALE:	1/16" = 1'-0"

SHEET NO:	DM-2.7
OF	7