

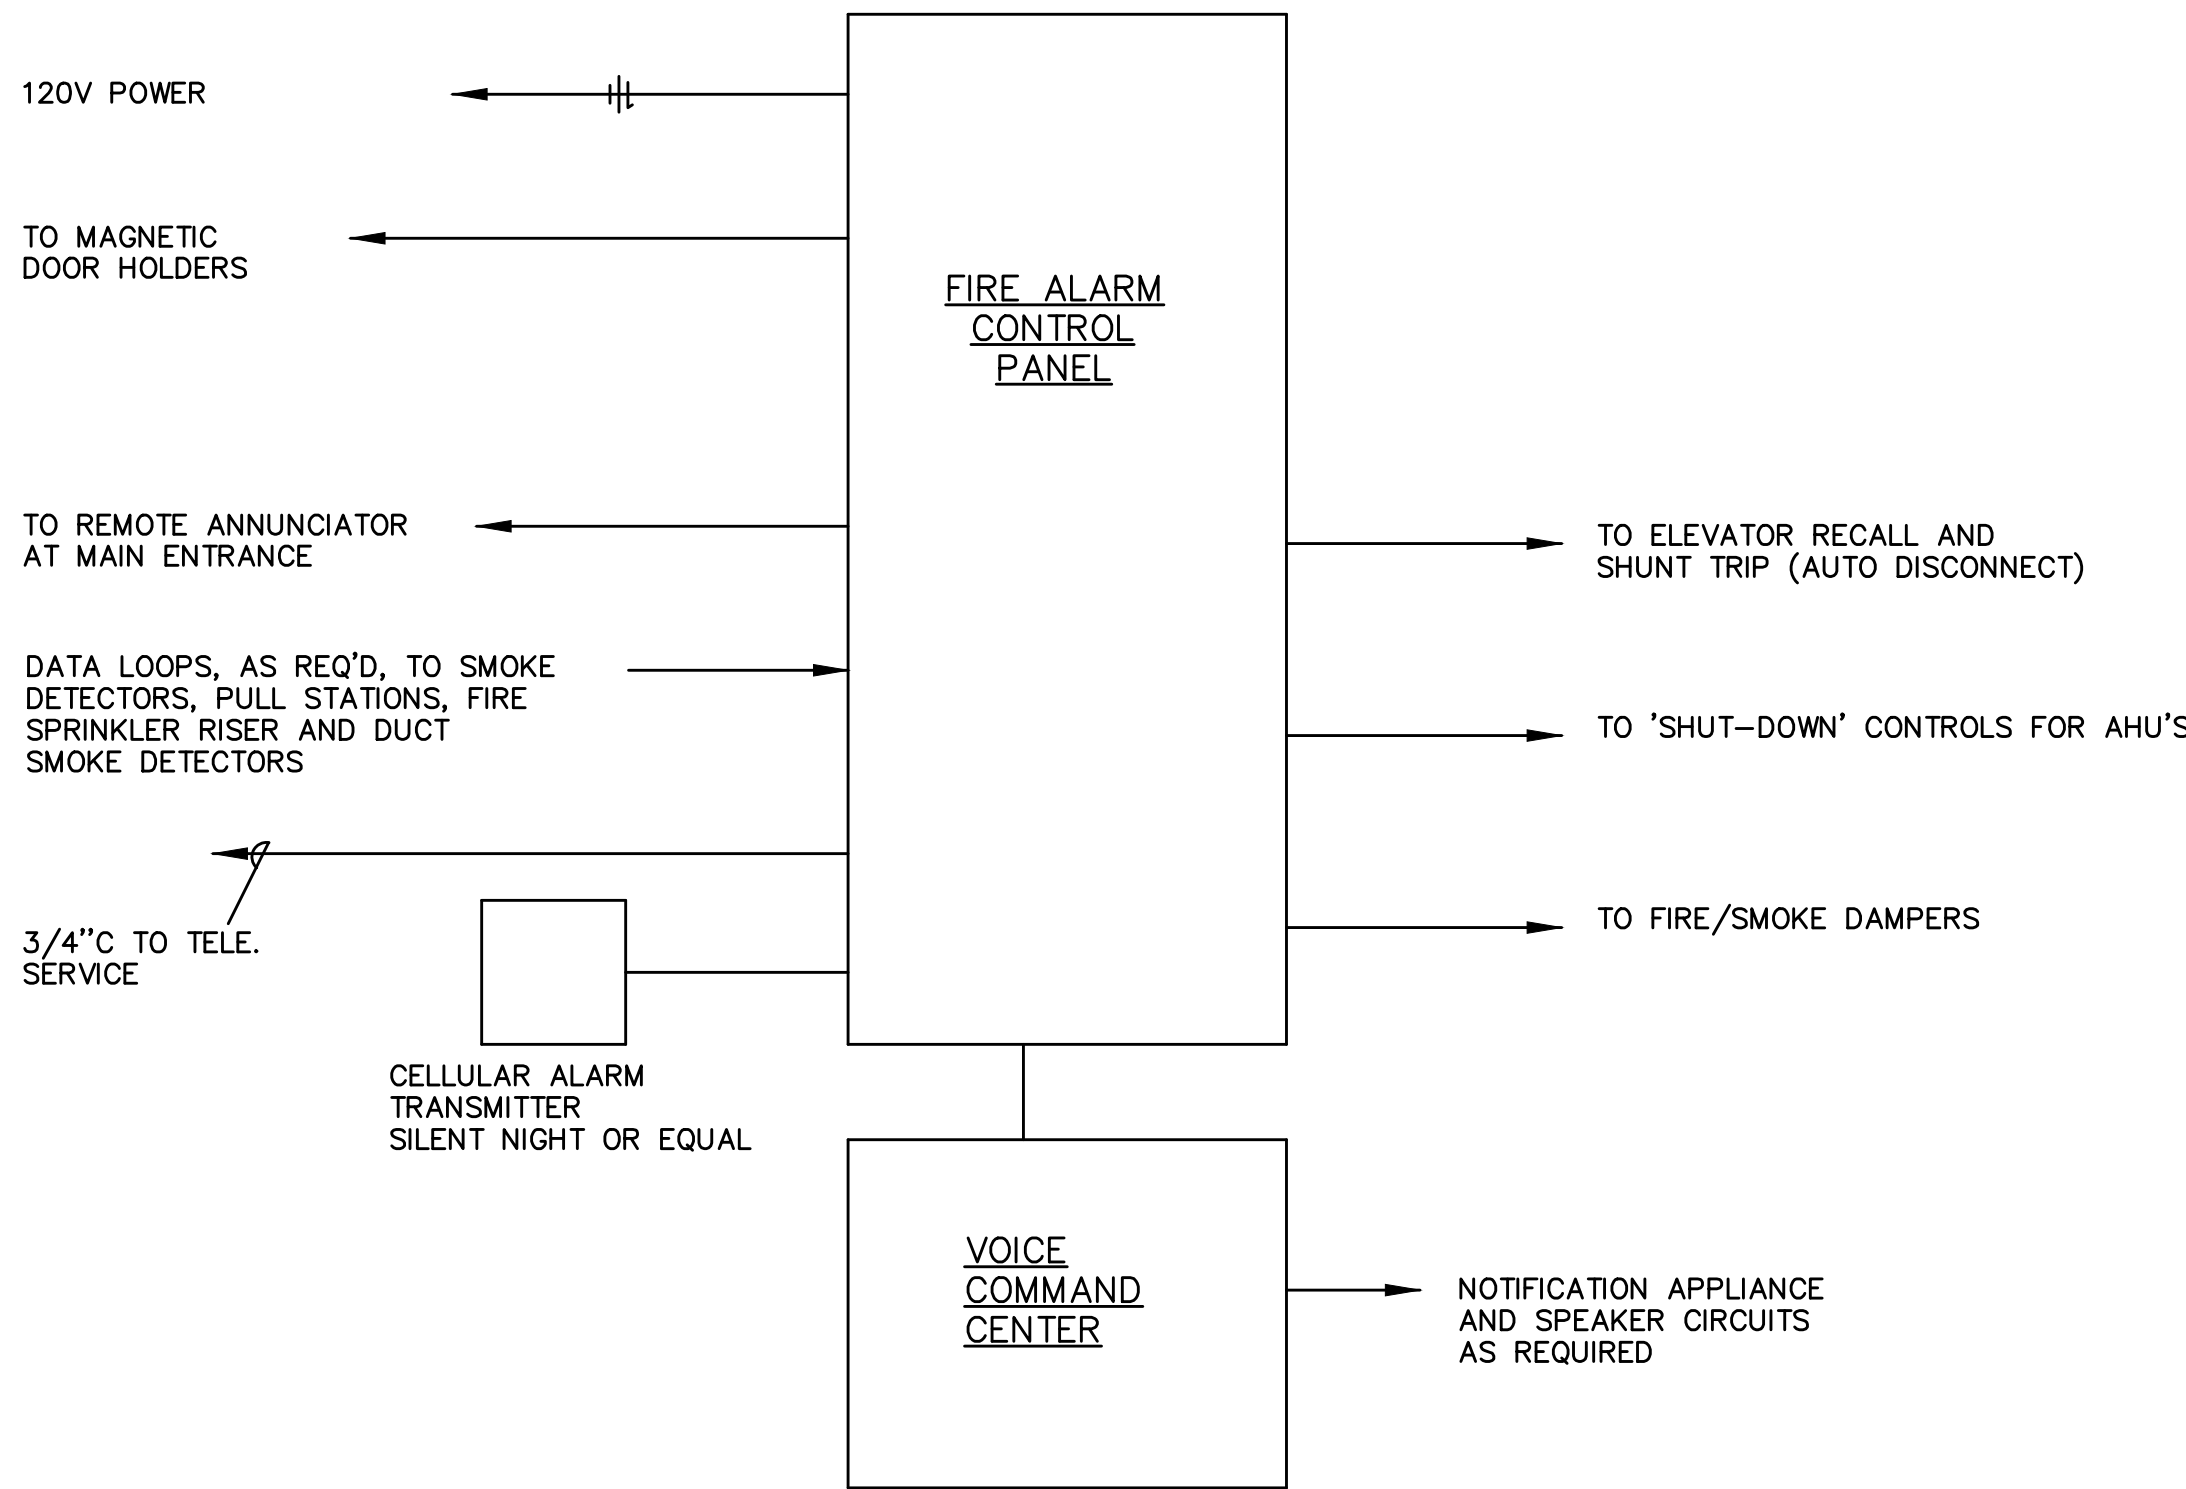


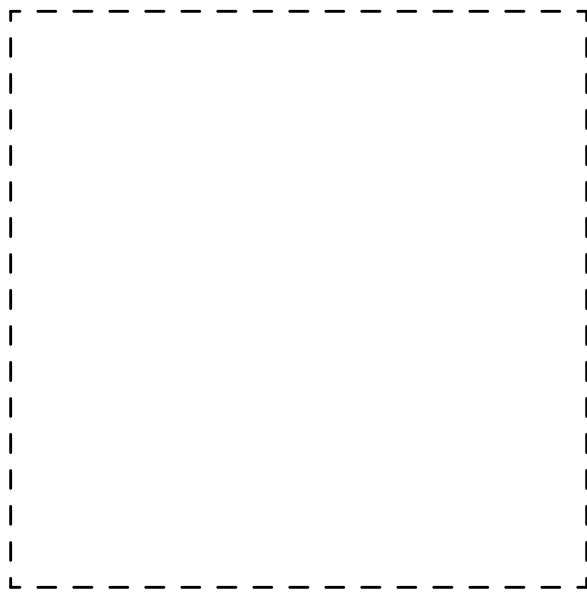

1 FIRE ALARM ONE LINE DIAGRAM
T1.11 NTS

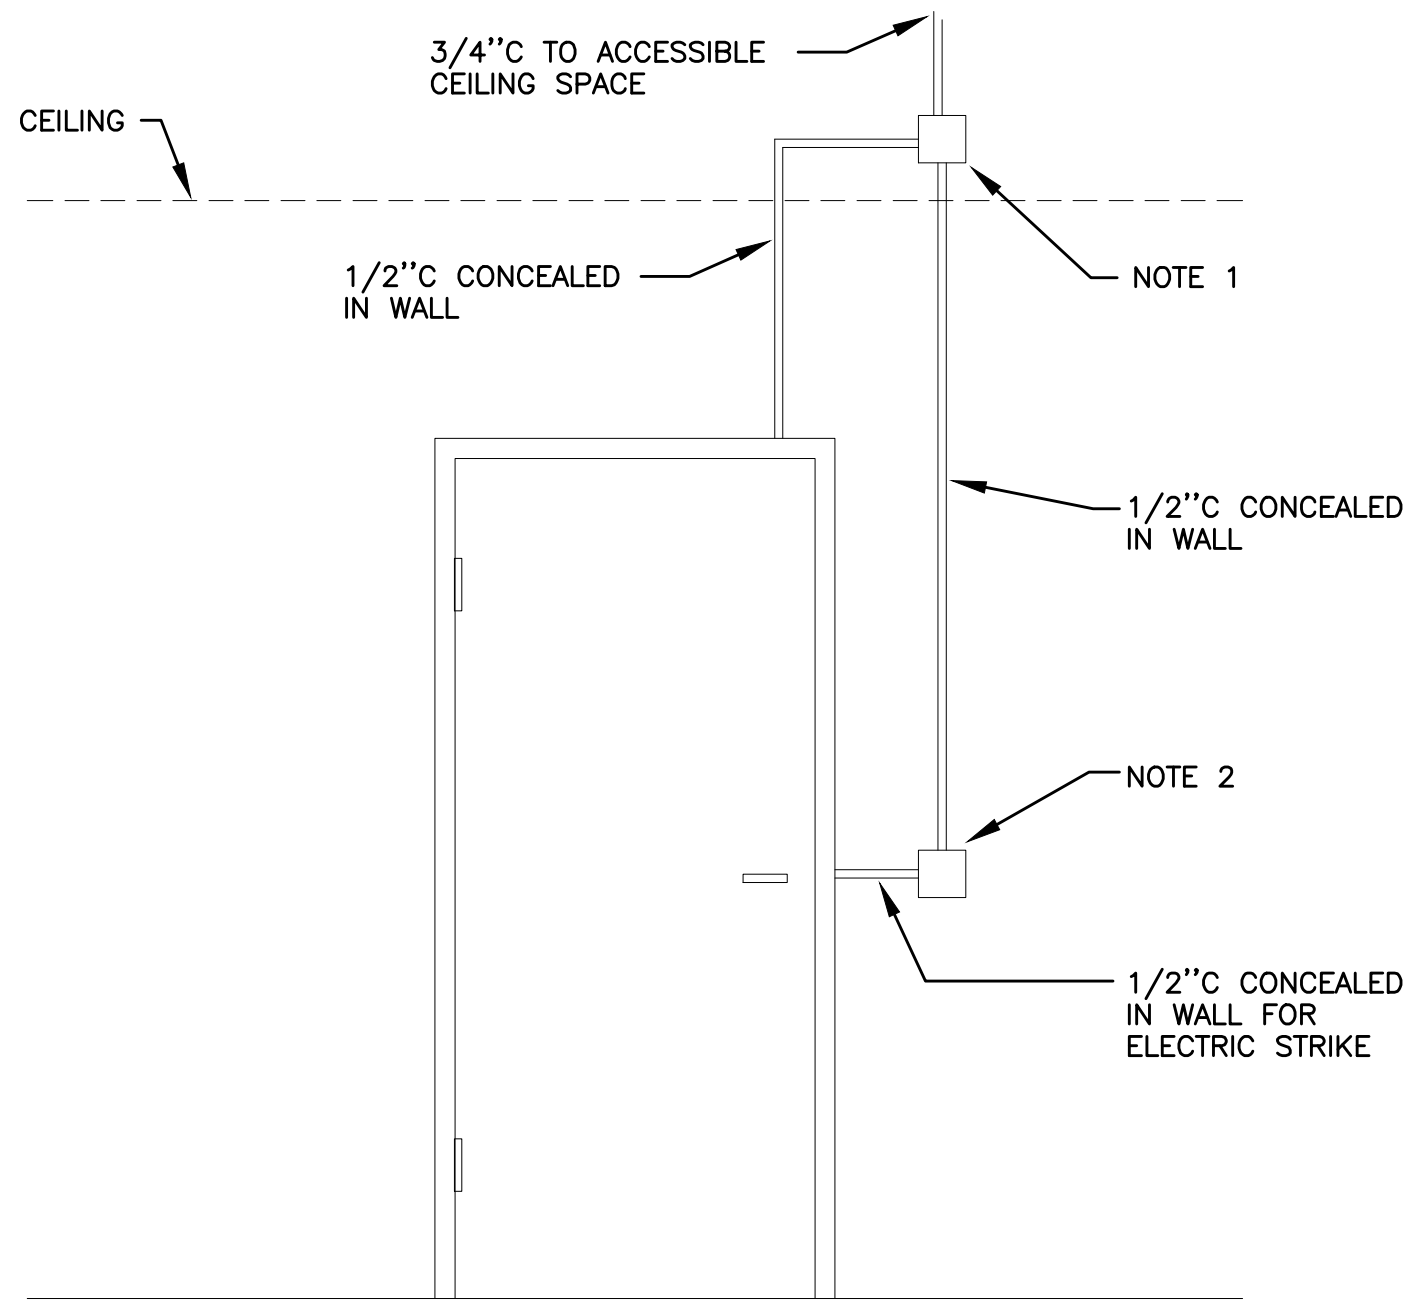


SECURITY ROUGH-IN NOTES

1. 4 SQUARE J-BOX @ 0'-6" ABOVE FINISHED CEILING, VERIFY WITH ARCHITECT.

2. DBL GANG BOX, PROVIDE SNGL GANG REDUCER RING IF NEEDED BY SECURITY DEVICE. COORDINATE WITH ARCHITECT TO MEET ADA REQUIREMENTS.

3 ACCESS CONTROL ROUGH-IN
T1.11 NTS

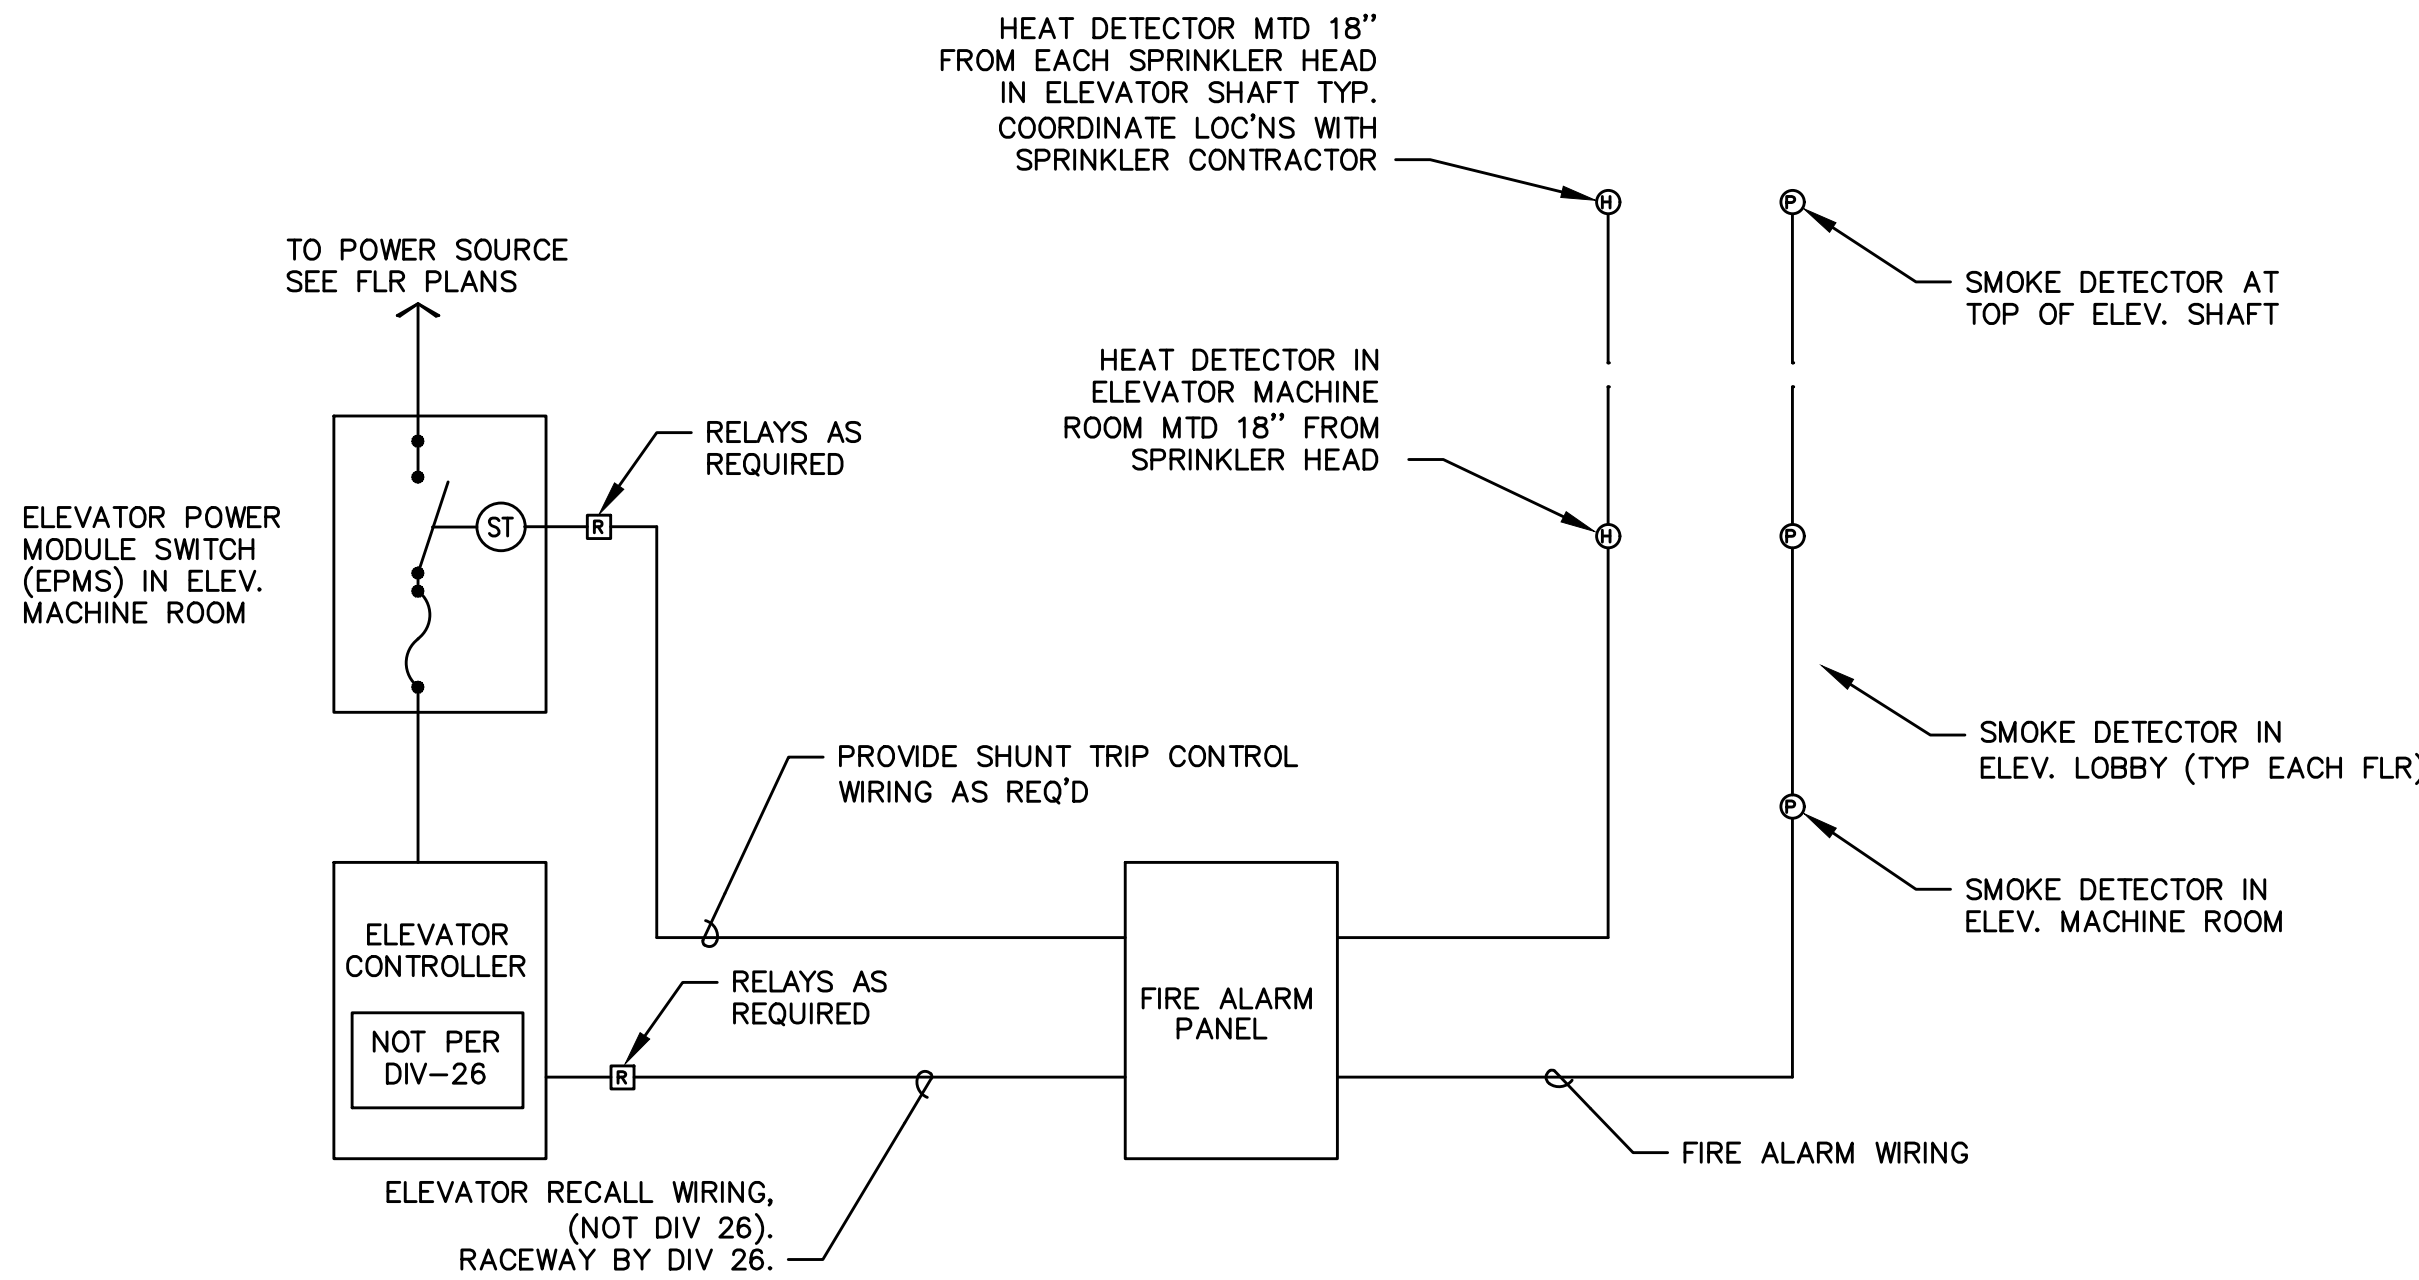


NOTES

1. CONNECT HEAT DETECTORS IN MACHINE RM AND ELEVATOR SHAFT SUCH THAT AN ALARM CONDITION WILL ACTIVATE SHUNT TRIP DEVICE IN 'EMPS'.

2. CONNECT SMOKE DETECTORS IN MACHINE ROOM, ELEVATOR LOBBYS, AND ELEVATOR SHAFT SUCH THAT AN ALARM CONDITION WILL ACTIVATE ELEVATOR RECALL SYSTEM. COORDINATE WITH ELEVATOR SUPPLIER.

2 ELEVATOR RECALL & AUTO DISCONNECT DETAIL
T1.11 NTS

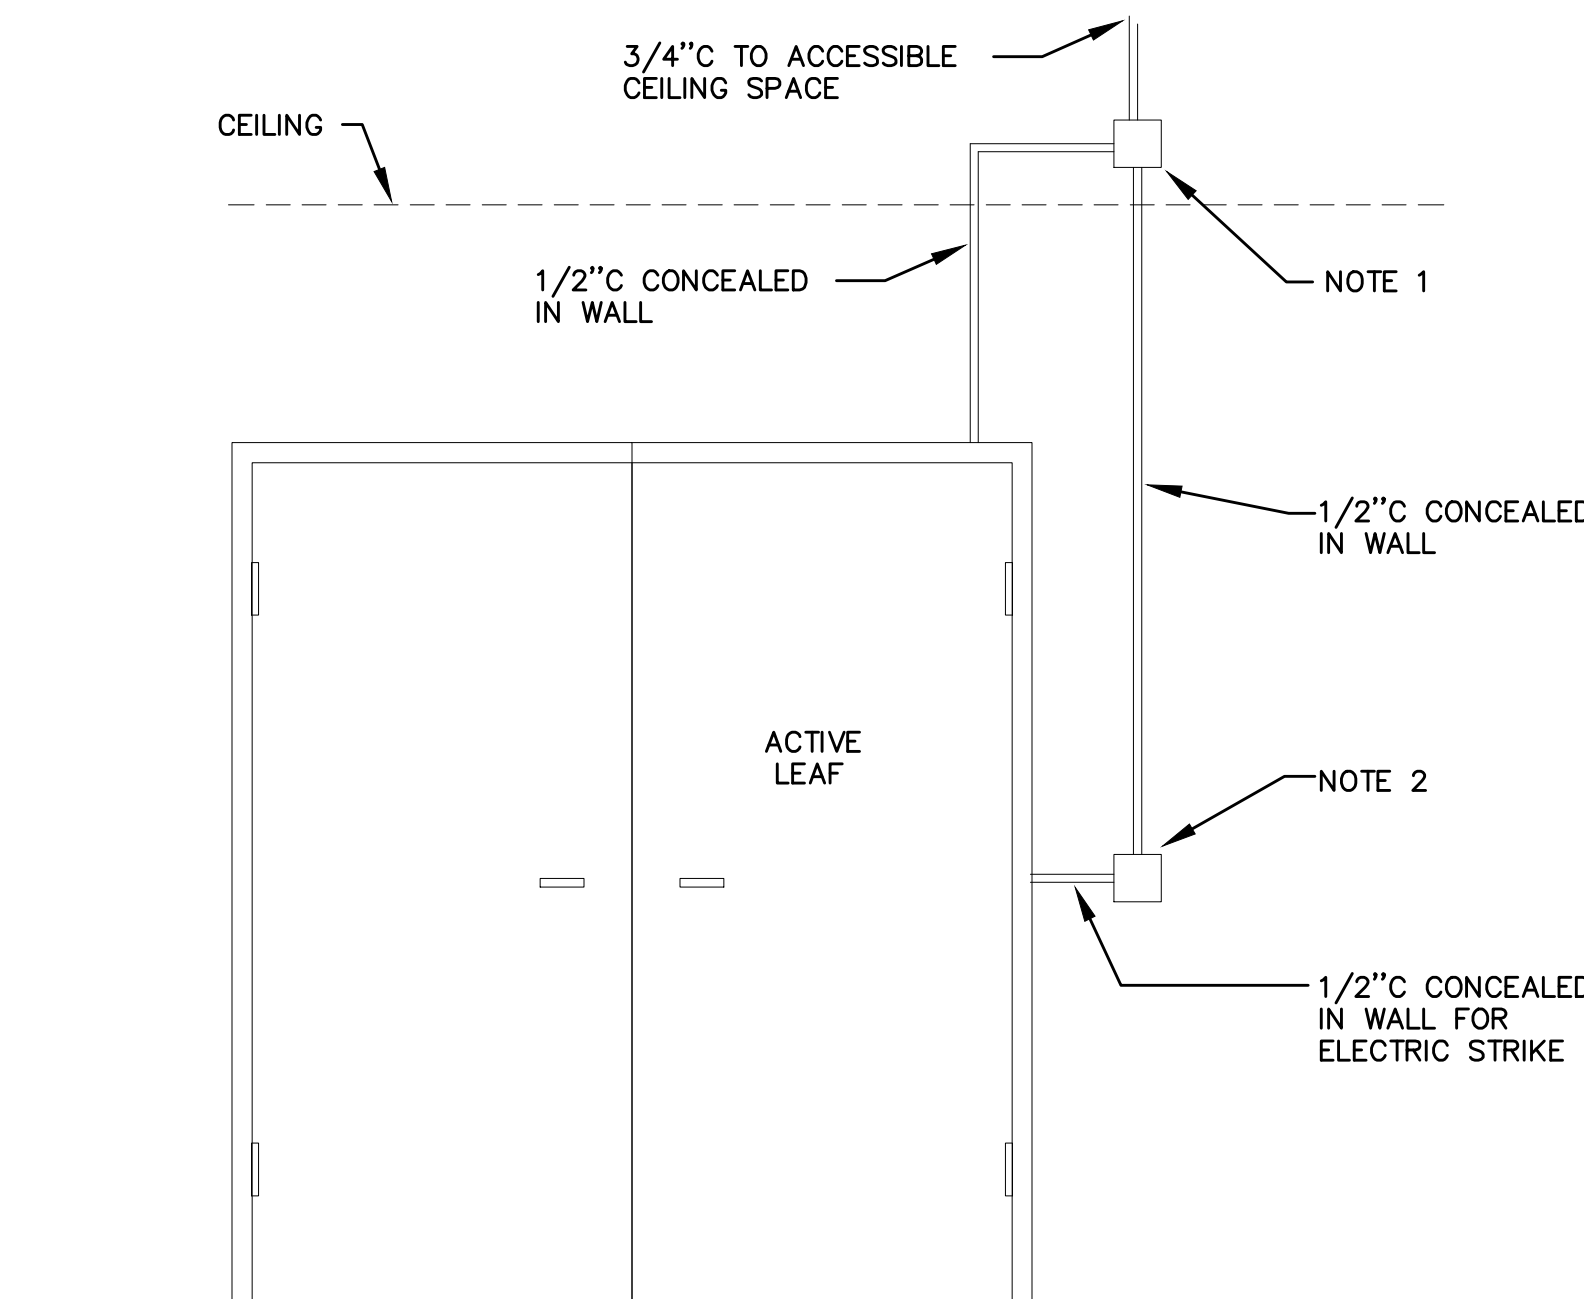

SECURITY ROUGH-IN NOTES

1. 4 SQUARE J-BOX @ 0'-6" ABOVE FINISHED CEILING, VERIFY WITH ARCHITECT.

2. DBL GANG BOX, PROVIDE SNGL GANG REDUCER RING IF NEEDED BY SECURITY DEVICE. COORDINATE WITH ARCHITECT TO MEET ADA REQUIREMENTS.

4 ACCESS CONTROL ROUGH-IN
T1.11 NTS

FIRE ALARM AND DETECTION SYSTEM SHOWN ON PLAN(S) ARE FOR DESIGN INTENT ONLY. THIS IS A DEFERRED SUBMITTAL SYSTEM REQUIRING THE CONTRACTOR TO COMPLETE THE PERMIT READY DESIGN AND CALCULATIONS AS REQUIRED PER THE AUTHORITY HAVING JURISDICTION. VERIFY BUILDING OCCUPANCY TYPE AND OCCUPANT LOAD WITH ARCHITECTURAL PLANS.

PRELIMINARY
NOT FOR
CONSTRUCTION

M
F
A
INC. Consulting Engineers
2007 S.E. Ash St.
Portland, OR 97214
PHN: (503) 234-0548
FAX: (503) 234-0677
CONTACT: GARY ADOVNIK

Project Owner:
NATIVE LAND DEVELOPMENT

Project Name:

MINNESOTA
PLACES

1208 N. JESSUP &
5627 N. MINNESOTA
(R226159, R226160)

PERMIT
SET

Issued:
PERMIT SET 7.29.2021

Job #: 2020

ORIGINAL SHEET SIZE: 24" x 36"
HALF SIZE: 12" x 18"

TECHNOLOGY
ONE-LINE
DIAGRAM

Drawing Number

T1.11