

PLUMBING LEGEND


AFF ABOVE FINISHED FLOOR	— — — — — (CW) COLD WATER
ARCH ARCHITECTURAL	— — — — — (HW) HOT WATER
B.G. BELOW GRADE	— — — — — (HWR) HOT WATER RECIRC
BTU BRITISH THERMAL UNIT	— - / - - (HT) HOT WATER HEAT TRACED
CAP. CAPACITY	— — — — — (W) BELOW GRADE WASTE
C.I. CAST IRON	— — — — — (W) ABOVE GRADE WASTE
COMP. COMPARTMENT	— V — V — (V) VENT
CONT. CONTINUATION	— RD — (RD) RAIN DRAIN
CU. CUBIC	— OD — (OD) OVERFLOW RAIN DRAIN
DF DRINKING FOUNTAIN	— FDC — (FDC) FIRE DEPARTMENT CONNECTION
DI DEIONIZED (WATER)	— (G) NATURAL GAS
DIA. DIAMETER	— (F) FIRE WATER
ELEV. ELEVATION	
EW ELECTRIC WATER COOLER	
FD FLOOR DRAIN	
FDC FIRE DEPARTMENT CONNECTION	
F.F. FINISH FLOOR	
F.L.G. FLANGE	
FT FOOT / FEET	
G GAS	
GA. GAUGE	
GALV. GALVANIZED	
GPM GALLONS PER MINUTE	
G.V. GATE VALVE	
HP HORSEPOWER	
HR. HOUR	
I.E. INVERT ELEVATION	
KW KILOWATT	
LAV LAVATORY	
LBS POUNDS	
MAX. MAXIMUM	
MBH THOUSANDS OF BTUs PER HOUR	----- (D) DEMOLISH, (R) RELOCATE
MIN. MINIMUM	----- (E) EXISTING
M.J. MECHANICAL JOINT	----- NEW WORK
N.I.M. NOT IN MECHANICAL	
OS&Y OUTSIDE STEM & YOKE	
PROT. PROTECTION	
PRV PRESSURE REDUCING VALVE	
PSI, PSIG POUNDS PER SQUARE INCH	
P/T PRESSURE / TEMPERATURE	
REQ'D REQUIRED	
RPBP REDUCED PRESSURE BACKFLOW PREVENTER	
RPM REVOLUTIONS PER MINUTE	
TYP. TYPICAL	
UR URINAL	
VTR VENT THROUGH ROOF	
WC WATER CLOSET	

X EQUIPMENT MARK NUMBER	△ PRESSURE/TEMP RELIEF VALVE
XX	∩ BUTTERFLY VALVE
XXX FIXTURE MARK	⊕ GAS PRESSURE REGULATING VALVE
(E) EXISTING	⊕ OR ⊖ TOP CONNECTION
# NOTE	⊖ BOTTOM CONNECTION
⊕ CONNECT TO EXISTING	— O — PIPE TURNED UP, PIPE TURNED DOWN
⊕ CAP	— — GATE VALVE
⊕ TEE	— — BALL VALVE
⊕ ELBOW	— — BALANCING VALVE
⊕ CLEANOUT	— — CHECK VALVE
		— — UNION
		⊕— — DOUBLE CHECK ASSEMBLY


PLUMBING CONNECTION SCHEDULE

MARK	FIXTURE	W	V	CW	HW	REMARKS
DF-1	DRINKING FOUNTAIN	1-1/2"	1-1/2"	1/2"		DUAL HEIGHT
FD-1	FLOOR DRAIN	3"	V.L.			J.R. SMITH 2005
HB-1	HOSE BIB				3/4"	RECESSED WITH LOCKING COVER
CW-1	CAN WASHER	2"	1-1/2"	1/2"	1/2"	J.R. SMITH 2690, MIXING VALVE
LV-1	LAVATORY	1-1/2"	1-1/2"	1/2"	1/2"	EXISTING
SH-1	SHOWER	2"	1-1/2"	1/2"	1/2"	FIBERGLASS
MS-1	MOP SINK	3"	2"	1/2"	1/2"	
UR-1	URINAL	2"	2"	1"		WALL MOUNT, FLUSH VALVE
UR-2	URINAL				1"	EXISTING, NEW FLUSH VALVE
WC-1	WATER CLOSET	4"	2"	1"		WALL MOUNT, FLUSH VALVE
WC-2	WATER CLOSET	4"	2"	1"		WALL MOUNT, FLUSH VALVE, ADA
WF-1	WASH FOUNTAIN	2"	2"	1/2"	1/2"	WALL MOUNT
CO	CLEAN OUT					

V.L. - VENTED LINE
ALL FIXTURES ARE NEW UNLESS NOTED AS EXISTING.

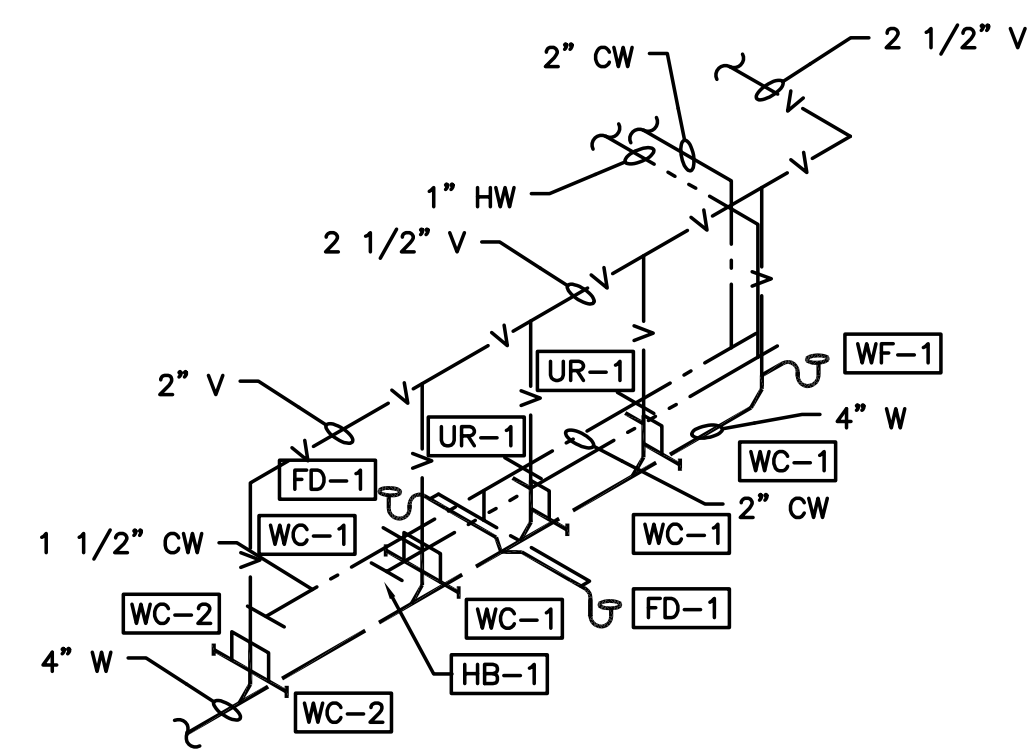

1 S RESTROOM RISER DIAGRAM
NO SCALE

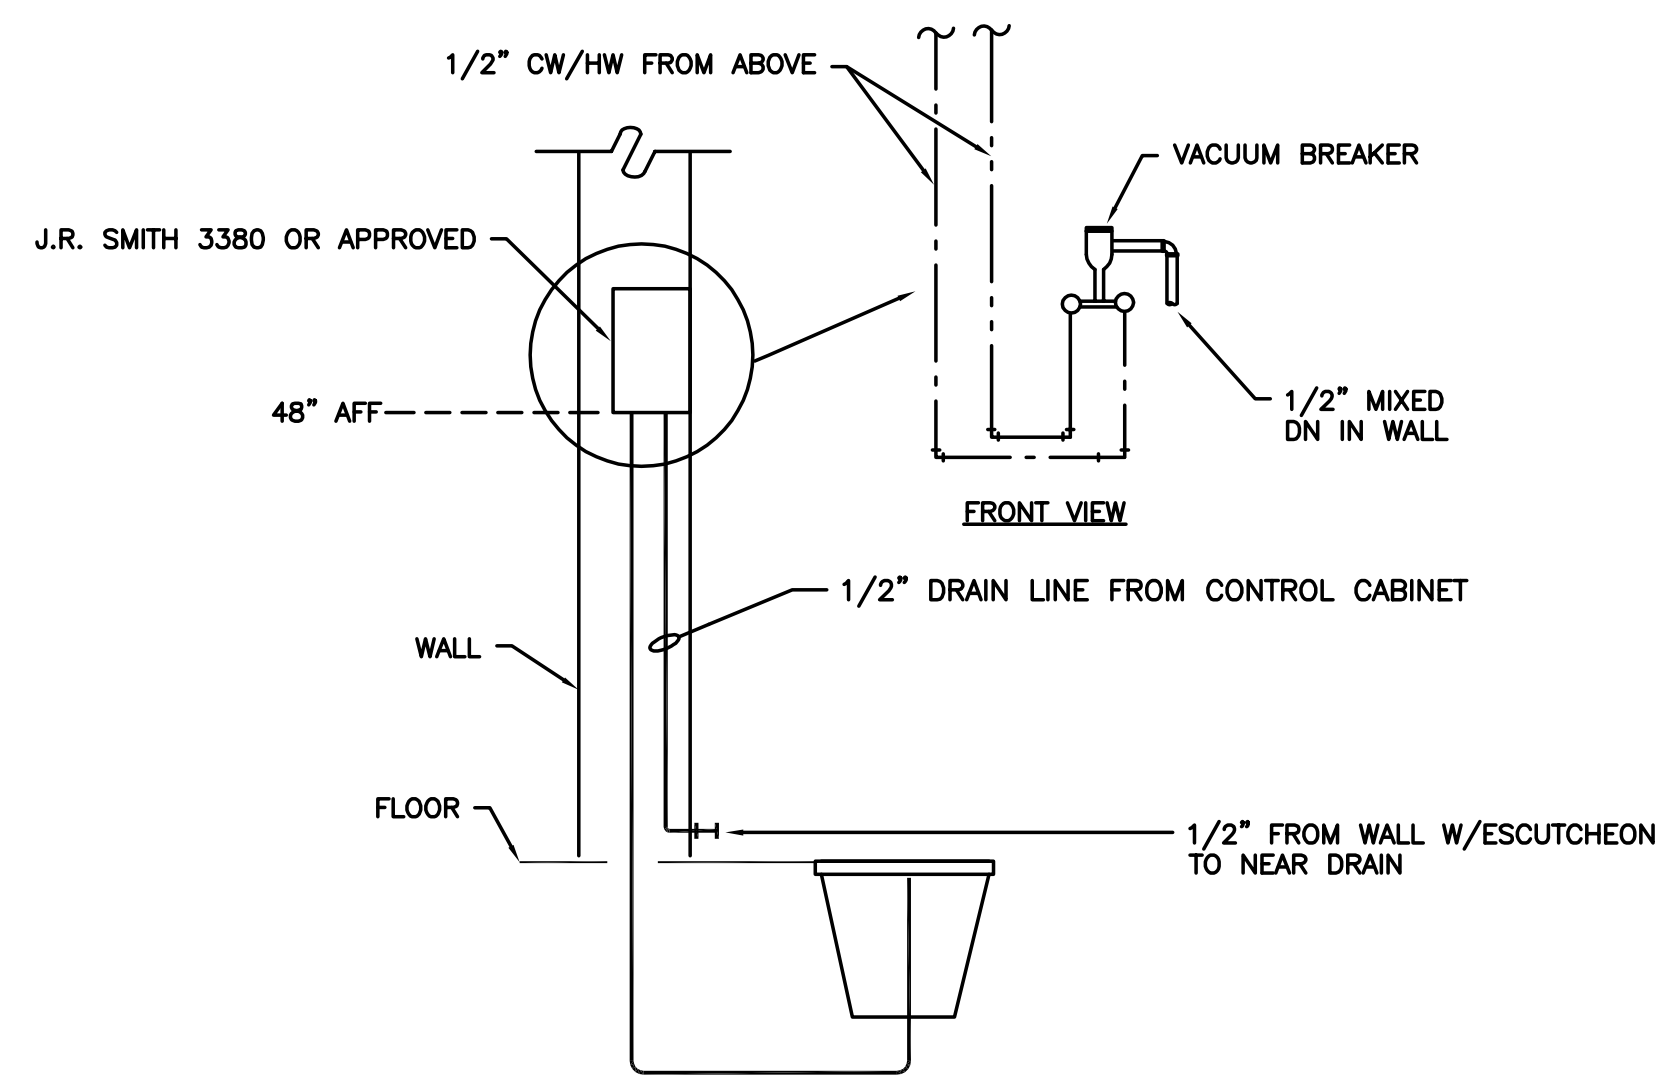

2 CAN WASH
SCALE: DETAIL

COPYRIGHT 2015 STEELE ASSOCIATES ARCHITECTS LLC. All rights reserved. Reproduction or use in any form or by any means -- graphic, electronic, mechanical, etc. -- without written permission of STEELE ASSOCIATES ARCHITECTS LLC is prohibited and subject to criminal prosecution.

STEELE ASSOCIATES
ARCHITECTS LLC
760 NW YORK DRIVE, SUITE 200
BEND, OR 97701
541.382.9867 FAX 541.385.8816
info@steele-arch.com

JEWELL ELEMENTARY REMODEL
20550 MURPHY ROAD
BEND OREGON
PLUMBING SCHEDULES

PRINTS ISSUED:	DATE:
JOB NO. 14117.01	DATE 11-21-14
DRAWN BY EPIC	CHECKED BY JLT
REVISIONS APPENDIX 1	DATE 4/13/15
SHEET NO.	OF SHEETS

P6.01

RECORD DRAWING:
THIS DRAWING HAS BEEN UPDATED TO REFLECT CHANGES MADE DURING CONSTRUCTION BASED UPON INFORMATION FURNISHED TO THE ENGINEER BY THE INSTALLATION CONTRACTOR. NO WARRANTY EITHER EXPLICIT OR IMPLIED IS GIVEN BY MFIA, INC. AS TO THE ACCURACY AND/OR COMPLETENESS OF THIS INFORMATION.

RECORD SET
1/29/2016

M Consulting Engineers
2007 S.E. Ash St.
Portland, OR 97214
PH: (503) 234-0548
FAX: (503) 234-0677
WWW.MFIA-ENG.COM
CONTACT: JIM TORMEY

RECORD SET - JANUARY 29, 2016