

**EXPIRES:** July 5th, 2020

IF THE EVENT CONFLICTS ARE DISCOVERED
BETWEEN THE ORIGINAL SIGNED AND SEALED


PROJECT # 2017-053
DATE: 11/06/2019

PLAN REVIEW	01.24.202
PLAN REVIEW	03.13.202
PLAN REVIEW	04.24.202
PLAN REVIEW	08.10.202
PLAN REVIEW	09.17.202
PLAN REVIEW	10.16.202
PLAN REVIEW	11.25.202
PLAN REVIEW	03.26.202
PLAN REVIEW	07.15.202
COORDINATION	08.27.202
COORDINATION	11.05.202
COORDINATION	12.10.202
COORDINATION	03.03.202

AEGIS
MIXED-USE DEVELOPMENT
312 E EVERGREEN BOULEVARD, VANCOUVER, WA 98660

EET:

E1.02

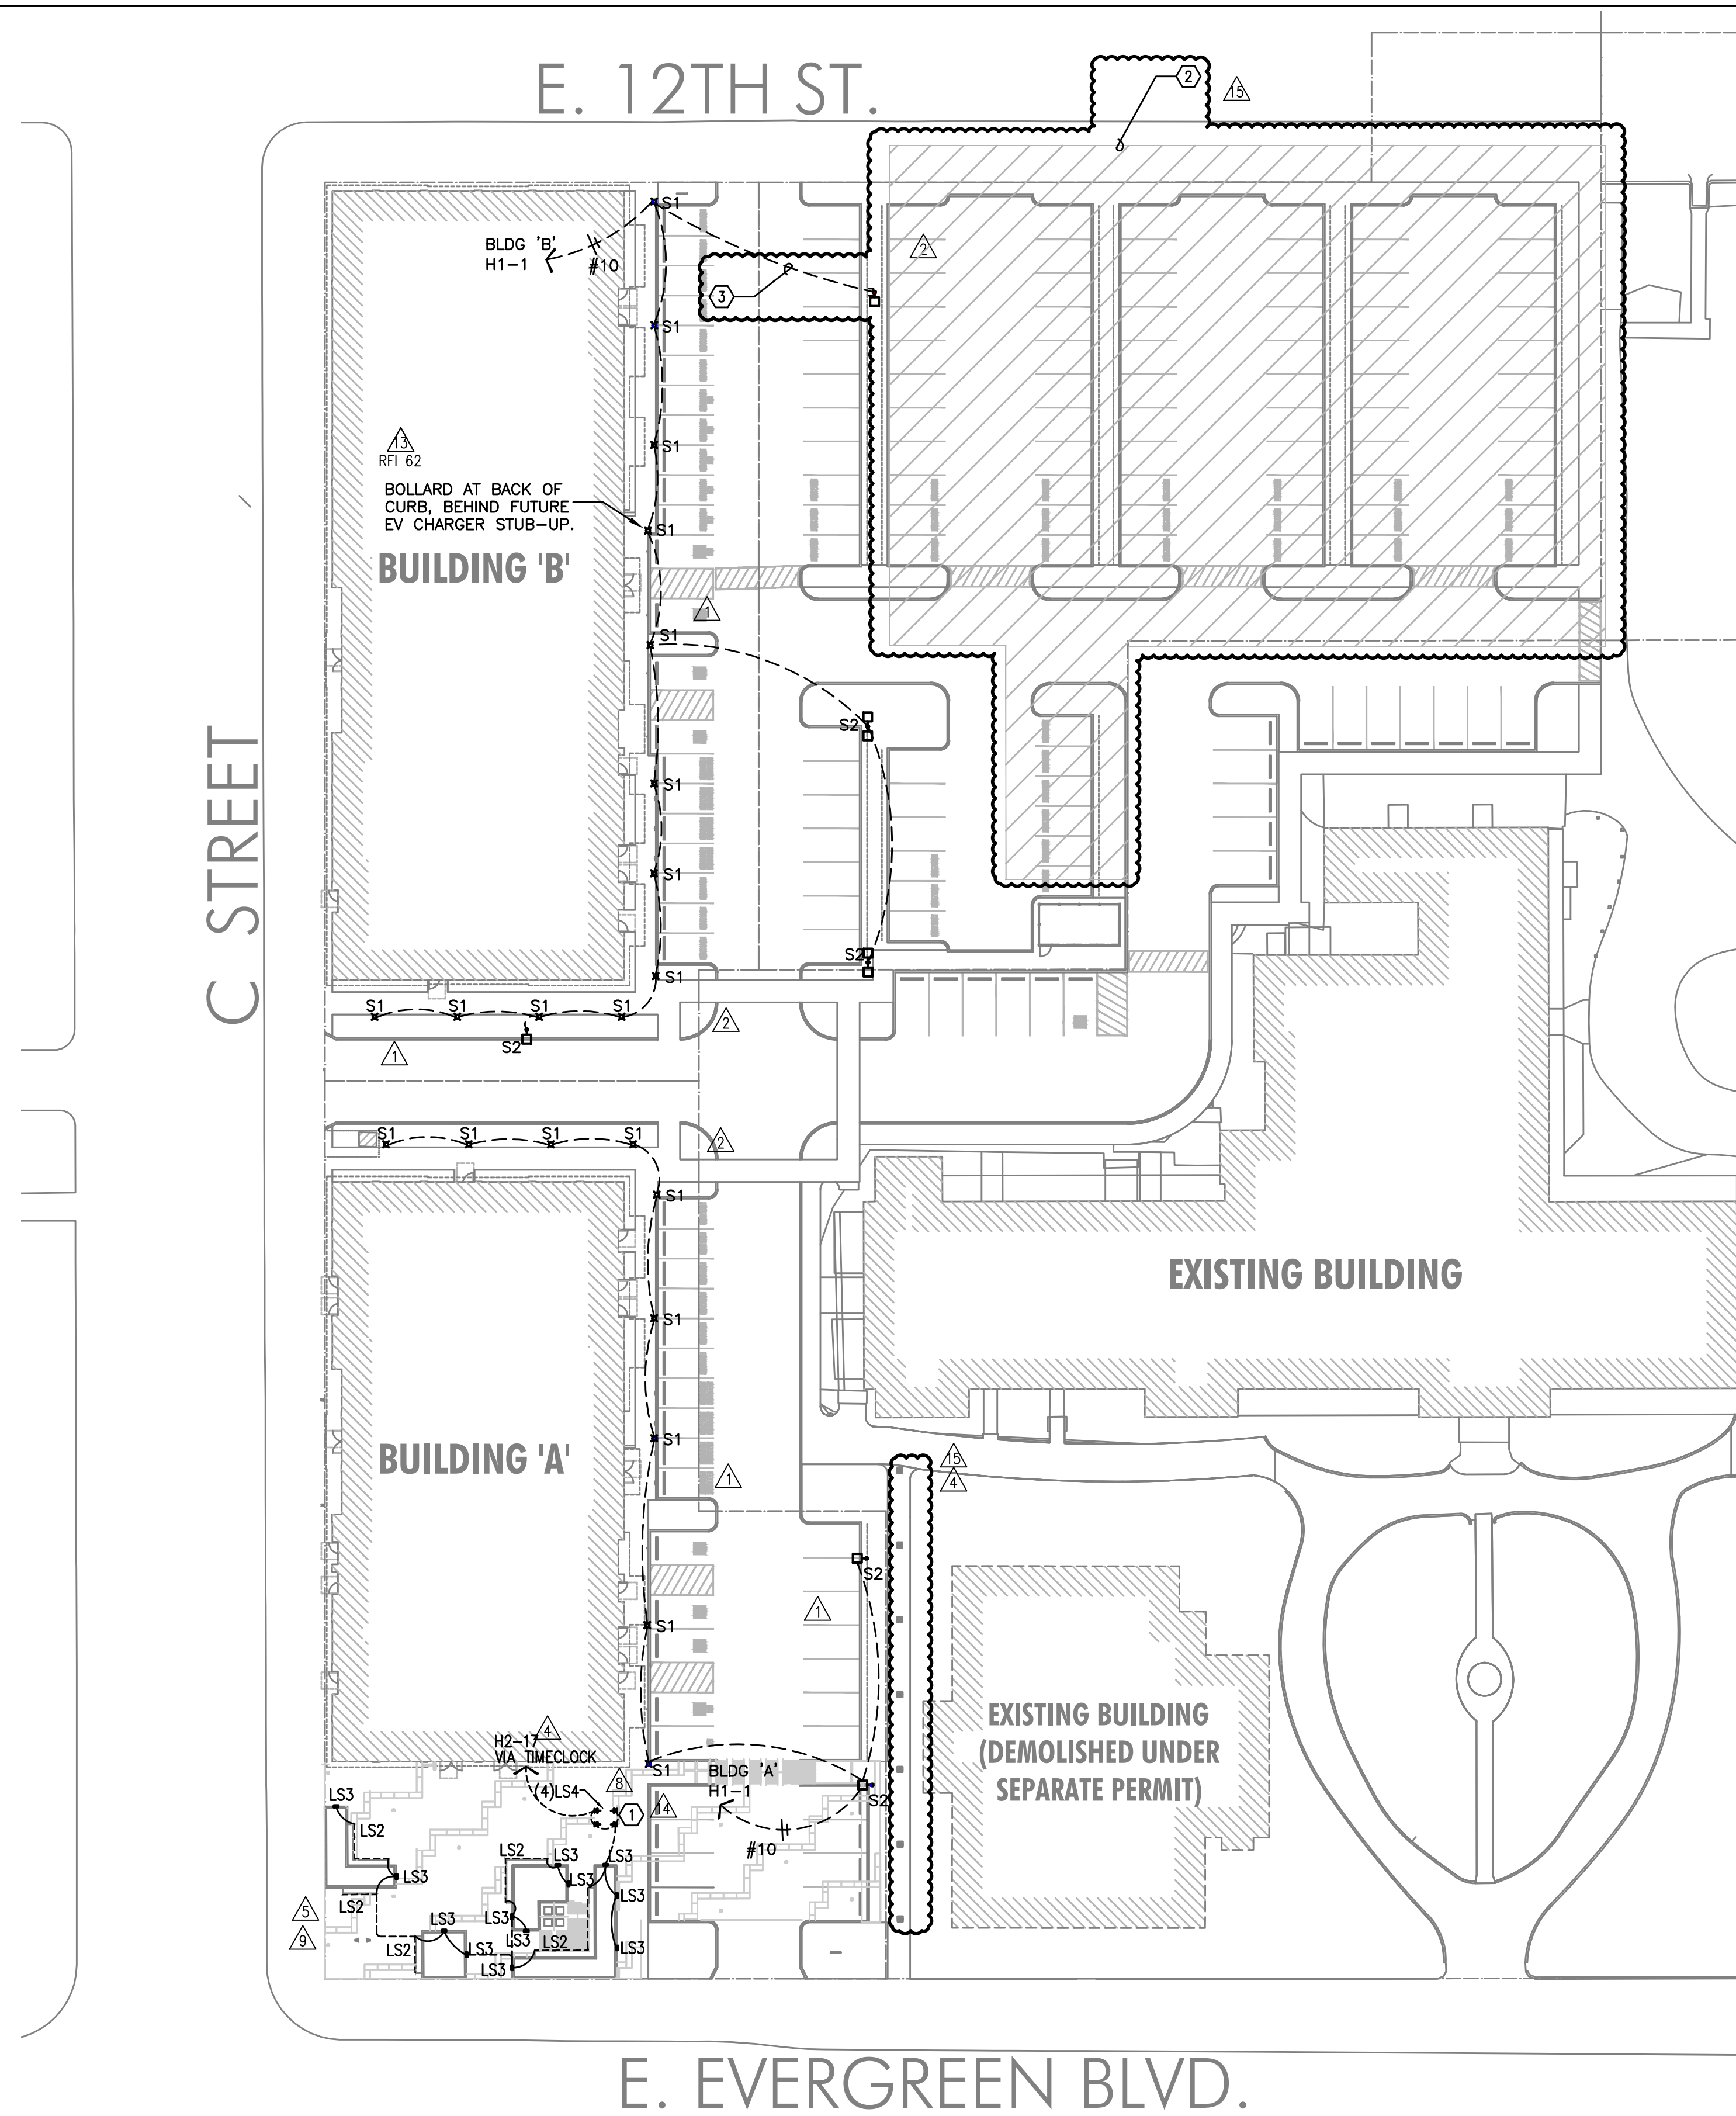

GENERAL SITE LIGHTING NOTES:

- A. ALL WORK SHALL BE PERFORMED IN ACCORDANCE WITH ALL APPLICABLE LOCAL, STATE AND NATION CODES.
- B. ALL PLANS ARE CONSIDERED DIAGRAMMATICAL. THEREFORE ALL EQUIPMENT SIZES AND DEVICE LOCATIONS ARE APPROXIMATE AND SUBJECT TO FIELD CONDITIONS AND PRODUCT APPROVAL.
- C. REFER TO SHEETS E1.11 & E1.14 FOR ONE-LINE DIAGRAM, LOAD SUMMARY INFORMATION AND TYPICAL FEEDER SCHEDULE.
- D. REFER TO SHEETS E2.01A & E2.01B FOR EXTERIOR BUILDING LIGHTS.
- E. REFER TO SHEET E1.21 FOR LIGHT FIXTURE SCHEDULE.

 KEYED LIGHTING NOTES:

1. FLOOD LIGHTS AT SCULPTURE PLATFORM TO BE FIELD AIMED. CONSULT WITH ARCHITECT AND/OR INSTALLATION ARTIST FOR DIRECTION.
2. ELECTRICAL WORK IN PARCEL 'E' REMOVED FROM PHASE I OF THE AEGIS PROJECT.
3. EXTEND EMPTY CONDUIT WITH PULL STRING FROM BOLLARD LIGHTS TO THE PARKING AREA AS SHOWN. DO NOT EXTEND CONDUCTORS. CAP OFF CONDUIT FOR FUTURE LIGHT INSTALLATION.

1
E1.02

SITE LIGHTING PLAN
SCALE: 1" = 30'-0"

MFIA
INC.
Consulting Engineers
2007 S.E. Ash St.
Portland, OR 97214
PHN: (503) 234-0548
FAX: (503) 234-0677
WWW.MFIA-ENG.COM
CONTACT: DENISE TAYLOR