




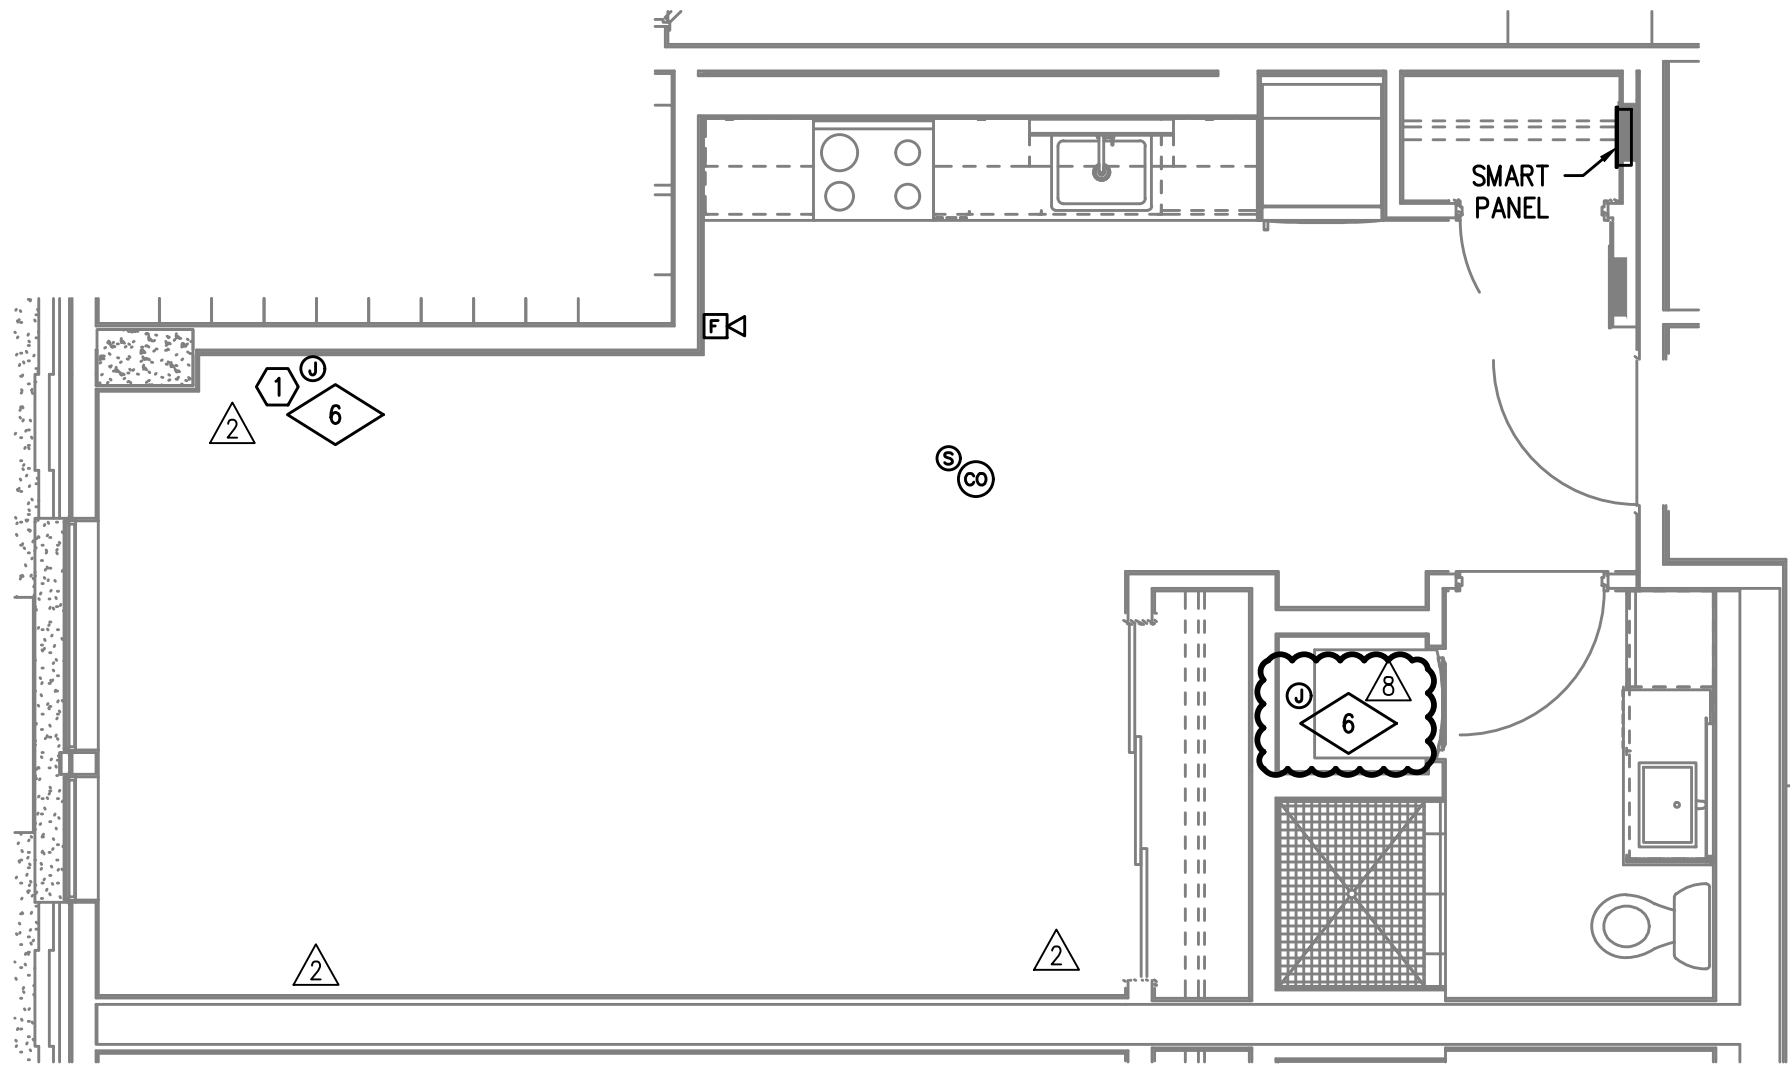


TYPICAL UNIT TYPE L
1 0 BED/1 BATH – TELCOM PLAN
T4.15 SCALE: 1/4" = 1'-0"

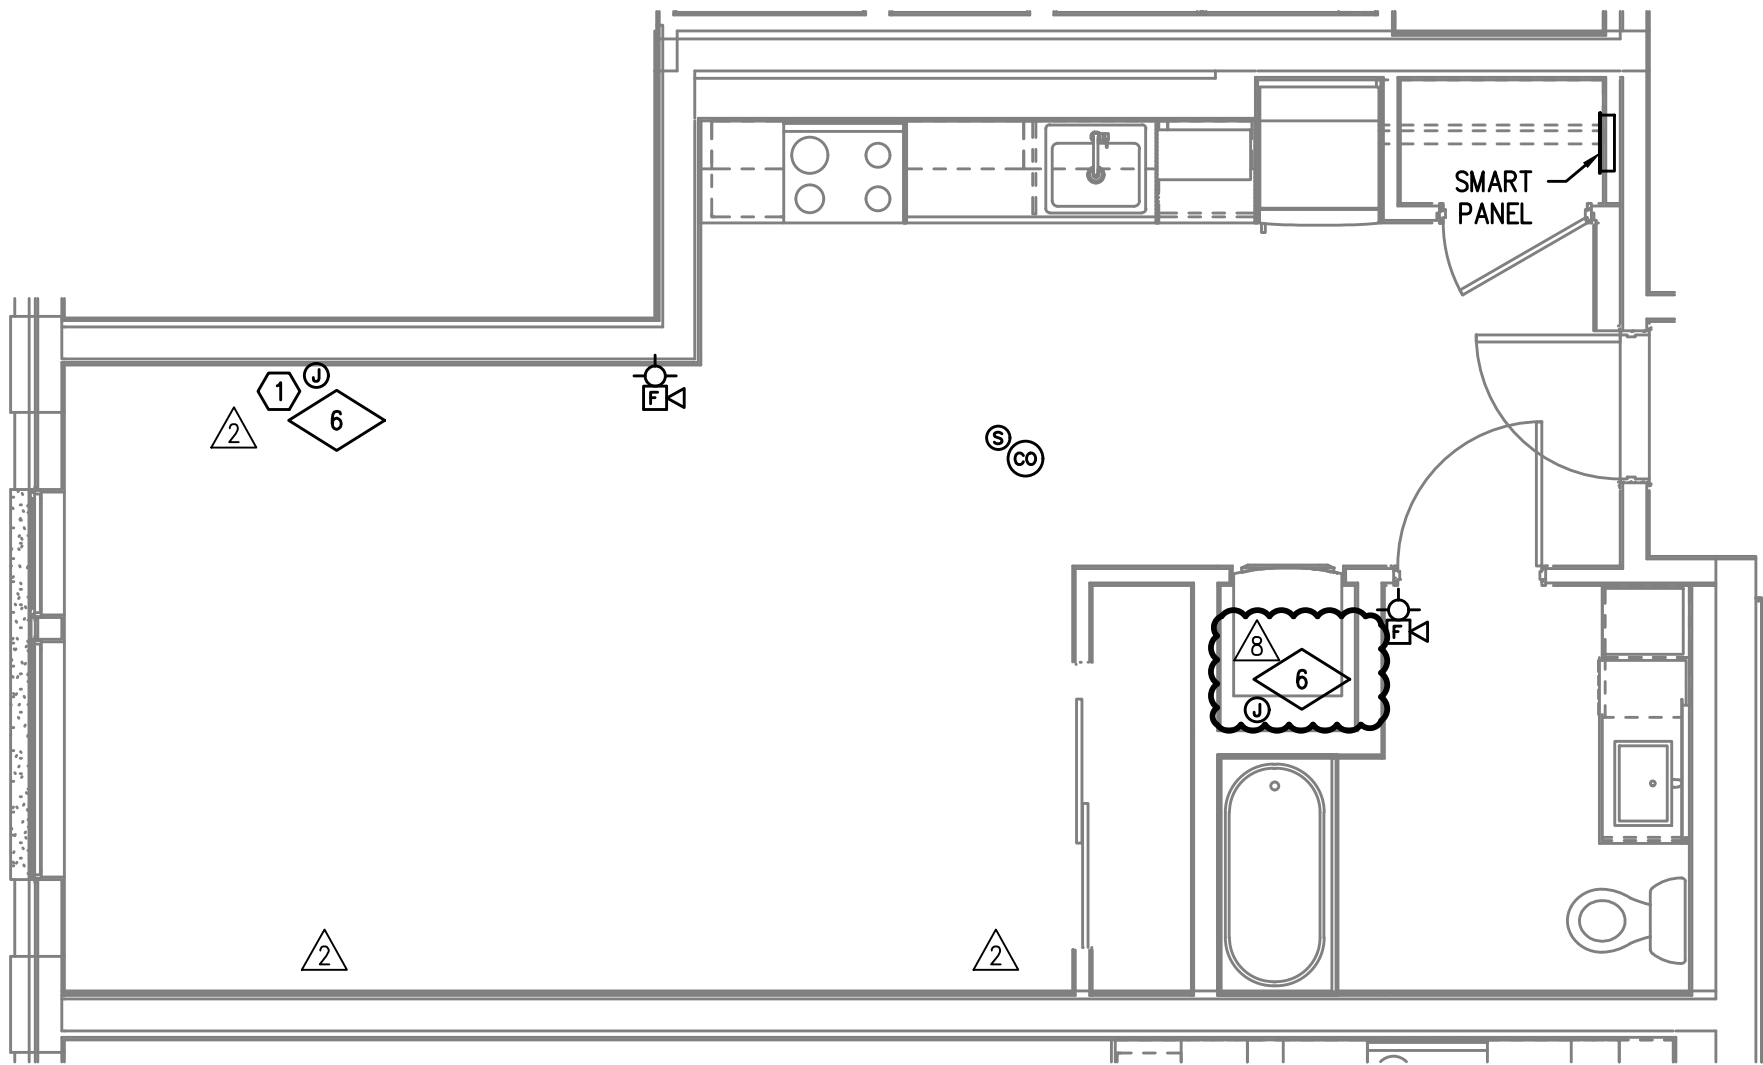

TYPICAL UNIT TYPE L-ADA
2 0 BED/1 BATH – TELCOM PLAN
T4.15 SCALE: 1/4" = 1'-0"

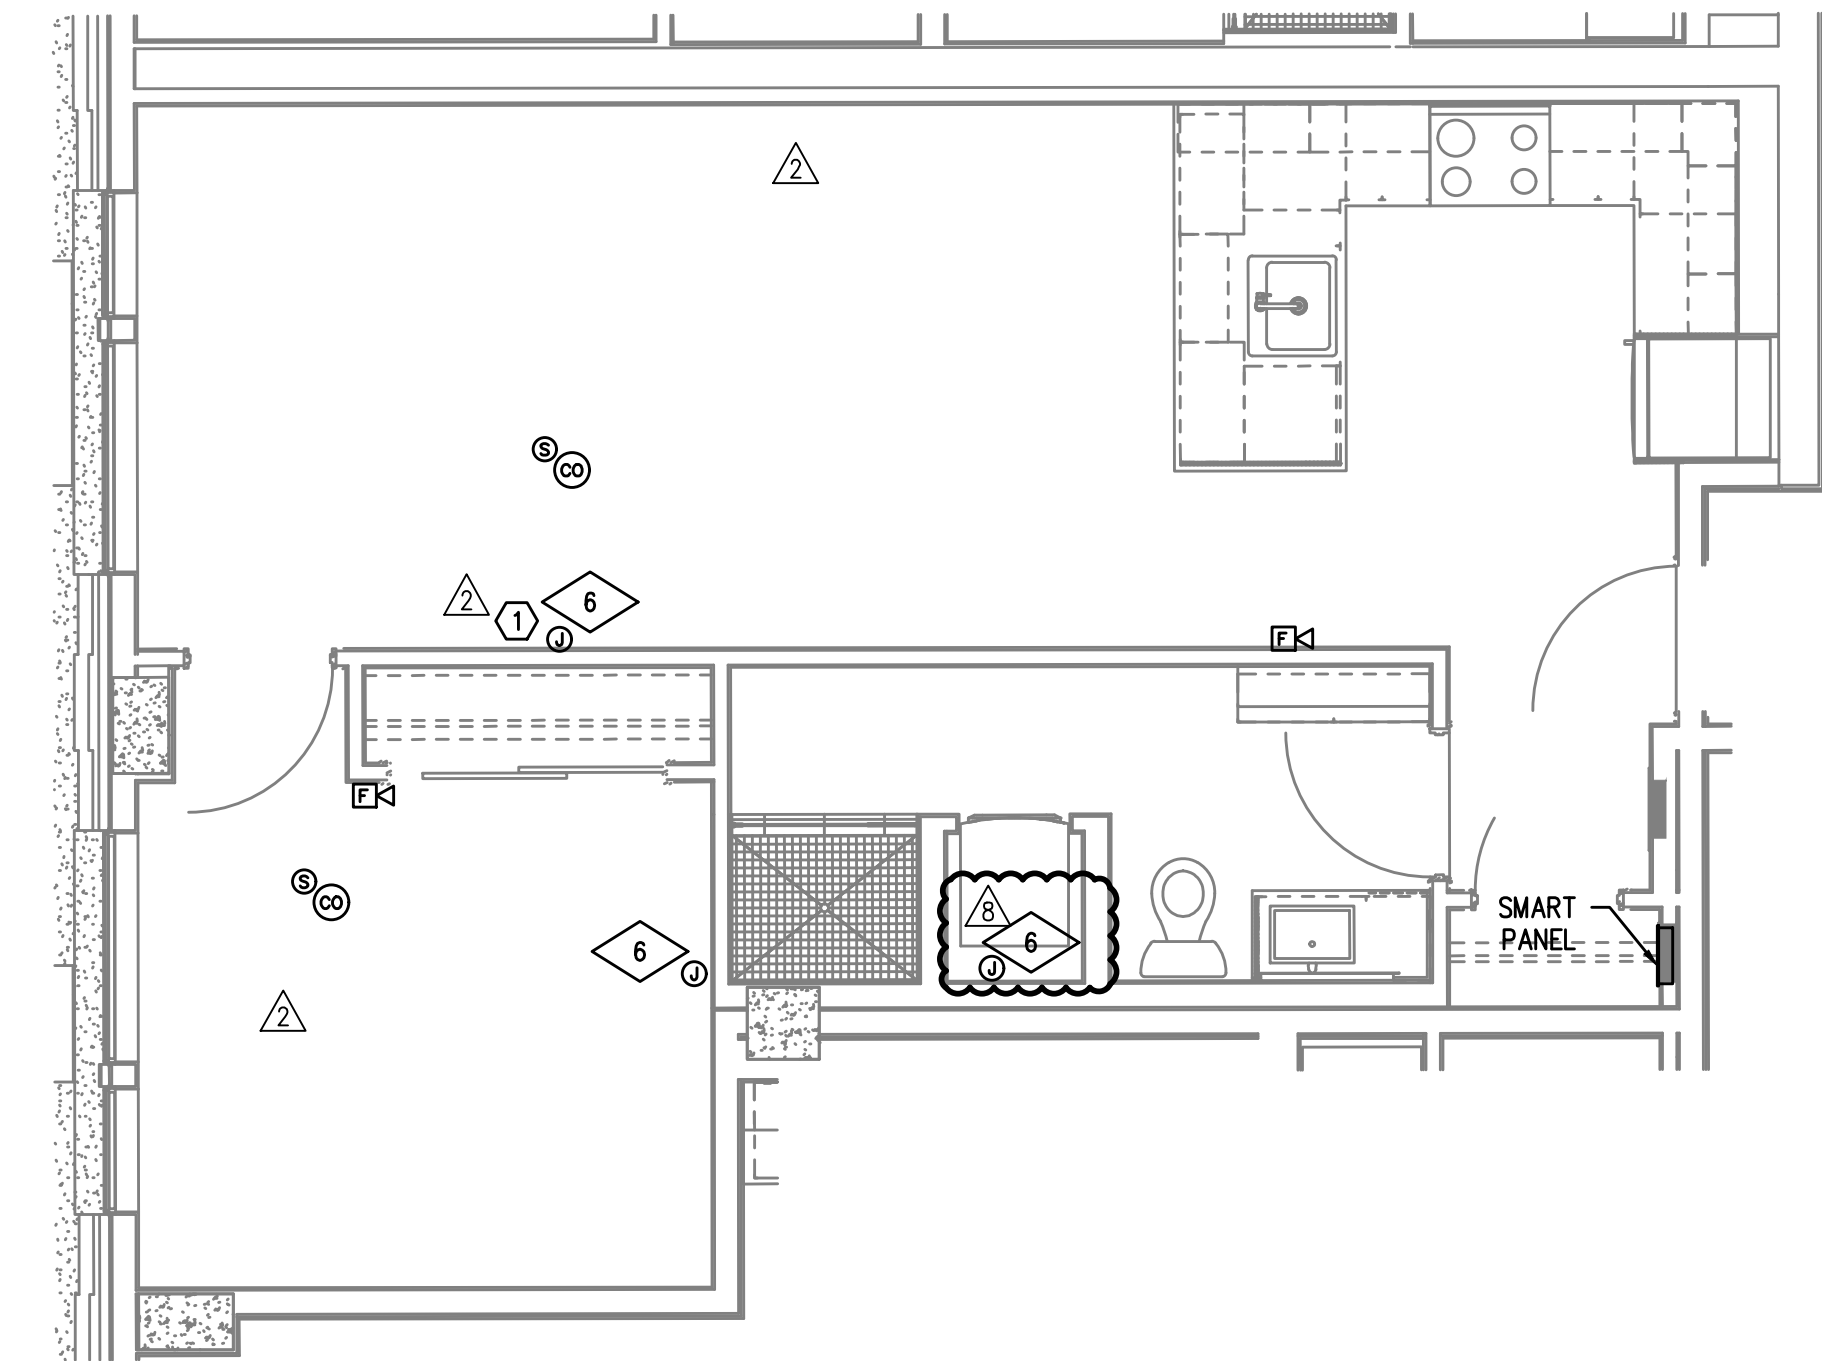

TYPICAL UNIT TYPE M
3 1 BED/1 BATH – TELCOM PLAN
T4.15 SCALE: 1/4" = 1'-0"

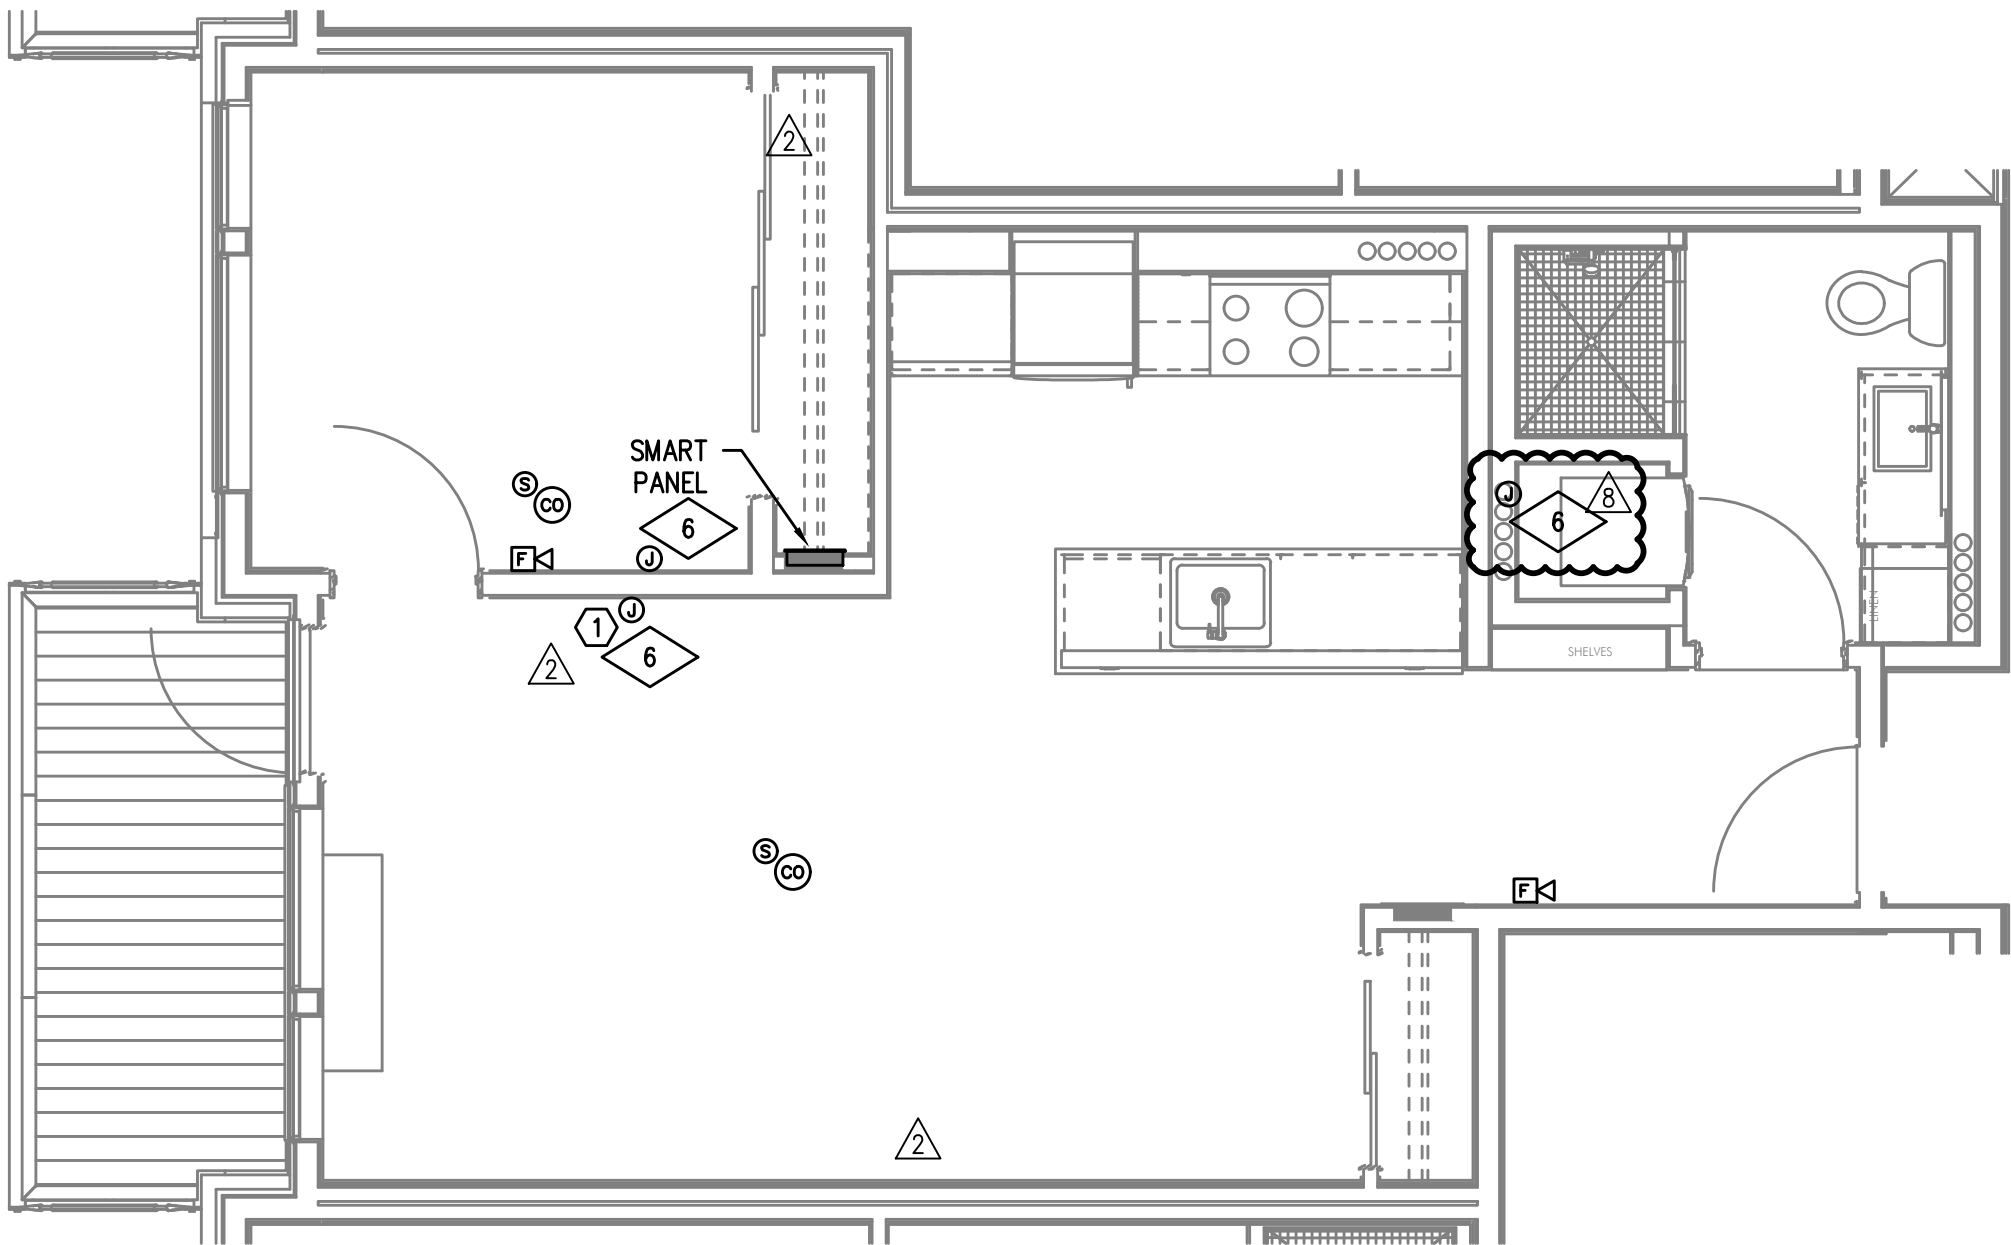

TYPICAL UNIT TYPE N
4 1 BED/1 BATH – TELCOM PLAN
T4.15 SCALE: 1/4" = 1'-0"

GENERAL NOTES:


- DRAWINGS ARE DIAGRAMMATICAL AND MAY NOT ACCURATELY REFLECT ACTUAL CONSTRUCTION CONDITIONS. THE CONTRACTOR SHALL BE RESPONSIBLE FOR COORDINATING THE INSTALLATION OF ALL EQUIPMENT THEY ARE INSTALLING, WITH ALL TRADES PRIOR TO AND DURING CONSTRUCTION.
- VOICE/CATV OUTLET SHALL BE AT THE SAME HEIGHT AS ADJACENT POWER OUTLET AND LESS THAN 6" SEPARATION. COORDINATE WITH ELECTRICAL.
- COORDINATE ALL DEVICE LOCATIONS WITH LATEST ARCHITECTURAL INTERIOR ELEVATIONS TO VERIFY DEVICES WILL NOT BE OBSTRUCTED.
- PROVIDE PULL STRING IN ALL CONDUITS FOR LATER USE.
- ALL PENETRATIONS THROUGH FIREWALLS WILL NEED FIRESTOP OF THE APPROPRIATE RATING.
- HORN AND/OR HORN-STROBE DEVICES CONNECT TO BUILDING FIRE ALARM SYSTEM.
- INSTALL STAND-ALONE SMOKE AND CO DETECTORS PER RESIDENTIAL CODE 907.

NOTES:

- SEE DETAIL 3, ON SHEET T1.21

FIRE ALARM AND DETECTION SYSTEM SHOWN ON PLAN(S) ARE FOR DESIGN INTENT ONLY. THIS IS A DEFERRED SUBMITTAL SYSTEM REQUIRING THE CONTRACTOR TO COMPLETE THE PERMIT READY DESIGN AND CALCULATIONS AS REQUIRED PER THE AUTHORITY HAVING JURISDICTION. VERIFY BUILDING OCCUPANCY TYPE AND OCCUPANT LOAD WITH ARCHITECTURAL PLANS.

M Consulting Engineers
2007 S.E. Ash St.
Portland, OR 97214
PHN: (503) 234-0548
FAX: (503) 234-0677
INC. WWW.MPIA-ENG.COM
CONTACT: GARY ADOVNIK

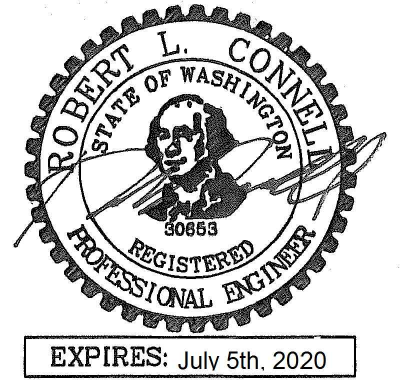

IN THE EVENT CONFLICTS ARE DISCOVERED BETWEEN THE ORIGINAL SIGNED AND SEALED DOCUMENTS PREPARED BY THE ARCHITECTS AND/OR THEIR CONSULTANTS, AND ANY COPY OF THE DOCUMENTS TRANSMITTED BY MAIL, FAX, ELECTRONICALLY OR OTHERWISE, THE ORIGINAL SIGNED AND SEALED DOCUMENTS SHALL GOVERN.

PROJECT # 2017-053
DATE: 11/06/2019

REVISIONS
PLAN REVIEW 01.24.2020
PLAN REVIEW 03.13.2020
PLAN REVIEW 04.24.2020
PLAN REVIEW 08.10.2020
PLAN REVIEW 09.17.2020
PLAN REVIEW 10.16.2020
PLAN REVIEW 11.25.2020

AEGIS
MIXED-USE DEVELOPMENT
312 E EVERGREEN BOULEVARD, VANCOUVER, WA 98660

SHEET:

T4.15