

PRELIMINARY
NOT FOR
CONSTRUCTIONIN THE EVENT CONFLICTS ARE DISCOVERED
BETWEEN THE ORIGINAL SIGNED AND SEALED
DOCUMENTS PREPARED BY THE ARCHITECTS
AND/OR THEIR CONSULTANTS, AND ANY COPY OF
THE DOCUMENTS TRANSMITTED BY MAIL, FAX,
ELECTRONICALLY OR OTHERWISE, THE ORIGINAL
SIGNED AND SEALED DOCUMENTS SHALL GOVERN.PROJECT # 2017-053
DATE: 11/19/2021

REVISIONS

AEGIS - PHASE II
MIXED-USE DEVELOPMENT
312 E EVERGREEN BOULEVARD, VANCOUVER, WA 98660

SHEET:


E4.00

GENERAL NOTES:


- A. ALL PLANS ARE DIAGRAMMATICAL. CONSULT ARCHITECTURAL PLANS FOR EXACT LOCATION OF ALL DEVICES AND FIXTURES.
- B. REFER TO SHEET E1.14 FOR TYPICAL UNIT LOAD CENTER DIRECTORIES.
- C. ALL LIGHT SWITCHES SHALL BE ROCKER STYLE, SUCH AS LEVITON DECORA, OR APPROVED EQUAL.
- D. REFER TO ARCHITECTURAL REFLECTED CEILING PLANS FOR EXACT FIXTURE LOCATIONS. CONSULT INTERIOR DESIGNER FOR MOUNTING HEIGHTS NOT SPECIFIED.

KEYED NOTES:

1. REFER TO TYPICAL BATHROOM SWITCHING DETAILS ON SHEET E1.22.
2. PROVIDE ROUGH IN AND FINAL POWER CONNECTION FOR CEILING MOUNTED LOW VOLTAGE DEVICES. TIE INTO CLOSEST RECEPTACLE CIRCUIT. REFER TO 'T' SERIES SHEETS FOR EXACT LOCATIONS AND COORDINATE INSTALLATION WITH SYSTEM INSTALLER.
3. RECEPTACLE FOR PTHP UNIT SHALL BE LOCATED BELOW THE UNIT, NEAR THE BASE OF THE WALL SUCH THAT THE CORD SET IS CONCEALED AS MUCH AS POSSIBLE. COORDINATE INSTALLATION WITH THE MECHANICAL INSTALLER.
4. LOCATE SWITCH FOR SINK LIGHT AT THE END OF THE COUNTER, JUST UNDER THE EDGE OF THE COUNTER TOP.
5. SWITCHING FOR CEILING FAN SHALL BE MANUFACTURER'S RECOMMENDATION FOR LIGHT AND FAN CONTROL.
6. REFER TO ARCHITECTURAL INTERIOR ELEVATIONS FOR LOCATION AND MOUNTING OF UNDER CABINET LIGHTS.
7. TIE BATHROOM LIGHTS INTO THE NEAREST LIGHTING CIRCUIT.

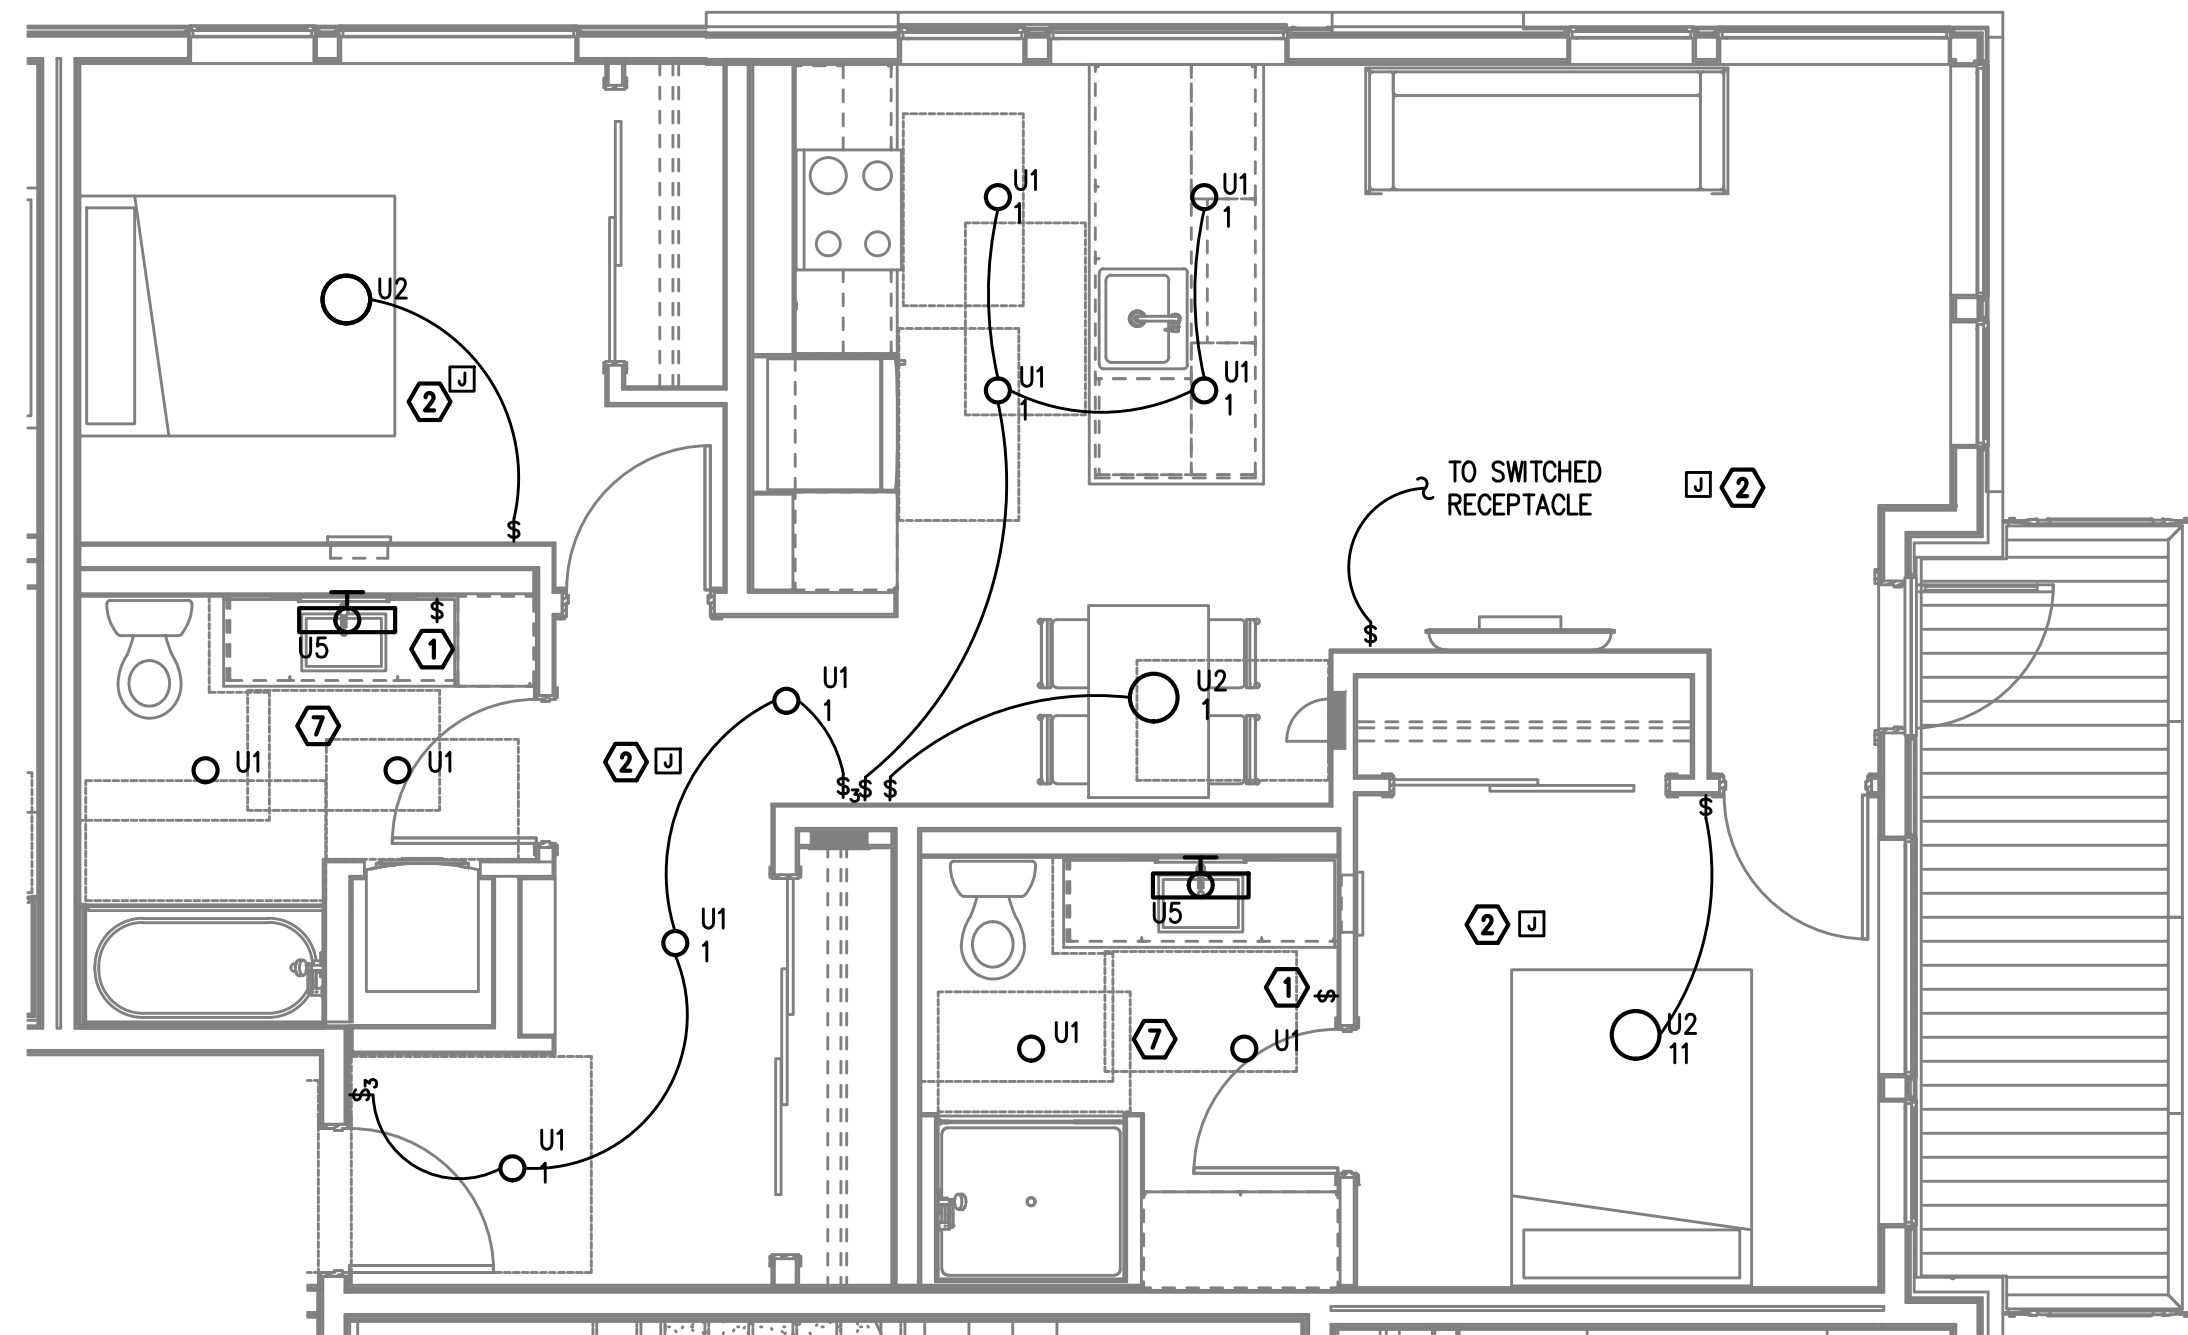


1 TYPICAL UNIT TYPE A
2 BED/2 BATH - LIGHTING PLAN
E4.00 SCALE: 1/4" = 1'-0"

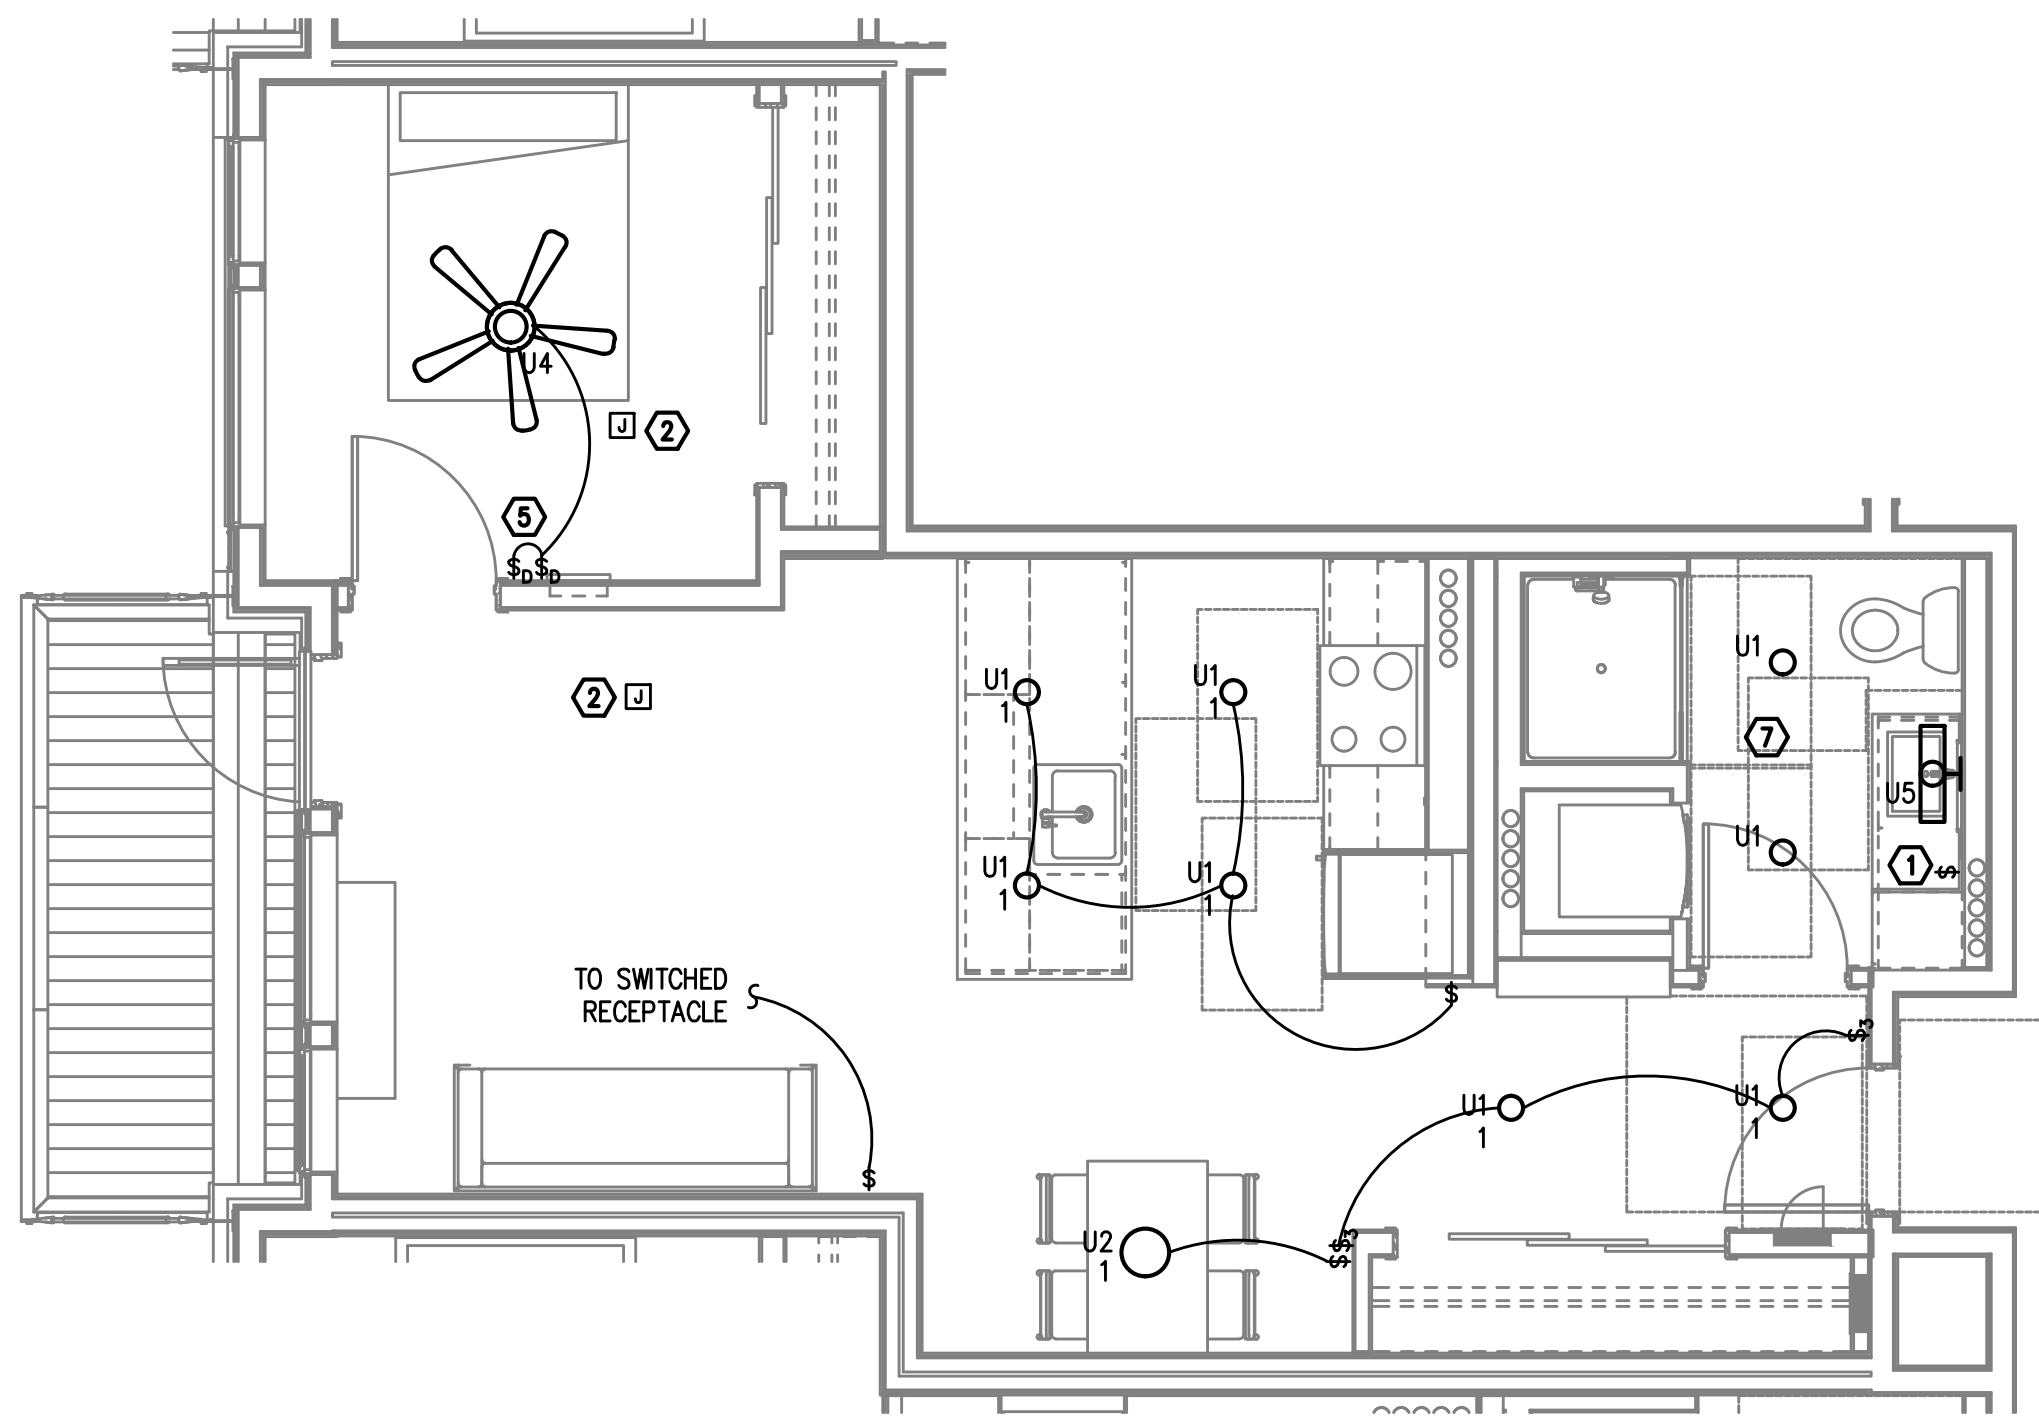

2 TYPICAL UNIT TYPE B
1 BED/1 BATH - LIGHTING PLAN
E4.00 SCALE: 1/4" = 1'-0"


PRELIMINARY
NOT FOR
CONSTRUCTIONIN THE EVENT CONFLICTS ARE DISCOVERED
BETWEEN THE ORIGINAL SIGNED AND SEALED
DOCUMENTS PREPARED BY THE ARCHITECTS
AND/OR THEIR CONSULTANTS, AND ANY COPY OF
THE DOCUMENTS TRANSMITTED BY MAIL, FAX,
ELECTRONICALLY OR OTHERWISE, THE ORIGINAL
SIGNED AND SEALED DOCUMENTS SHALL GOVERN.PROJECT # 2017-053
DATE: 11/19/2021

REVISIONS

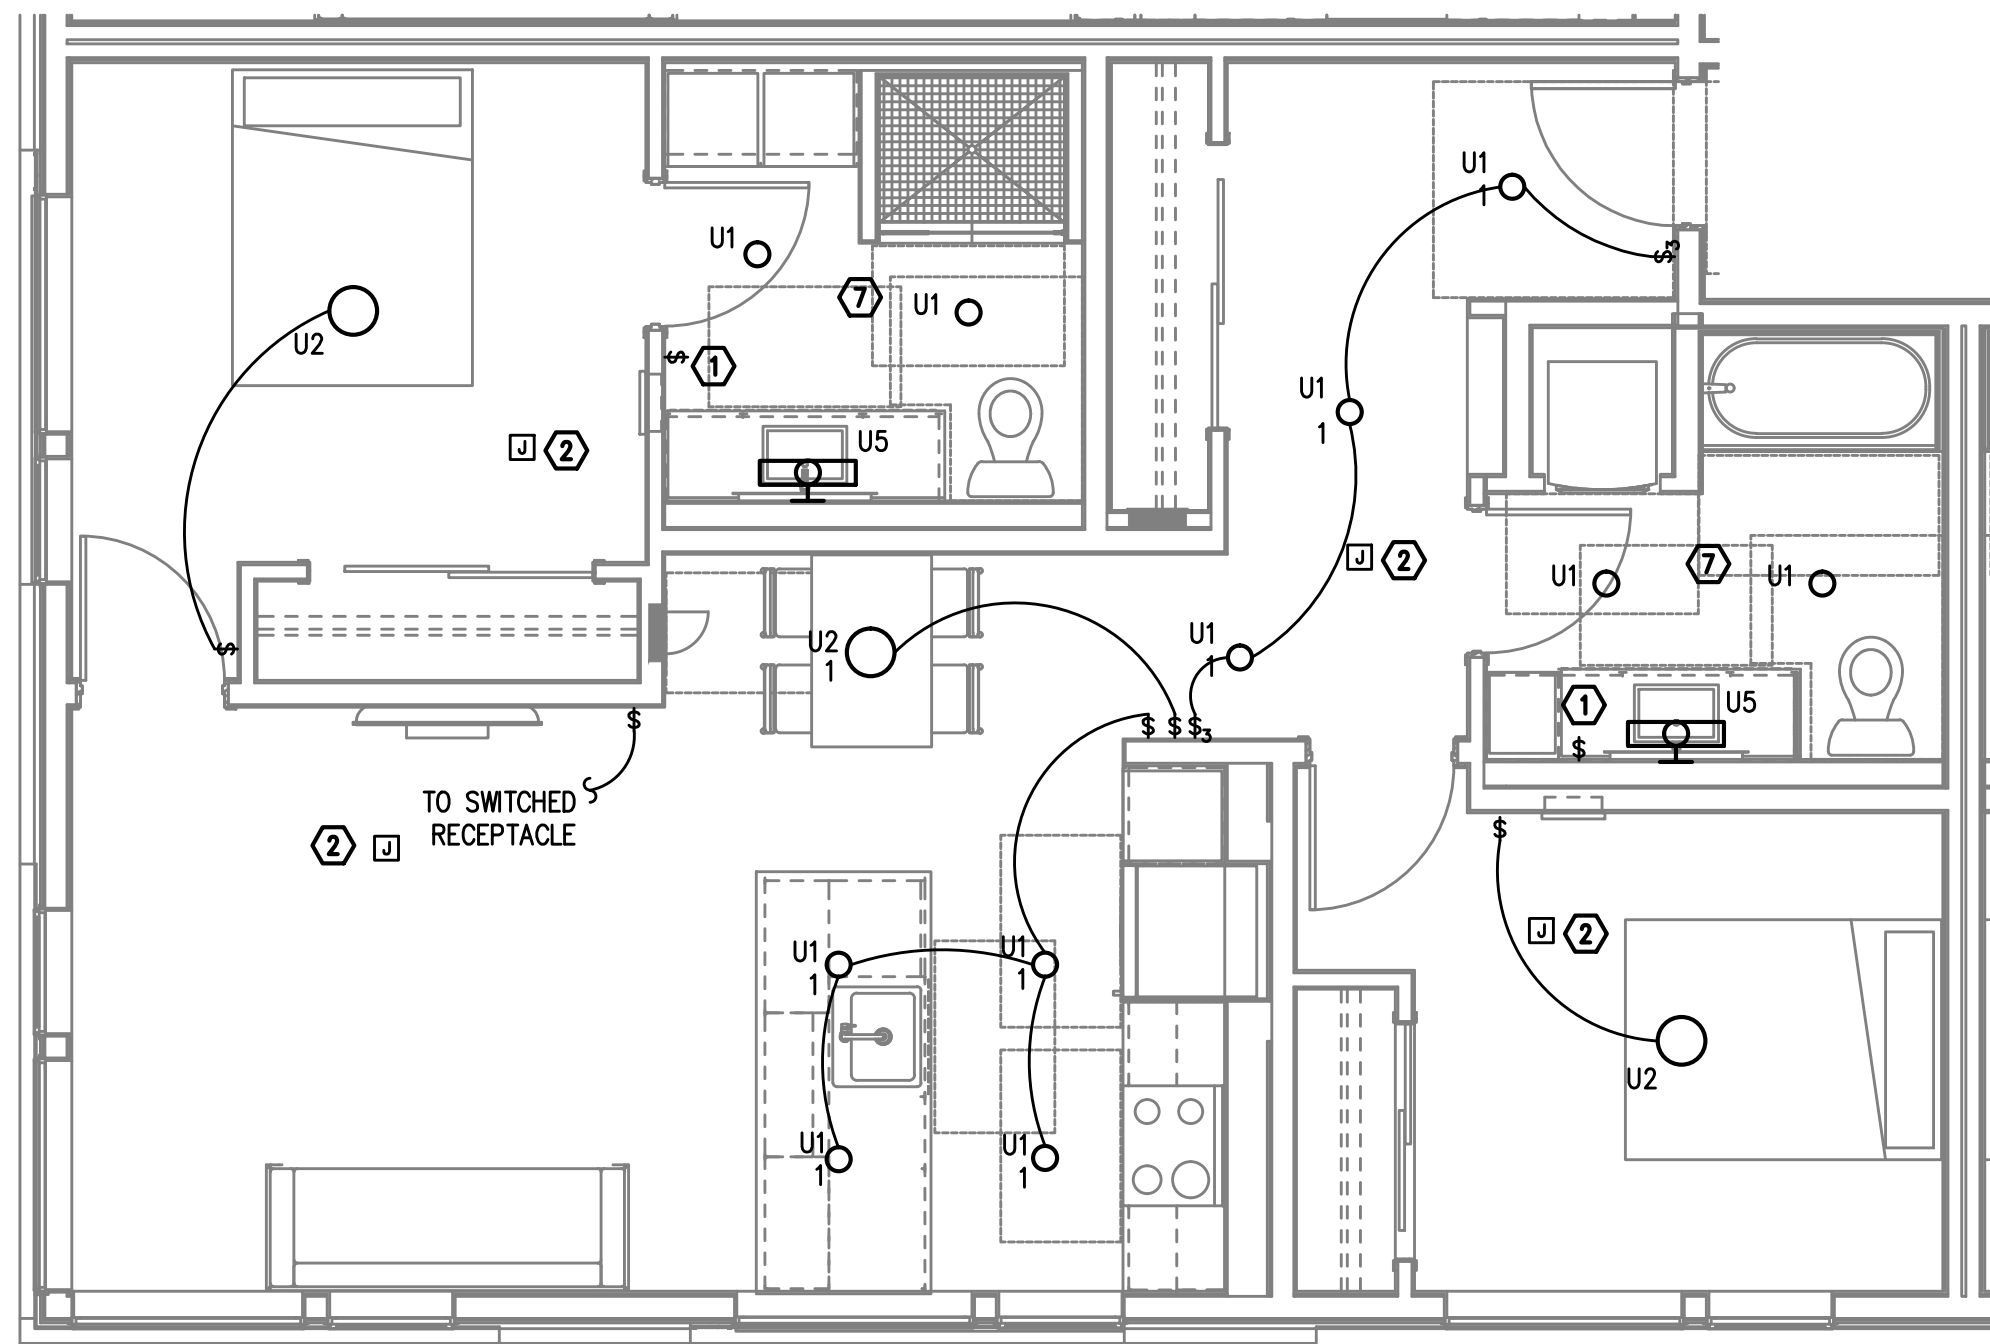


TYPICAL UNIT TYPE E

1 2 BED/1 BATH – LIGHTING PLAN
E4.01 SCALE: 1/4" = 1'-0"

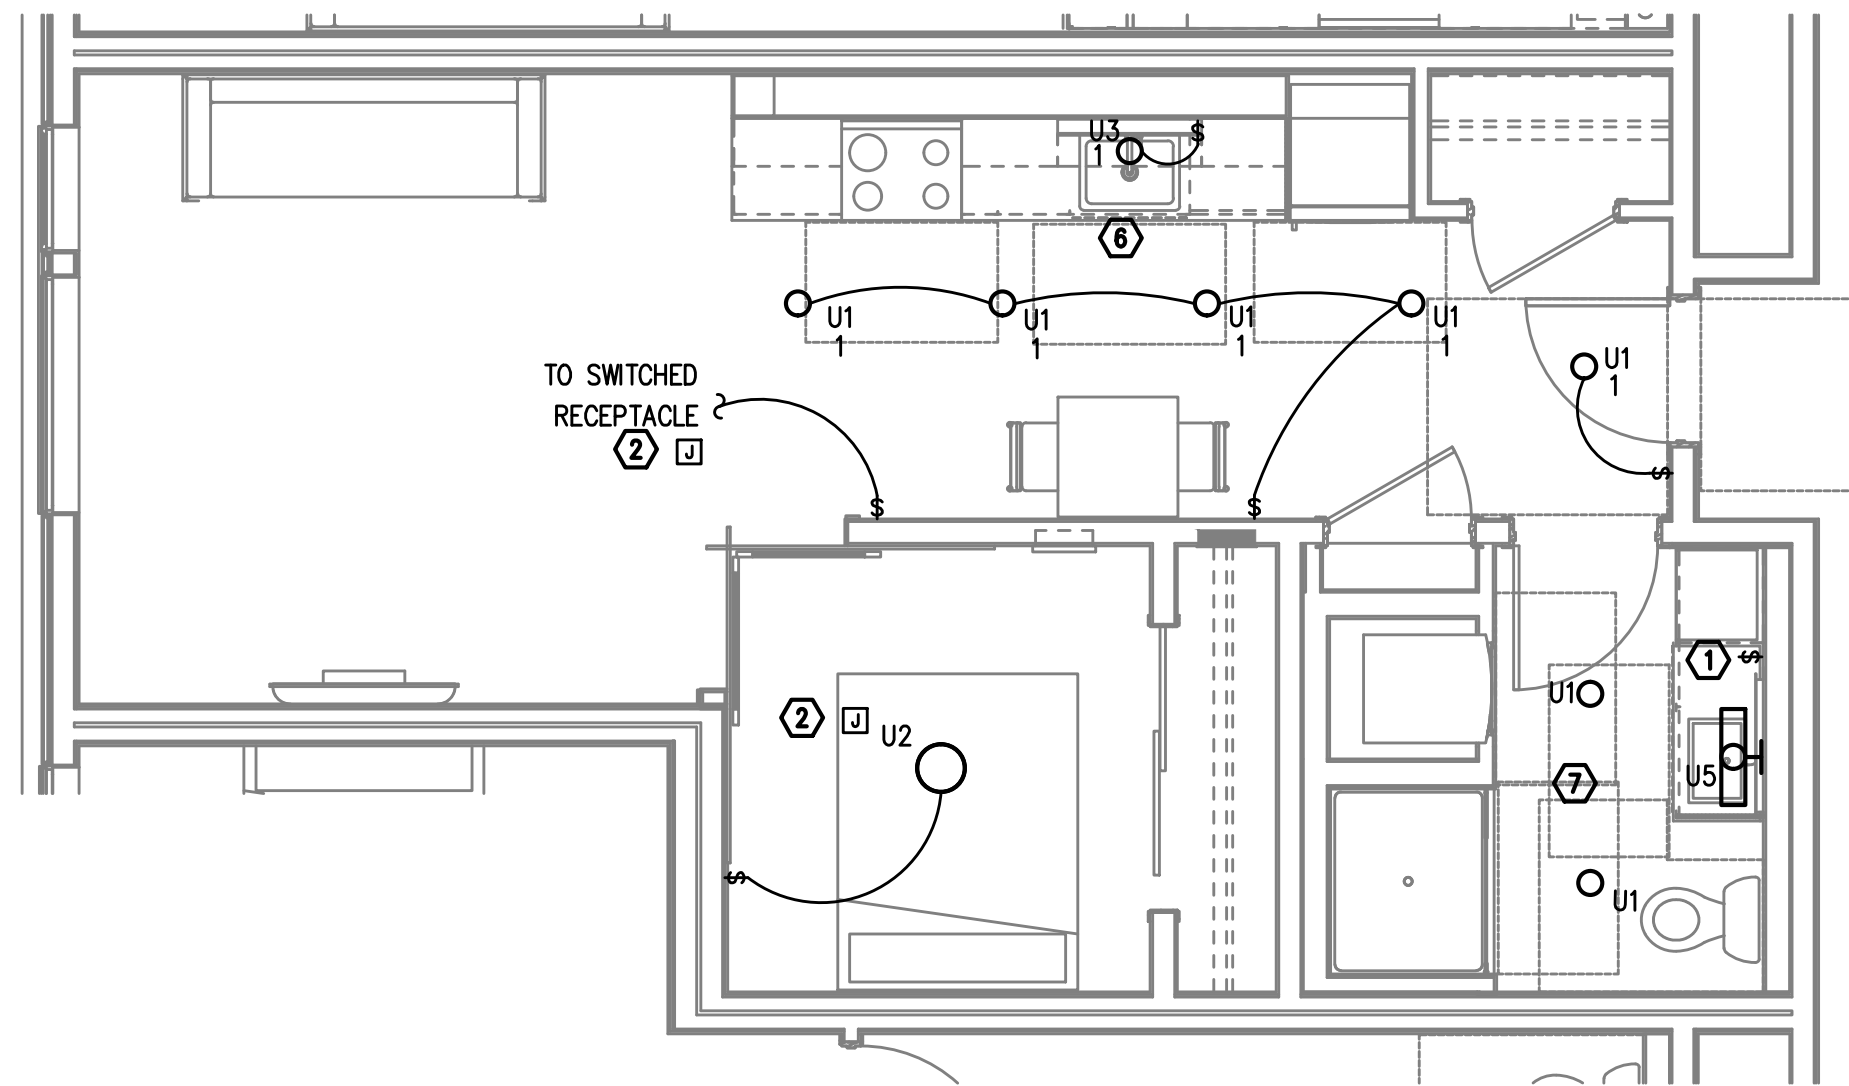


TYPICAL UNIT TYPE G

2 0 BED/1 BATH – LIGHTING PLAN
E4.01 SCALE: 1/4" = 1'-0"

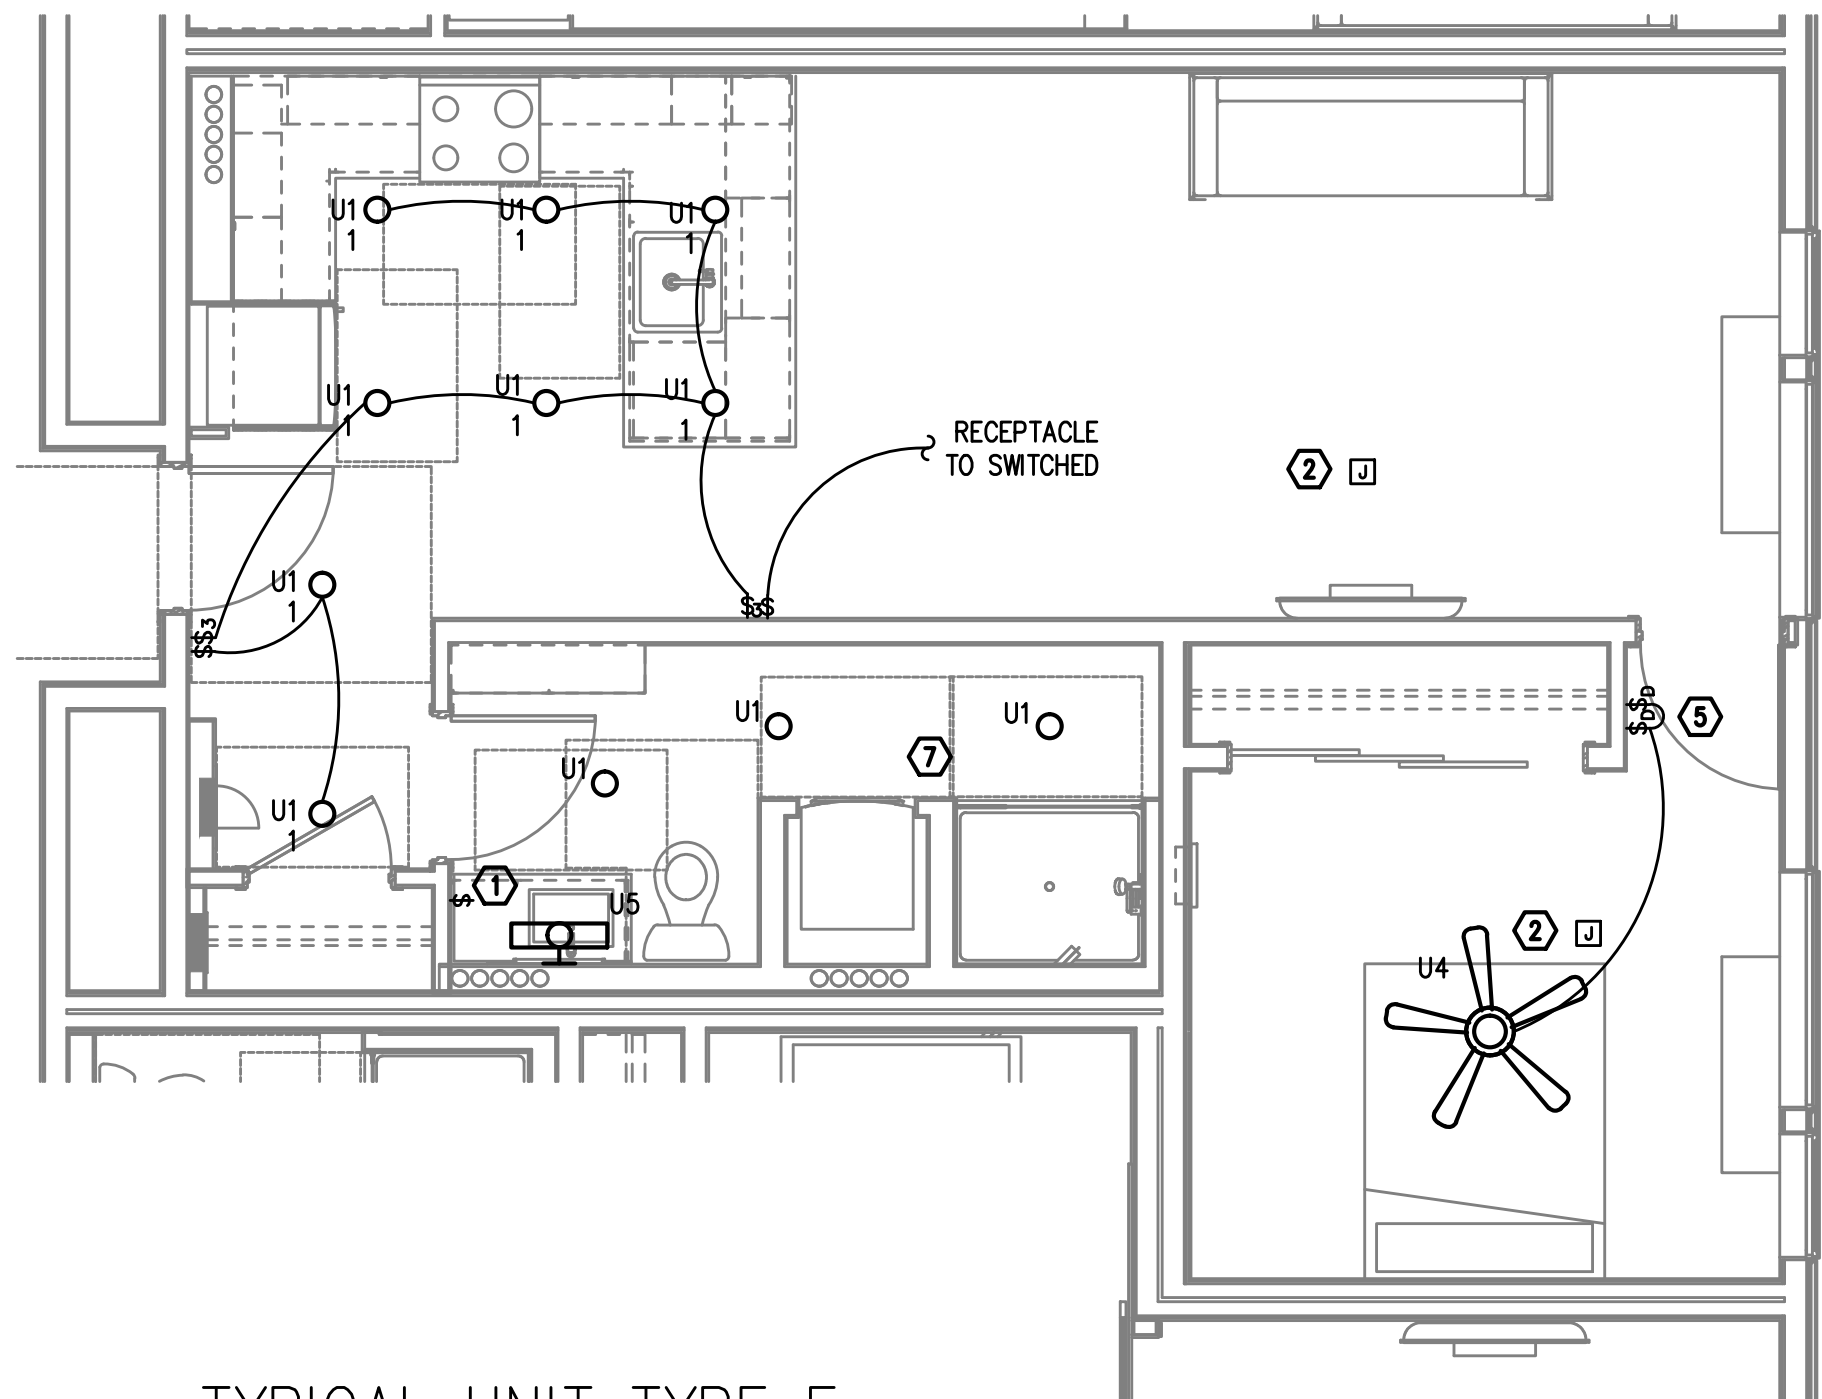

TYPICAL UNIT TYPE F

3 2 BED/1 BATH – LIGHTING PLAN
E4.01 SCALE: 1/4" = 1'-0"

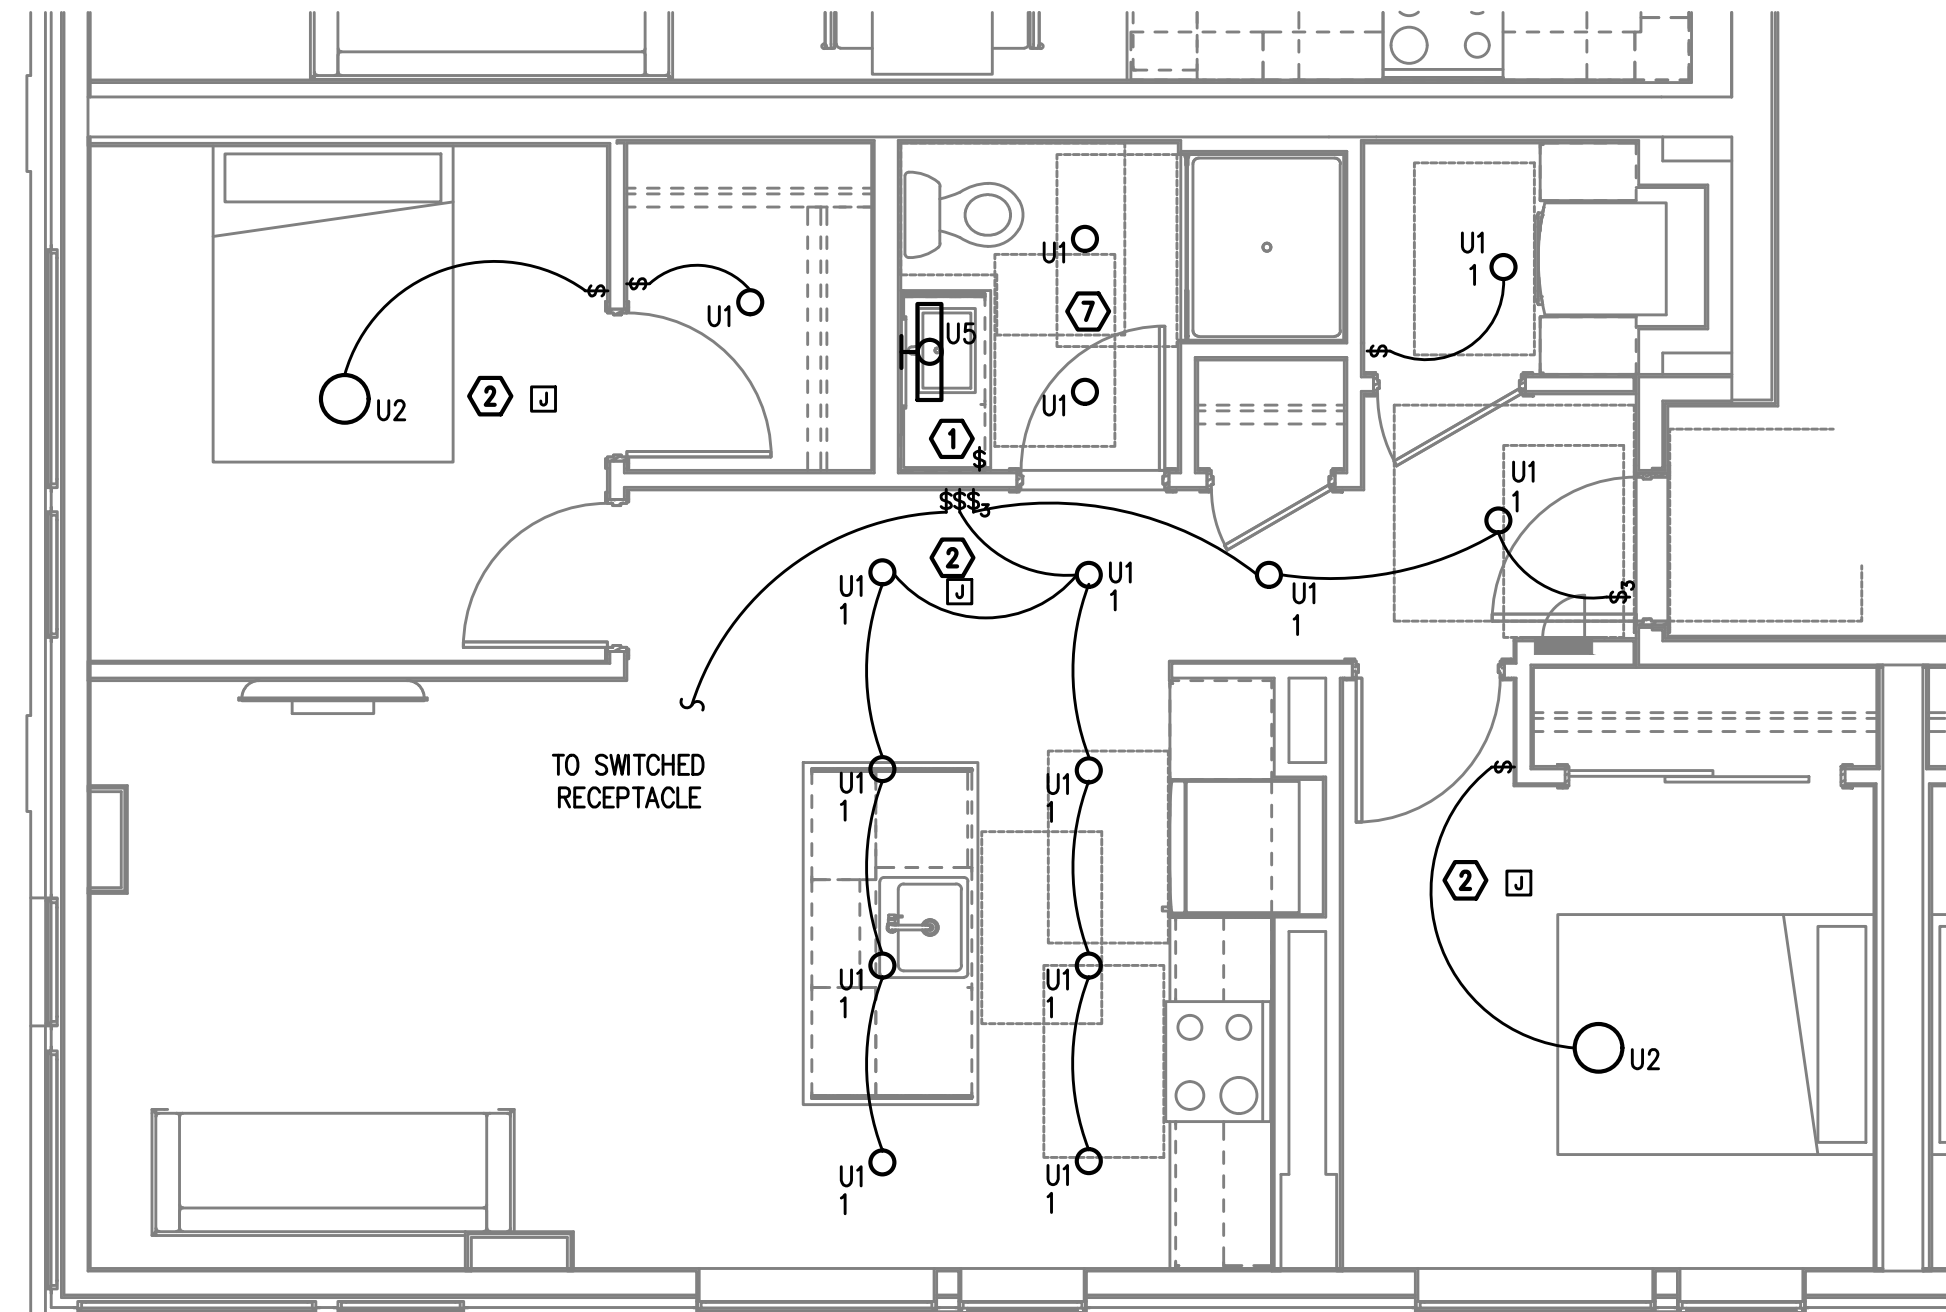

TYPICAL UNIT TYPE K

4 2 BED/1 BATH – LIGHTING PLAN
E4.01 SCALE: 1/4" = 1'-0"

NOTE:

REFER TO SHEET E4.01 FOR GENERAL AND KEYED LIGHTING NOTES.


M Consulting Engineers
F 2007 S.E. Ash St.
E Portland, OR 97214
A PHN: (503) 234-0548
INC. FAX: (503) 234-0677
CONTACT: DENISE TAYLOR

**AEGIS - PHASE II
MIXED-USE DEVELOPMENT**
312 E EVERGREEN BOULEVARD, VANCOUVER, WA 98660


SHEET:

E4.01


NOTE:
REFER TO SHEET E4.01 FOR GENERAL AND KEYED LIGHTING NOTES.

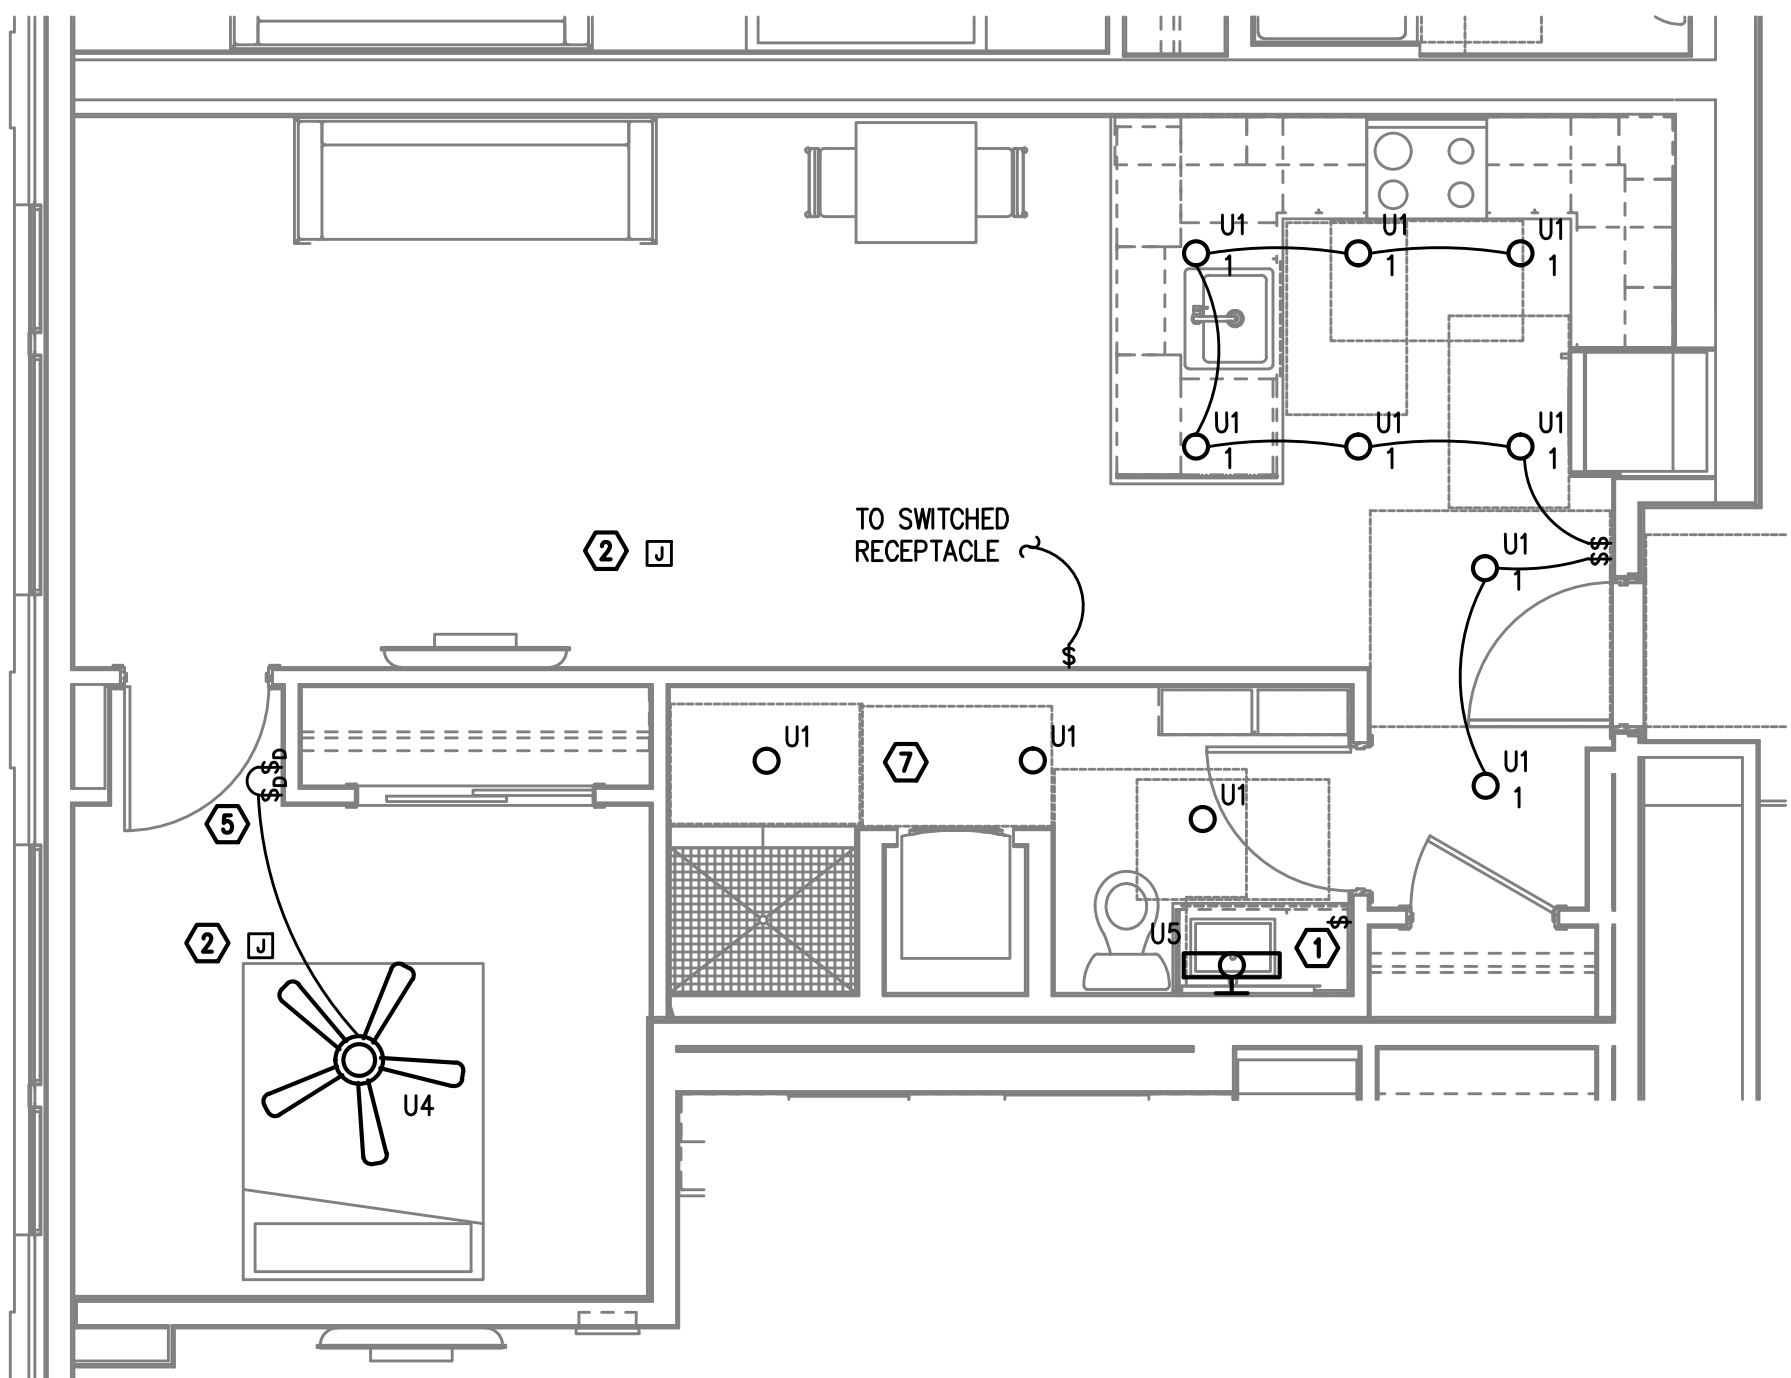

2
E4.02
TYPICAL UNIT TYPE M
1 BED/1 BATH - LIGHTING PLAN
SCALE: 1/4" = 1'-0"

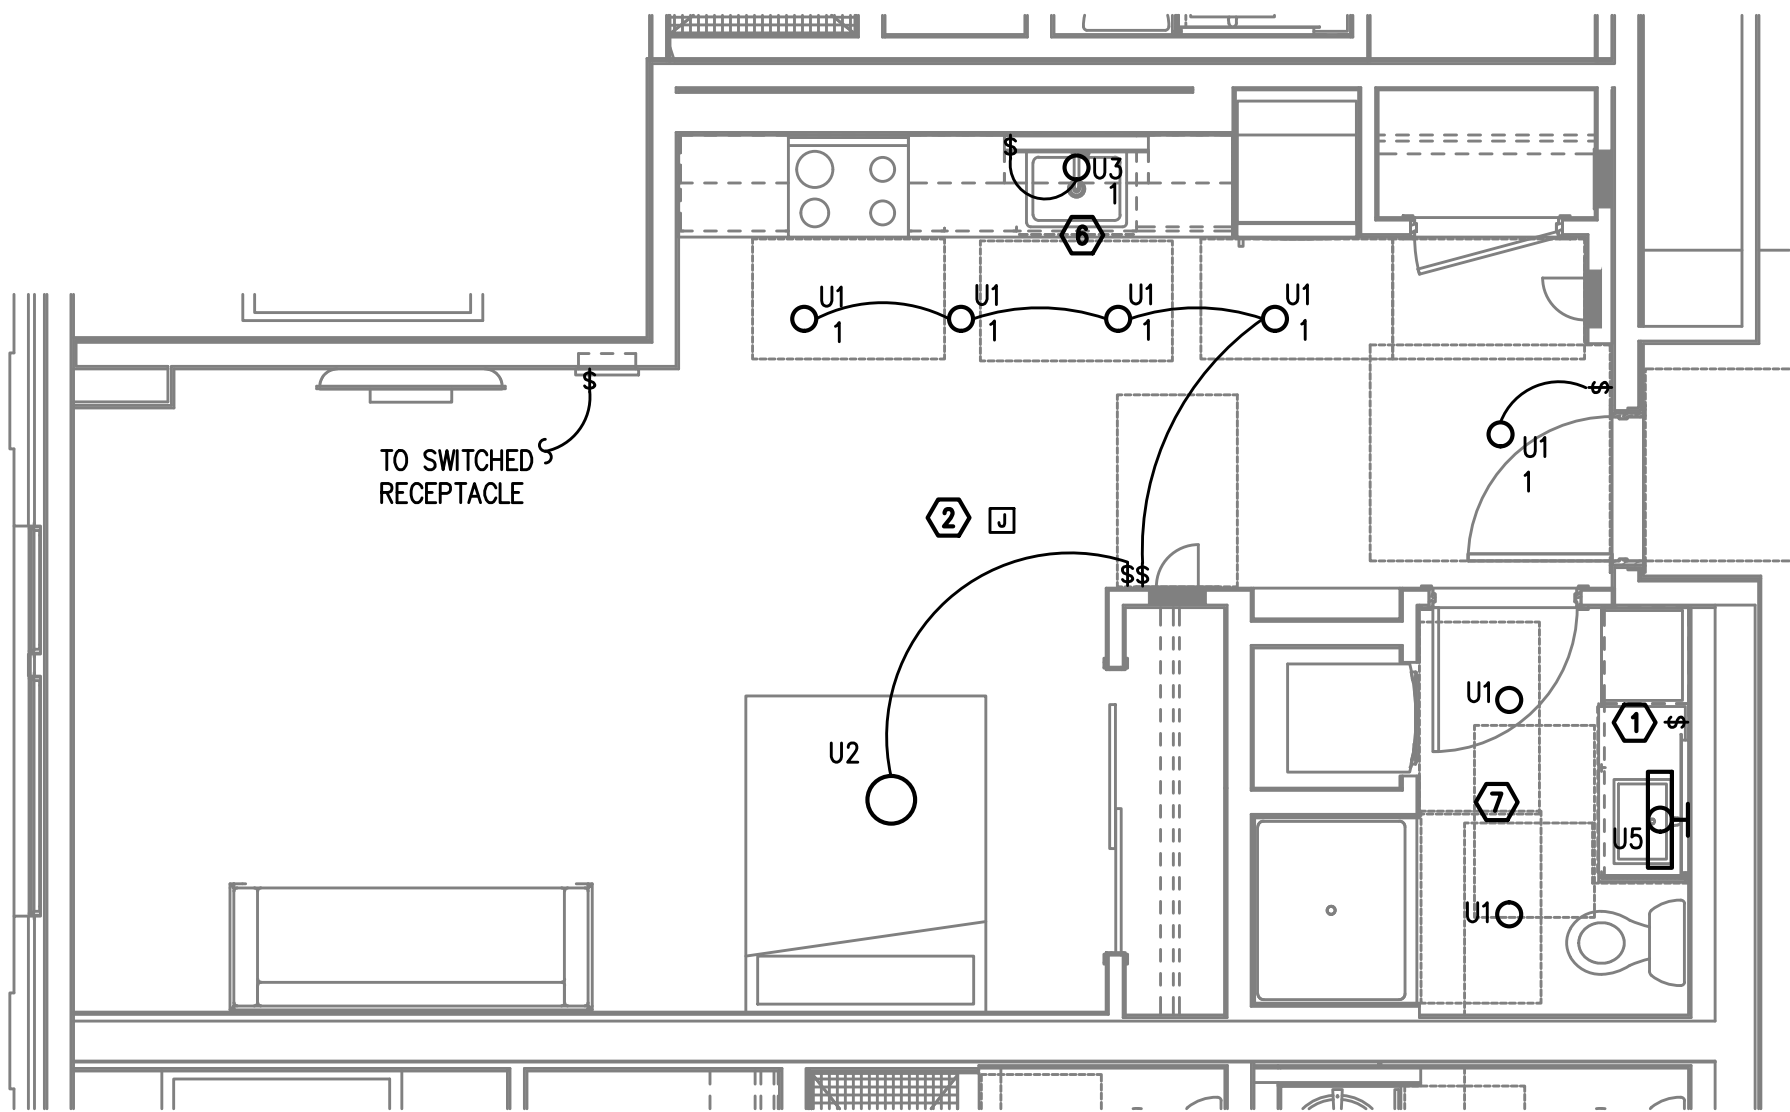

1
E4.02
TYPICAL UNIT TYPE L
0 BED/1 BATH - LIGHTING PLAN
SCALE: 1/4" = 1'-0"

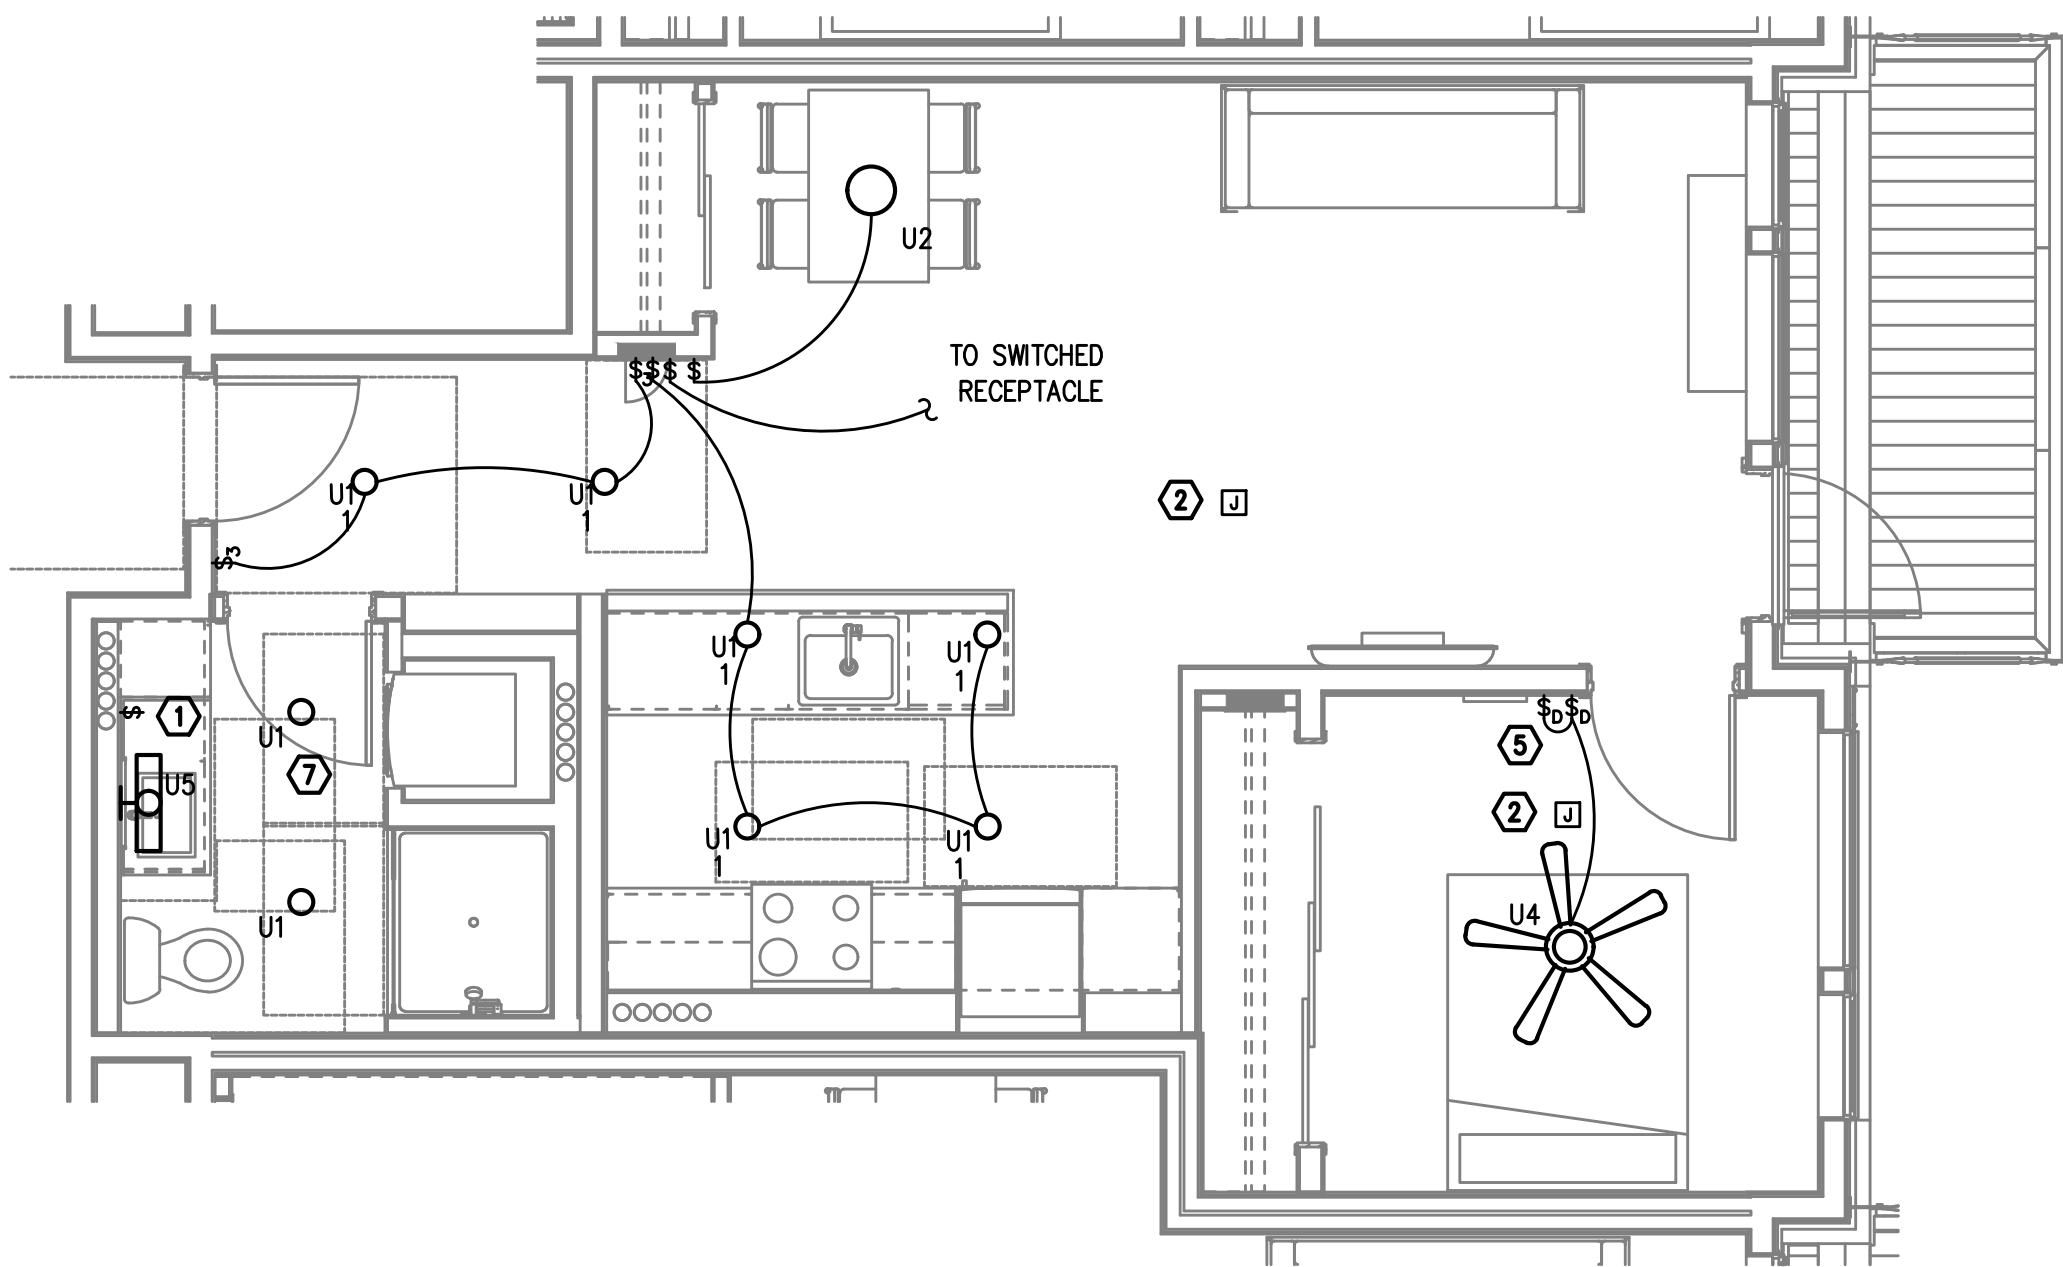

3
E4.02
TYPICAL UNIT TYPE N
1 BED/1 BATH - LIGHTING PLAN
SCALE: 1/4" = 1'-0"


PRELIMINARY
NOT FOR
CONSTRUCTIONIN THE EVENT CONFLICTS ARE DISCOVERED
BETWEEN THE ORIGINAL SIGNED AND SEALED
DOCUMENTS PREPARED BY THE ARCHITECTS
AND/OR THEIR CONSULTANTS, AND ANY COPY OF
THE DOCUMENTS TRANSMITTED BY MAIL, FAX,
ELECTRONICALLY OR OTHERWISE, THE ORIGINAL
SIGNED AND SEALED DOCUMENTS SHALL GOVERN.PROJECT # 2017-053
DATE: 11/19/2021

REVISIONS

AEGIS - PHASE II
MIXED-USE DEVELOPMENT
312 E EVERGREEN BOULEVARD, VANCOUVER, WA 98660

SHEET:


E4.03

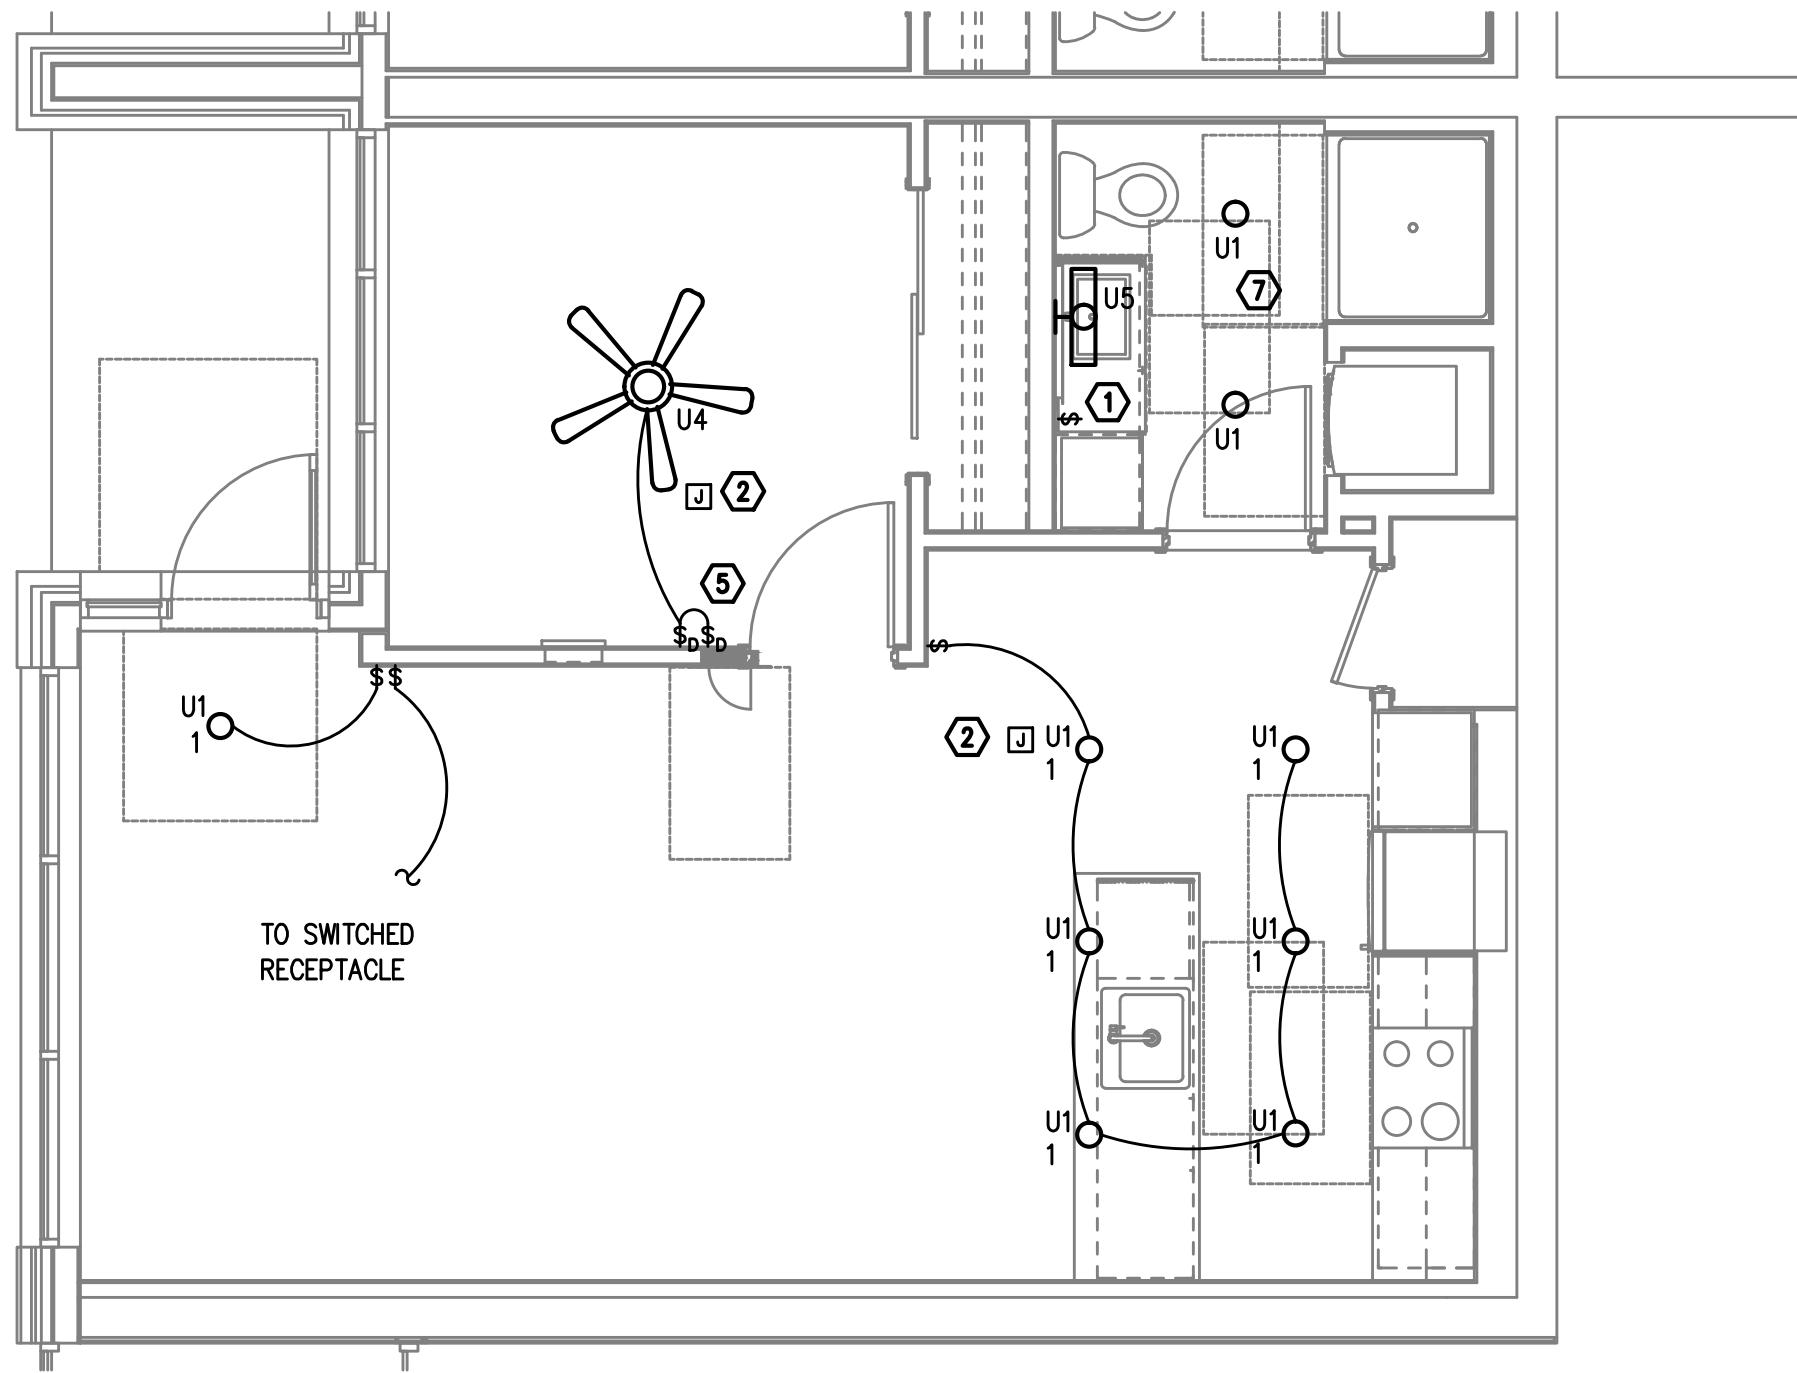

TYPICAL UNIT TYPE Q

1 1 BED/1 BATH - LIGHTING PLAN


E4.03 SCALE: 1/4" = 1'-0"

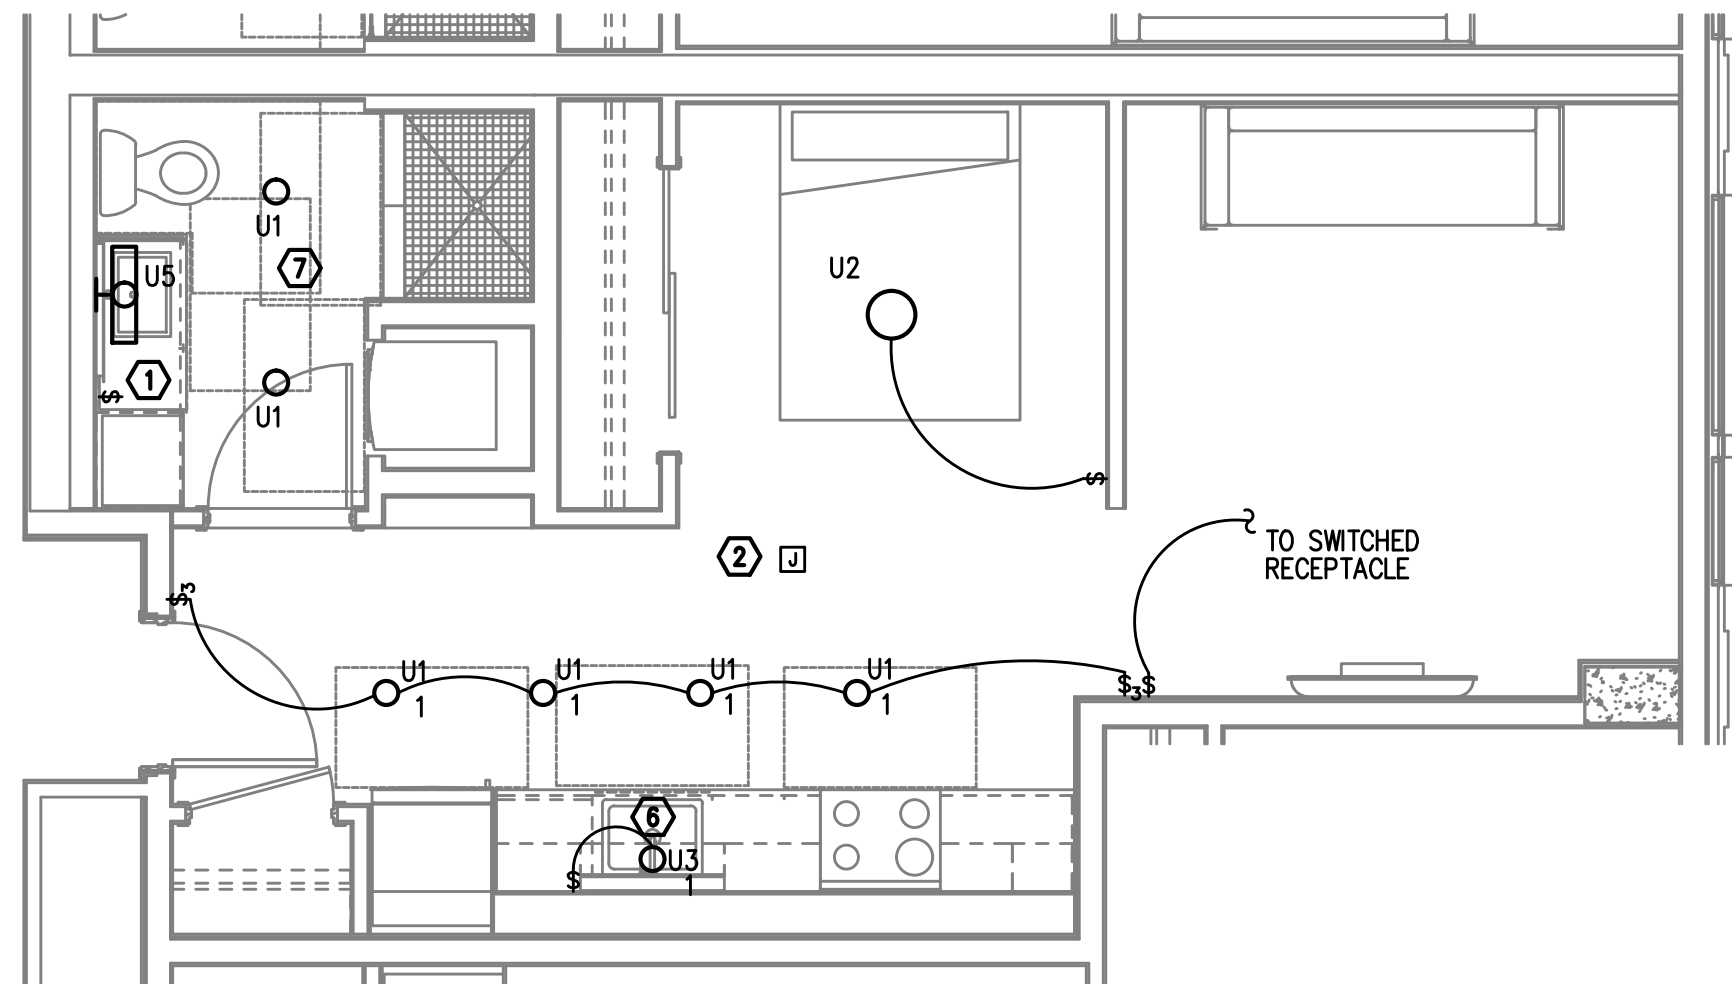

TYPICAL UNIT TYPE S

3 0 BED/1 BATH - LIGHTING PLAN


E4.03 SCALE: 1/4" = 1'-0"

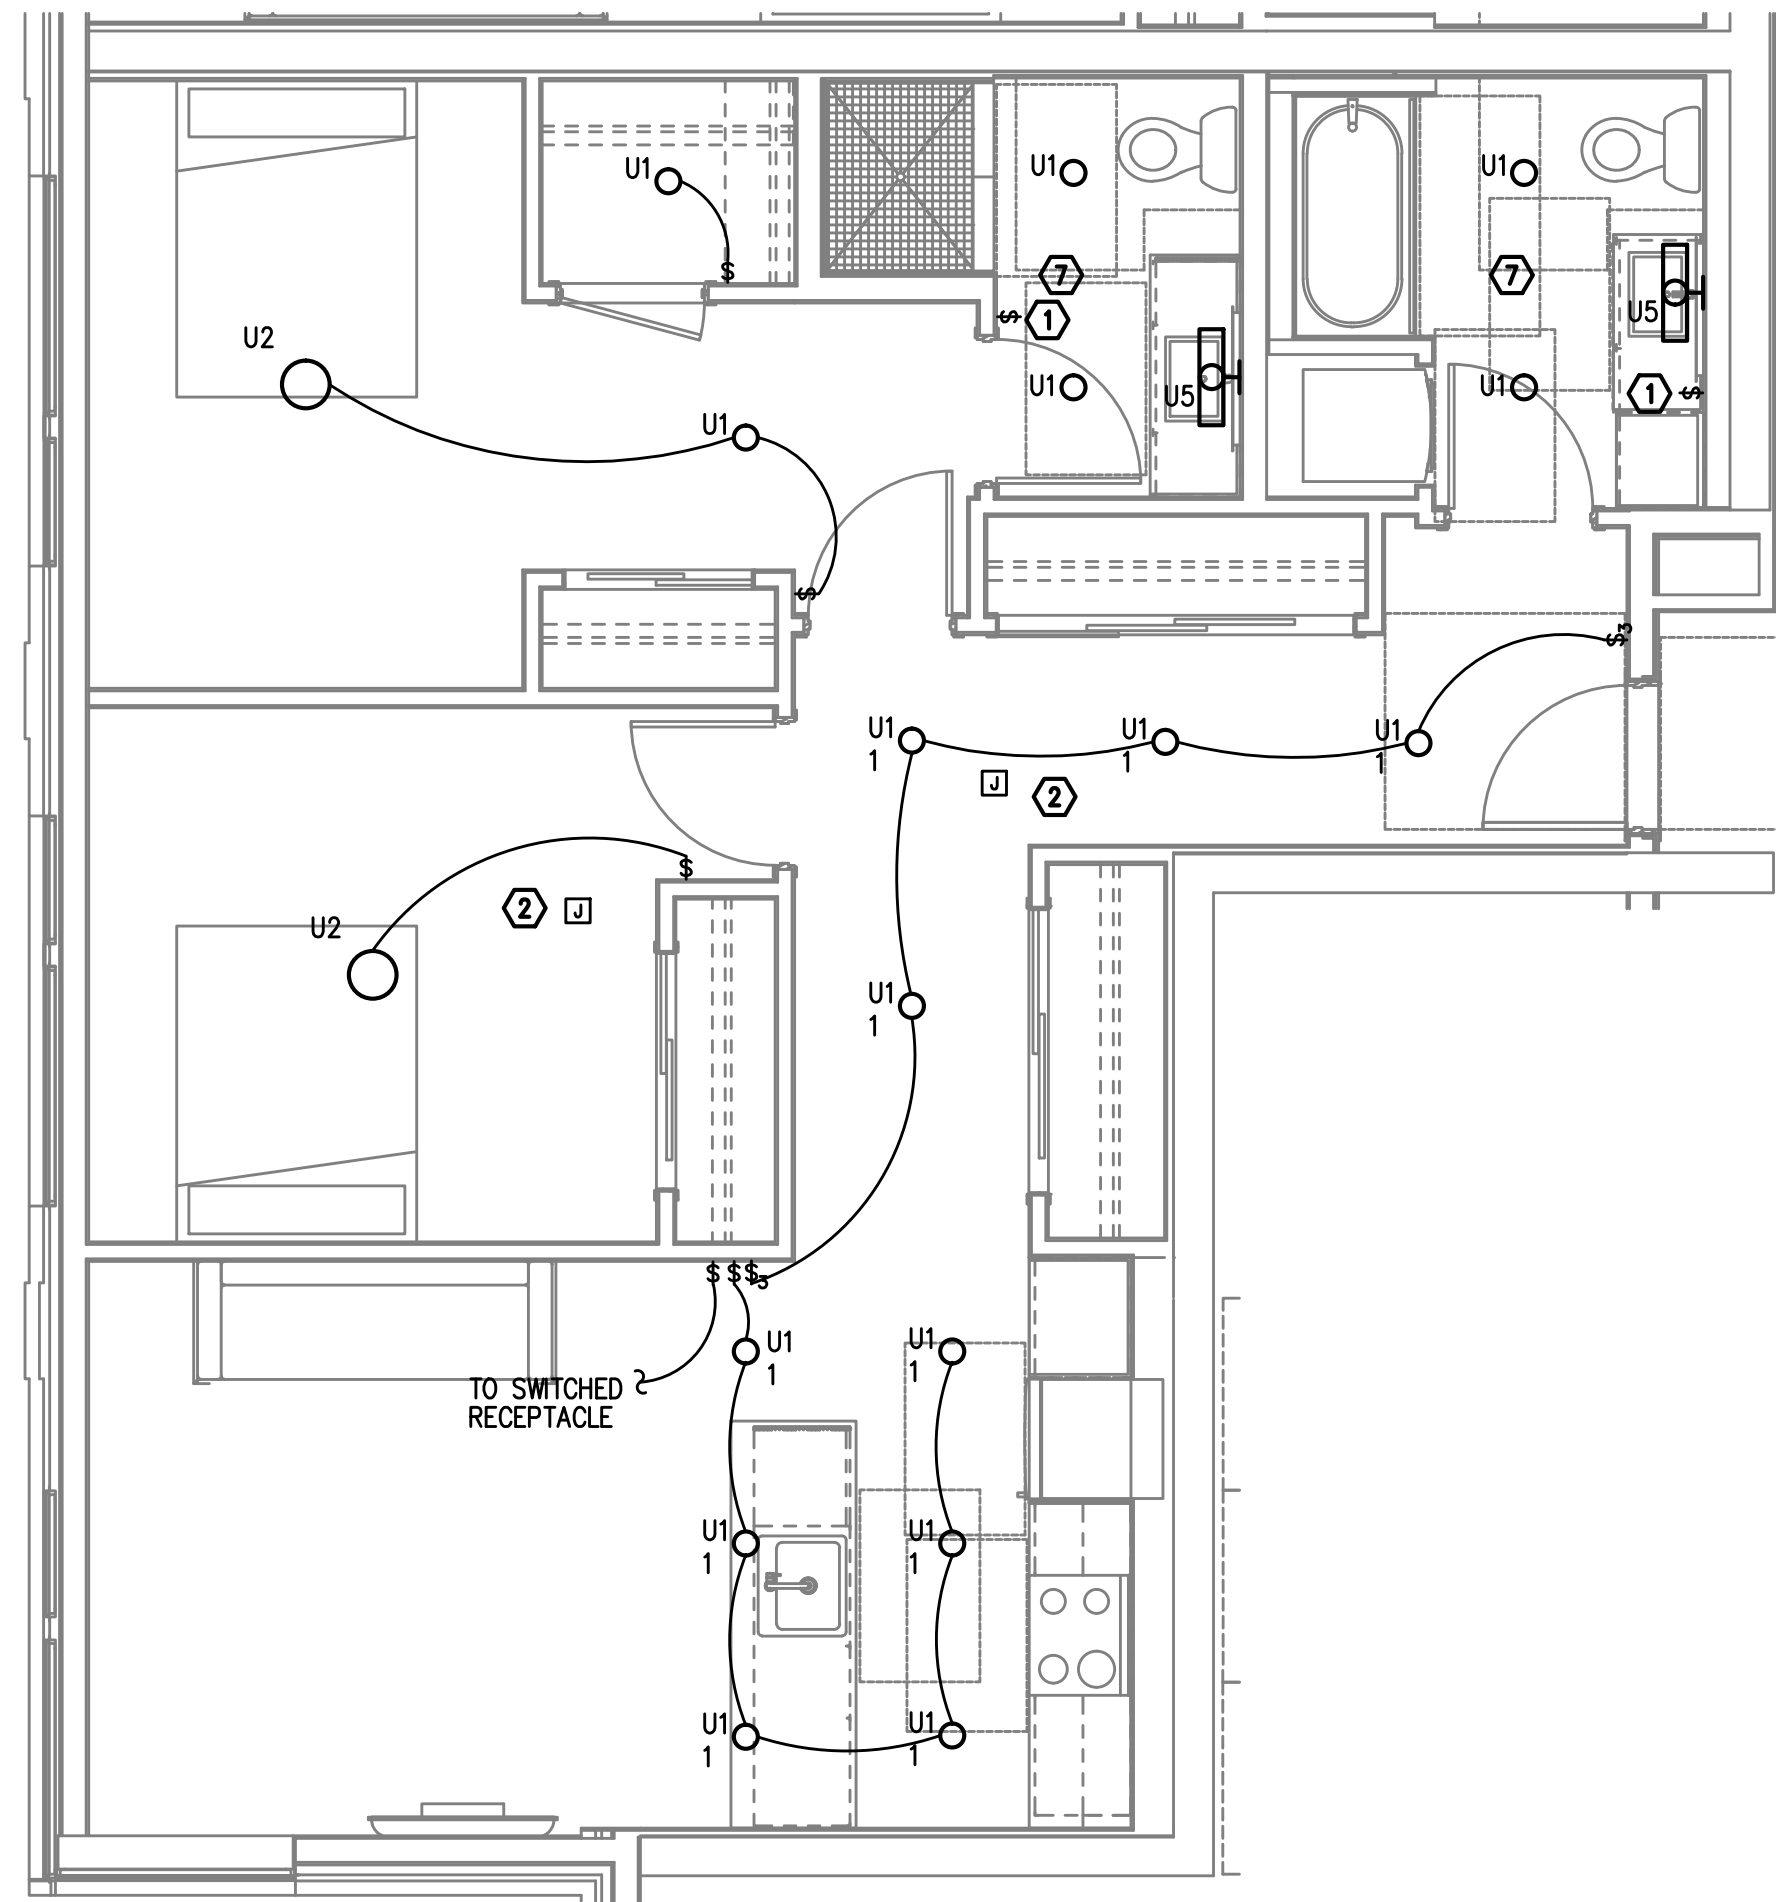

TYPICAL UNIT TYPE R

2 2 BED/2 BATH - LIGHTING PLAN

E4.03 SCALE: 1/4" = 1'-0"

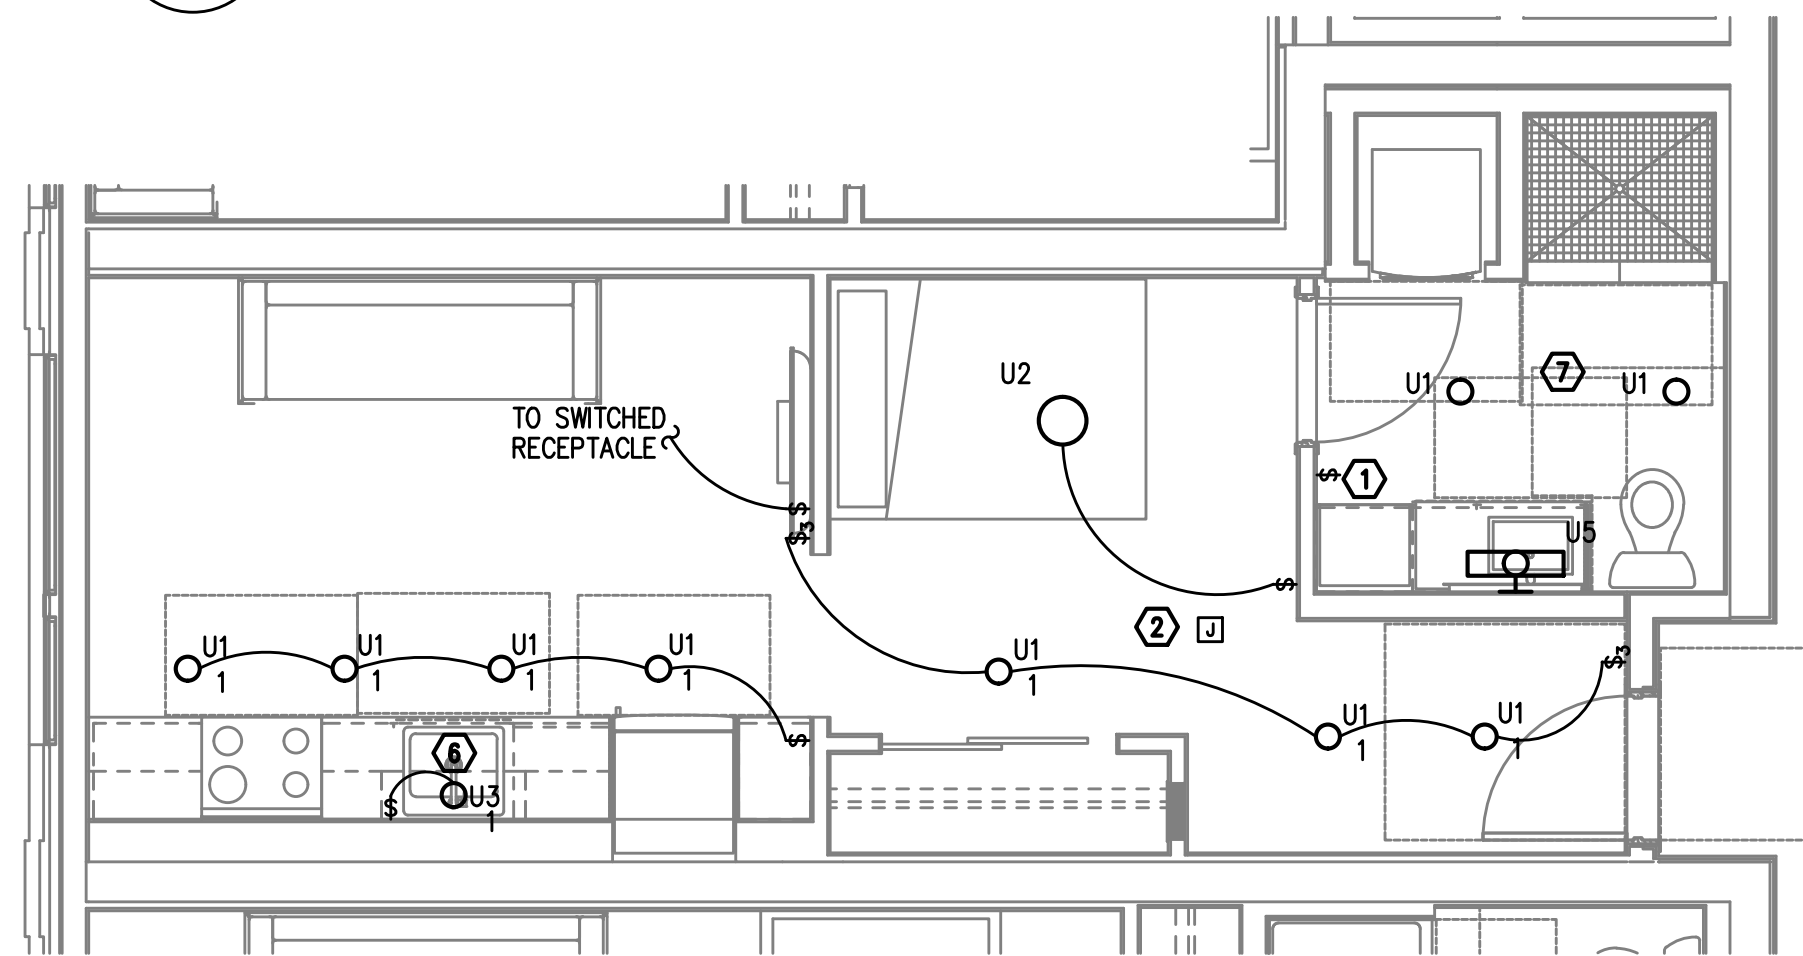

TYPICAL UNIT TYPE T

4 0 BED/1 BATH - LIGHTING PLAN

E4.03 SCALE: 1/4" = 1'-0"

NOTE:

REFER TO SHEET E4.01 FOR GENERAL AND KEYED LIGHTING NOTES.

M
F
A
INC. Consulting Engineers
2007 S.E. Ash St.
Portland, OR 97214
PHN: (503) 234-0548
FAX: (503) 234-0677
CONTACT: DENISE TAYLOR


PRELIMINARY
NOT FOR
CONSTRUCTIONIN THE EVENT CONFLICTS ARE DISCOVERED
BETWEEN THE ORIGINAL SIGNED AND SEALED
DOCUMENTS PREPARED BY THE ARCHITECTS
AND/OR THEIR CONSULTANTS, AND ANY COPY OF
THE DOCUMENTS TRANSMITTED BY MAIL, FAX,
ELECTRONICALLY OR OTHERWISE, THE ORIGINAL
SIGNED AND SEALED DOCUMENTS SHALL GOVERN.PROJECT # 2017-053
DATE: 11/19/2021

REVISIONS


AEGIS - PHASE II
MIXED-USE DEVELOPMENT
312 E EVERGREEN BOULEVARD, VANCOUVER, WA 98660

SHEET:


E4.04

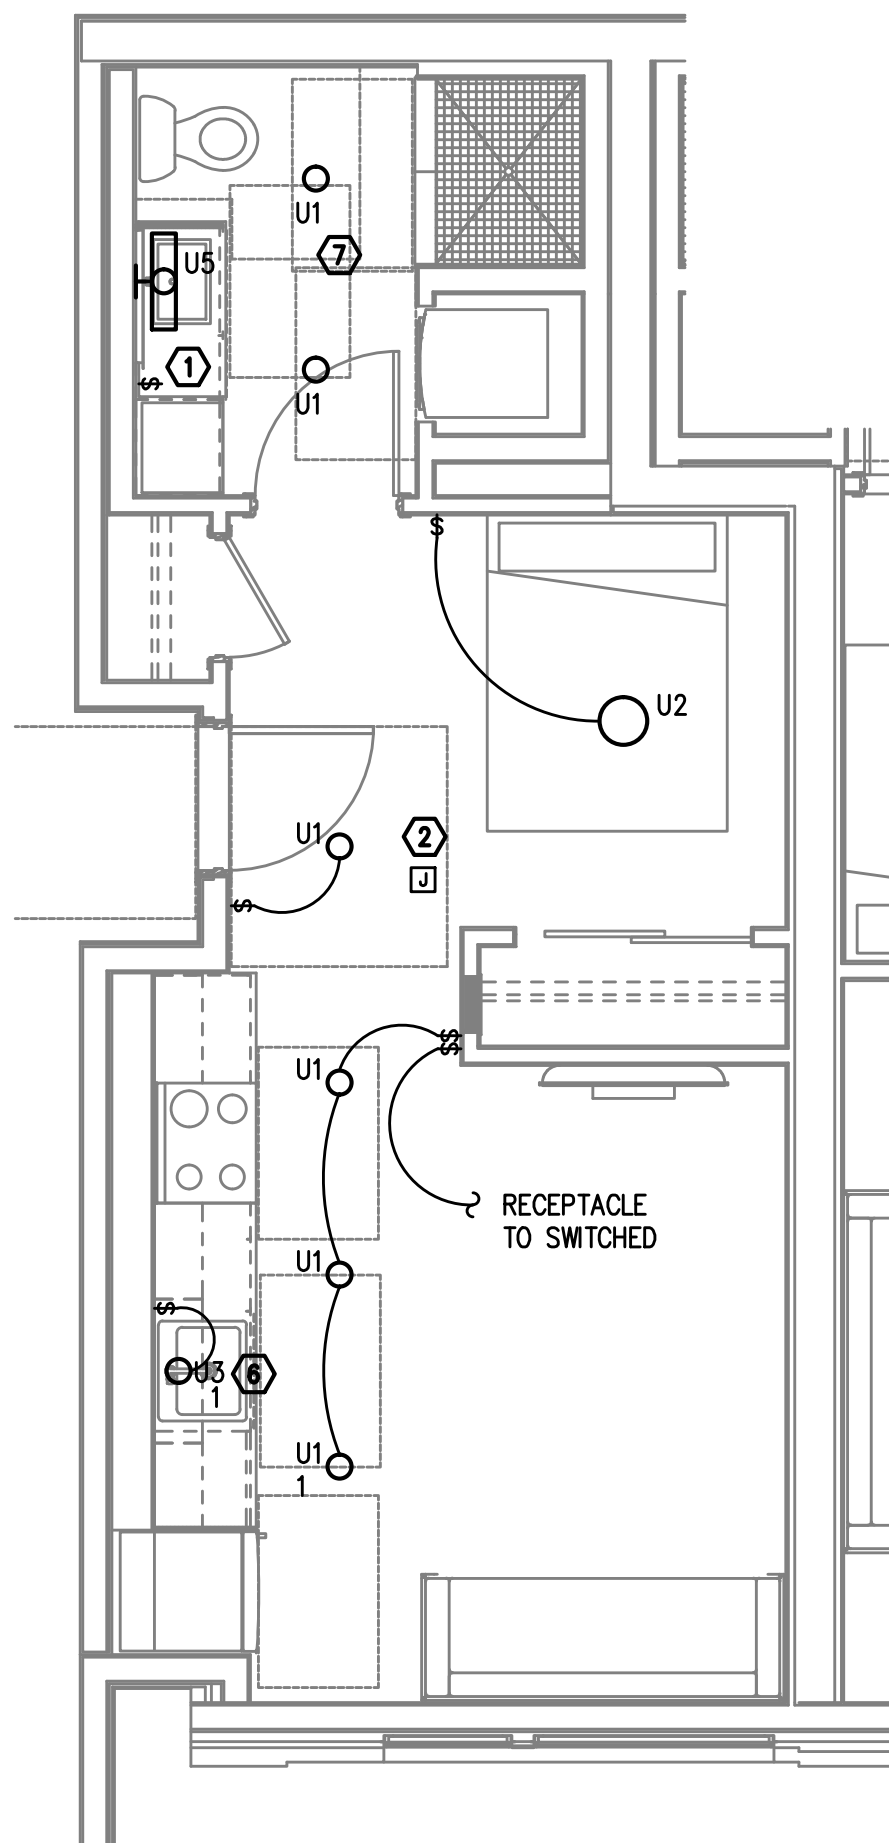

TYPICAL UNIT TYPE U

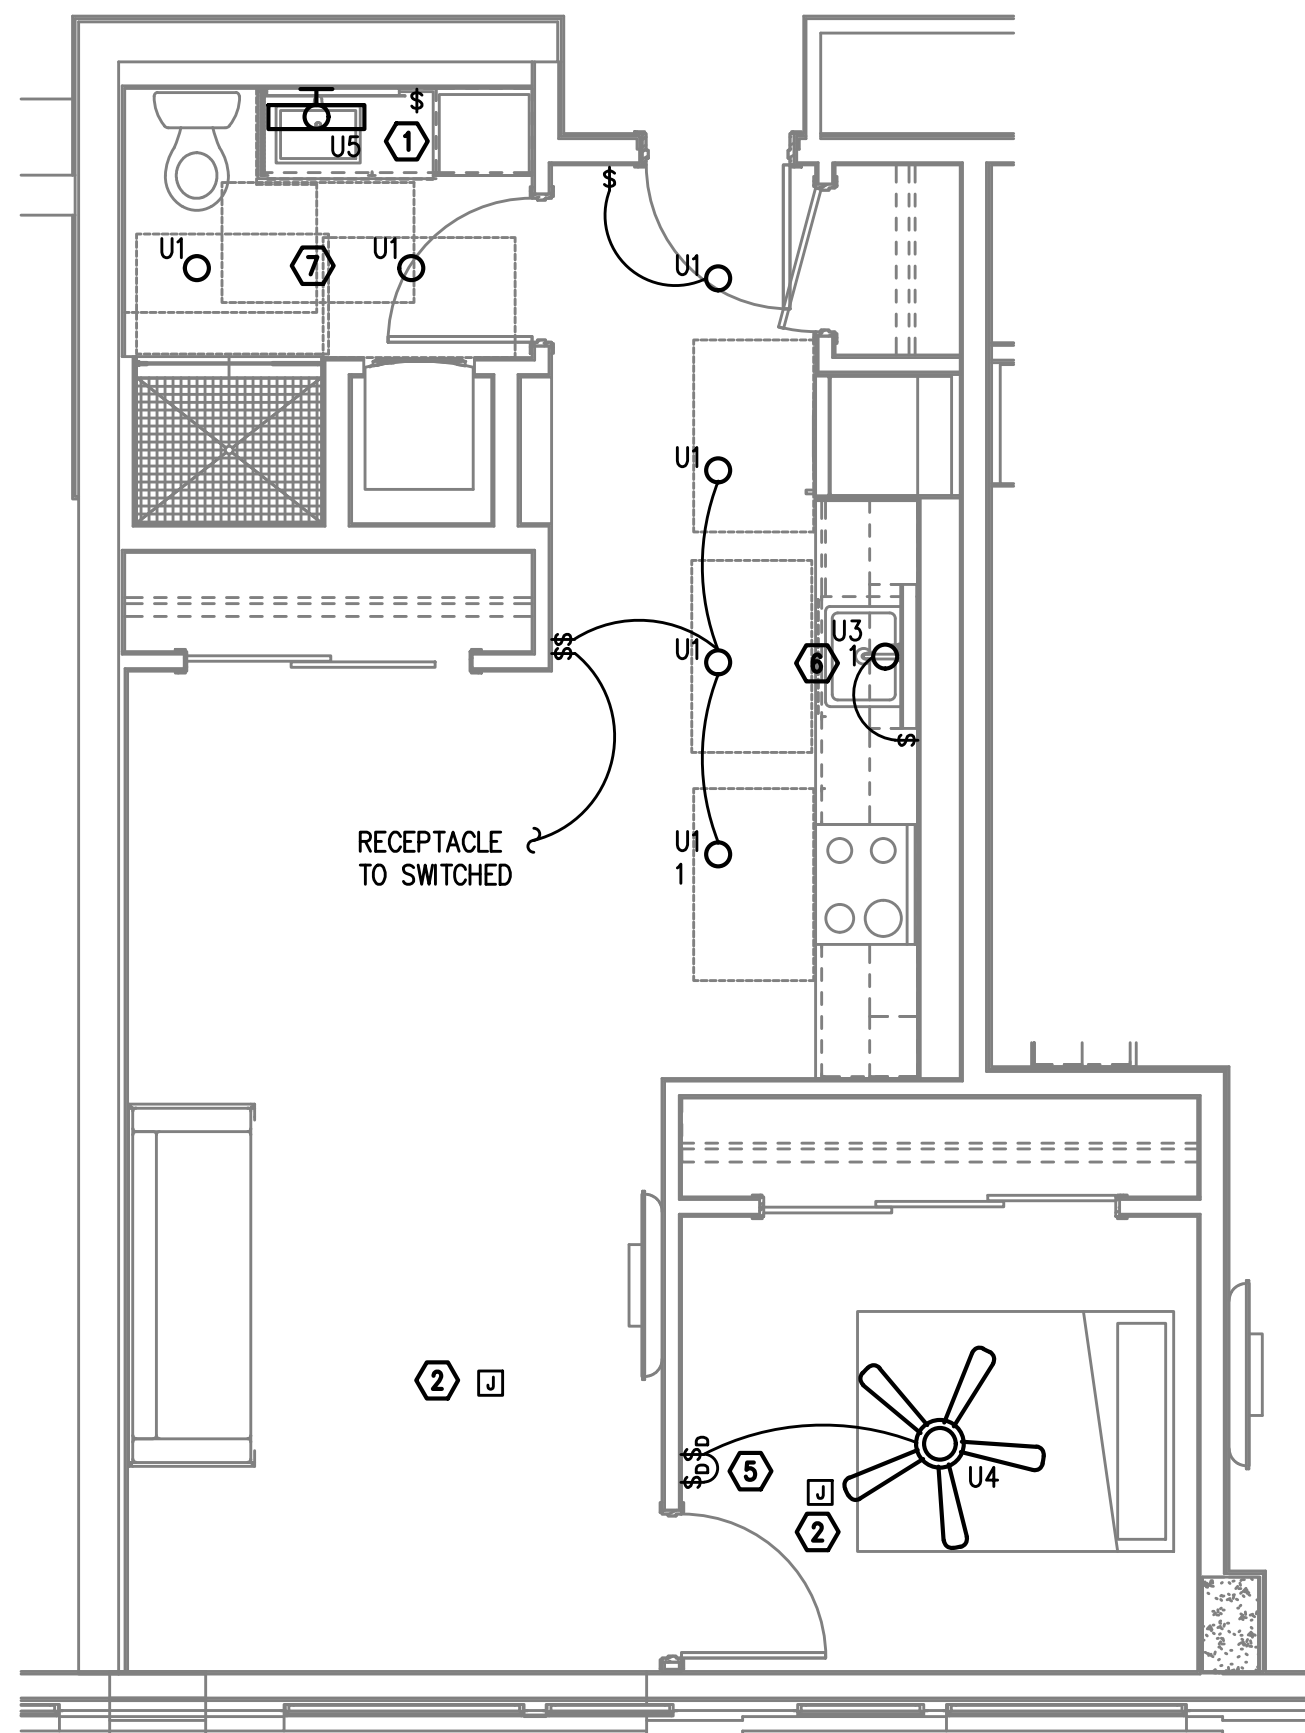1 0 BED/1 BATH - LIGHTING PLAN
E4.04 SCALE: 1/4" = 1'-0"

TYPICAL UNIT TYPE V

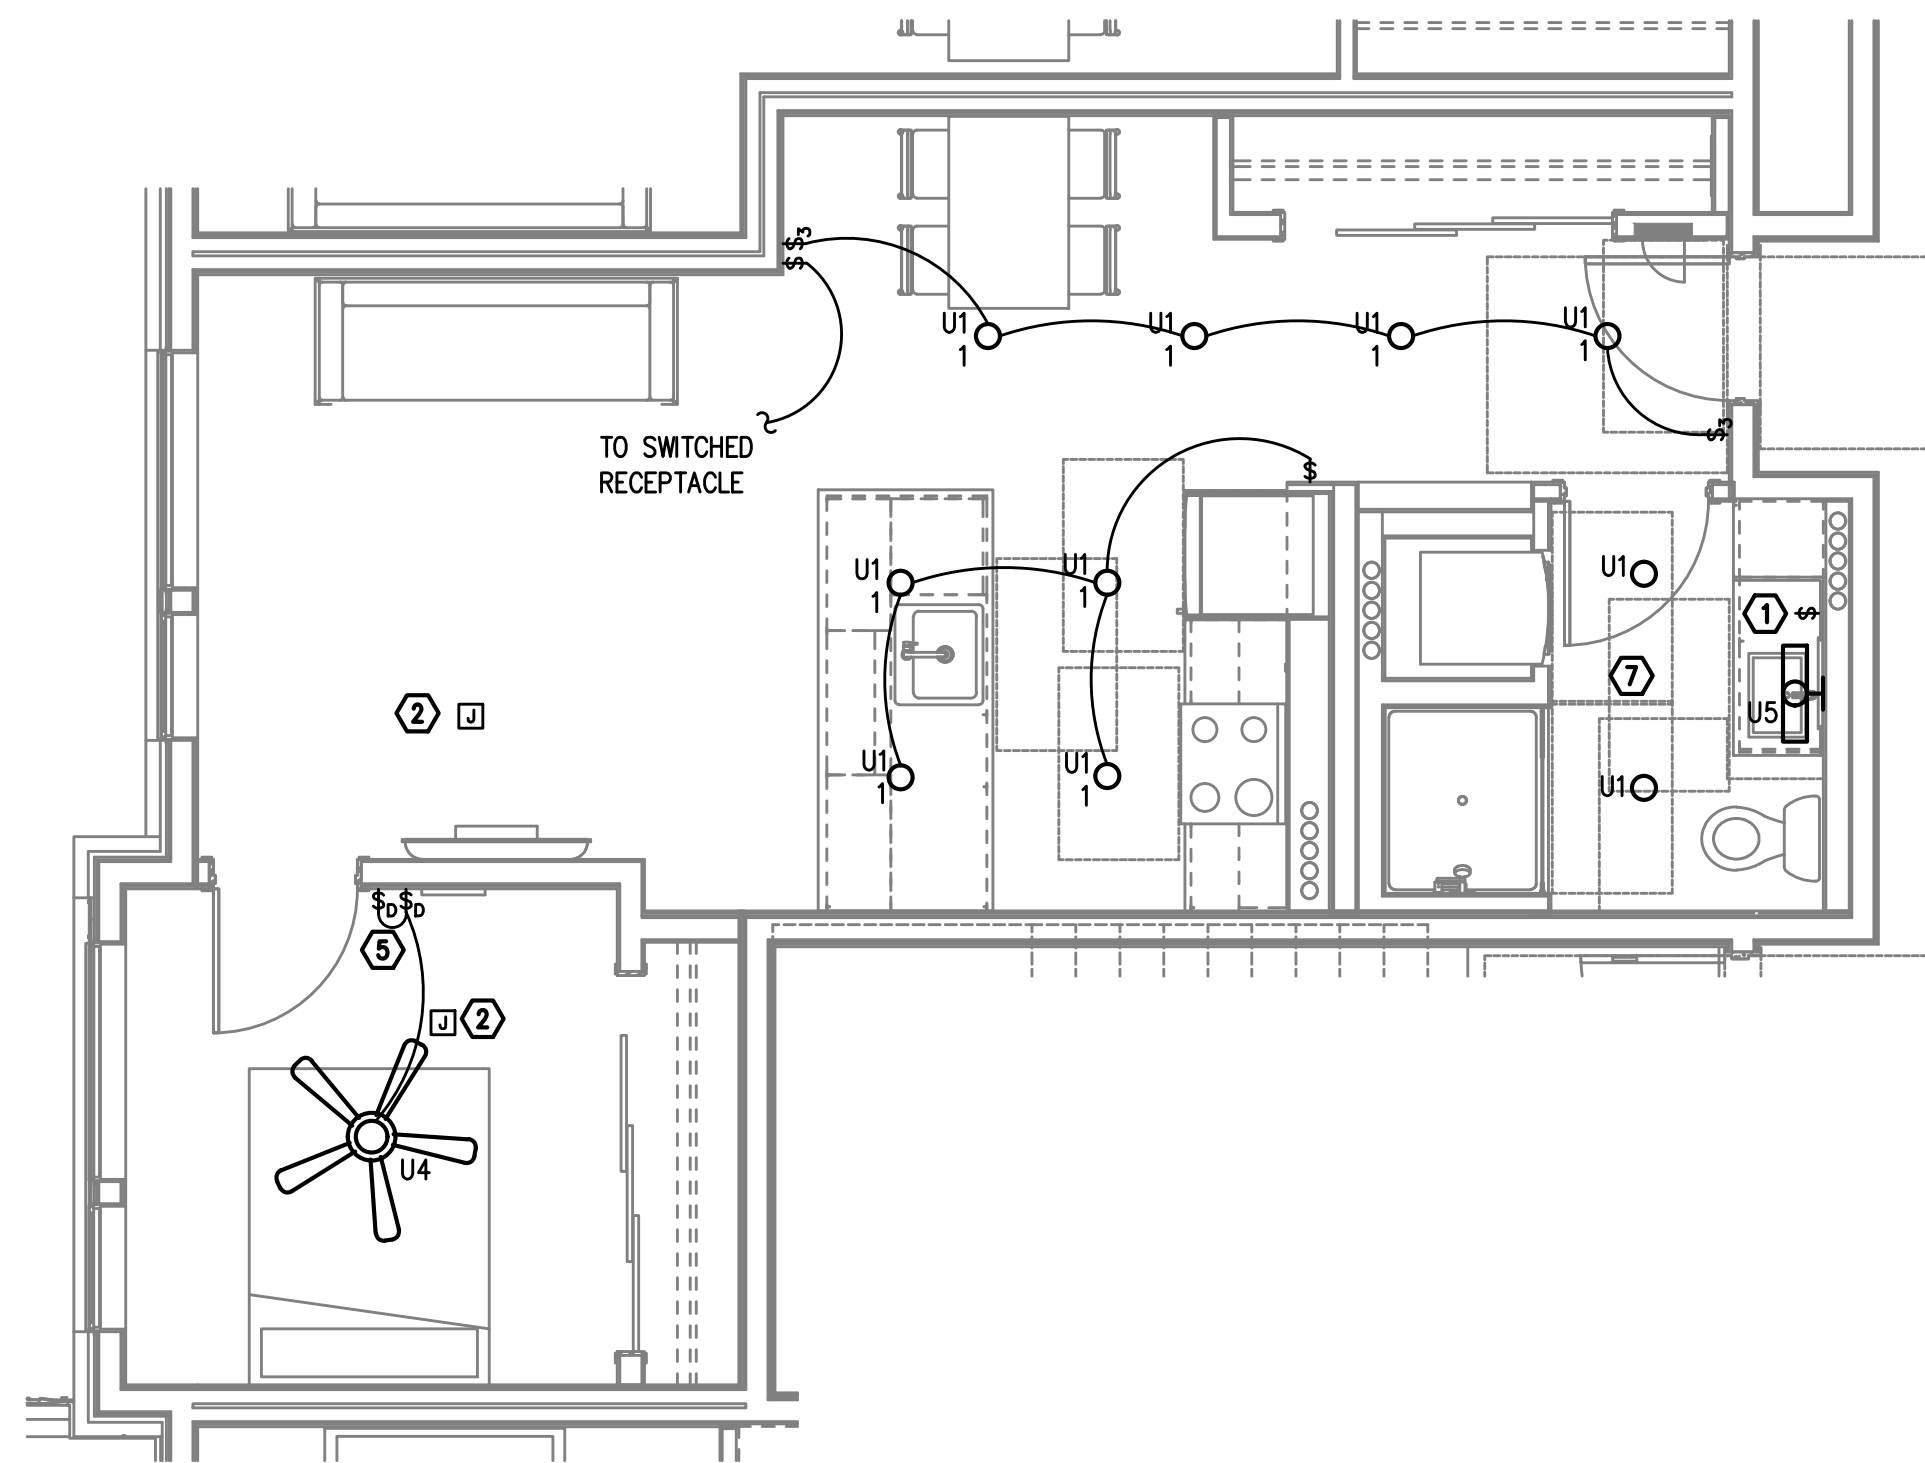2 1 BED/1 BATH - LIGHTING PLAN
E4.04 SCALE: 1/4" = 1'-0"

TYPICAL UNIT TYPE W

3 1 BED/1 BATH - LIGHTING PLAN
E4.04 SCALE: 1/4" = 1'-0"

NOTE:

REFER TO SHEET E4.01 FOR GENERAL AND KEYED LIGHTING NOTES.

M
F
A
INC. Consulting Engineers
2007 S.E. Ash St.
Portland, OR 97214
PHN: (503) 234-0548
FAX: (503) 234-0677
WWW.MFIA-ENG.COM
CONTACT: DENISE TAYLOR


PRELIMINARY
NOT FOR
CONSTRUCTIONIN THE EVENT CONFLICTS ARE DISCOVERED
BETWEEN THE ORIGINAL SIGNED AND SEALED
DOCUMENTS PREPARED BY THE ARCHITECTS
AND/OR THEIR CONSULTANTS, AND ANY COPY OF
THE DOCUMENTS TRANSMITTED BY MAIL, FAX,
ELECTRONICALLY OR OTHERWISE, THE ORIGINAL
SIGNED AND SEALED DOCUMENTS SHALL GOVERN.PROJECT # 2017-053
DATE: 11/19/2021

REVISIONS


AEGIS - PHASE II
MIXED-USE DEVELOPMENT
312 E EVERGREEN BOULEVARD, VANCOUVER, WA 98660

SHEET:


E4.05

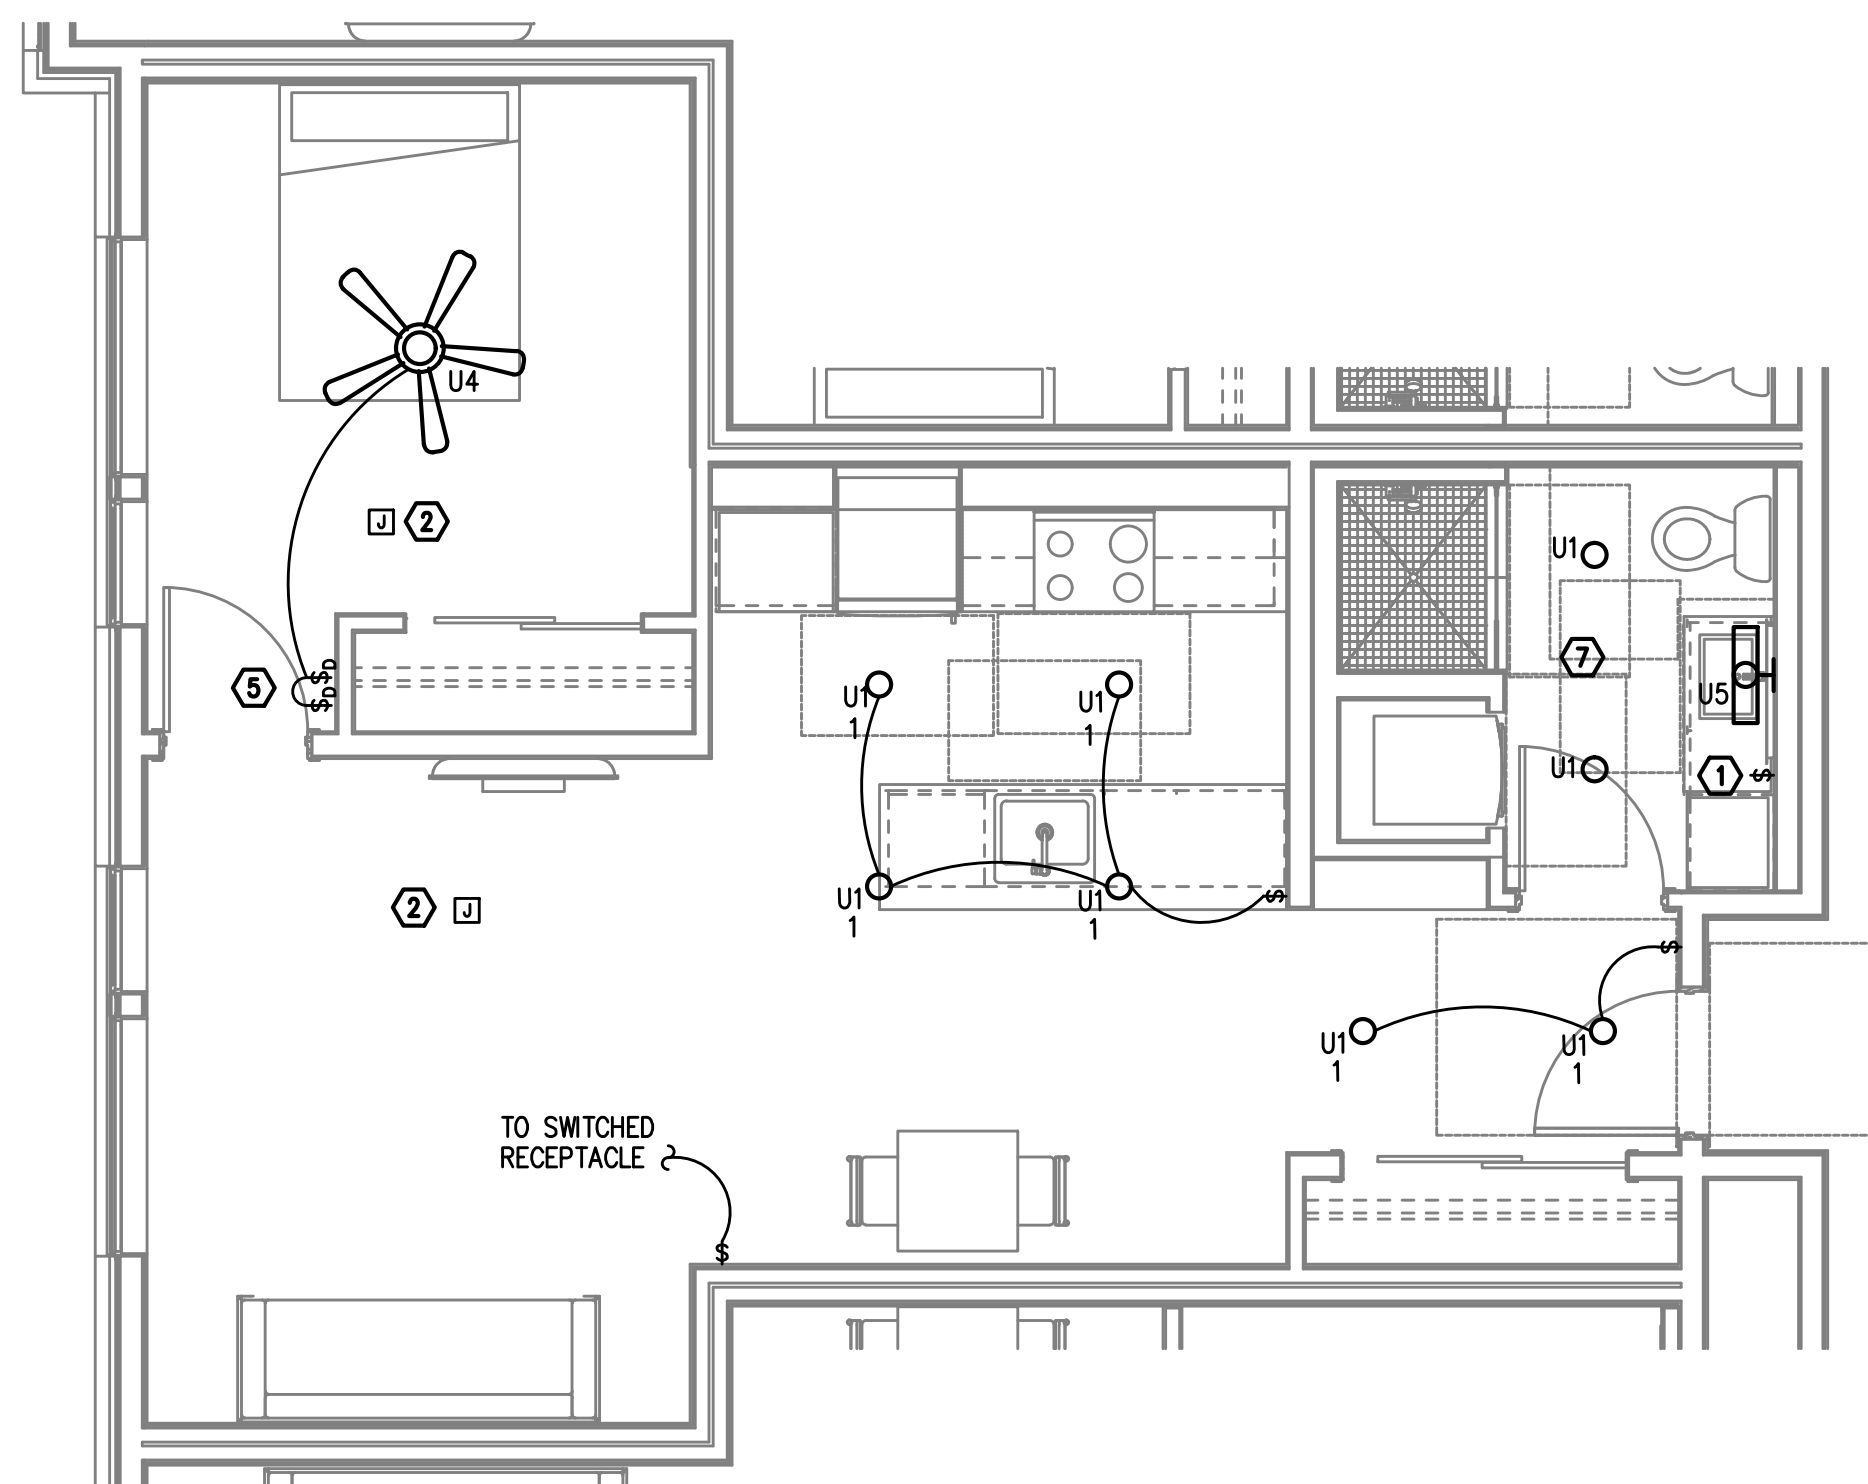

TYPICAL UNIT TYPE X

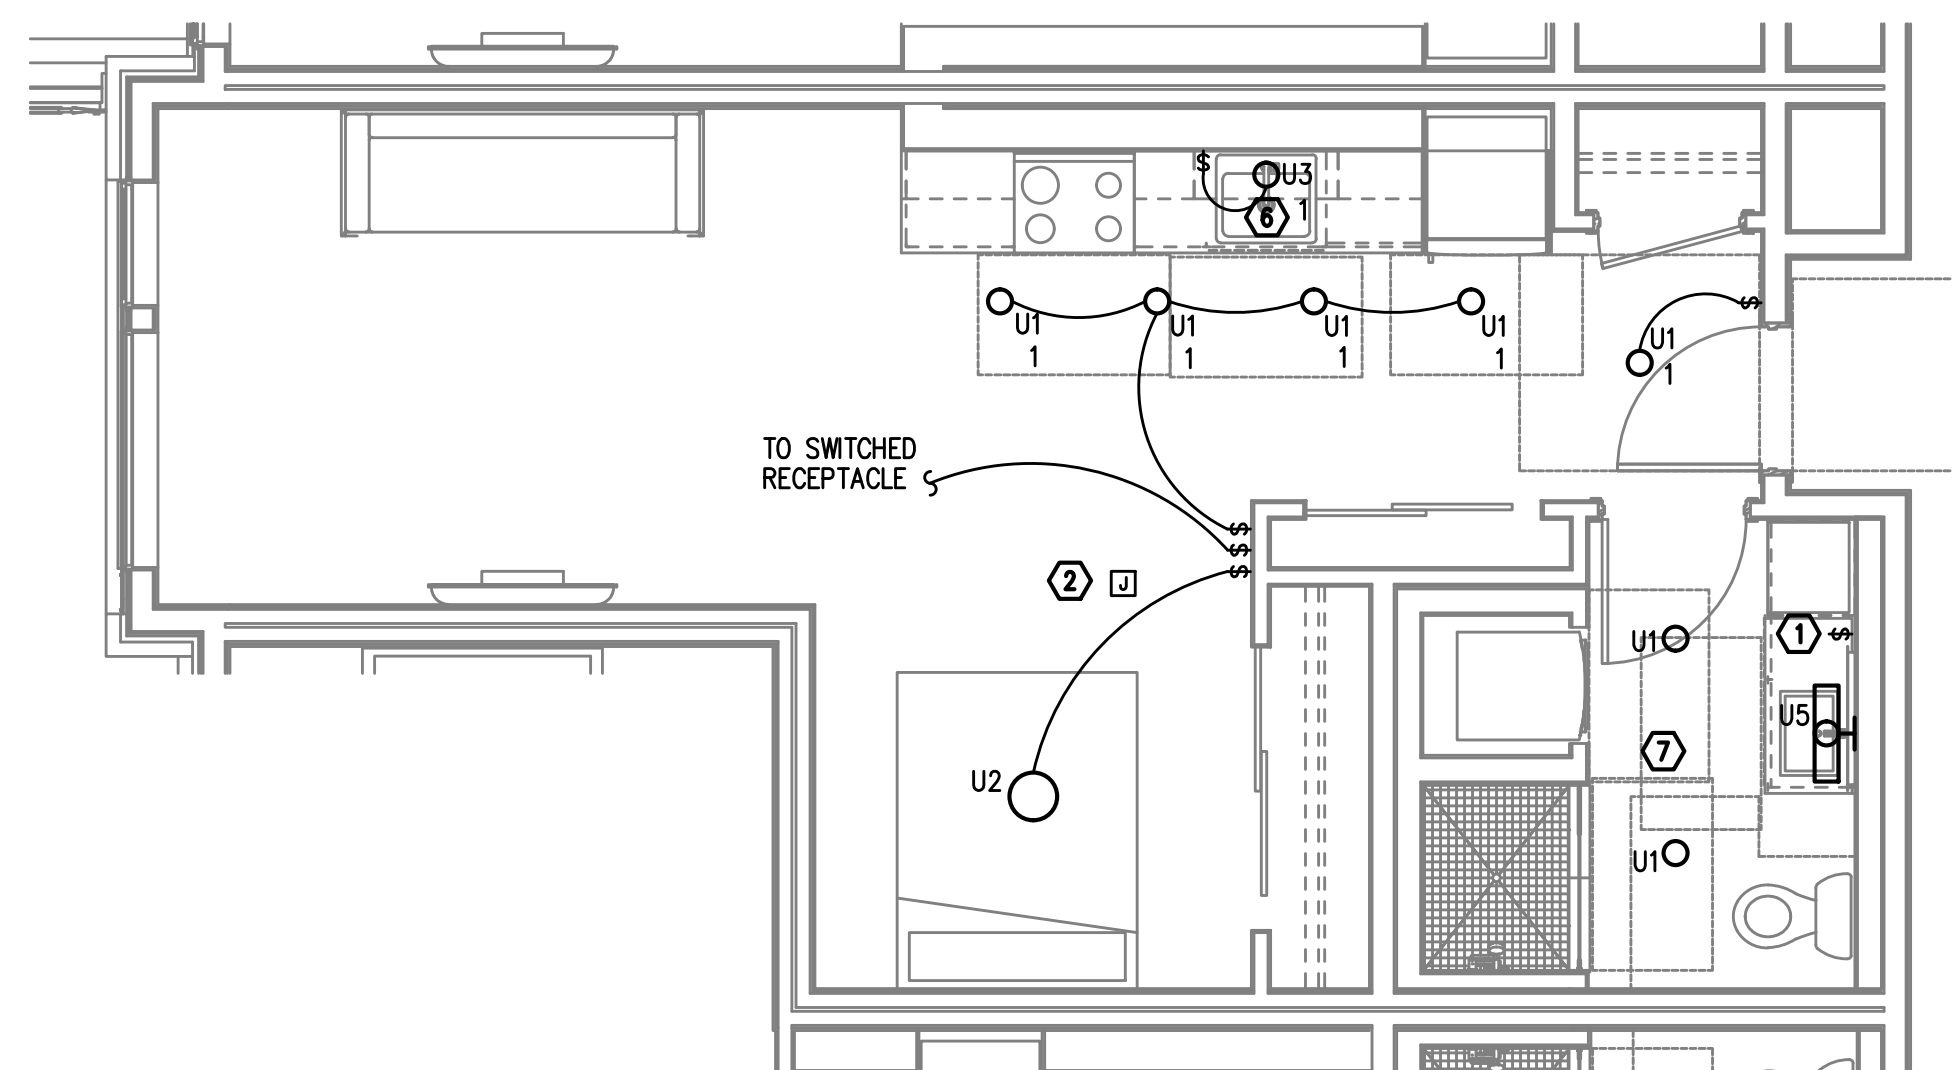1 1 BED/1 BATH - LIGHTING PLAN
E4.05 SCALE: 1/4" = 1'-0"

TYPICAL UNIT TYPE Y

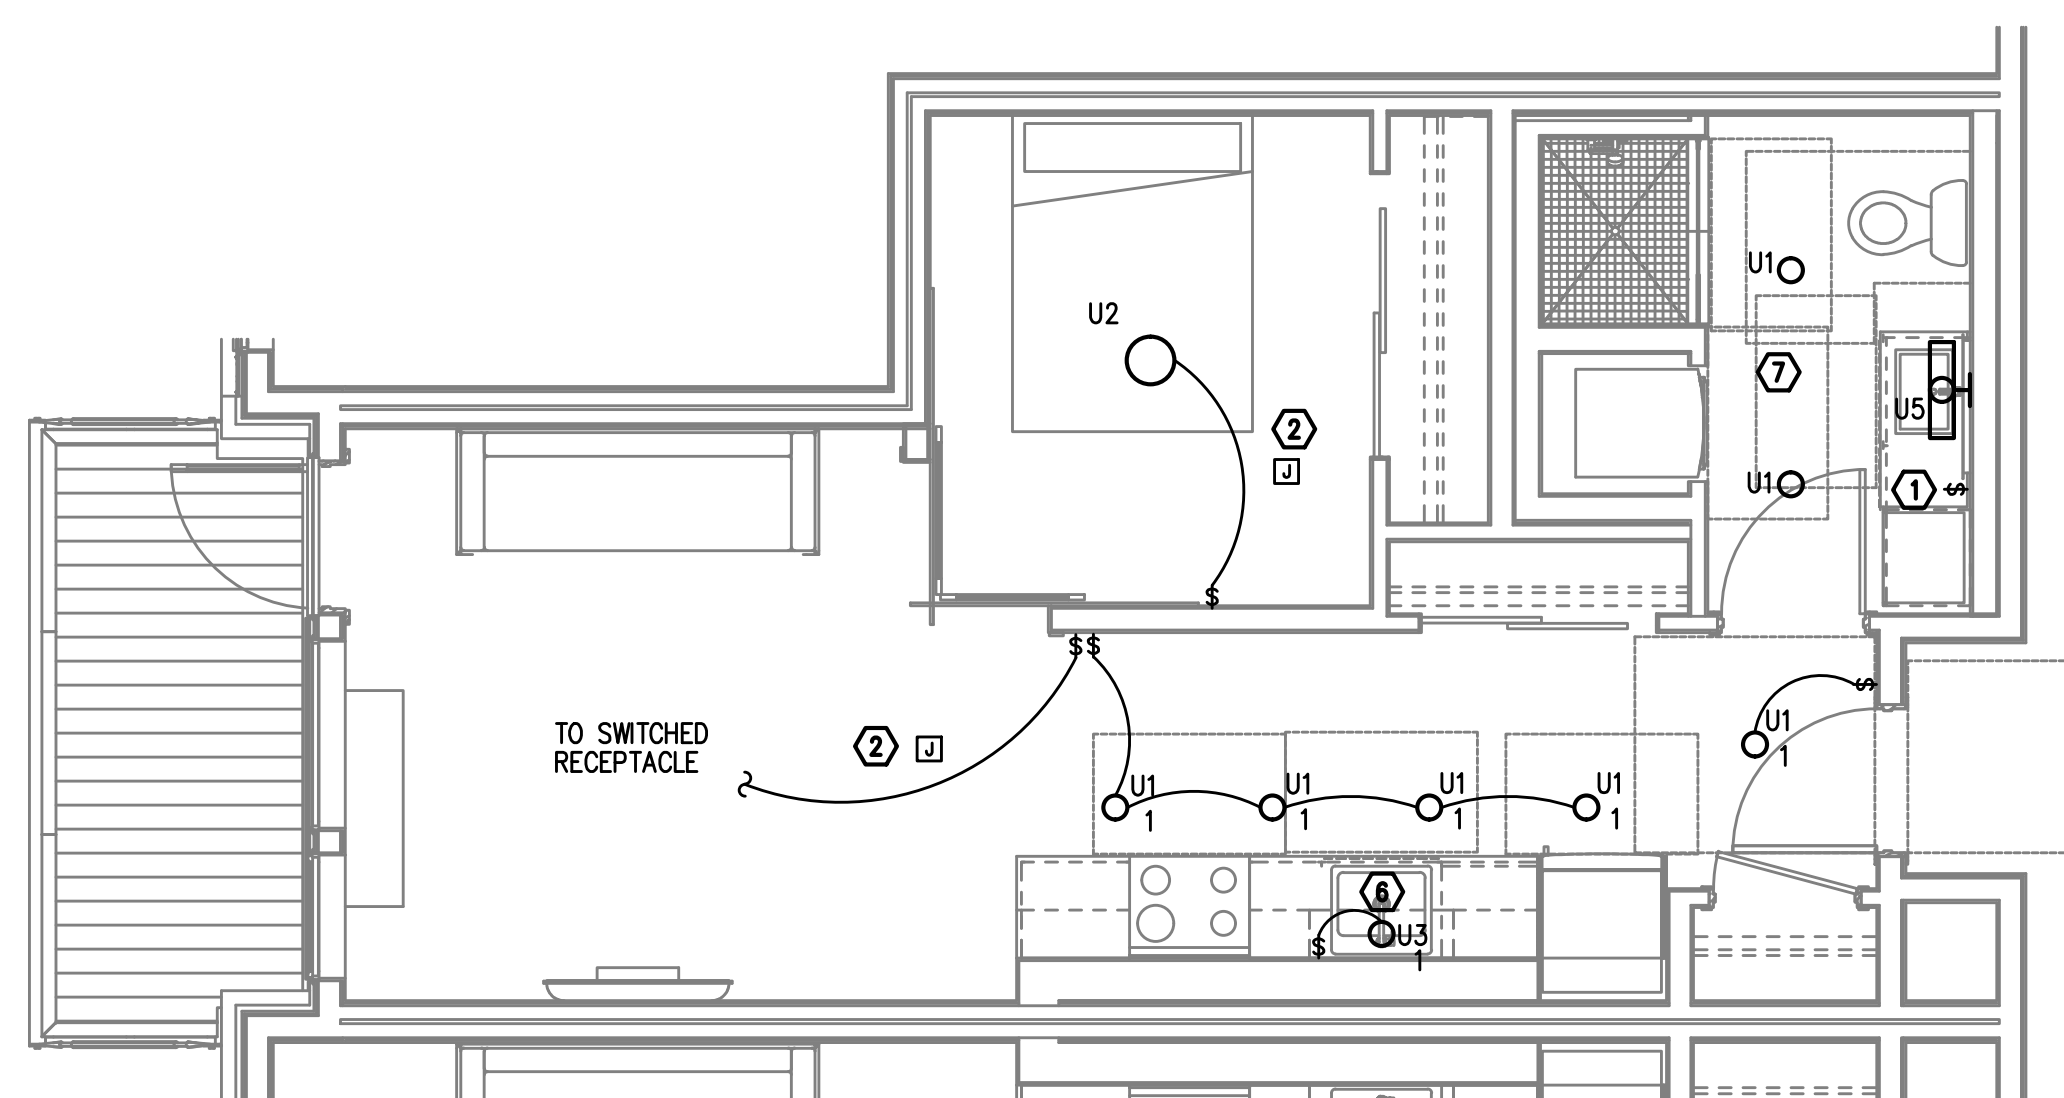2 0 BED/1 BATH - LIGHTING PLAN
E4.05 SCALE: 1/4" = 1'-0"

TYPICAL UNIT TYPE Z

3 0 BED/1 BATH - LIGHTING PLAN
E4.05 SCALE: 1/4" = 1'-0"

NOTE:

REFER TO SHEET E4.01 FOR GENERAL AND KEYED LIGHTING NOTES.

M
F
A
INC. Consulting Engineers
2007 S.E. Ash St.
Portland, OR 97214
PHN: (503) 234-0548
FAX: (503) 234-0677
CONTACT: DENISE TAYLOR
WWW.MFIA-ENG.COM




PRELIMINARY
NOT FOR
CONSTRUCTIONIN THE EVENT CONFLICTS ARE DISCOVERED
BETWEEN THE ORIGINAL SIGNED AND SEALED
DOCUMENTS PREPARED BY THE ARCHITECTS
AND/OR THEIR CONSULTANTS, AND ANY COPY OF
THE DOCUMENTS TRANSMITTED BY MAIL, FAX,
ELECTRONICALLY OR OTHERWISE, THE ORIGINAL
SIGNED AND SEALED DOCUMENTS SHALL GOVERN.PROJECT # 2017-053
DATE: 11/19/2021

REVISIONS

AEGIS - PHASE II
MIXED-USE DEVELOPMENT
312 E EVERGREEN BOULEVARD, VANCOUVER, WA 98660

SHEET:


E4.06

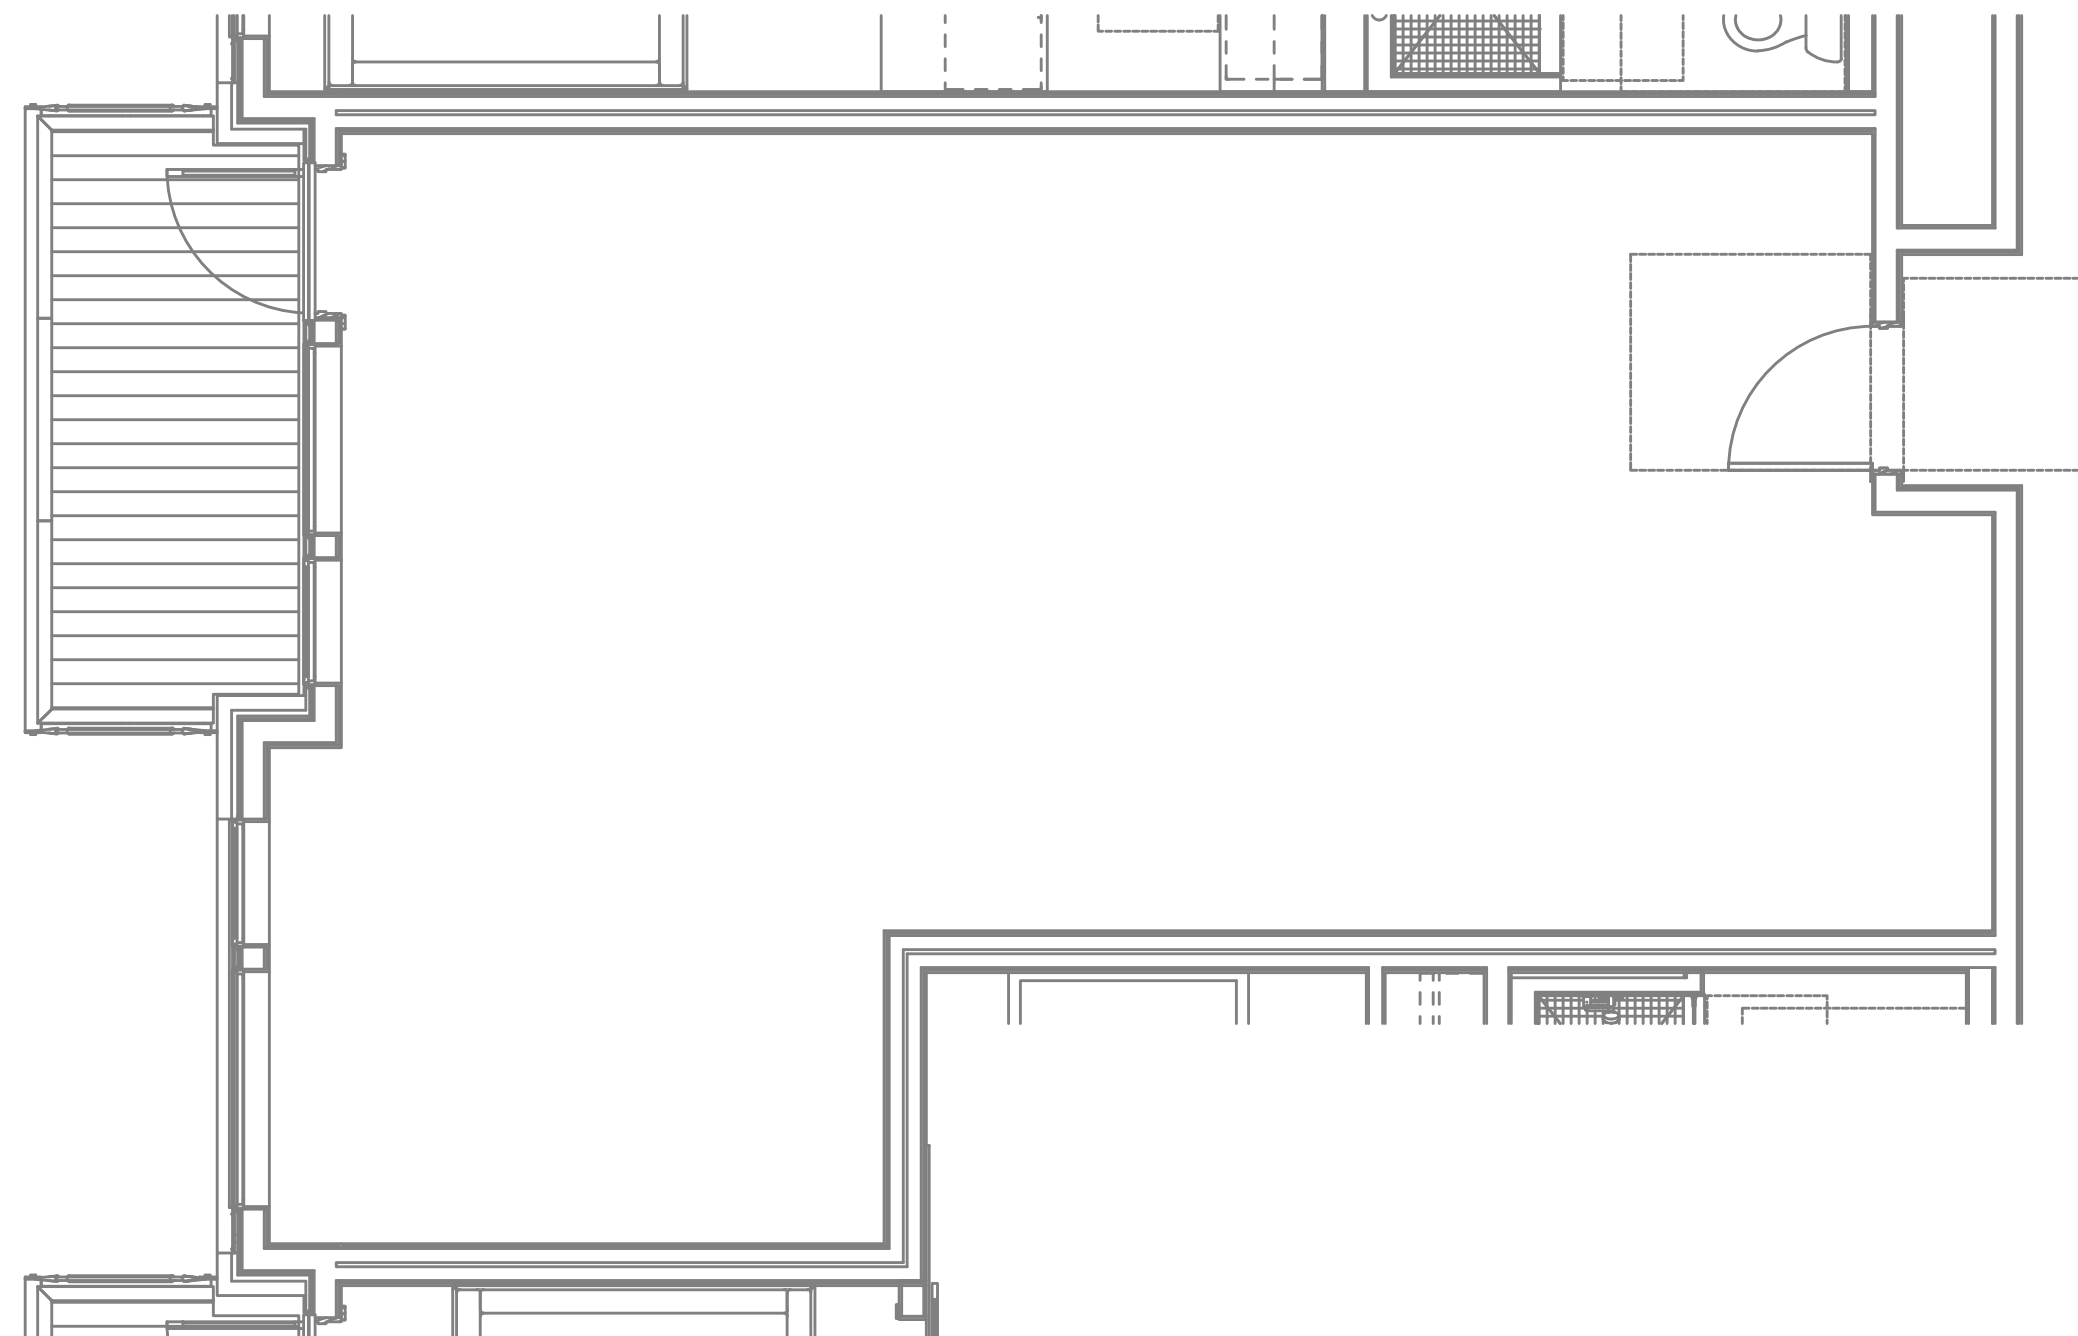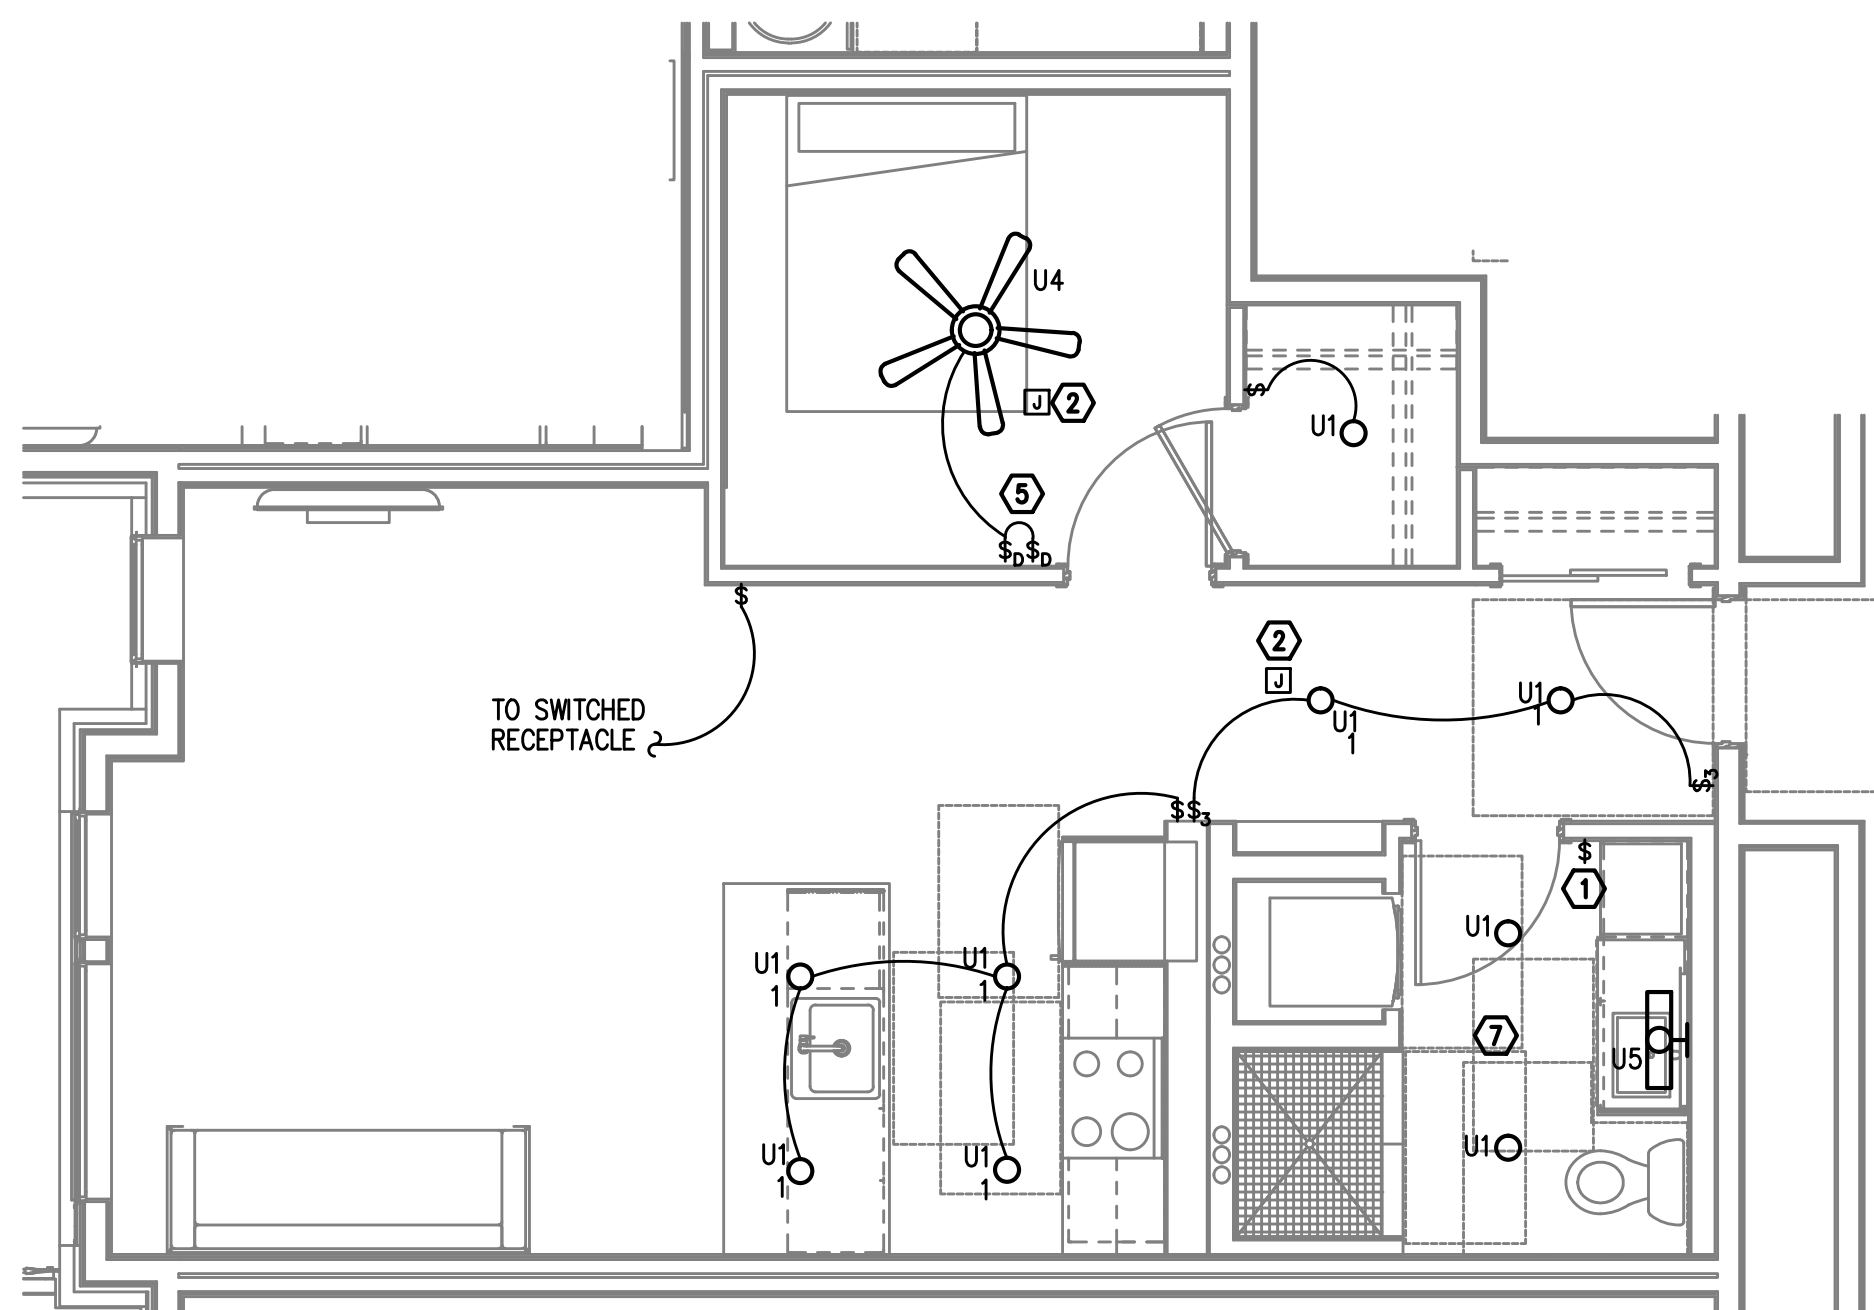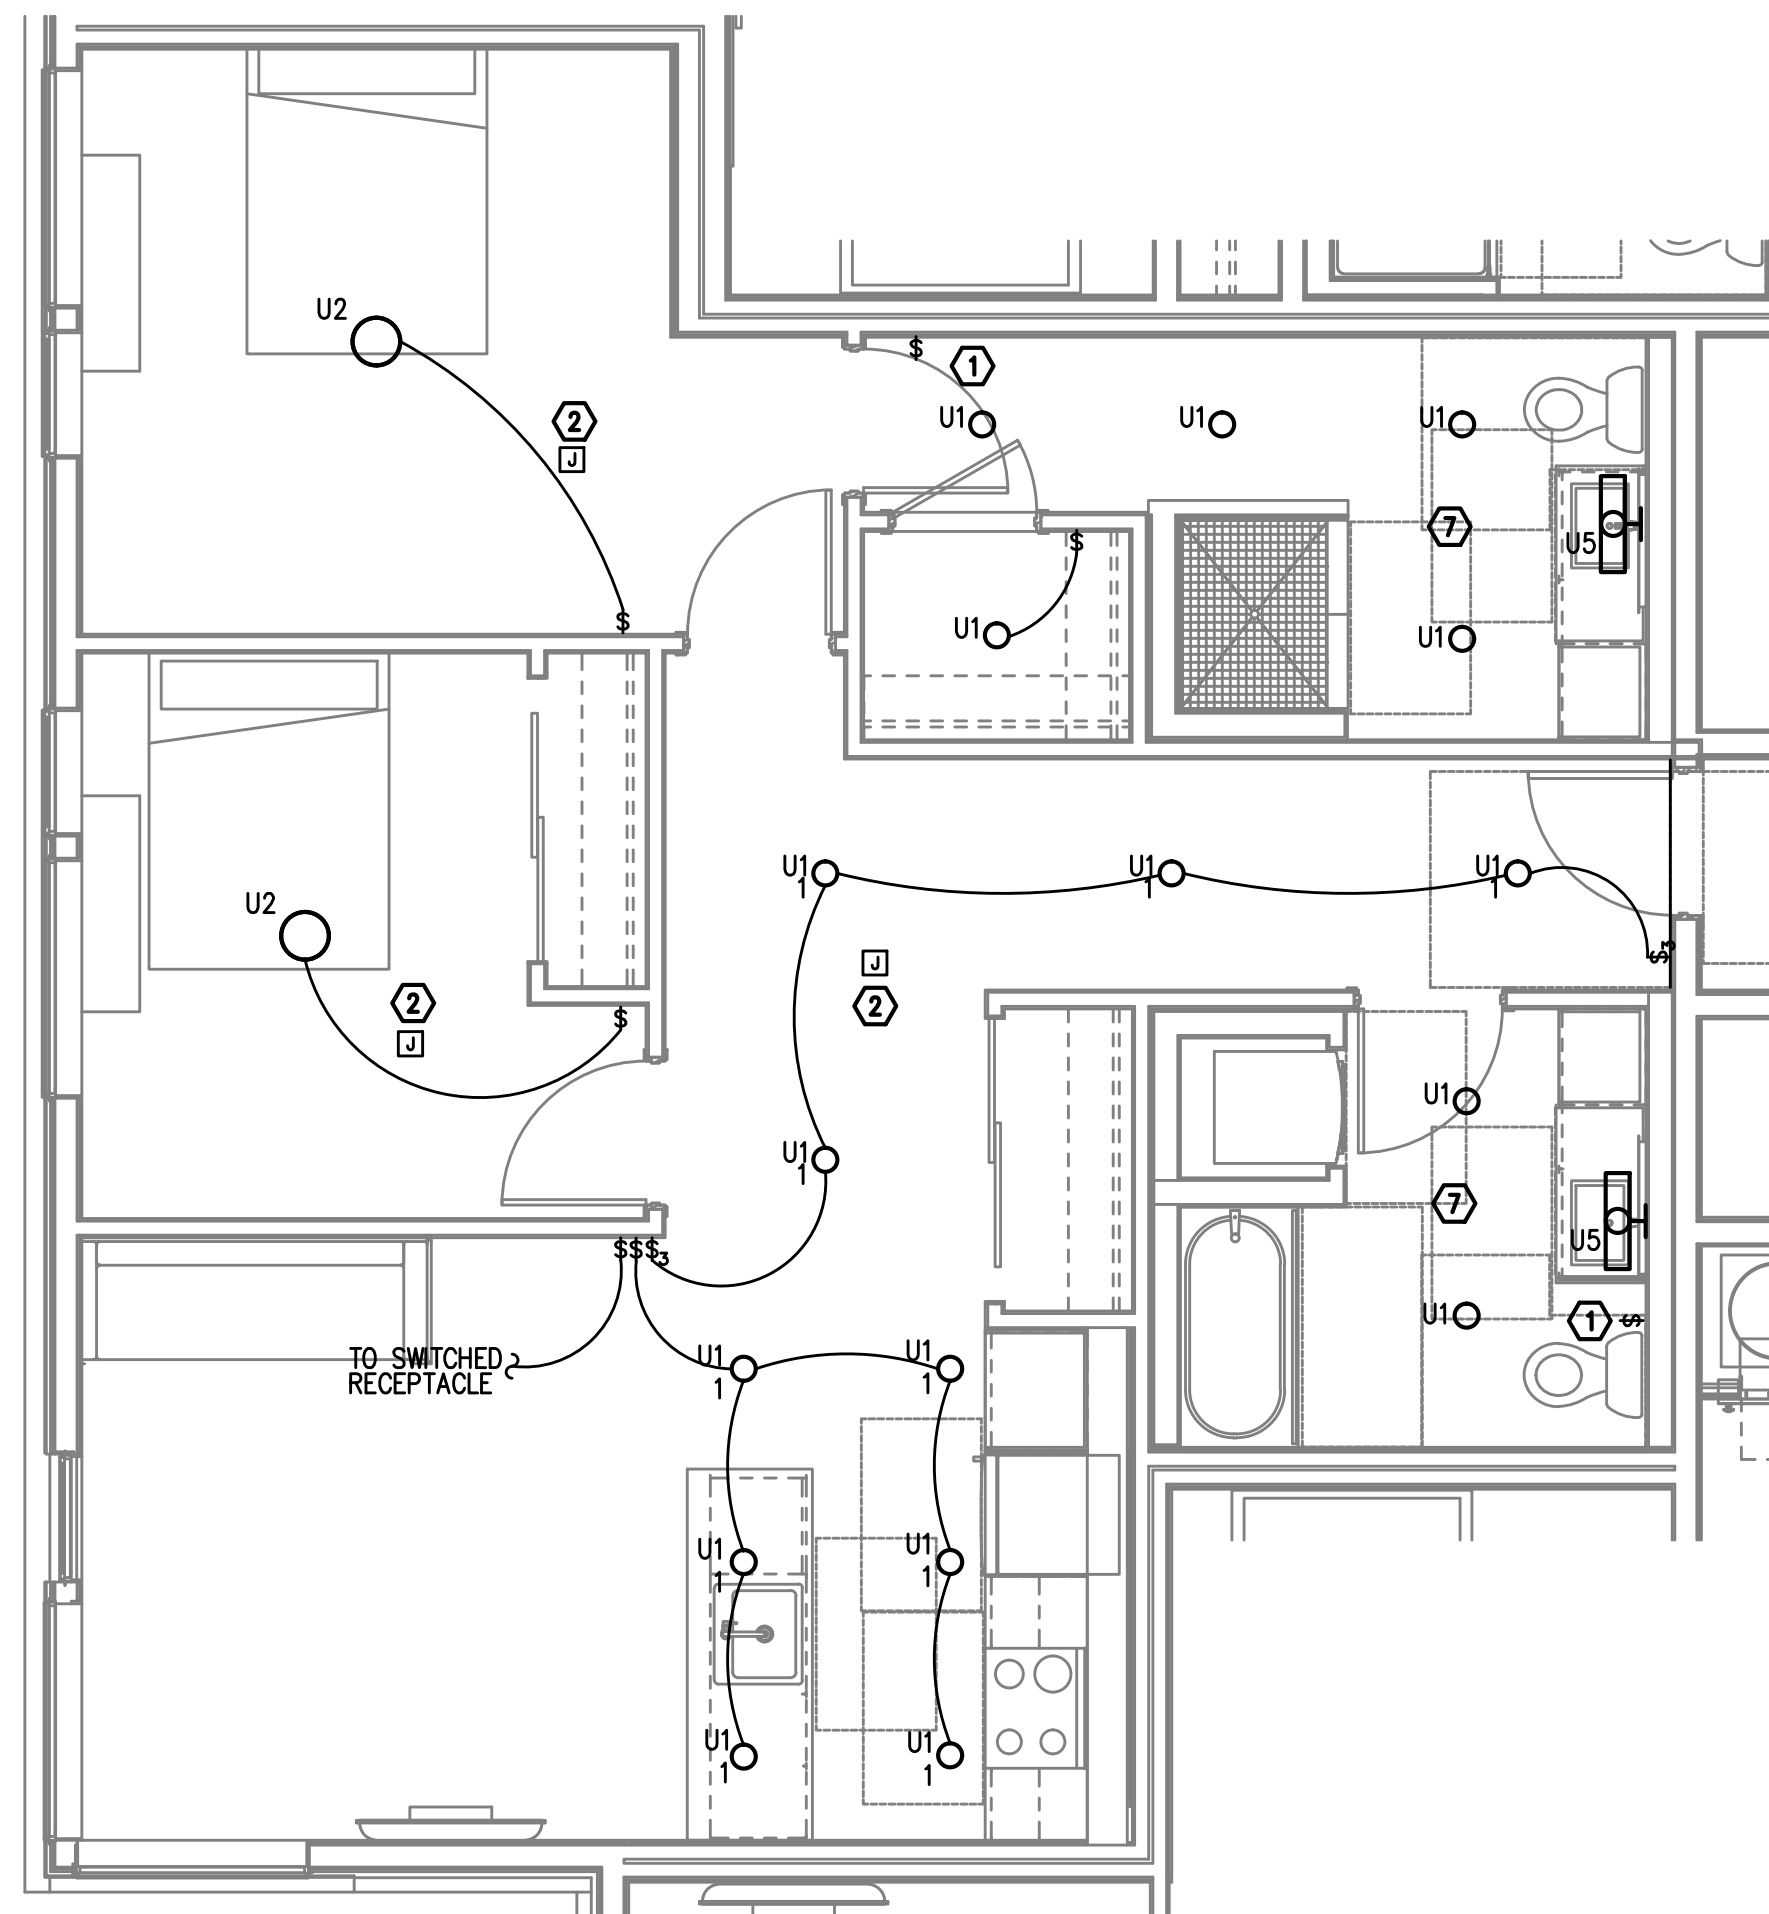1
E4.06 TYPICAL UNIT TYPE AA
2 BED/2 BATH - LIGHTING PLAN
SCALE: 1/4" = 1'-0"2
E4.06 TYPICAL UNIT TYPE BB
1 BED/1 BATH - LIGHTING PLAN
SCALE: 1/4" = 1'-0"3
E4.06 TYPICAL UNIT TYPE CC
2 BED/2 BATH - LIGHTING PLAN
SCALE: 1/4" = 1'-0"


NOTE:

REFER TO SHEET E4.01 FOR GENERAL AND KEYED LIGHTING NOTES.


M
F
A
INC. Consulting Engineers
2007 S.E. Ash St.
Portland, OR 97214
PHN: (503) 234-0548
FAX: (503) 234-0677
CONTACT: DENISE TAYLOR

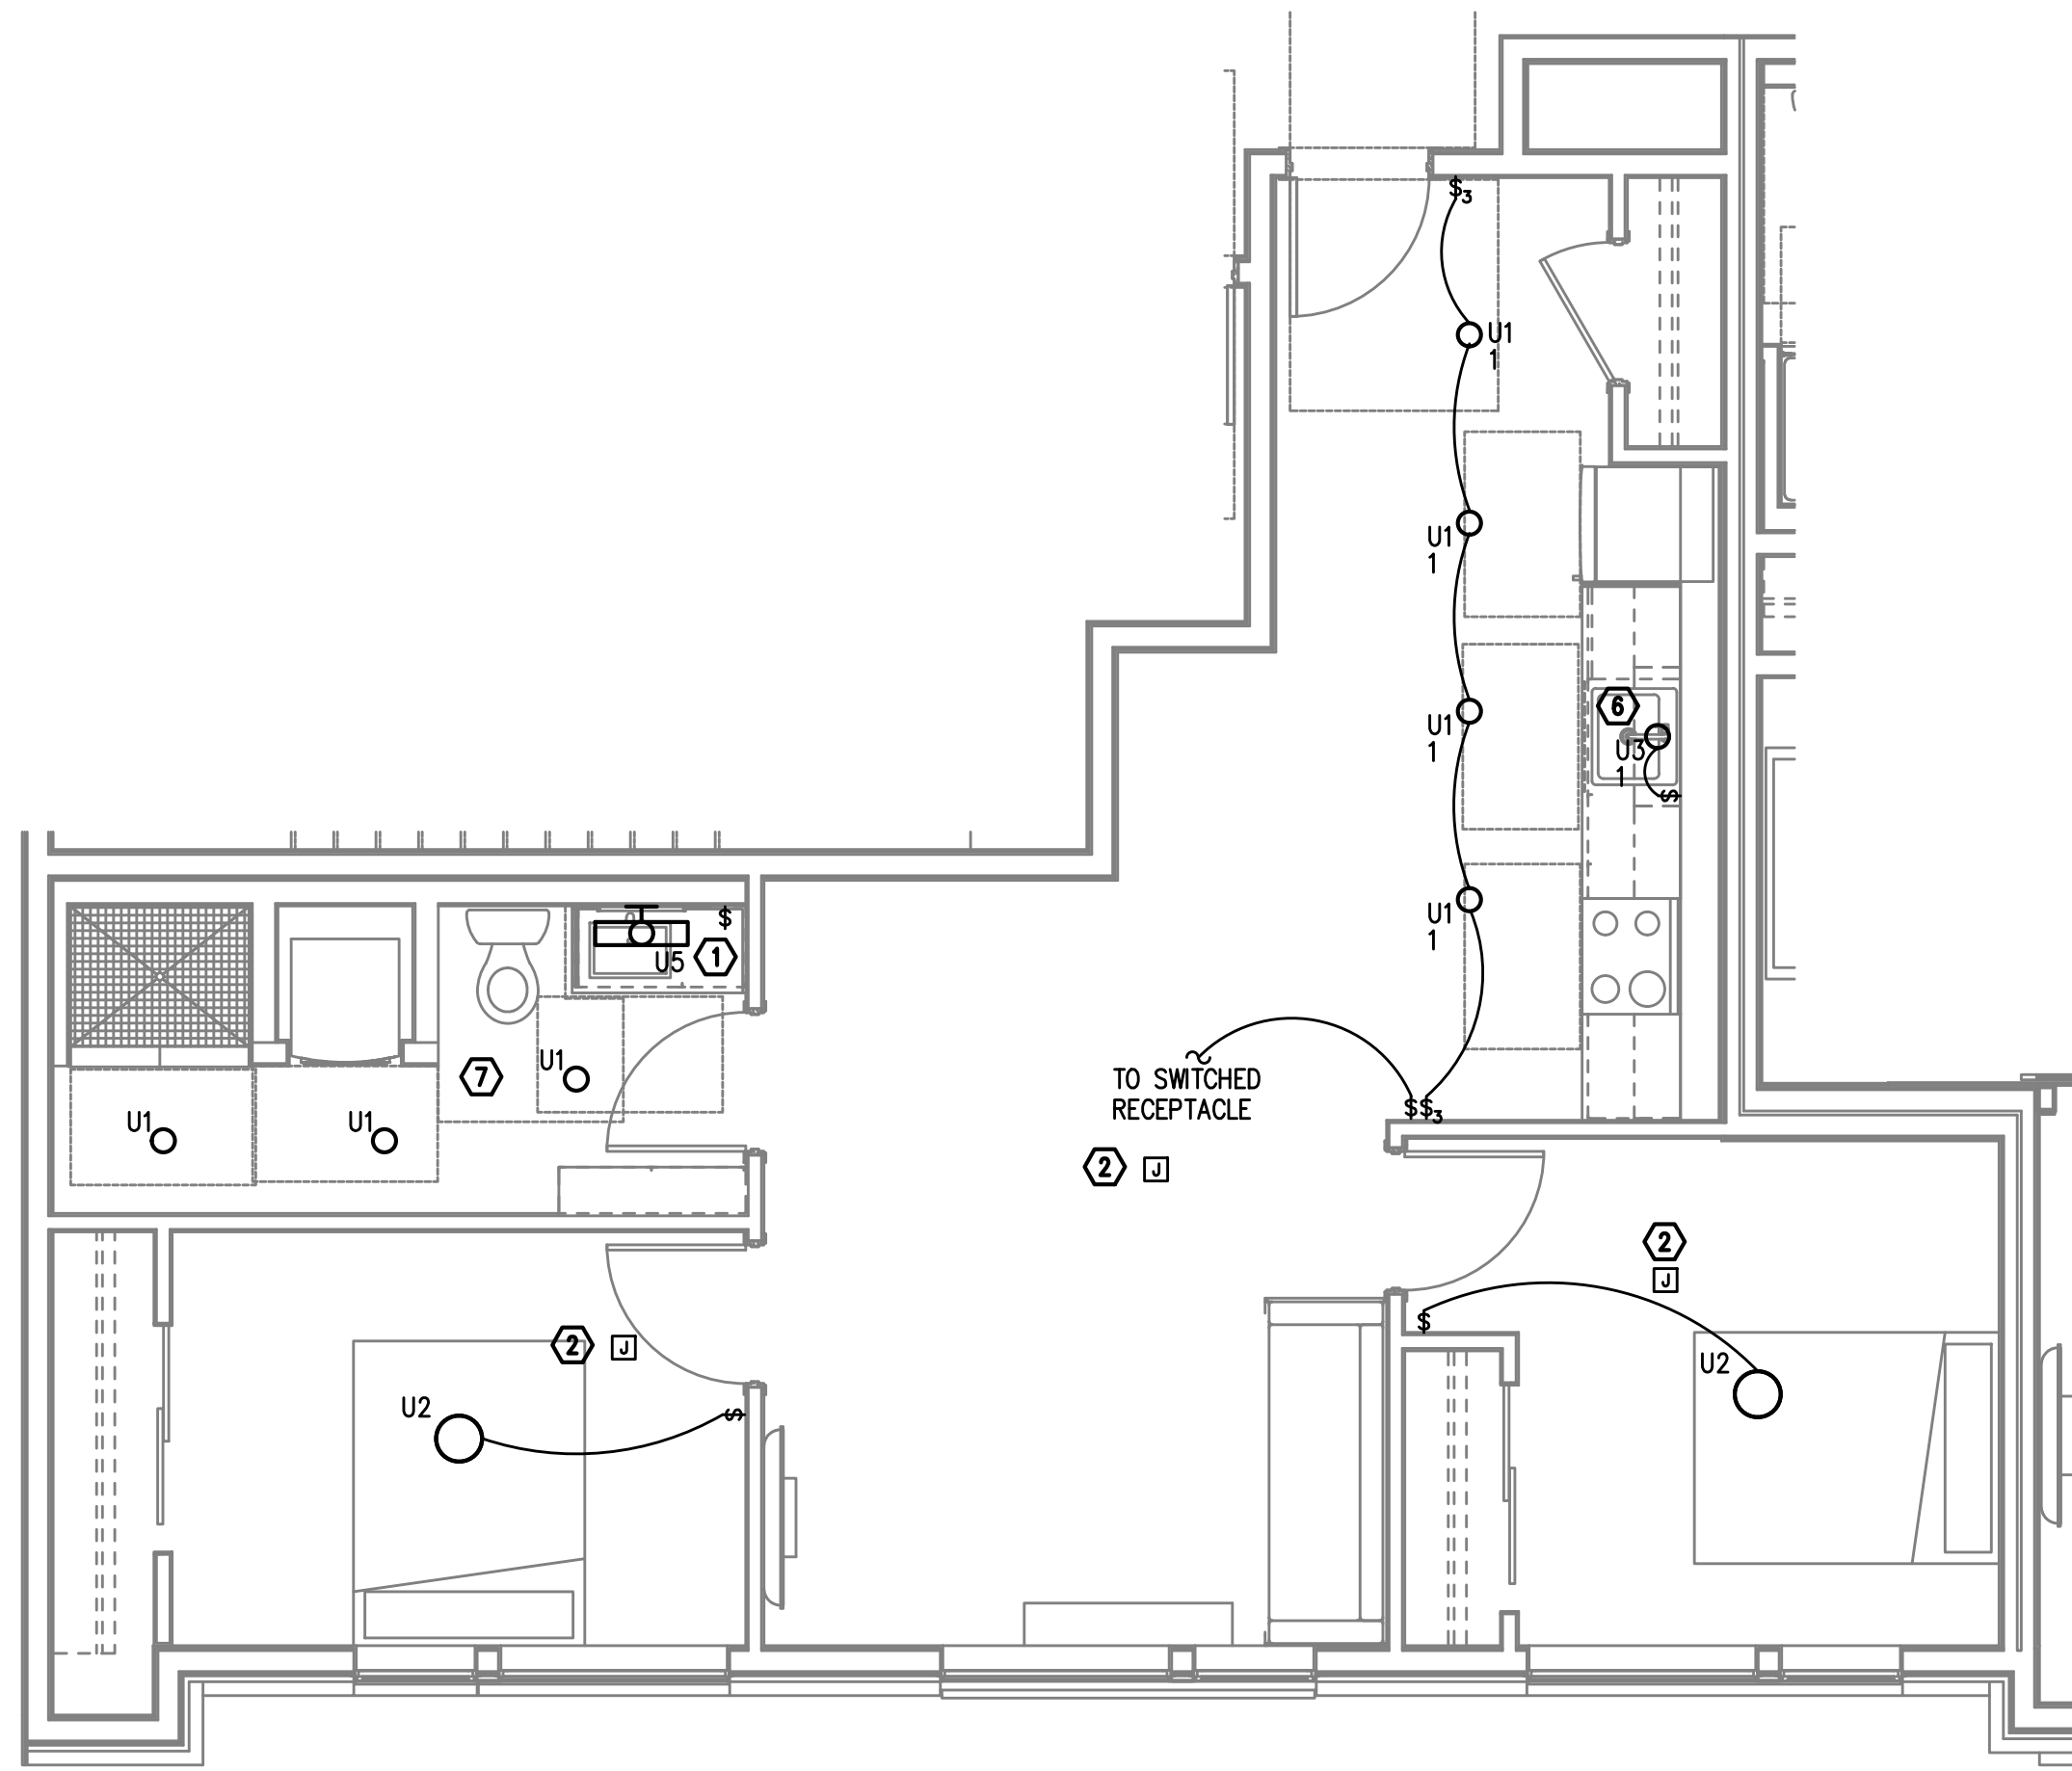


1
E4.07
TYPICAL UNIT TYPE DD
2 BED/1 BATH – LIGHTING PLAN
SCALE: 1/4" = 1'-0"

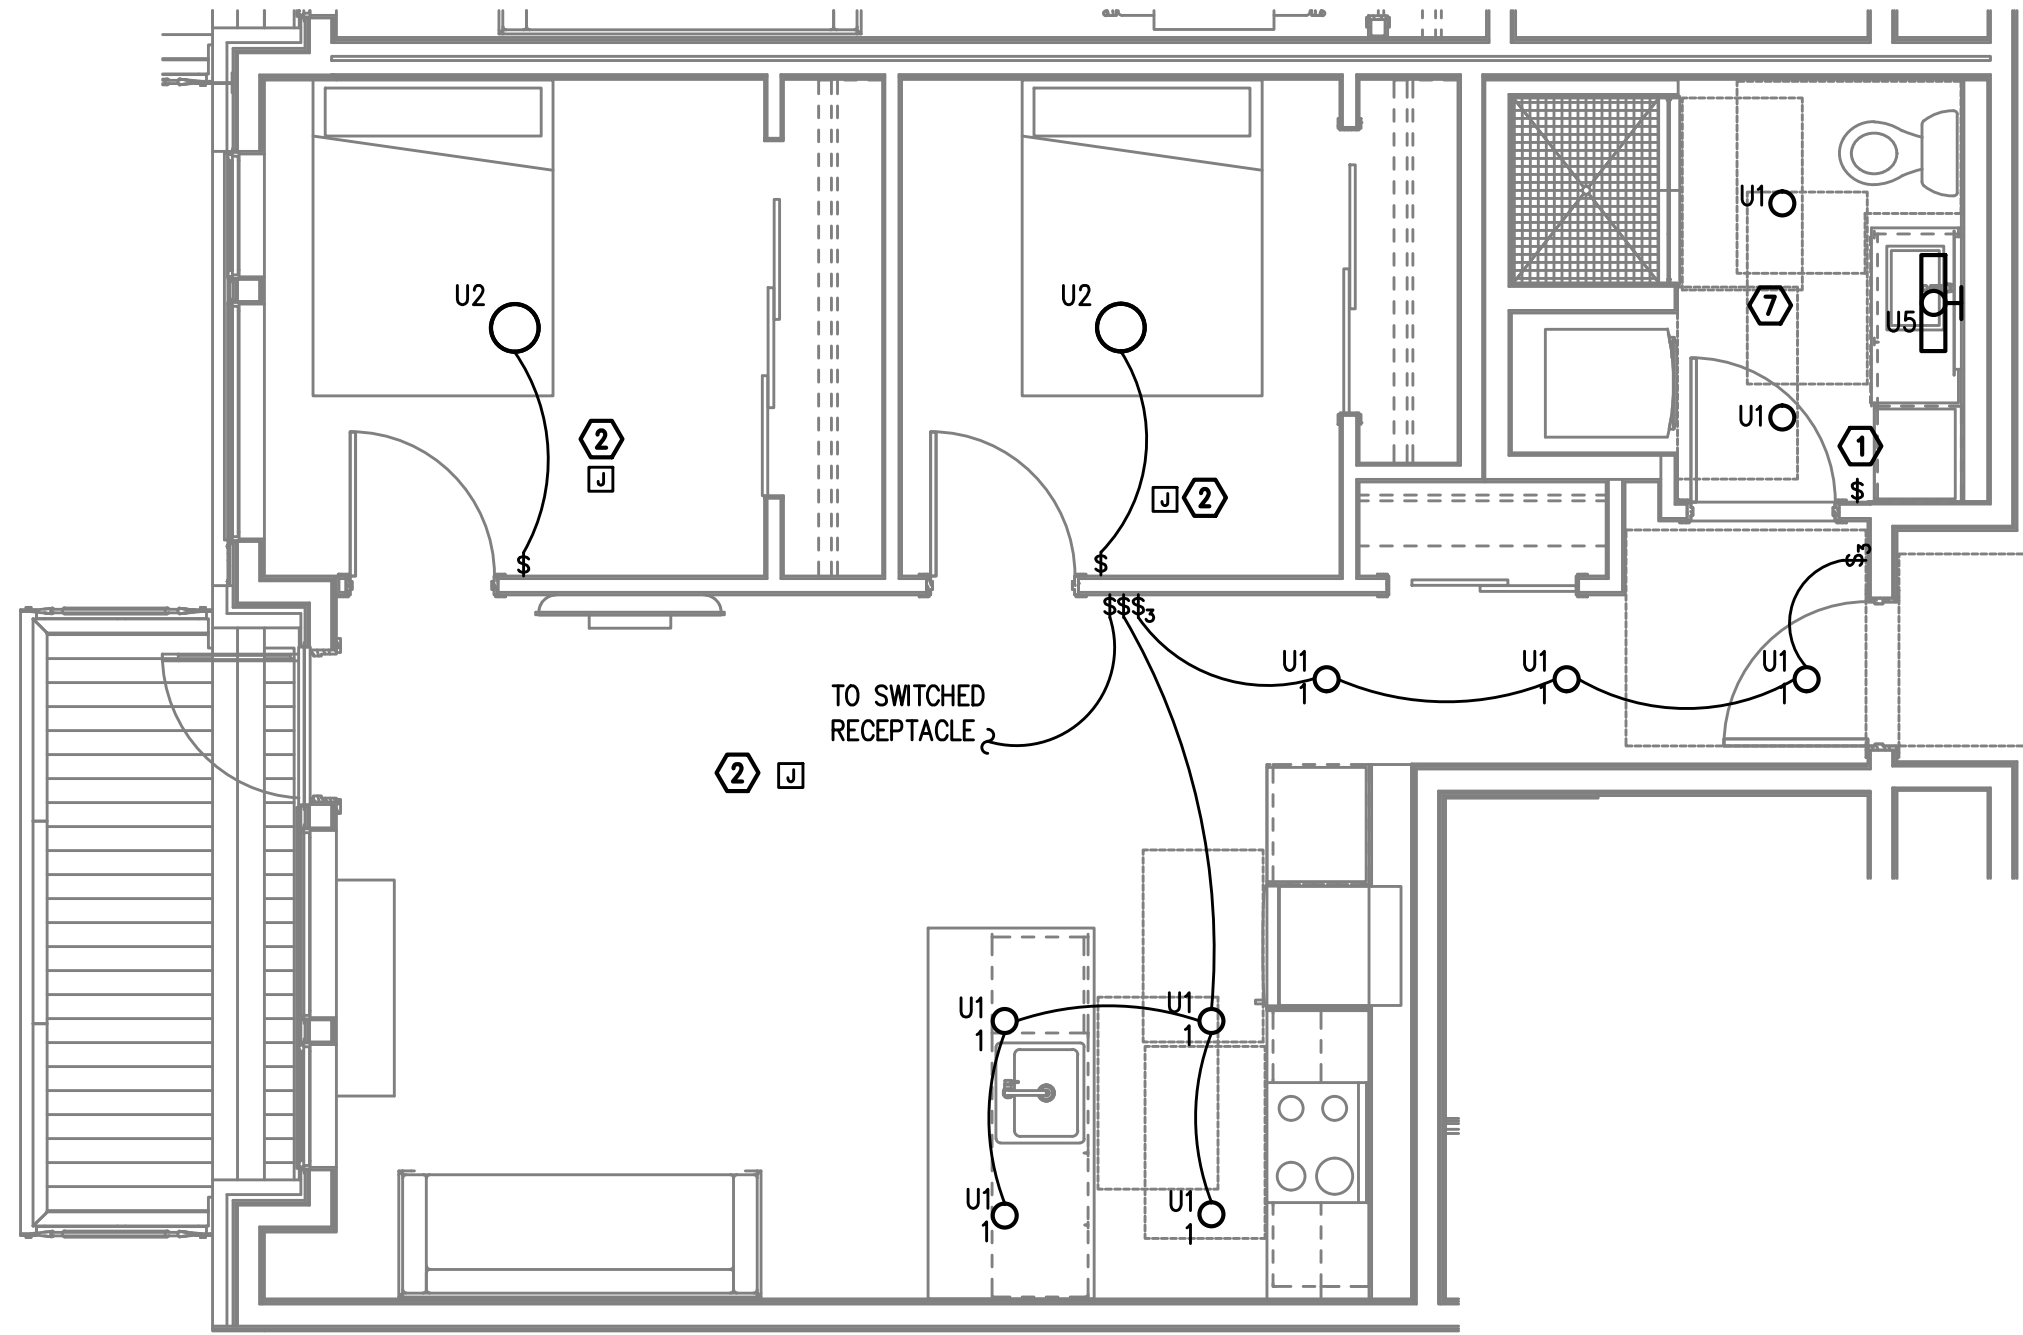

2
E4.07
TYPICAL UNIT TYPE EE
1 BED/1 BATH – LIGHTING PLAN
SCALE: 1/4" = 1'-0"

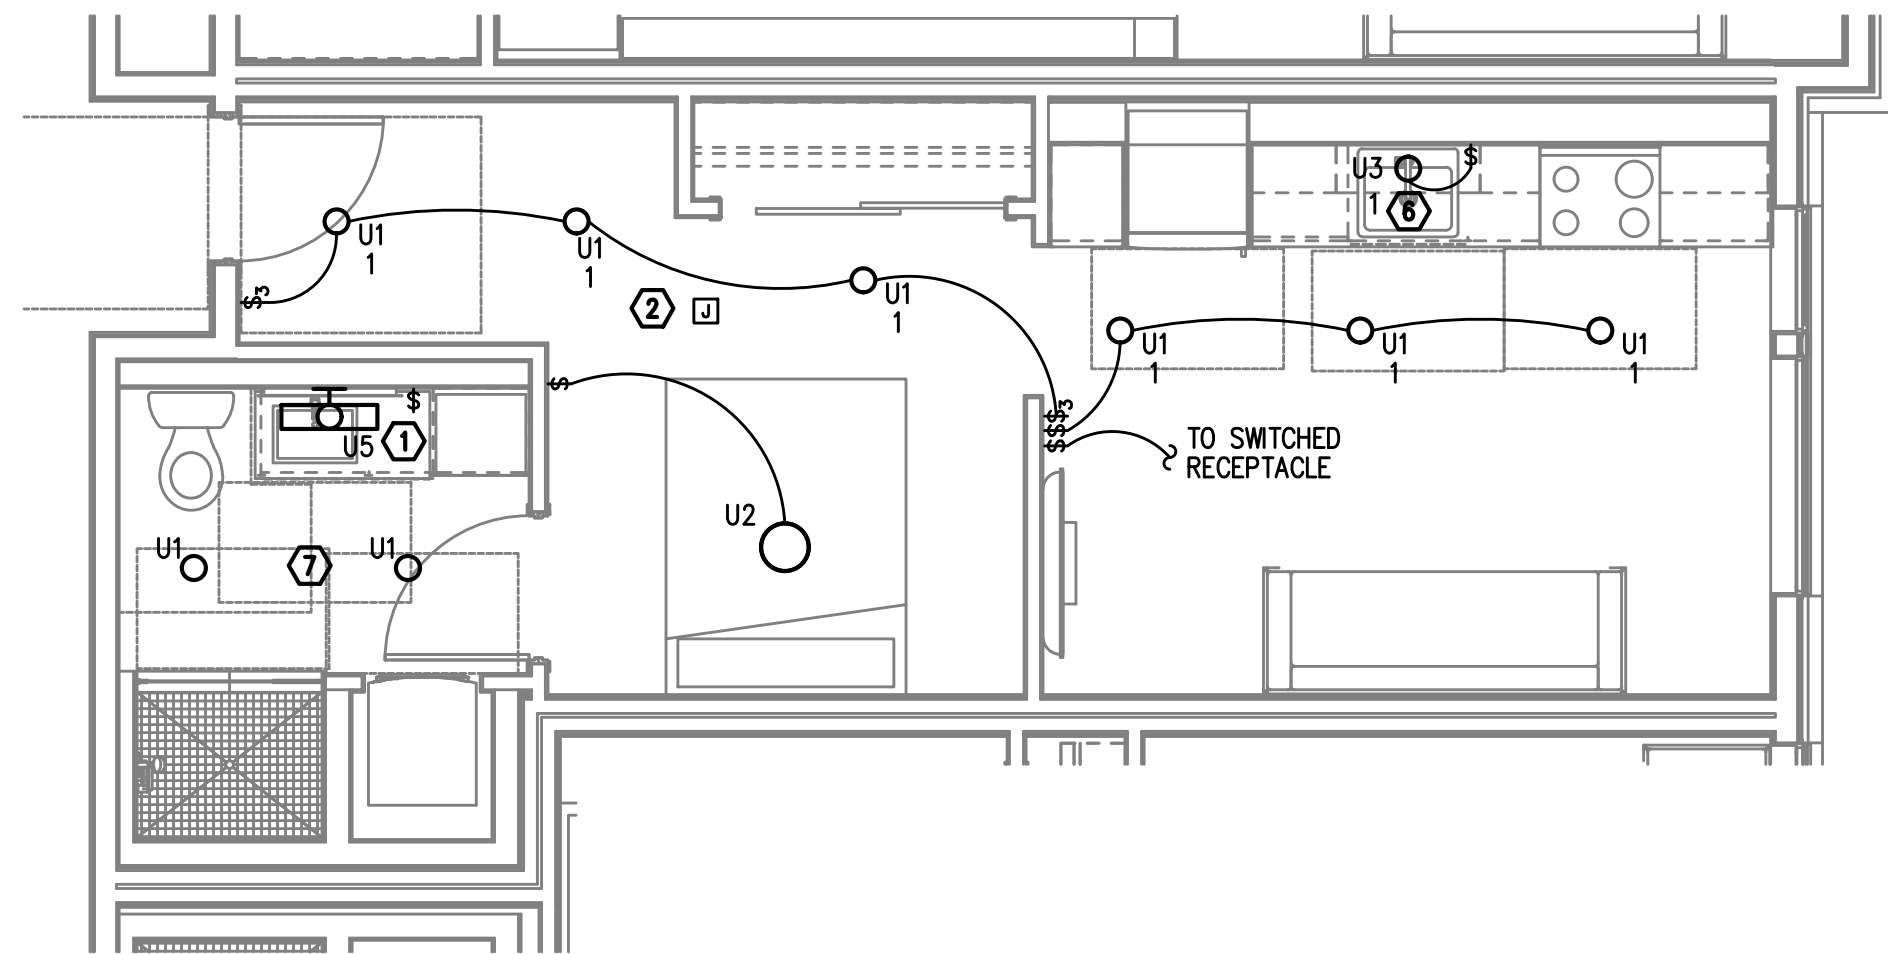


3
E4.07
TYPICAL UNIT TYPE FF
0 BED/1 BATH – LIGHTING PLAN
SCALE: 1/4" = 1'-0"

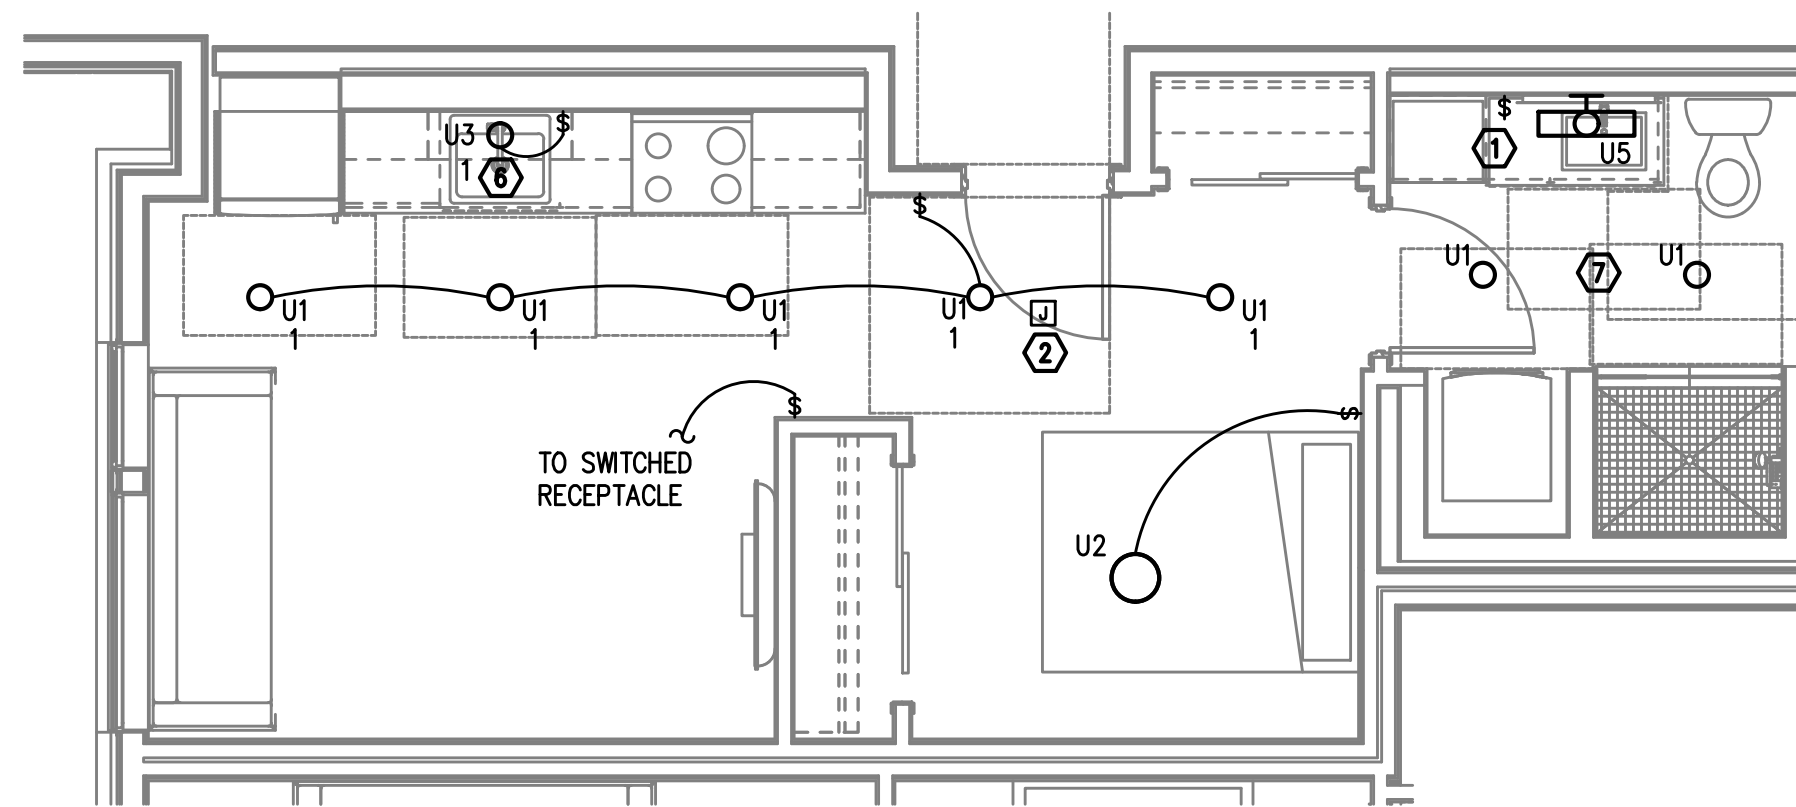

4
E4.07
TYPICAL UNIT TYPE GG
0 BED/1 BATH – LIGHTING PLAN
SCALE: 1/4" = 1'-0"


NOTE:
REFER TO SHEET E4.01 FOR GENERAL AND KEYED LIGHTING NOTES.

M
F
A
INC.
Consulting Engineers
2007 S.E. Ash St.
Portland, OR 97214
PHN: (503) 234-0548
FAX: (503) 234-0677
WWW.MFIA-ENG.COM
CONTACT: DENISE TAYLOR

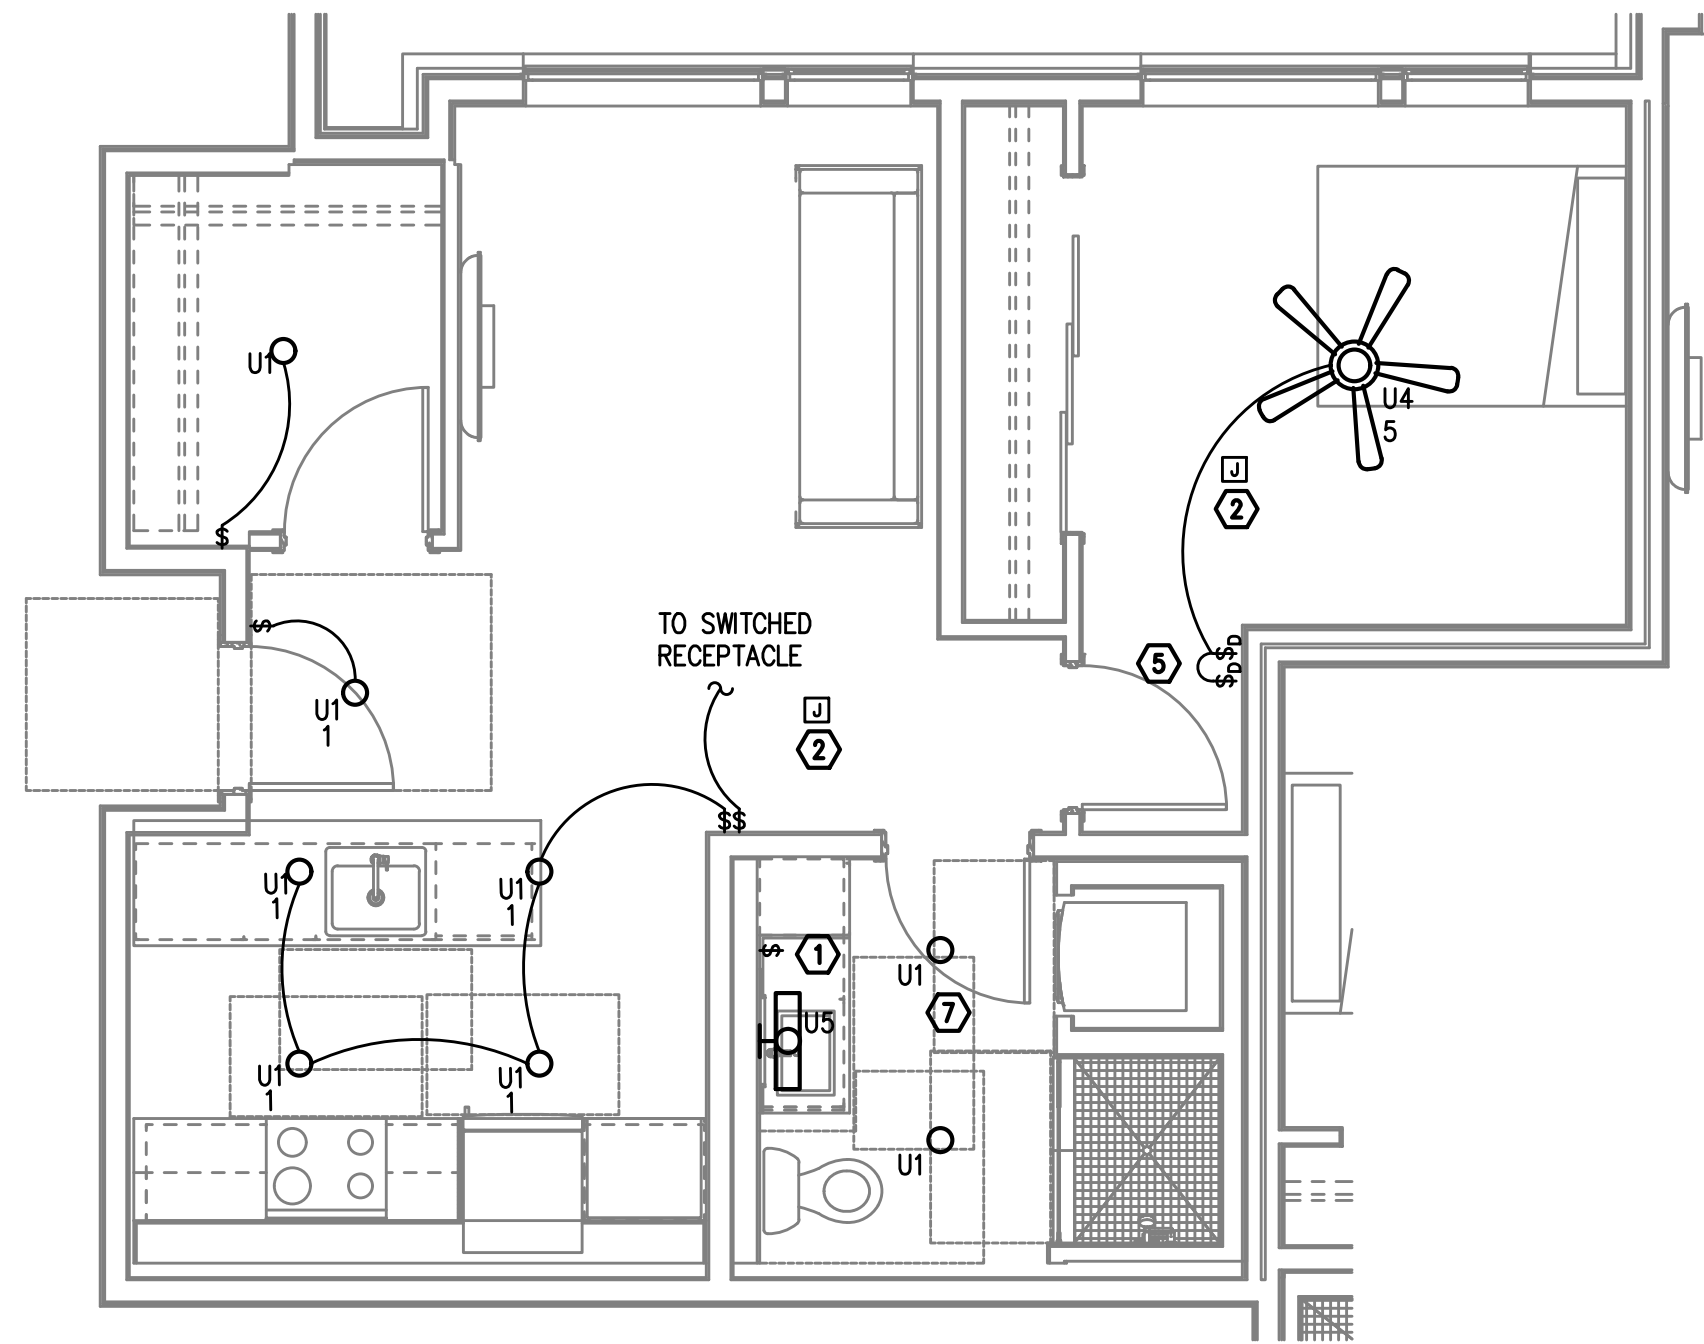


1
E4.08

TYPICAL UNIT TYPE HH
1 BED/1 BATH – LIGHTING PLAN
SCALE: 1/4" = 1'-0"

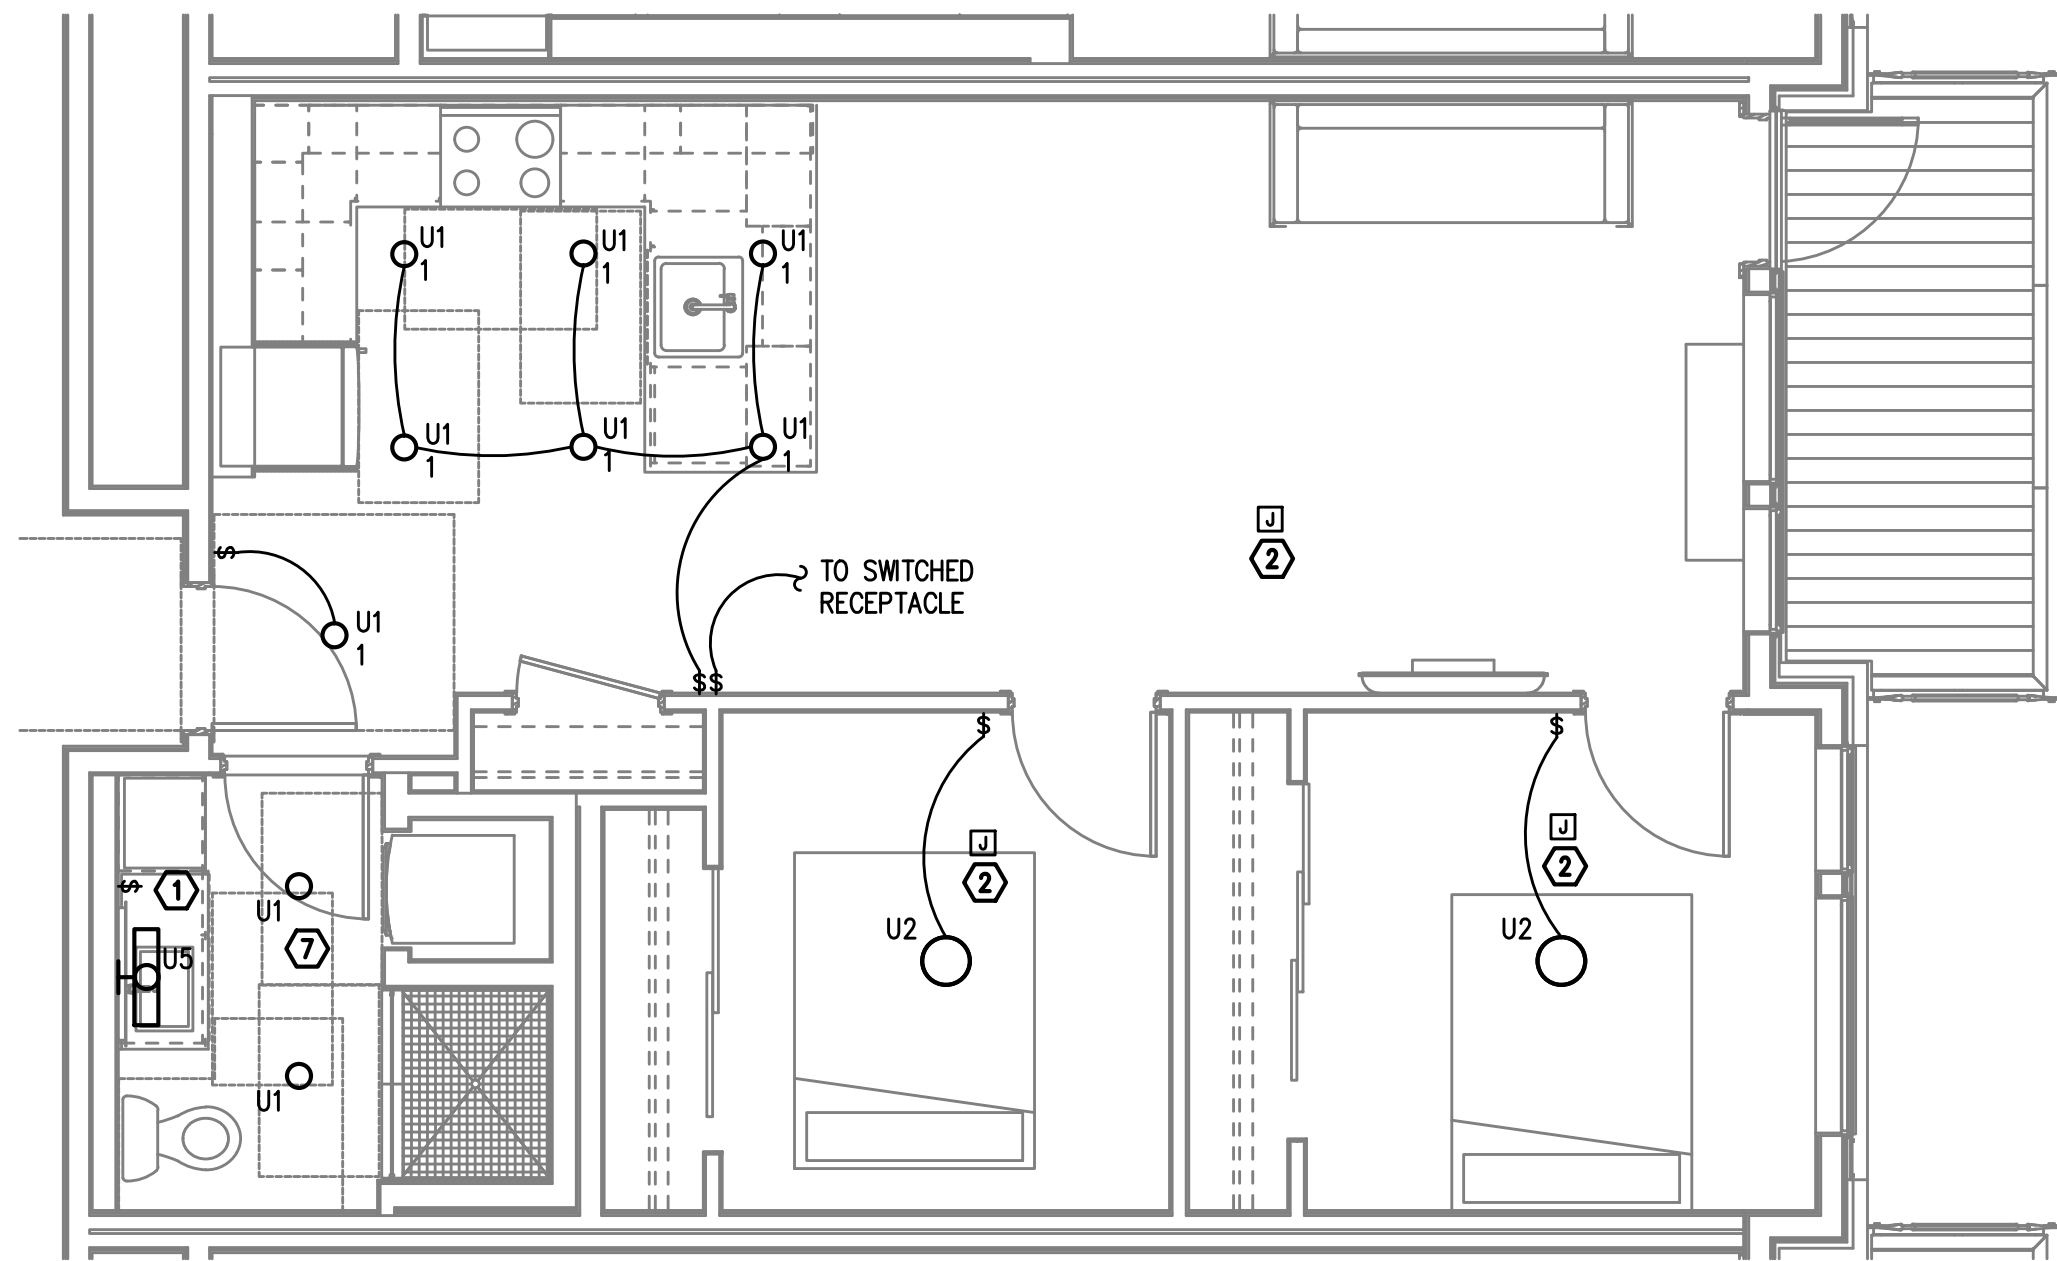

2
E4.08

TYPICAL UNIT TYPE II
2 BED/1 BATH – LIGHTING PLAN
SCALE: 1/4" = 1'-0"

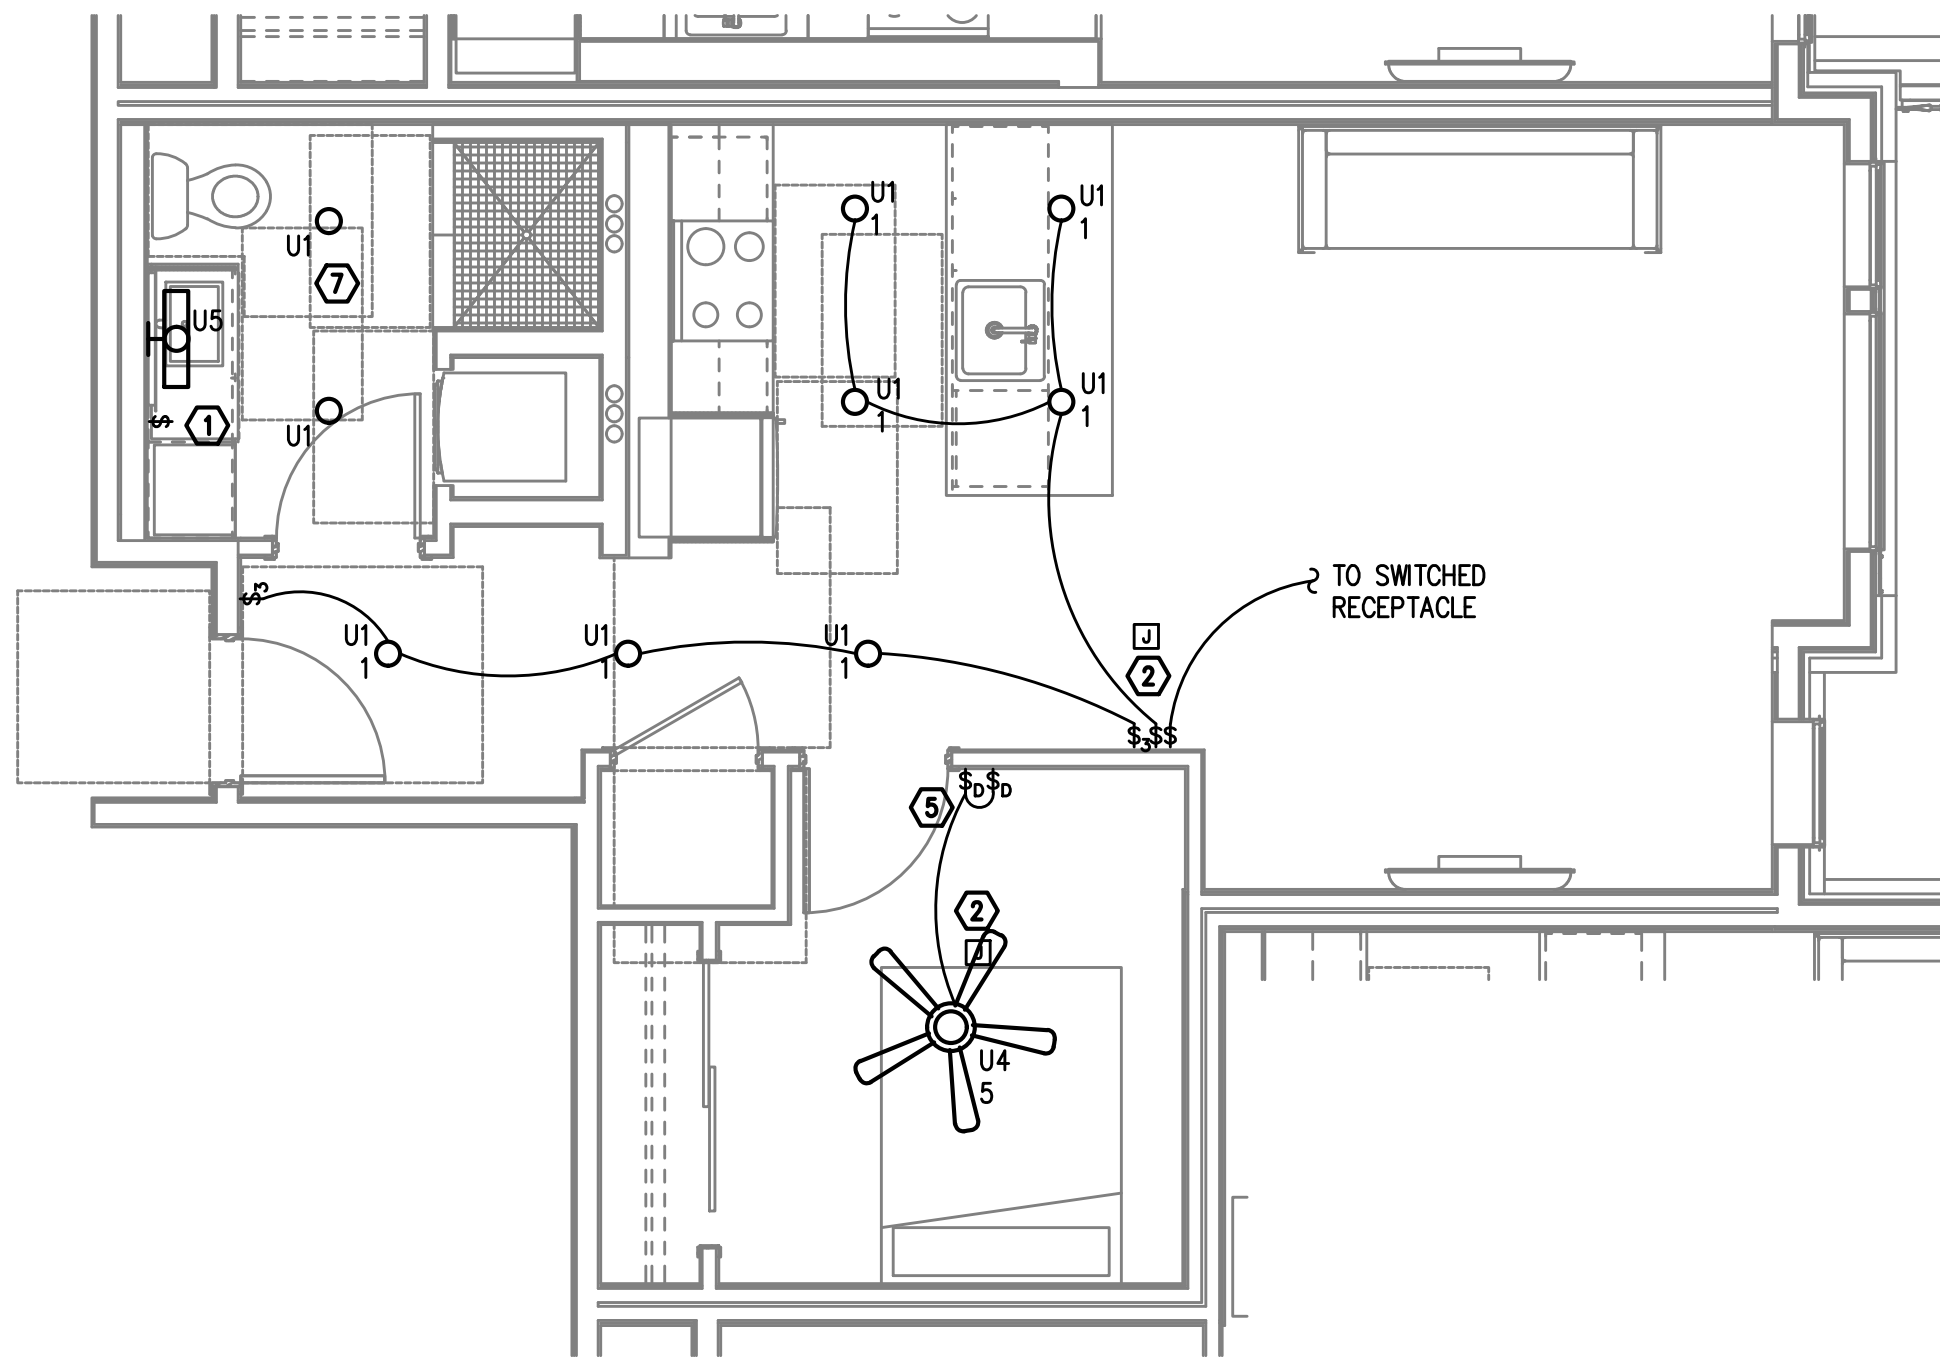

3
E4.08

TYPICAL UNIT TYPE JJ
1 BED/1 BATH – LIGHTING PLAN
SCALE: 1/4" = 1'-0"

NOTE:
REFER TO SHEET E4.01 FOR GENERAL AND KEYED LIGHTING NOTES.

M
F
A
INC.

Consulting Engineers
2007 S.E. Ash St.
Portland, OR 97214
PHN: (503) 234-0548
FAX: (503) 234-0677
WWW.MFIA-ENG.COM
CONTACT: DENISE TAYLOR

PRELIMINARY
NOT FOR
CONSTRUCTION

IN THE EVENT CONFLICTS ARE DISCOVERED
BETWEEN THE ORIGINAL SIGNED AND SEALED
DOCUMENTS PREPARED BY THE ARCHITECTS
AND/OR THEIR CONSULTANTS, AND ANY COPY OF
THE DOCUMENTS TRANSMITTED BY MAIL, FAX,
ELECTRONICALLY OR OTHERWISE, THE ORIGINAL
SIGNED AND SEALED DOCUMENTS SHALL GOVERN.

PROJECT # 2017-053
DATE: 11/19/2021

REVISIONS

AEGIS - PHASE II
MIXED-USE DEVELOPMENT
312 E EVERGREEN BOULEVARD, VANCOUVER, WA 98660


NOTE:

REFER TO SHEET E4.01 FOR GENERAL AND KEYED LIGHTING NOTES.

M
F
A
INC. Consulting Engineers
2007 S.E. Ash St.
Portland, OR 97214
PHN: (503) 234-0548
FAX: (503) 234-0677
WWW.MFIA-ENG.COM
CONTACT: DENISE TAYLOR

SHEET:


E4.09

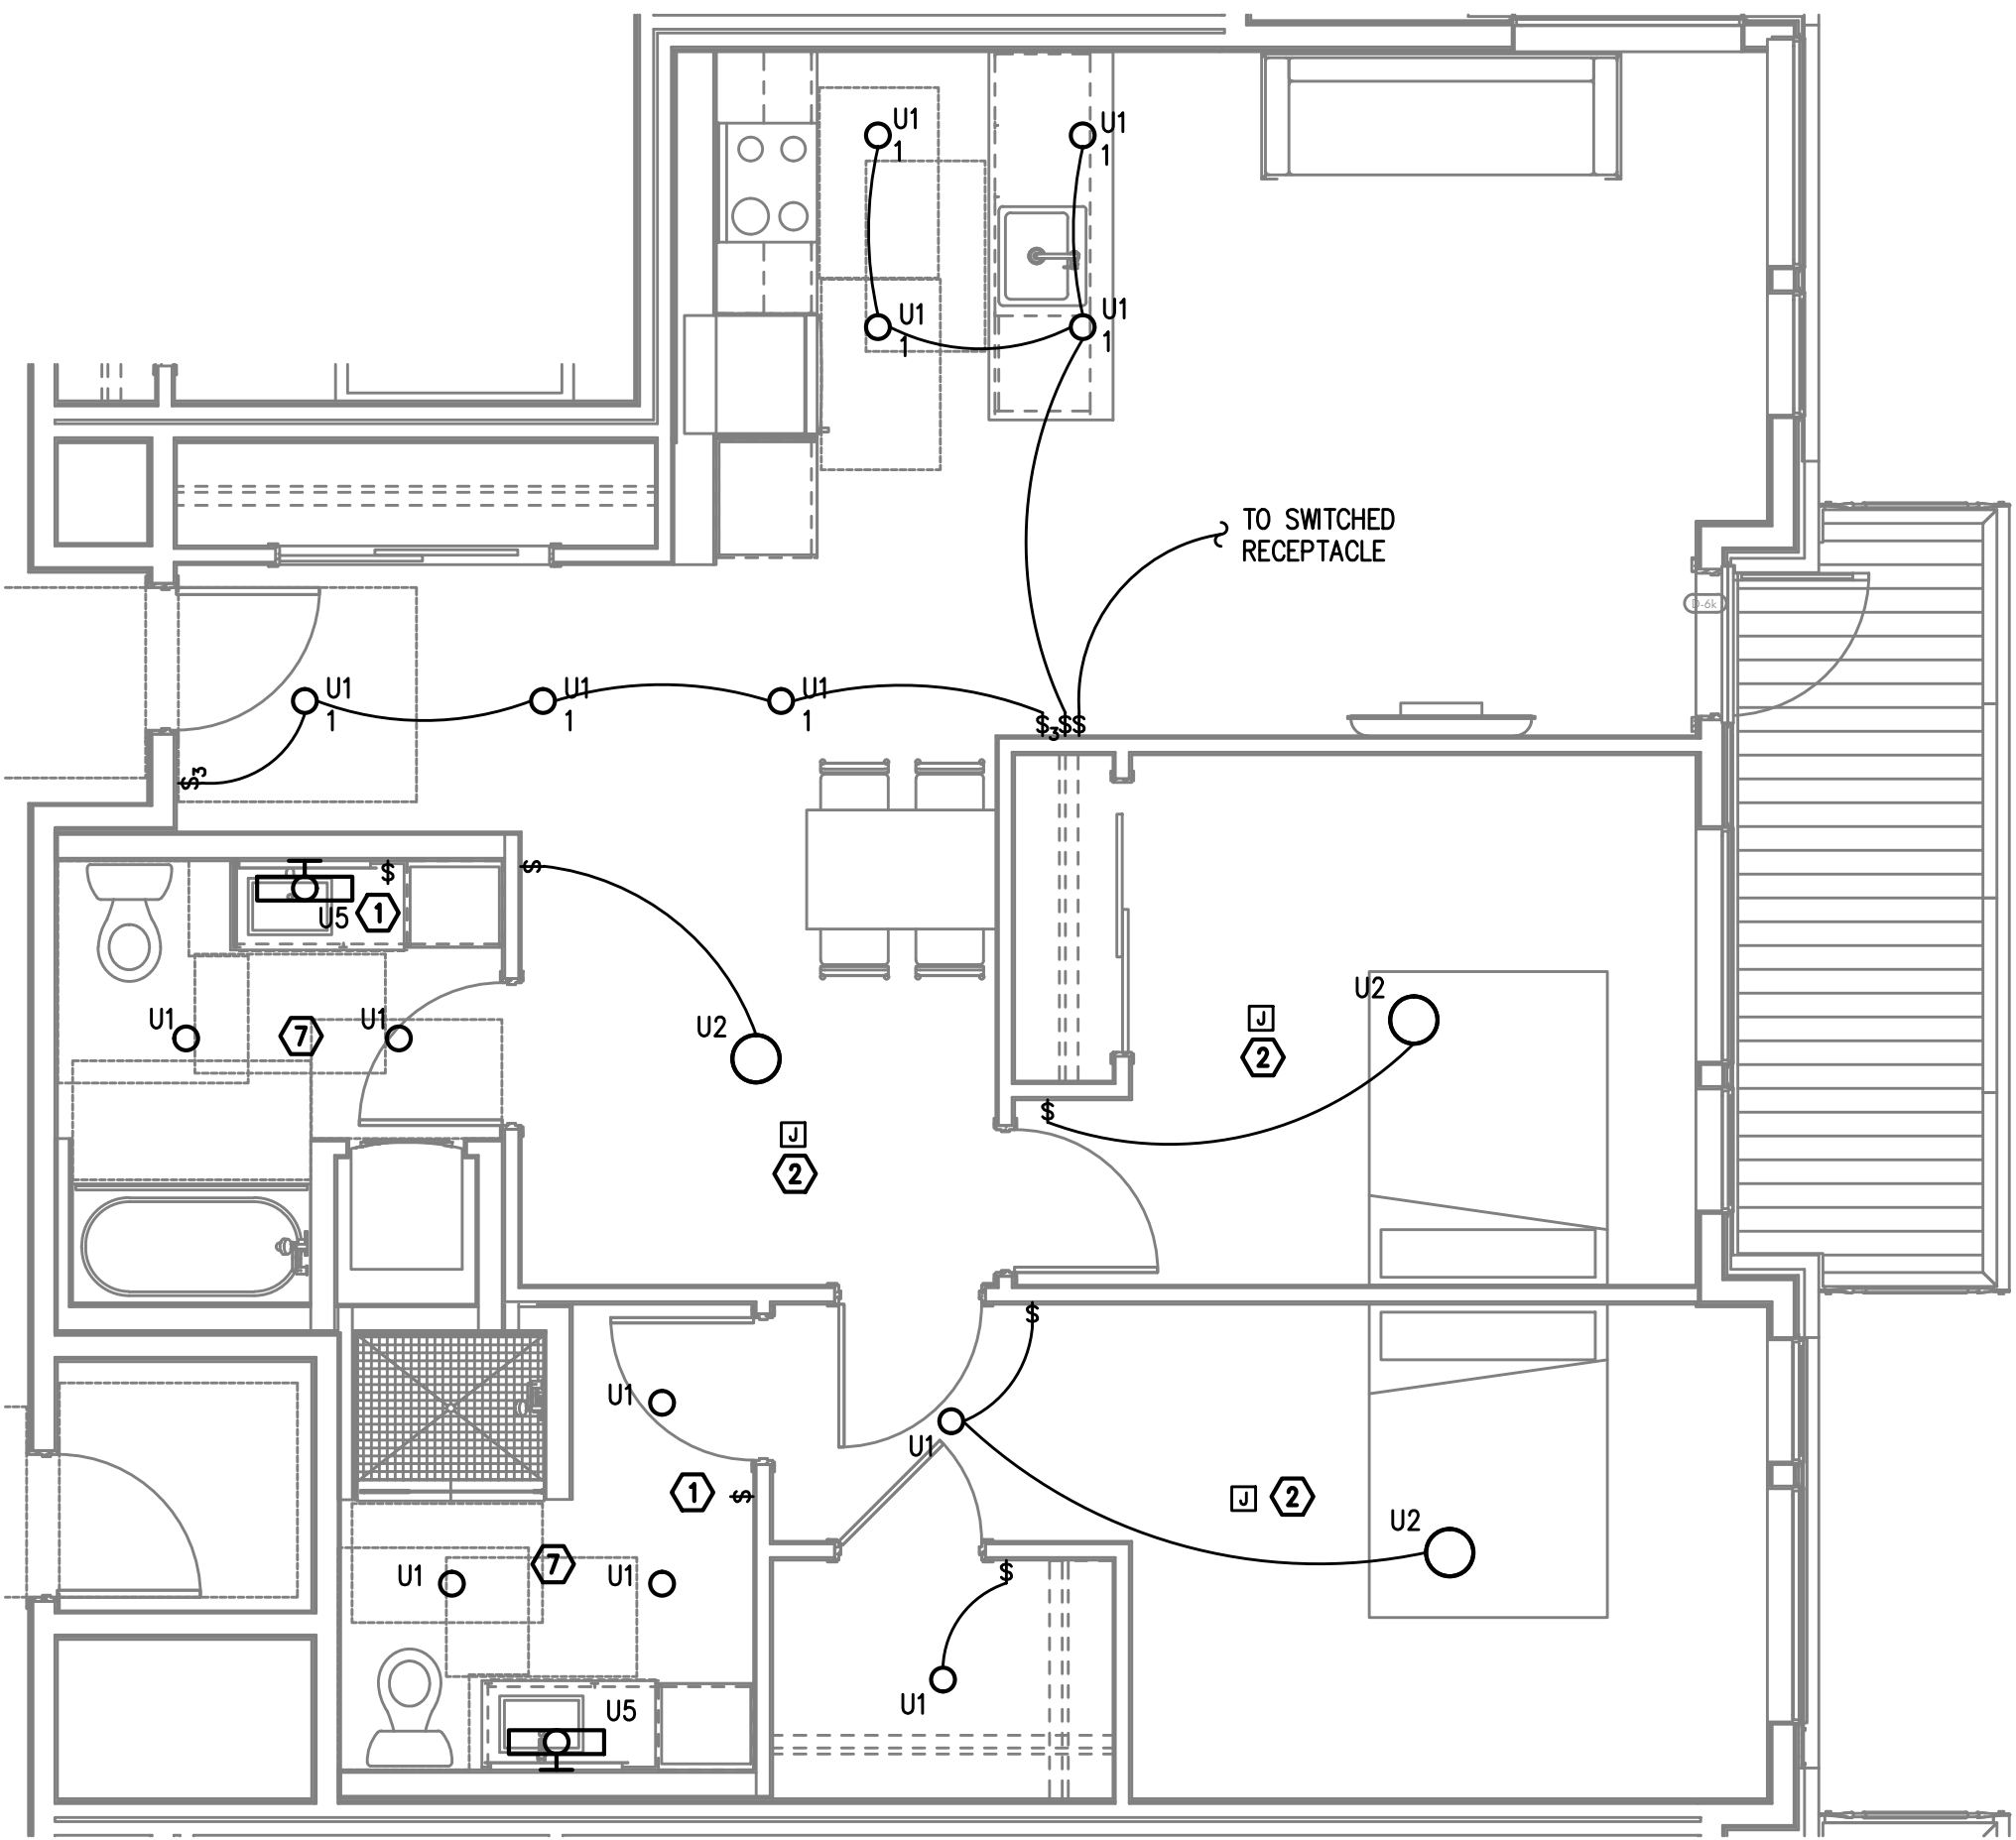

TYPICAL UNIT TYPE KK

2 BED/2 BATH - LIGHTING PLAN

SCALE: 1/4" = 1'-0"

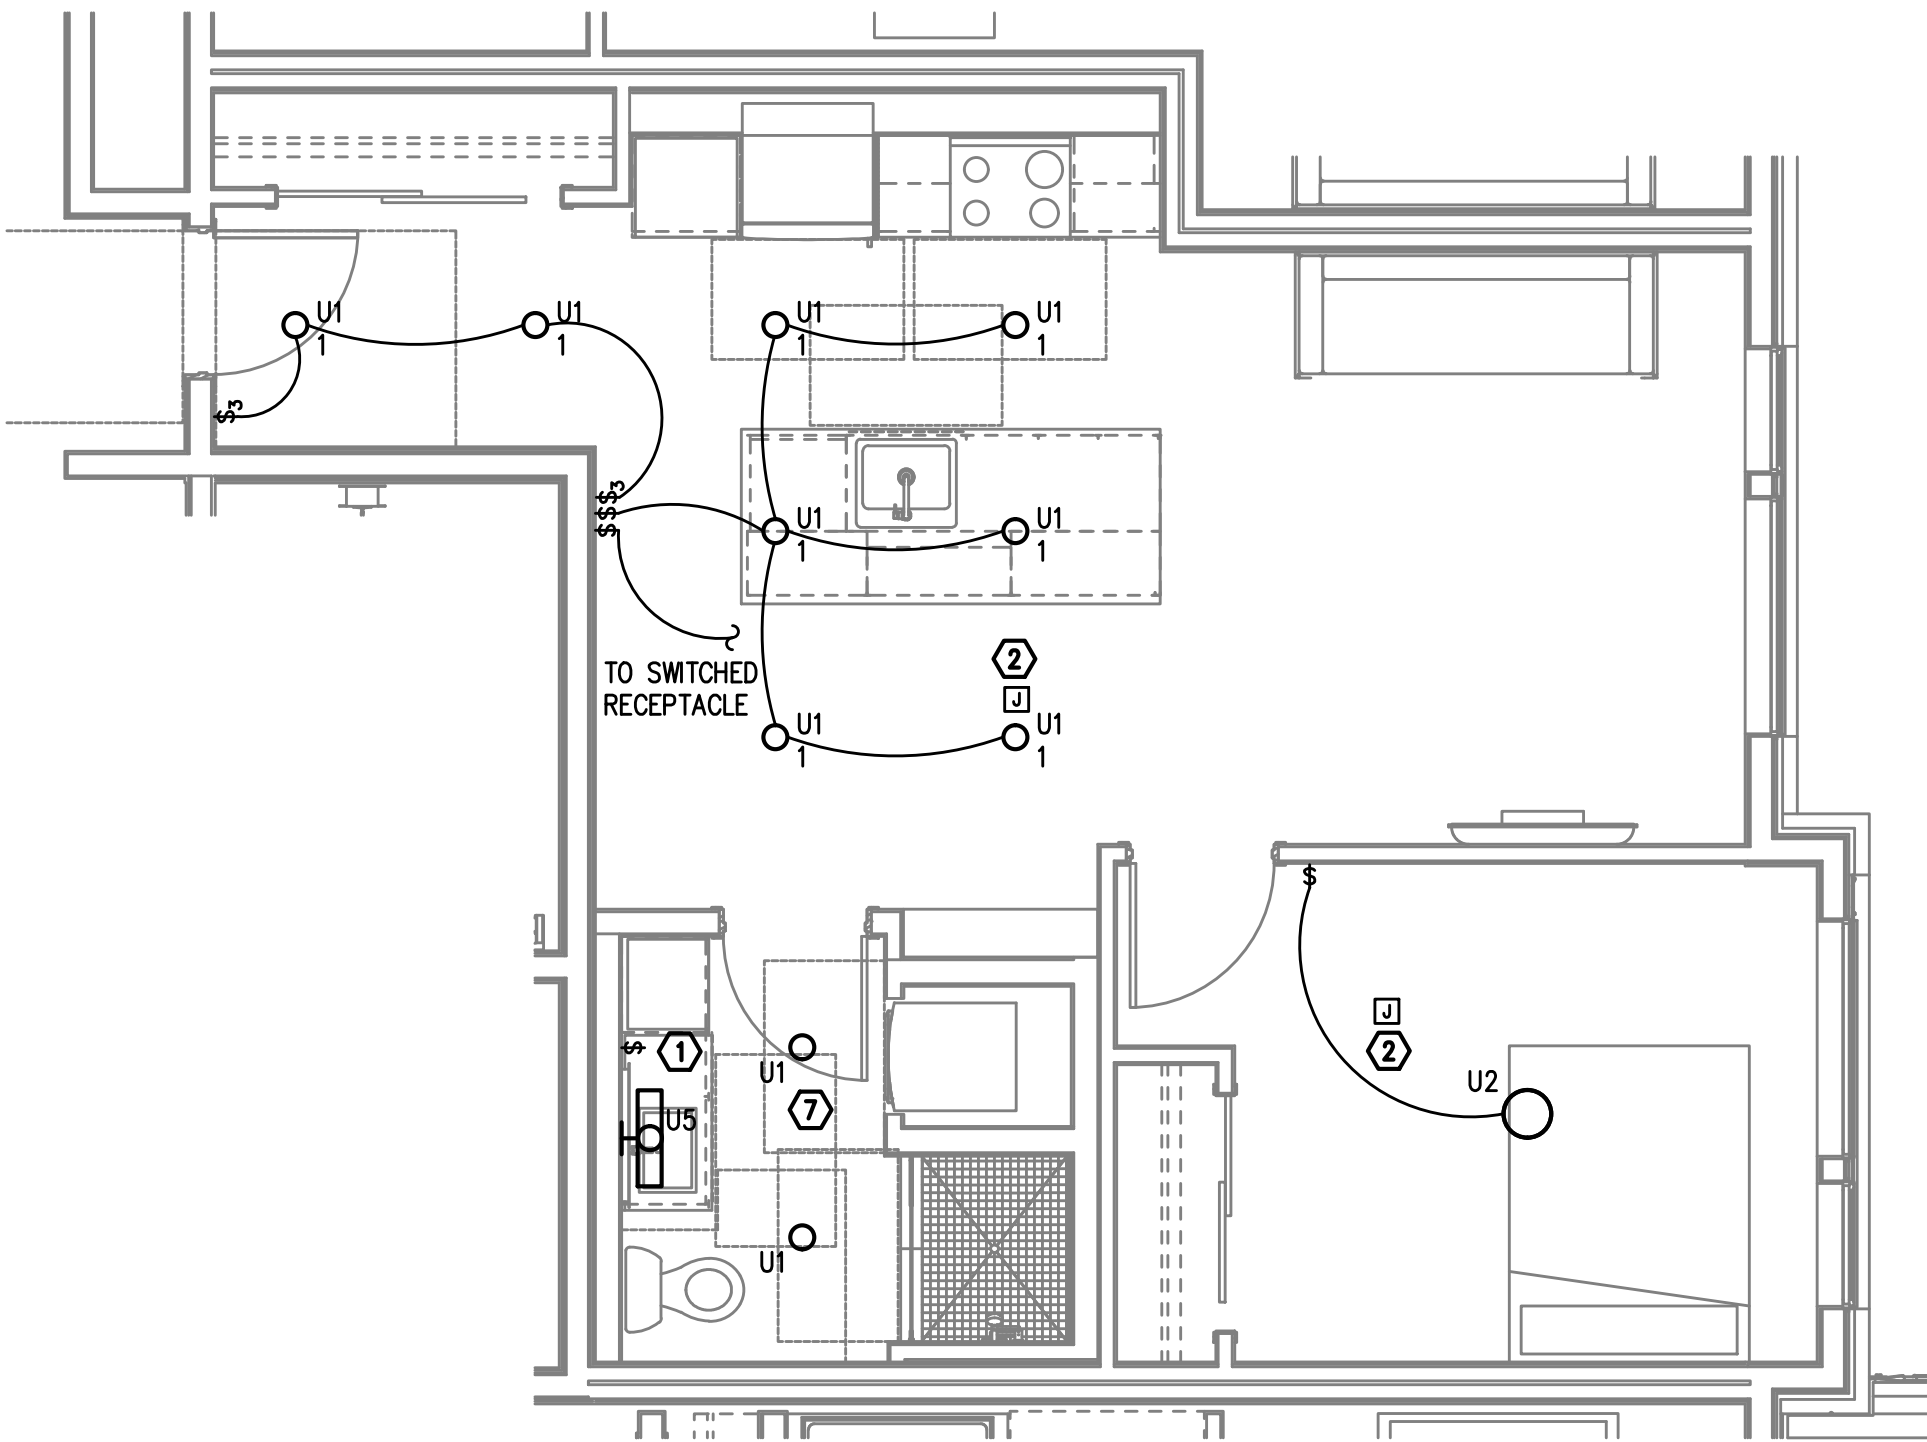

TYPICAL UNIT TYPE LL

1 BED/1 BATH - LIGHTING PLAN

SCALE: 1/4" = 1'-0"

PRELIMINARY
NOT FOR
CONSTRUCTIONIN THE EVENT CONFLICTS ARE DISCOVERED
BETWEEN THE ORIGINAL SIGNED AND SEALED
DOCUMENTS PREPARED BY THE ARCHITECTS
AND/OR THEIR CONSULTANTS, AND ANY COPY OF
THE DOCUMENTS TRANSMITTED BY MAIL, FAX,
ELECTRONICALLY OR OTHERWISE, THE ORIGINAL
SIGNED AND SEALED DOCUMENTS SHALL GOVERN.PROJECT # 2017-053
DATE: 11/19/2021


REVISIONS

GENERAL NOTES:


- KITCHEN RECEPTACLES LOCATED IN ISLANDS OR PENINSULAS WHERE THE BACK SPLASH WILL NOT ACCOMMODATE VERTICAL PLACEMENT OR THE DUPLEX RECEPTACLE, THE CONTRACTOR SHALL ROTATE THE DEVICE 90 DEGREES SO THAT THE RECEPTACLE IS INSTALLED HORIZONTALLY.
- REFER TO DETAILS ON SHEET E1.23 FOR ADDITIONAL INFORMATION REGARDING ADA REACH REQUIREMENTS FOR RECEPTACLE AND SWITCH MOUNTING HEIGHT.
- STANDARD RECEPTACLE MOUNTING HEIGHT IS 18" A.F.F. UNLESS OTHERWISE SPECIFIED. RECEPTACLES LOCATED BELOW WINDOW SILLS SHALL NOT BE LESS THE 15" A.F.F.
- ALL PLANS ARE DIAGRAMMATICAL. CONSULT ARCHITECTURAL PLANS AND ELEVATIONS FOR EXACT LOCATION AND MOUNTING HEIGHT OF ALL DEVICES AND FIXTURES.
- REFER TO SHEET E1.17 FOR TYPICAL UNIT LOAD CENTER DIRECTORIES.
- RECEPTACLE FOR PTHP UNIT SHALL BE LOCATED BELOW THE UNIT, NEAR THE BASE OF THE WALL SUCH THAT THE CORD SET IS CONCEALED AS MUCH AS POSSIBLE. COORDINATE INSTALLATION WITH THE MECHANICAL INSTALLER.
- COORDINATE WITH THE 'T' SERIES SHEETS FOR EXACT LOCATIONS AND PROVIDE ROUGH IN FOR LOW VOLTAGE SYSTEMS (□) REFERS TO ROUGH IN BOXES.
- ALL KITCHEN COUNTER TOP RECEPTACLES SHALL BE INSTALLED A MINIMUM OF 36" FROM A CORNER WALL PER ADA REQUIREMENTS. WHERE COUNTERS ARE NOT LONG ENOUGH TO ACCOMMODATE THIS, THE RECEPTACLE SHALL BE PLACED ON AN END WALL, NO MORE THAN 12" FROM THE FRONT EDGE OF THE COUNTER.

KEYED NOTES:

- PROVIDE WIRE CONNECTION FOR THERMOSTAT(S). COORDINATE WITH MECHANICAL INSTALLER FOR EXACT LOCATION AND POWER REQUIREMENTS PRIOR TO ROUGH IN. THERMOSTATS TO BE MOUNTED AT 48" AFF MAX. TO HIGHEST OPERABLE PART.
- PROVIDE ONE 20A, 120V, 1P GFCI DUPLEX RECEPTACLE UNDER KITCHEN SINK FOR DISPOSAL POWER CONNECTION. DISPOSAL TO BE PROVIDED WITH "SAFEAIRE" SINK DISPOSAL AIR SWITCH, MOUNTED PER ARCHITECT'S DIRECTION. VERIFY DEVICE FINISH WITH ARCHITECT PRIOR TO ORDERING.
- REFER TO DETAIL 2/E1.17 FOR TYPICAL LAUNDRY ALCOVE RECEPTACLE LOCATIONS. COORDINATE INSTALLATION WITH MECHANICAL & PLUMBING CONTRACTOR.
- MOUNT DEVICES HORIZONTALLY, JUST UNDER THE EDGE OF THE COUNTER TOP.
- PROVIDE ONE 15A, RECEPTACLE CIRCUIT FROM TENANT LOAD CENTER FOR TELECOM SMART PANEL. COORDINATE WORK WITH SERVICE PROVIDER FOR EXACT LOCATION AND FINAL CONNECTION.
- PROVIDE ONE 20A, 120V, 1P RECEPTACLE WITH USB PORT, MOUNTED AT 44" A.F.F. (MAX) AT KITCHEN ISLAND/PENNISULA COUNTER & AT 18" AFF IN BEDROOMS. CONSULT ARCHITECT AND/OR INTERIOR DESIGNER FOR ADDITIONAL LOCATIONS WHERE REQUIRED.
- INDOOR HEAT PUMP UNIT INTERCONNECTED WITH OUTDOOR UNIT LOCATED ON ROOF. CONTRACTOR SHALL COORDINATE WITH THE MECHANICAL HVAC INSTALLER AND MECHANICAL PLANS FOR EXACT POWER REQUIREMENTS & LOCATION OF EACH UNIT PRIOR TO ROUGH IN.
- COORDINATE WITH MECHANICAL EQUIPMENT INSTALLER FOR EXACT POWER REQUIREMENTS, CONTROLS & LOCATION OF THRU-WALL FAN. TIE INTO BEDROOM RECEPTACLE CIRCUIT.
- MOUNT DEVICES HORIZONTALLY, UNDER WINDOW SILL.
- RECEPTACLE MOUNTED IN FACE OF CABINET.
- COORDINATE WITH MECHANICAL EQUIPMENT INSTALLER FOR EXACT POWER REQUIREMENTS & LOCATION OF CONTINUOUS OPERATING EXHAUST FAN. TIE INTO LIVING ROOM LIGHTING RECEPTACLE CIRCUIT.
- PROVIDE POWER CONNECTION FOR BRANCH BOX, TIED INTO THE MINI-SPLIT SYSTEM, FROM THE TENANT LOAD CENTER. COORDINATE WORK WITH THE MECHANICAL EQUIPMENT INSTALLER.
- IN UNITS AT THE PT DECK, PROVIDE SURFACE MOUNTED RECEPTACLES AT STANDARD MOUNTING HEIGHT ON THE CORNER COLUMN. CONSULT ARCHITECT FOR ADDITIONAL INFORMATION.

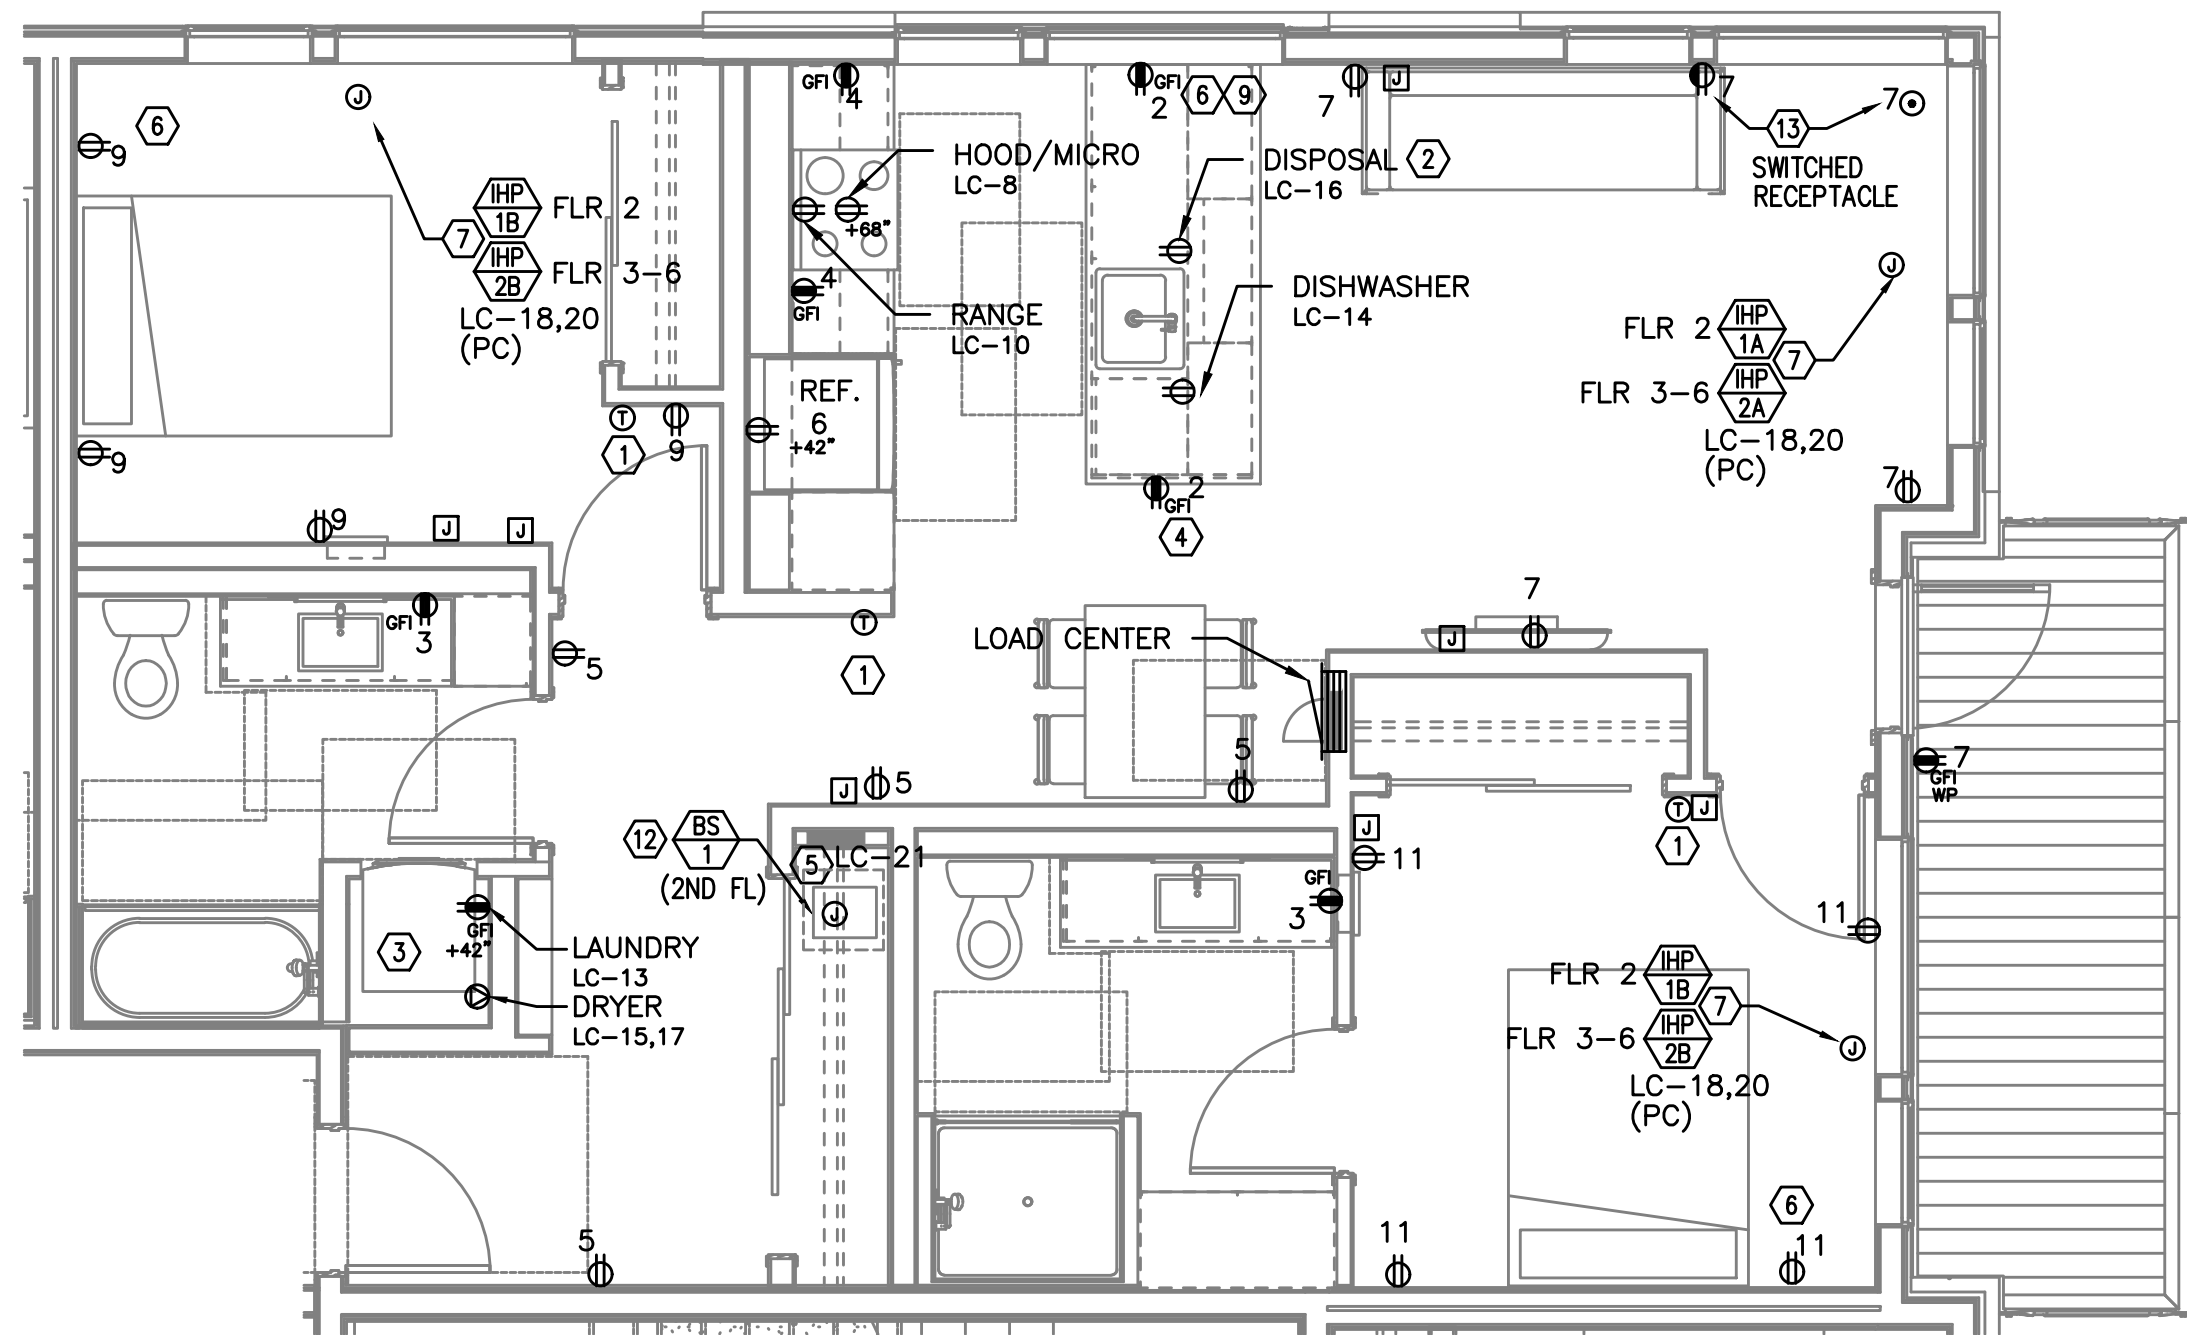

TYPICAL UNIT TYPE A

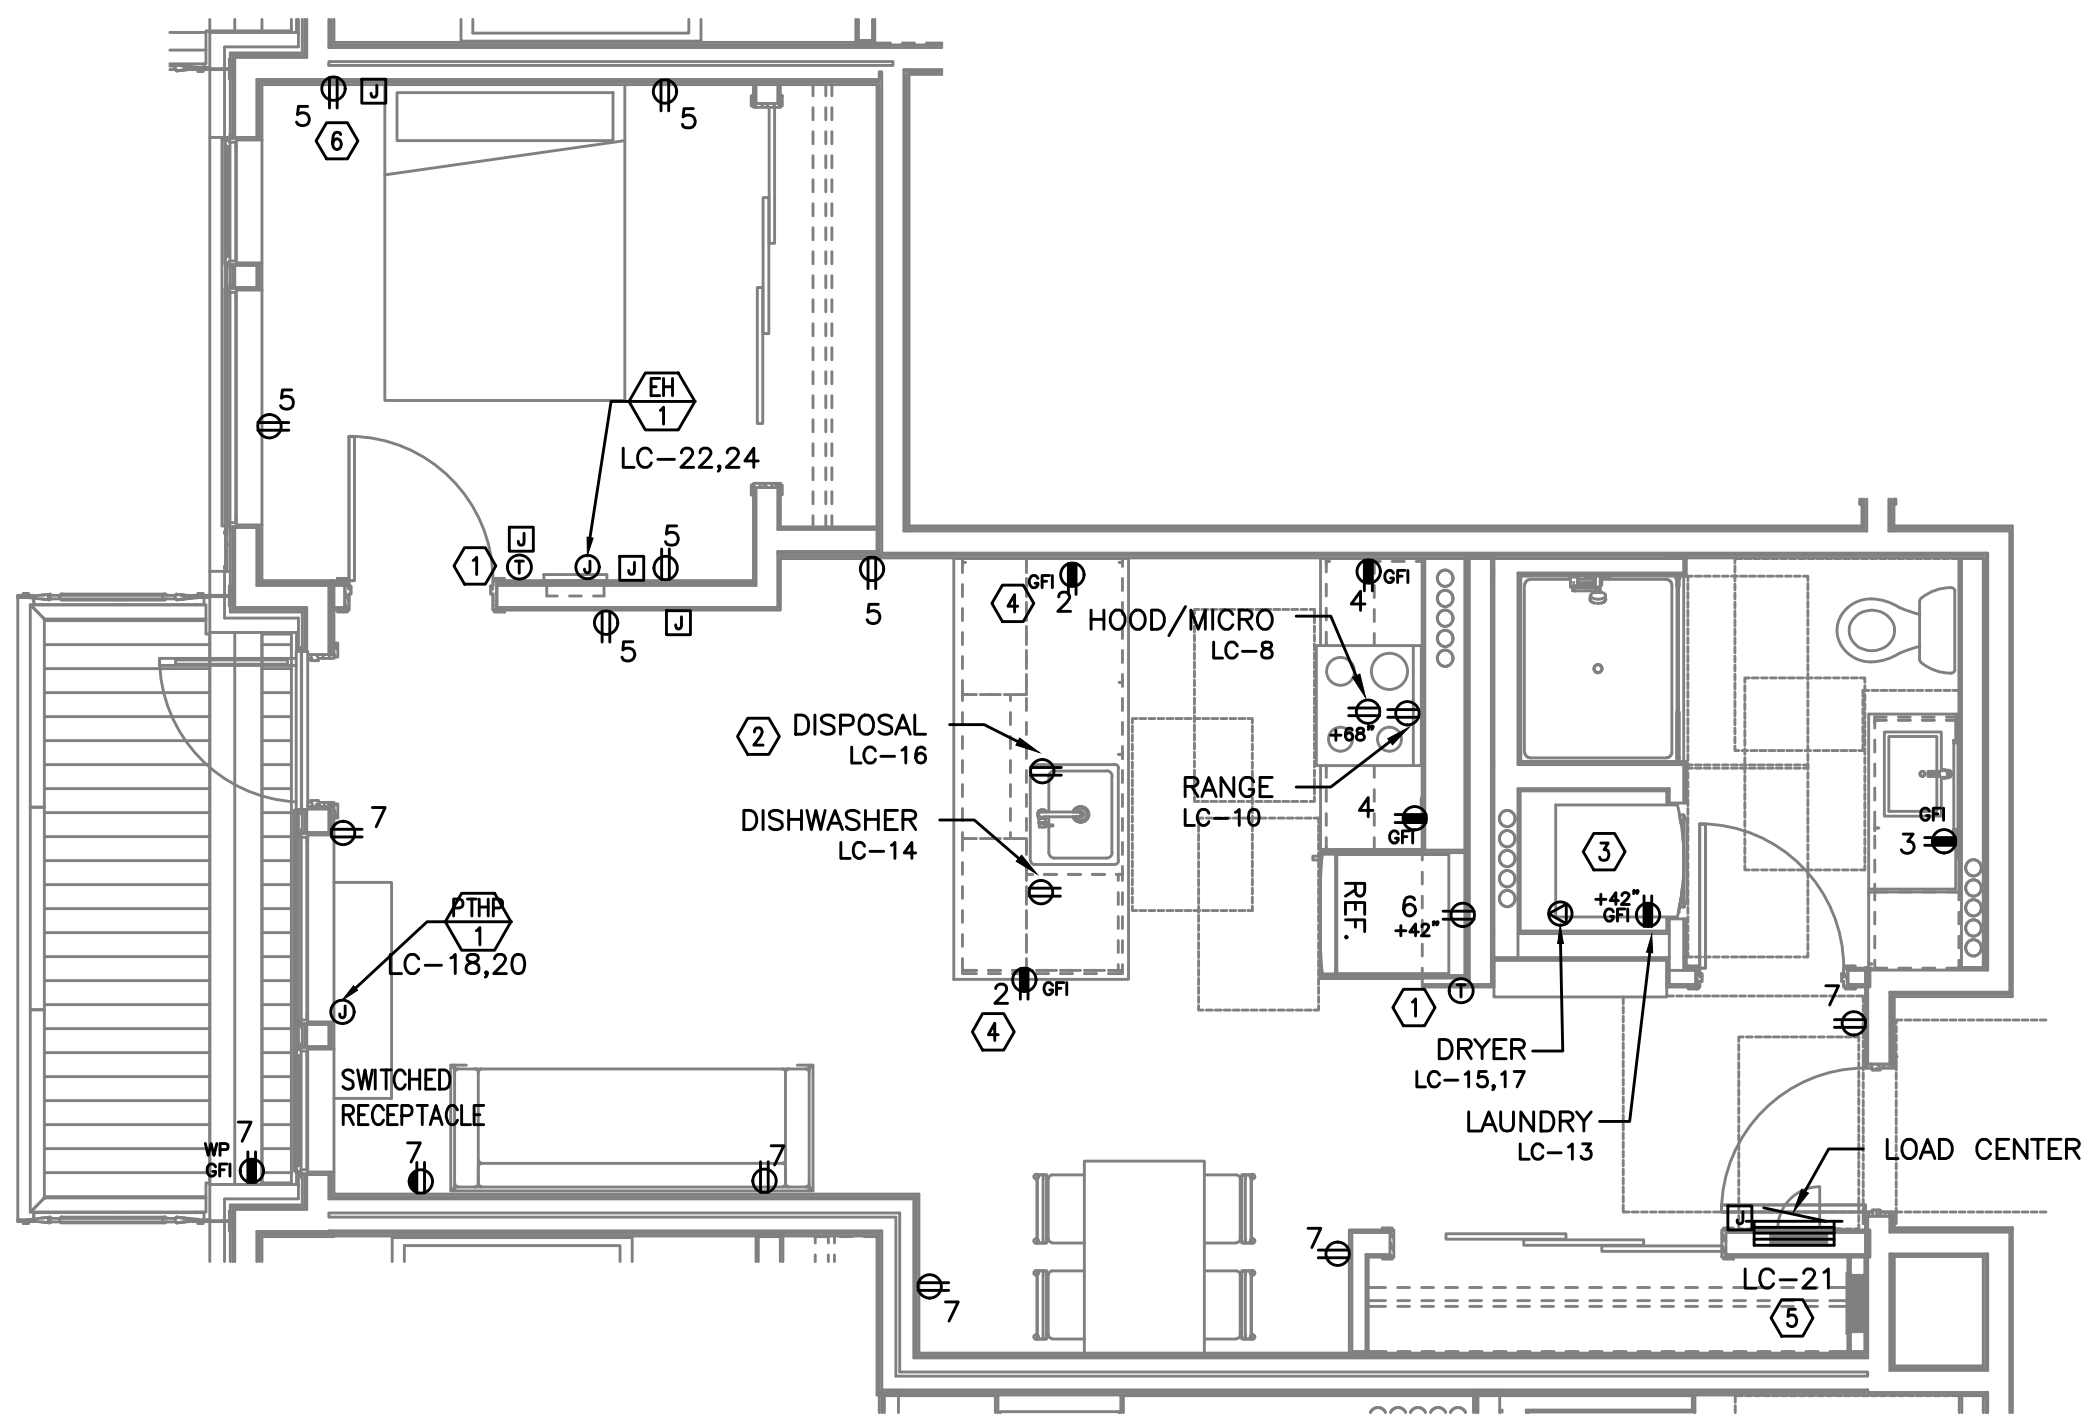
1 2 BED/2 BATH – POWER PLAN
E4.10 SCALE: 1/4" = 1'-0"

TYPICAL UNIT TYPE B

2 1 BED/1 BATH – POWER PLAN
E4.10 SCALE: 1/4" = 1'-0"

PRELIMINARY
NOT FOR
CONSTRUCTIONIN THE EVENT CONFLICTS ARE DISCOVERED
BETWEEN THE ORIGINAL SIGNED AND SEALED
DOCUMENTS PREPARED BY THE ARCHITECTS
AND/OR THEIR CONSULTANTS, AND ANY COPY OF
THE DOCUMENTS TRANSMITTED BY MAIL, FAX,
ELECTRONICALLY OR OTHERWISE, THE ORIGINAL
SIGNED AND SEALED DOCUMENTS SHALL GOVERN.PROJECT # 2017-053
DATE: 11/19/2021

REVISIONS

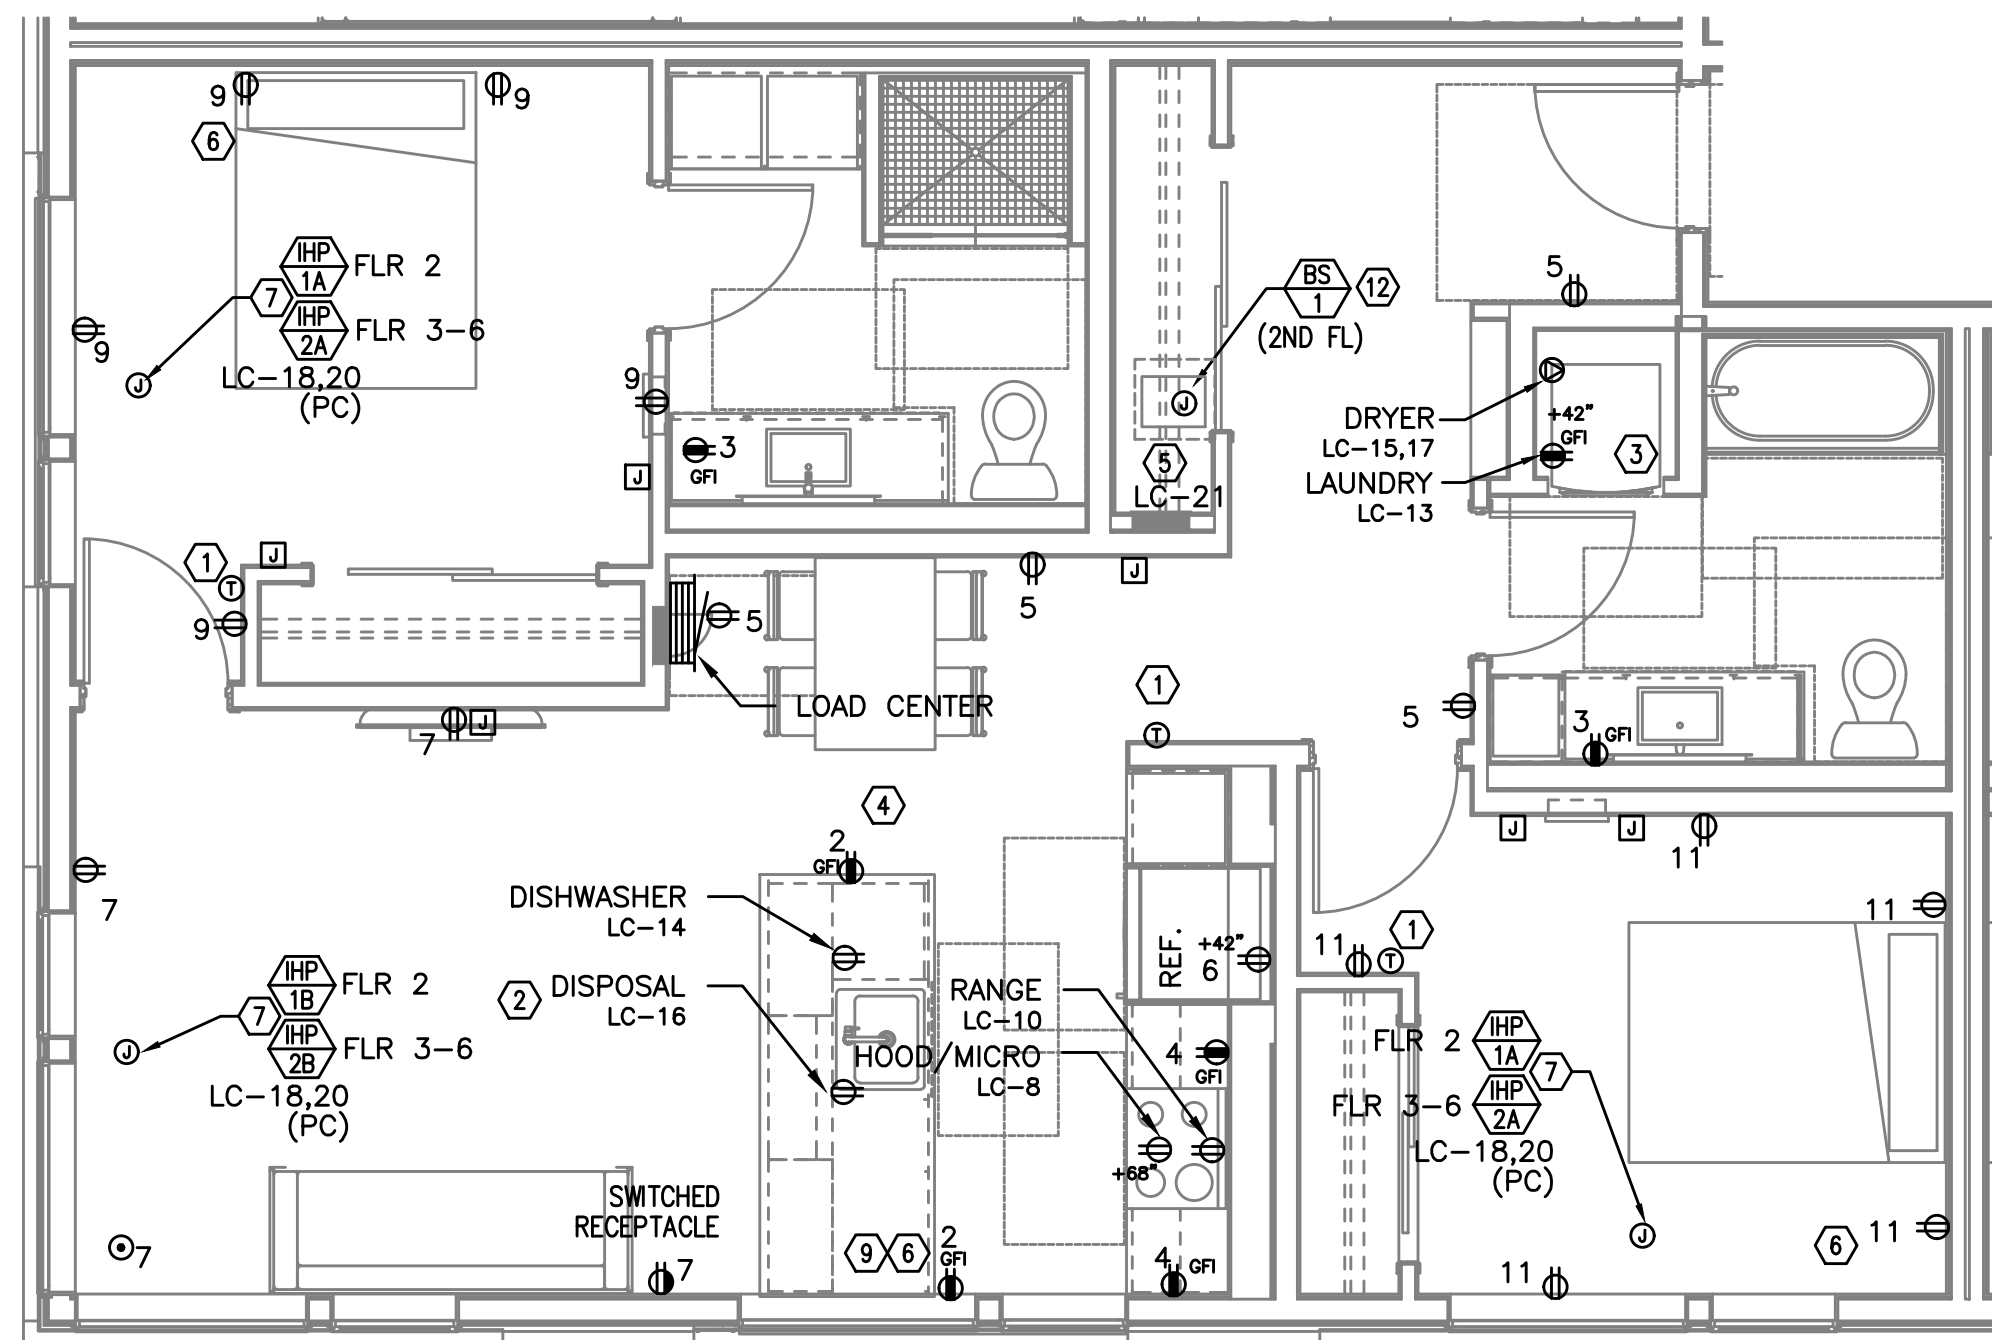


TYPICAL UNIT TYPE E

2 BED/1 BATH – POWER PLAN

1
E4.11

SCALE: 1/4" = 1'-0"

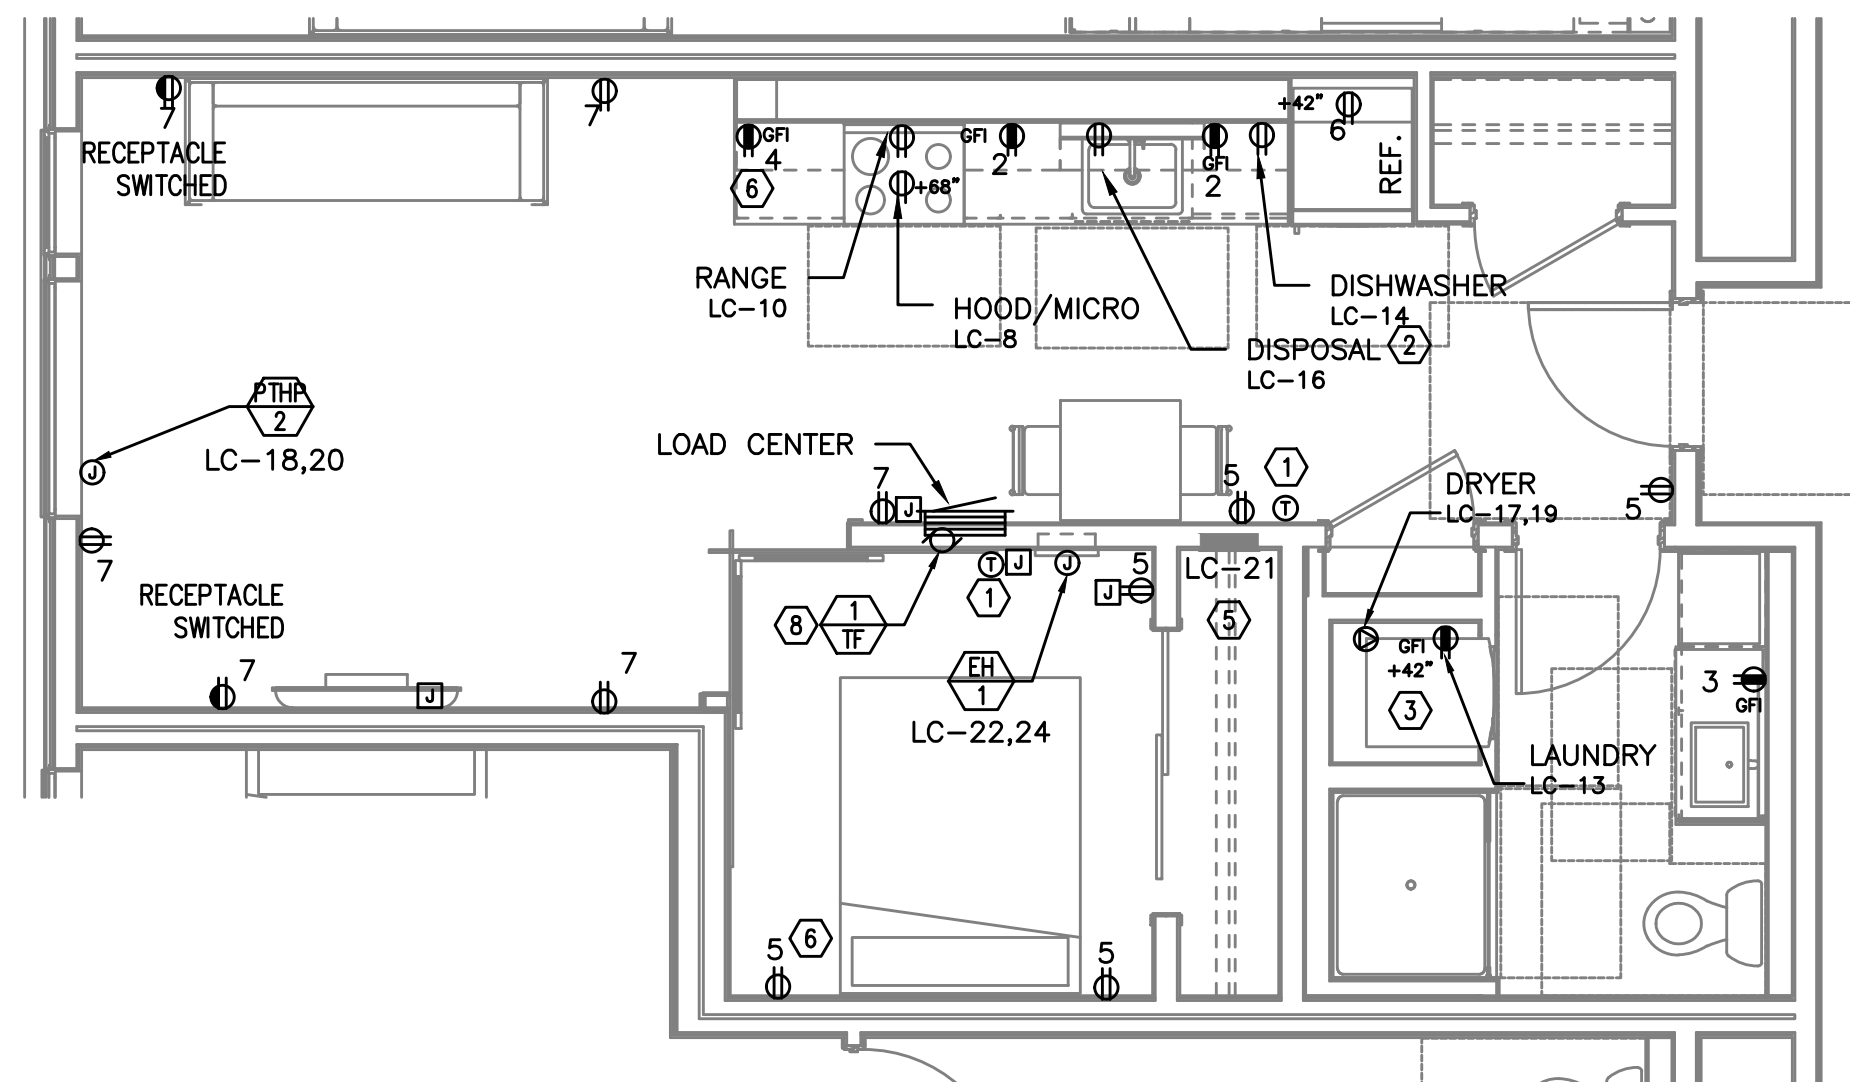


TYPICAL UNIT TYPE G

0 BED/1 BATH – POWER PLAN

2
E4.11

SCALE: 1/4" = 1'-0"

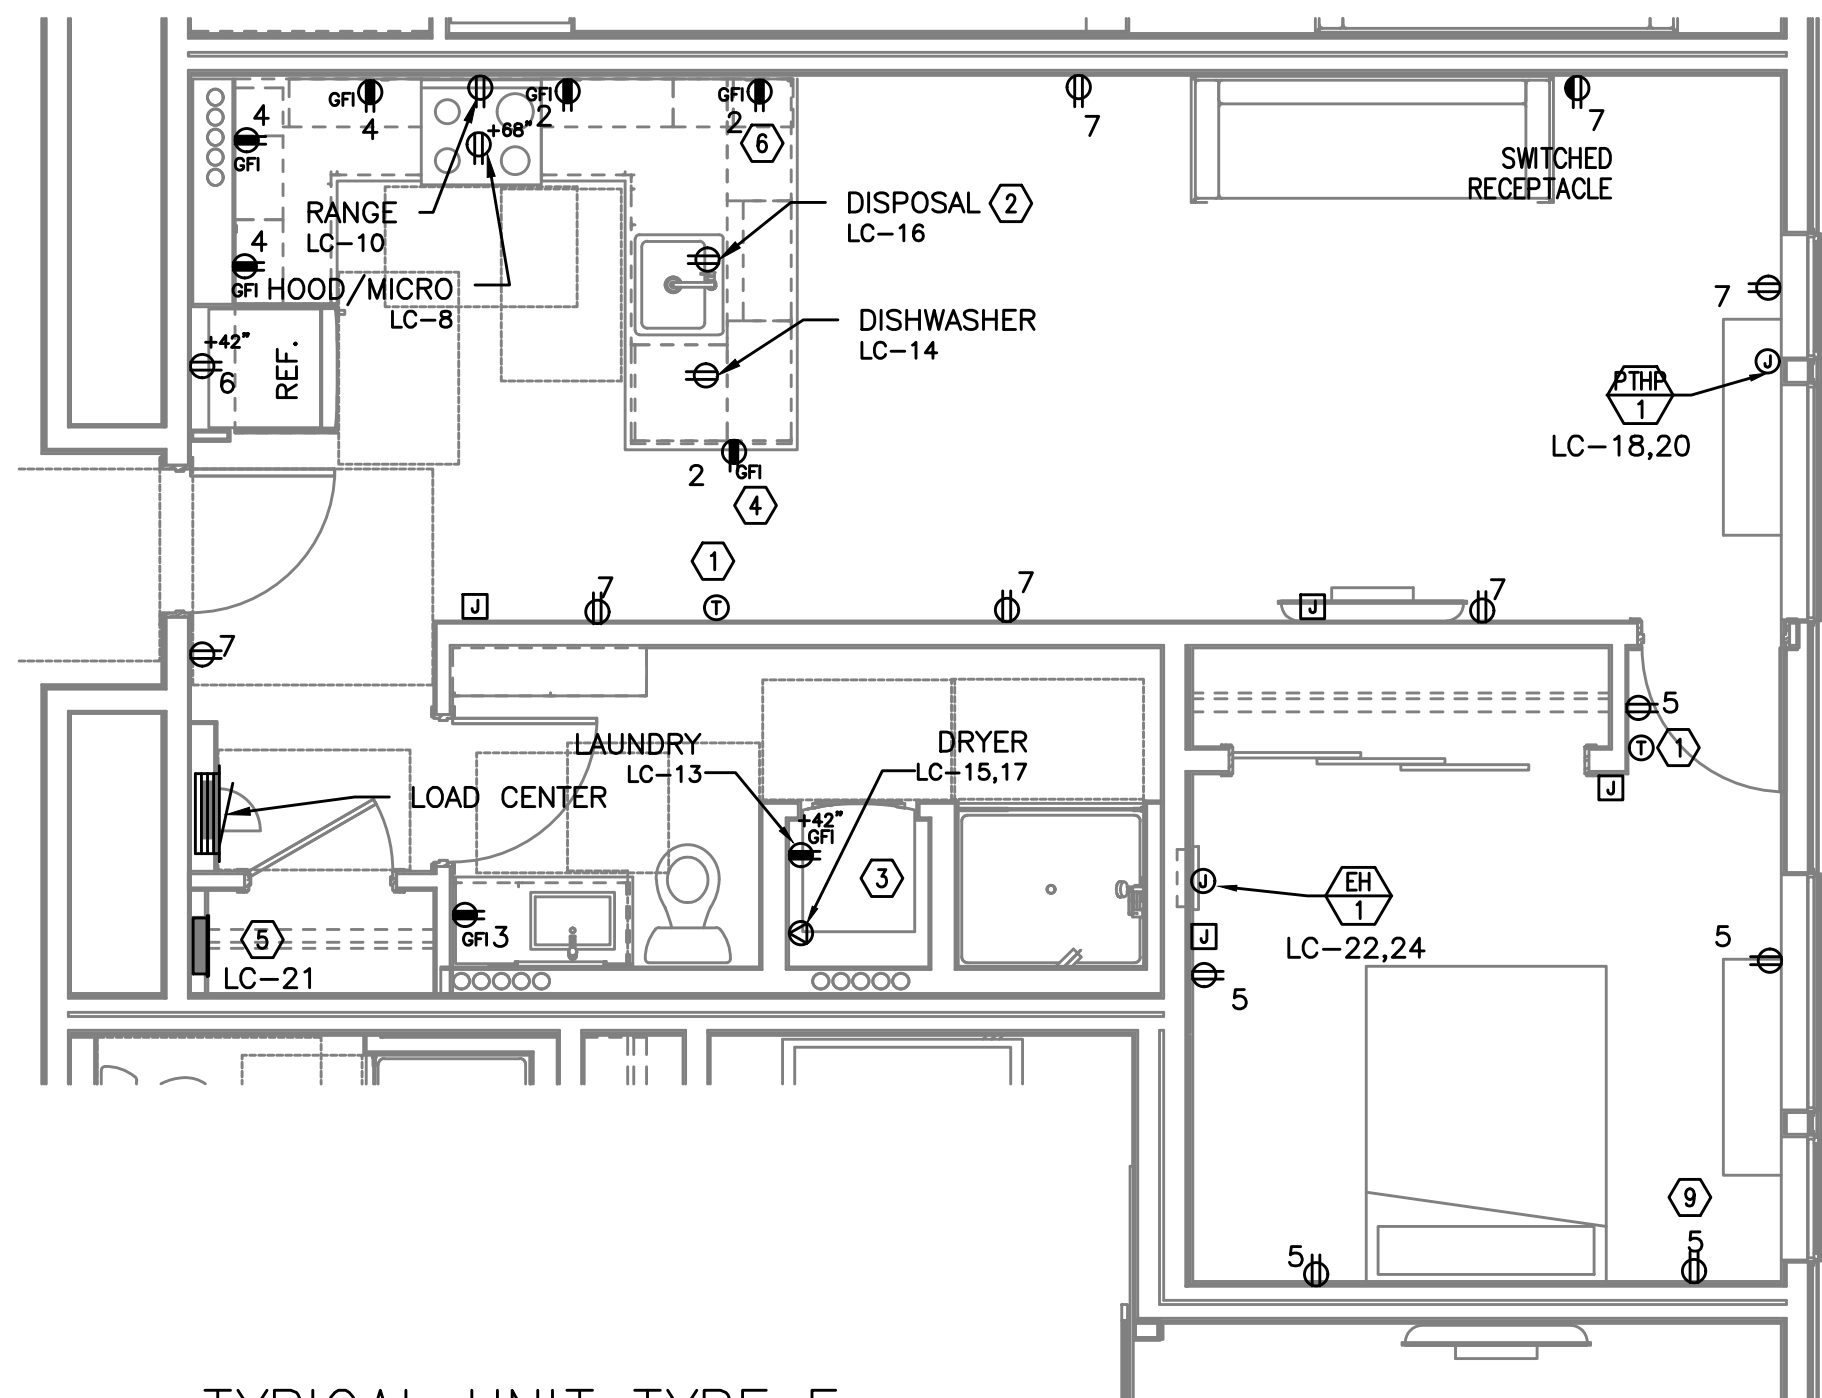


TYPICAL UNIT TYPE F

2 BED/1 BATH – POWER PLAN

3
E4.11

SCALE: 1/4" = 1'-0"

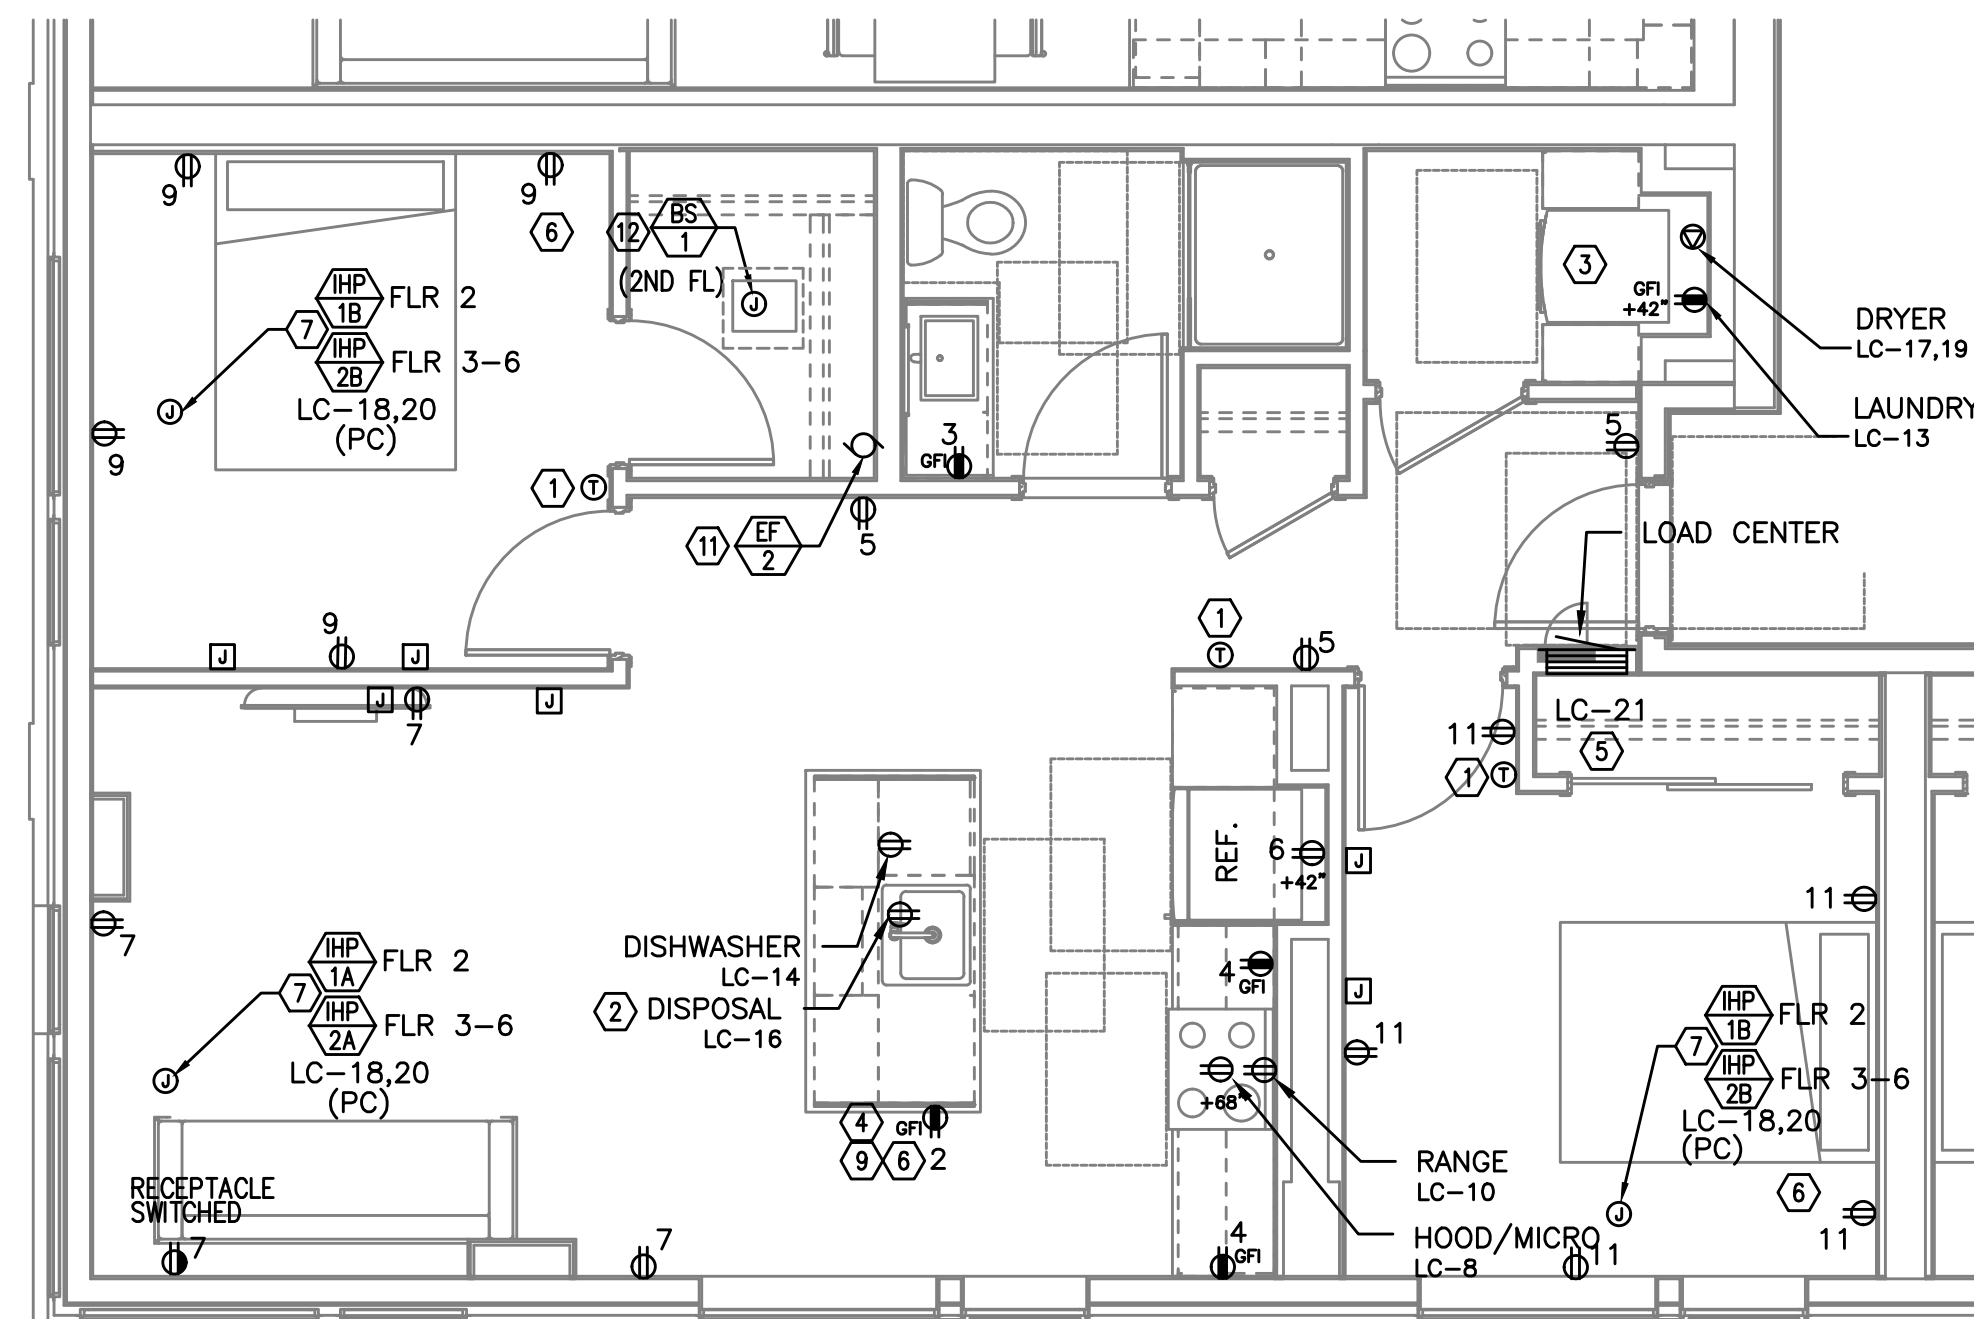

TYPICAL UNIT TYPE K

2 BED/1 BATH – POWER PLAN

4
E4.11

SCALE: 1/4" = 1'-0"

NOTE:

REFER TO SHEET E4.11 FOR GENERAL AND KEYED POWER NOTES.

M Consulting Engineers
F 2007 S.E. Ash St.
E Portland, OR 97214
A PHN: (503) 234-0548
I FAX: (503) 234-0677
INC. WWW.MFIA-ENG.COM
 CONTACT: DENISE TAYLOR

AEGIS - PHASE II
MIXED-USE DEVELOPMENT
 312 E EVERGREEN BOULEVARD, VANCOUVER, WA 98660

SHEET:

E4.11


PRELIMINARY
NOT FOR
CONSTRUCTIONIN THE EVENT CONFLICTS ARE DISCOVERED
BETWEEN THE ORIGINAL SIGNED AND SEALED
DOCUMENTS PREPARED BY THE ARCHITECTS
AND/OR THEIR CONSULTANTS, AND ANY COPY OF
THE DOCUMENTS TRANSMITTED BY MAIL, FAX,
ELECTRONICALLY OR OTHERWISE, THE ORIGINAL
SIGNED AND SEALED DOCUMENTS SHALL GOVERN.PROJECT # 2017-053
DATE: 11/19/2021

REVISIONS


AEGIS - PHASE II
MIXED-USE DEVELOPMENT
312 E EVERGREEN BOULEVARD, VANCOUVER, WA 98660

SHEET:


E4.12

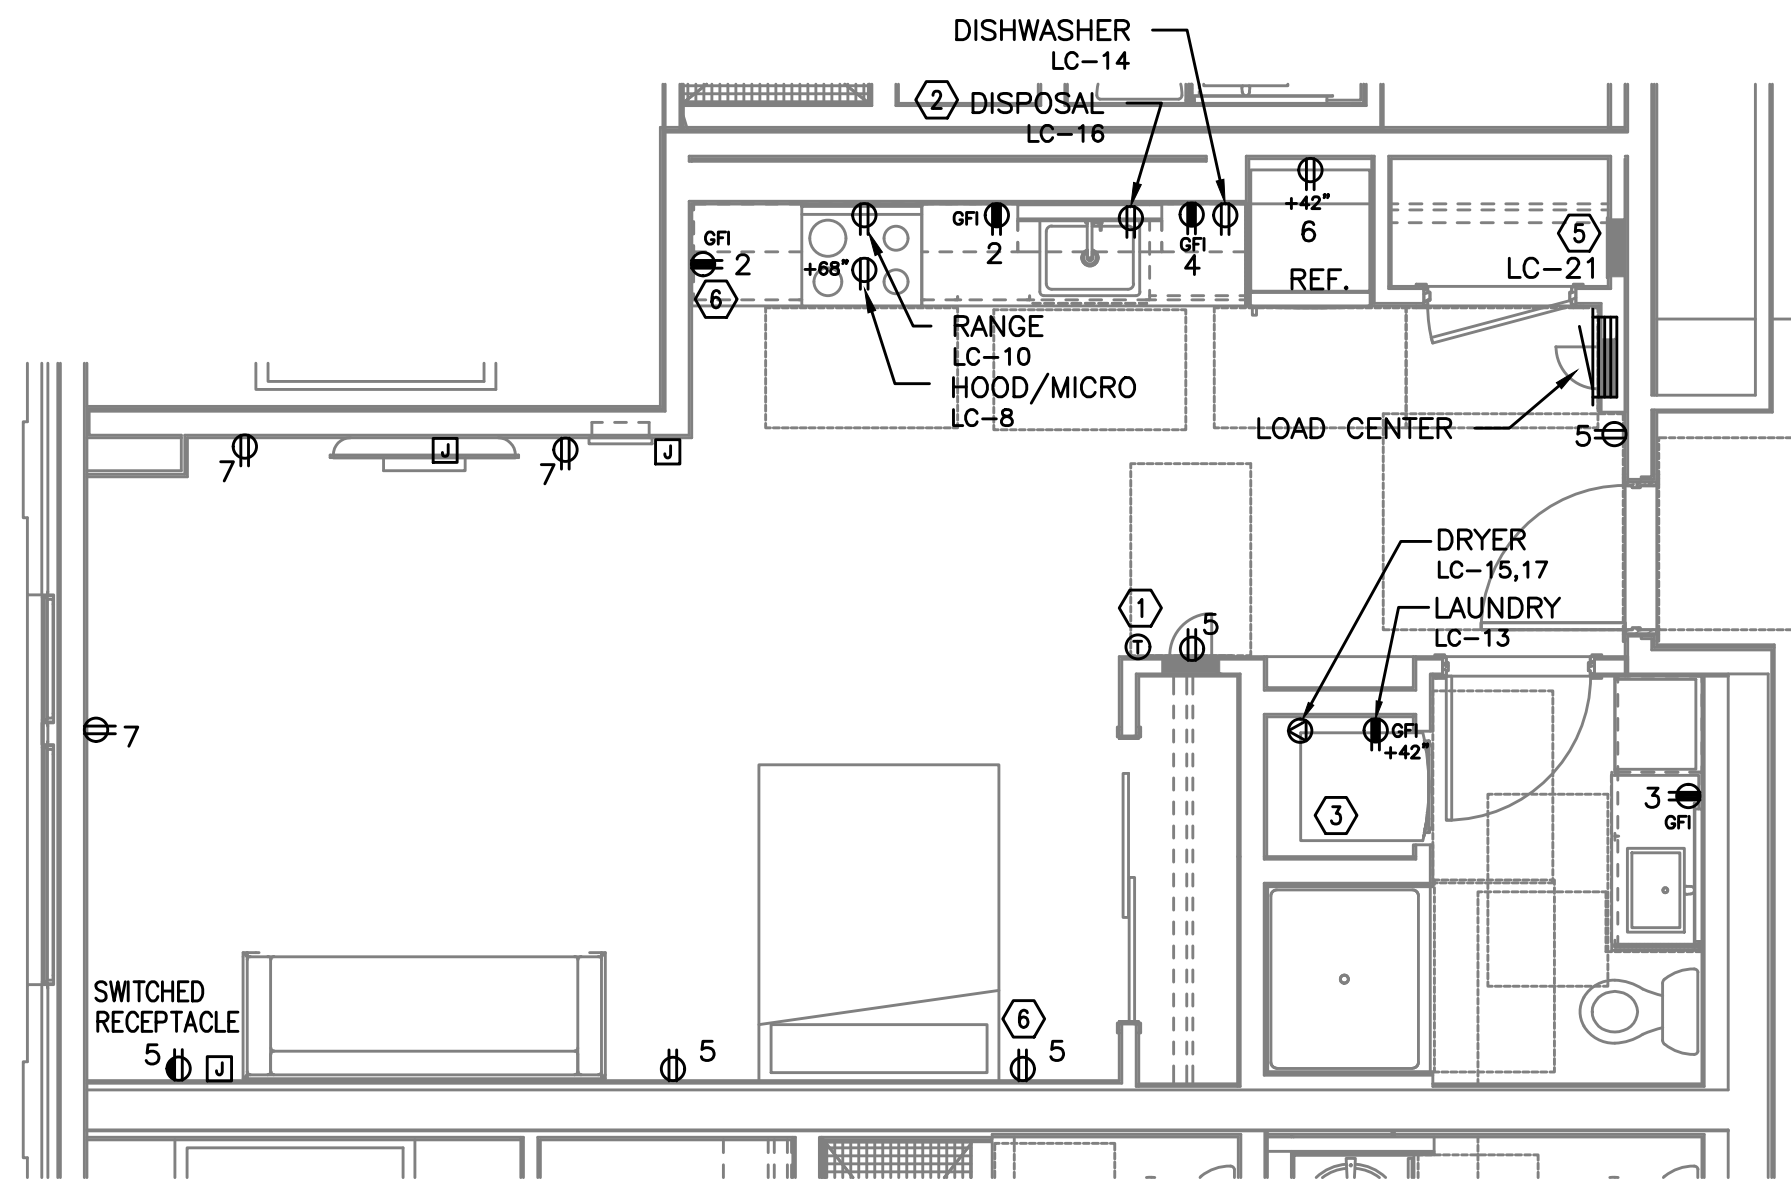

TYPICAL UNIT TYPE L

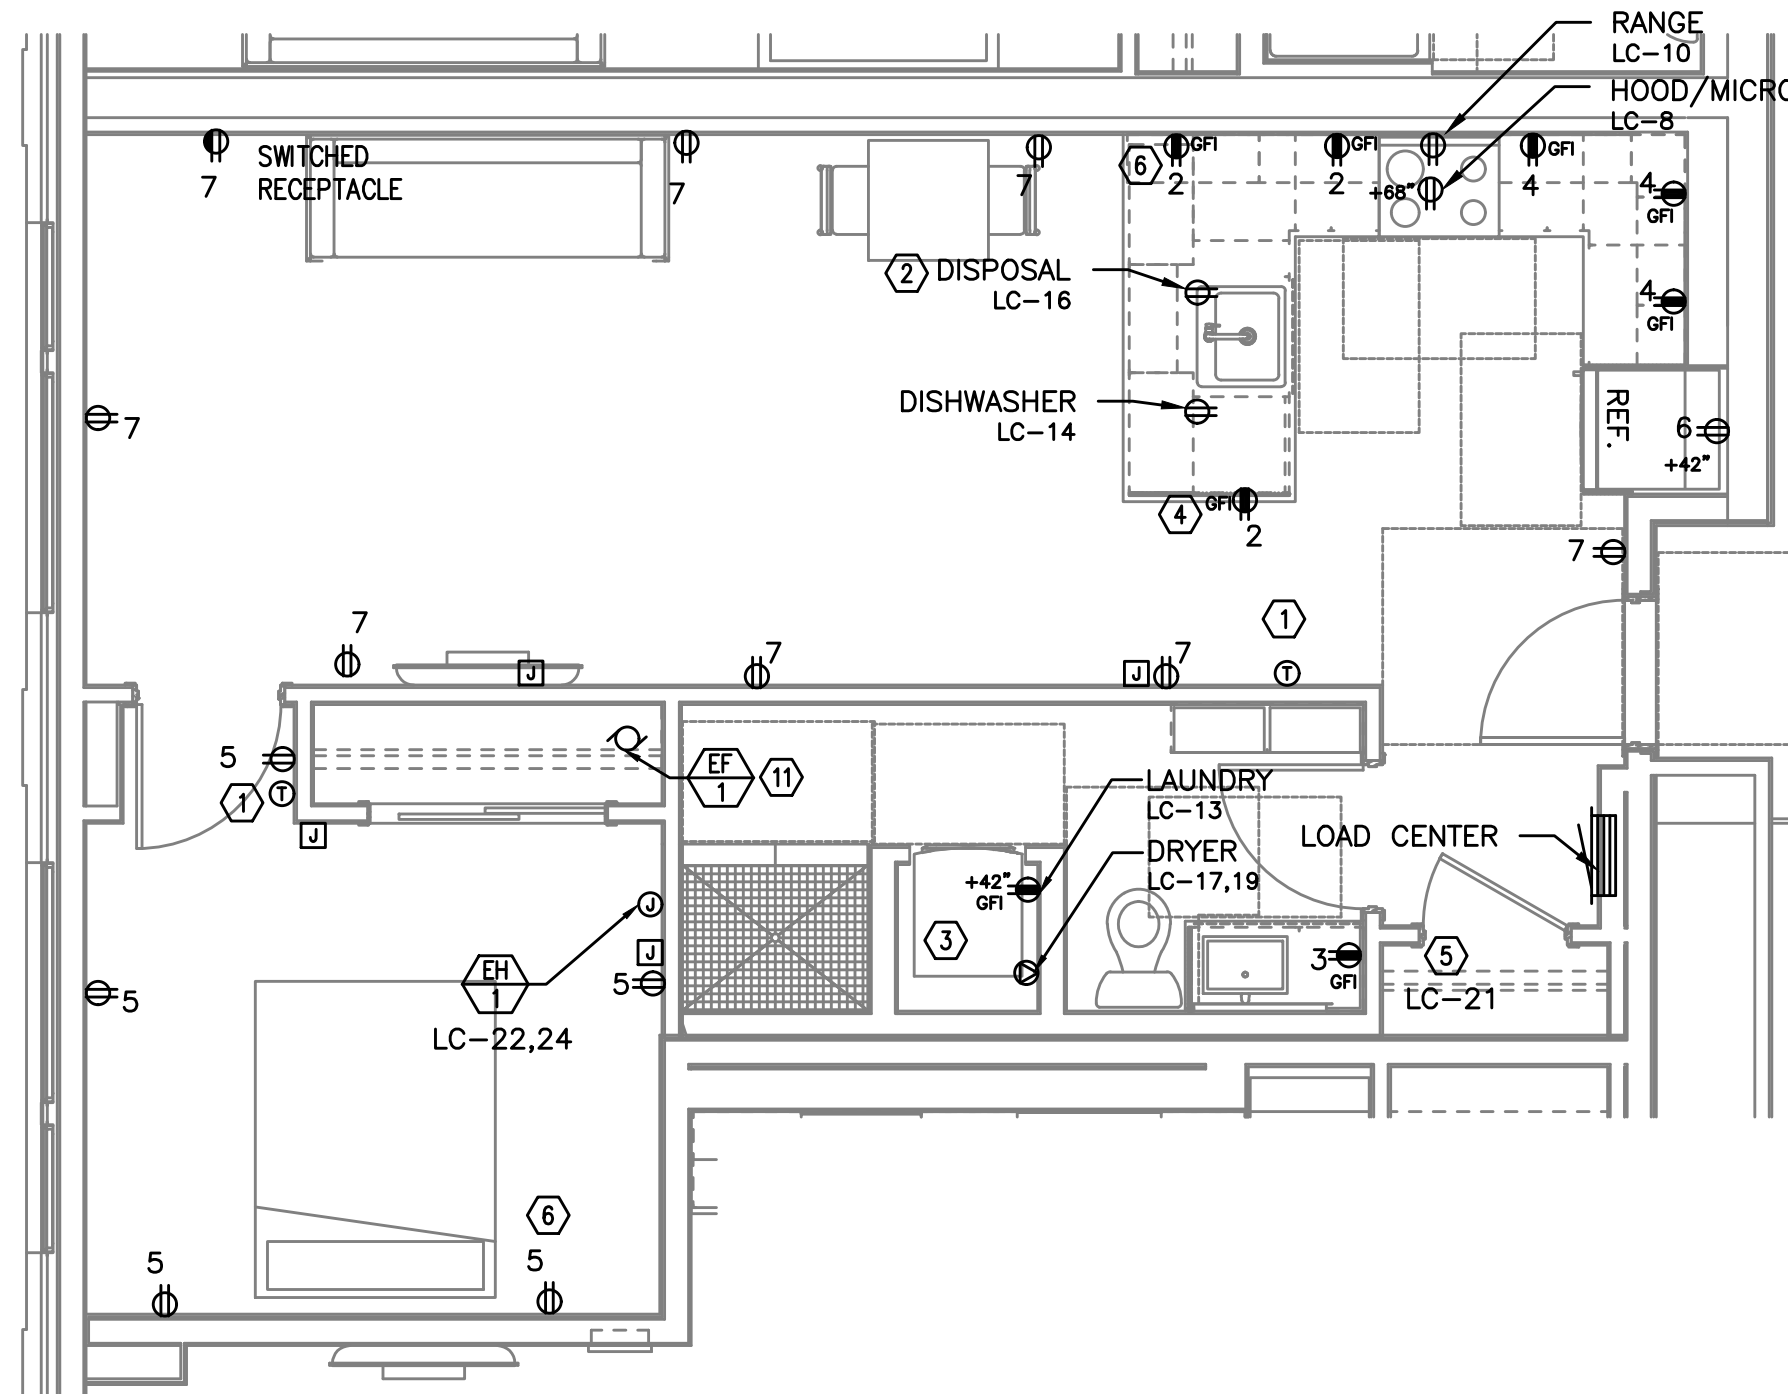1 0 BED/1 BATH - POWER PLAN
E4.12 SCALE: 1/4" = 1'-0"

TYPICAL UNIT TYPE M

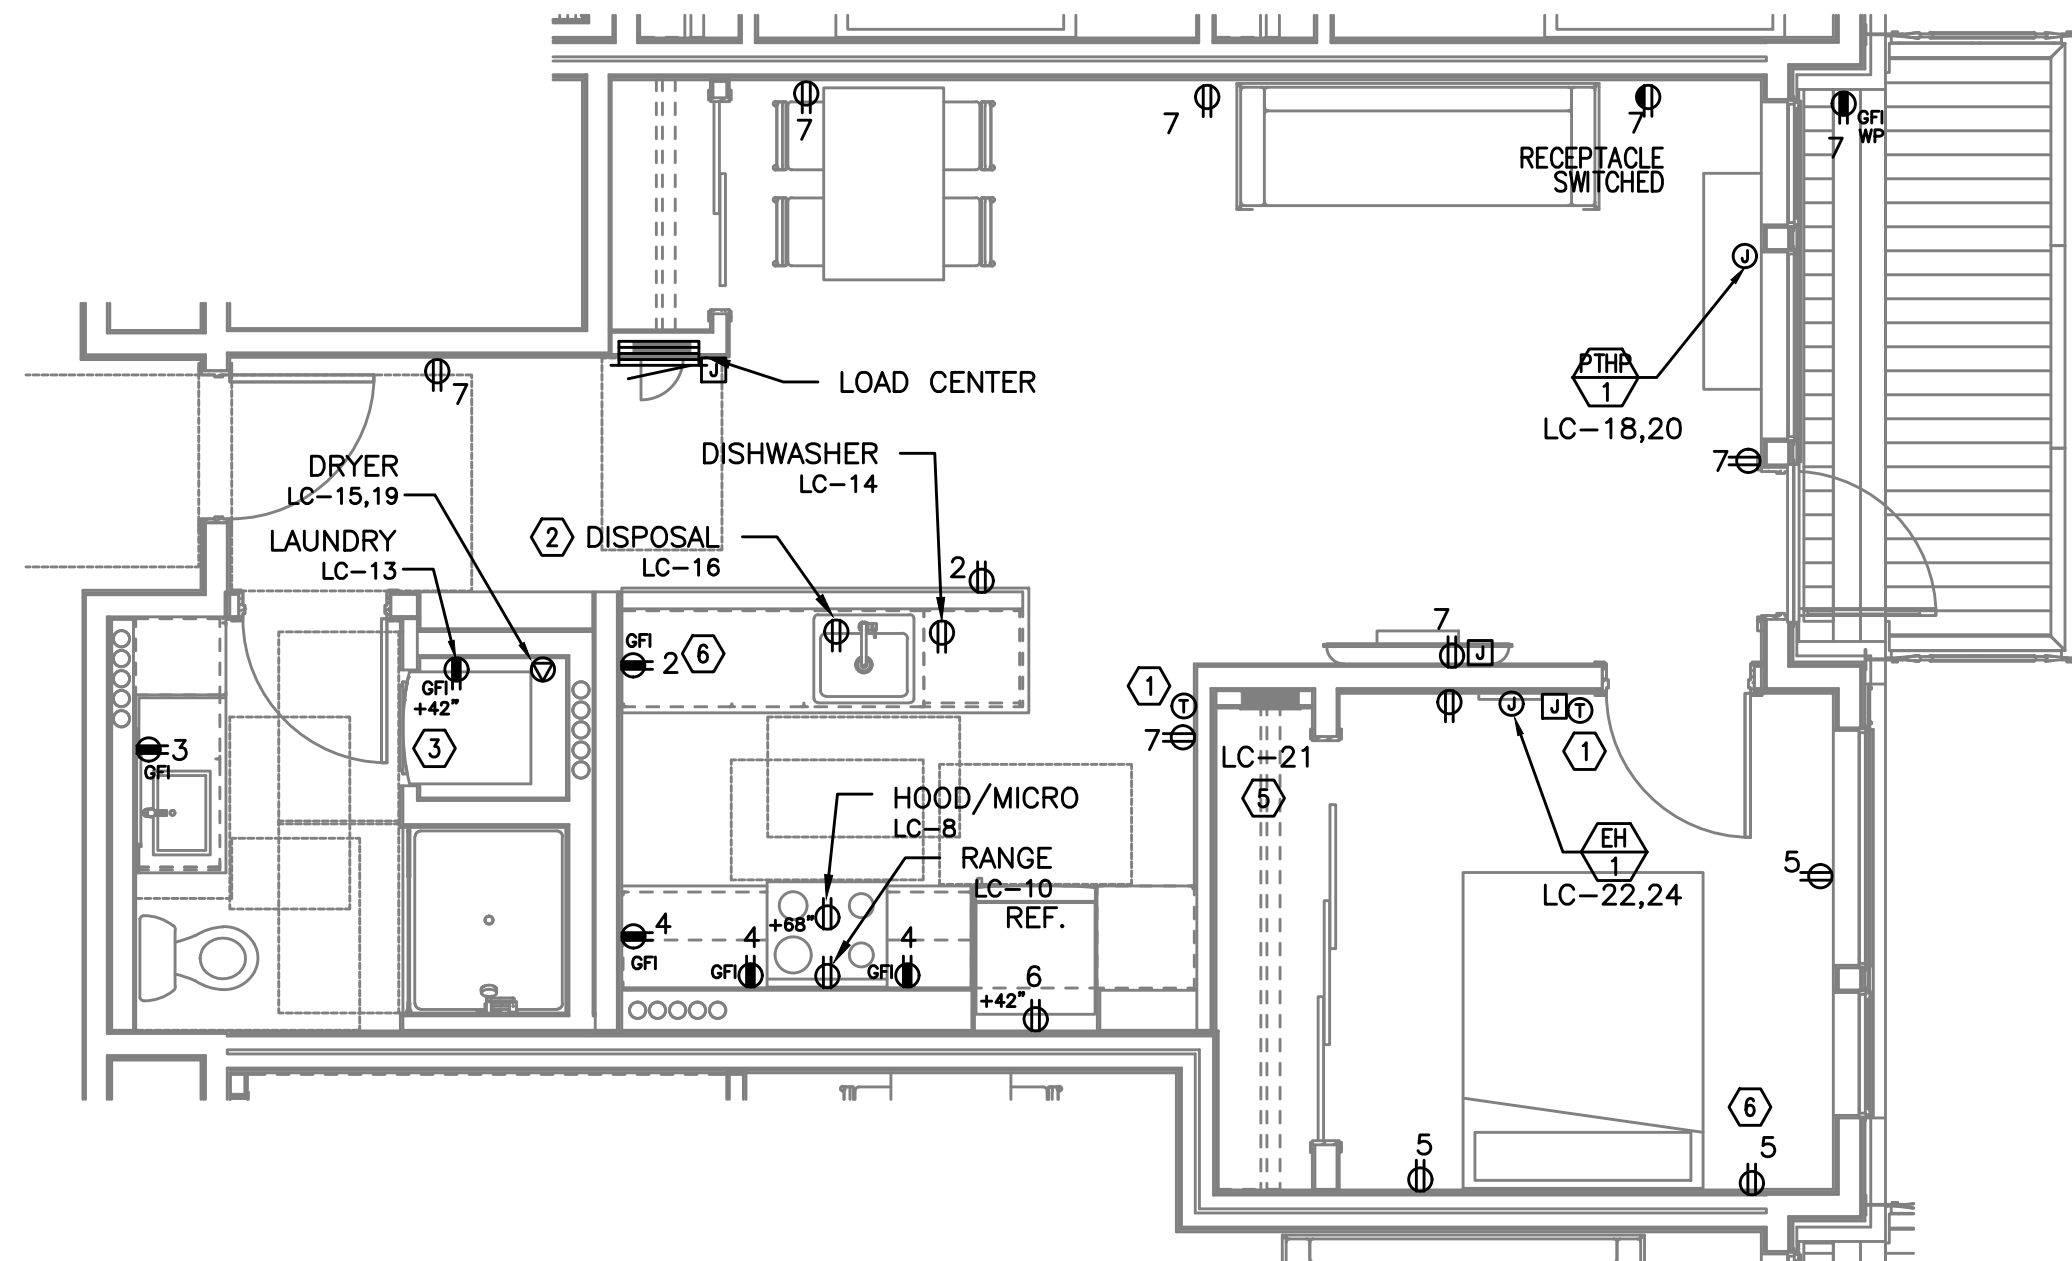2 1 BED/1 BATH - POWER PLAN
E4.12 SCALE: 1/4" = 1'-0"

TYPICAL UNIT TYPE N

3 1 BED/1 BATH - POWER PLAN
E4.12 SCALE: 1/4" = 1'-0"


NOTE:

REFER TO SHEET E4.11 FOR GENERAL AND KEYED POWER NOTES.

M
F
A
INC. Consulting Engineers
2007 S.E. Ash St.
Portland, OR 97214
PHN: (503) 234-0548
FAX: (503) 234-0677
WWW.MFIA-ENG.COM
CONTACT: DENISE TAYLOR

PRELIMINARY
NOT FOR
CONSTRUCTIONIN THE EVENT CONFLICTS ARE DISCOVERED
BETWEEN THE ORIGINAL SIGNED AND SEALED
DOCUMENTS PREPARED BY THE ARCHITECTS
AND/OR THEIR CONSULTANTS, AND ANY COPY OF
THE DOCUMENTS TRANSMITTED BY MAIL, FAX,
ELECTRONICALLY OR OTHERWISE, THE ORIGINAL
SIGNED AND SEALED DOCUMENTS SHALL GOVERN.PROJECT # 2017-053
DATE: 11/19/2021


REVISIONS

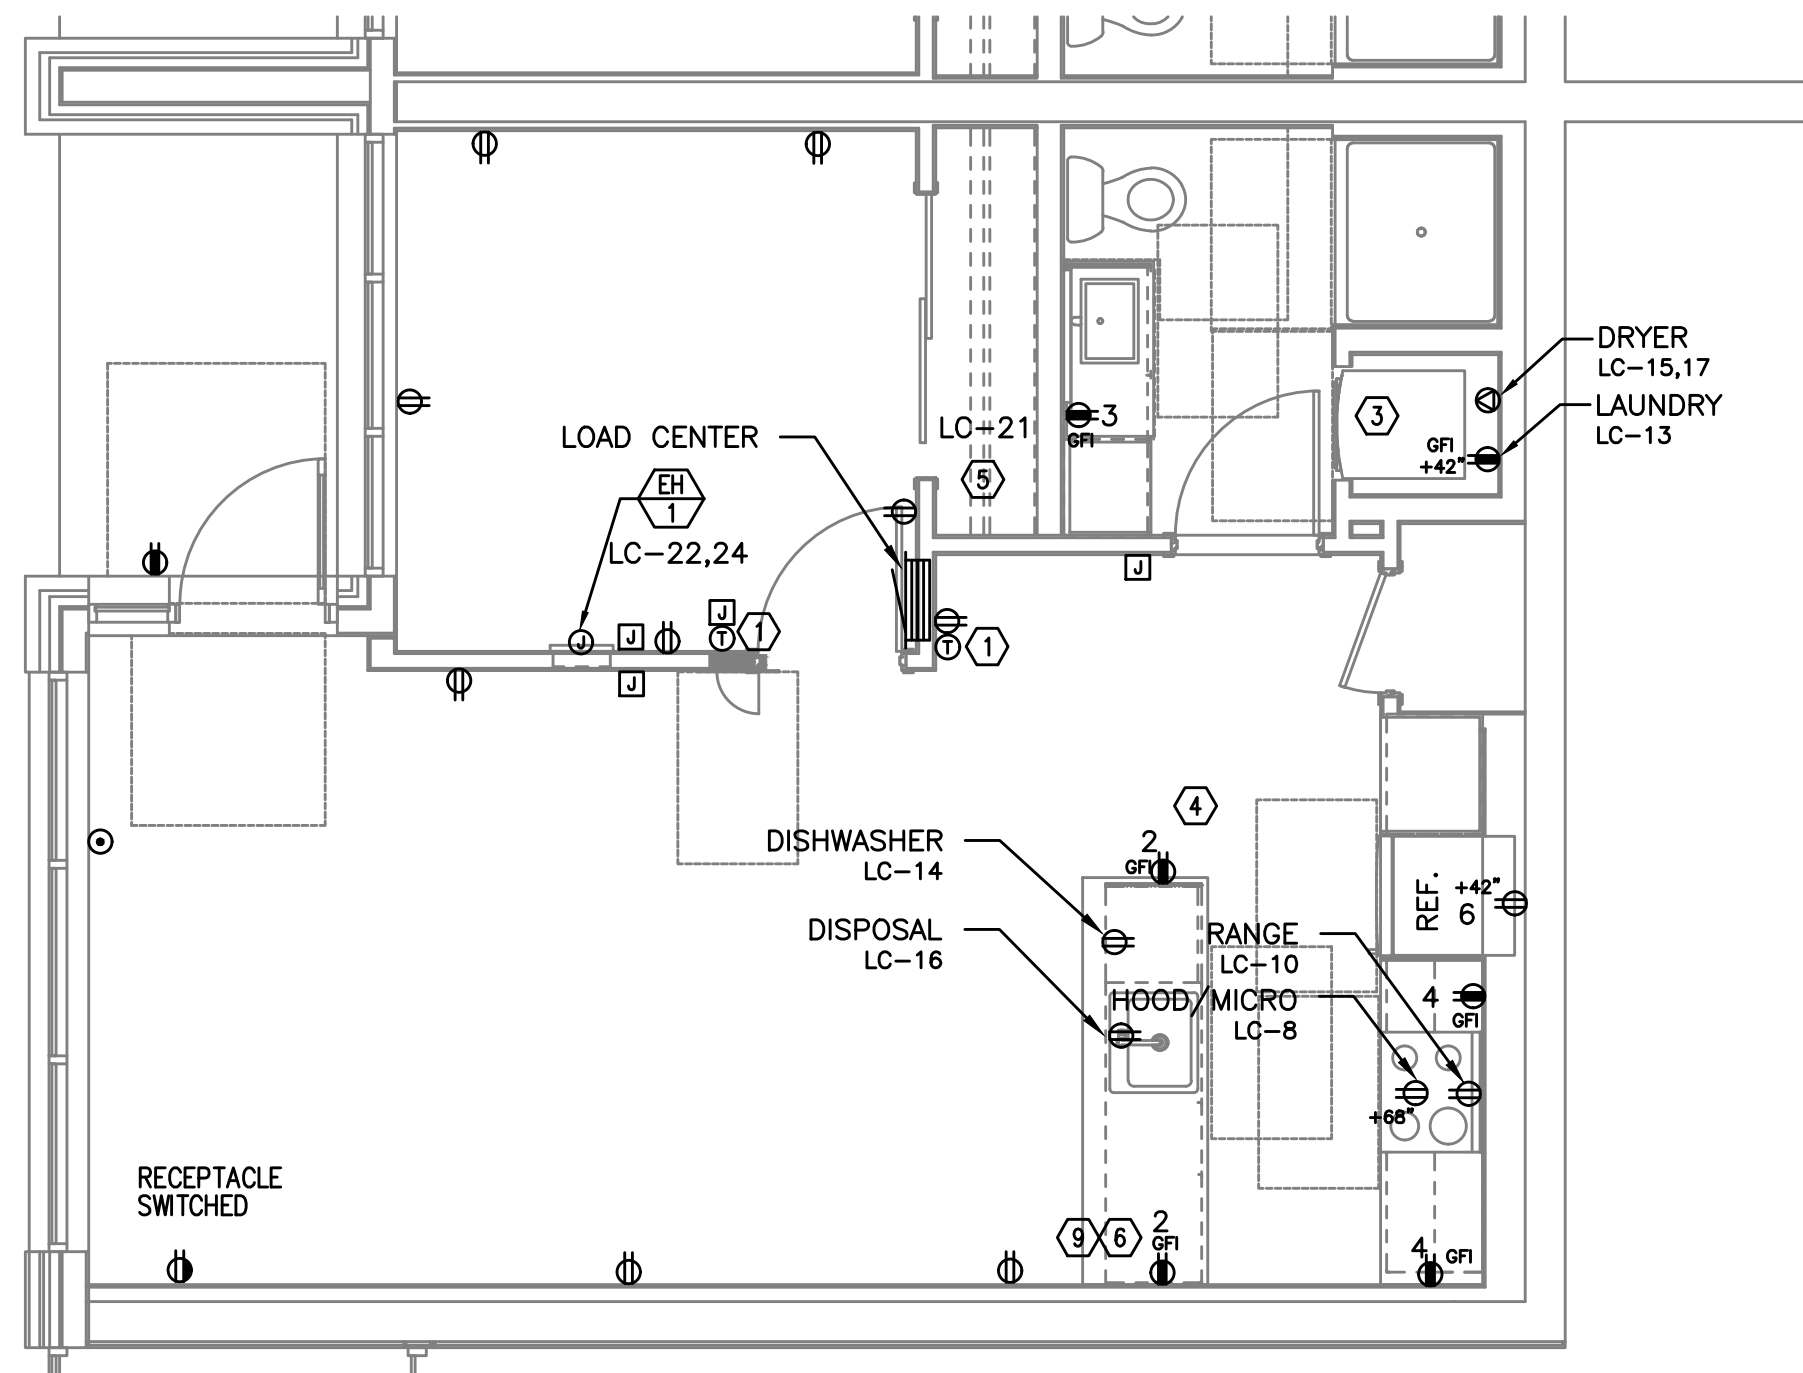AEGIS - PHASE II
MIXED-USE DEVELOPMENT
312 E EVERGREEN BOULEVARD, VANCOUVER, WA 98660

TYPICAL UNIT TYPE Q

1 1 BED/1 BATH - POWER PLAN


E4.13 SCALE: 1/4" = 1'-0"

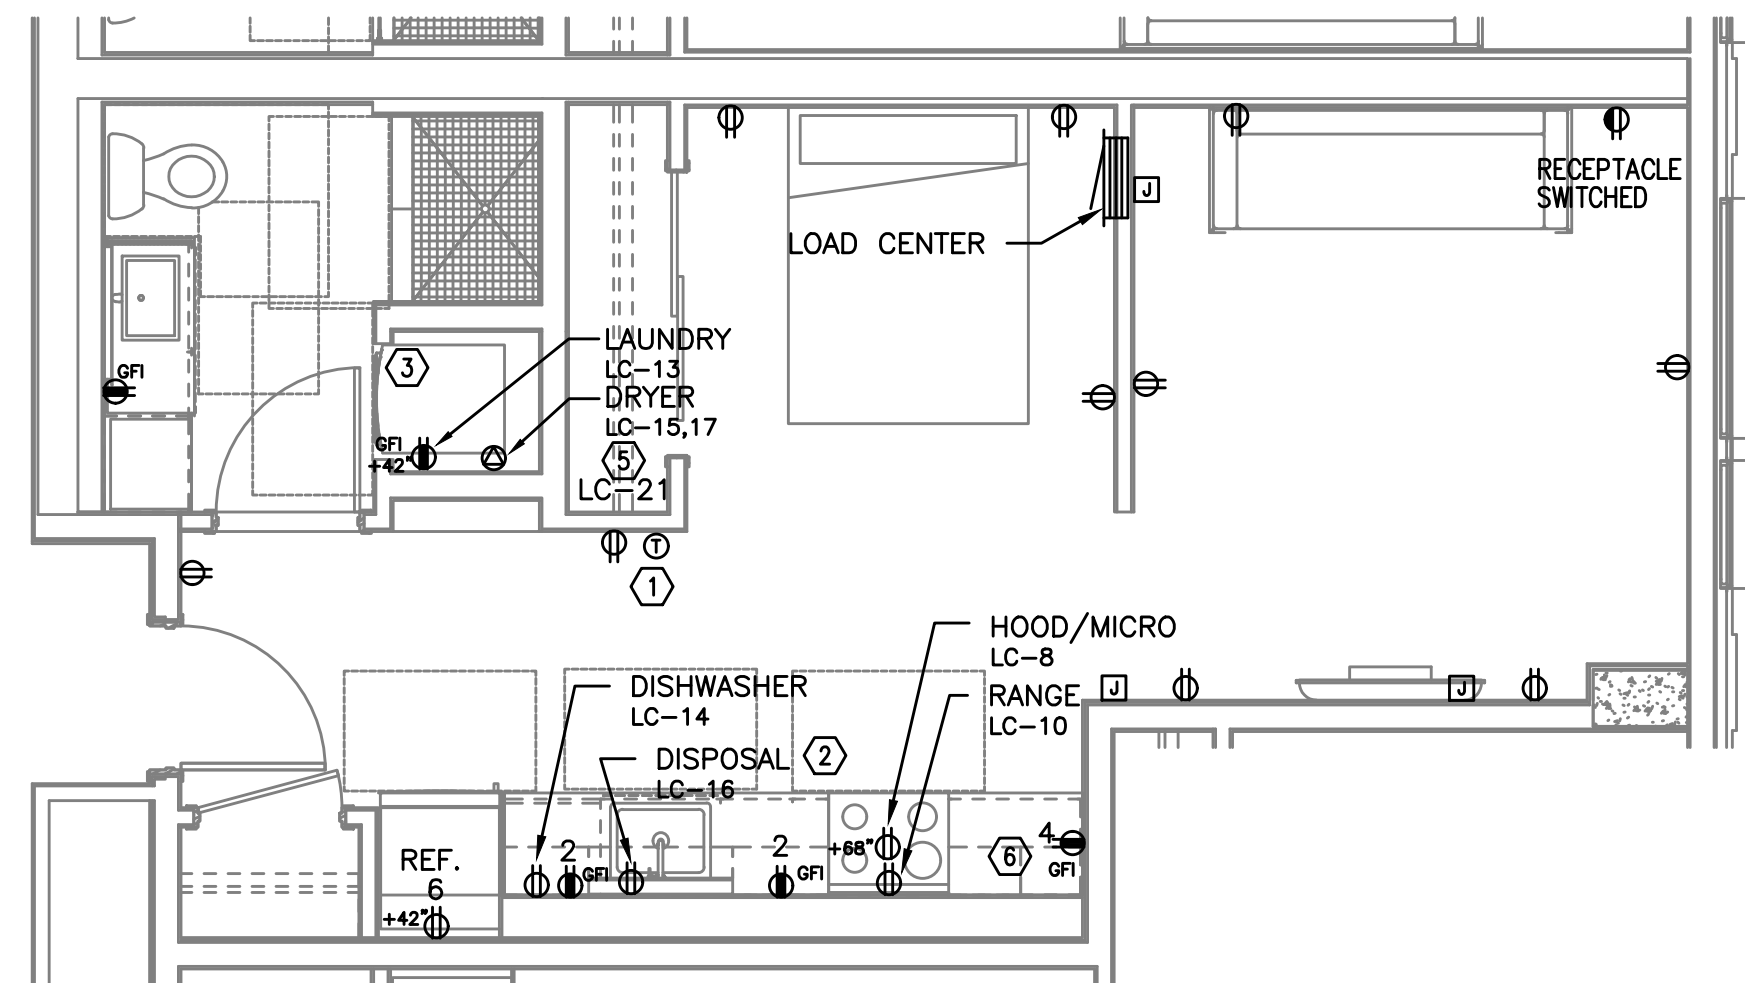

TYPICAL UNIT TYPE S

3 0 BED/1 BATH - POWER PLAN


E4.13 SCALE: 1/4" = 1'-0"

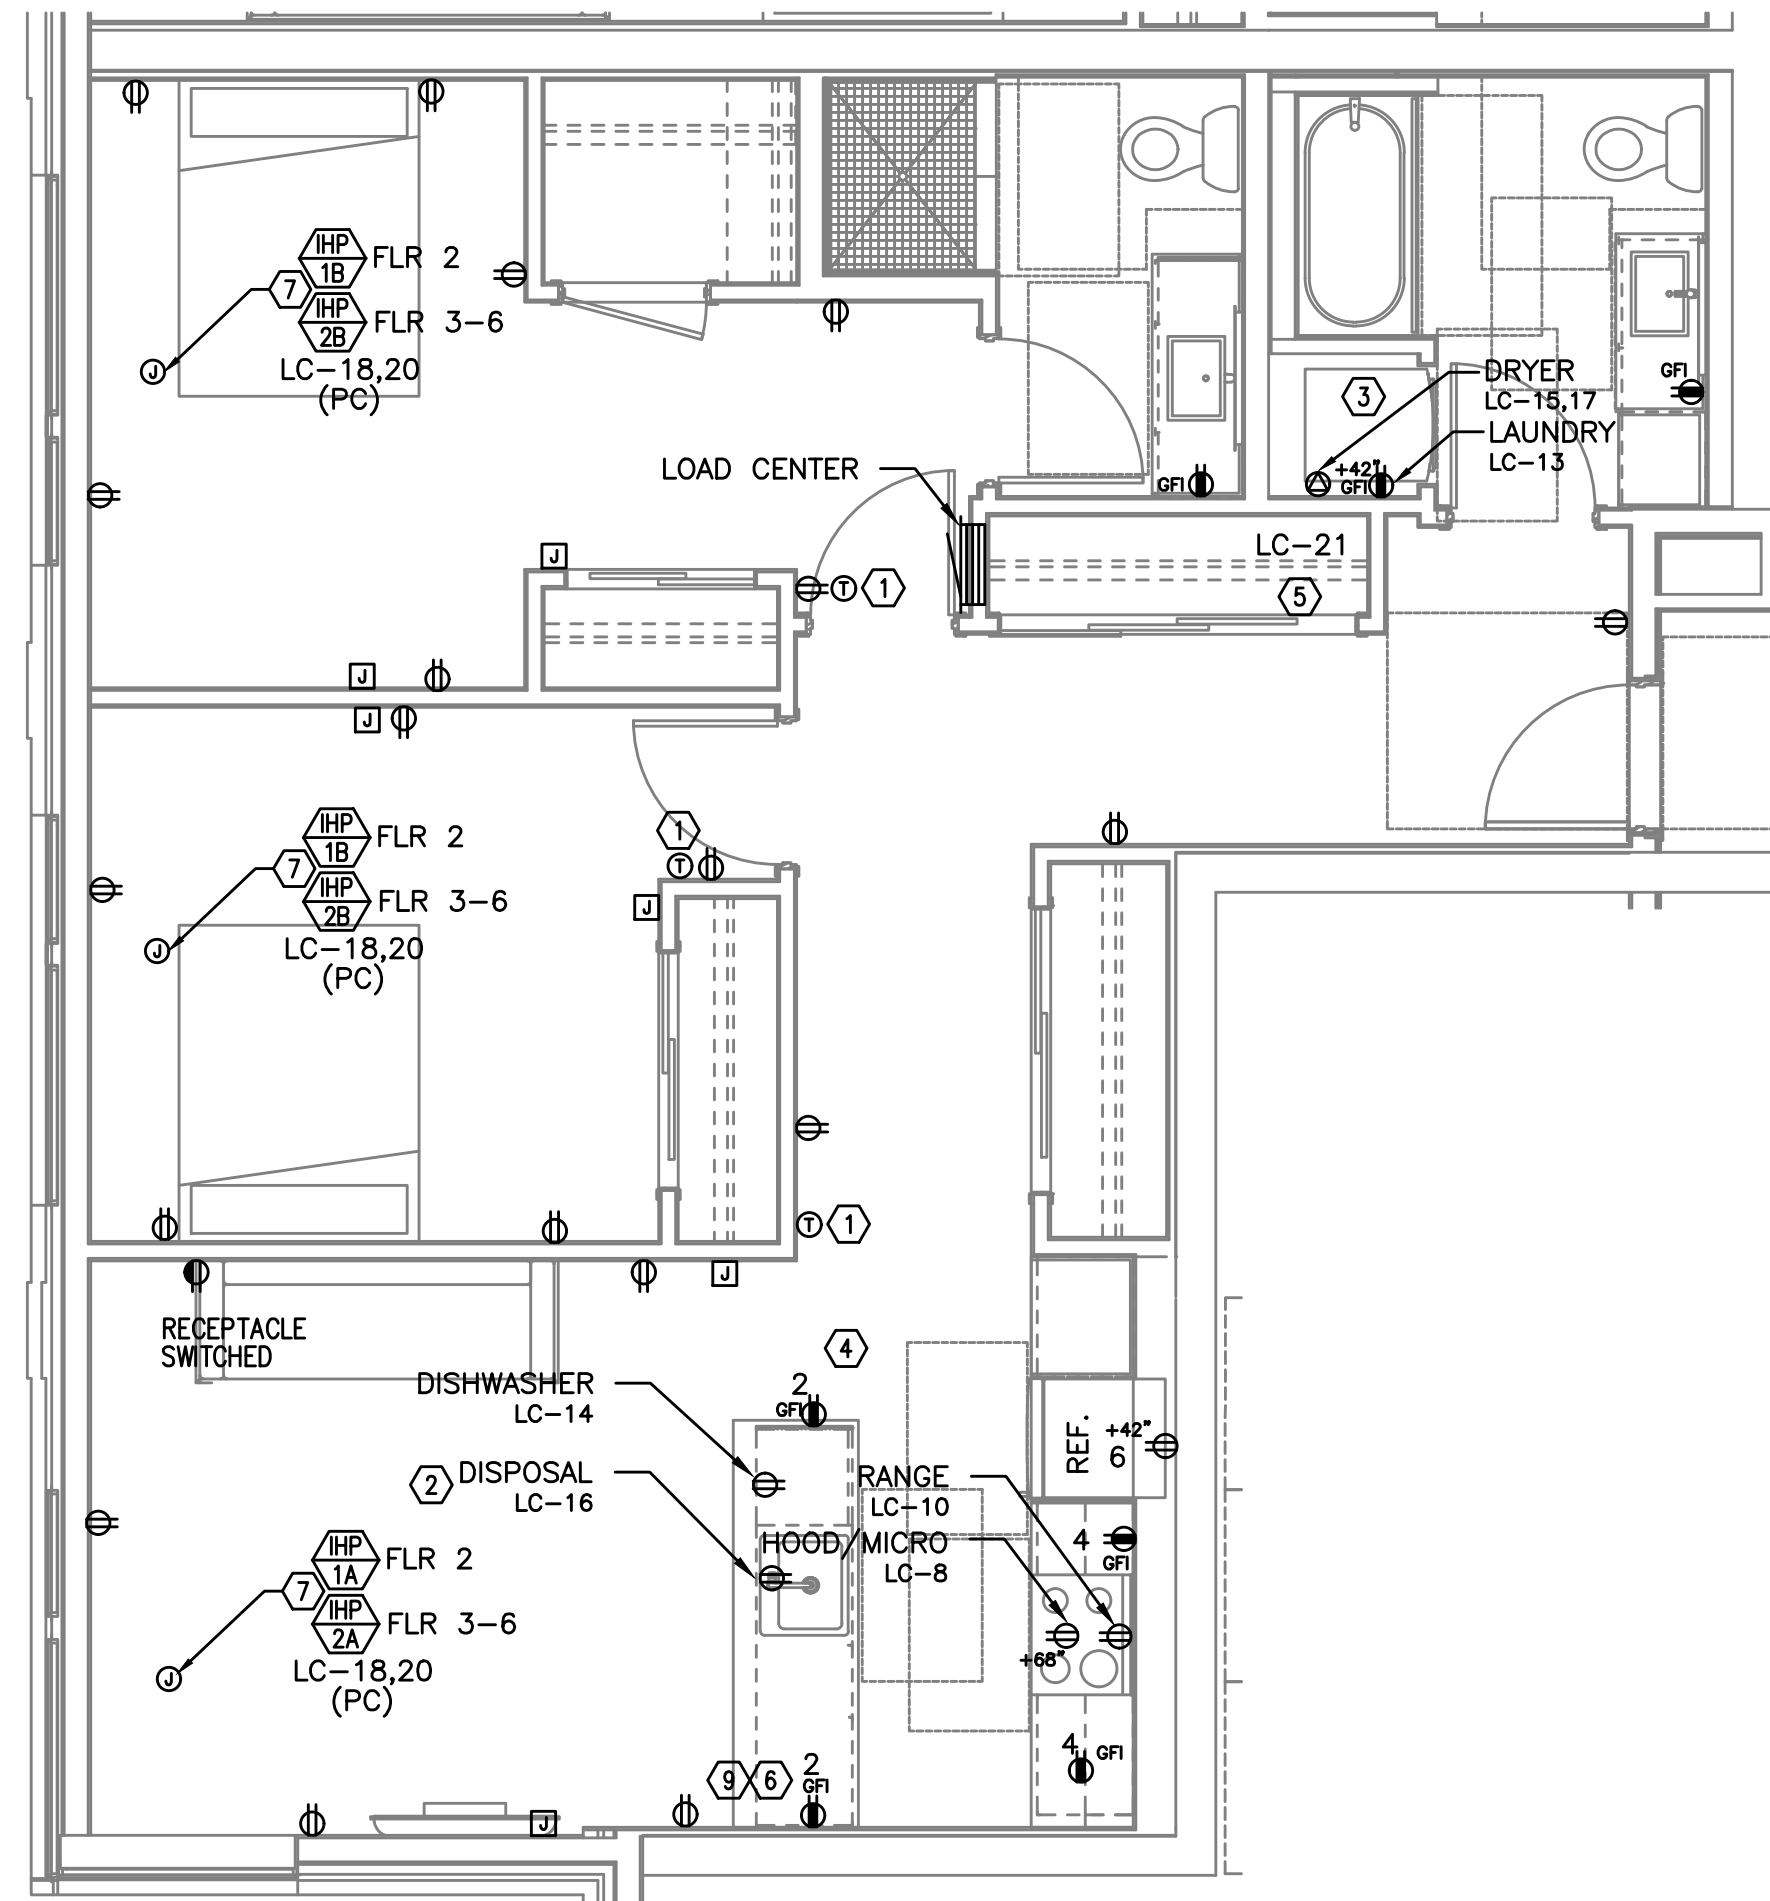

TYPICAL UNIT TYPE R

2 2 BED/2 BATH - POWER PLAN

E4.13 SCALE: 1/4" = 1'-0"

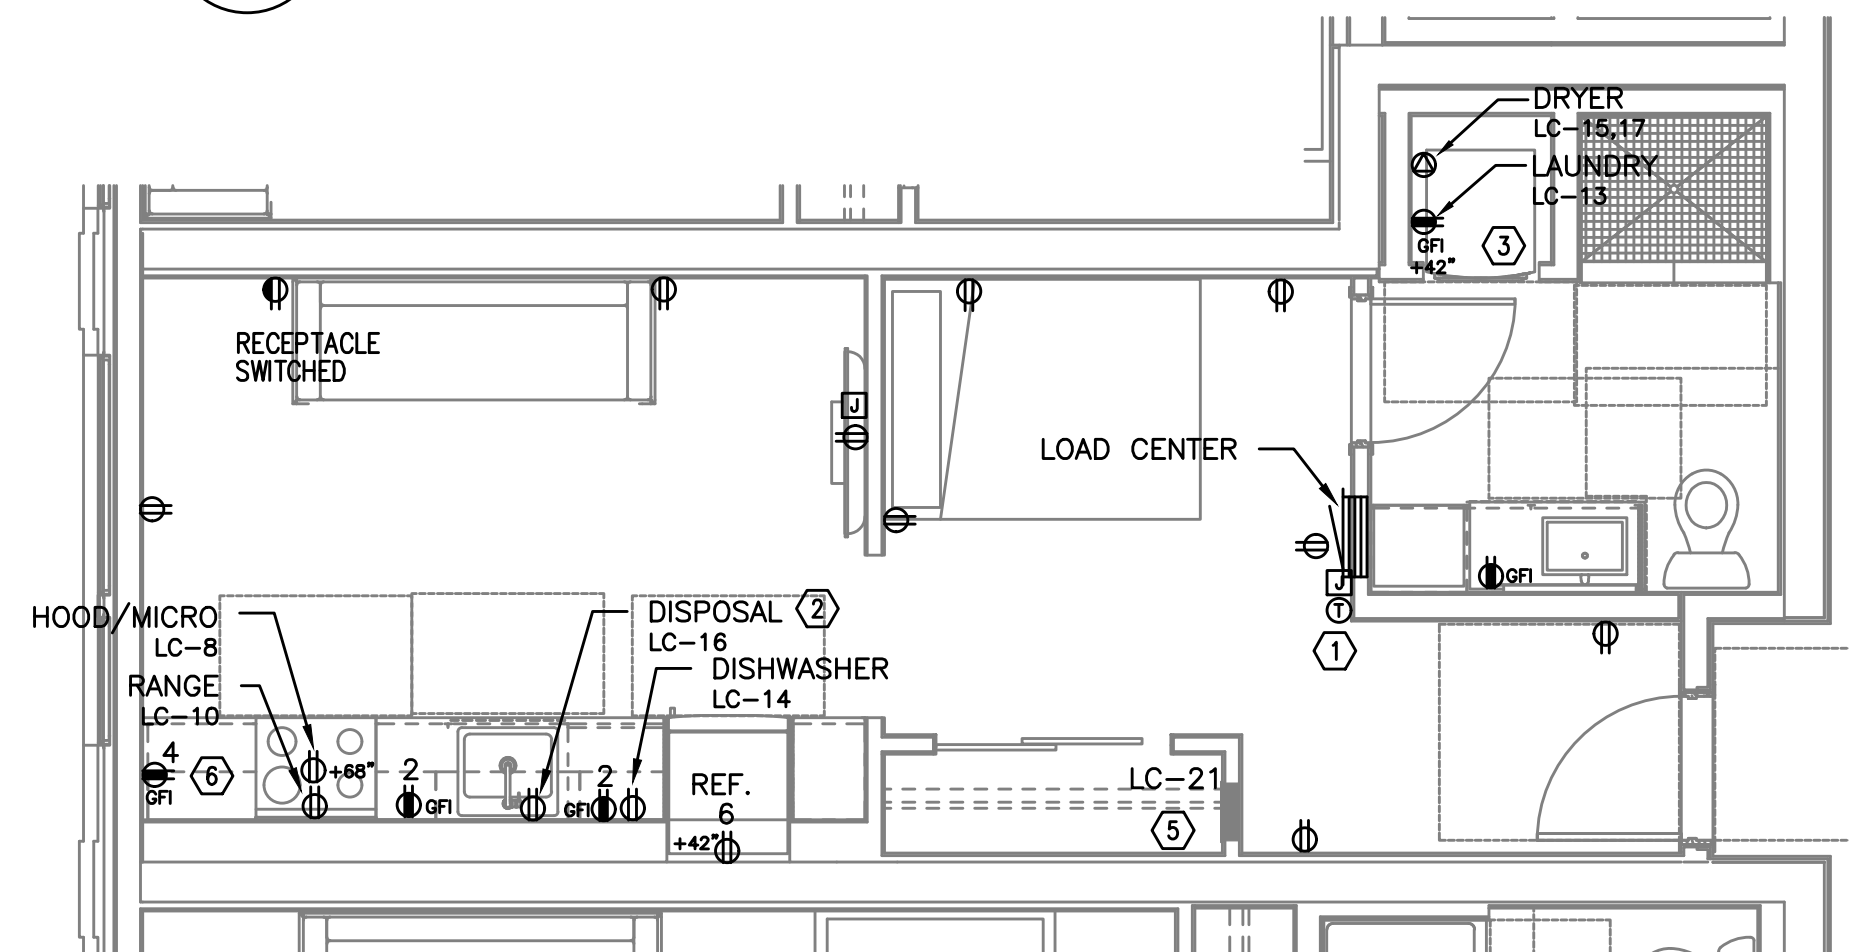

TYPICAL UNIT TYPE T

4 0 BED/1 BATH - POWER PLAN


E4.13 SCALE: 1/4" = 1'-0"

NOTE:

REFER TO SHEET E4.11 FOR GENERAL AND KEYED POWER NOTES.

PRELIMINARY
NOT FOR
CONSTRUCTIONIN THE EVENT CONFLICTS ARE DISCOVERED
BETWEEN THE ORIGINAL SIGNED AND SEALED
DOCUMENTS PREPARED BY THE ARCHITECTS
AND/OR THEIR CONSULTANTS, AND ANY COPY OF
THE DOCUMENTS TRANSMITTED BY MAIL, FAX,
ELECTRONICALLY OR OTHERWISE, THE ORIGINAL
SIGNED AND SEALED DOCUMENTS SHALL GOVERN.PROJECT # 2017-053
DATE: 11/19/2021


REVISIONS

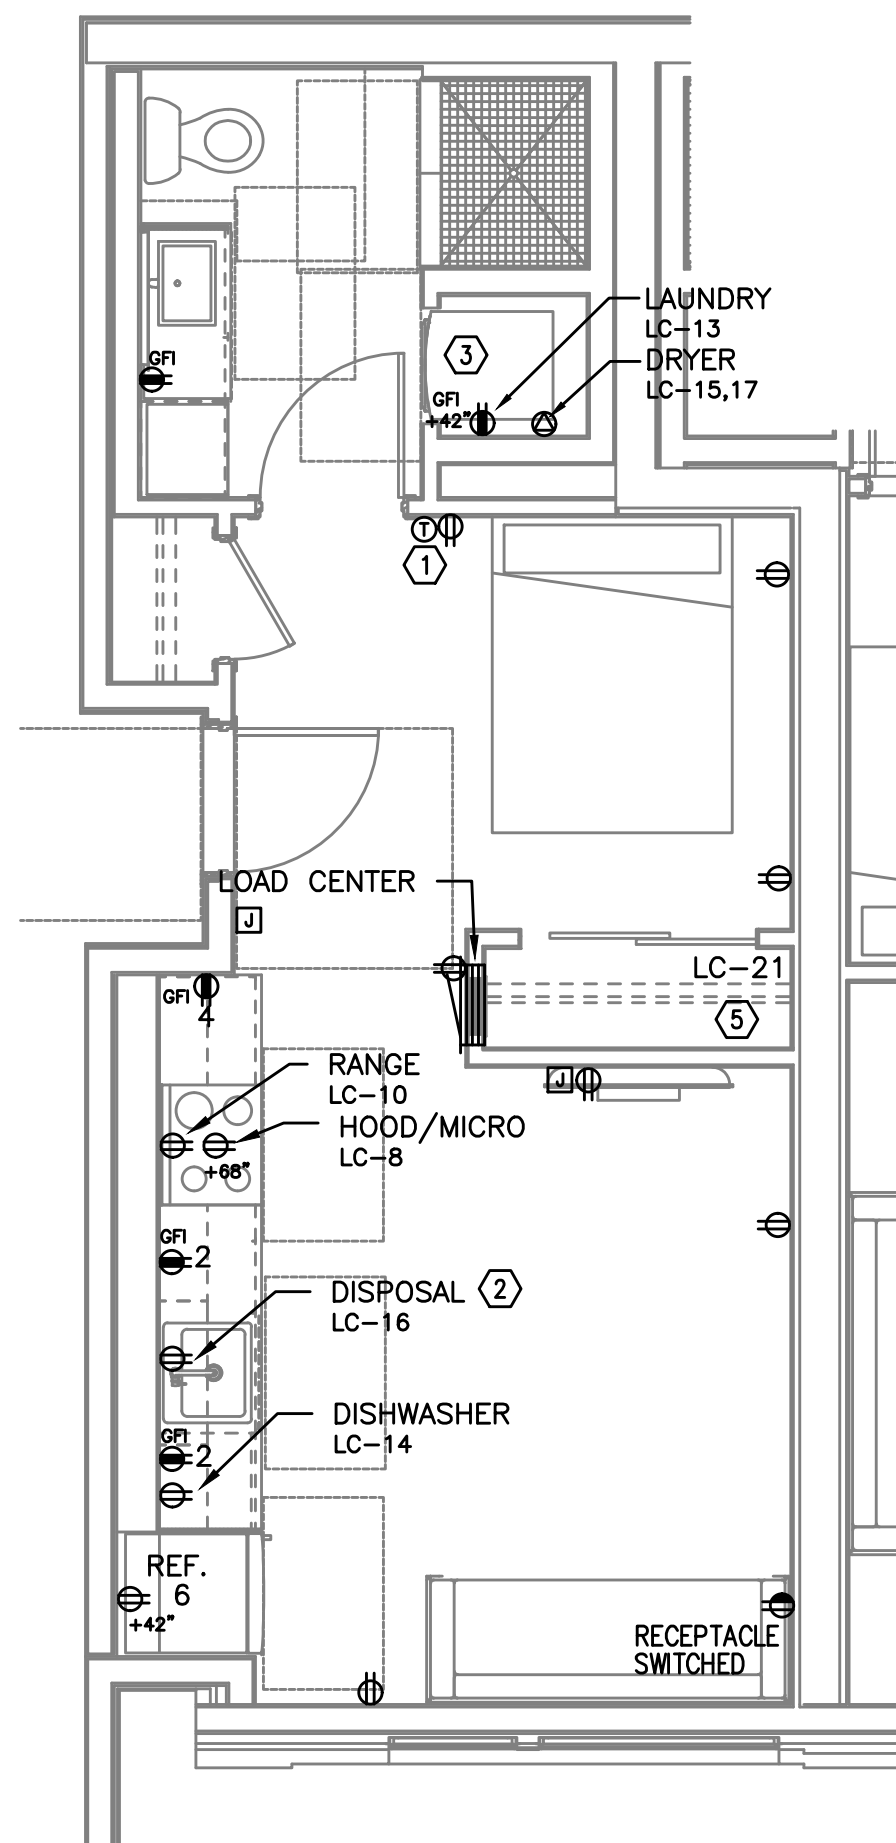AEGIS - PHASE II
MIXED-USE DEVELOPMENT
312 E EVERGREEN BOULEVARD, VANCOUVER, WA 98660

TYPICAL UNIT TYPE U

1 0 BED/1 BATH - POWER PLAN


SCALE: 1/4" = 1'-0"

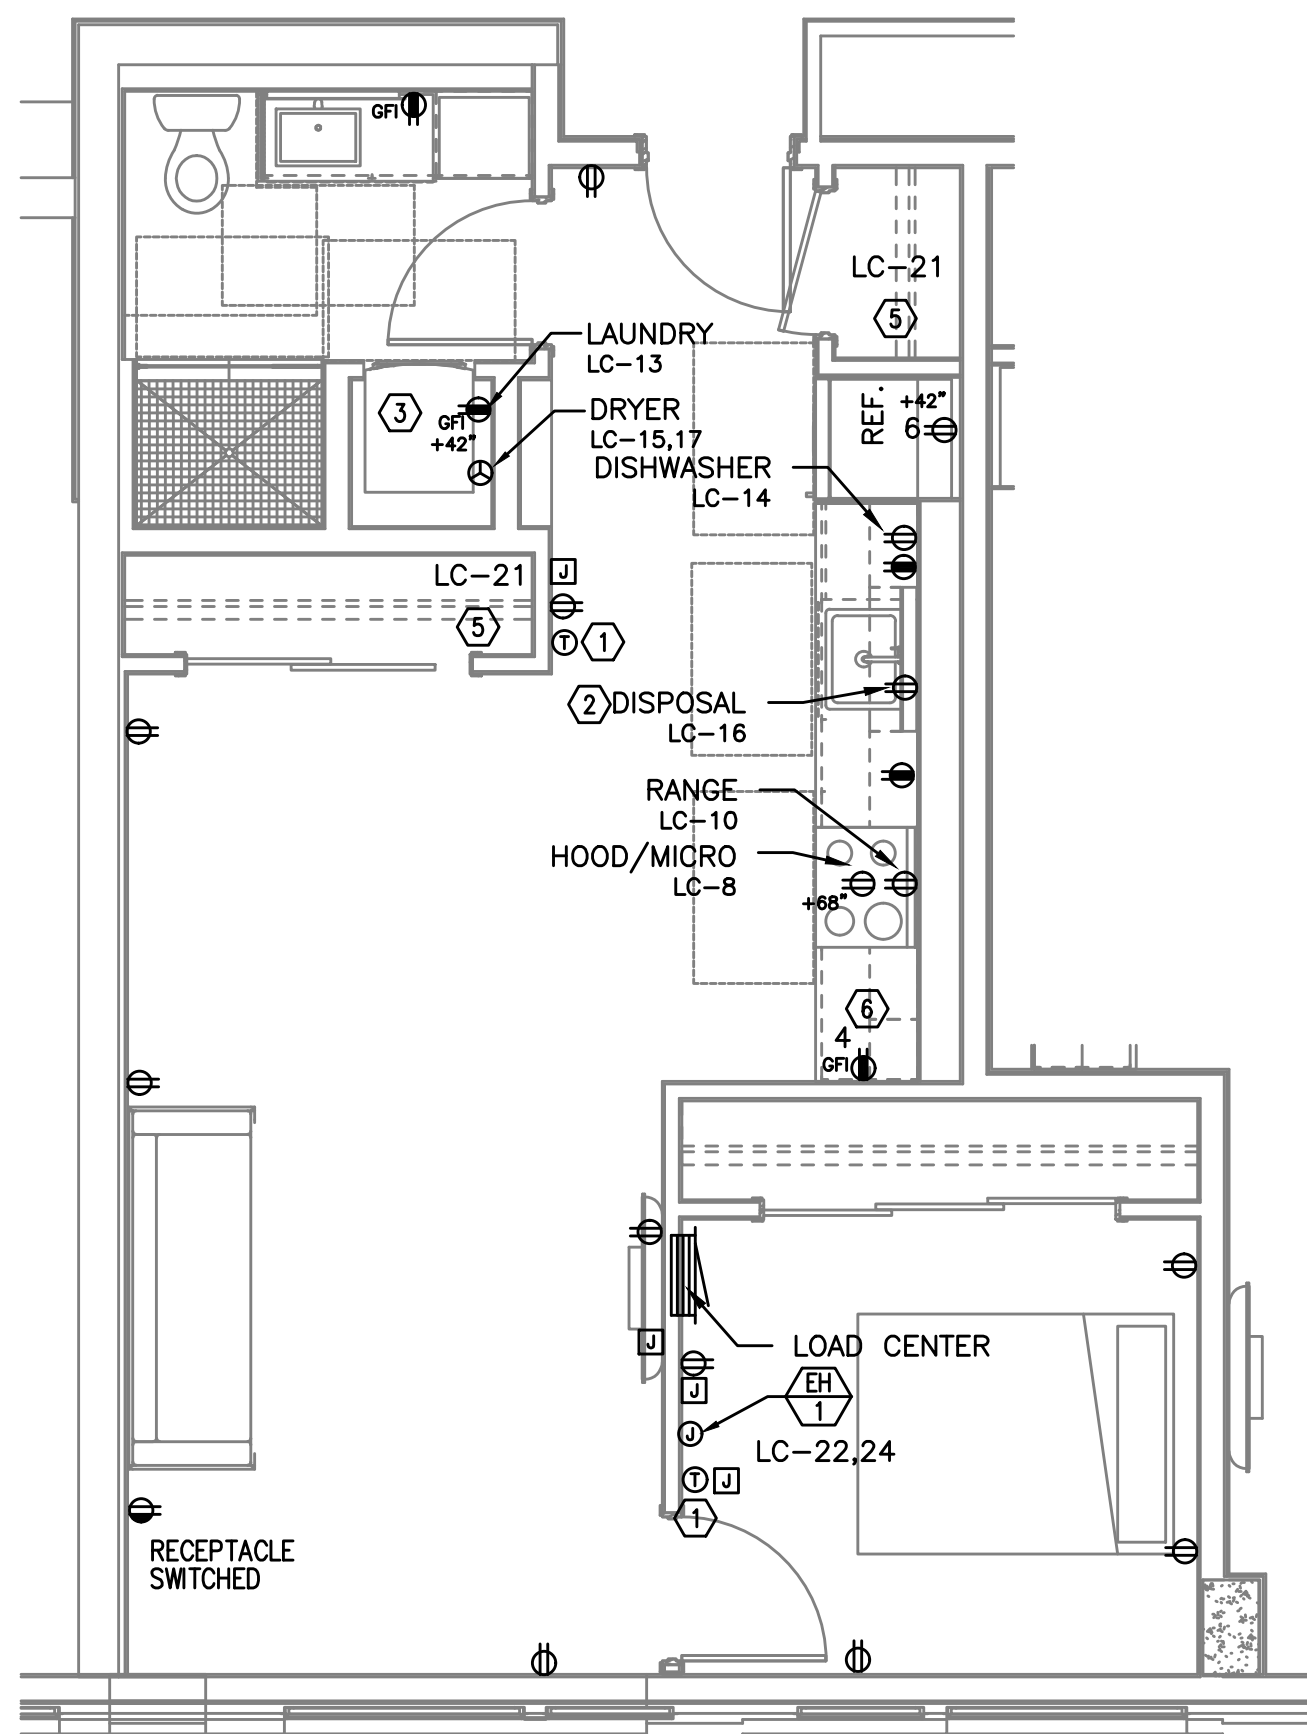

TYPICAL UNIT TYPE V

2 1 BED/1 BATH - POWER PLAN

SCALE: 1/4" = 1'-0"

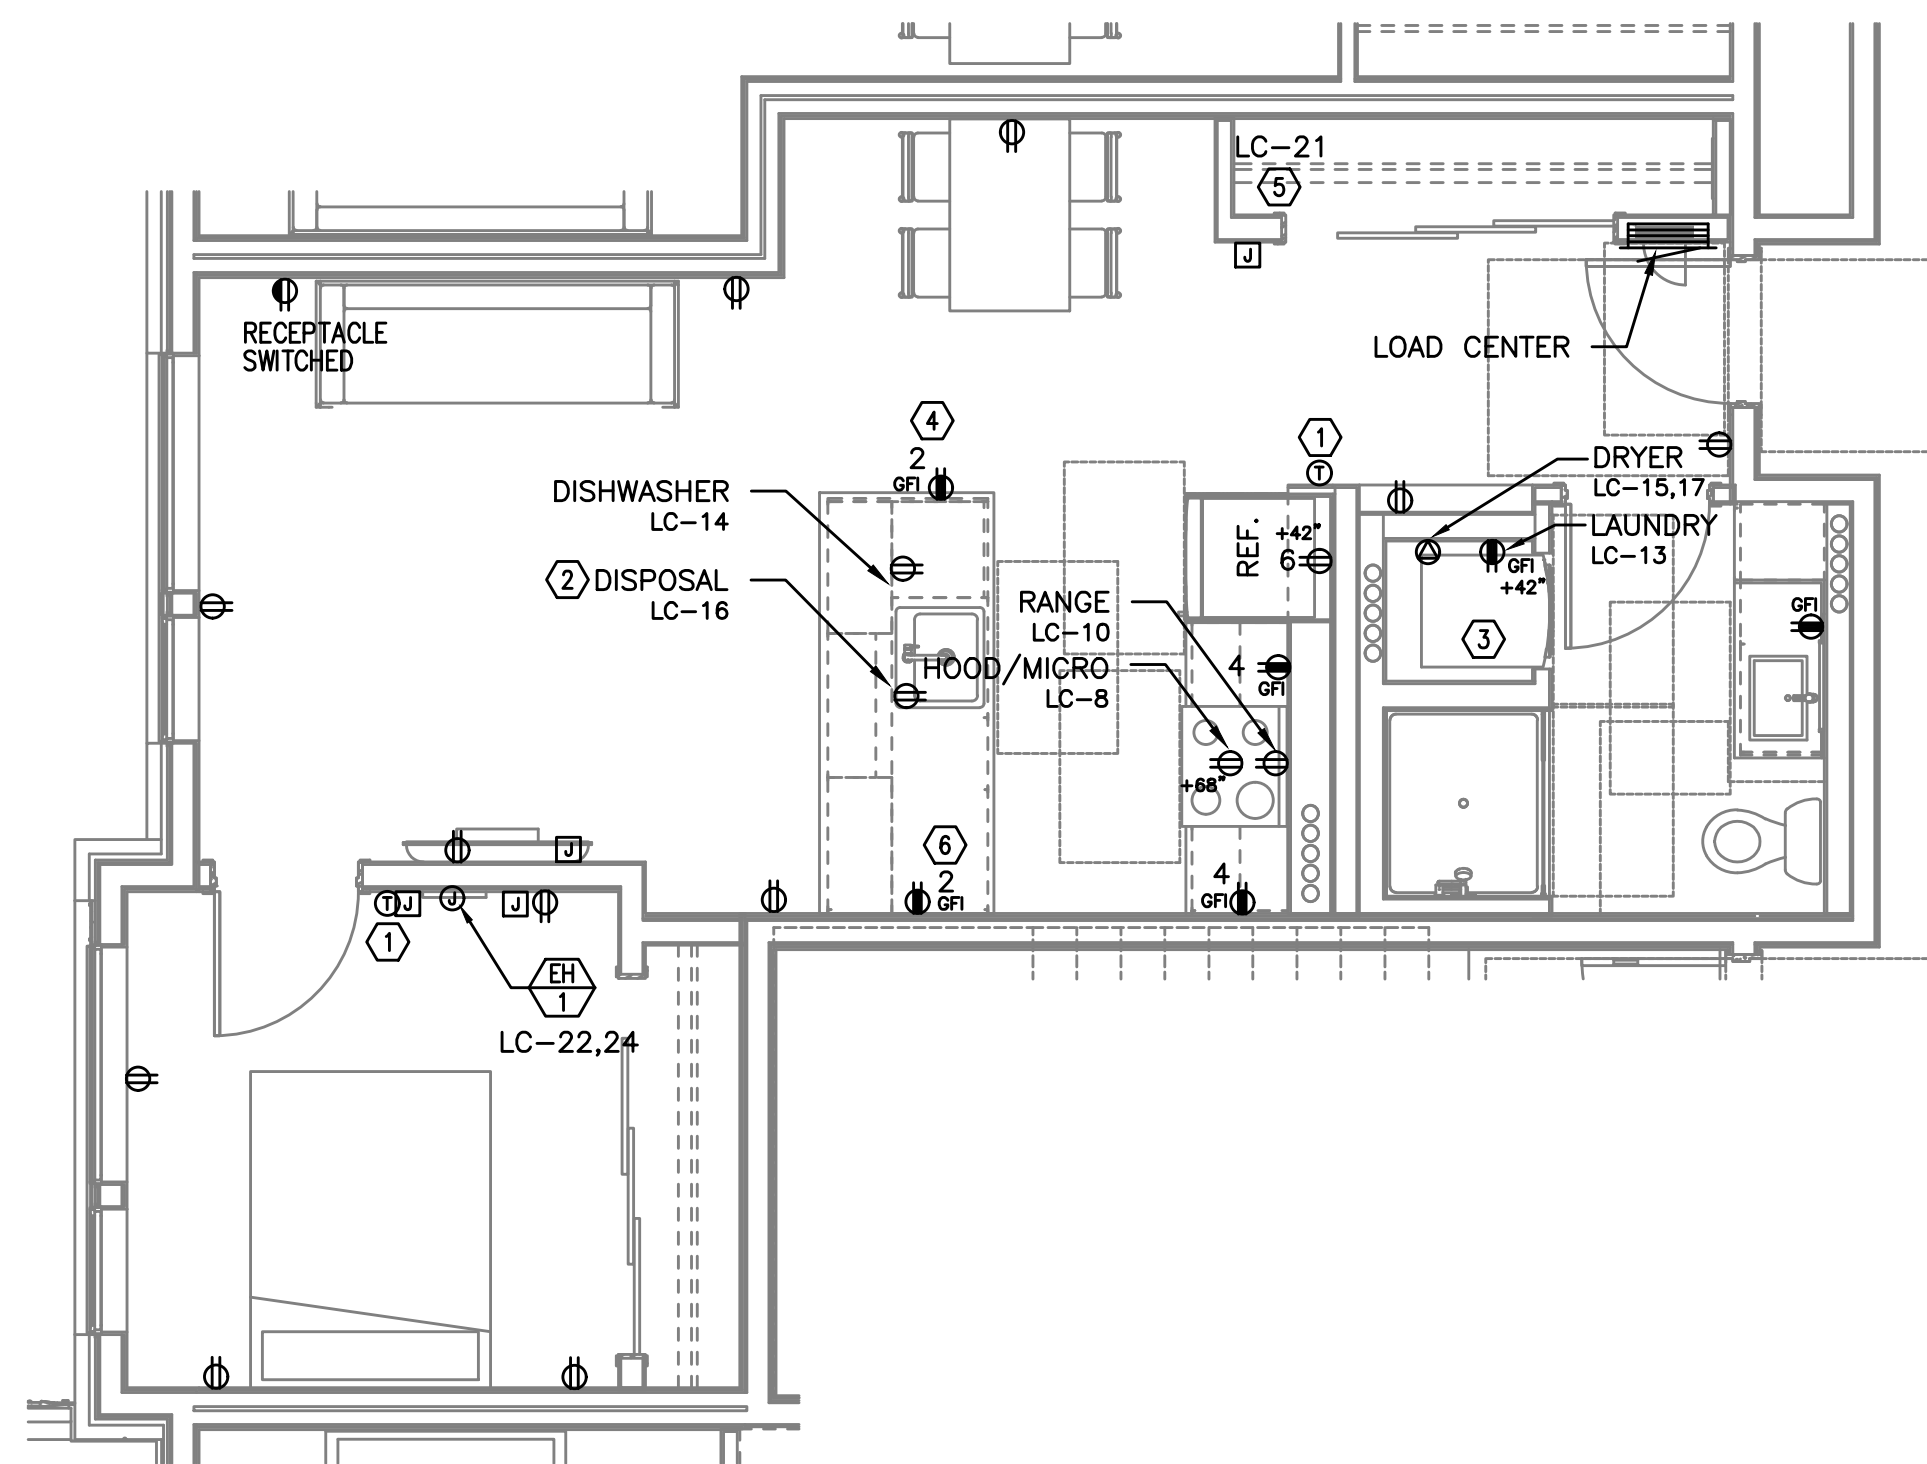

TYPICAL UNIT TYPE W

3 1 BED/1 BATH - POWER PLAN

SCALE: 1/4" = 1'-0"

NOTE:

REFER TO SHEET E4.11 FOR GENERAL AND KEYED POWER NOTES.

M
F
A
INC. Consulting Engineers
2007 S.E. Ash St.
Portland, OR 97214
PHN: (503) 234-0548
FAX: (503) 234-0677
WWW.MFIA-ENG.COM
CONTACT: DENISE TAYLOR

SHEET:

E4.14


PRELIMINARY
NOT FOR
CONSTRUCTIONIN THE EVENT CONFLICTS ARE DISCOVERED
BETWEEN THE ORIGINAL SIGNED AND SEALED
DOCUMENTS PREPARED BY THE ARCHITECTS
AND/OR THEIR CONSULTANTS, AND ANY COPY OF
THE DOCUMENTS TRANSMITTED BY MAIL, FAX,
ELECTRONICALLY OR OTHERWISE, THE ORIGINAL
SIGNED AND SEALED DOCUMENTS SHALL GOVERN.PROJECT # 2017-053
DATE: 11/19/2021

REVISIONS

AEGIS - PHASE II
MIXED-USE DEVELOPMENT
312 E EVERGREEN BOULEVARD, VANCOUVER, WA 98660


SHEET:

E4.15

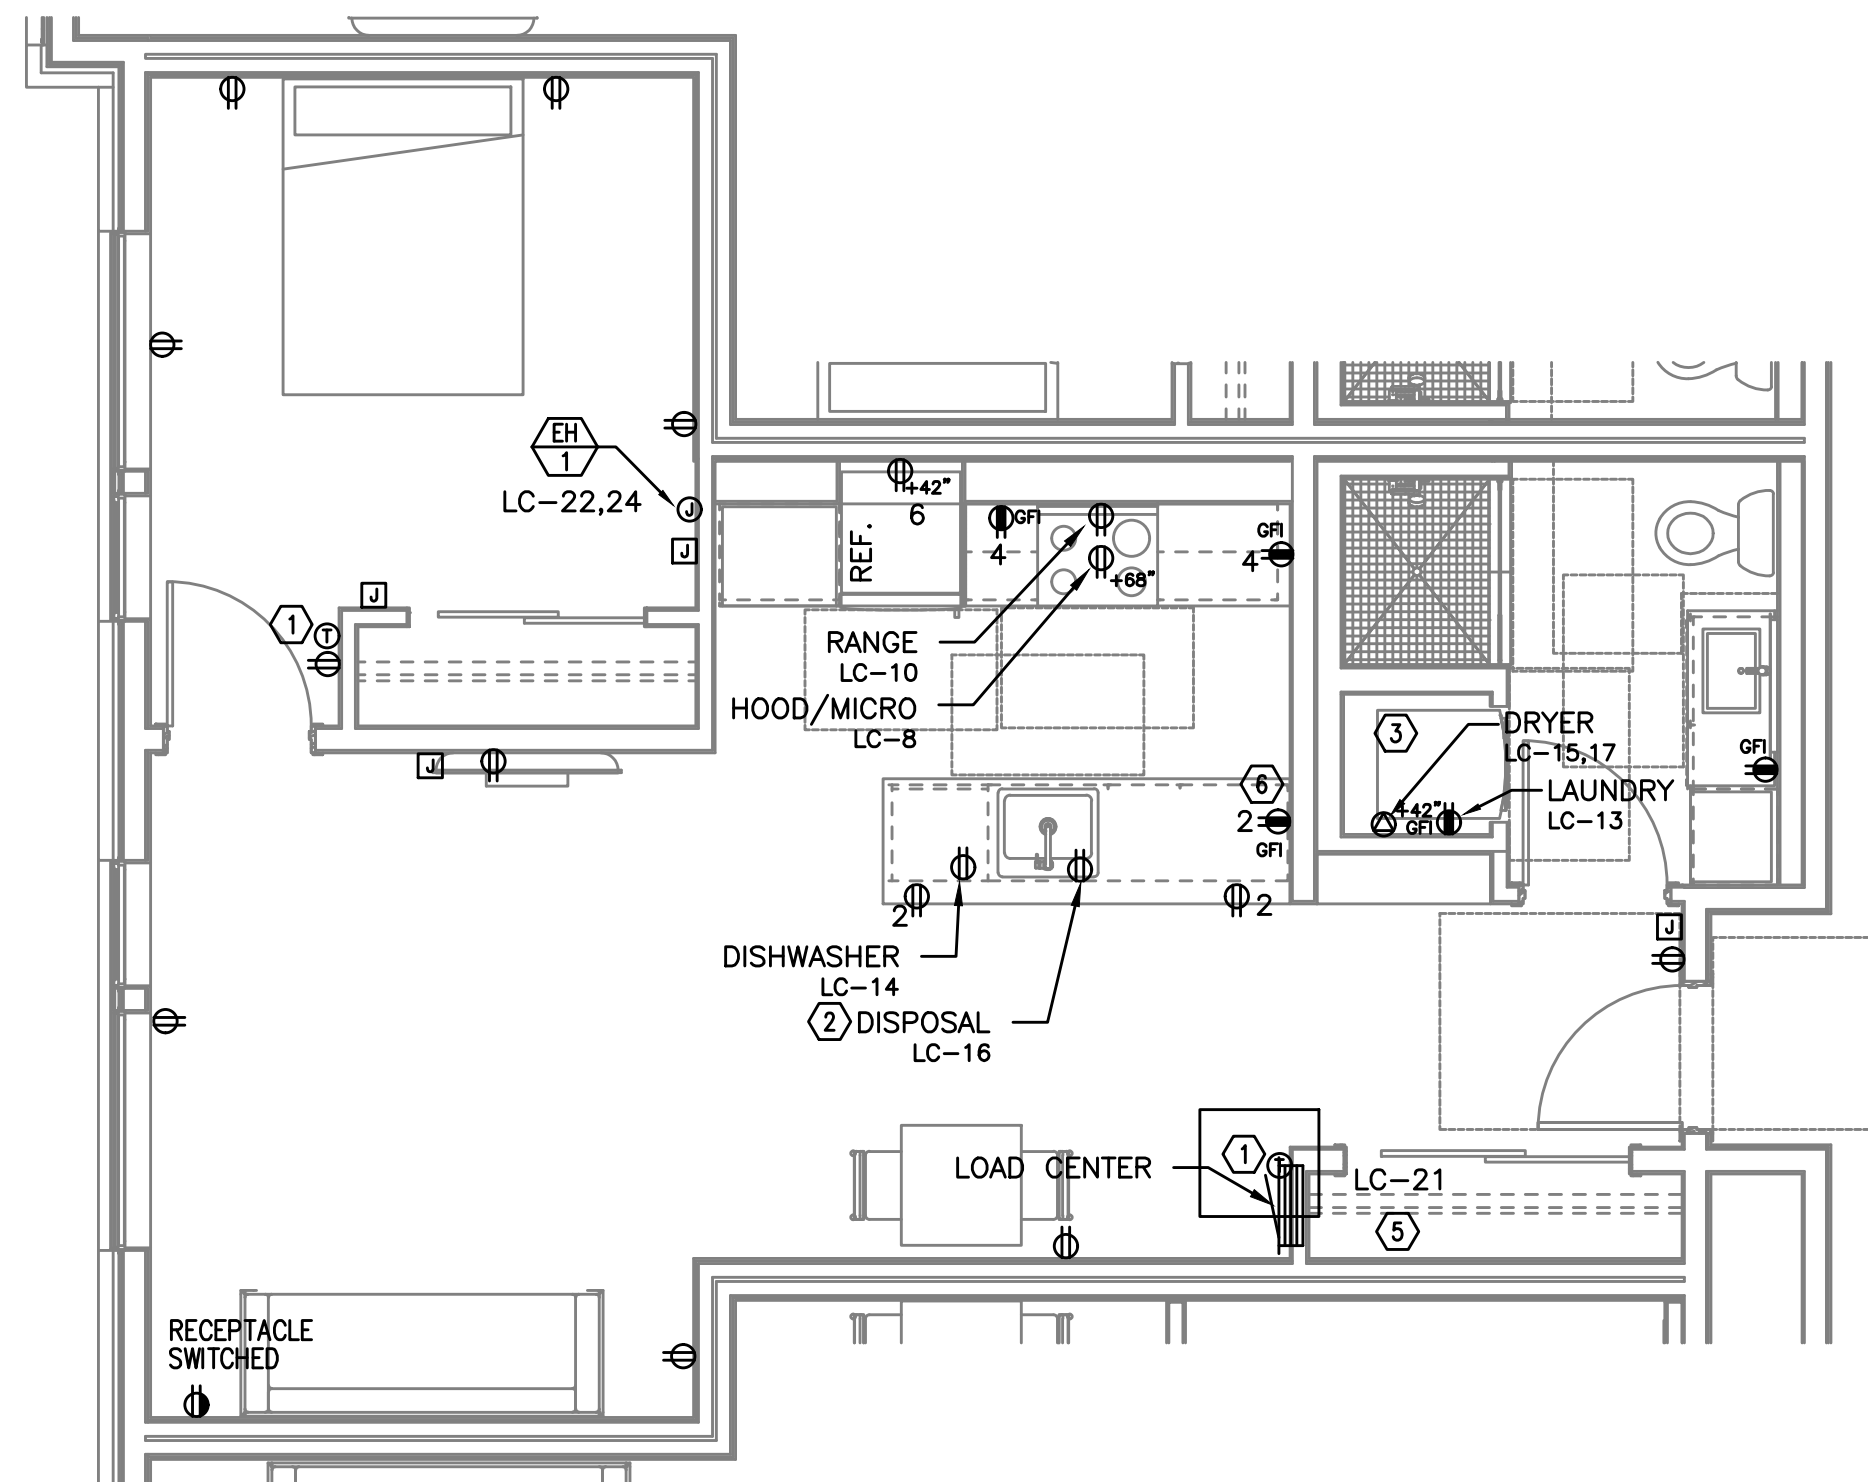


1
E4.15

TYPICAL UNIT TYPE X
1 BED/1 BATH - POWER PLAN
SCALE: 1/4" = 1'-0"

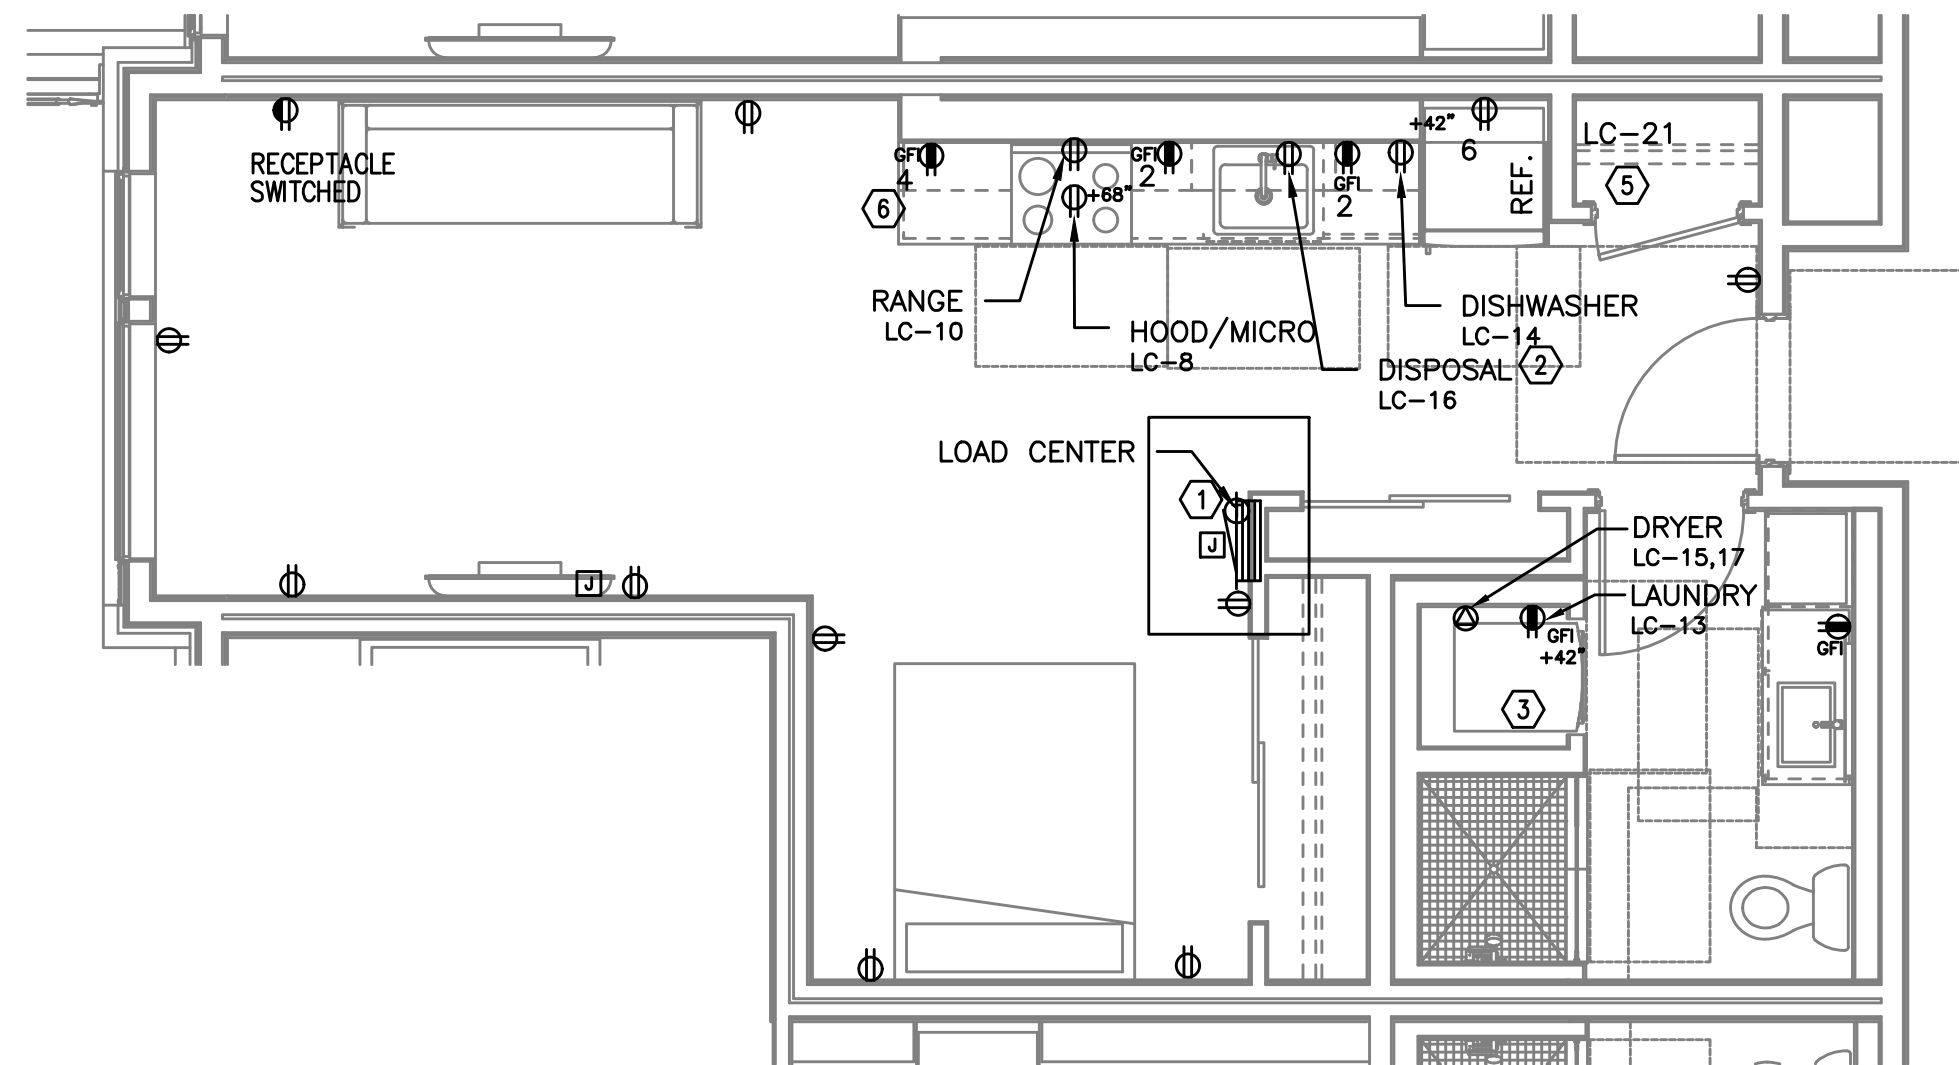

2
E4.15

TYPICAL UNIT TYPE Y
0 BED/1 BATH - POWER PLAN
SCALE: 1/4" = 1'-0"

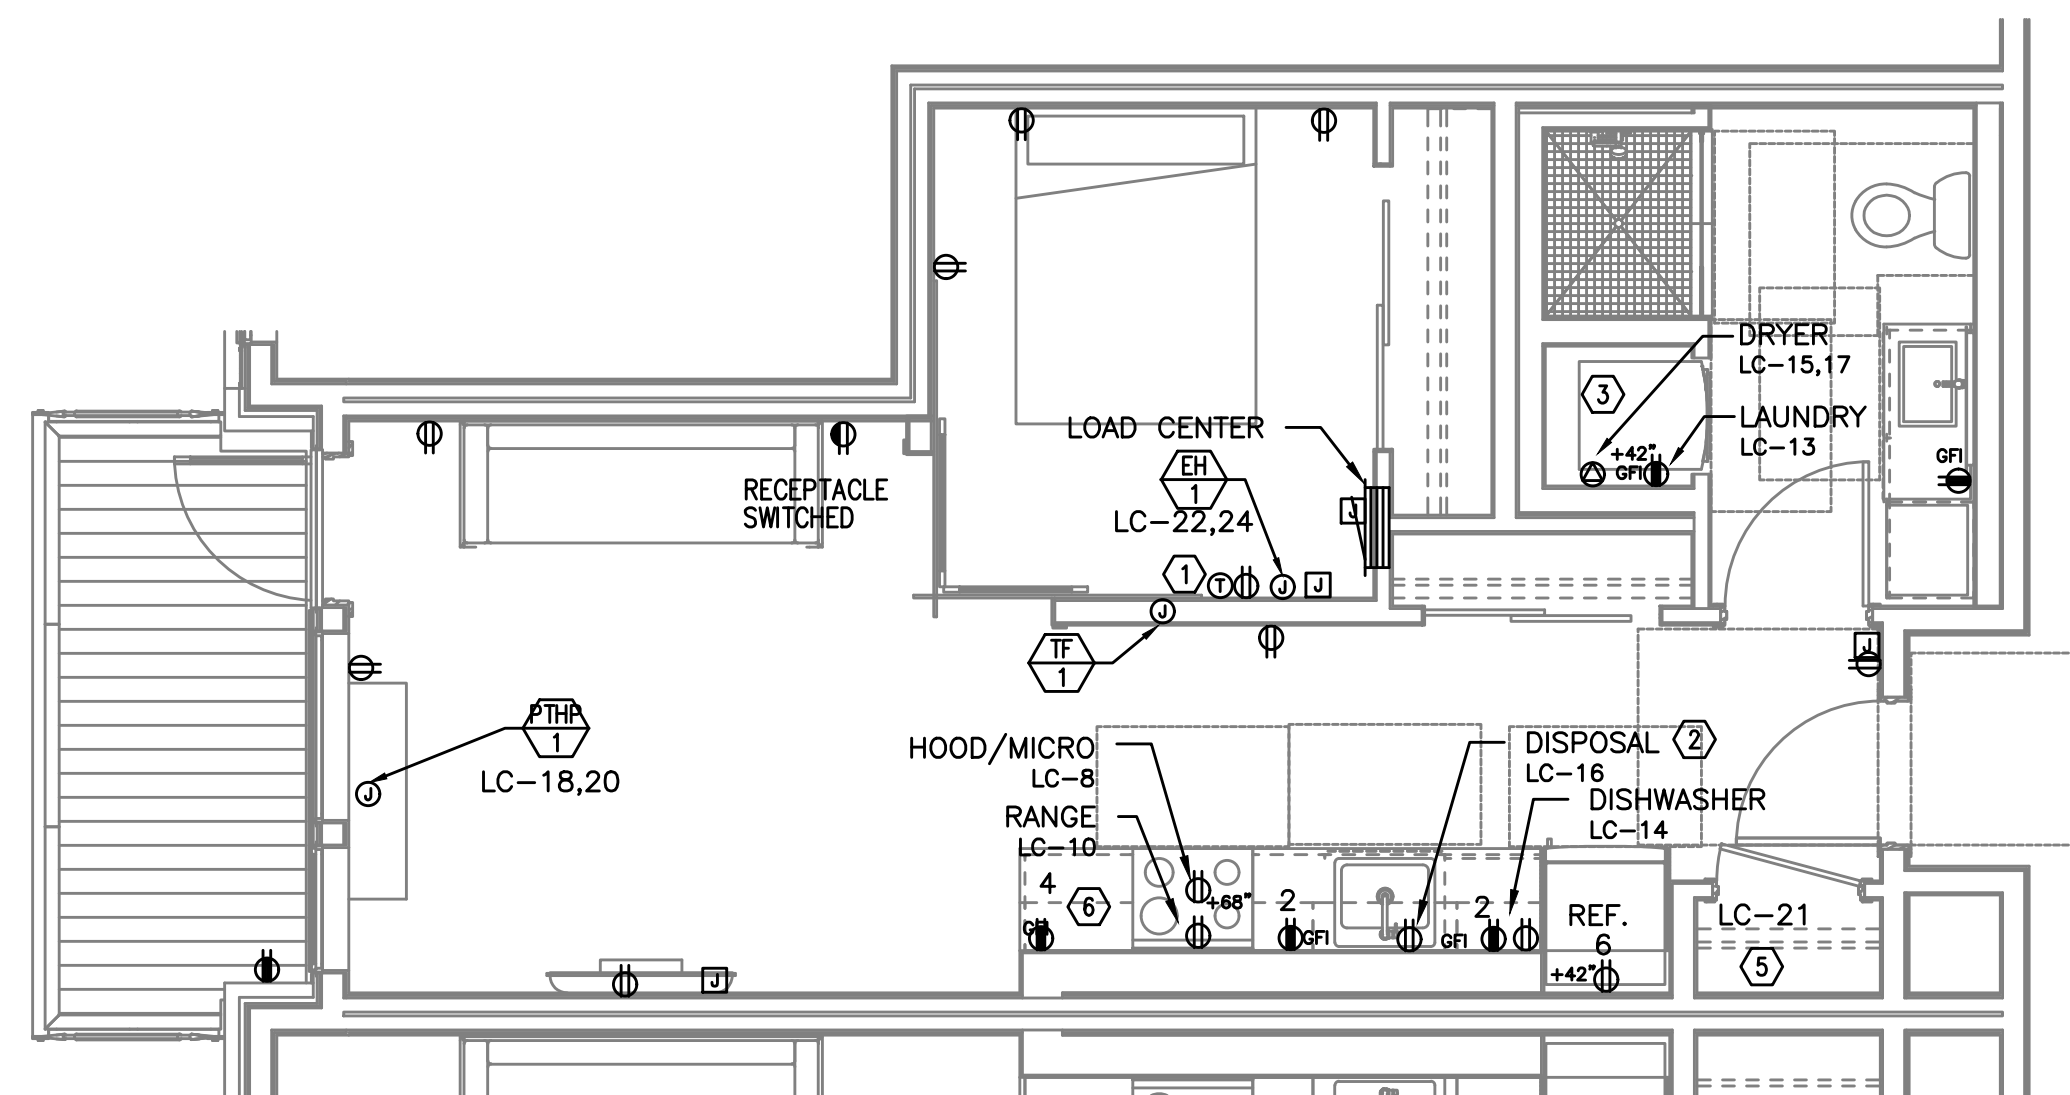


3
E4.15

TYPICAL UNIT TYPE Z
0 BED/1 BATH - POWER PLAN
SCALE: 1/4" = 1'-0"

NOTE:


REFER TO SHEET E4.11 FOR GENERAL AND KEYED POWER NOTES.

M
F
A
INC. Consulting Engineers
2007 S.E. Ash St.
Portland, OR 97214
PHN: (503) 234-0548
FAX: (503) 234-0677
WWW.MFIA-ENG.COM
CONTACT: DENISE TAYLOR

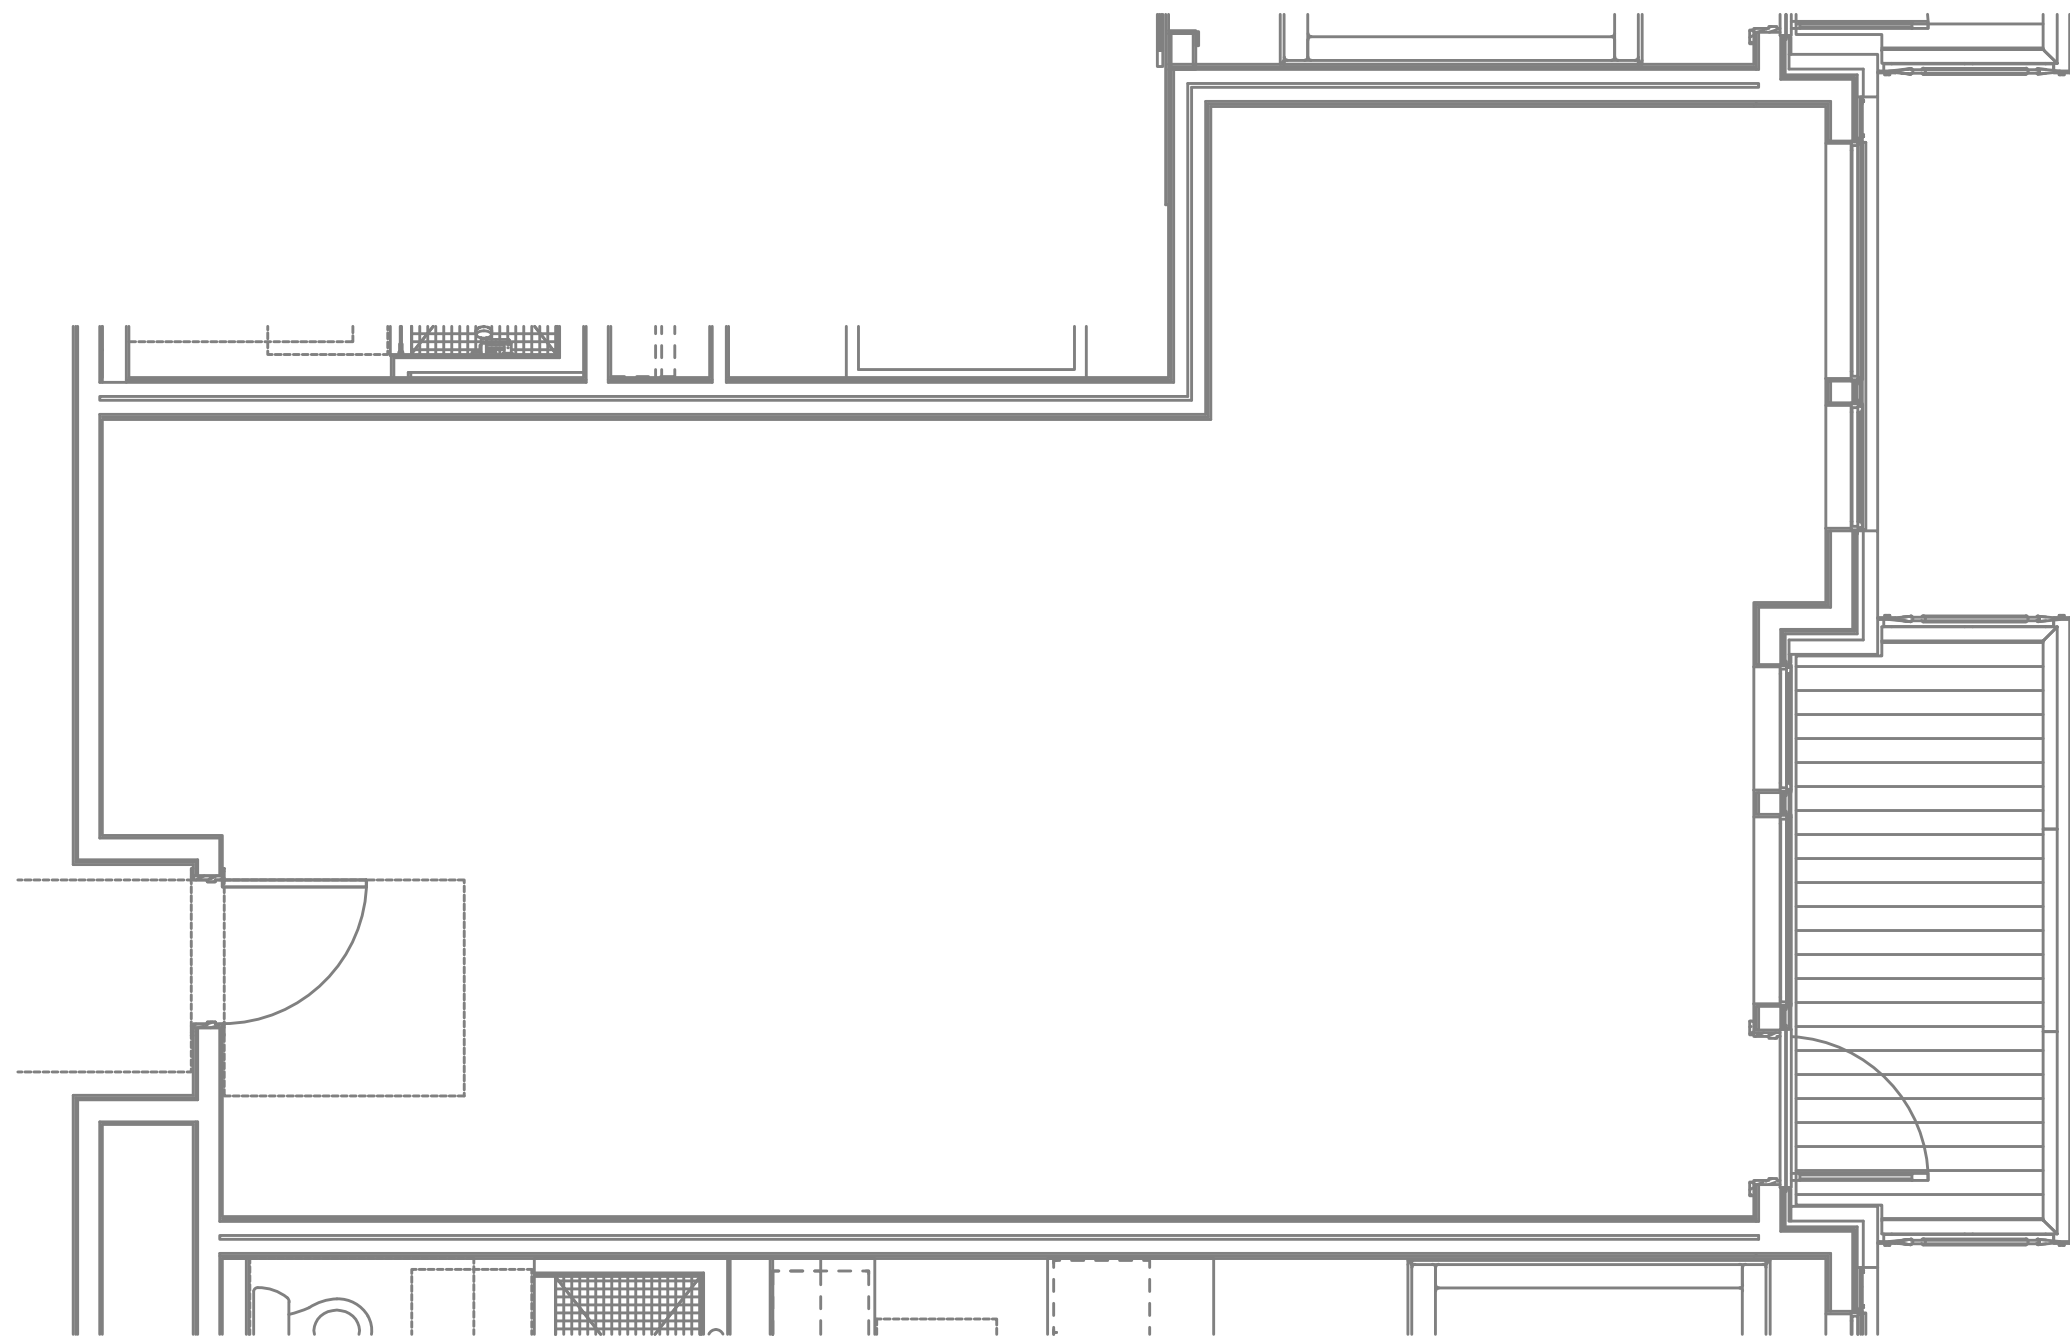


1
E4.16

TYPICAL UNIT TYPE AA
2 BED/2 BATH – POWER PLAN
SCALE: 1/4" = 1'-0"

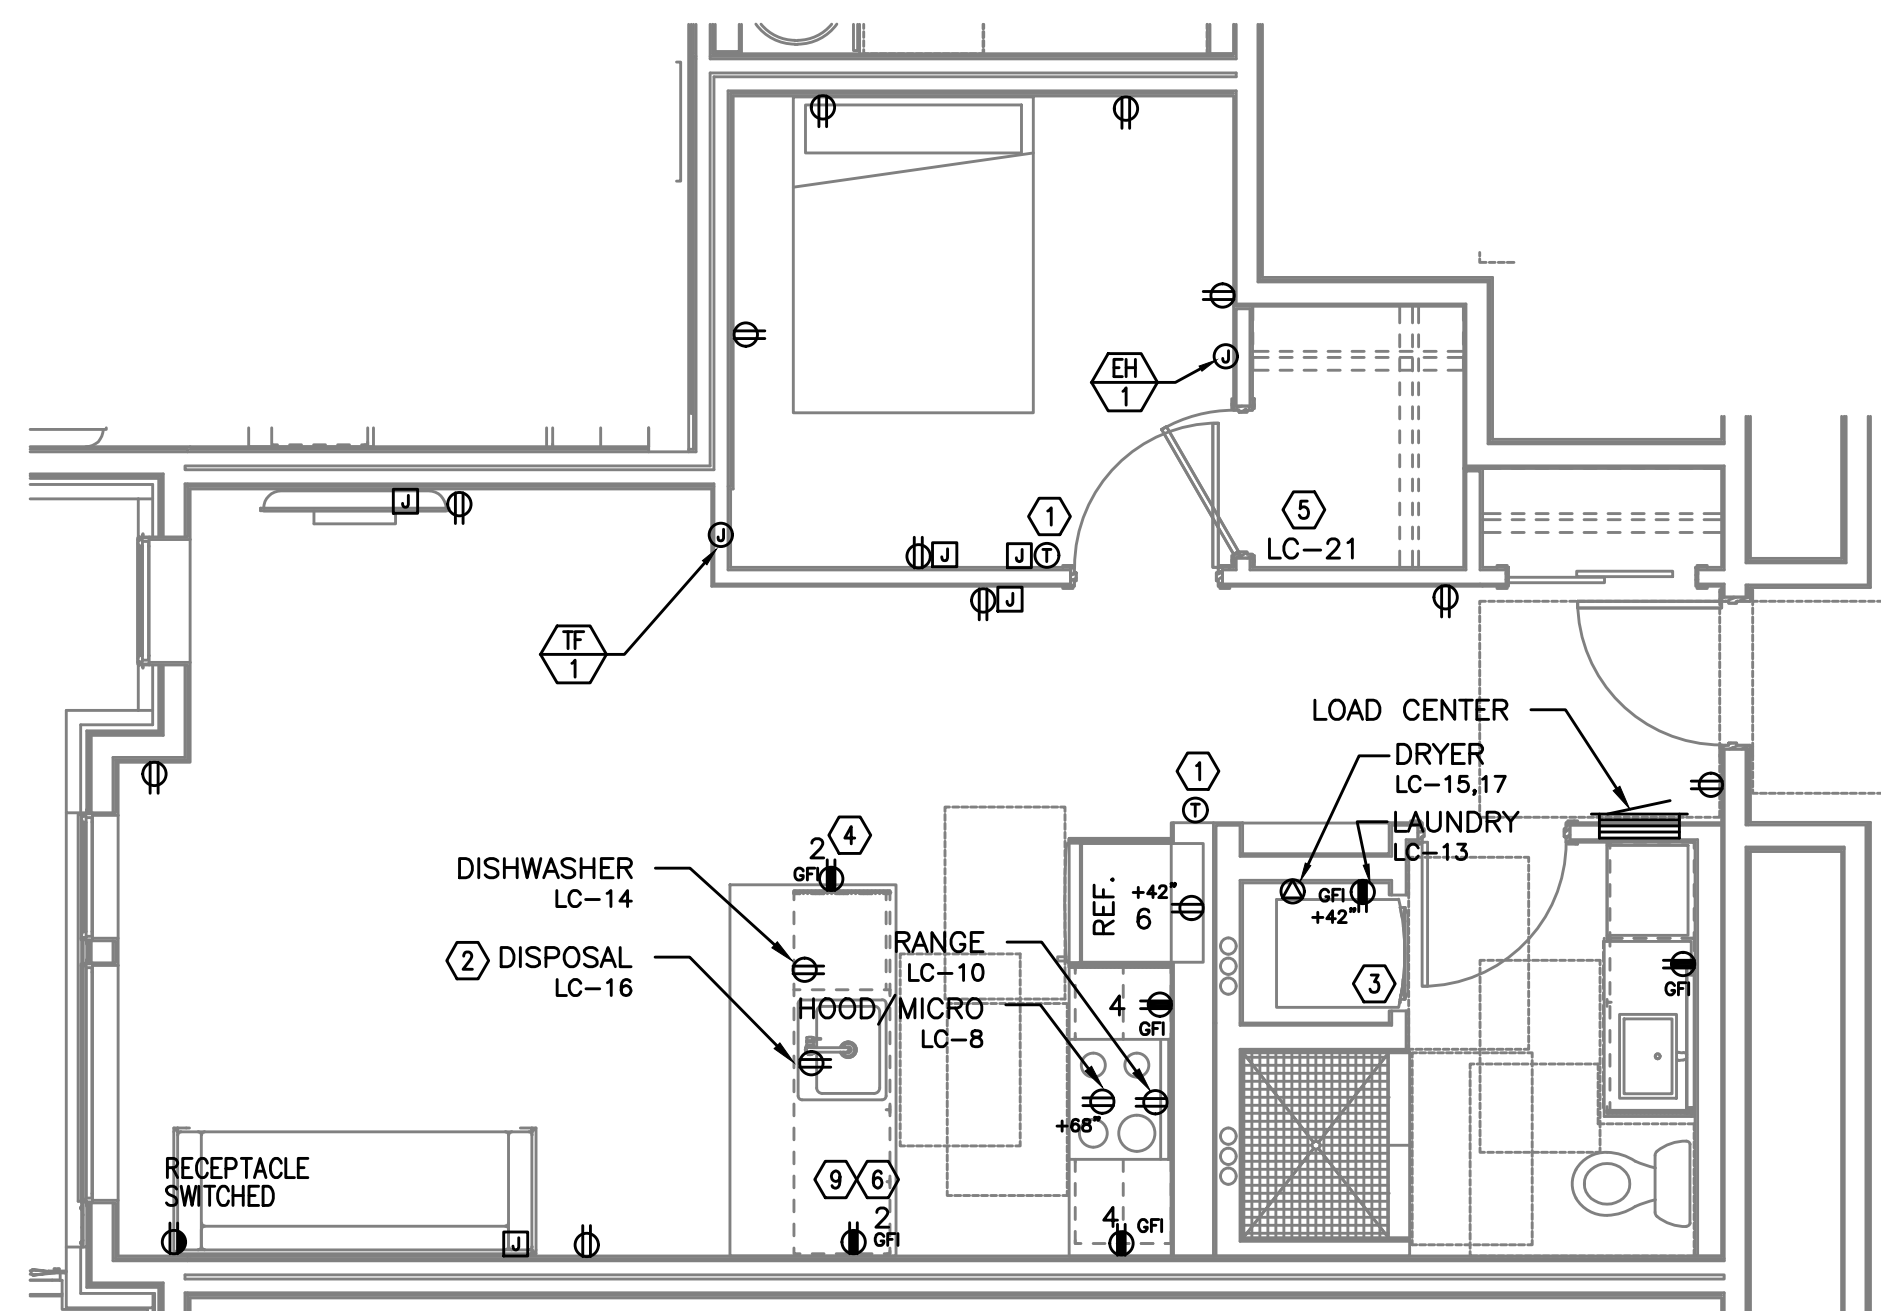

2
E4.16

TYPICAL UNIT TYPE BB
1 BED/1 BATH – POWER PLAN
SCALE: 1/4" = 1'-0"

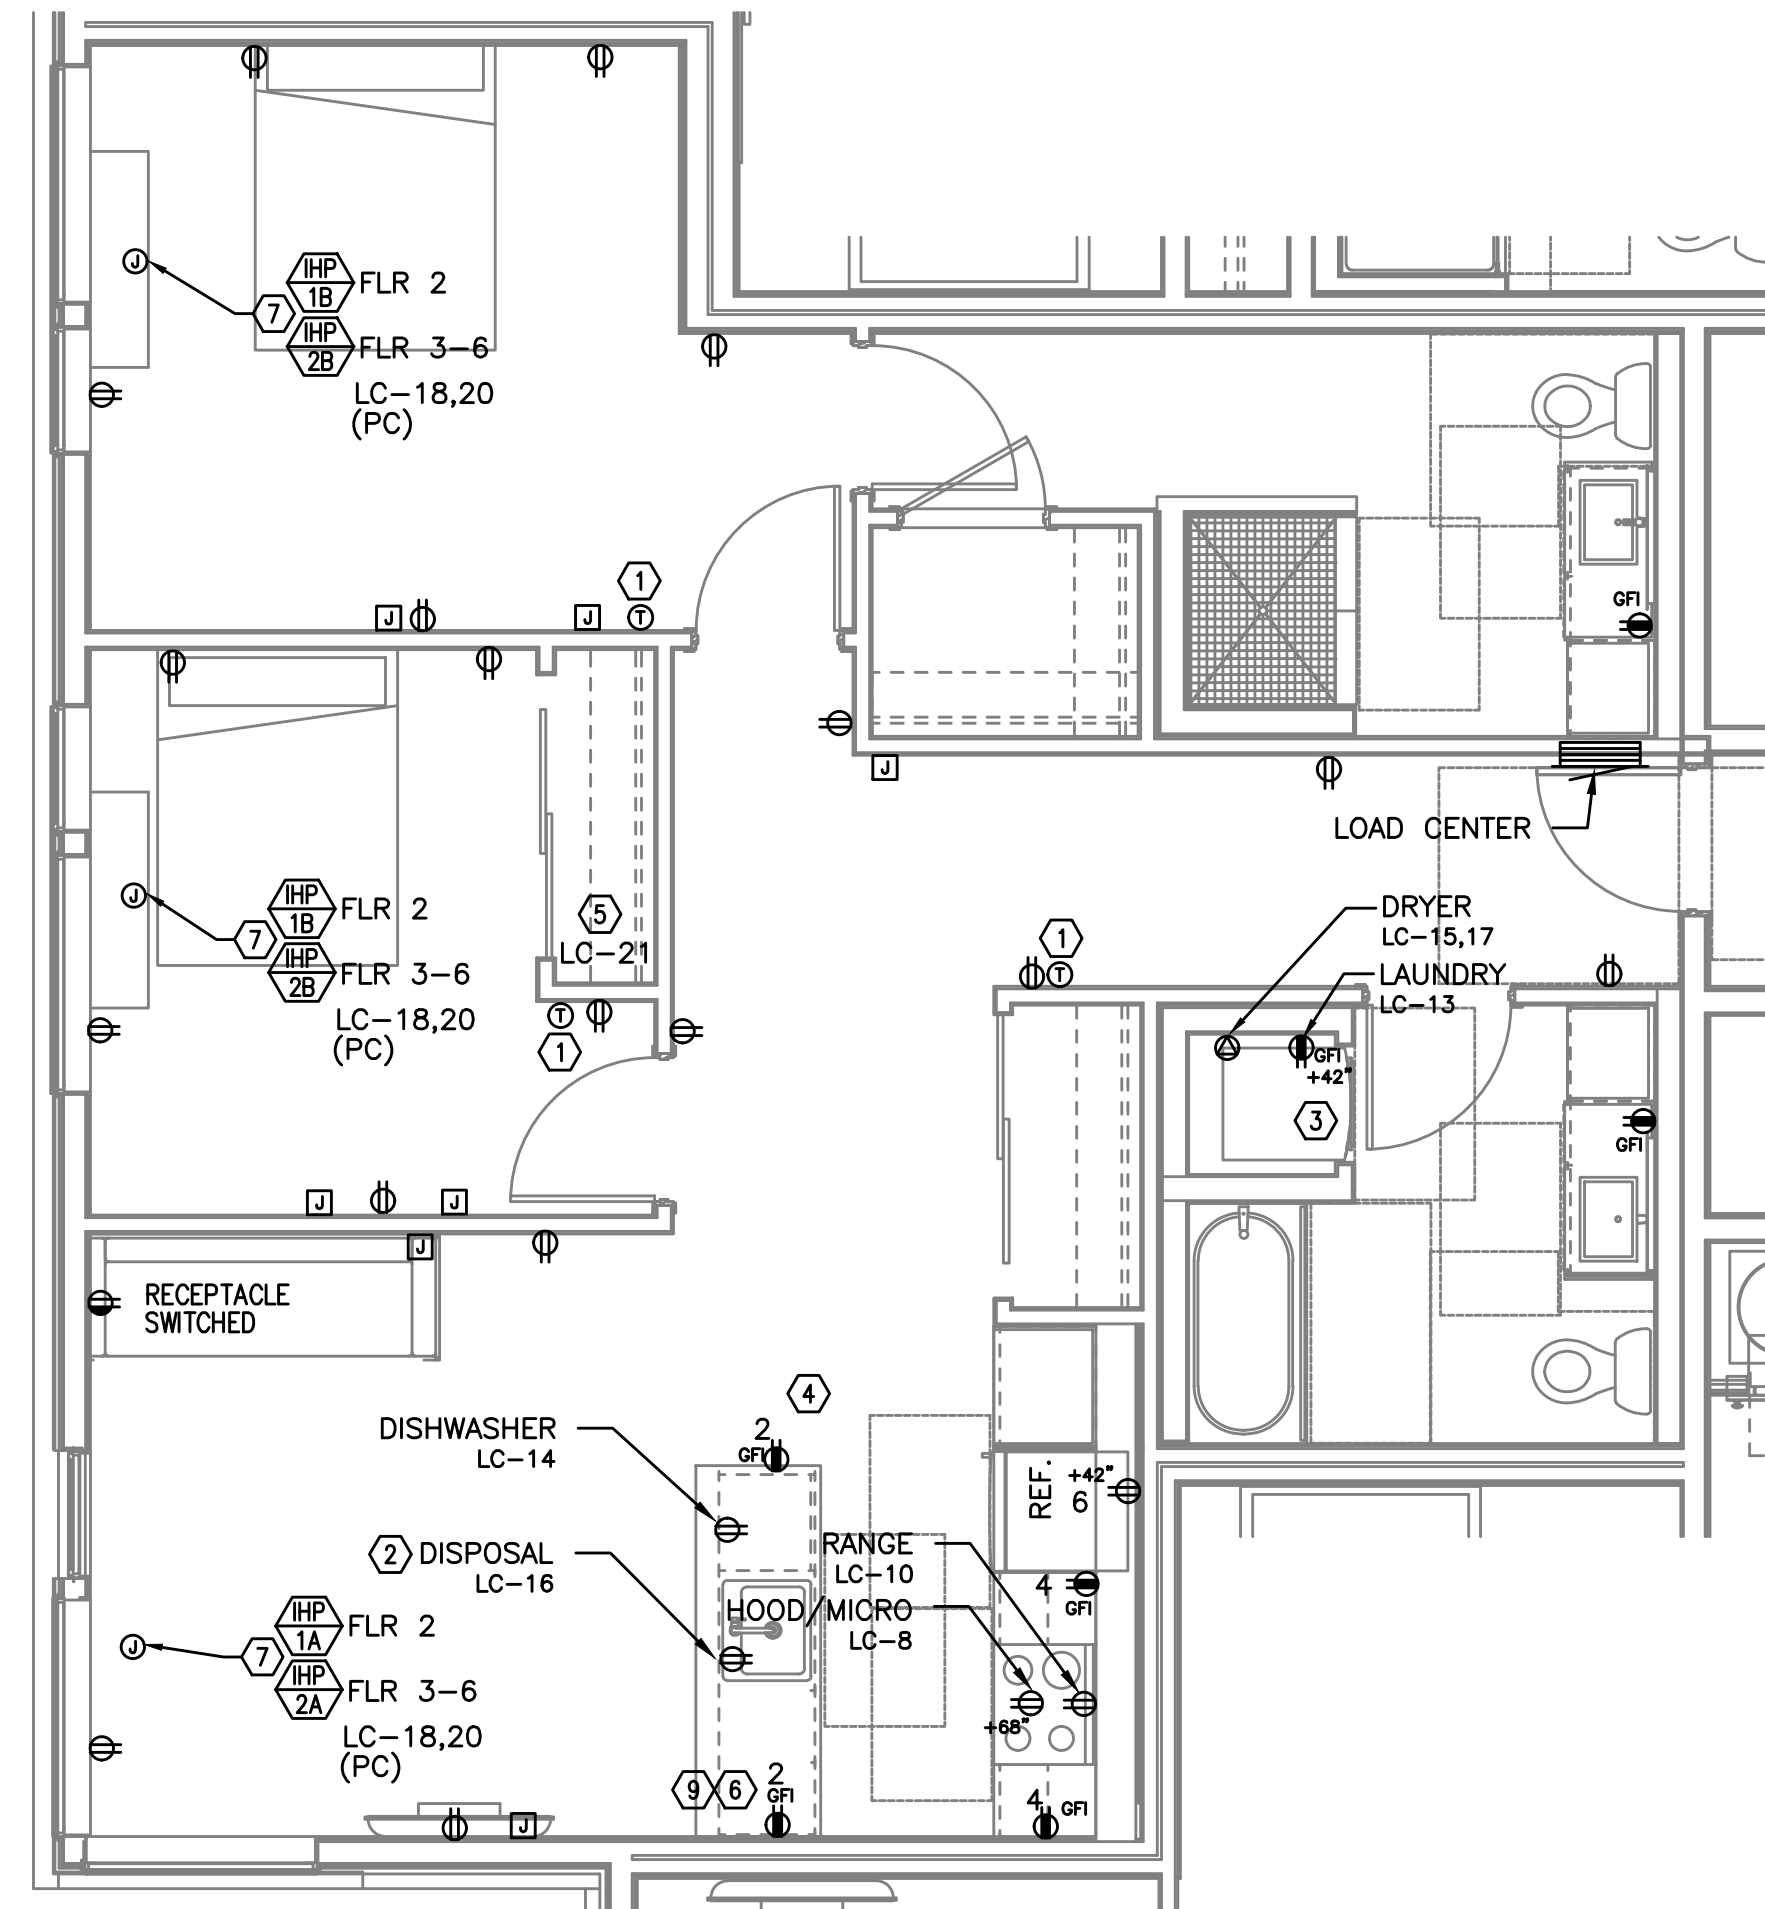

3
E4.16

TYPICAL UNIT TYPE CC
2 BED/2 BATH – POWER PLAN
SCALE: 1/4" = 1'-0"

NOTE:

REFER TO SHEET E4.11 FOR GENERAL AND KEYED POWER NOTES.

M
F
A
INC.

Consulting Engineers
2007 S.E. Ash St.
Portland, OR 97214
PHN: (503) 234-0548
FAX: (503) 234-0677
CONTACT: DENISE TAYLOR

PRELIMINARY
NOT FOR
CONSTRUCTION

IN THE EVENT CONFLICTS ARE DISCOVERED
BETWEEN THE ORIGINAL SIGNED AND SEALED
DOCUMENTS PREPARED BY THE ARCHITECTS
AND/OR THEIR CONSULTANTS, AND ANY COPY OF
THE DOCUMENTS TRANSMITTED BY MAIL, FAX,
ELECTRONICALLY OR OTHERWISE, THE ORIGINAL
SIGNED AND SEALED DOCUMENTS SHALL GOVERN.

PROJECT # 2017-053
DATE: 11/19/2021

REVISIONS


AEGIS - PHASE II
MIXED-USE DEVELOPMENT
312 E EVERGREEN BOULEVARD, VANCOUVER, WA 98660

SHEET:


E4.16

PRELIMINARY
NOT FOR
CONSTRUCTIONIN THE EVENT CONFLICTS ARE DISCOVERED
BETWEEN THE ORIGINAL SIGNED AND SEALED
DOCUMENTS PREPARED BY THE ARCHITECTS
AND/OR THEIR CONSULTANTS, AND ANY COPY OF
THE DOCUMENTS TRANSMITTED BY MAIL, FAX,
ELECTRONICALLY OR OTHERWISE, THE ORIGINAL
SIGNED AND SEALED DOCUMENTS SHALL GOVERN.PROJECT # 2017-053
DATE: 11/19/2021


REVISIONS

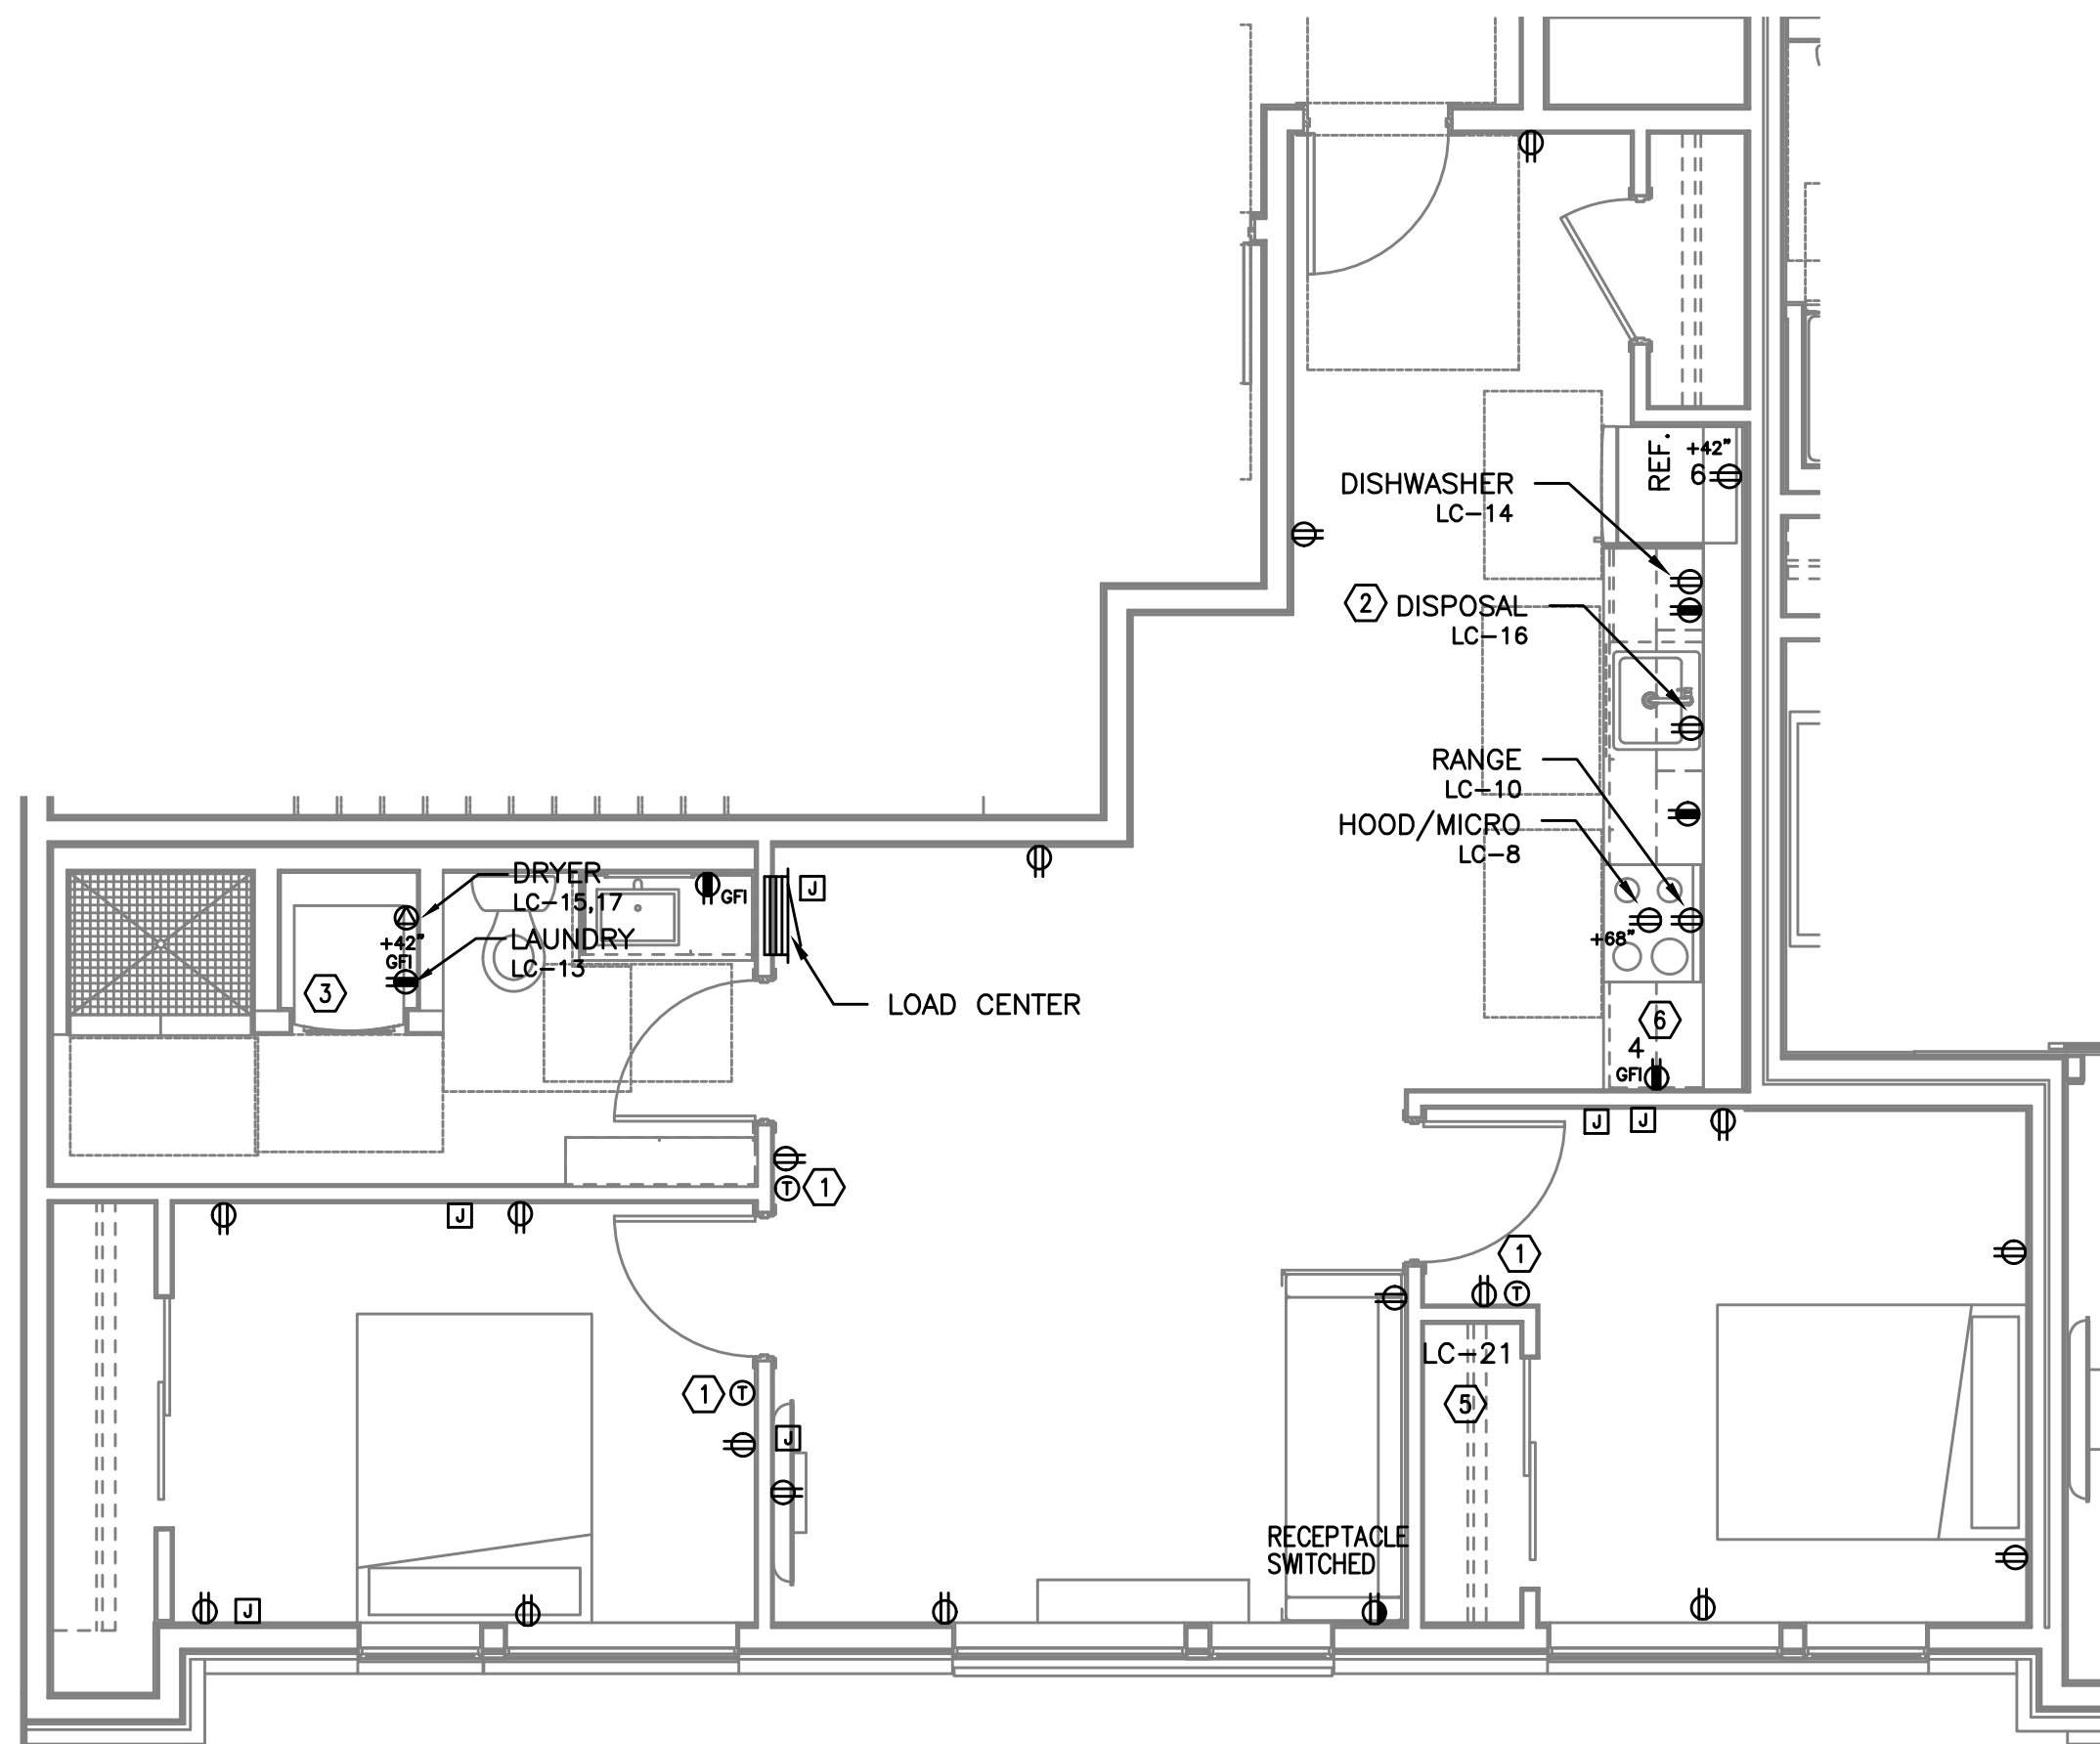AEGIS - PHASE II
MIXED-USE DEVELOPMENT
312 E EVERGREEN BOULEVARD, VANCOUVER, WA 98660


1
E4.17
TYPICAL UNIT TYPE DD
2 BED/1 BATH - POWER PLAN
SCALE: 1/4" = 1'-0"

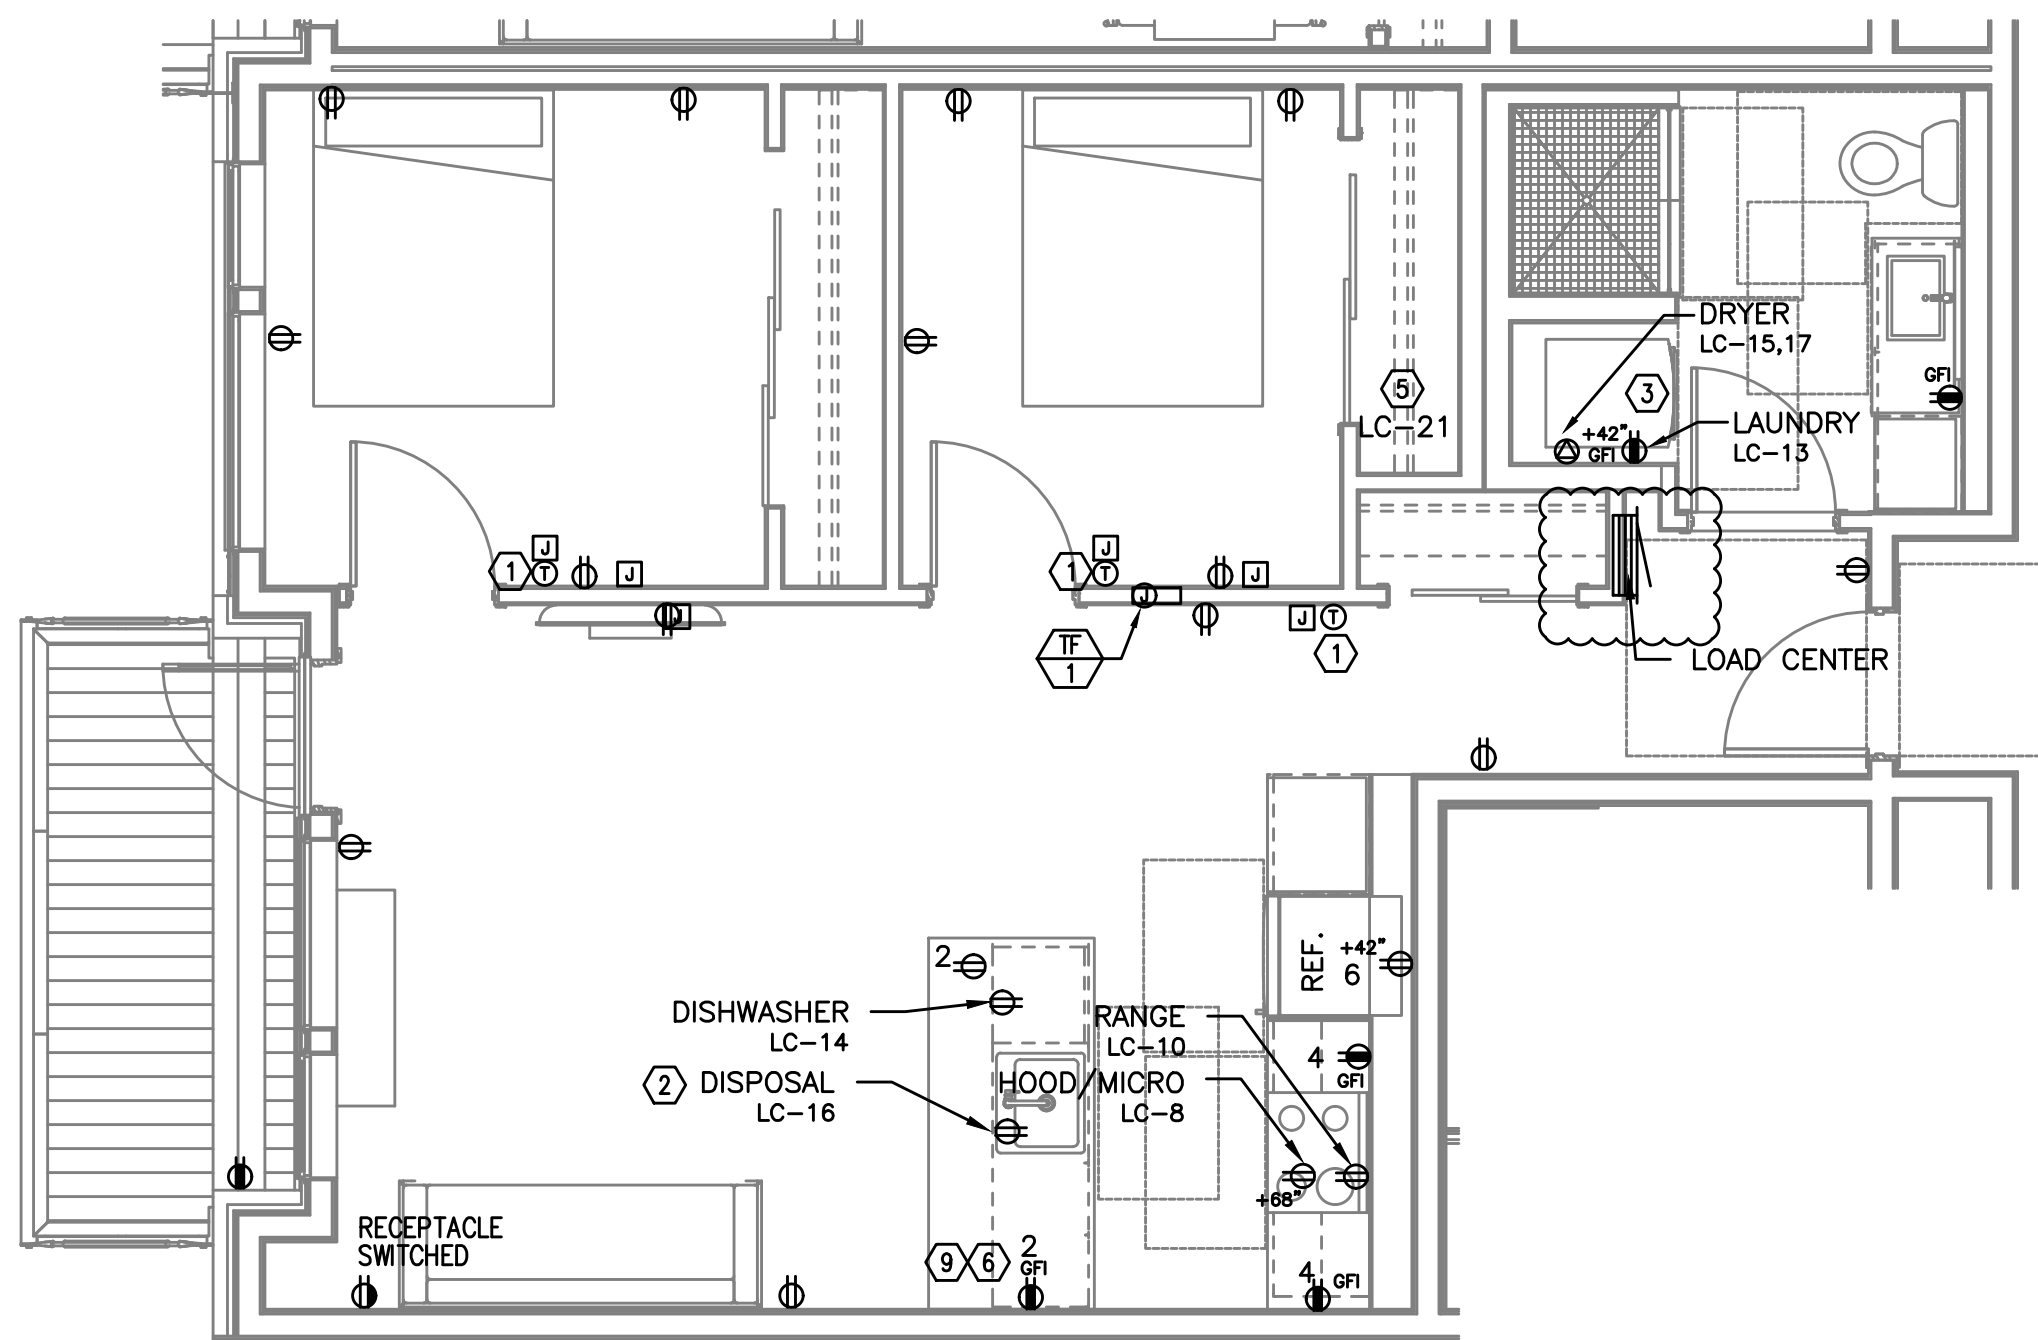

2
E4.17
TYPICAL UNIT TYPE EE
1 BED/1 BATH - POWER PLAN
SCALE: 1/4" = 1'-0"

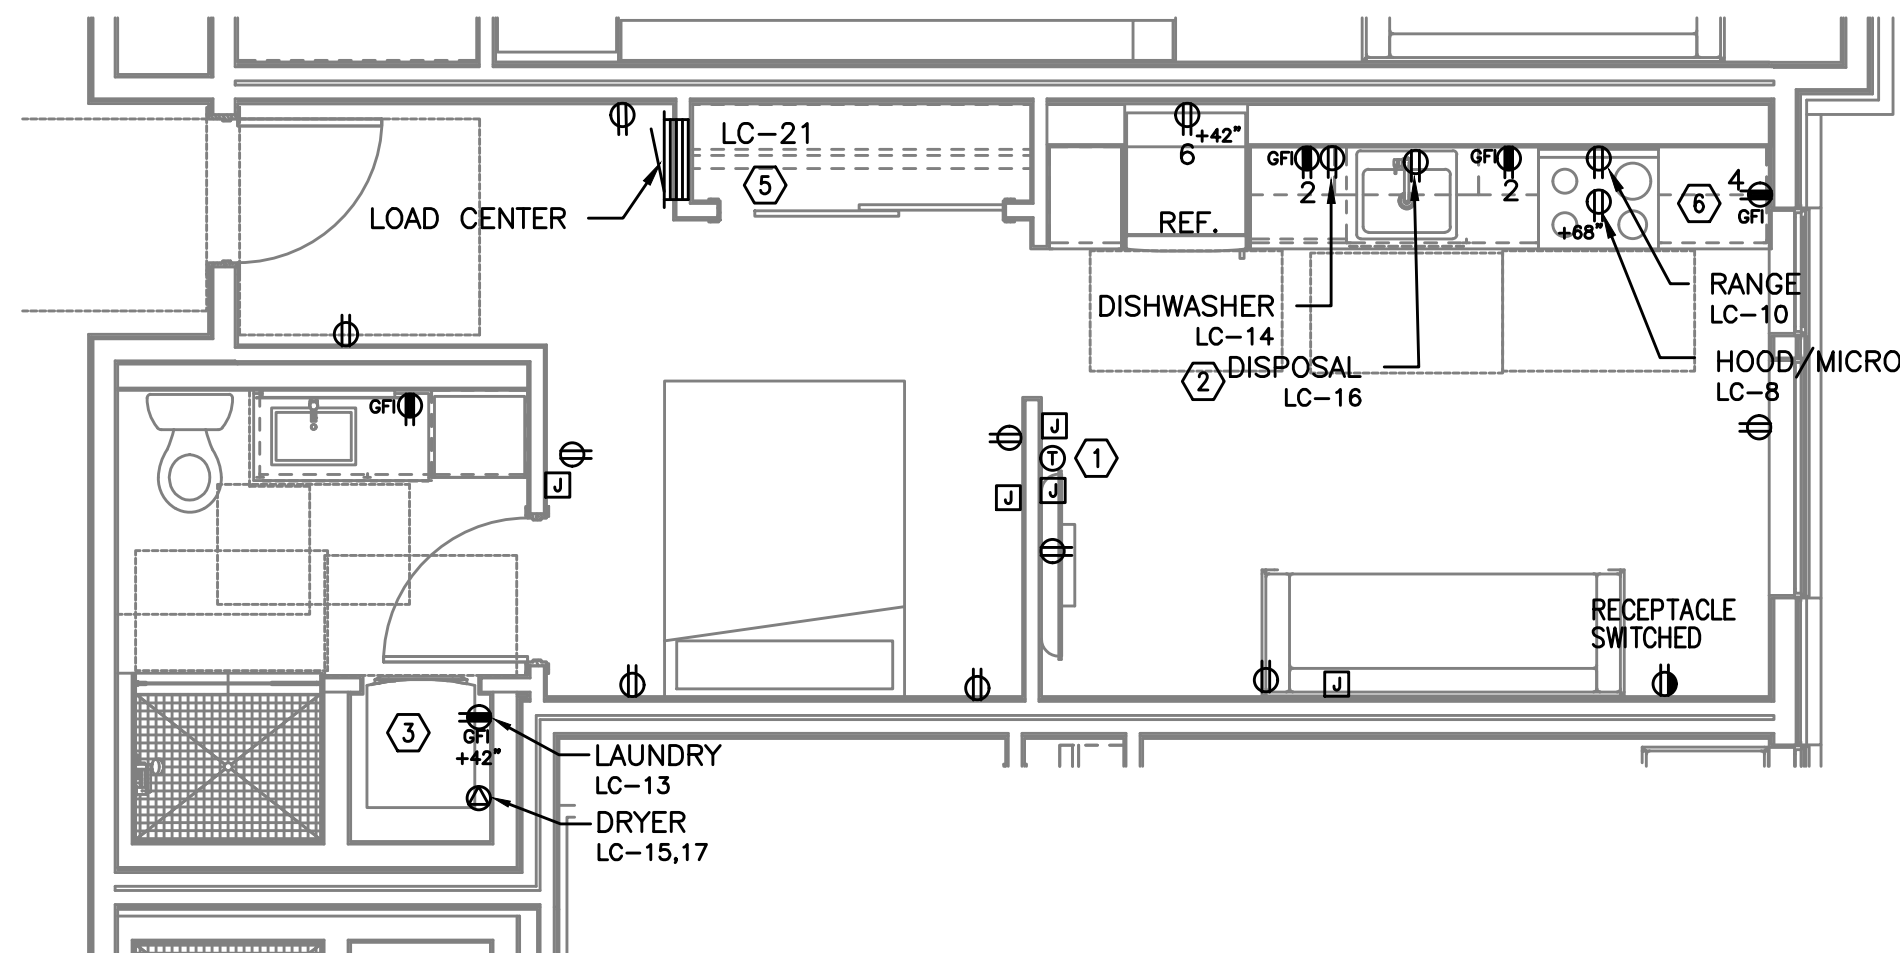


3
E4.17
TYPICAL UNIT TYPE FF
0 BED/1 BATH - POWER PLAN
SCALE: 1/4" = 1'-0"

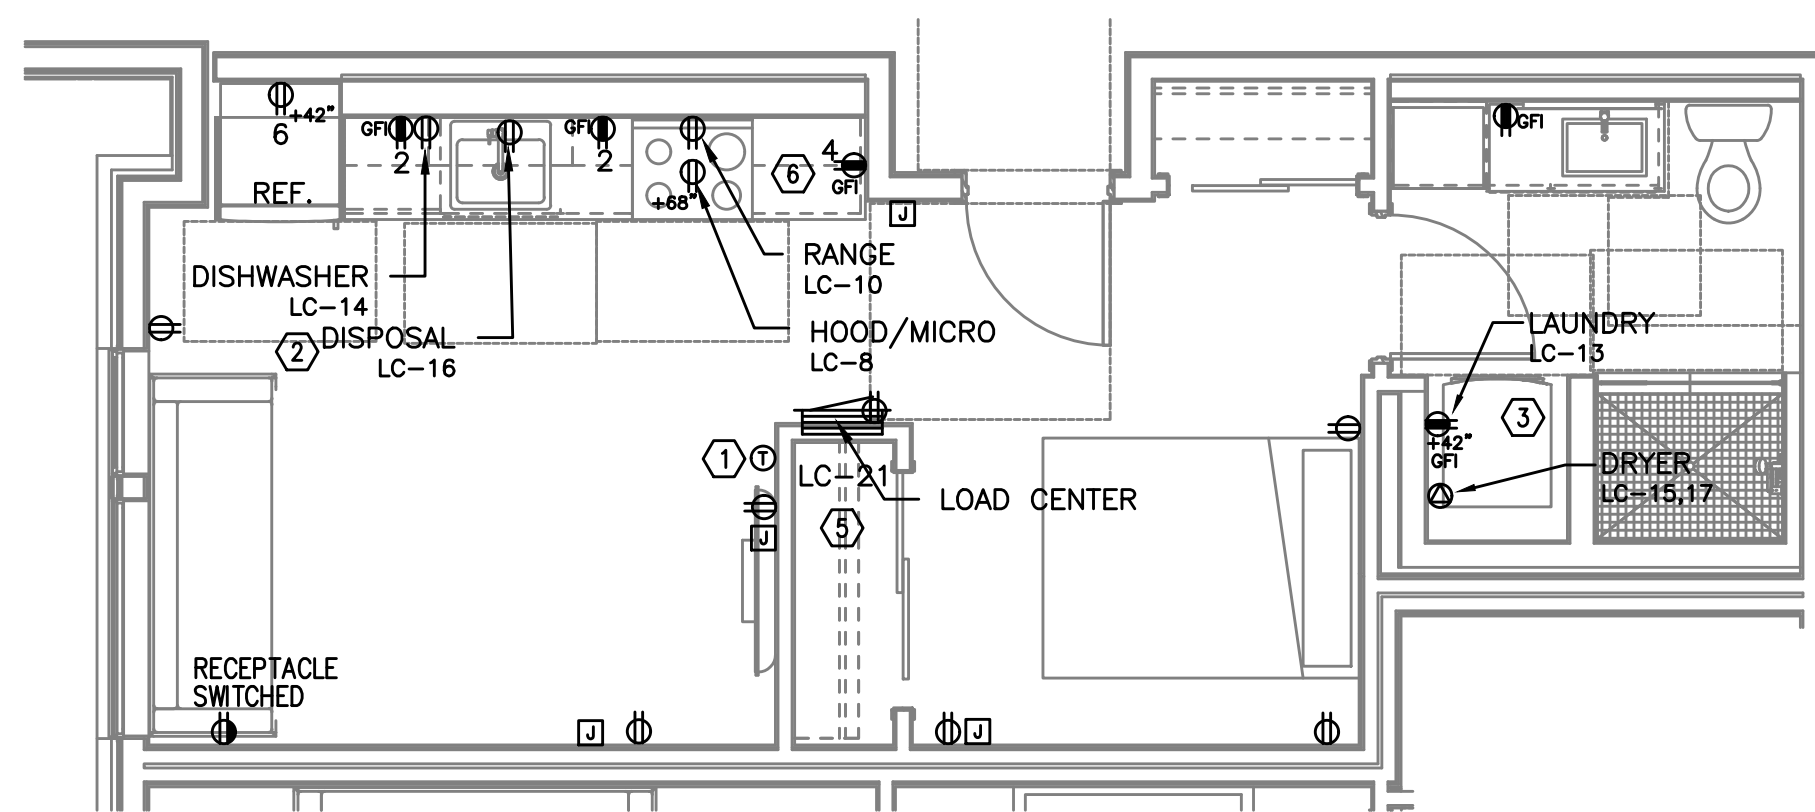

4
E4.17
TYPICAL UNIT TYPE GG
0 BED/1 BATH - POWER PLAN
SCALE: 1/4" = 1'-0"


NOTE:

REFER TO SHEET E4.11 FOR GENERAL AND KEYED POWER NOTES.

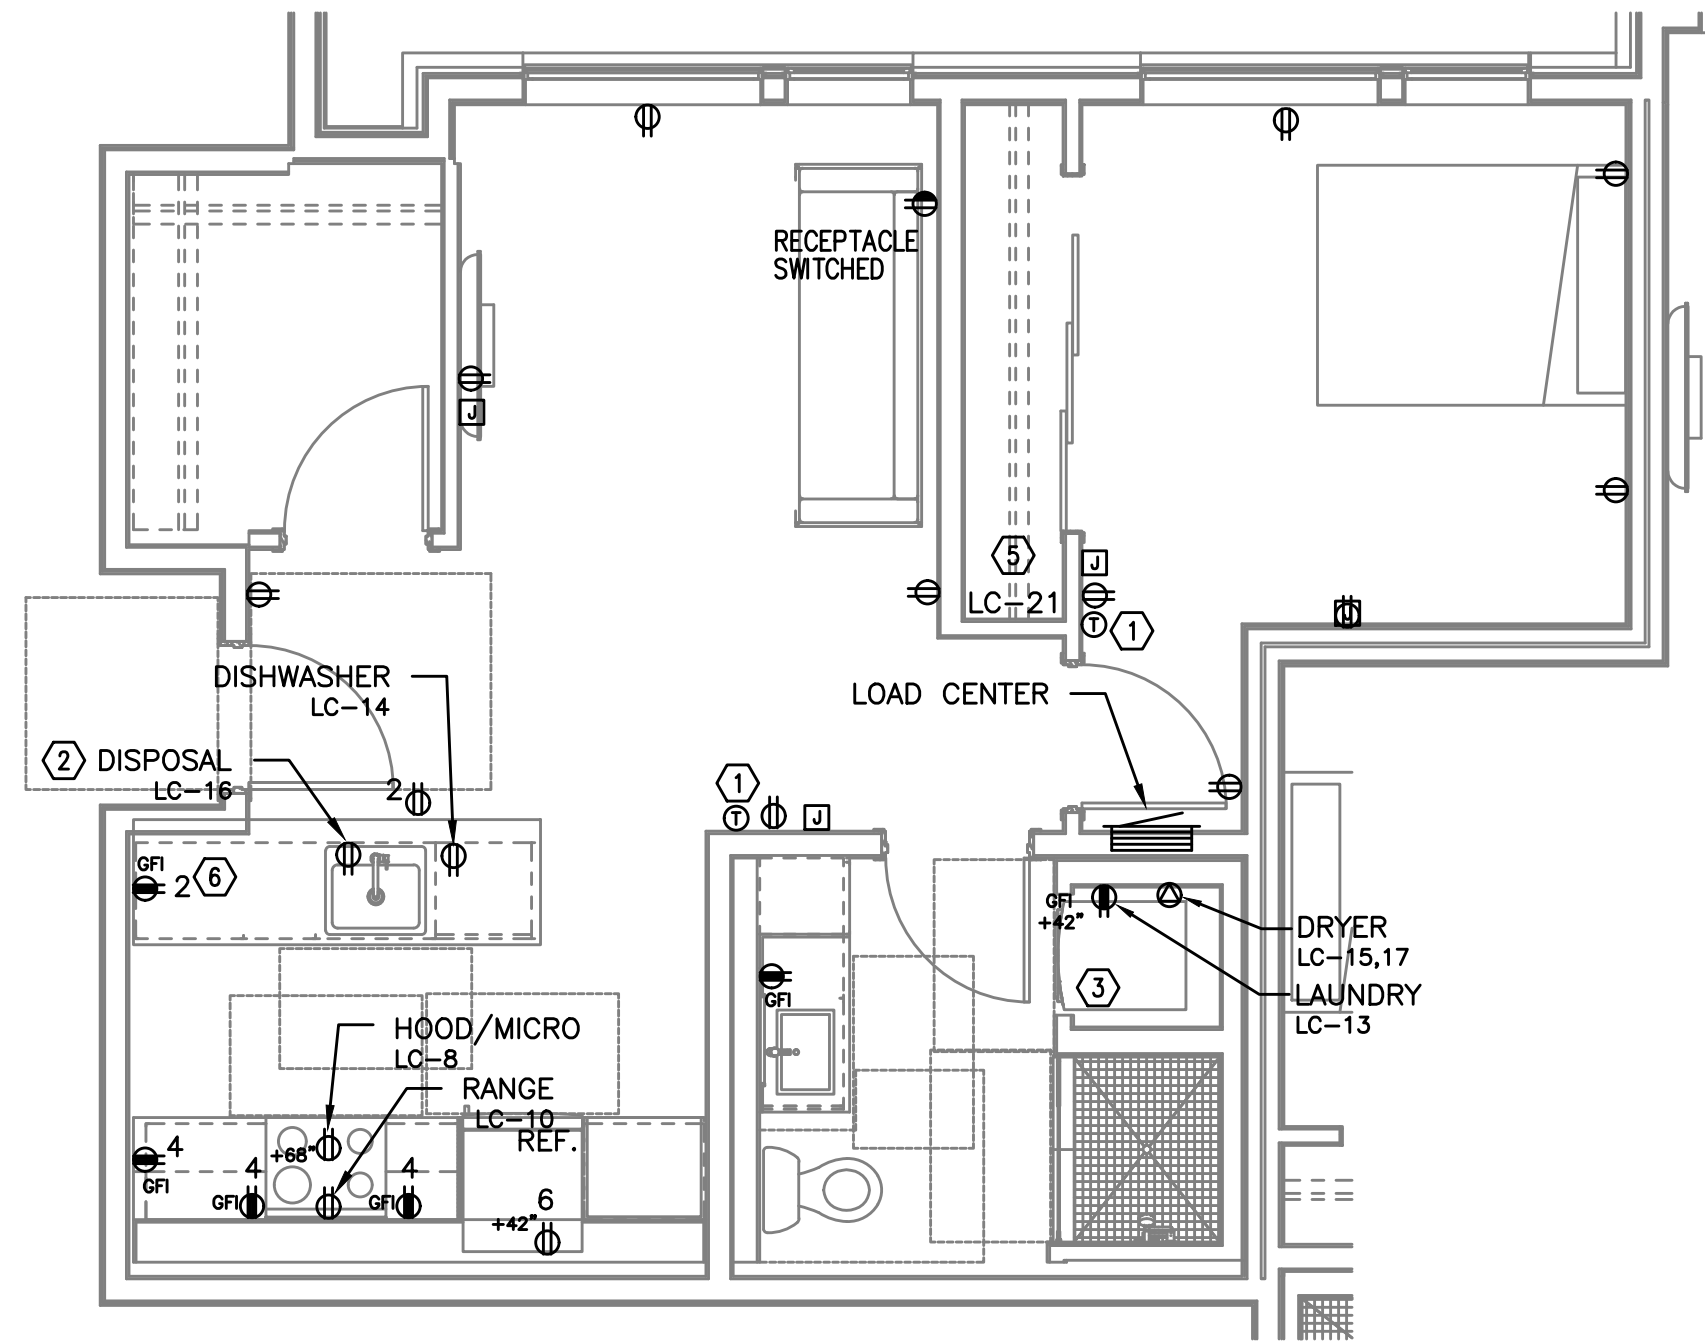


1
E4.18

TYPICAL UNIT TYPE HH
1 BED/1 BATH – POWER PLAN
SCALE: 1/4" = 1'-0"

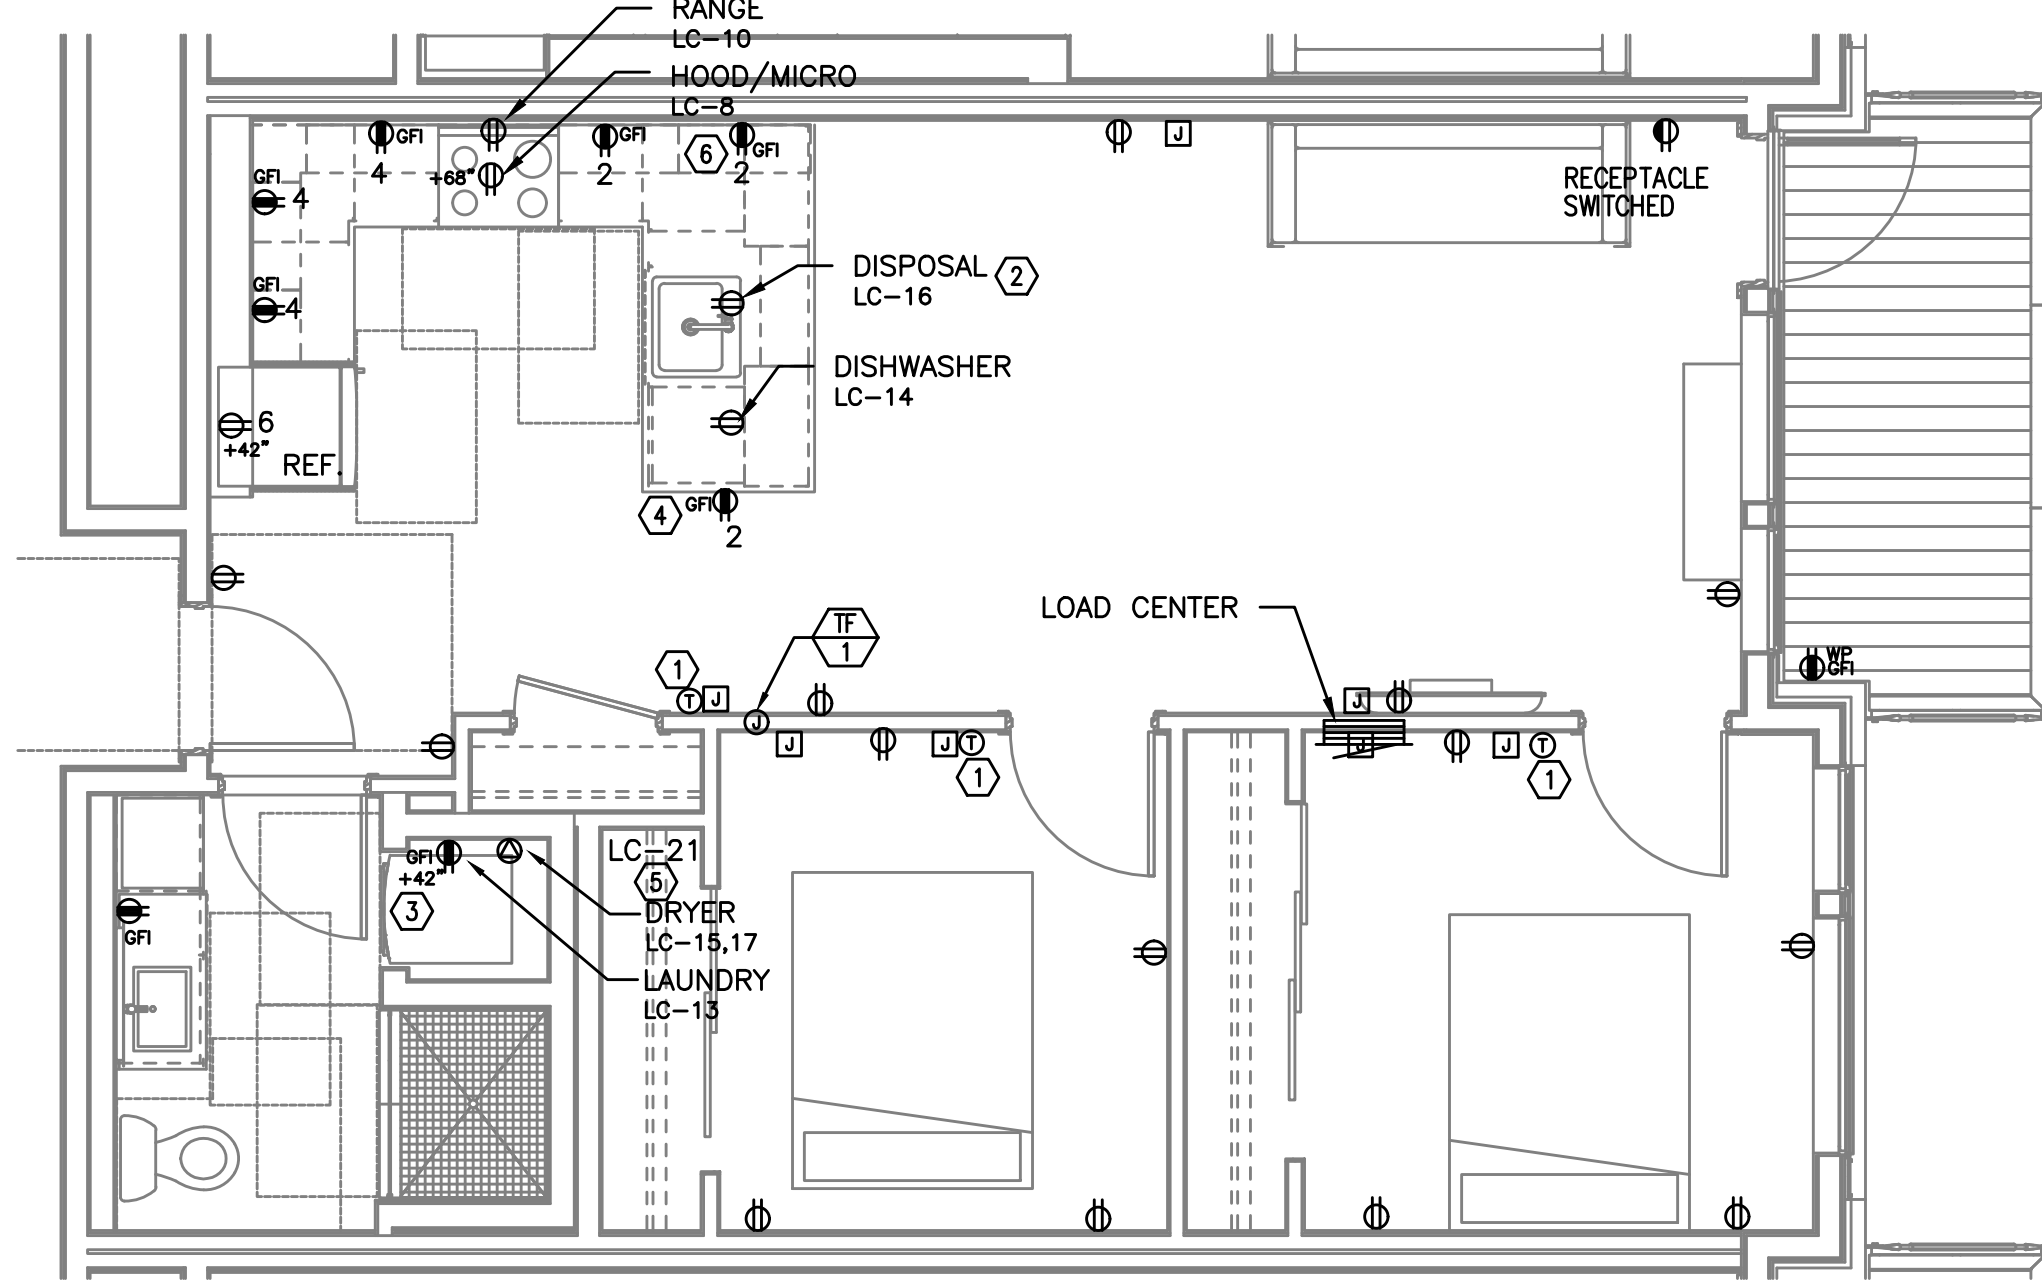

2
E4.18

TYPICAL UNIT TYPE II
2 BED/1 BATH – POWER PLAN
SCALE: 1/4" = 1'-0"

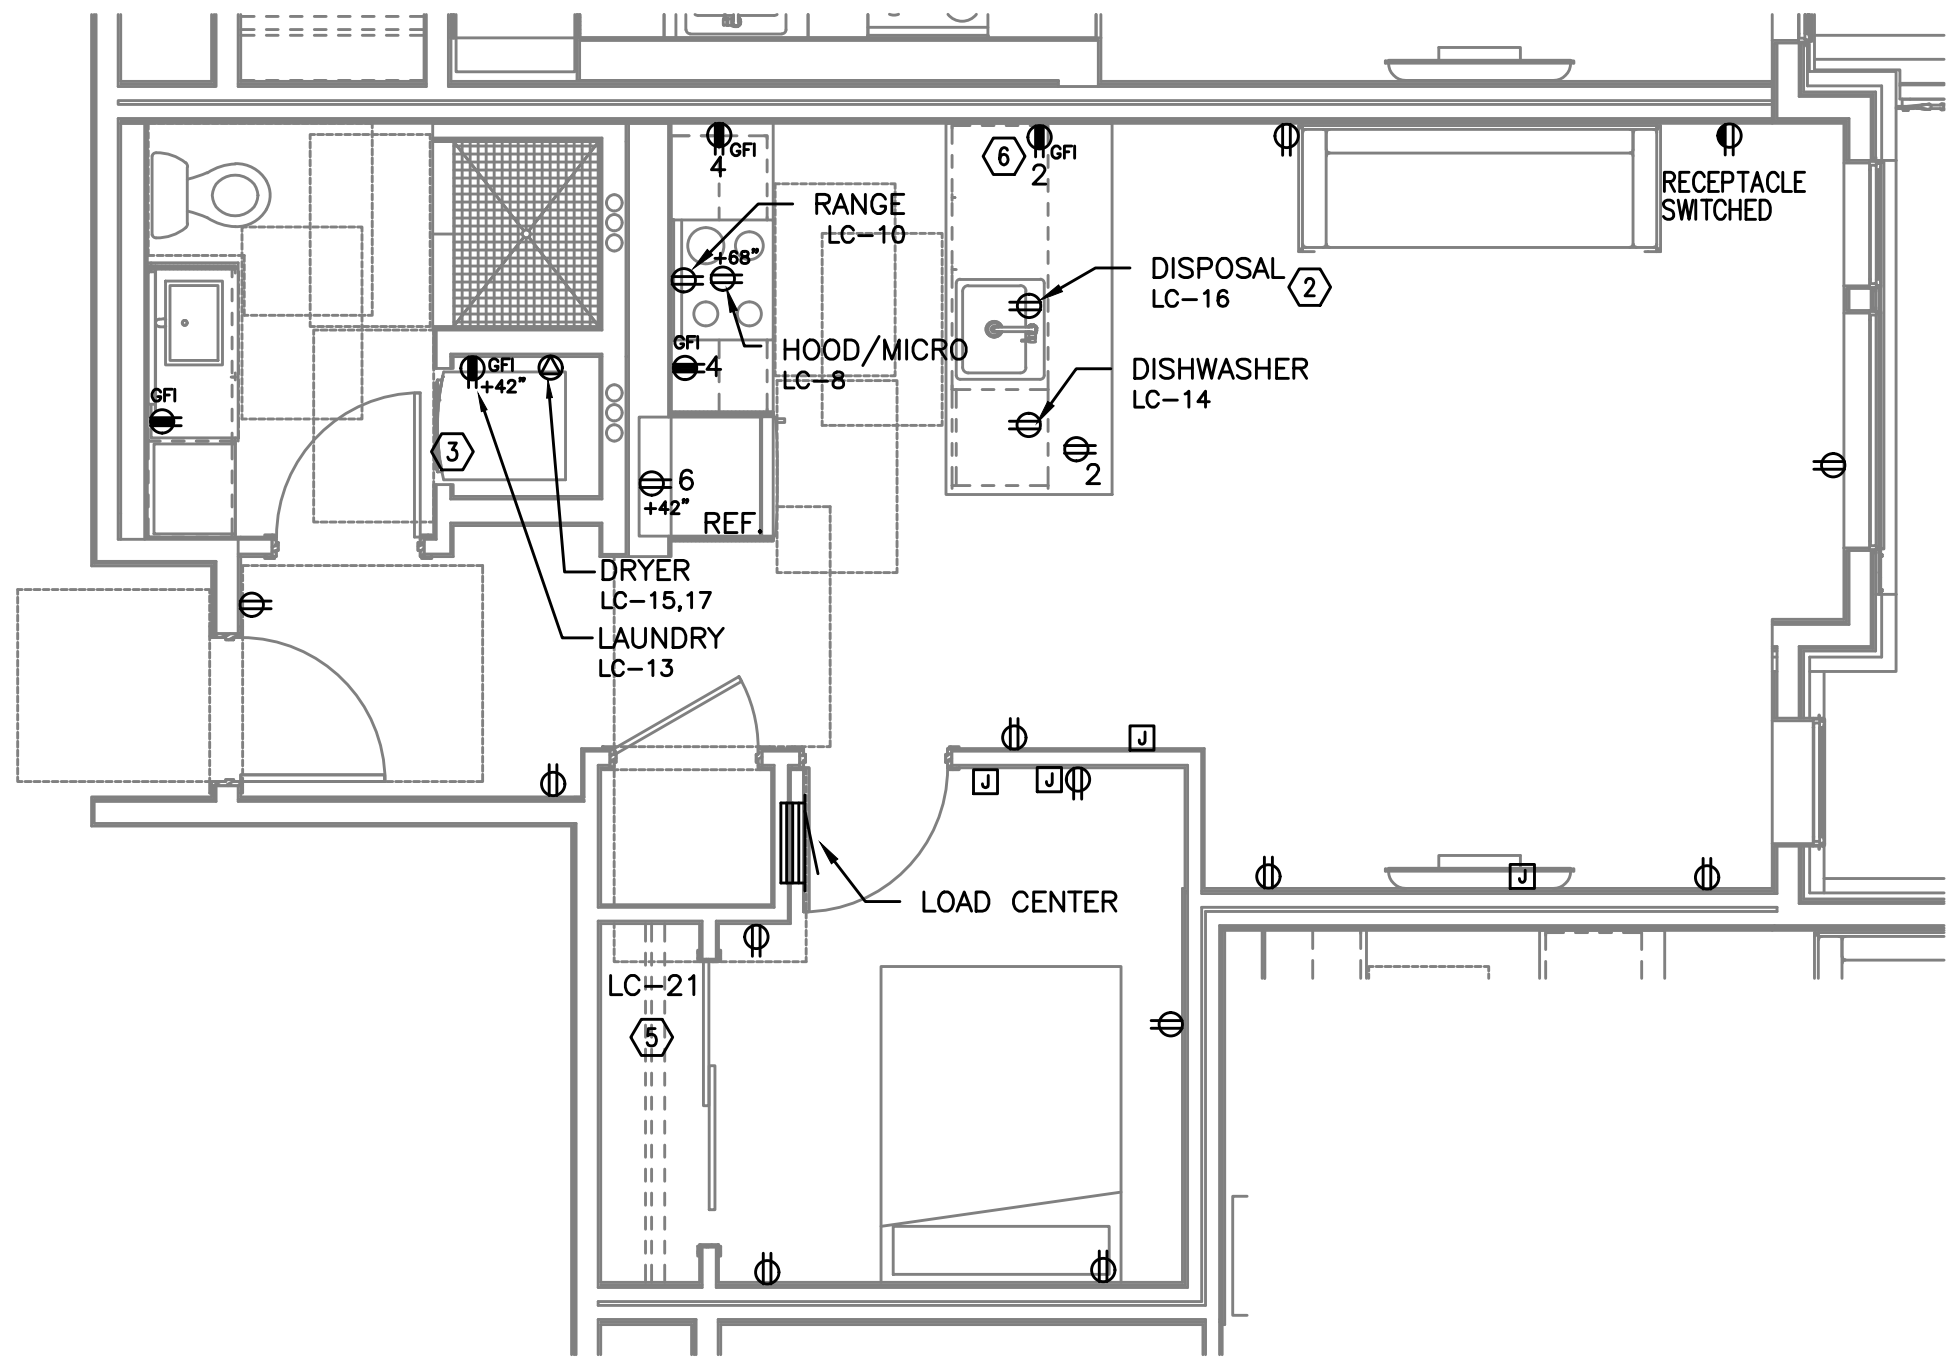

3
E4.18

TYPICAL UNIT TYPE JJ
1 BED/1 BATH – POWER PLAN
SCALE: 1/4" = 1'-0"

NOTE:
REFER TO SHEET E4.11 FOR GENERAL AND KEYED POWER NOTES.

M
F
A
INC.

Consulting Engineers
2007 S.E. Ash St.
Portland, OR 97214
PHN: (503) 234-0548
FAX: (503) 234-0677
WWW.MFIA-ENG.COM
CONTACT: DENISE TAYLOR

STUDIO
3
ARCHITECTURE
INCORPORATED

275 COURT ST. NE
SALEM, OR 97301-3442
P: 503.390.6500
www.studio3architecture.com

PRELIMINARY
NOT FOR
CONSTRUCTION

IN THE EVENT CONFLICTS ARE DISCOVERED
BETWEEN THE ORIGINAL SIGNED AND SEALED
DOCUMENTS PREPARED BY THE ARCHITECTS
AND/OR THEIR CONSULTANTS, AND ANY COPY OF
THE DOCUMENTS TRANSMITTED BY MAIL, FAX,
ELECTRONICALLY OR OTHERWISE, THE ORIGINAL
SIGNED AND SEALED DOCUMENTS SHALL GOVERN.

PROJECT # 2017-053
DATE: 11/19/2021

REVISIONS

AEGIS - PHASE II
MIXED-USE DEVELOPMENT
312 E EVERGREEN BOULEVARD, VANCOUVER, WA 98660

SHEET:

E4.18

PRELIMINARY
NOT FOR
CONSTRUCTION

IN THE EVENT CONFLICTS ARE DISCOVERED
BETWEEN THE ORIGINAL SIGNED AND SEALED
DOCUMENTS PREPARED BY THE ARCHITECTS
AND/OR THEIR CONSULTANTS, AND ANY COPY OF
THE DOCUMENTS TRANSMITTED BY MAIL, FAX,
ELECTRONICALLY OR OTHERWISE, THE ORIGINAL
SIGNED AND SEALED DOCUMENTS SHALL GOVERN.

PROJECT # 2017-053
DATE: 11/19/2021


REVISIONS

AEGIS - PHASE II MIXED-USE DEVELOPMENT

312 E EVERGREEN BOULEVARD, VANCOUVER, WA 98660


SHEET:

E4.19

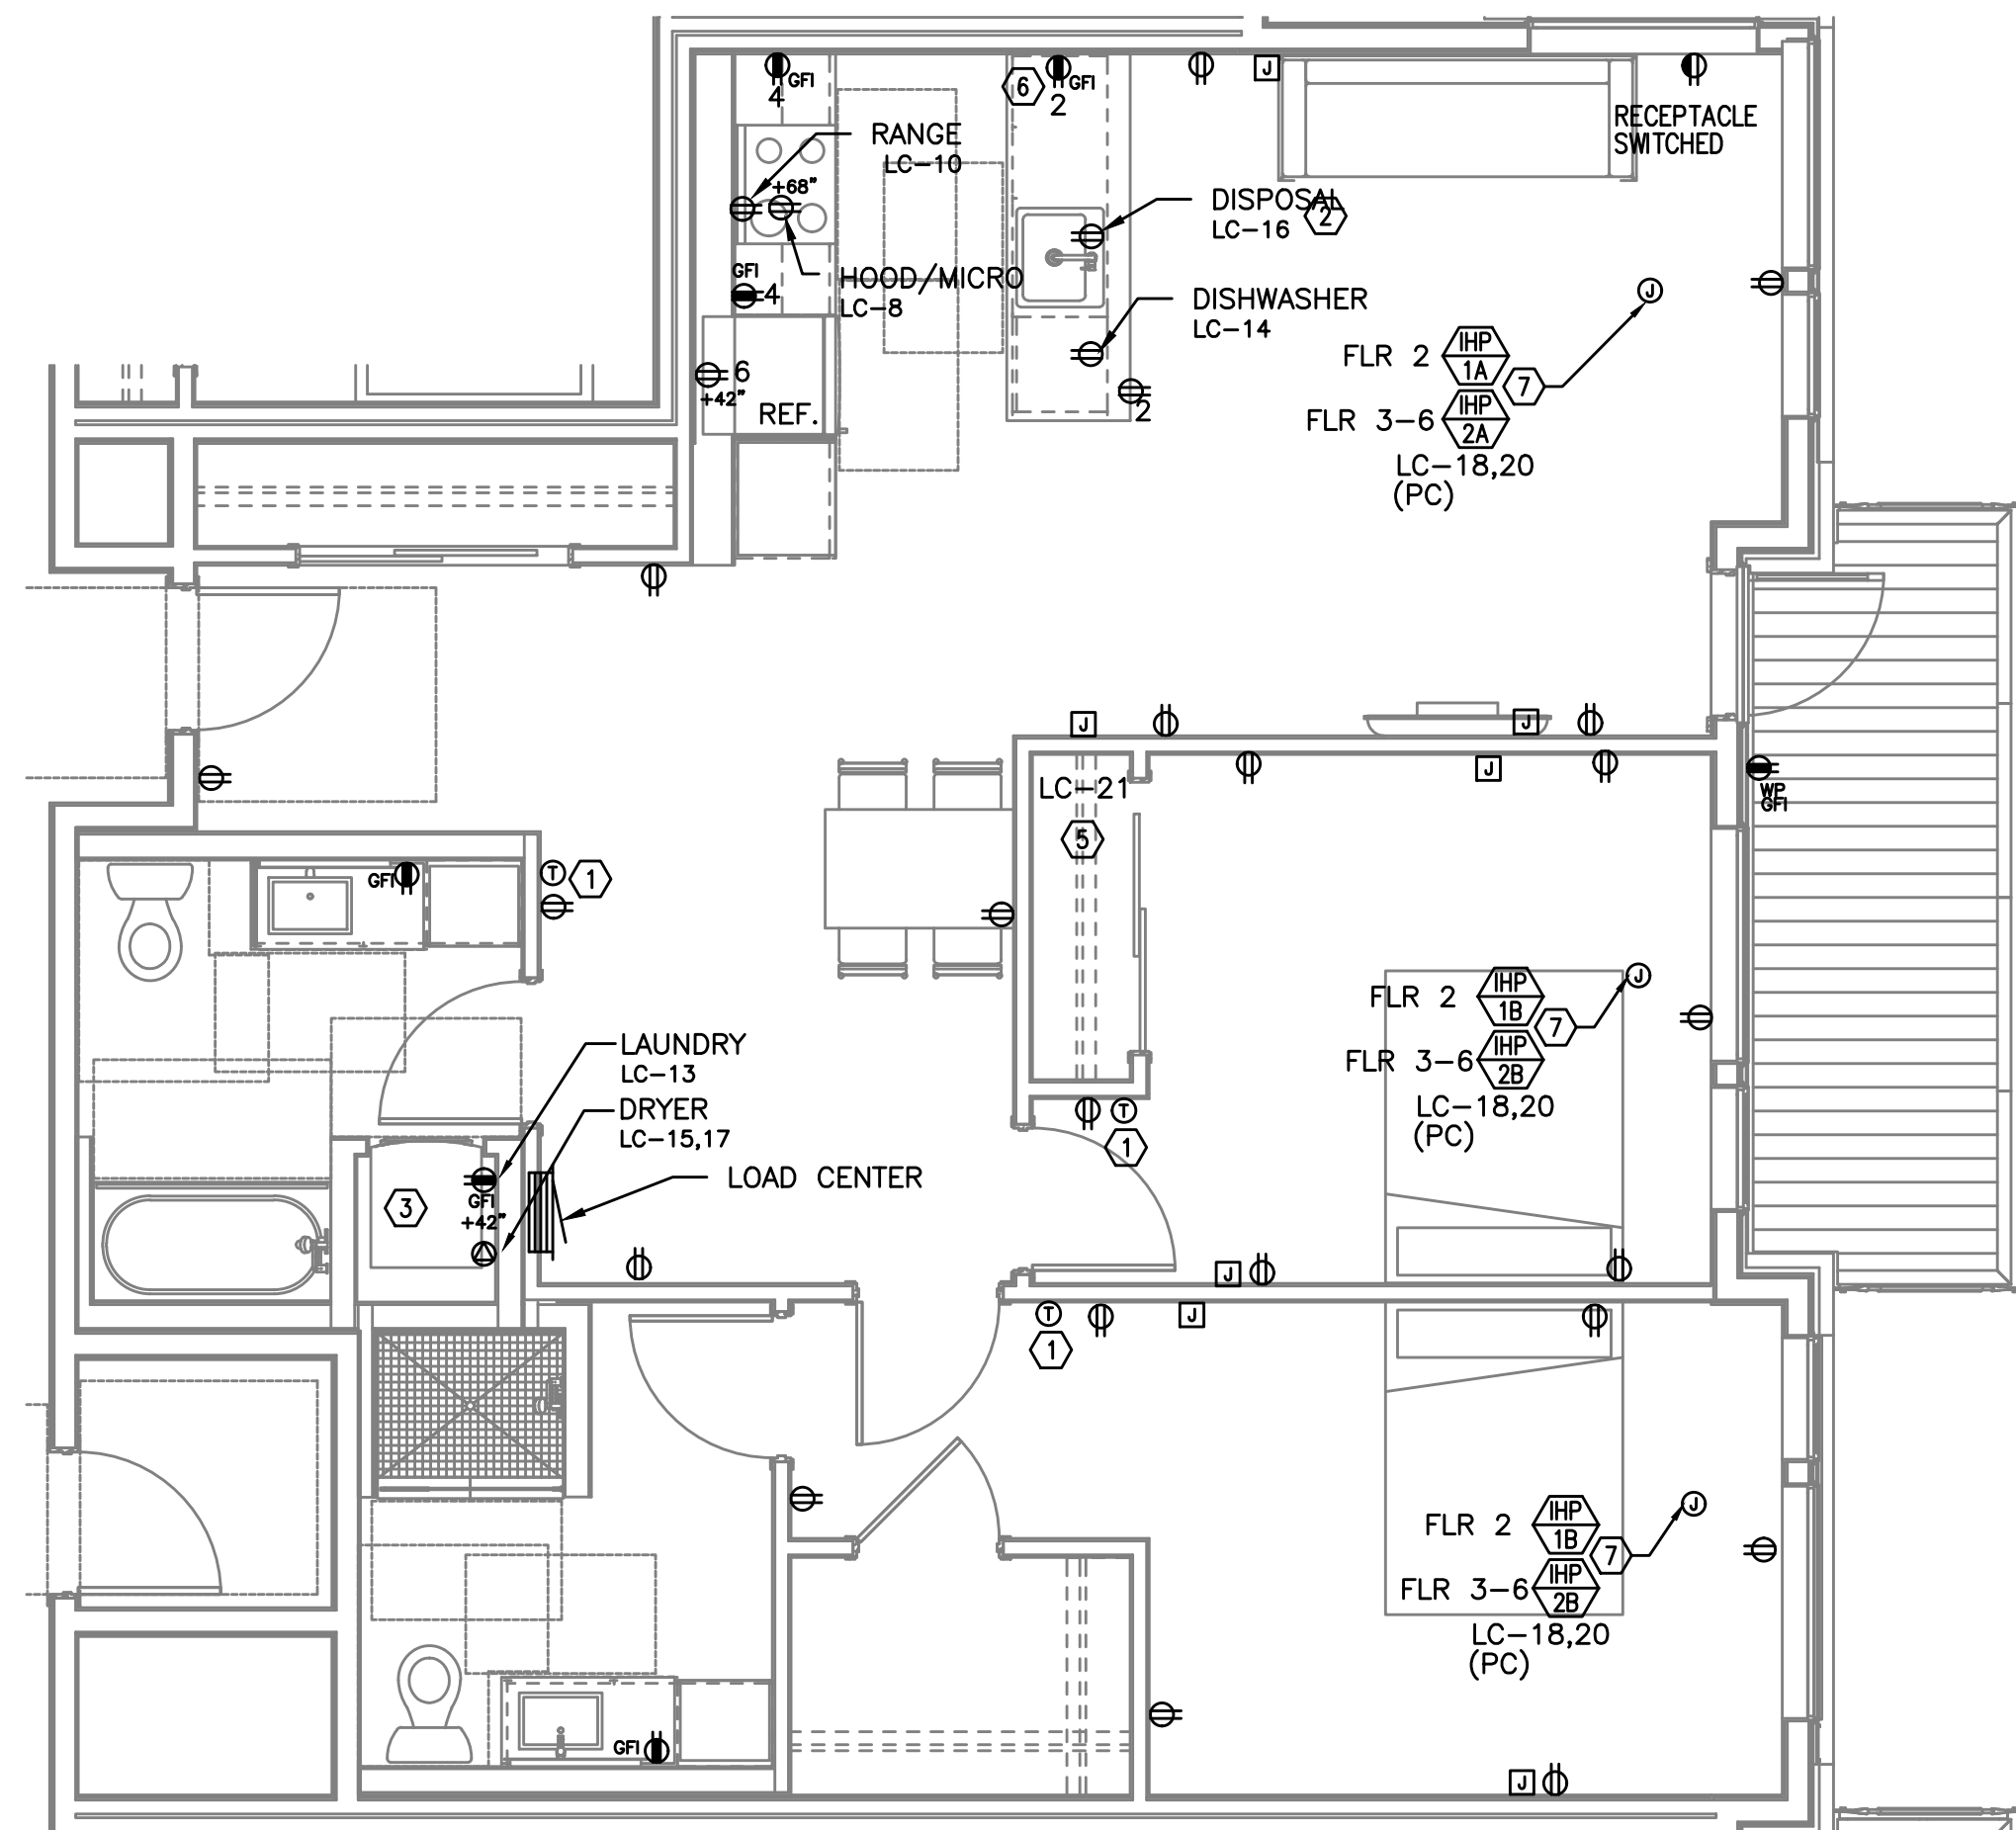

TYPICAL UNIT TYPE KK

1 2 BED/2 BATH - POWER PLAN
E4.19 SCALE: 1/4" = 1'-0"

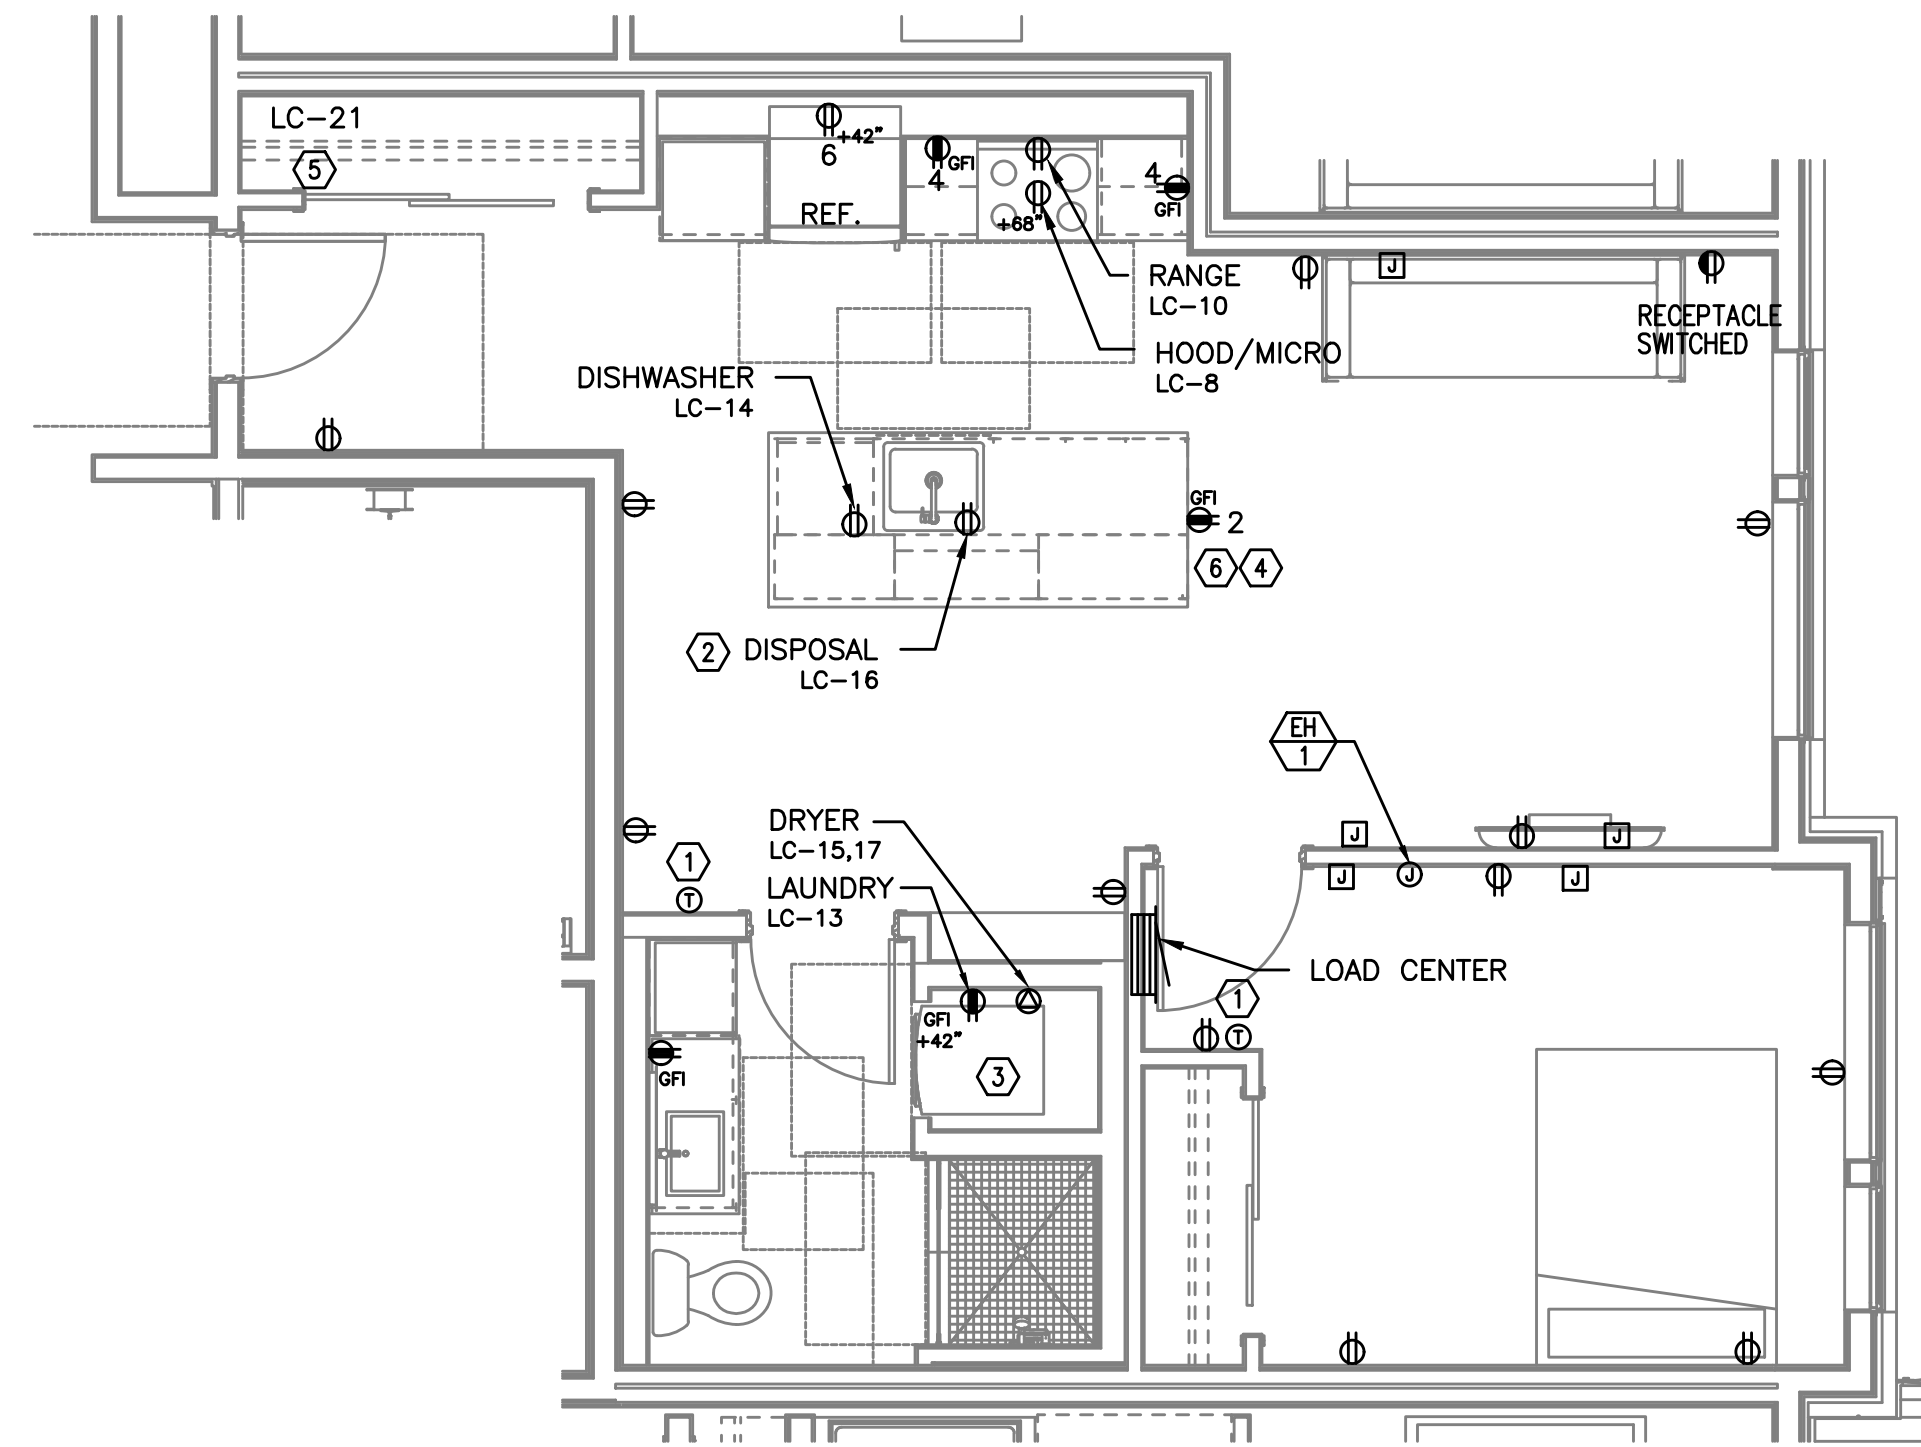

TYPICAL UNIT TYPE LL

2 1 BED/1 BATH - POWER PLAN
E4.19 SCALE: 1/4" = 1'-0"

NOTE:

REFER TO SHEET E4.11 FOR GENERAL AND KEYED POWER NOTES.