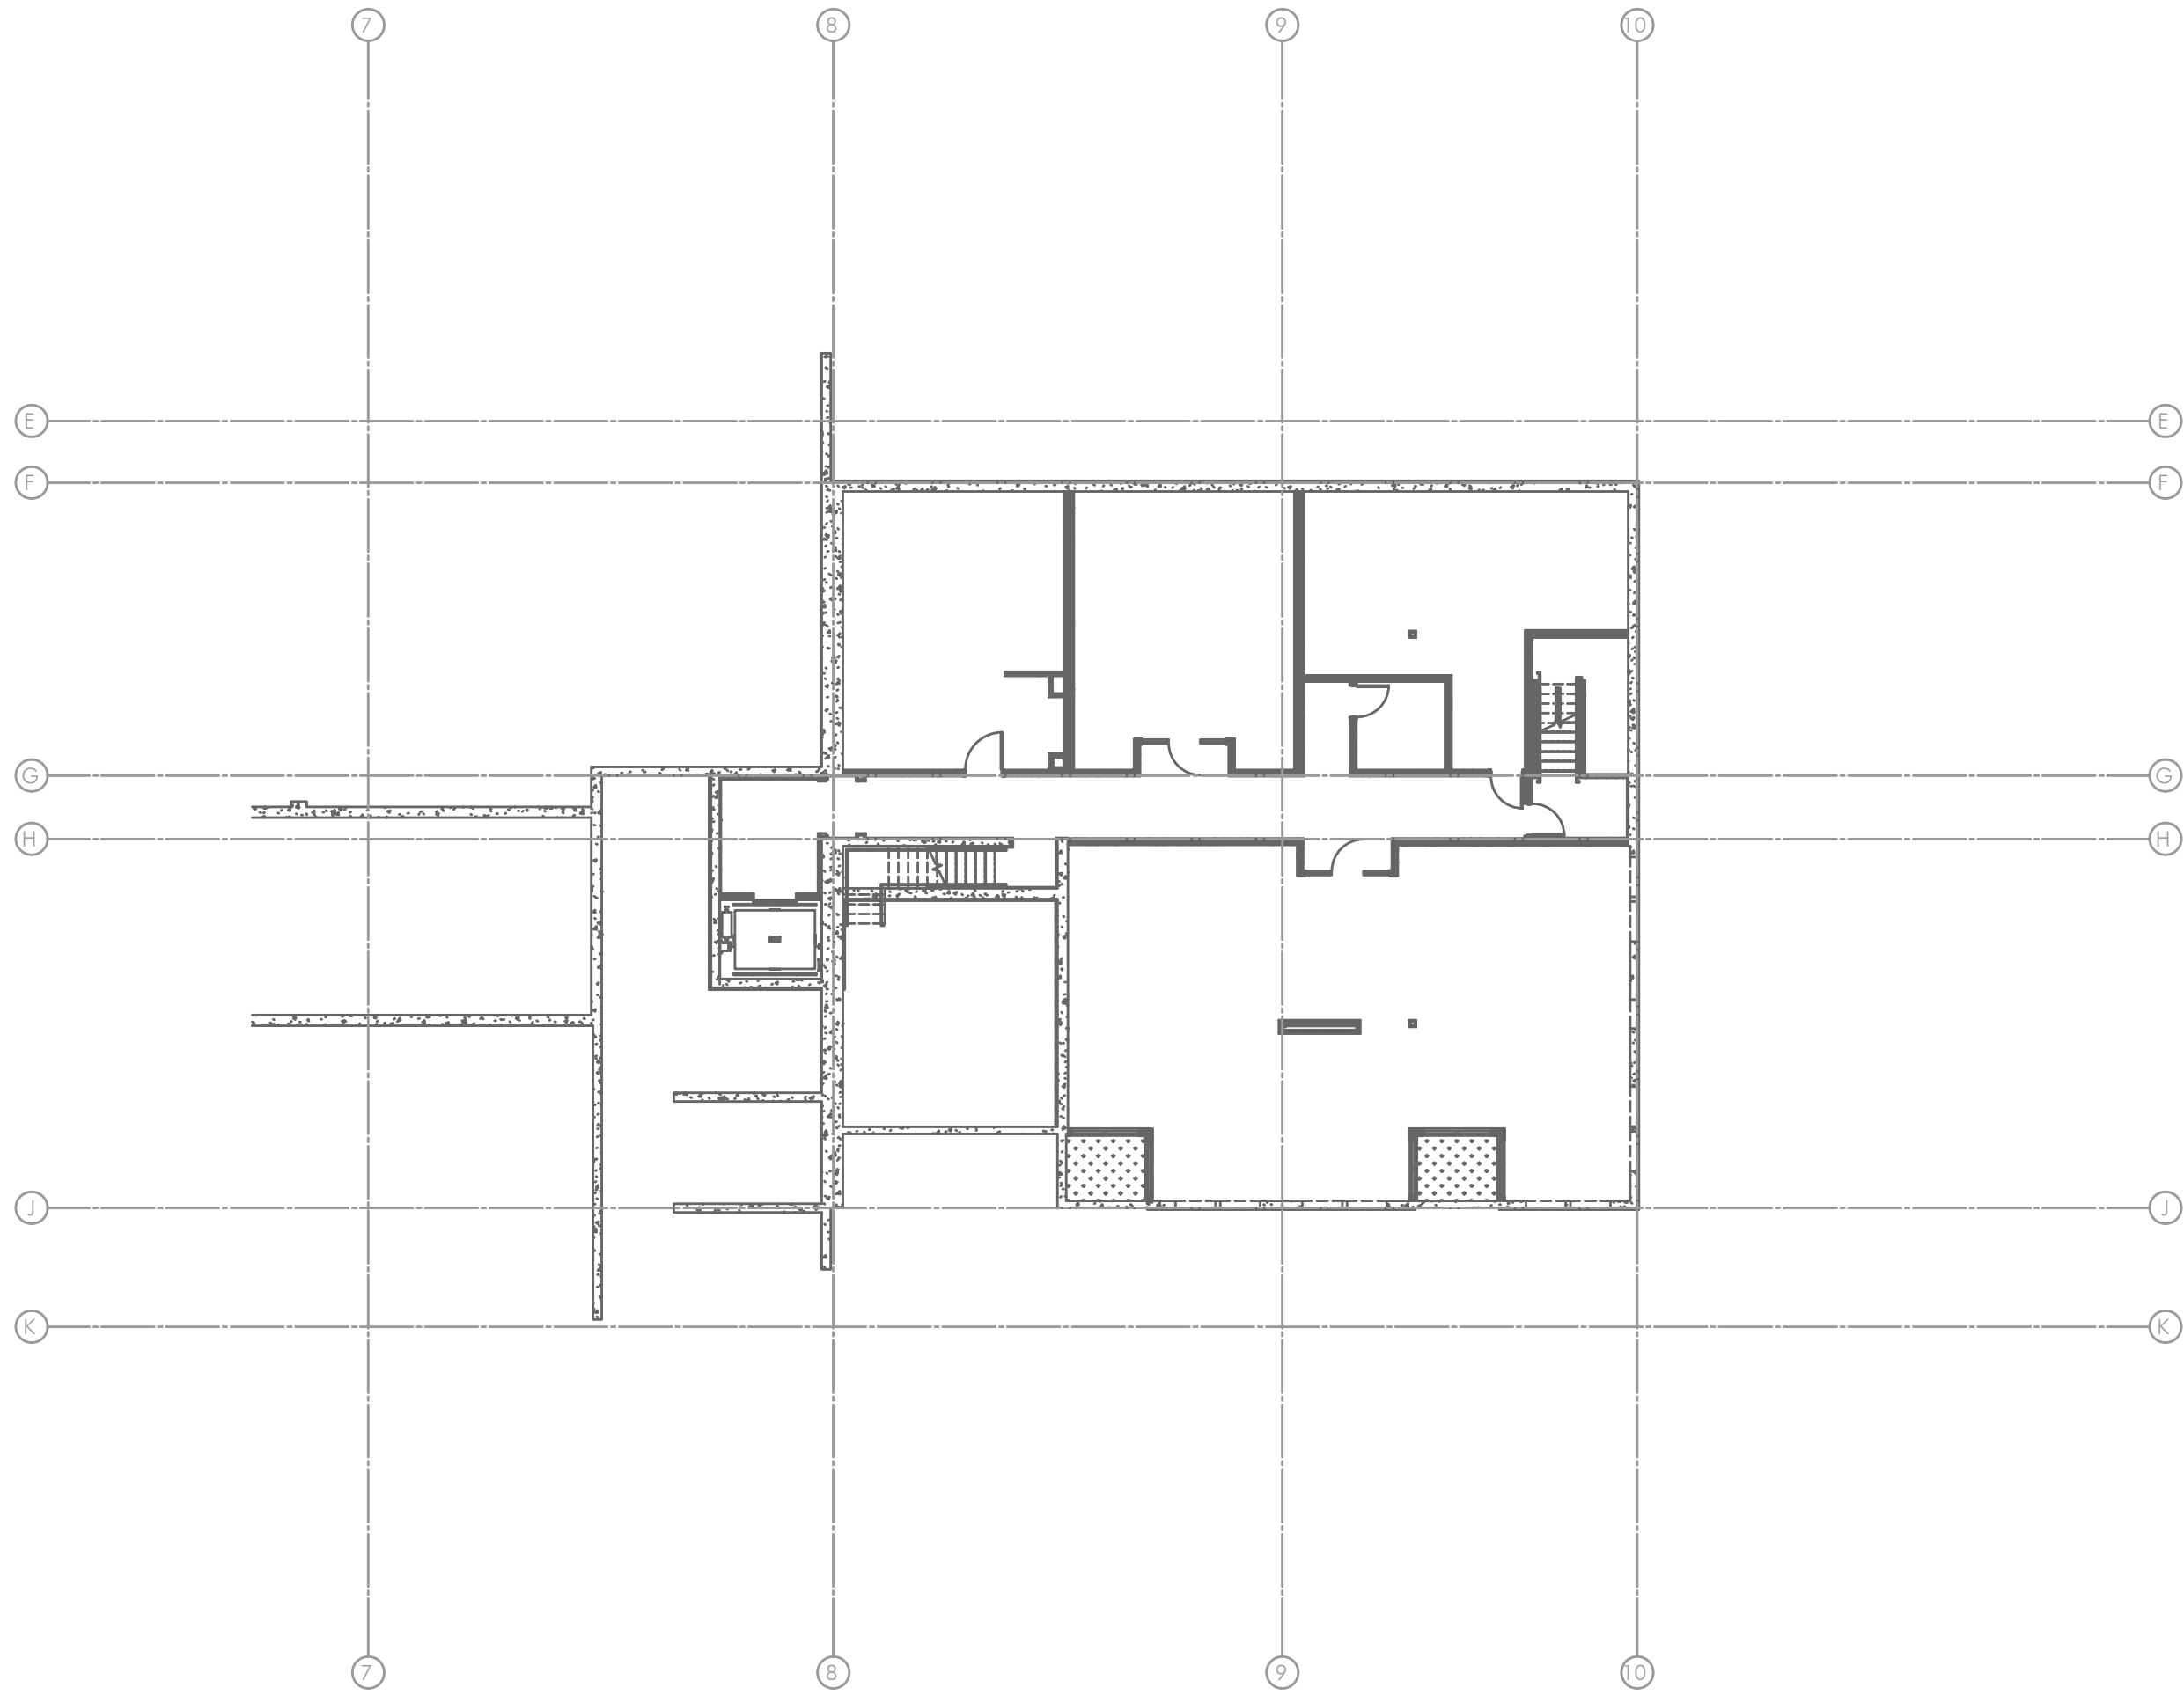


OVERALL BASEMENT LEVEL TECHNOLOGY PLAN

SCALE: 1/16" = 1'-0"