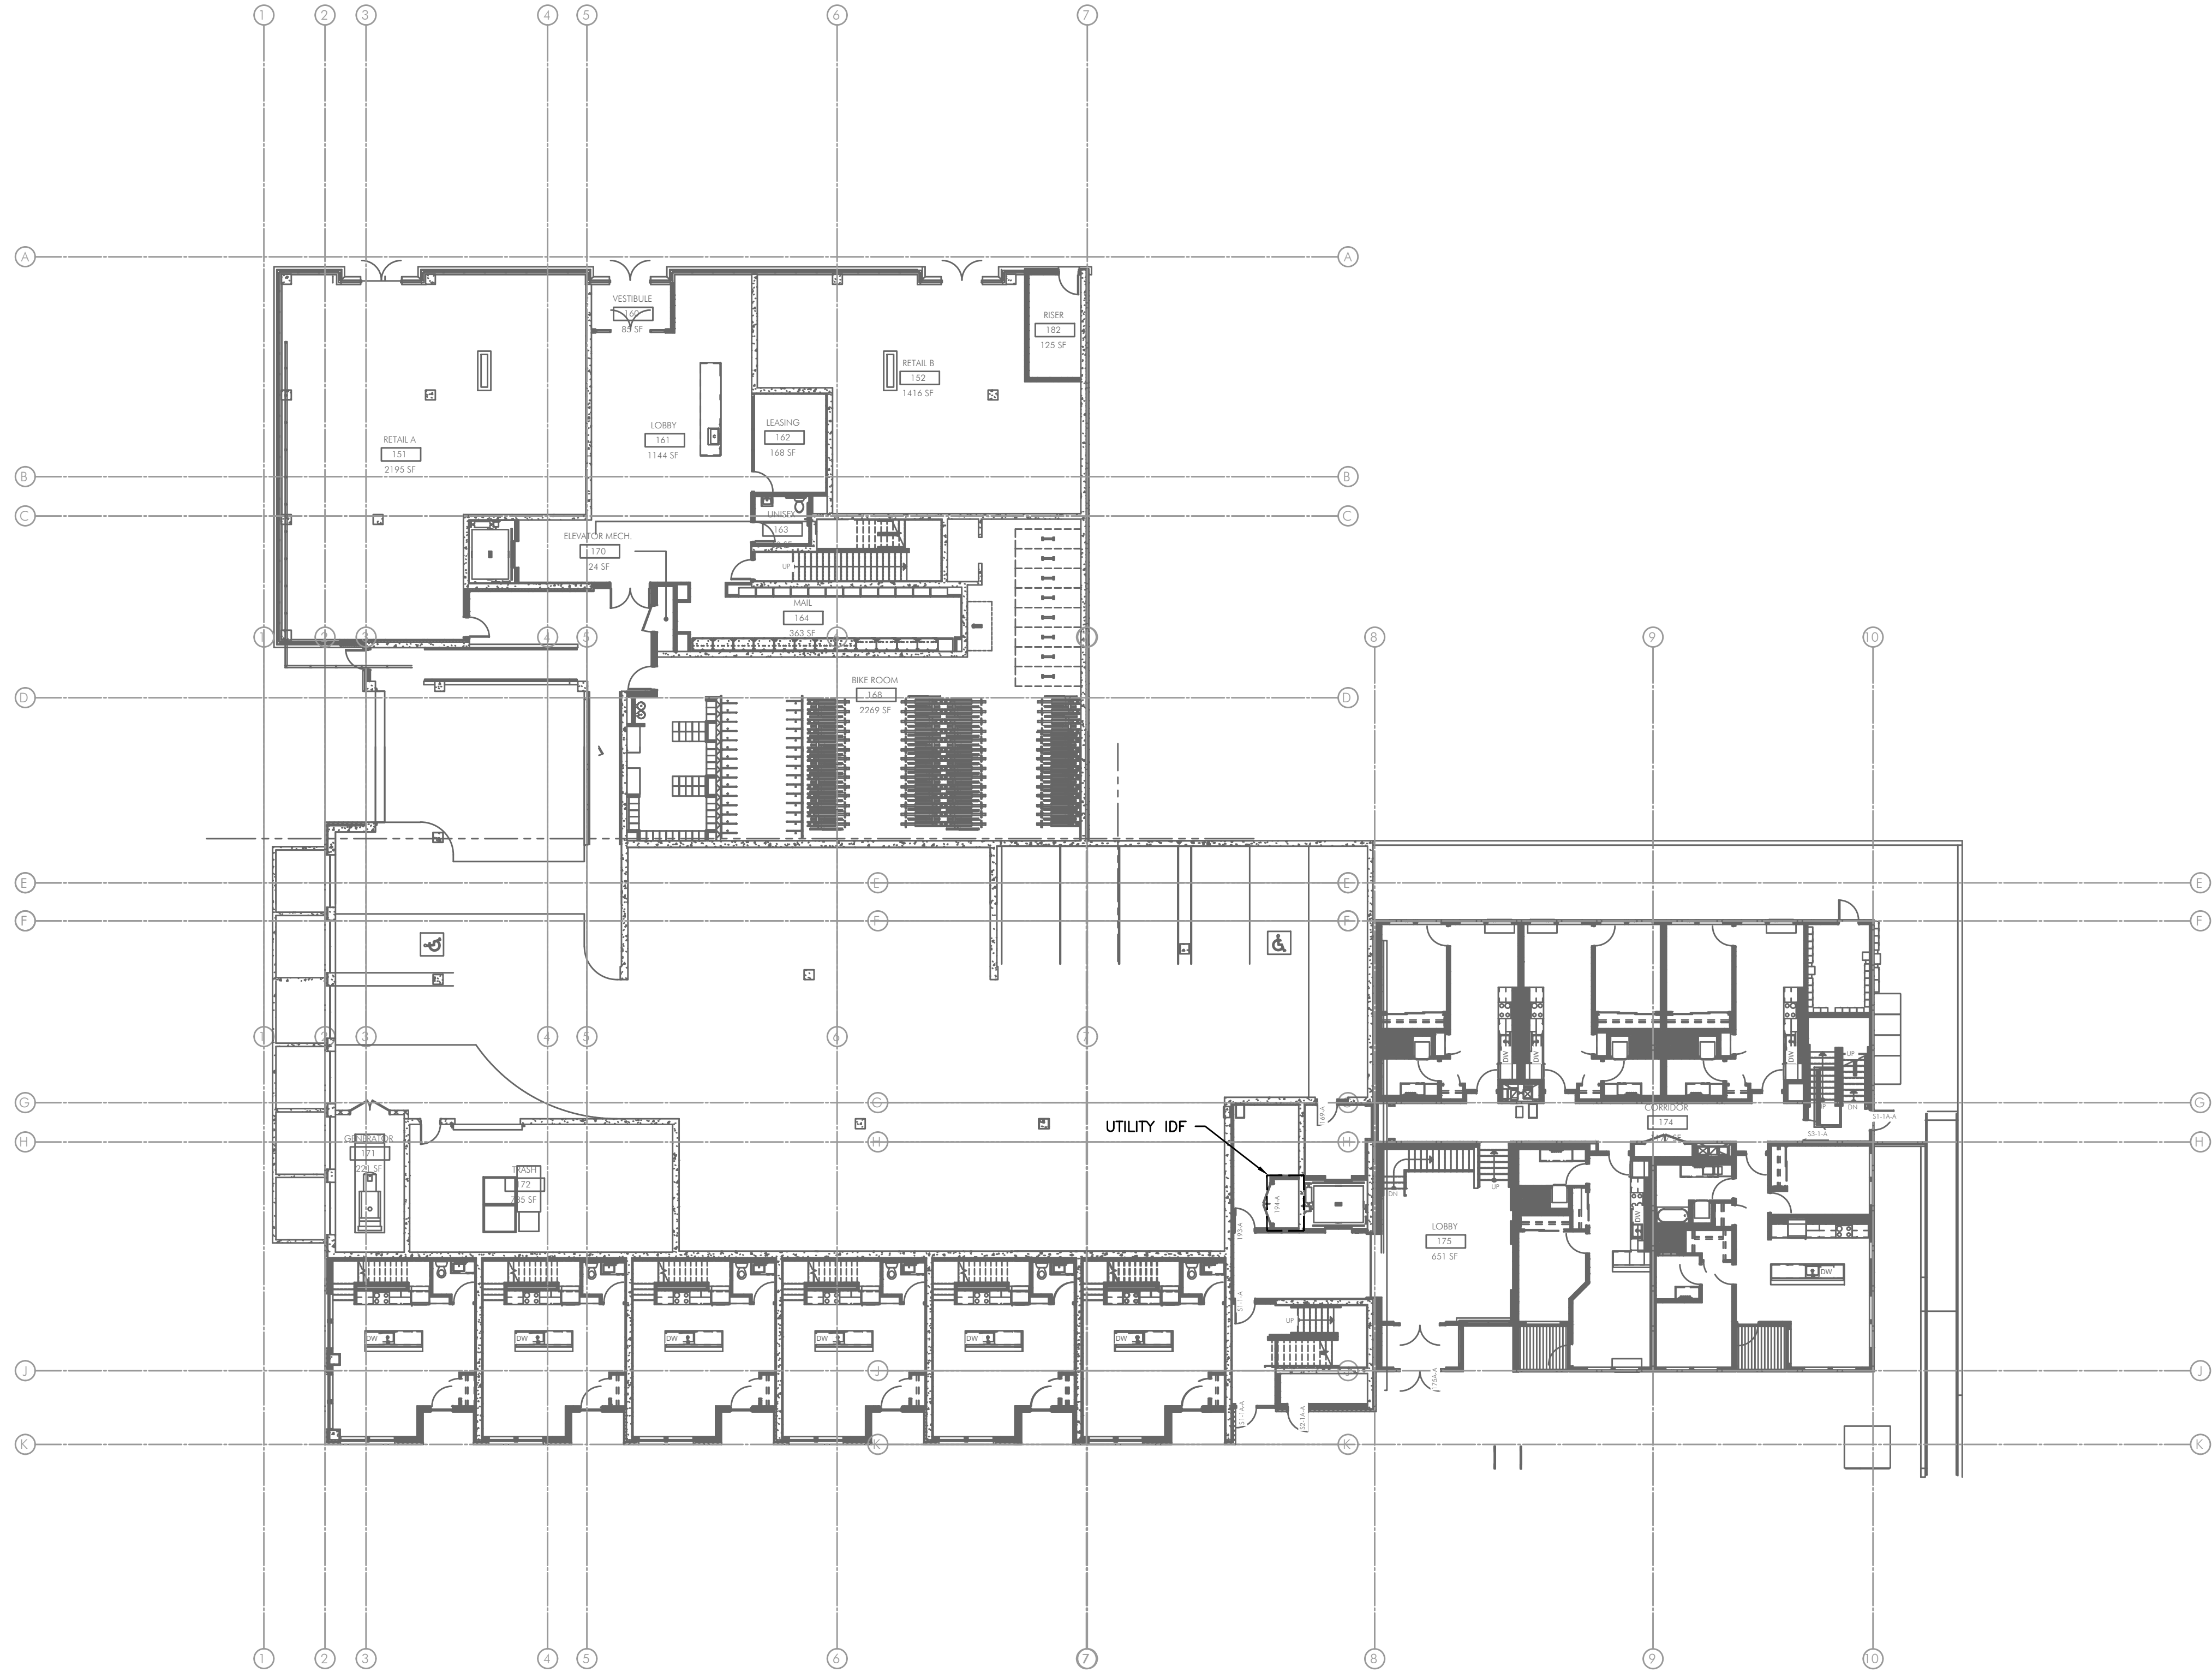


1 OVERALL FIRST FLOOR TECHNOLOGY PLAN
T2.01 SCALE: 1/16" = 1'-0"