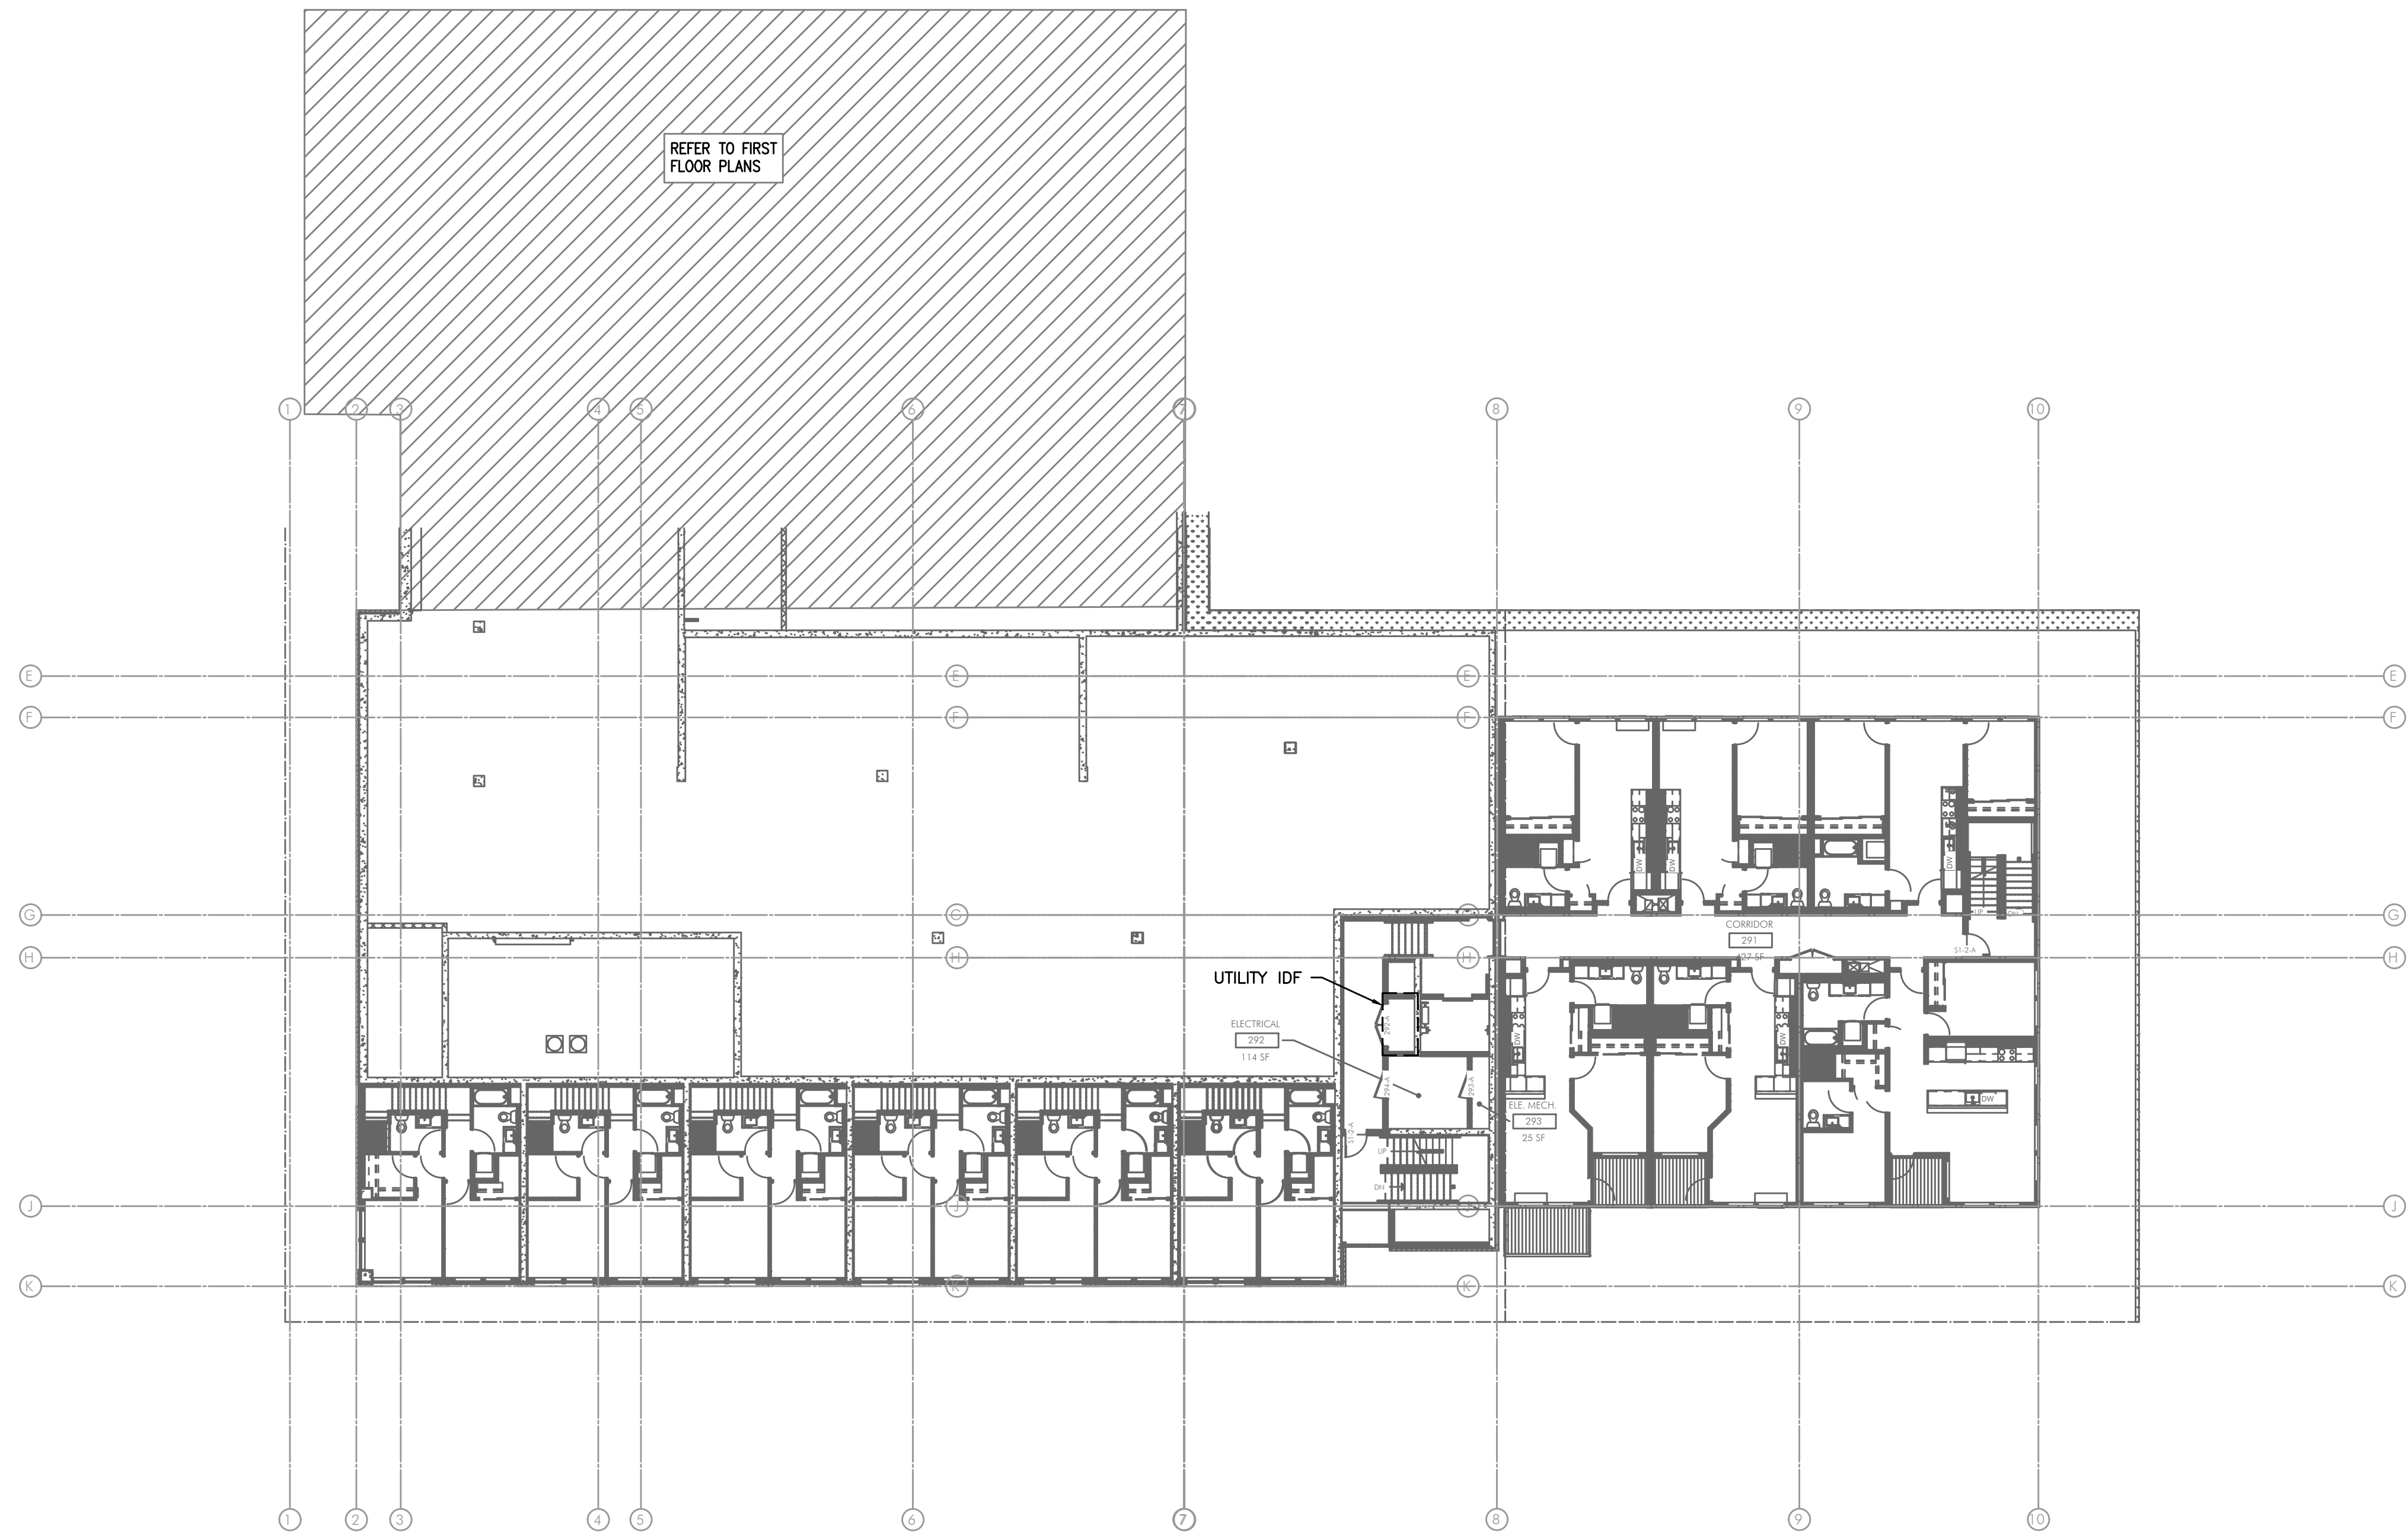


1
T2.02

OVERALL SECOND FLOOR TECHNOLOGY PLAN
SCALE: 1/16" = 1'-0"