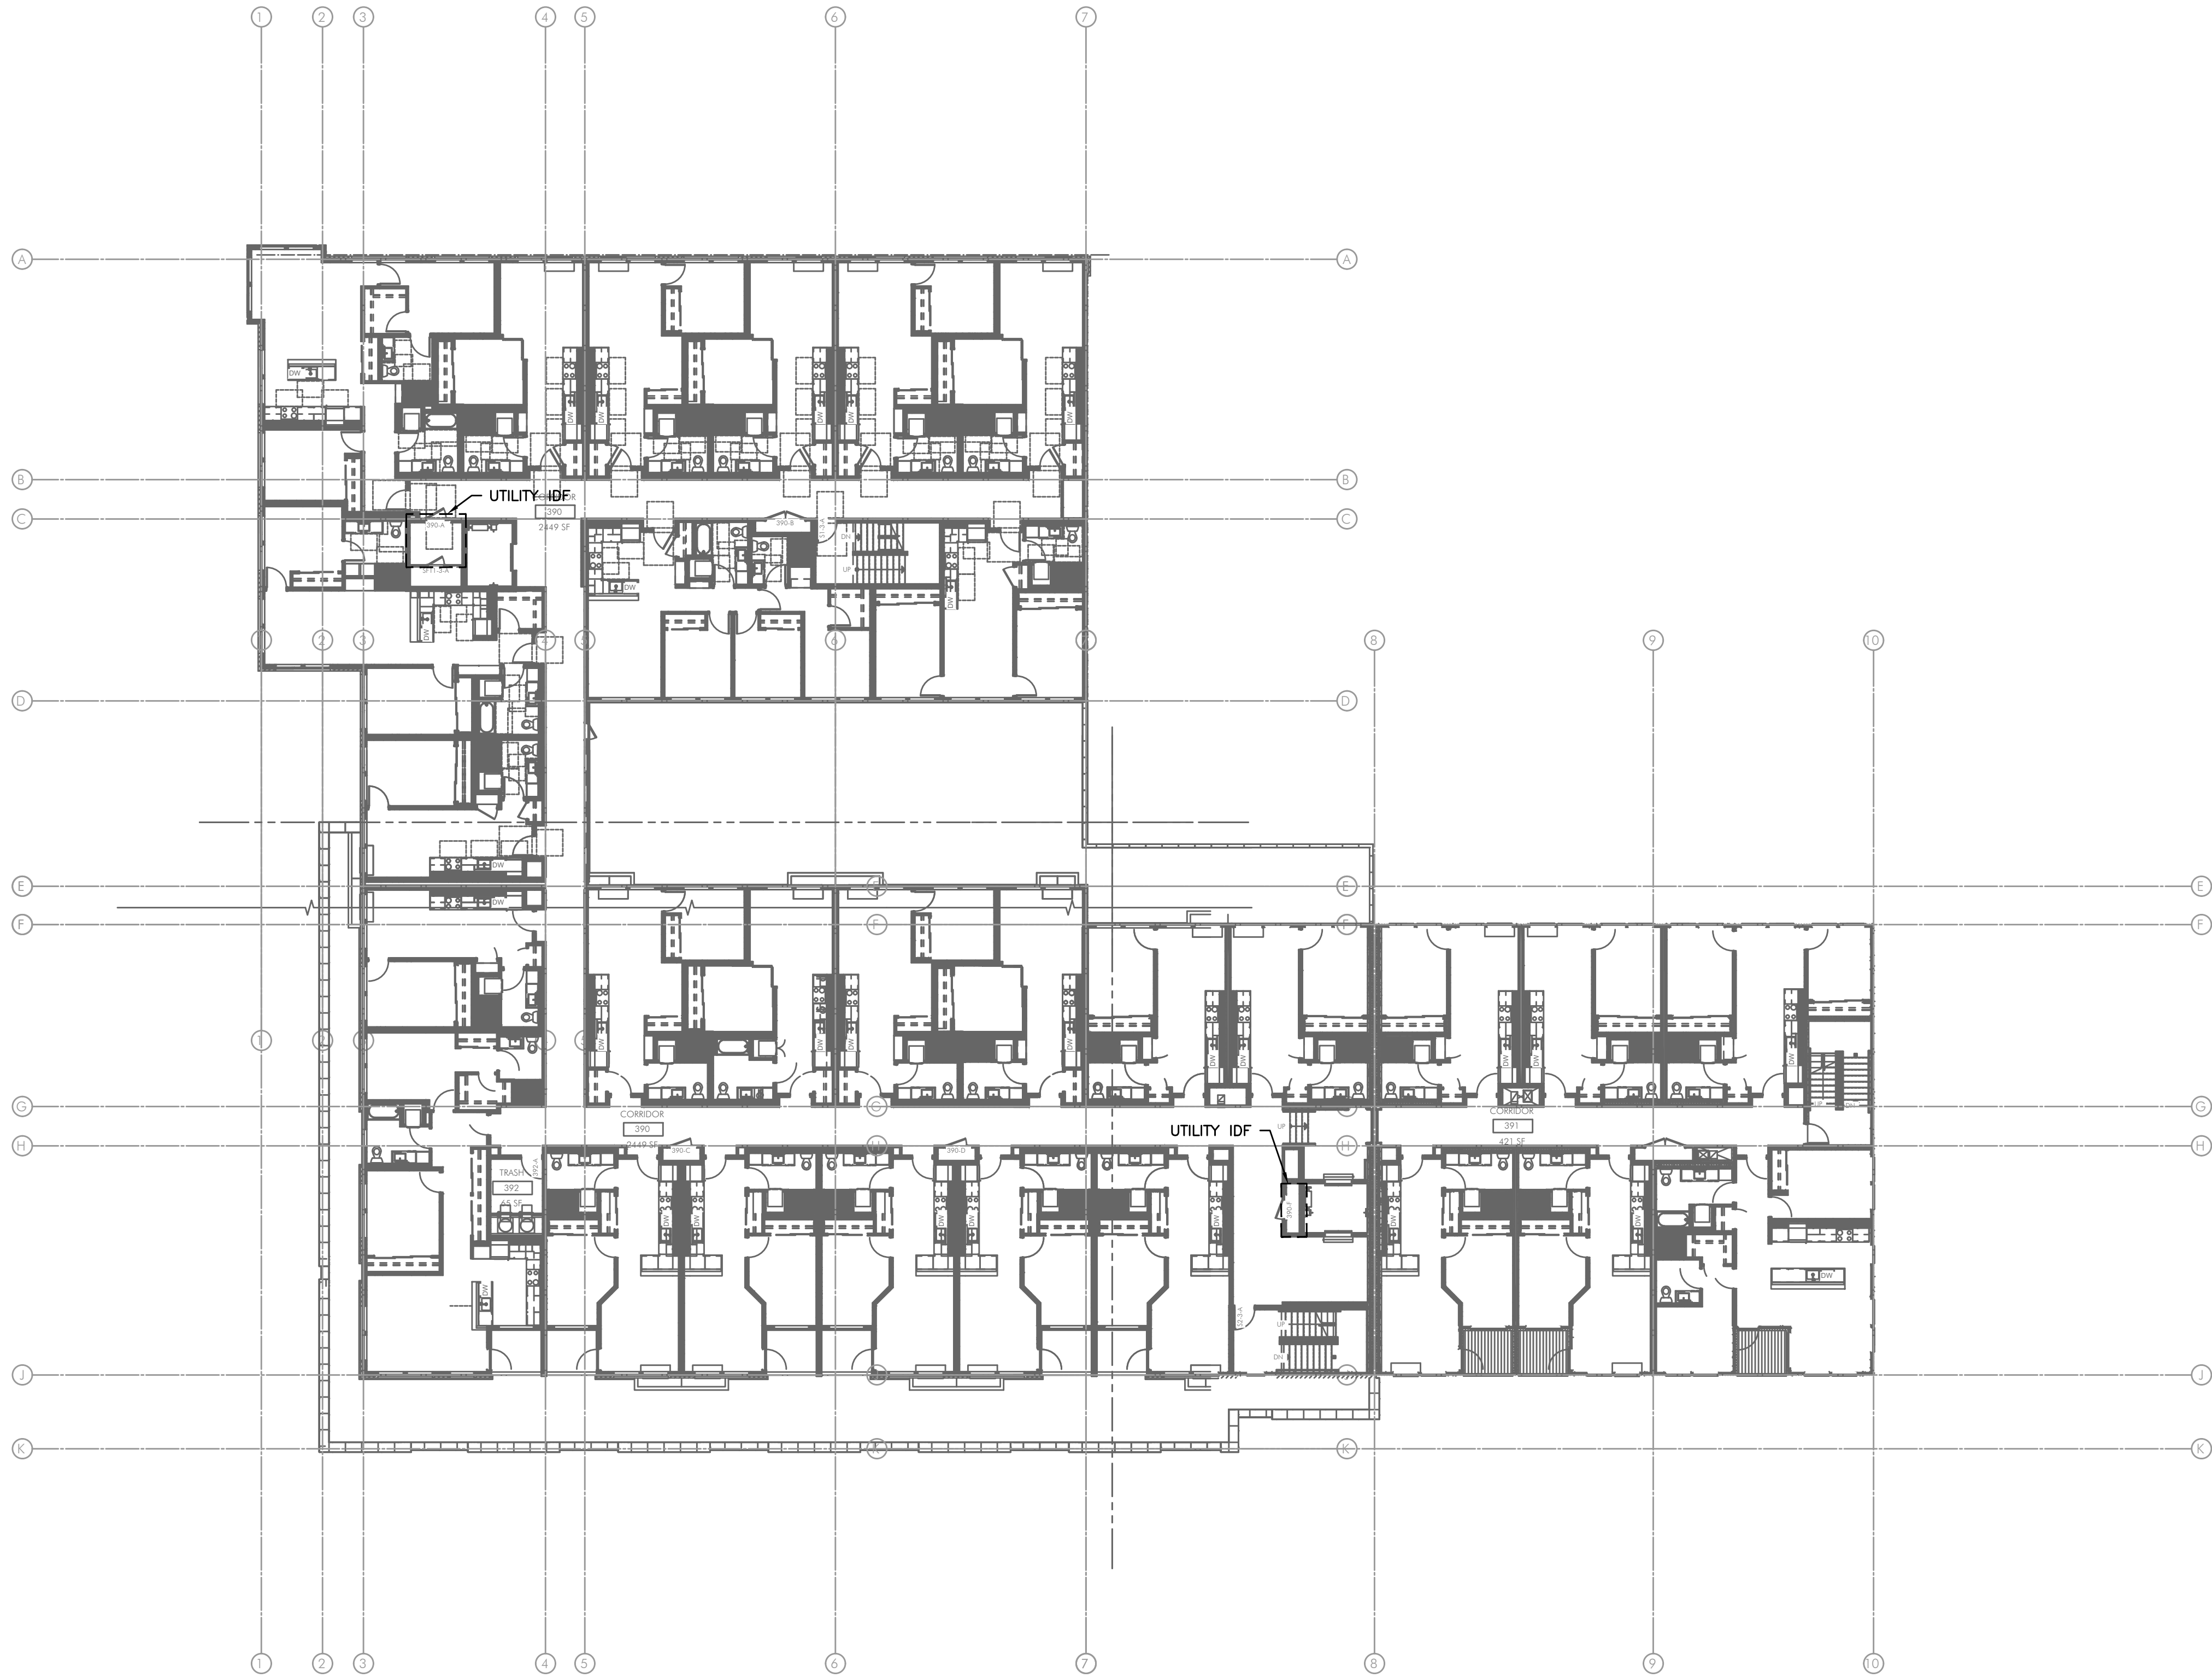


1 OVERALL THIRD FLOOR TECHNOLOGY PLAN
T2.03 SCALE: 1/16" = 1'-0"