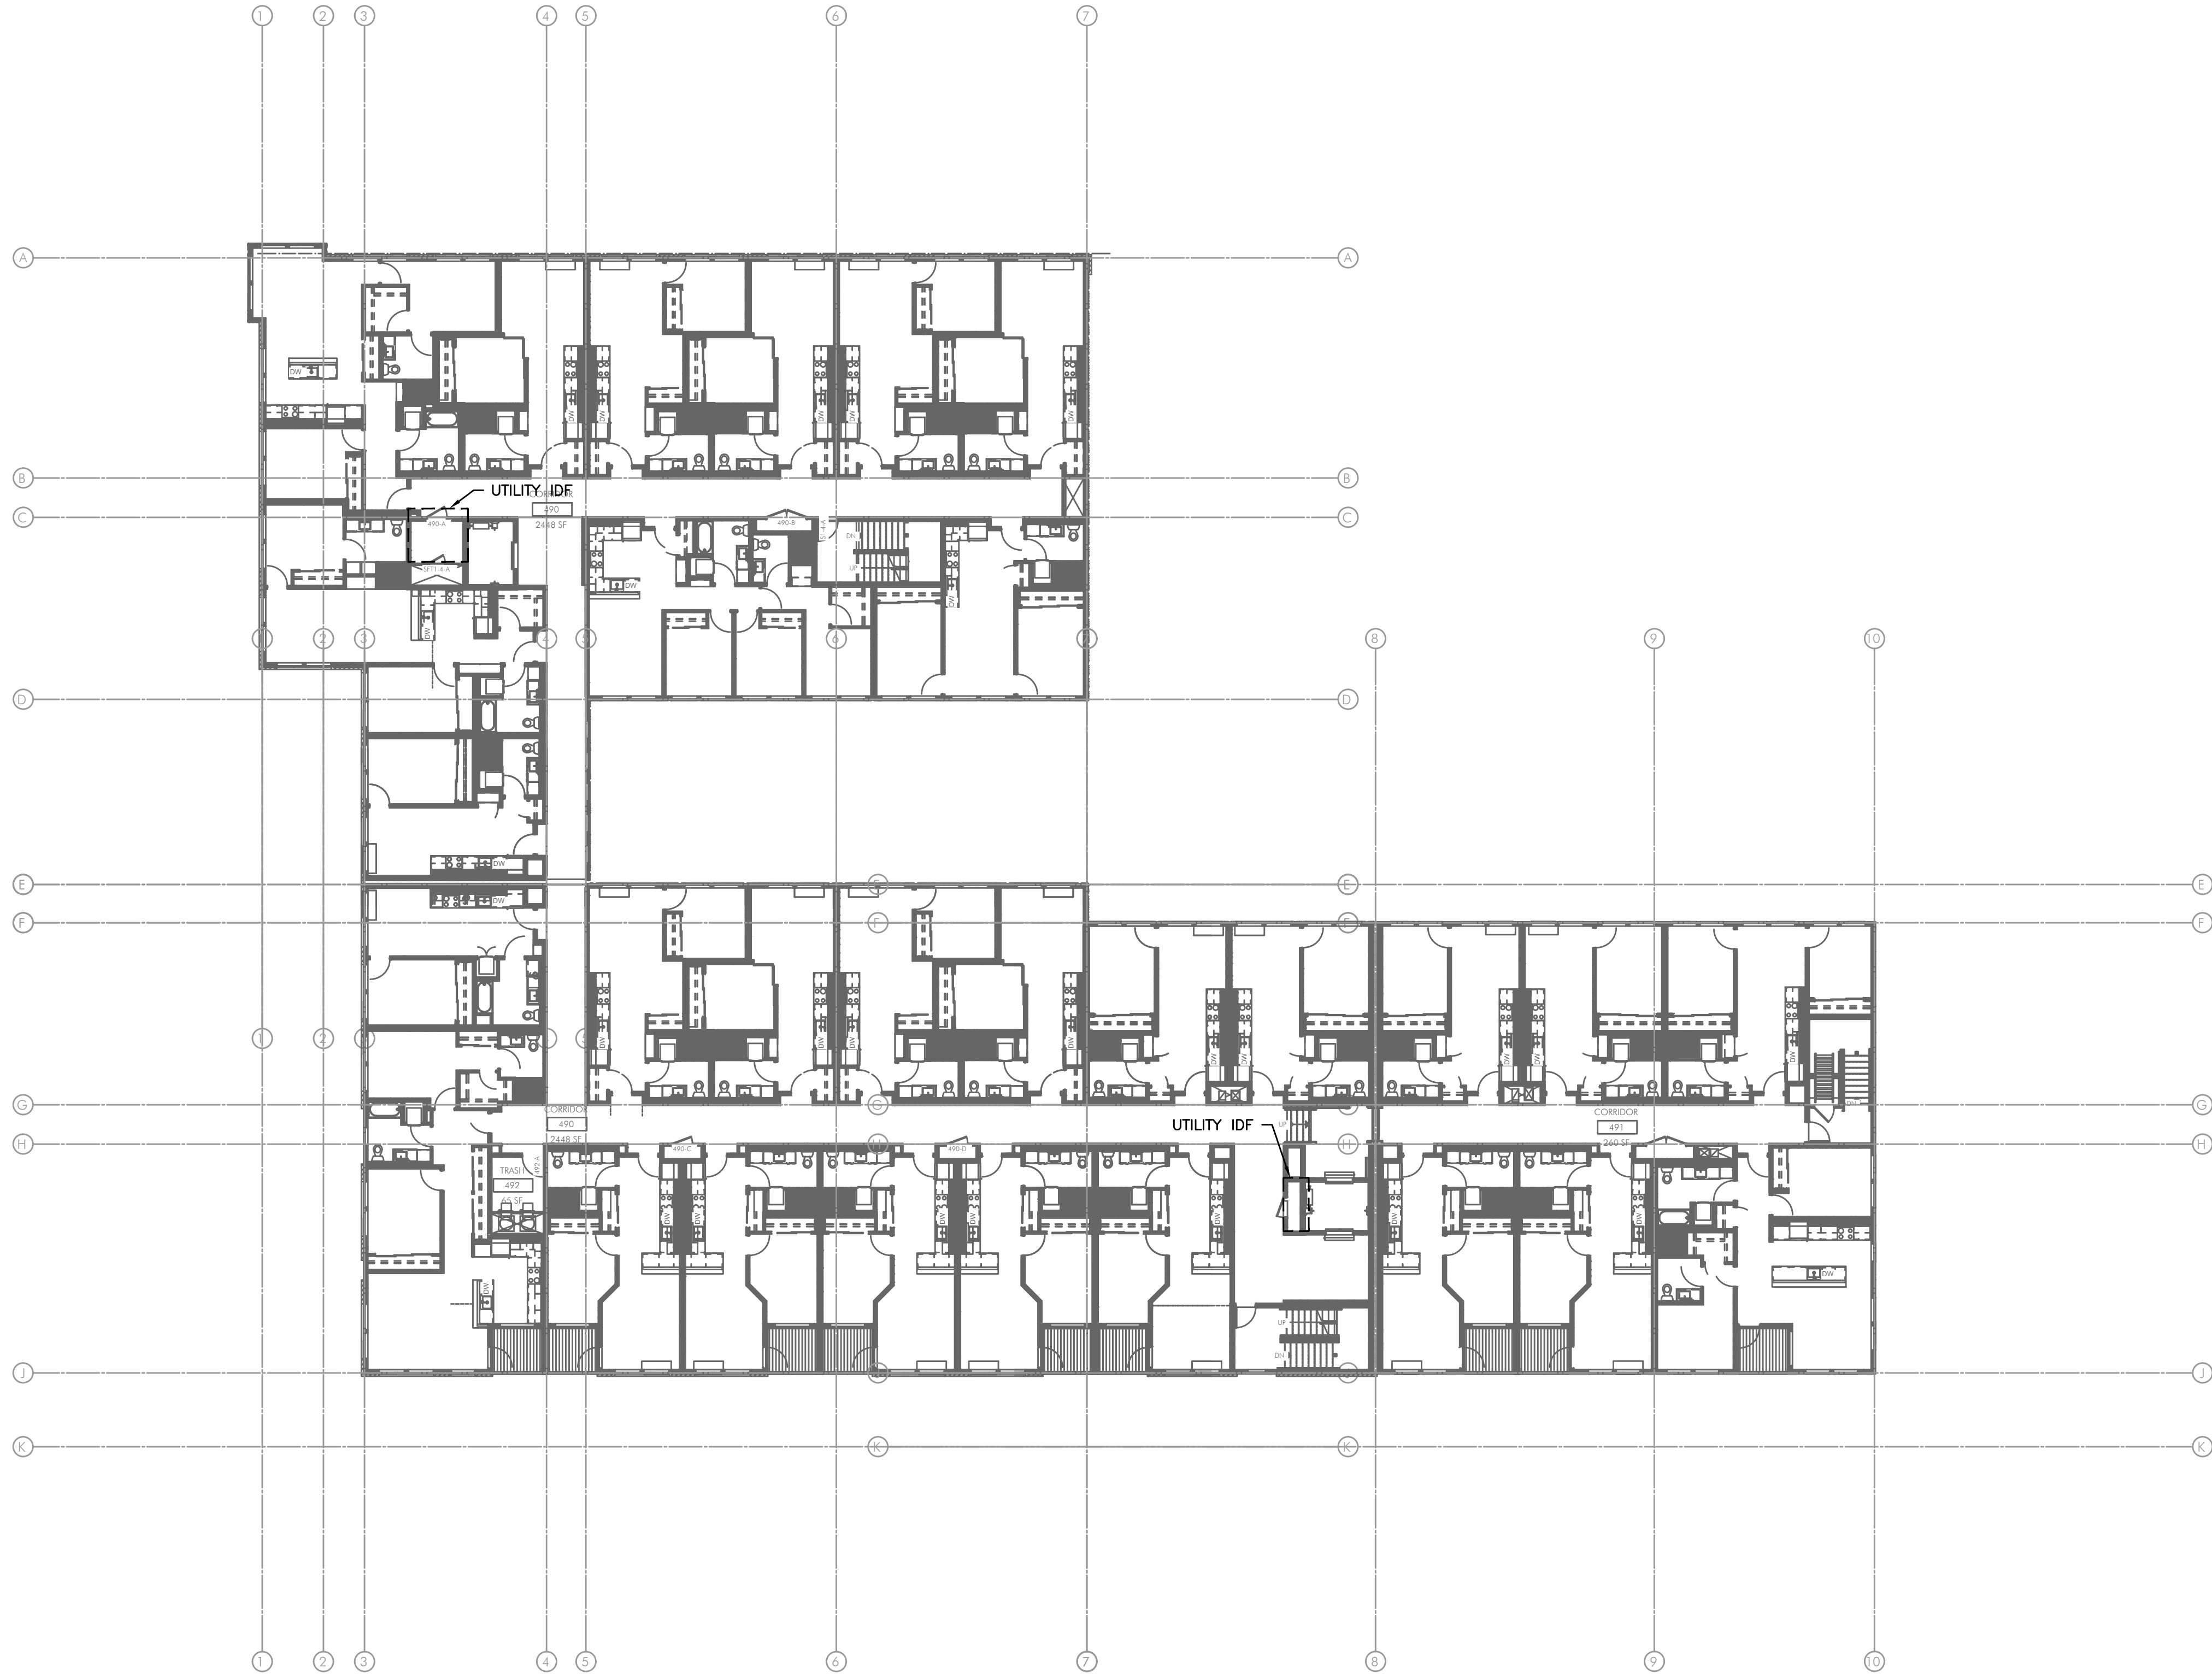


1 OVERALL FOURTH FLOOR TECHNOLOGY PLAN
T2.04 SCALE: 1/16" = 1'-0"