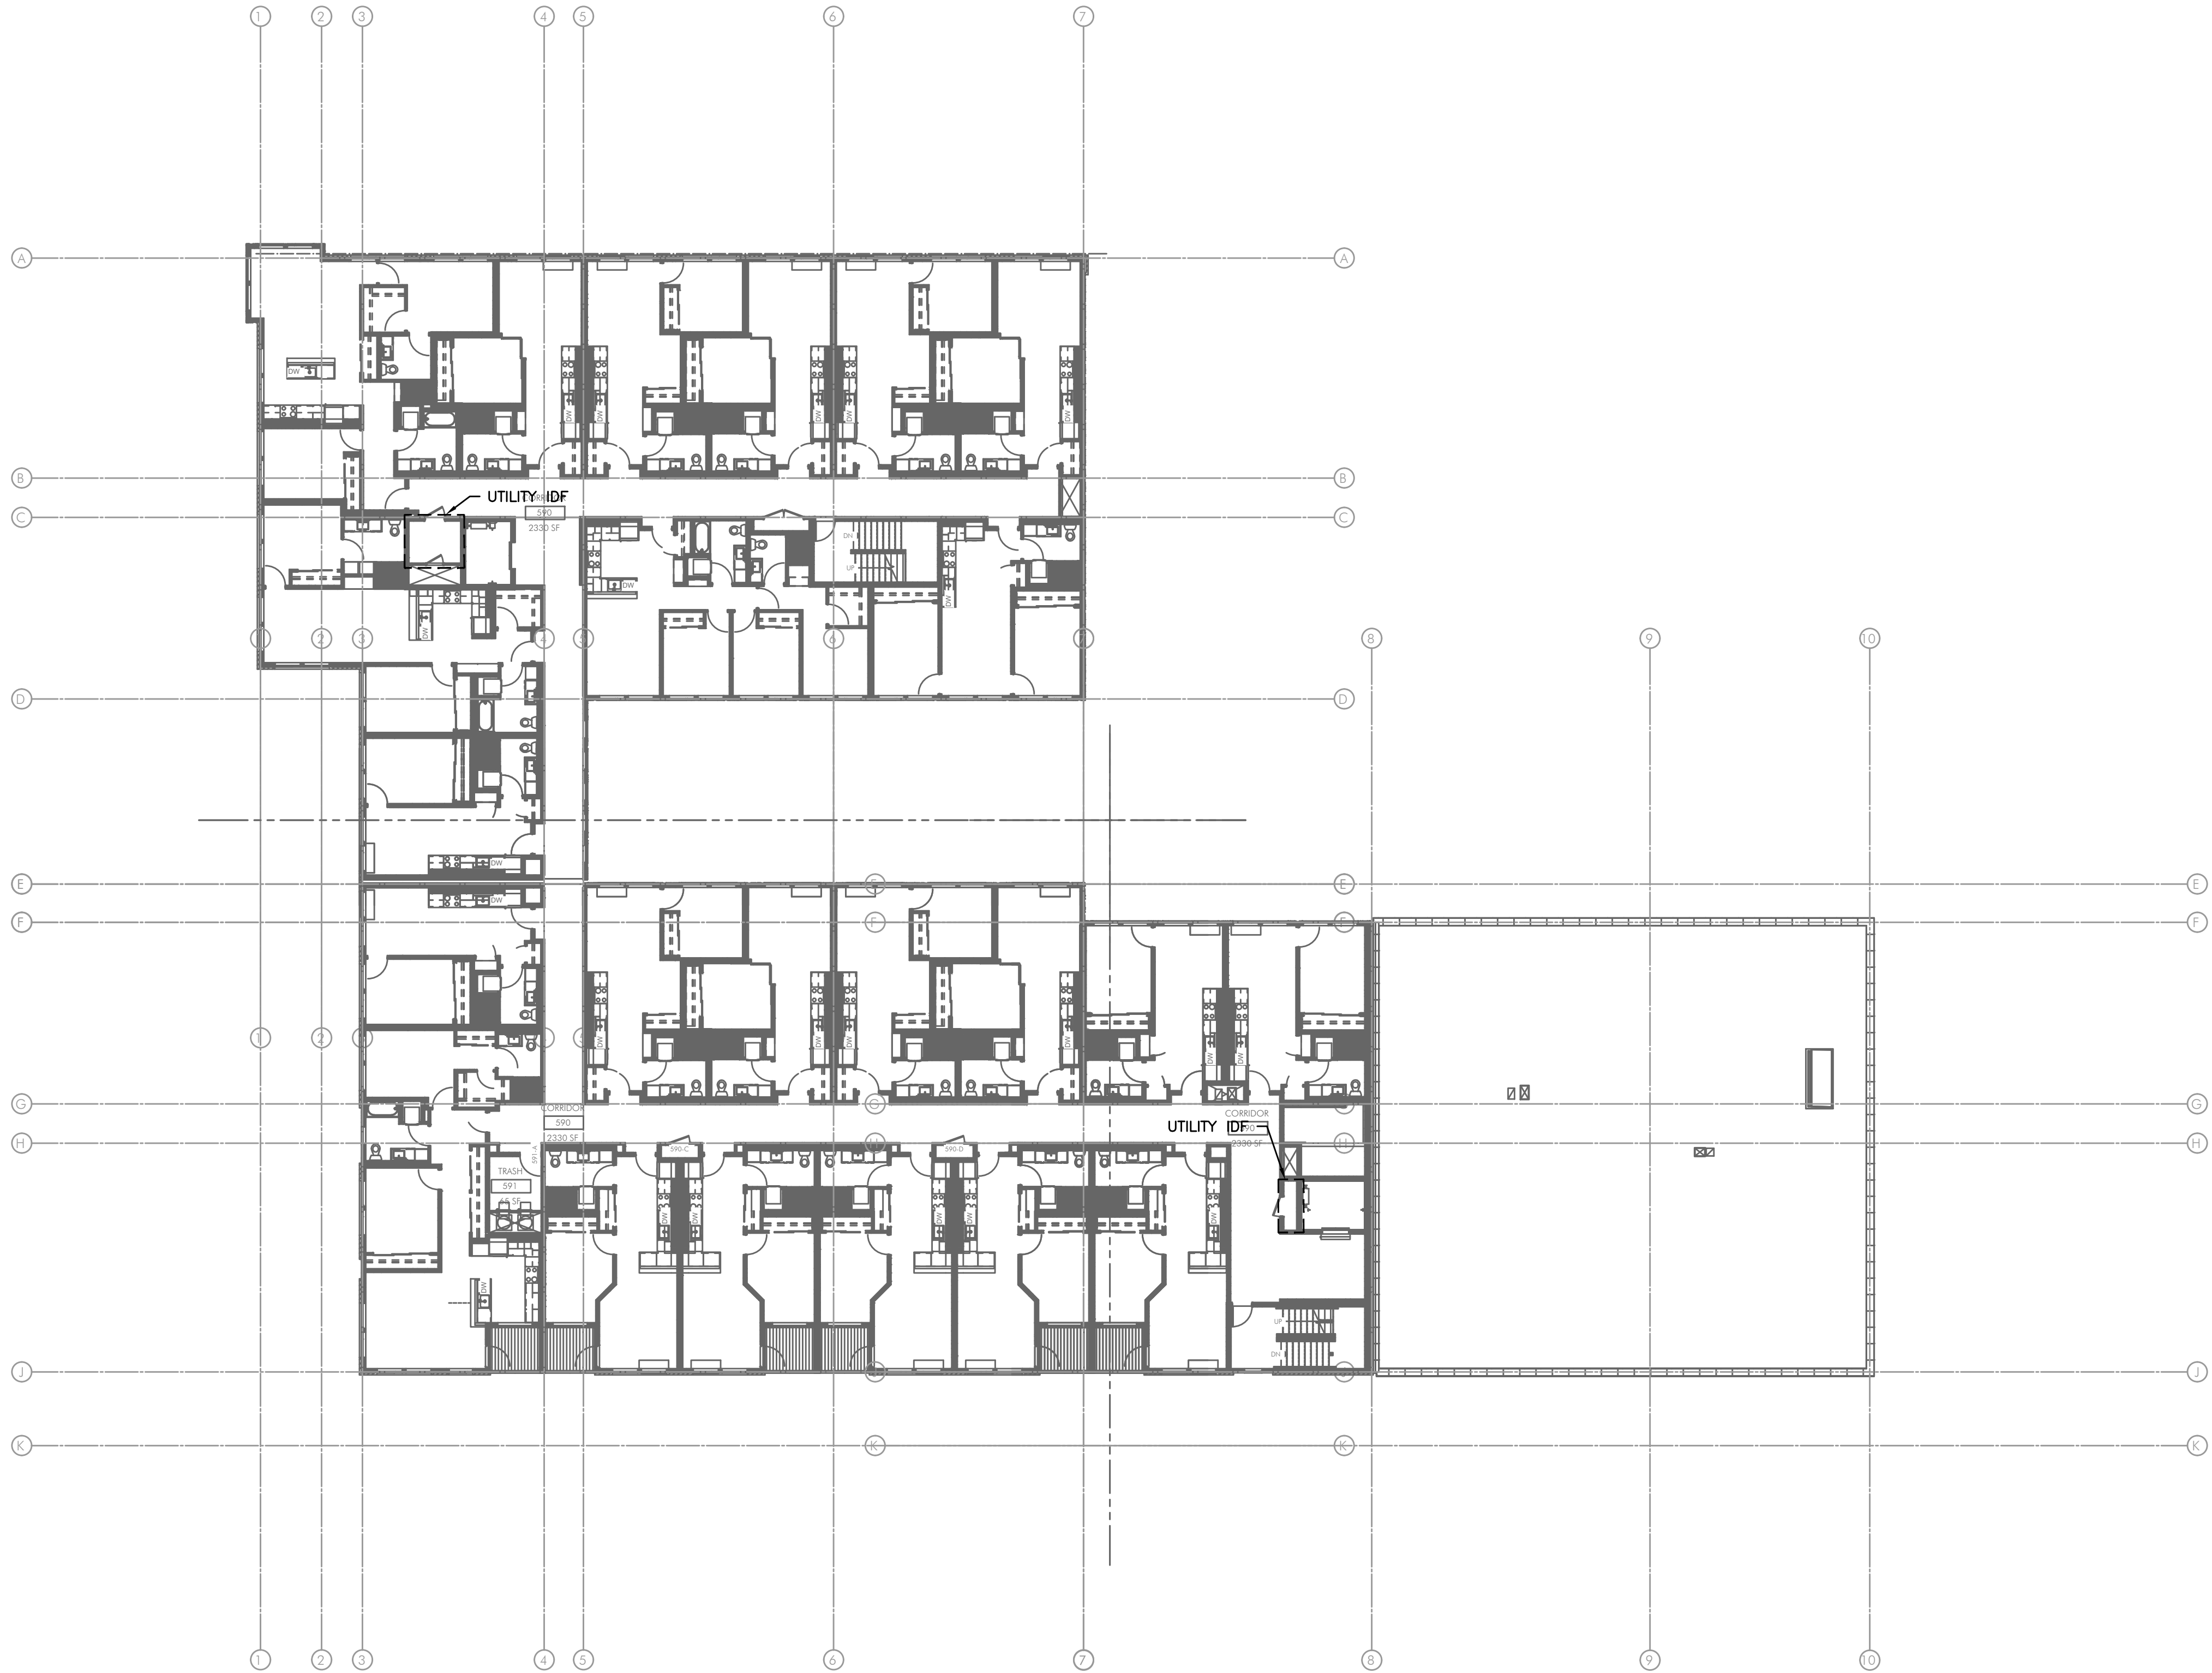


1 OVERALL FIFTH FLOOR TECHNOLOGY PLAN
T2.05 SCALE: 1/16" = 1'-0"