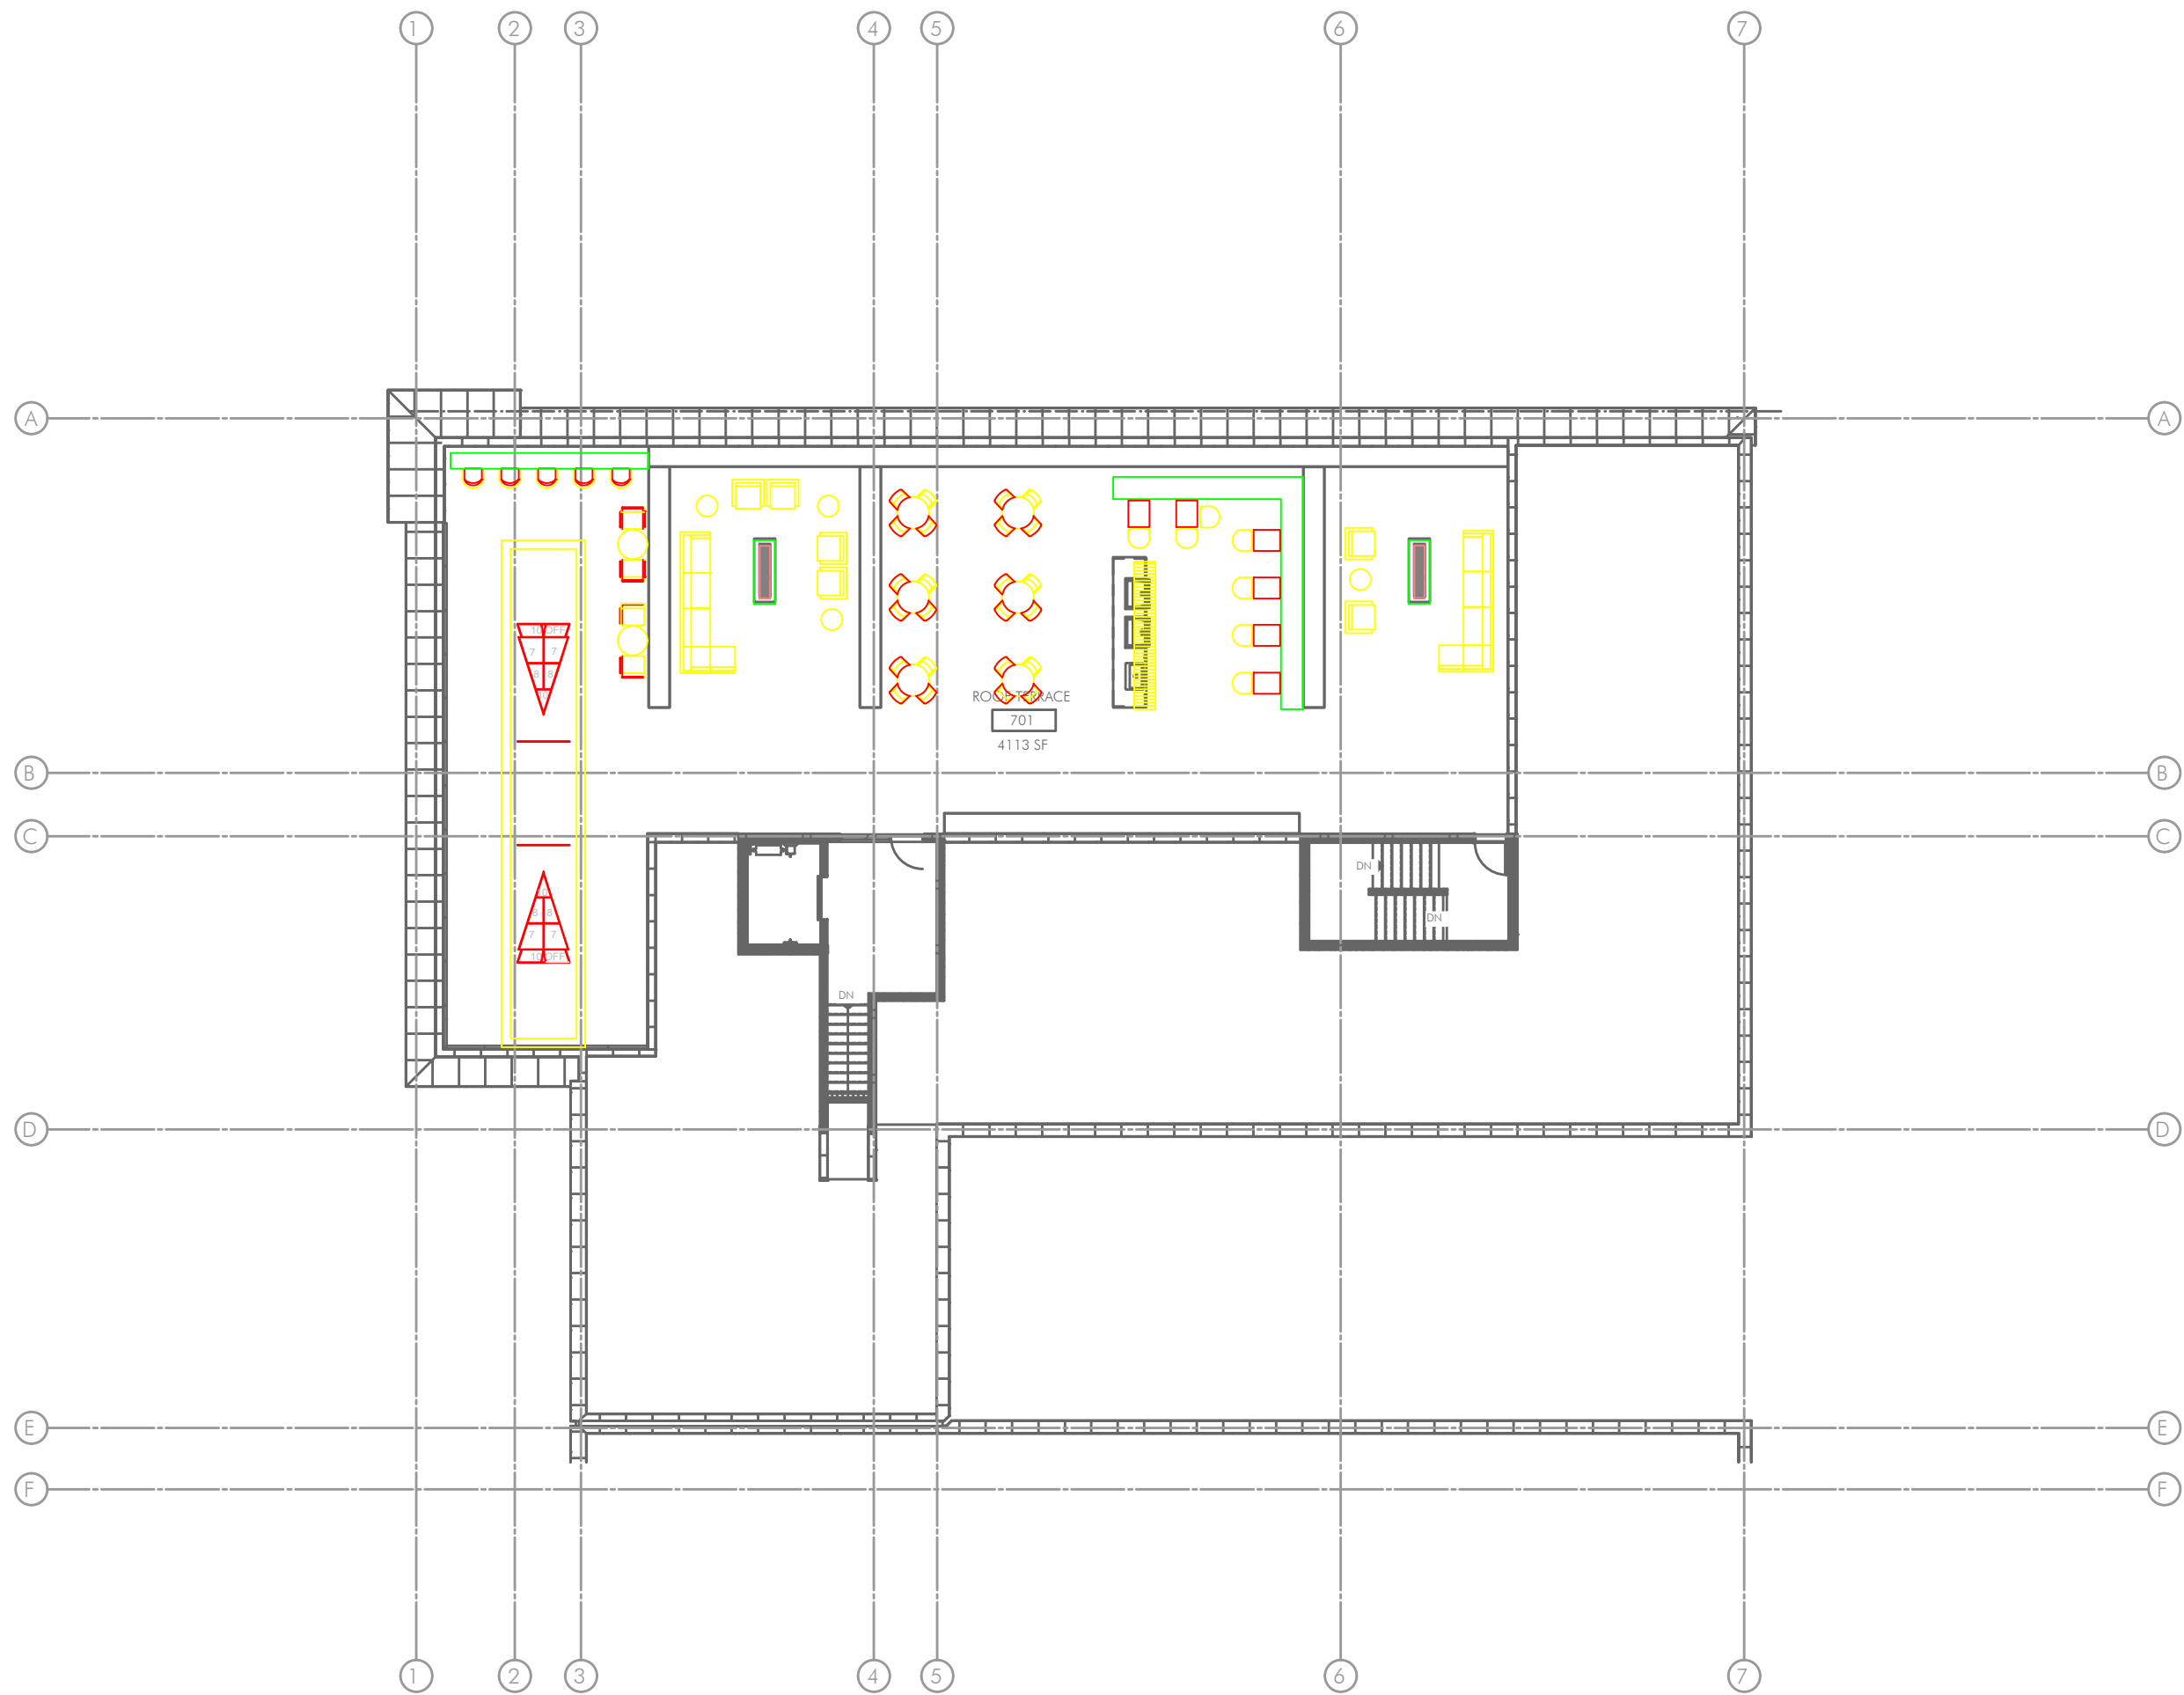


1 OVERALL ROOF LEVEL TECHNOLOGY PLAN
T2.07 SCALE: 1/16" = 1'-0"