



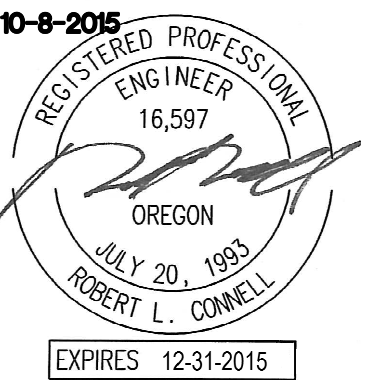


IN THE EVENT CONFLICTS ARE DISCOVERED
BETWEEN THE ORIGINAL SIGNED AND SEALED
DOCUMENTS PREPARED BY THE ARCHITECTS
AND/OR THEIR CONSULTANTS, AND ANY COPY OF
THE DOCUMENTS TRANSMITTED BY MAIL, FAX,
ELECTRONICALLY OR OTHERWISE, THE ORIGINAL
SIGNED AND SEALED DOCUMENTS SHALL GOVERN.

PROJECT # 2014-75
DATE: 10-08-2015

REVISIONS	
Δ	02.05.16 PLAN REVIEW

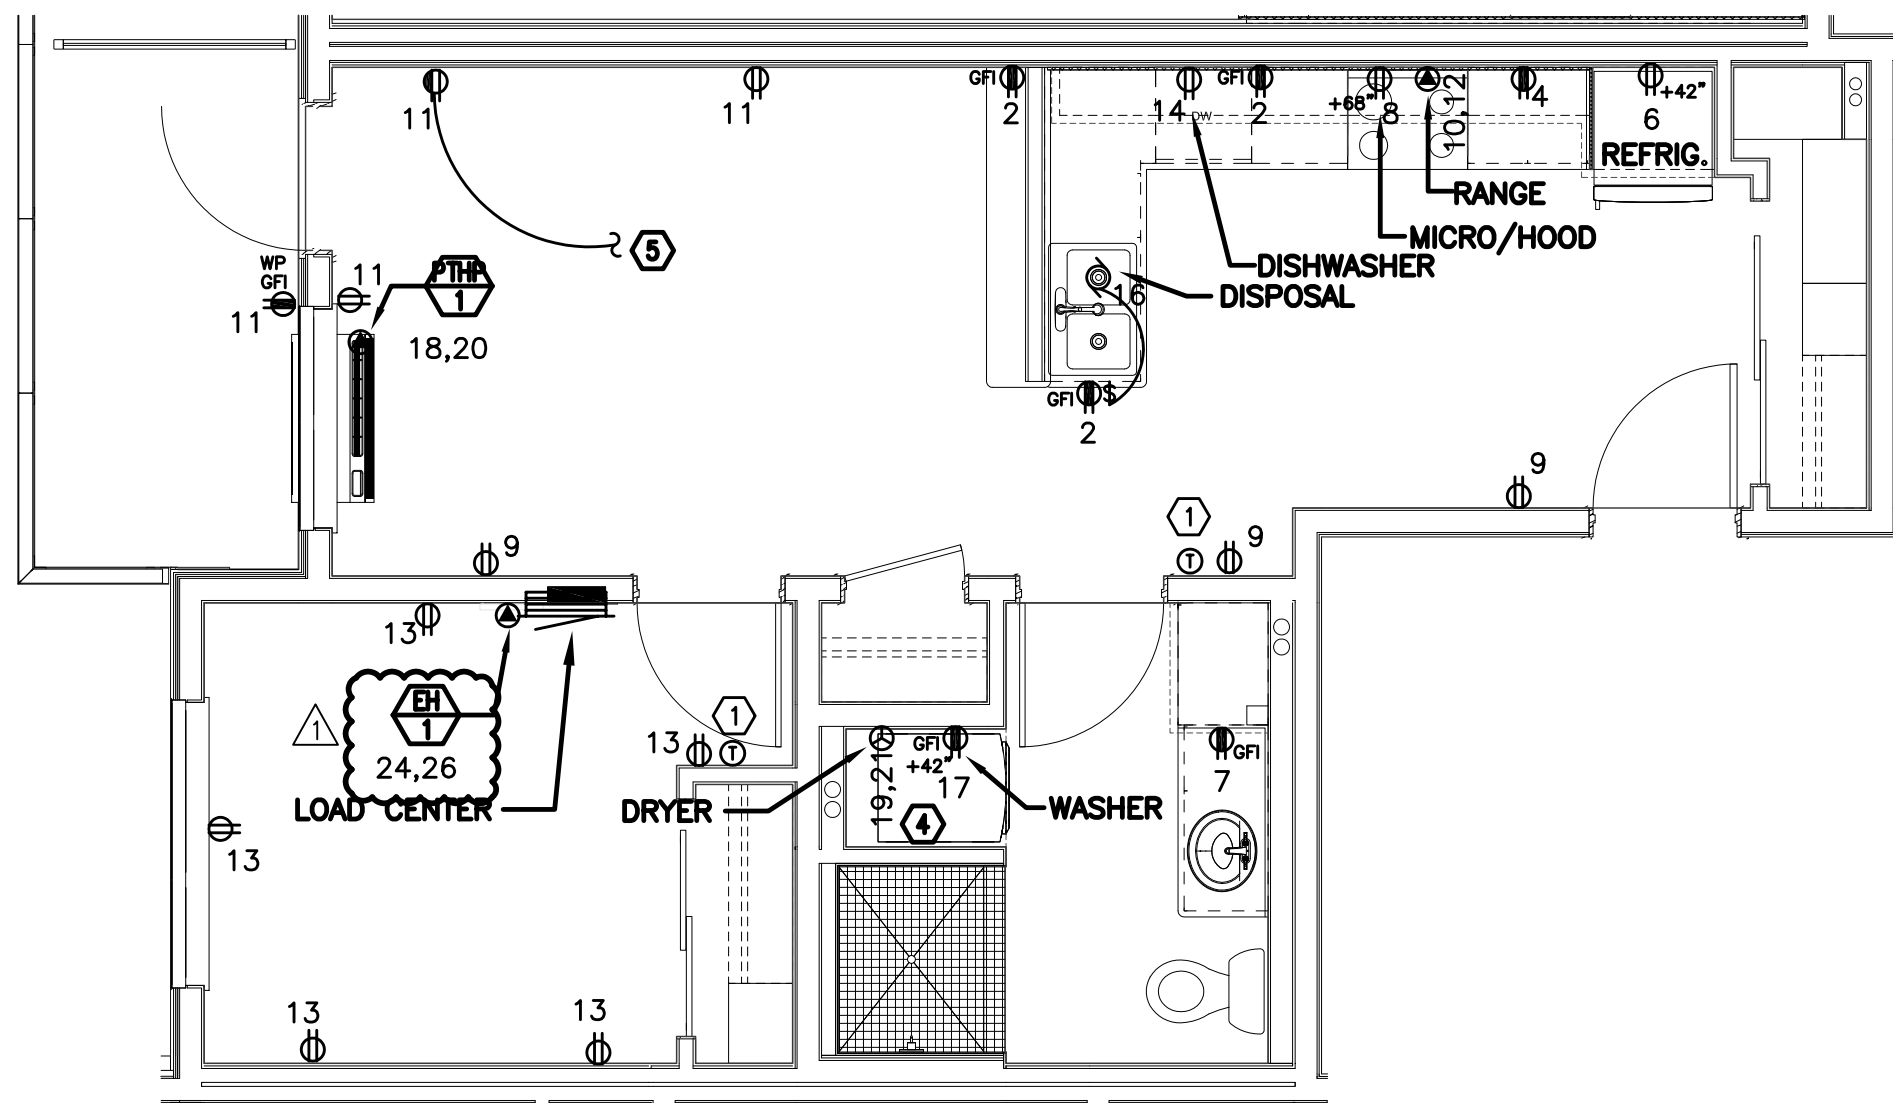

POWER PLAN
TYPICAL UNIT TYPE I
SCALE: 1/4" = 1'-0"

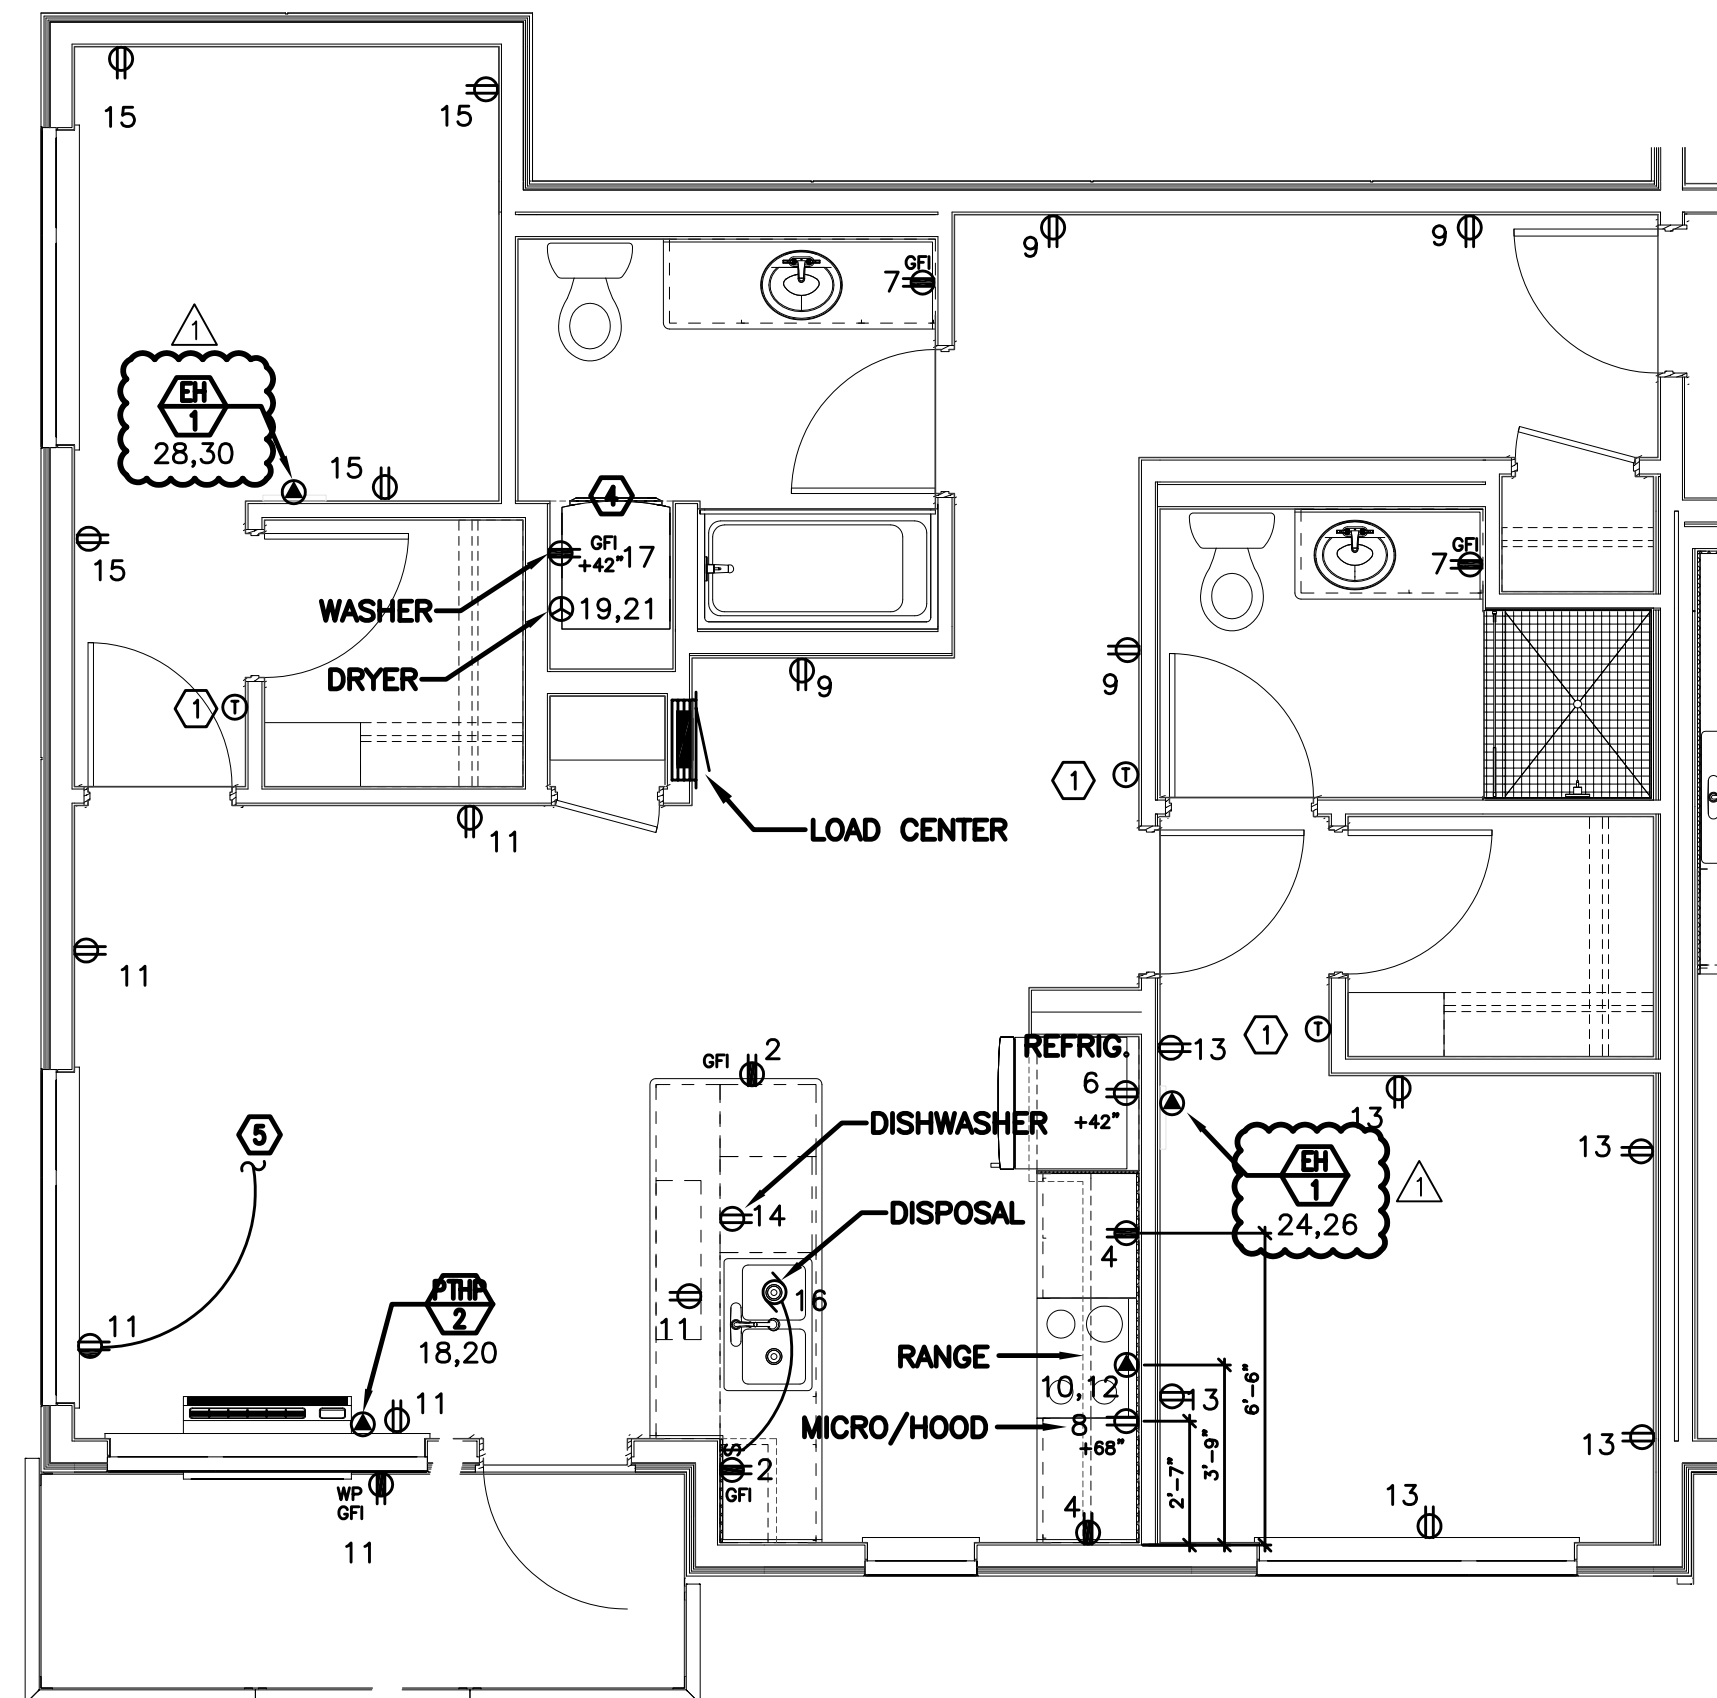


POWER PLAN
TYPICAL UNIT TYPE J
SCALE: 1/4" = 1'-0"

GENERAL NOTES (APARTMENT UNITS):

- KITCHEN RECEPTACLES LOCATED IN ISLANDS OR PENINSULAS WHERE THE BACK SPLASH WILL NOT ACCOMMODATE VERTICAL PLACEMENT OR THE DUPLEX RECEPTACLE, THE CONTRACTOR SHALL ROTATE THE DEVICE 90 DEGREES SO THAT THE RECEPTACLE IS INSTALLED HORIZONTALLY.
- REFER TO DETAILS ON SHEET E1.22 AND G2.01 FOR ADDITIONAL INFORMATION REGARDING ADA REACH REQUIREMENTS FOR RECEPTACLE AND SWITCH MOUNTING HEIGHT.
- STANDARD RECEPTACLE MOUNTING HEIGHT IS 18" A.F.F. UNLESS OTHERWISE SPECIFIED. RECEPTACLES LOCATED BELOW WINDOW SILLS SHALL NOT BE LESS THE 15" A.F.F.

KEYED NOTES (APARTMENT UNITS):

- PROVIDE WIRE CONNECTION FOR THERMOSTAT(S). COORDINATE WITH MECHANICAL INSTALLER FOR EXACT LOCATION AND POWER REQUIREMENTS PRIOR TO ROUGH IN.
- CONTINUOUS OPERATION EXHAUST FAN TO BE CIRCUITED WITH LIGHTING AND SHALL NOT BE SWITCHED.
- REFER TO ARCHITECTURAL ELEVATIONS AND PROVIDE JUNCTION BOX AND BLANK COVER FOR FUTURE RECEPTACLE AND/OR SWITCH AT FALSE DRAWER FRONT TO MEET ADA REQUIREMENTS. CIRCUIT TO NEAREST KITCHEN APPLIANCE RECEPTACLE CIRCUIT AT EACH LOCATION.
- REFER TO DETAIL 1/E1.23 FOR TYPICAL LAUNDRY ALCOVE RECEPTACLE LOCATIONS. COORDINATE INSTALLATION WITH MECHANICAL & PLUMBING CONTRACTOR.
- SWITCHED RECEPTACLE. SEE SHEETS E4.01 THRU E4.03 FOR SWITCH LOCATION.

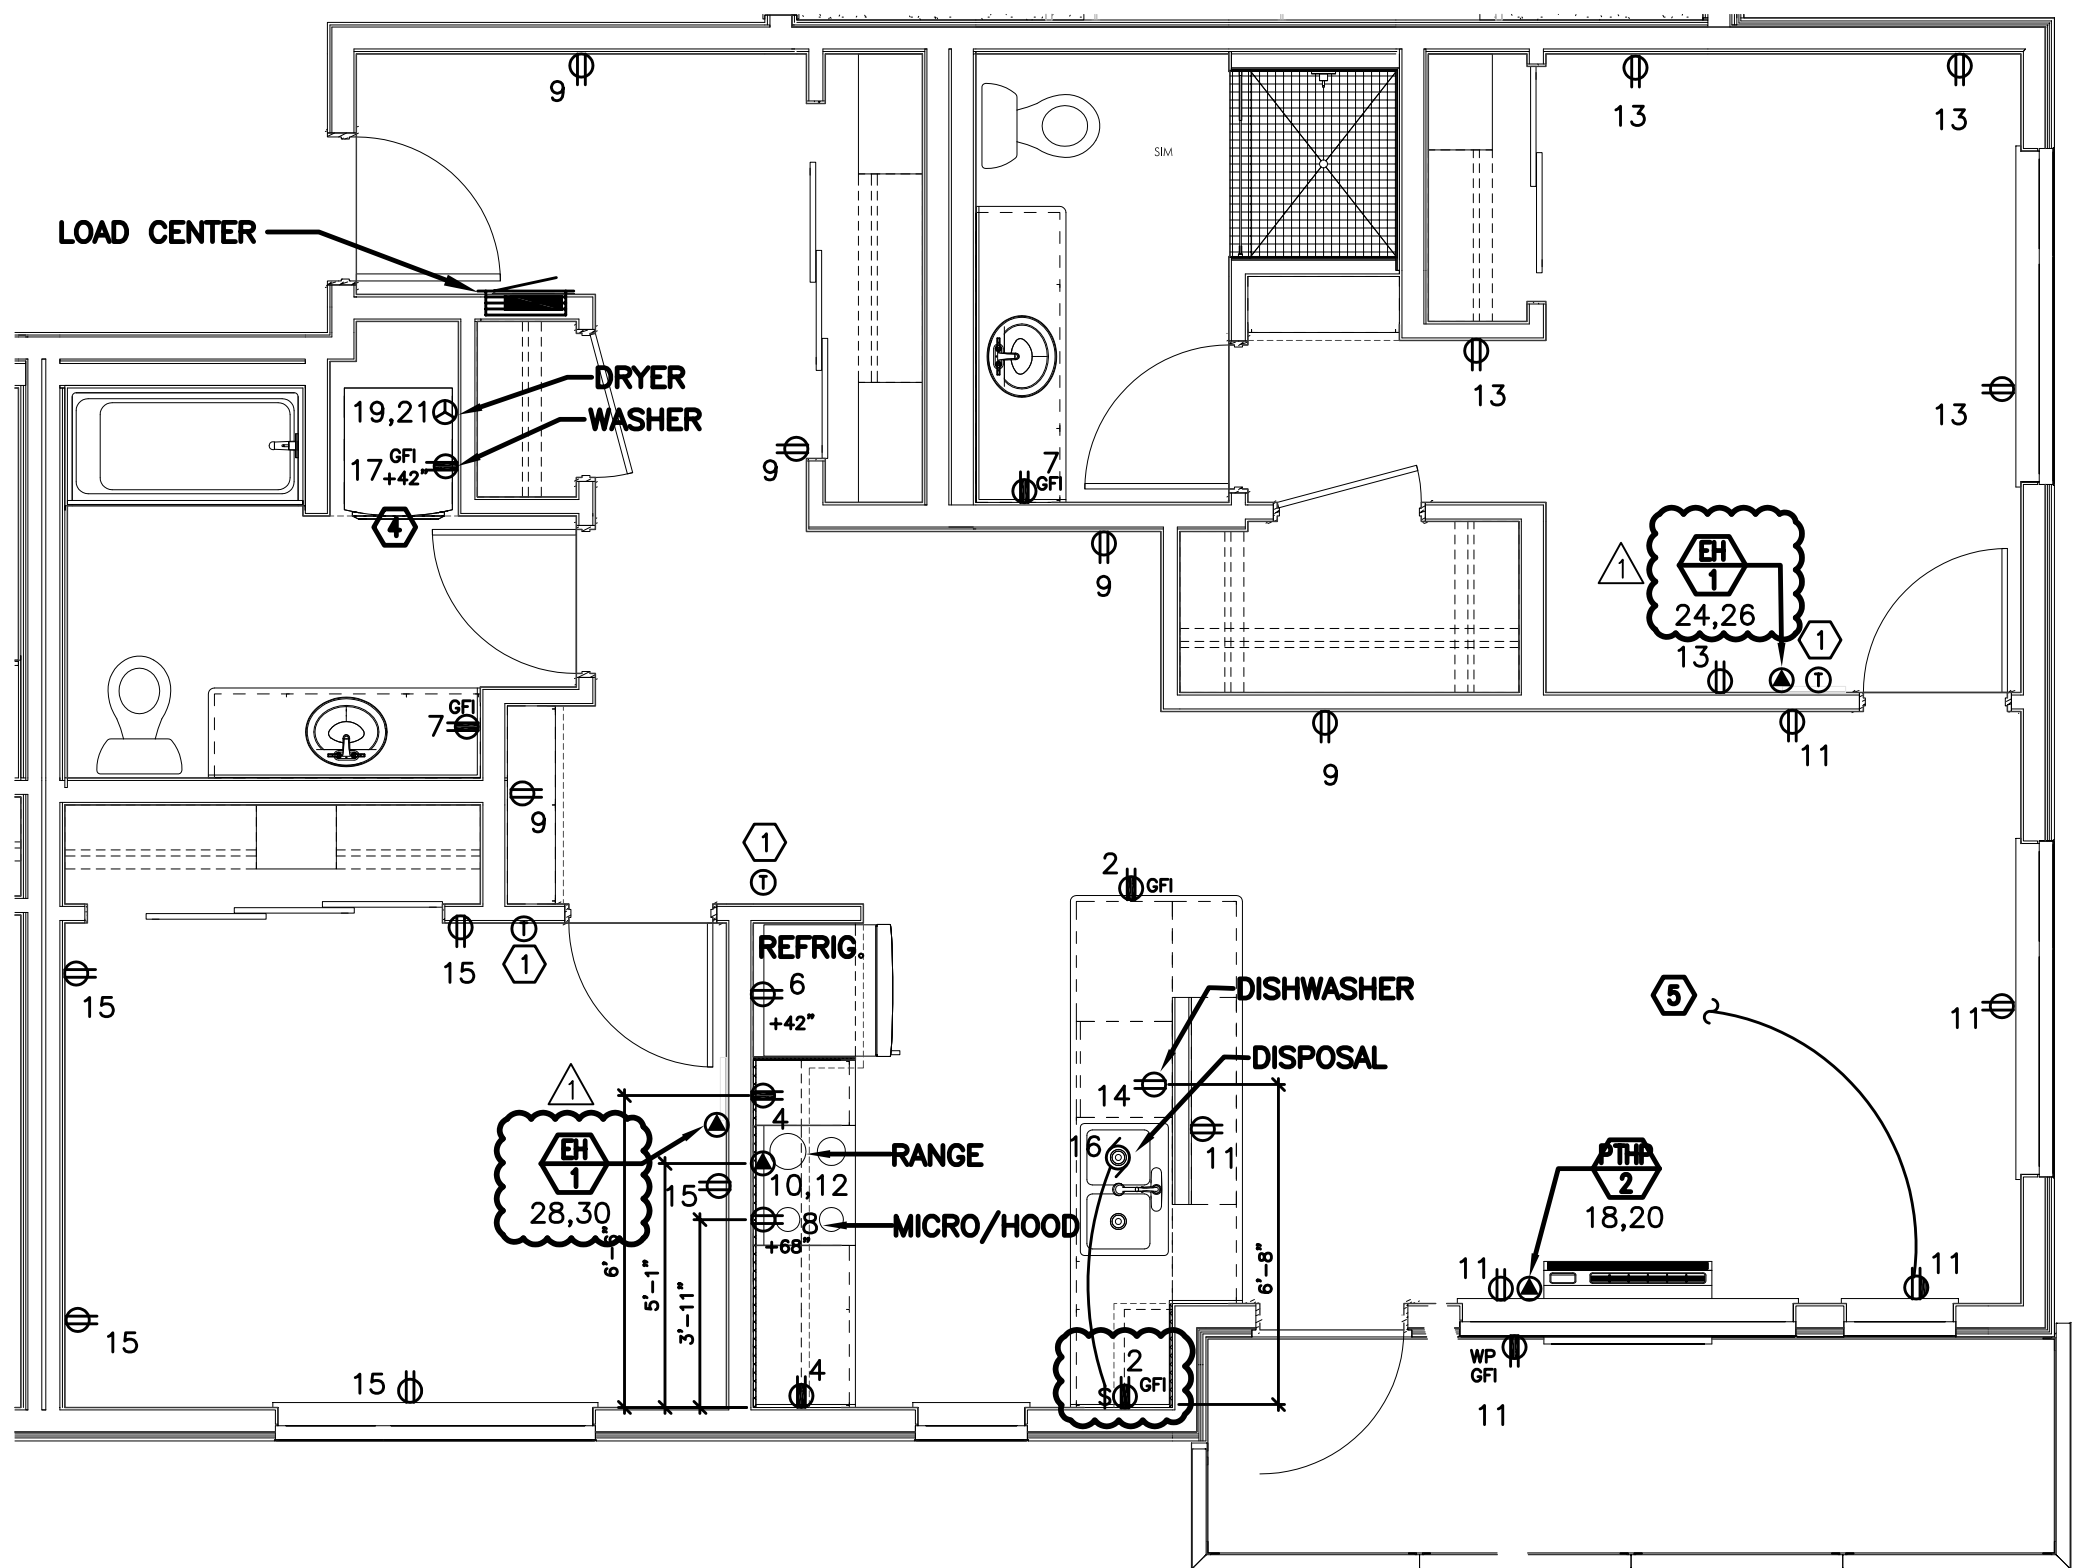

POWER PLAN
TYPICAL UNIT TYPE K
SCALE: 1/4" = 1'-0"

M Consulting Engineers
F 2007 S.E. Ash St.
E Portland, OR 97214
A PHN: (503) 234-0548
INC. FAX: (503) 234-0677
www.MFIA-ENG.COM
CONTACT: DENISE TAYLOR

SHEET:

E4.13