


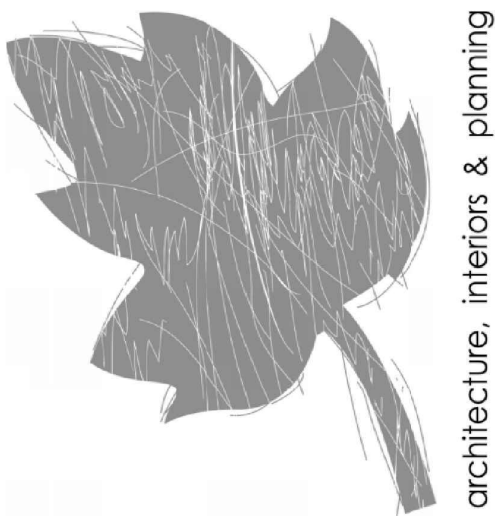

architecture, interiors & planning

419 SW 11th Ave
Suite 200
Portland OR 97205
Ph 503 228 7571
Fx 503 273 8891

Consulting Engineers
MHA INC.
P.O. Box 97214
Portland, OR 97206
PH: (503) 234-0548
FAX: (503) 234-0877
WWW.MHA-ENG.COM
CONTACT: DENISE TAYLOR

waterleaf

FULLER STATION HOUSING

PERMIT SET DOCUMENTS

9608 SE Fuller Road
Clackamas County, Oregon, 97086



PERMIT SET

PROJECT #: 1617.00


SHEET ISSUE DATE: 01/31/2020

REVISIONS:

#	DESCRIPTION	DATE
1	COUNTY REVIEW RESPONSES	10.09.2020
2	ADDENDUM #1	10.09.2020
6	ASI #01	03.03.2021
	RFI 63	07.20.2021
	RFI 92	08.10.2021
	RFI 122	09.10.2021
	RFI 42	09.30.2021
15	ASI #10	11.05.2021
	RFI 148	11.18.2021
	RFI 150	11.18.2021
	RFI 154	11.18.2021
	RFI 155	11.18.2021
17	ASI #12	12.04.2021
	RFI 170	12.06.2021

FIRST FLOOR
LIGHTING PLAN

E2.01

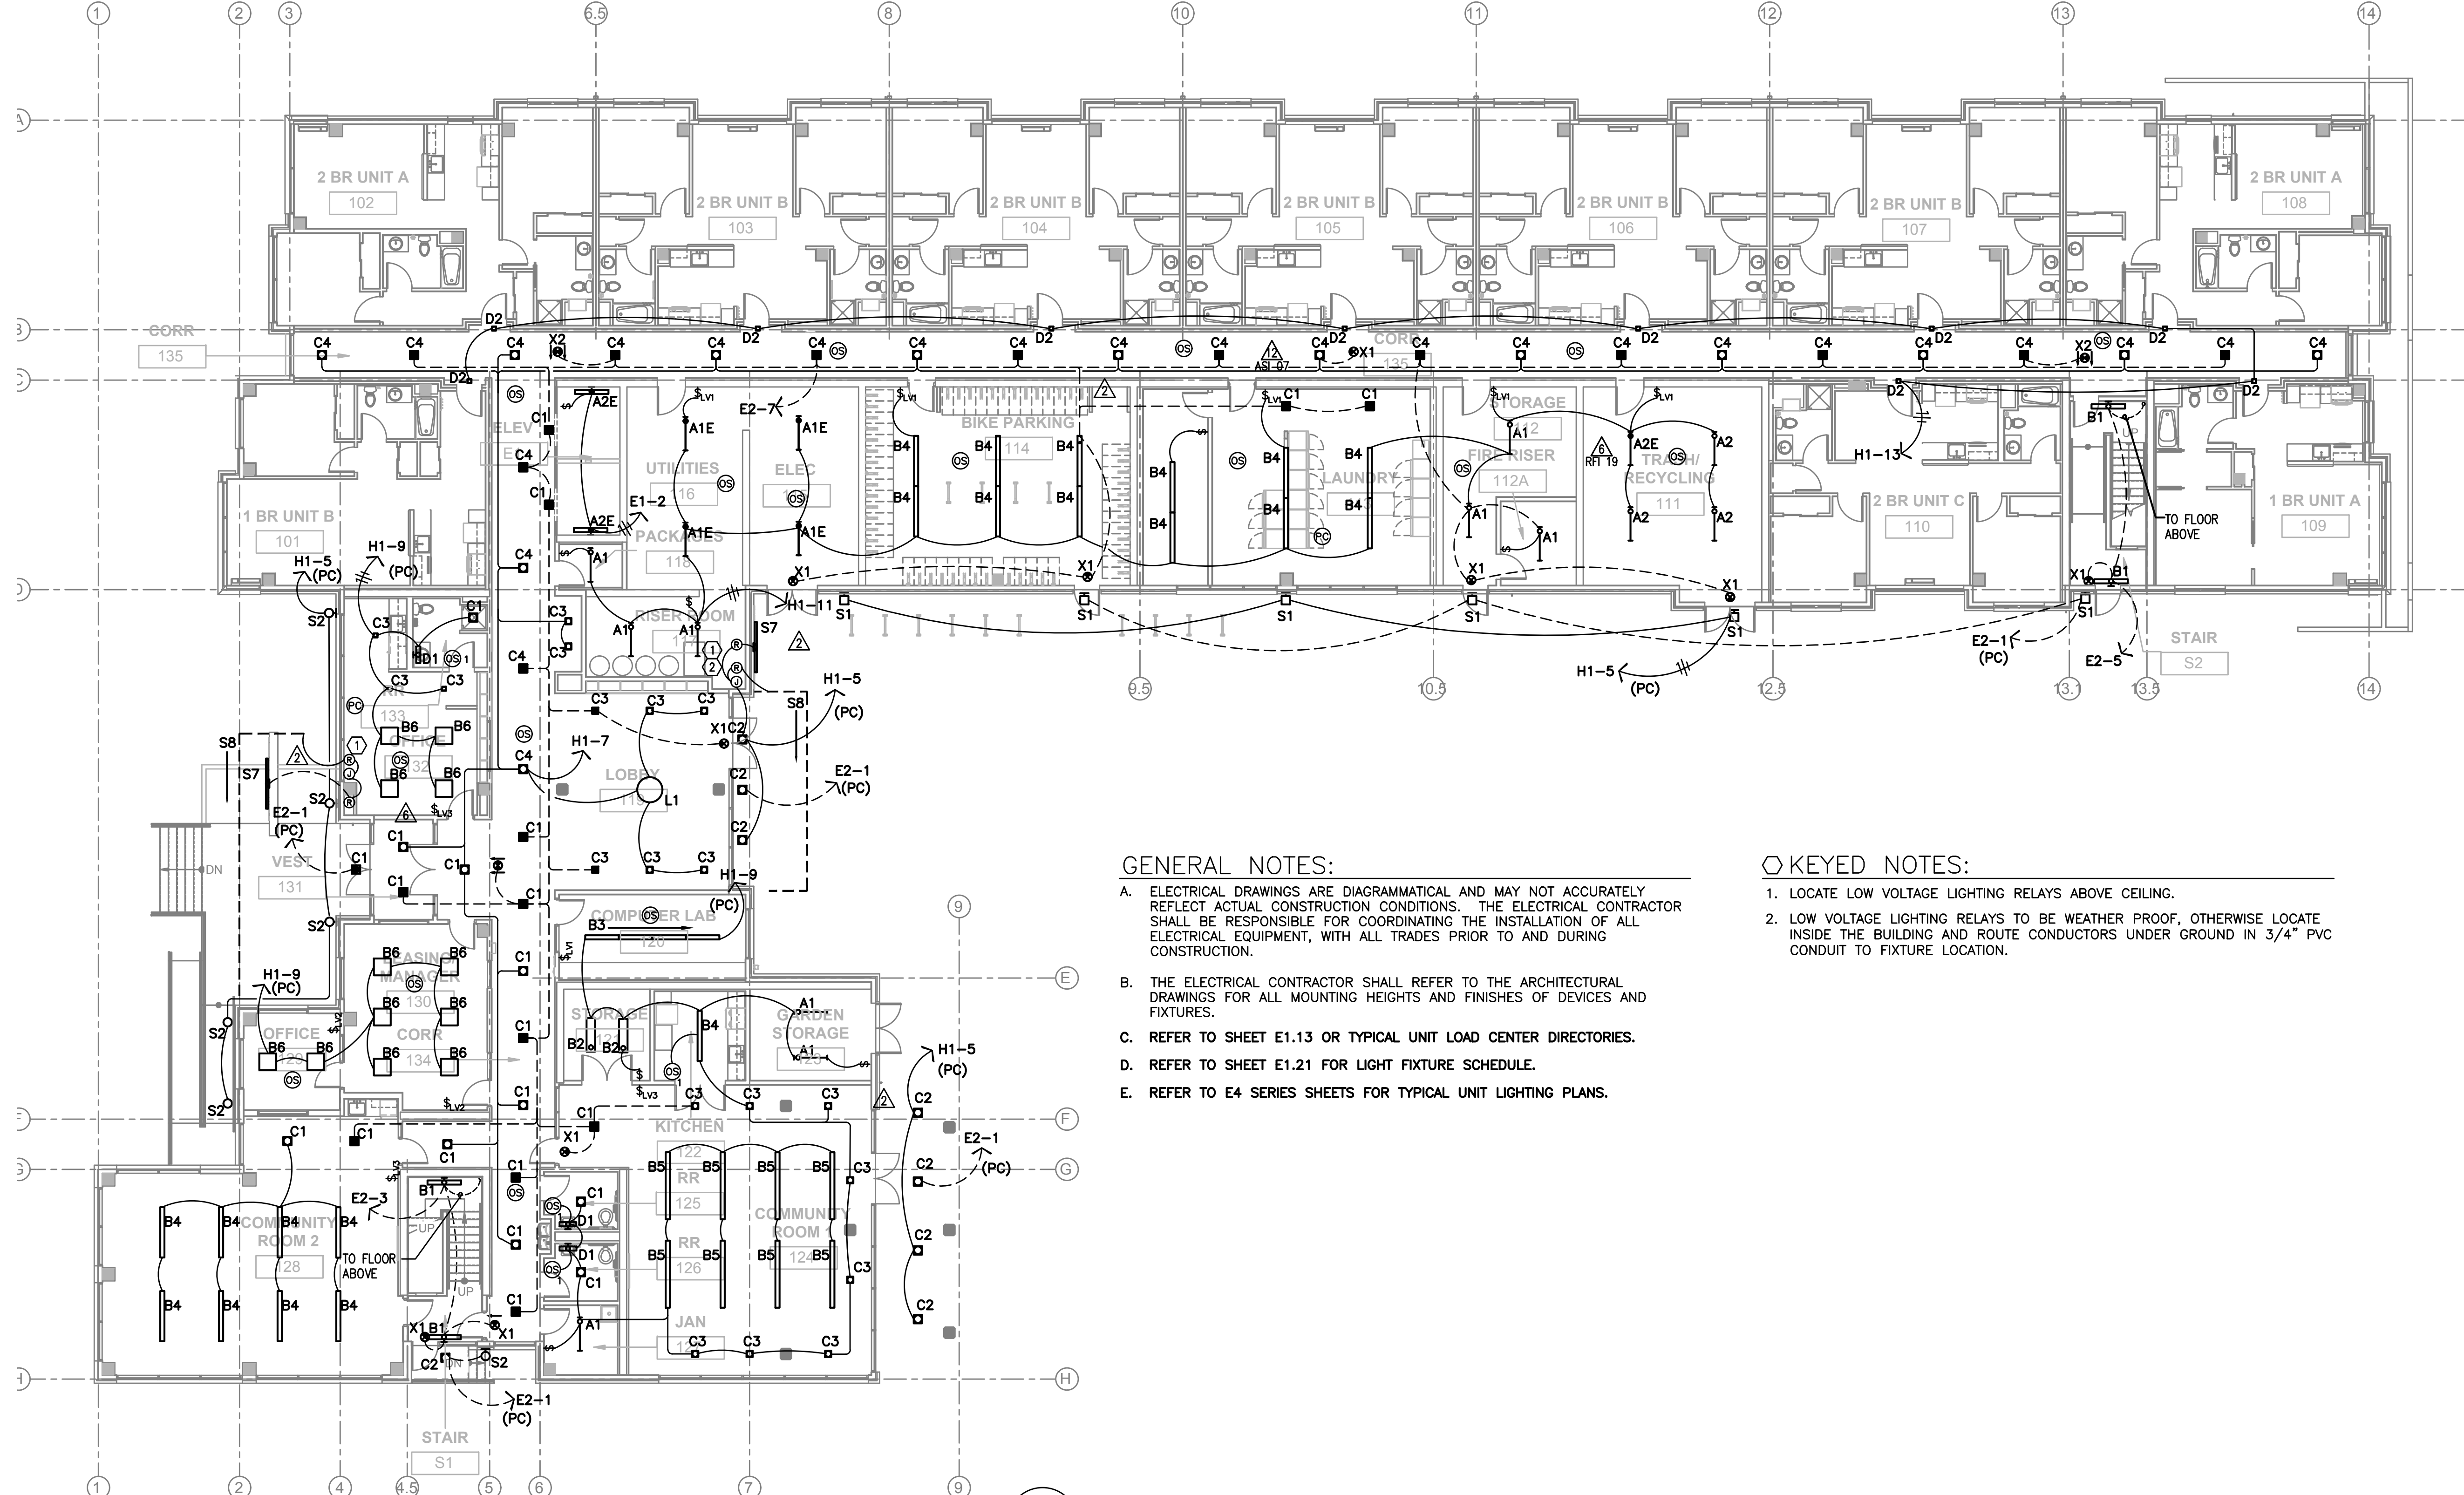

GENERAL NOTES:

- ELECTRICAL DRAWINGS ARE DIAGRAMMATICAL AND MAY NOT ACCURATELY REFLECT ACTUAL CONSTRUCTION CONDITIONS. THE ELECTRICAL CONTRACTOR SHALL BE RESPONSIBLE FOR COORDINATING THE INSTALLATION OF ALL ELECTRICAL EQUIPMENT, WITH ALL TRADES PRIOR TO AND DURING CONSTRUCTION.
- THE ELECTRICAL CONTRACTOR SHALL REFER TO THE ARCHITECTURAL DRAWINGS FOR ALL MOUNTING HEIGHTS AND FINISHES OF DEVICES AND FIXTURES.
- REFER TO SHEET E1.13 OR TYPICAL UNIT LOAD CENTER DIRECTORIES.
- REFER TO SHEET E1.21 FOR LIGHT FIXTURE SCHEDULE.
- REFER TO E4 SERIES SHEETS FOR TYPICAL UNIT LIGHTING PLANS.

KEYED NOTES:

- LOCATE LOW VOLTAGE LIGHTING RELAYS ABOVE CEILING.
- LOW VOLTAGE LIGHTING RELAYS TO BE WEATHER PROOF, OTHERWISE LOCATE INSIDE THE BUILDING AND ROUTE CONDUCTORS UNDER GROUND IN 3/4" PVC CONDUIT TO FIXTURE LOCATION.

1 FIRST FLOOR LIGHTING PLAN
E2.01 SCALE: 3/32" = 1'-0"