




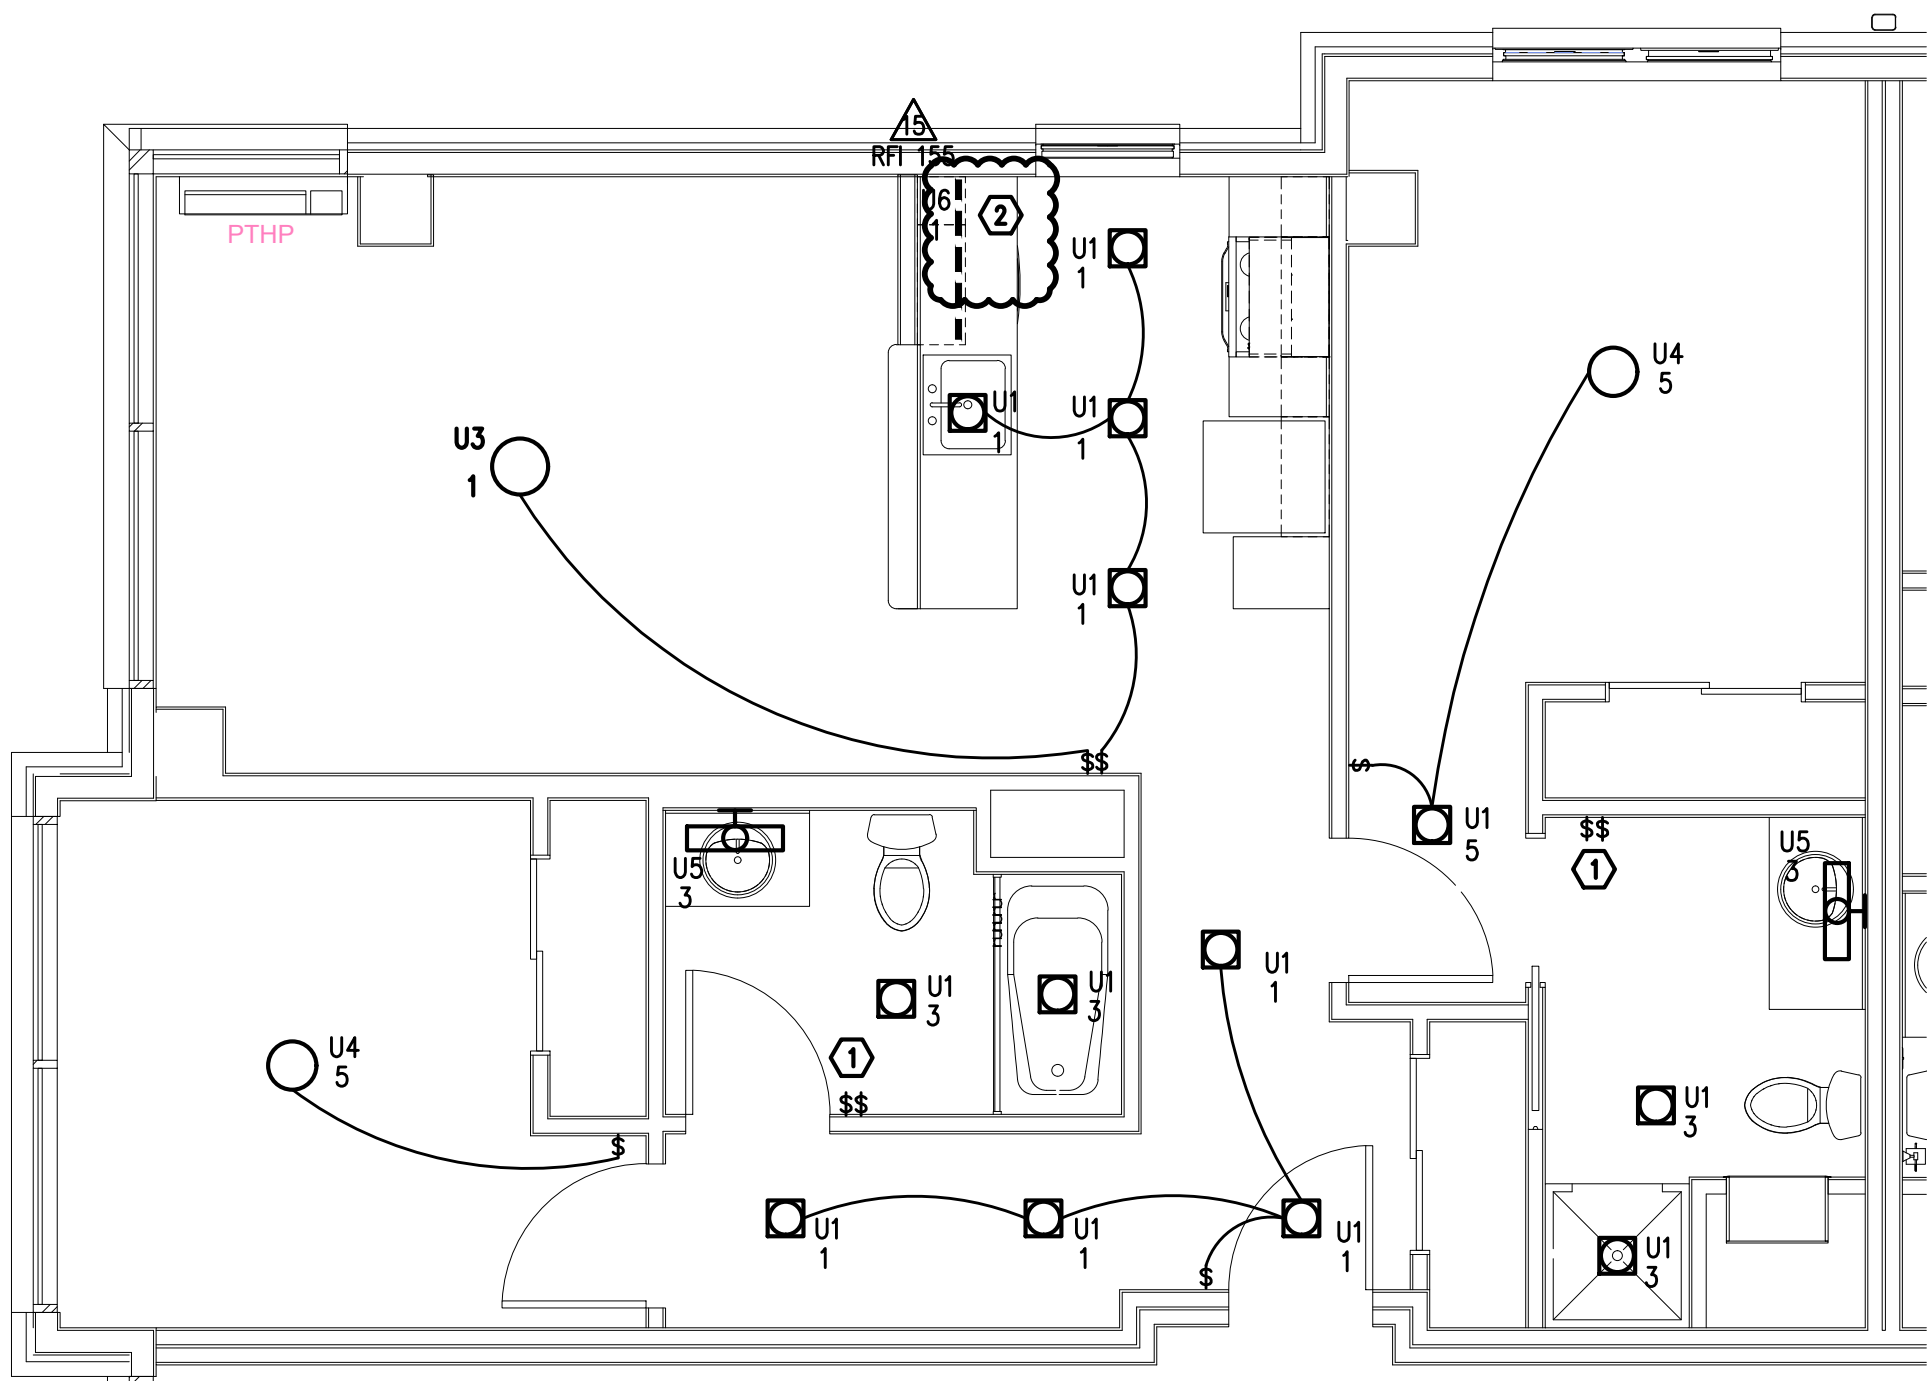

1
E4.02
TYPICAL UNIT TYPE 2A – LIGHTING PLAN
SCALE: 1/4" = 1'-0"

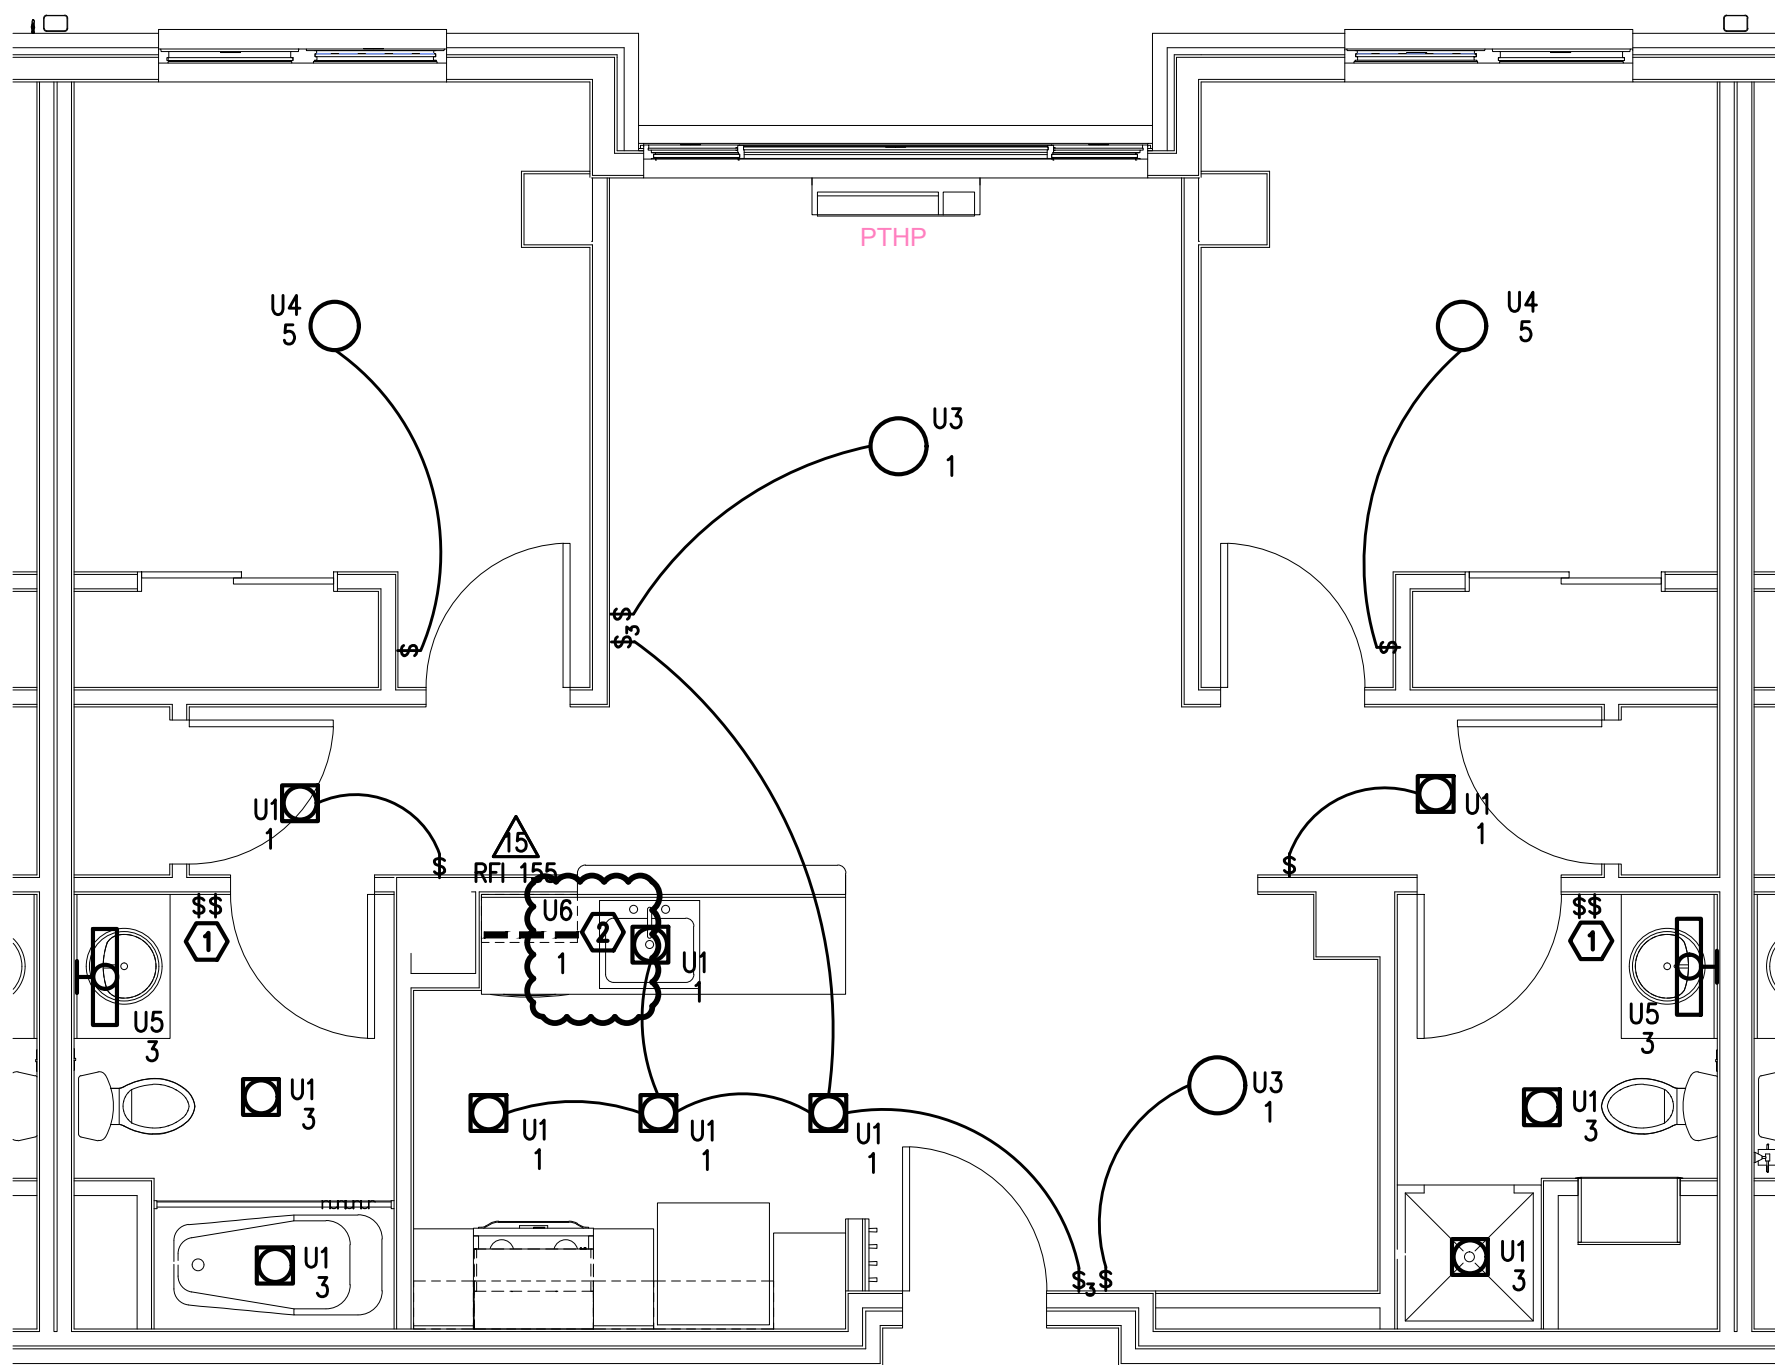

2
E4.02
TYPICAL UNIT TYPE 2B – LIGHTING PLAN
SCALE: 1/4" = 1'-0"

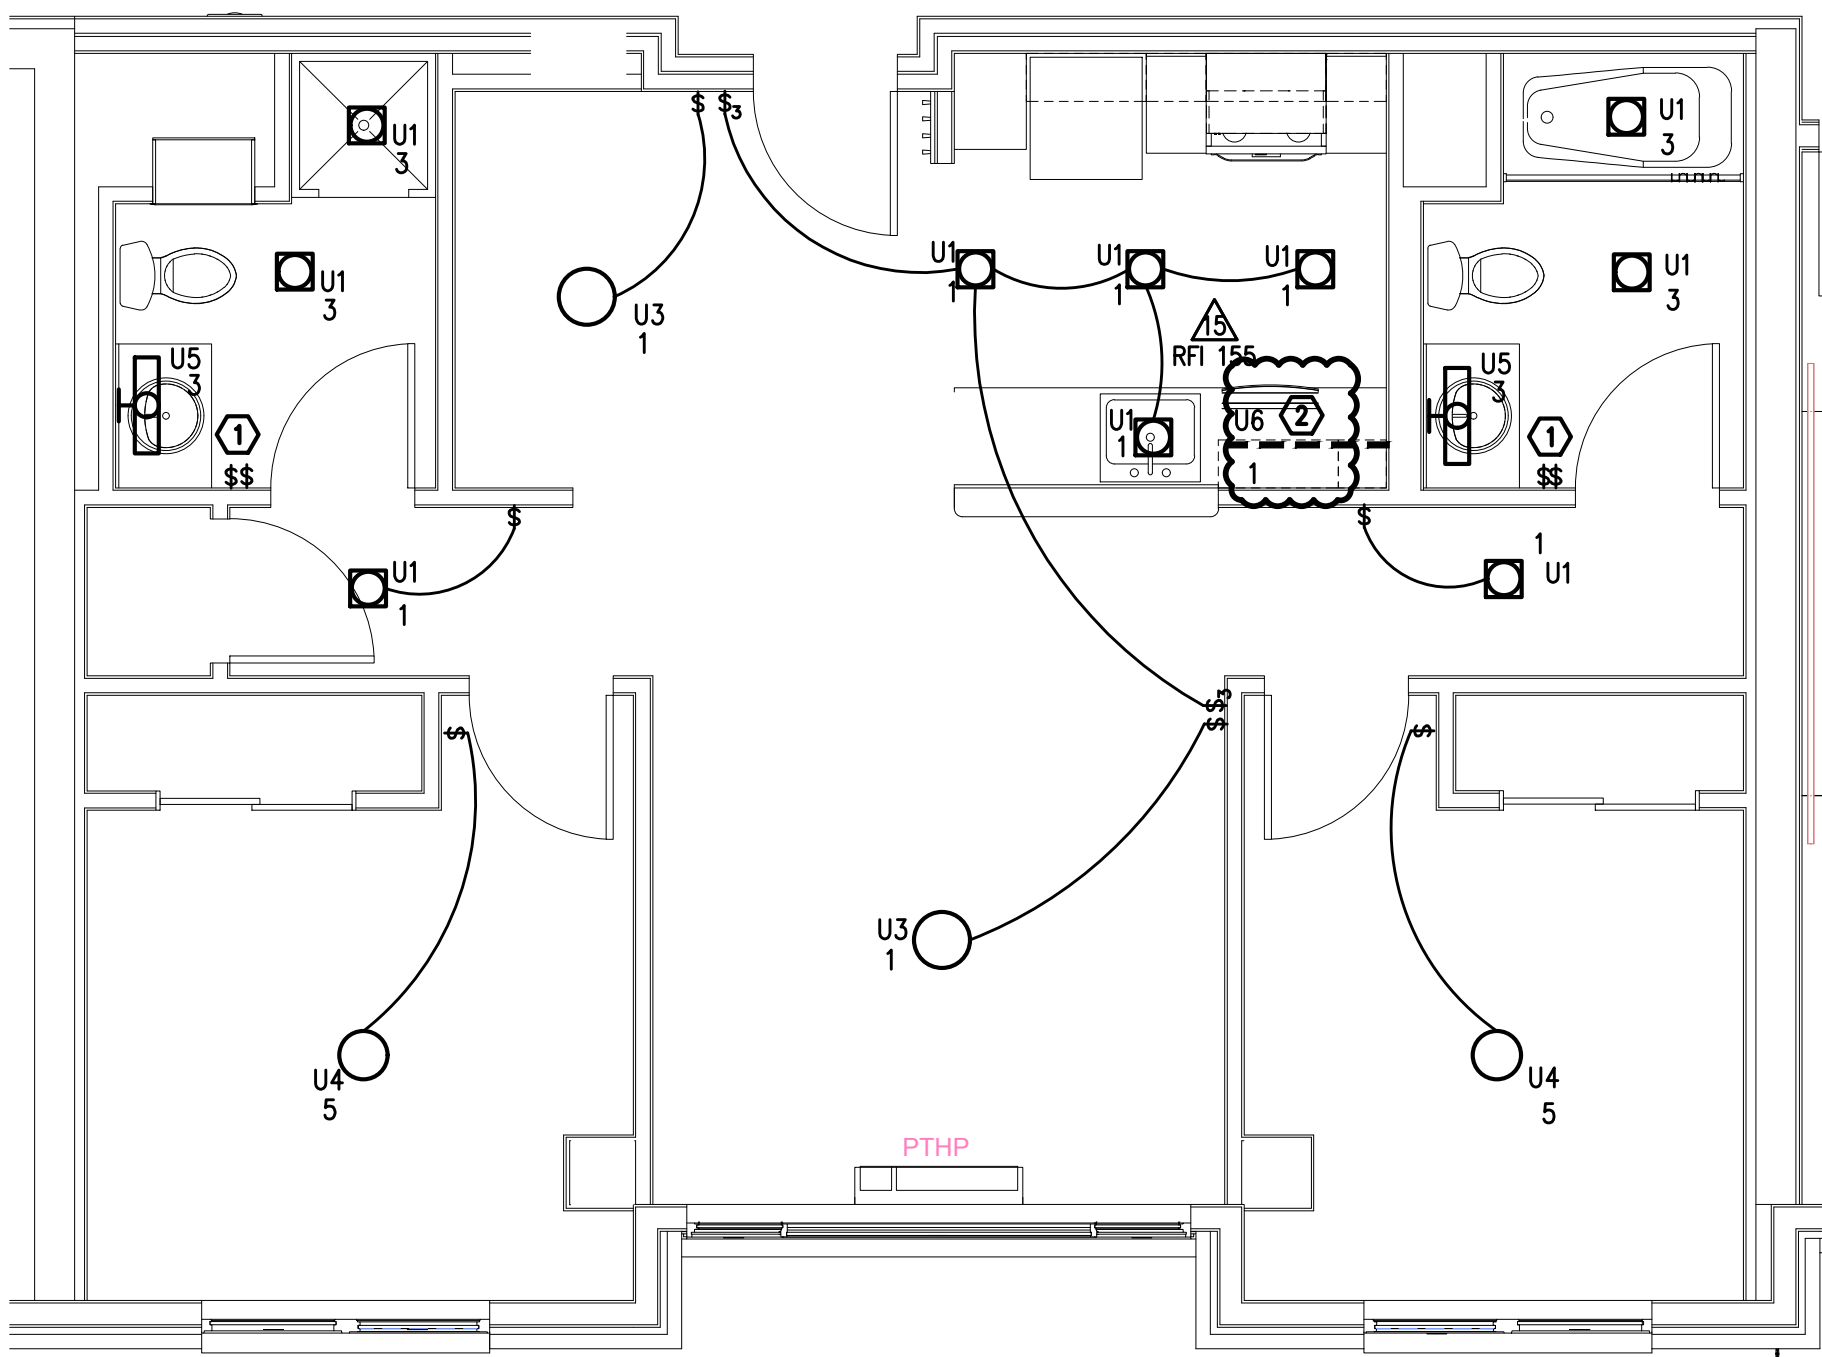

3
E4.02
TYPICAL UNIT TYPE 2C – LIGHTING PLAN
SCALE: 1/4" = 1'-0"

GENERAL NOTES:

- ALL PLANS ARE DIAGRAMMATICAL. CONSULT ARCHITECTURAL PLANS FOR EXACT LOCATION OF ALL DEVICES AND FIXTURES.
- REFER TO SHEET E1.14 FOR TYPICAL UNIT LOAD CENTER DIRECTORIES.
- ALL LIGHT SWITCHES SHALL BE ROCKER STYLE, SUCH AS LEVITON DECORA, OR APPROVED EQUAL.
- REFER TO SHEETS E4.11 – E4.14 FOR TYPICAL UNIT POWER PLANS.

KEYED NOTES:

- REFER TO E1.22 FOR TYPICAL BATHROOM SWITCHING DIAGRAM.
- REFER TO E4.1 SERIES SHEETS FOR UNDER CABINET LIGHT SWITCH LOCATION.



419 SW 11th Ave
Suite 200
Portland OR 97205
Ph 503 228 7571
Fx 503 273 8891

Consulting Engineers
M
H
A
INC.
PH: (503) 234-0648
FAX: (503) 234-0877
WWW.MHA-ENG.COM
CONTACT: DENISE TAYLOR

FULLER STATION HOUSING

PERMIT SET
DOCUMENTS

9608 SE Fuller Road
Clackamas County, Oregon, 97086



PERMIT SET

PROJECT #: 1617.00

SHEET ISSUE DATE: 01/31/2020

REVISIONS:

#	DESCRIPTION	DATE
1	COUNTY REVIEW RESPONSES	10.09.2020
2	ADDENDUM #1	10.09.2020
6	ASI #01	03.03.2021
	RFI 60	07.20.2021
	RFI 68	08.10.2021
	RFI 92	09.10.2021
	RFI 42	09.30.2021
15	ASI #10	11.05.2021
	RFI 148	11.18.2021
	RFI 150	11.18.2021
	RFI 154	11.18.2021
	RFI 155	11.18.2021
17	ASI #12	12.04.2021
	RFI 170	12.04.2021

ENLARGE UNIT
LIGHTING PLANS

E4.02