




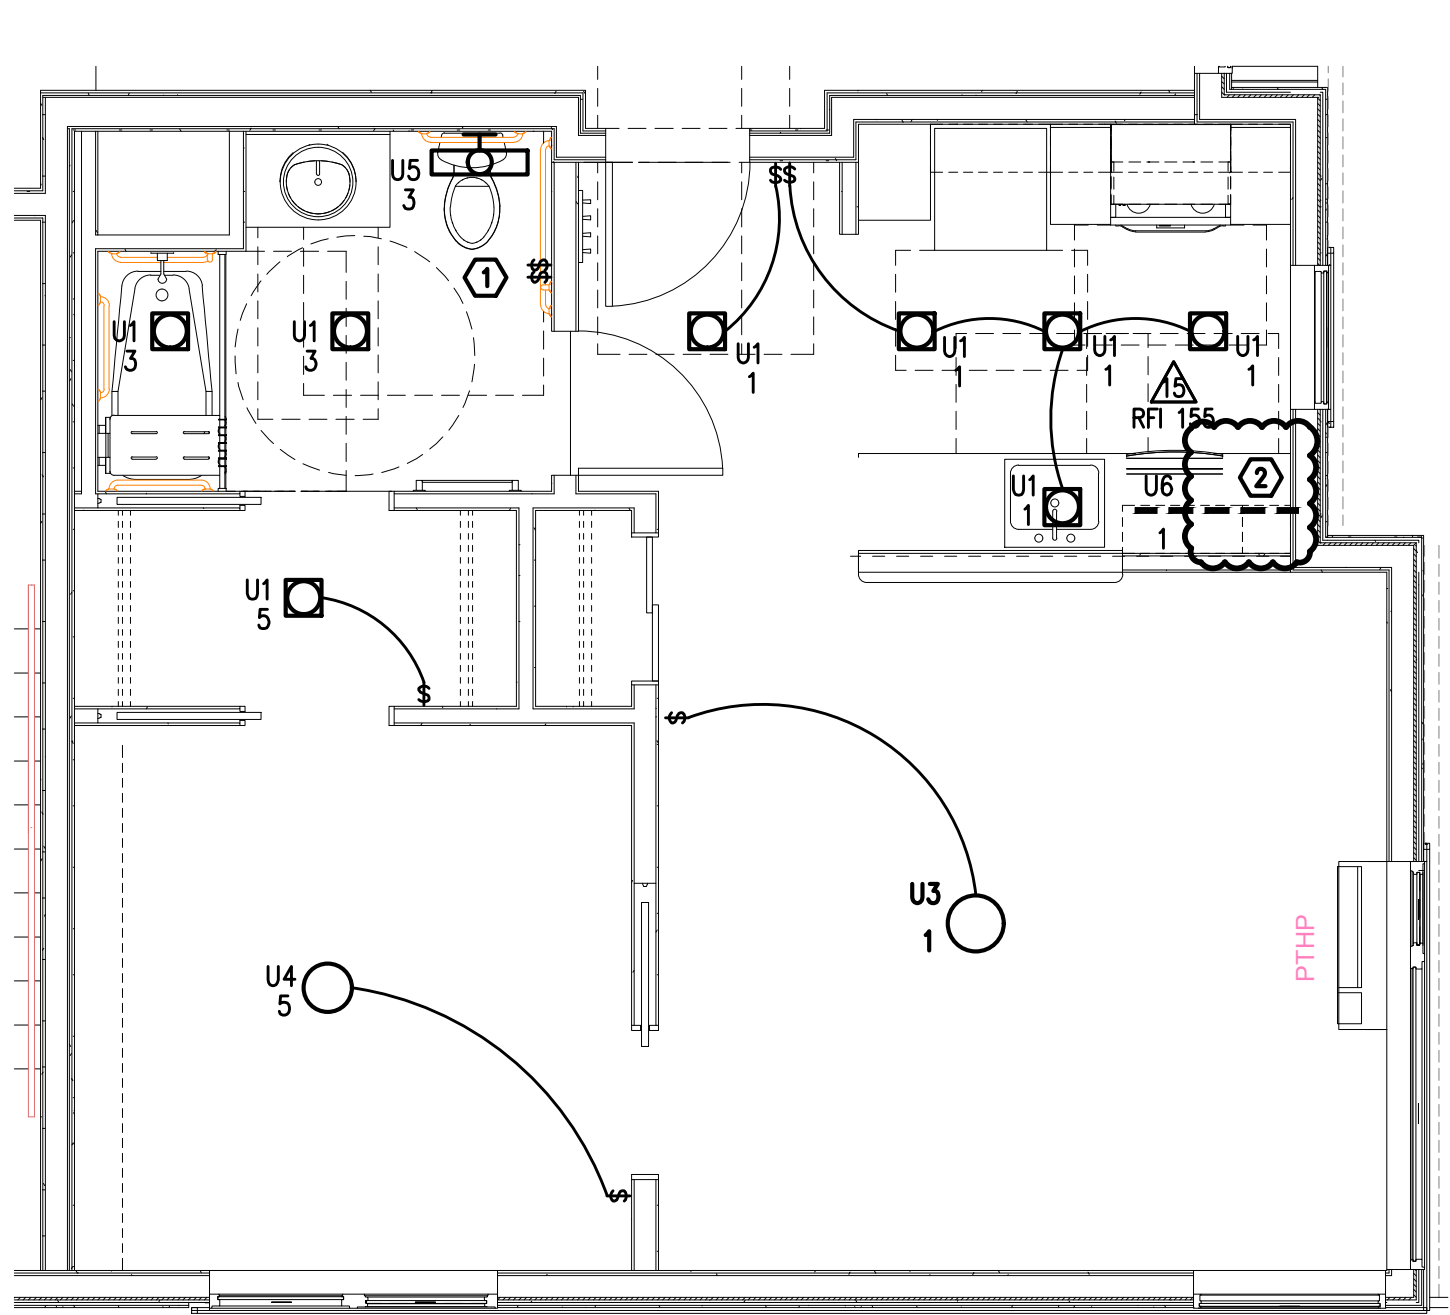


1 TYPICAL UNIT TYPE 1A/ADA - LIGHTING PLAN
 SCALE: 1/4" = 1'-0"
 (UNIT 209)

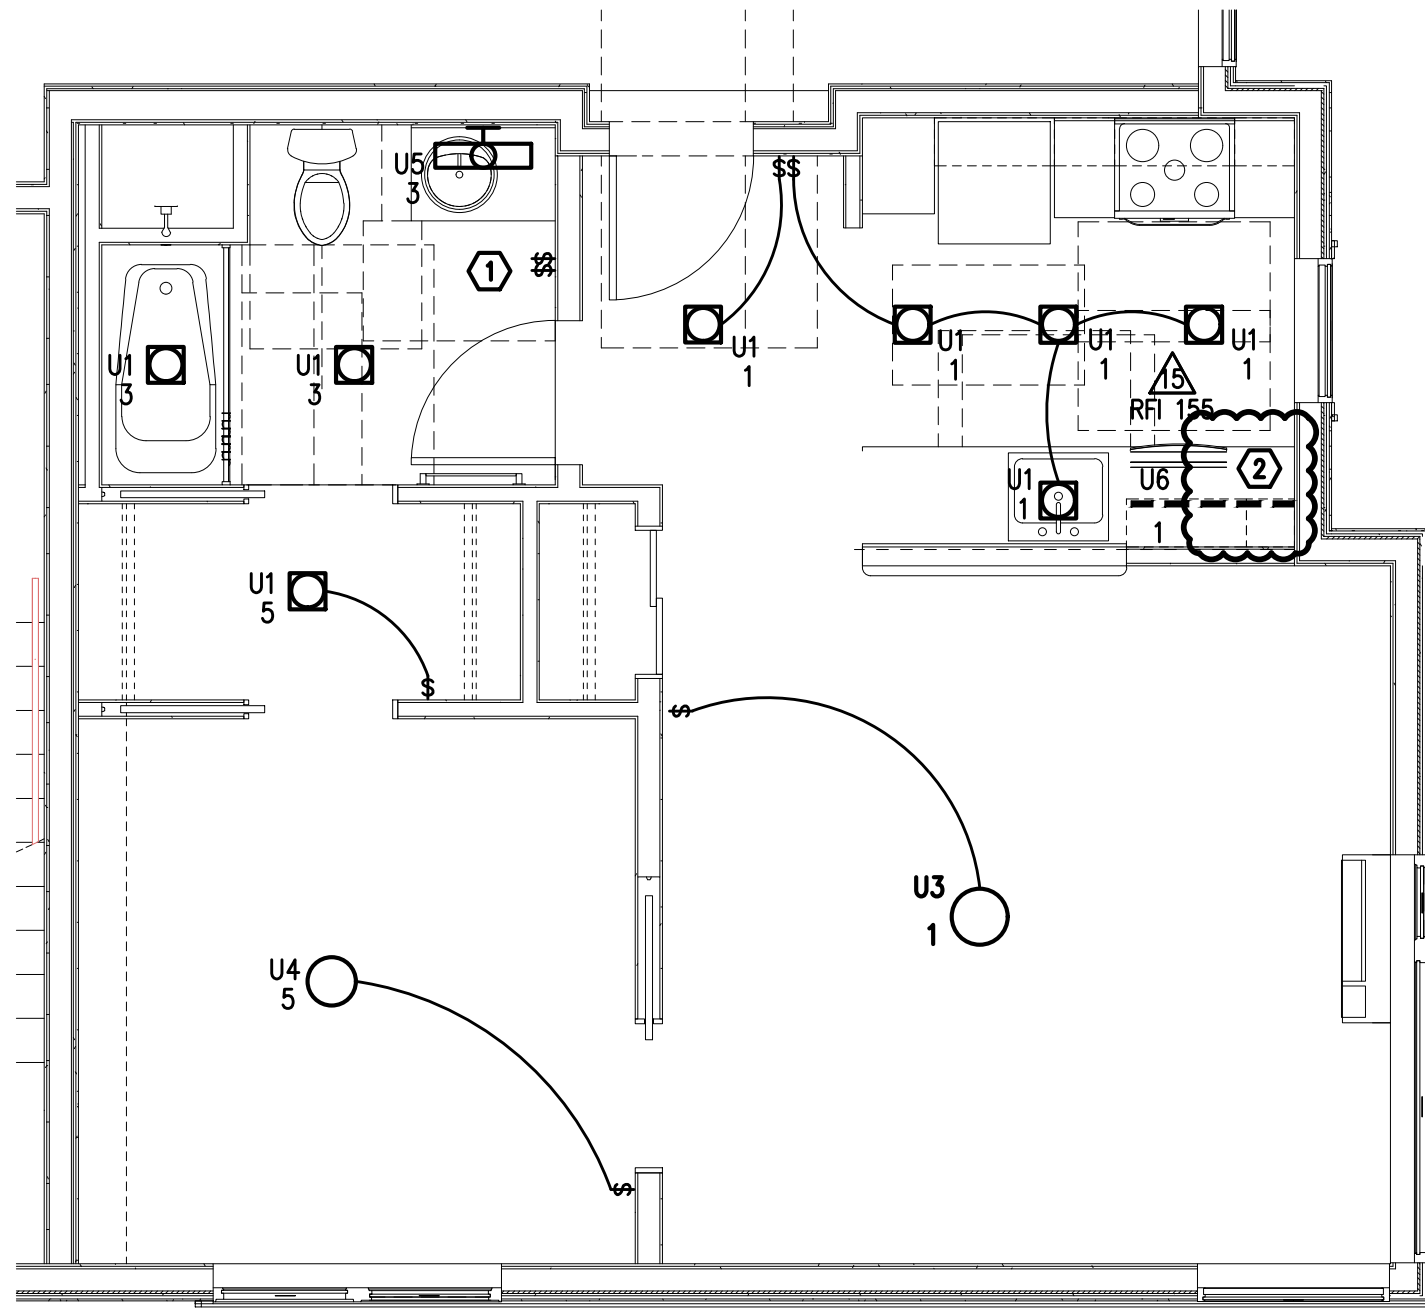

2 TYPICAL UNIT TYPE 1A - POWER PLAN
 SCALE: 1/4" = 1'-0"
 (FLOORS 3-6)

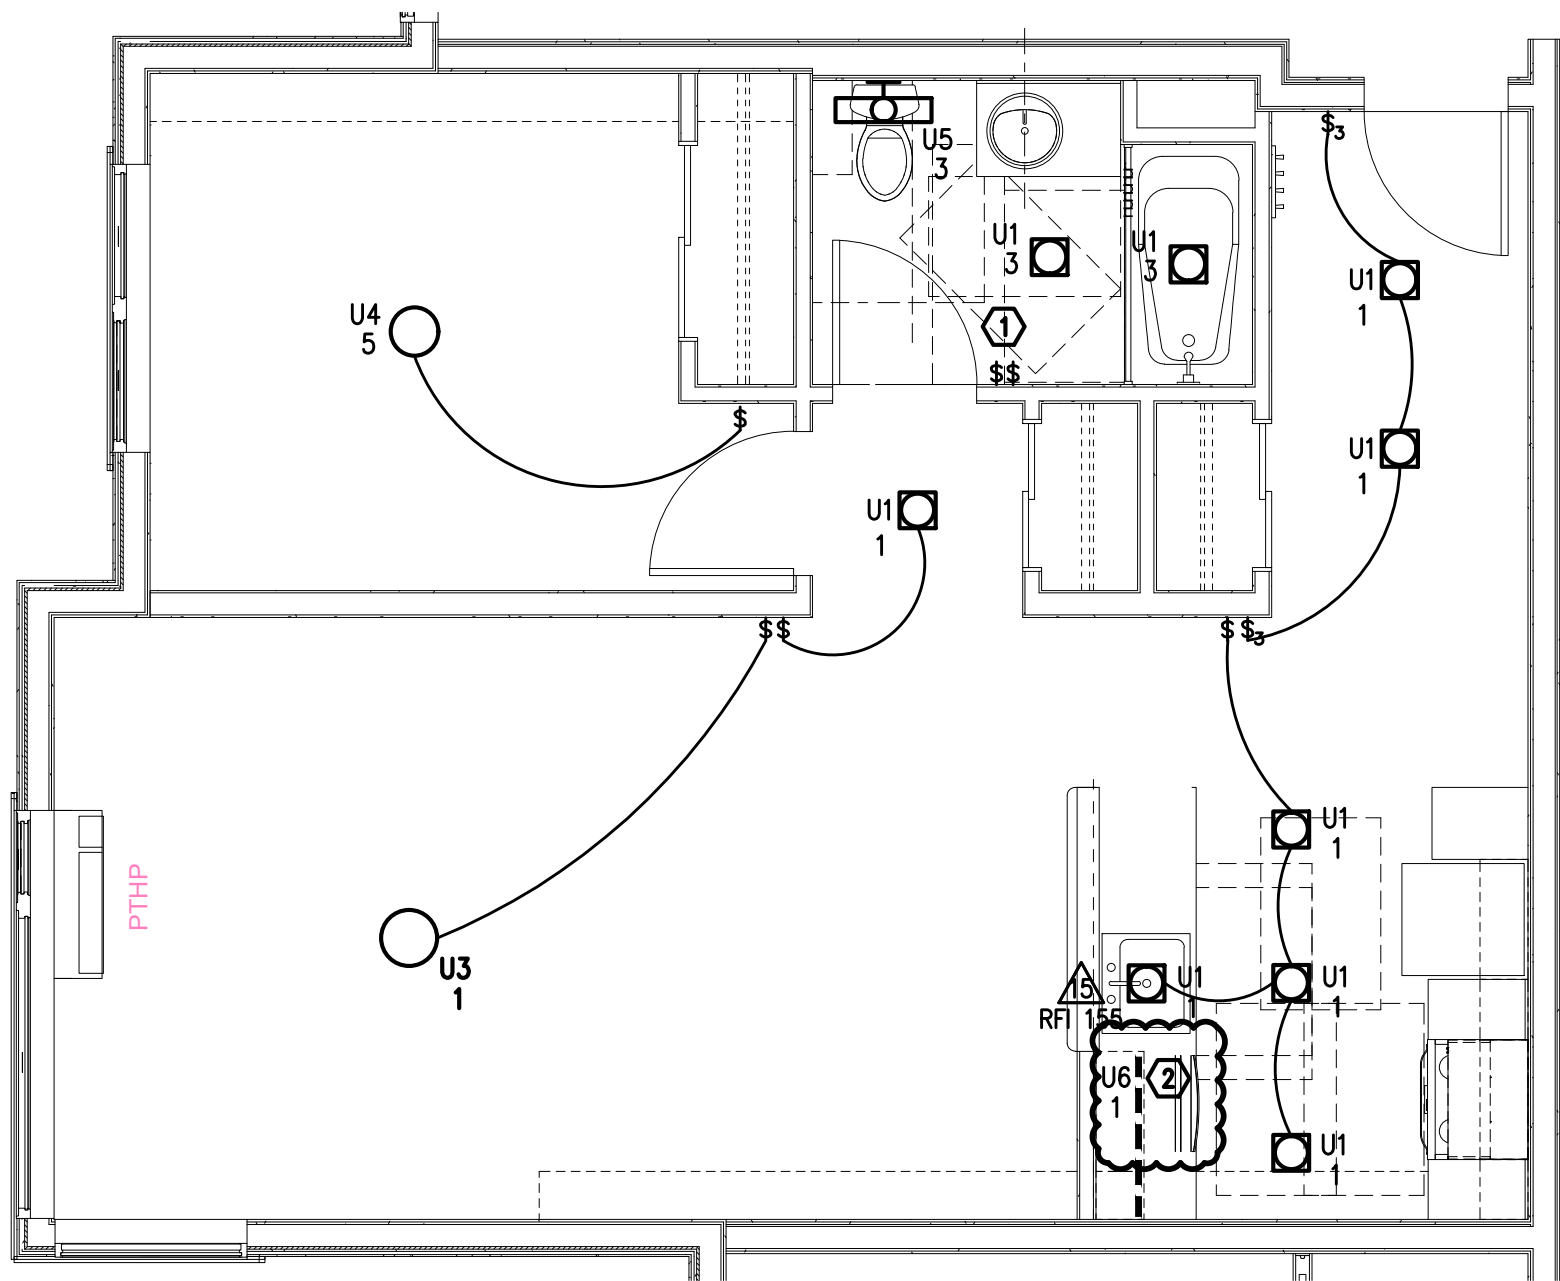

3 TYPICAL UNIT TYPE 1B - LIGHTING PLAN
 SCALE: 1/4" = 1'-0"
 (FLOORS 2-6)

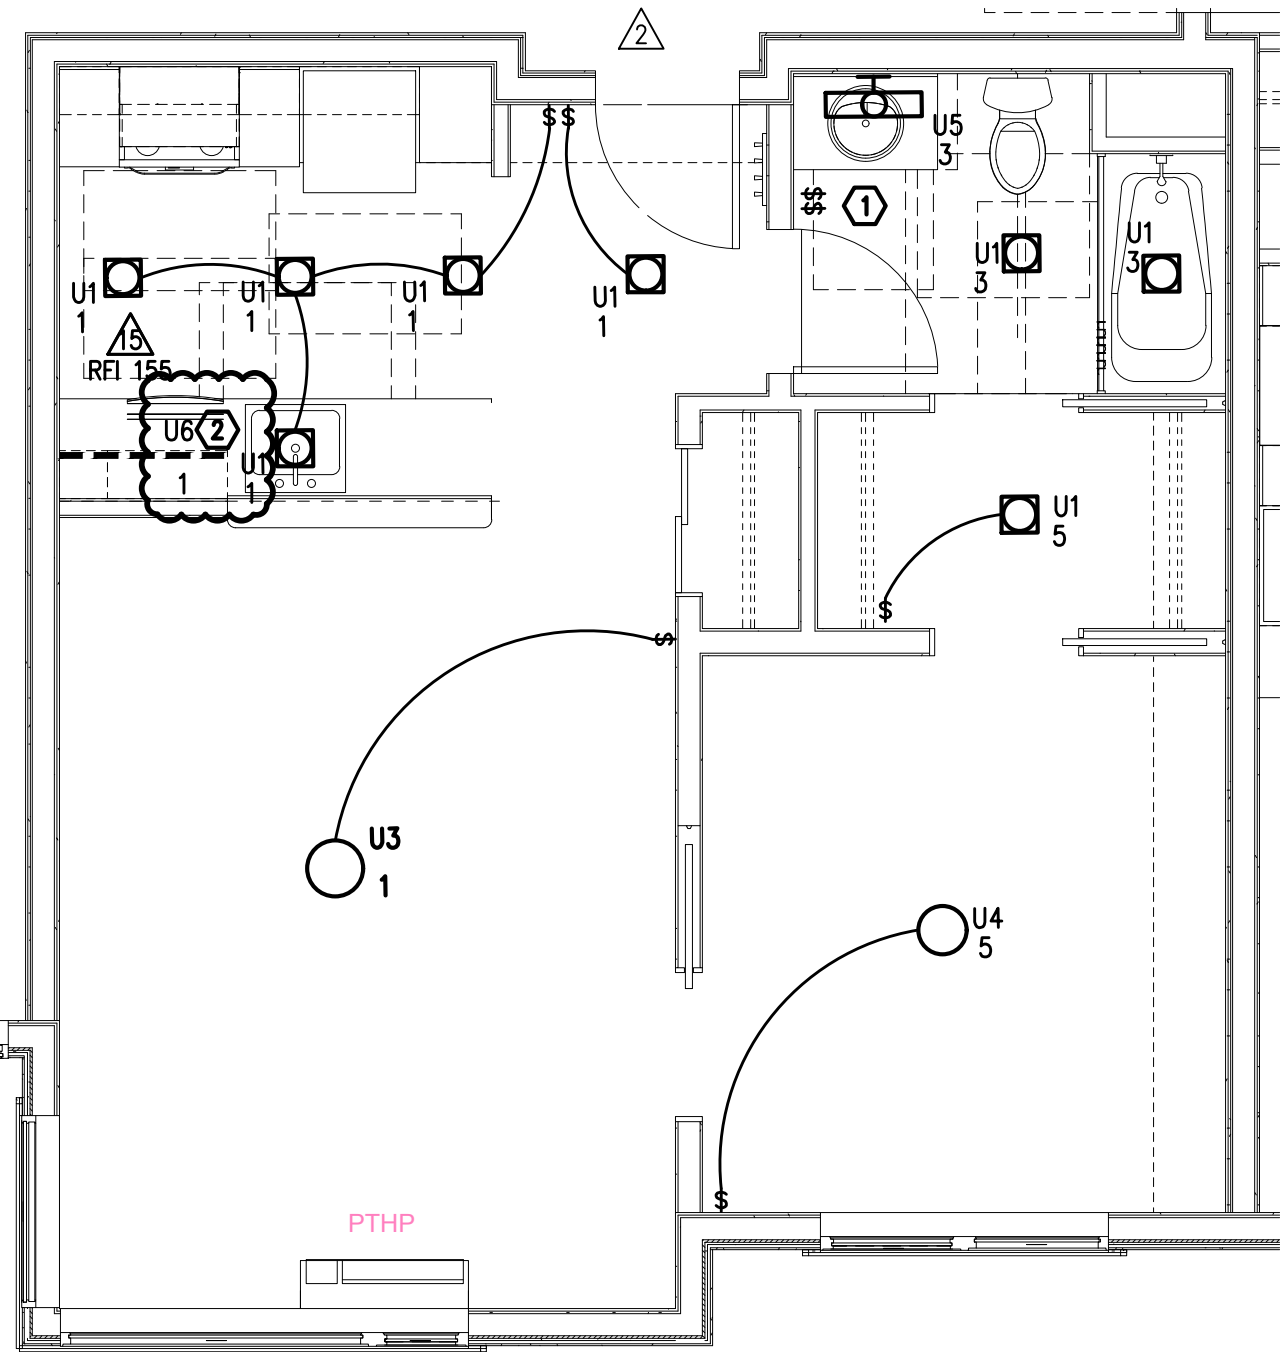

4 TYPICAL UNIT TYPE 1C - LIGHTING PLAN
 SCALE: 1/4" = 1'-0"

GENERAL NOTES:

- ALL PLANS ARE DIAGRAMMATICAL. CONSULT ARCHITECTURAL PLANS FOR EXACT LOCATION OF ALL DEVICES AND FIXTURES.
- REFER TO SHEET E1.14 FOR TYPICAL UNIT LOAD CENTER DIRECTORIES.
- ALL LIGHT SWITCHES SHALL BE ROCKER STYLE, SUCH AS LEVITON DECORA, OR APPROVED EQUAL.
- REFER TO SHEETS E4.11 - E4.14 FOR TYPICAL UNIT POWER PLANS.

KEYED NOTES:

- REFER TO E1.22 FOR TYPICAL BATHROOM SWITCHING DIAGRAM.
- REFER TO E4.1 SERIES SHEETS FOR UNDER CABINET LIGHT SWITCH LOCATION.



waterleaf


4179 SW 11th Ave
 Suite 200
 Portland OR 97205
 Ph 503 228 7571
 Fx 503 273 8891

Consulting Engineers
 M
 H
 INC.
 97014
 PHN: (503) 234-0548
 FAX: (503) 234-0877
 WWW.MH-ENG.COM
 CONTACT: DENISE TAYLOR

FULLER STATION HOUSING

PERMIT SET
 DOCUMENTS

9608 SE Fuller Road
 Clackamas County, Oregon, 97086

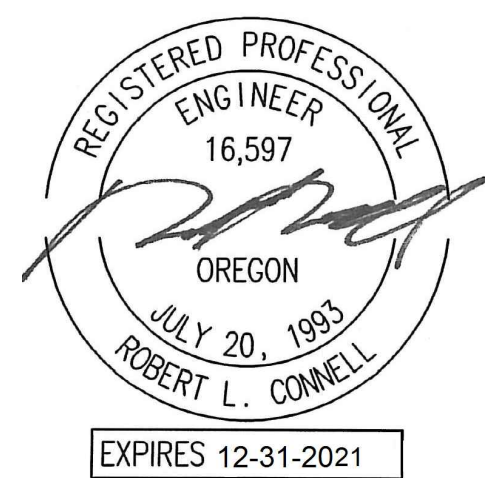

PERMIT SET

PROJECT #: 1617.00

SHEET ISSUE DATE: 01/31/2020

REVISIONS:

#	DESCRIPTION	DATE
1	COUNTY REVIEW RESPONSES	10.09.2020
2	ADDENDUM #1	10.09.2020
6	ASI #01	03.03.2021
	RFI 61	07.20.2021
	RFI 63	08.10.2021
	RFI 92	09.10.2021
	RFI 42	09.30.2021
15	ASI #10	11.05.2021
	RFI 148	11.18.2021
	RFI 150	11.18.2021
	RFI 154	11.18.2021
	RFI 155	11.18.2021
17	ASI #12	12.04.2021
	RFI 170	12.06.2021

ENLARGE UNIT
 LIGHTING PLANS

E4.03