


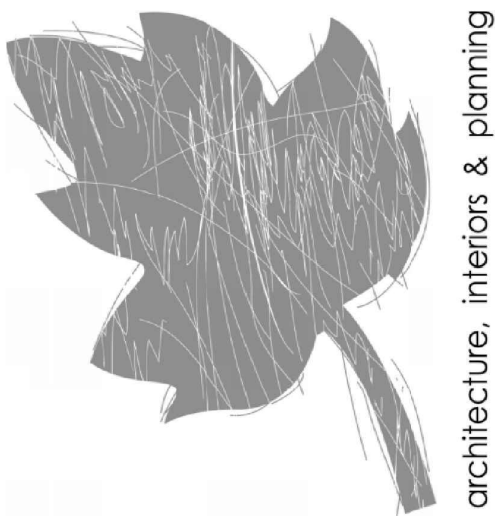

419 SW 11th Ave
Suite 200
Portland OR 97205
Ph 503 228 7571
Fx 503 273 8891

Consulting Engineers
M
H
I
N
C
P.O. Box 97214
Portland, OR 97206
PHN: (503) 234-0548
FAX: (503) 234-0877
WWW.MHIA-ENG.COM
CONTACT: DENISE TAYLOR

GENERAL NOTES:


- A. ALL PLANS ARE DIAGRAMMATICAL. CONSULT ARCHITECTURAL PLANS FOR EXACT LOCATION OF ALL DEVICES AND FIXTURES.
- B. REFER TO SHEET E1.14 FOR TYPICAL UNIT LOAD CENTER DIRECTORIES.
- C. ALL LIGHT SWITCHES SHALL BE ROCKER STYLE, SUCH AS LEVITON DECORA, OR APPROVED EQUAL.
- D. REFER TO SHEETS E4.11 - E4.14 FOR TYPICAL UNIT POWER PLANS.

KEYED NOTES:


- 1. REFER TO E1.22 FOR TYPICAL BATHROOM SWITCHING DIAGRAM.
- 2. REFER TO E4.1 SERIES SHEETS FOR UNDER CABINET LIGHT SWITCH LOCATION.




RFI 154

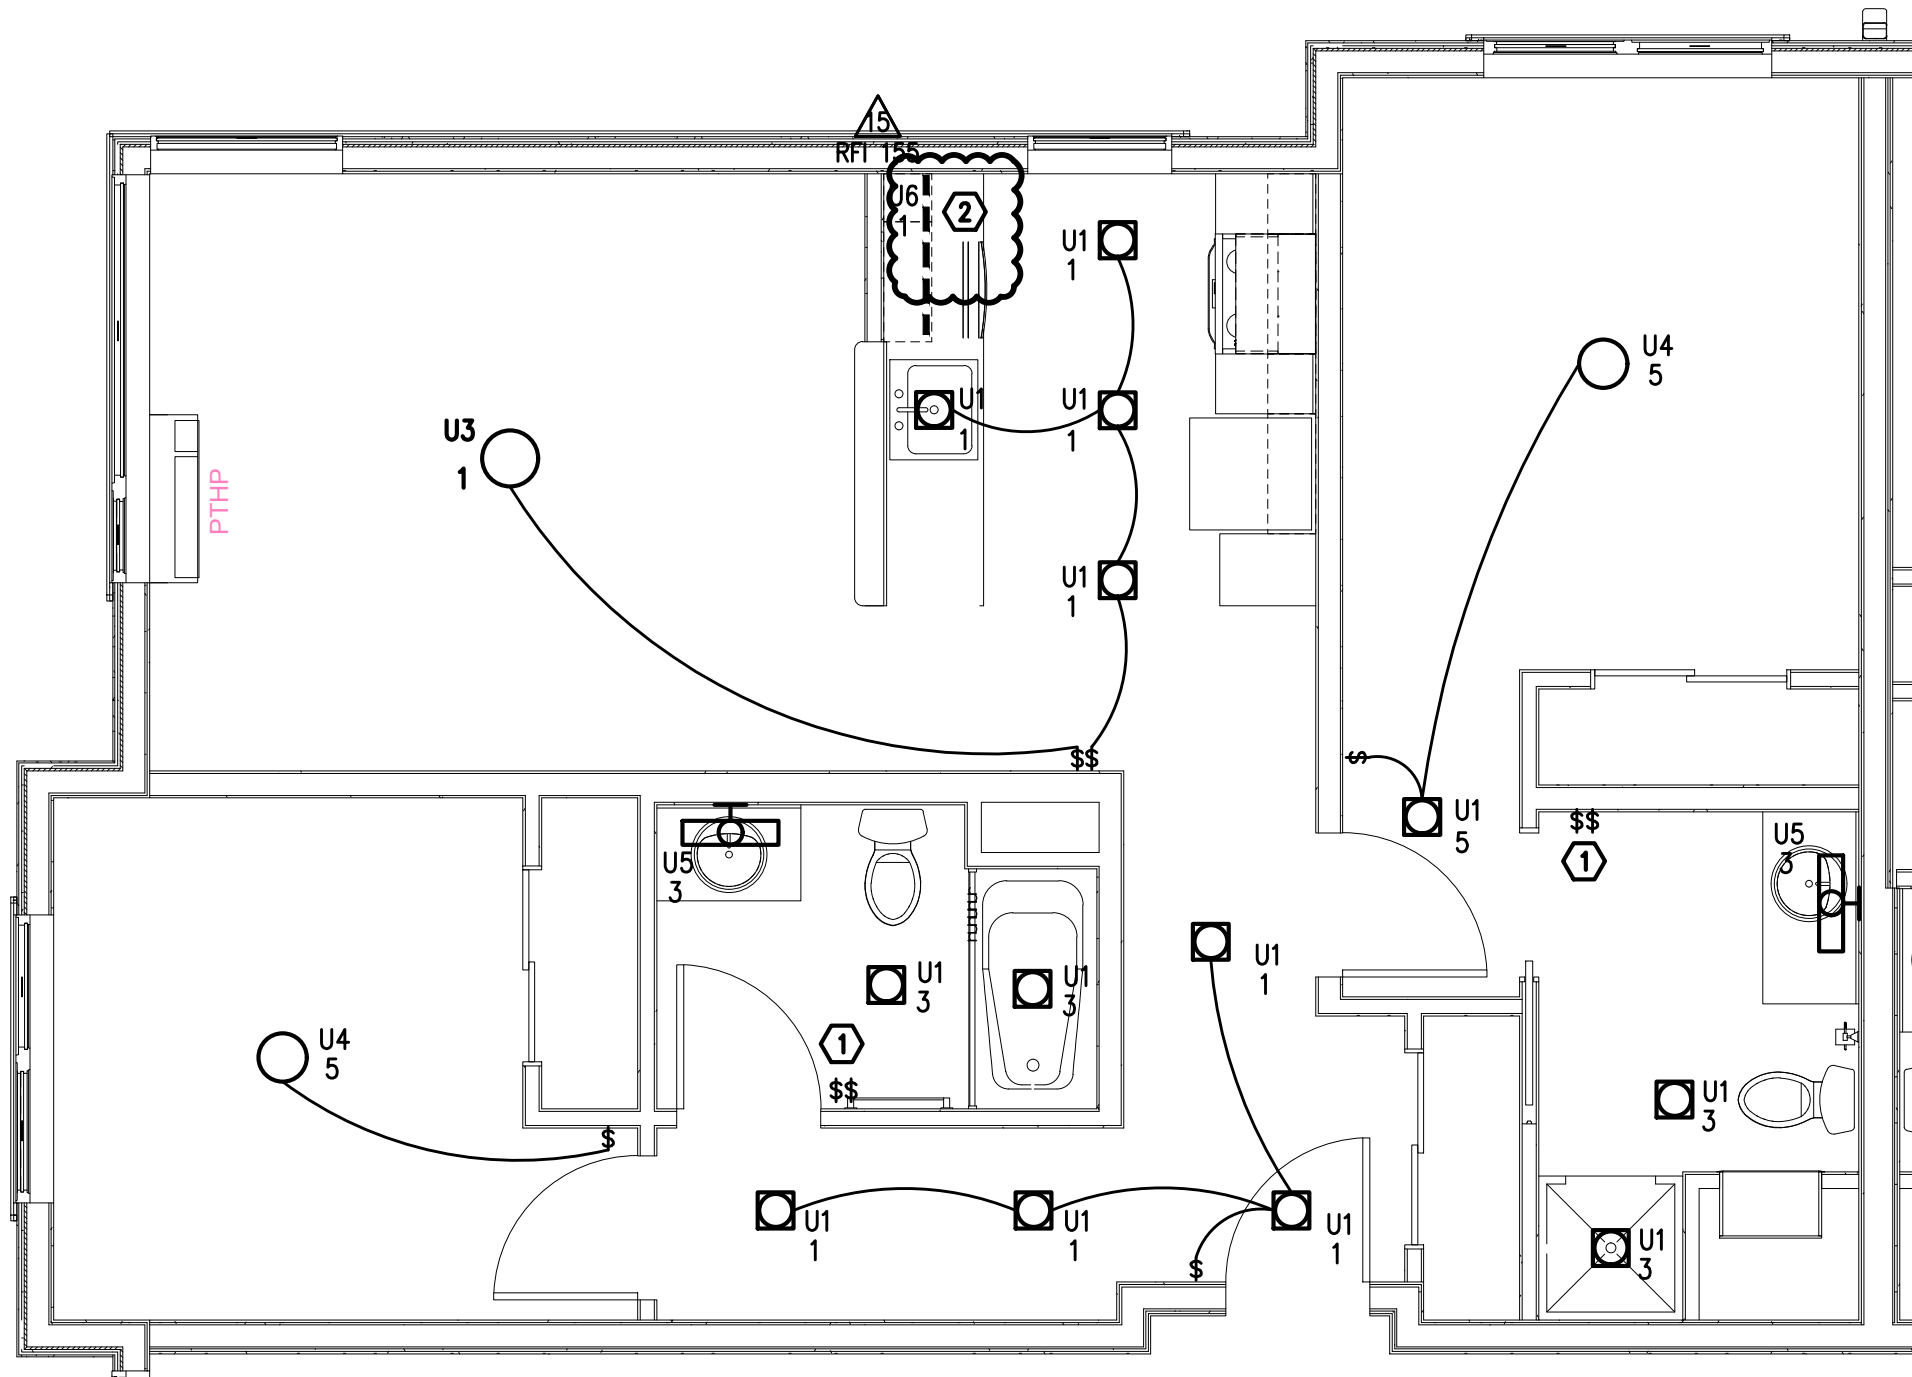


1 TYPICAL UNIT TYPE 2A - LIGHTING PLAN
E4.04 SCALE: 1/4" = 1'-0"
(FLOORS 2-6)

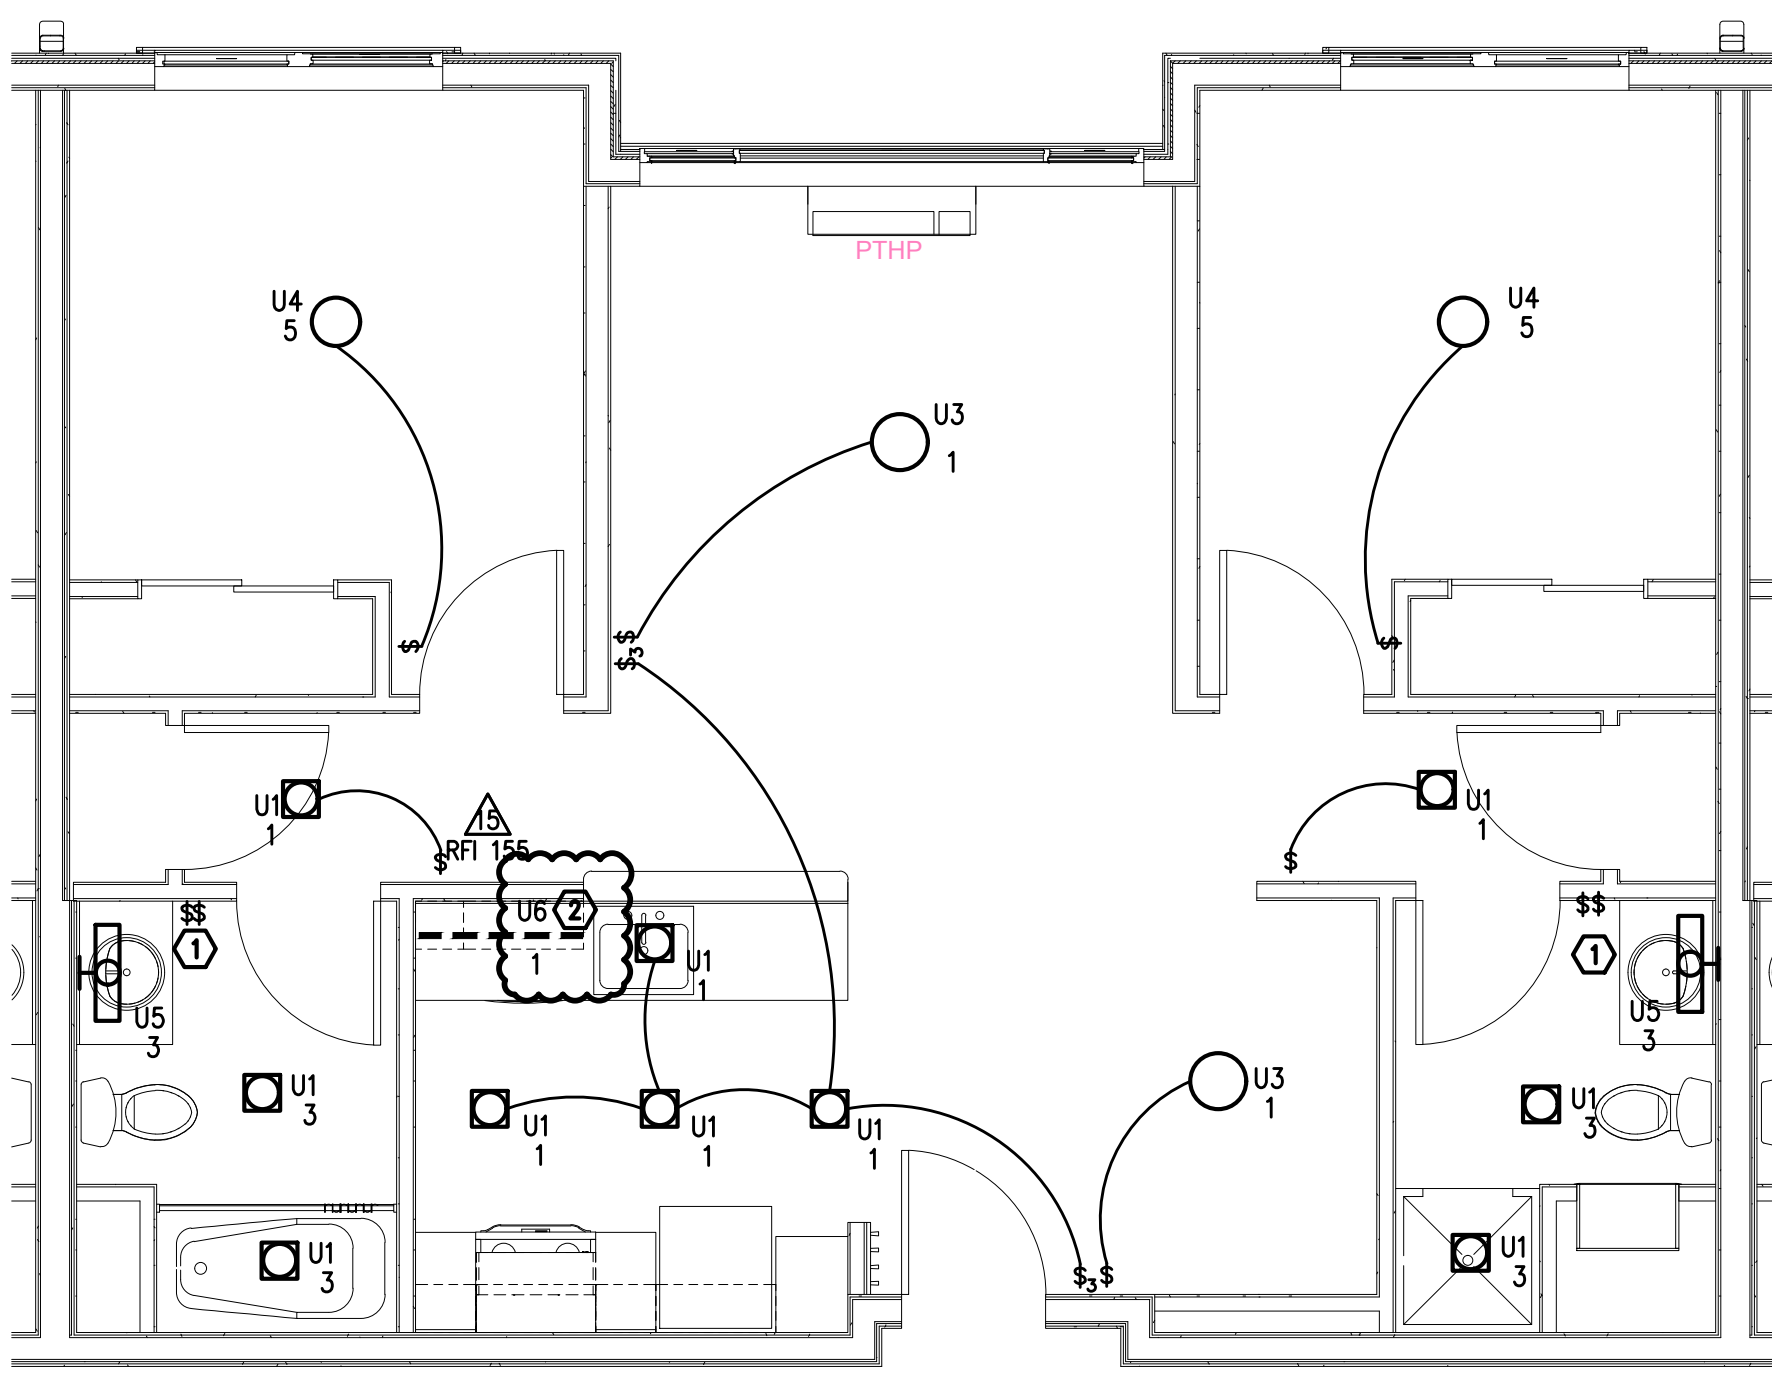

2 TYPICAL UNIT TYPE 2B - LIGHTING PLAN
E4.04 SCALE: 1/4" = 1'-0"
(FLOORS 2-6)

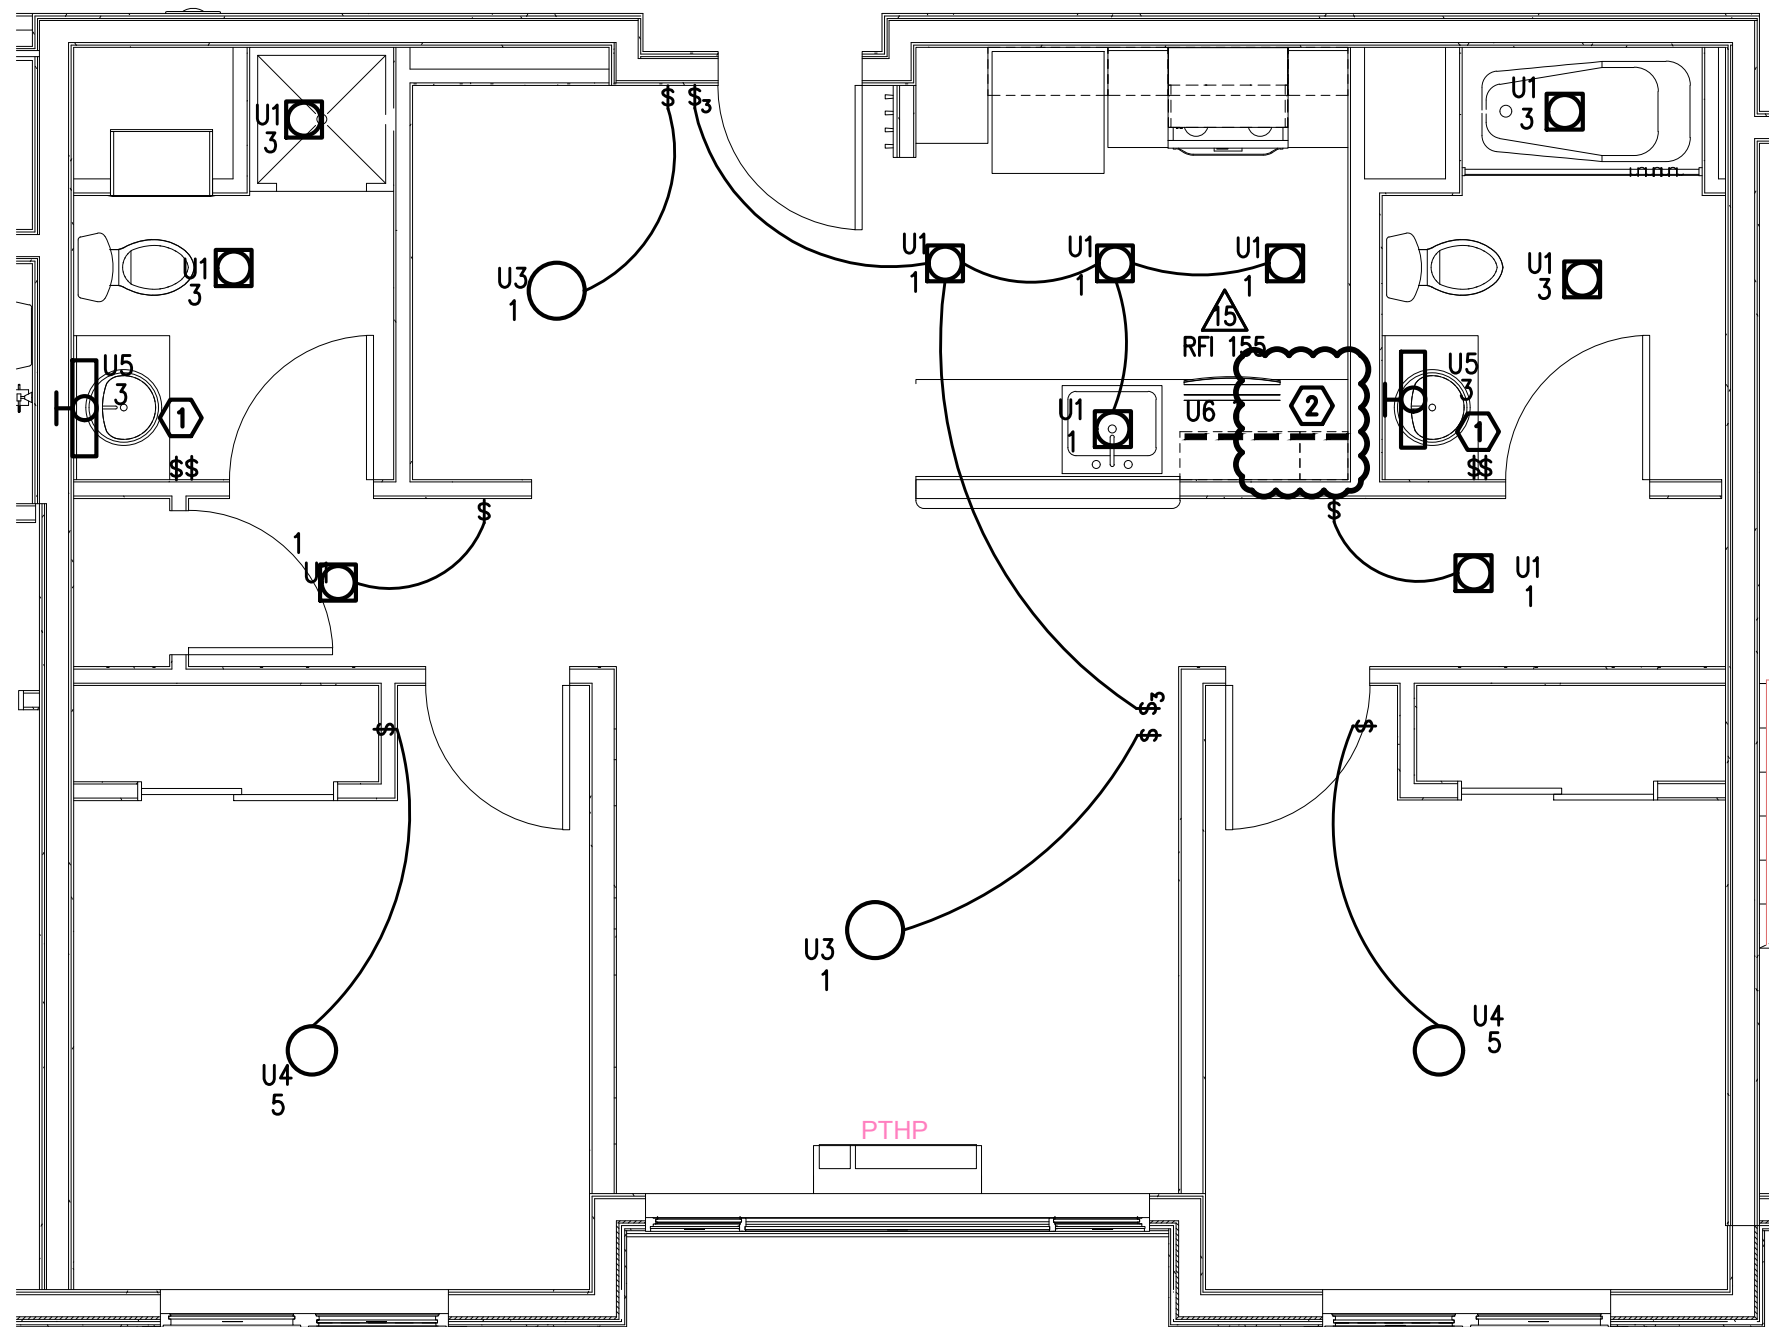

3 TYPICAL UNIT TYPE 2C - LIGHTING PLAN
E4.14 SCALE: 1/4" = 1'-0"
(FLOORS 2-6)

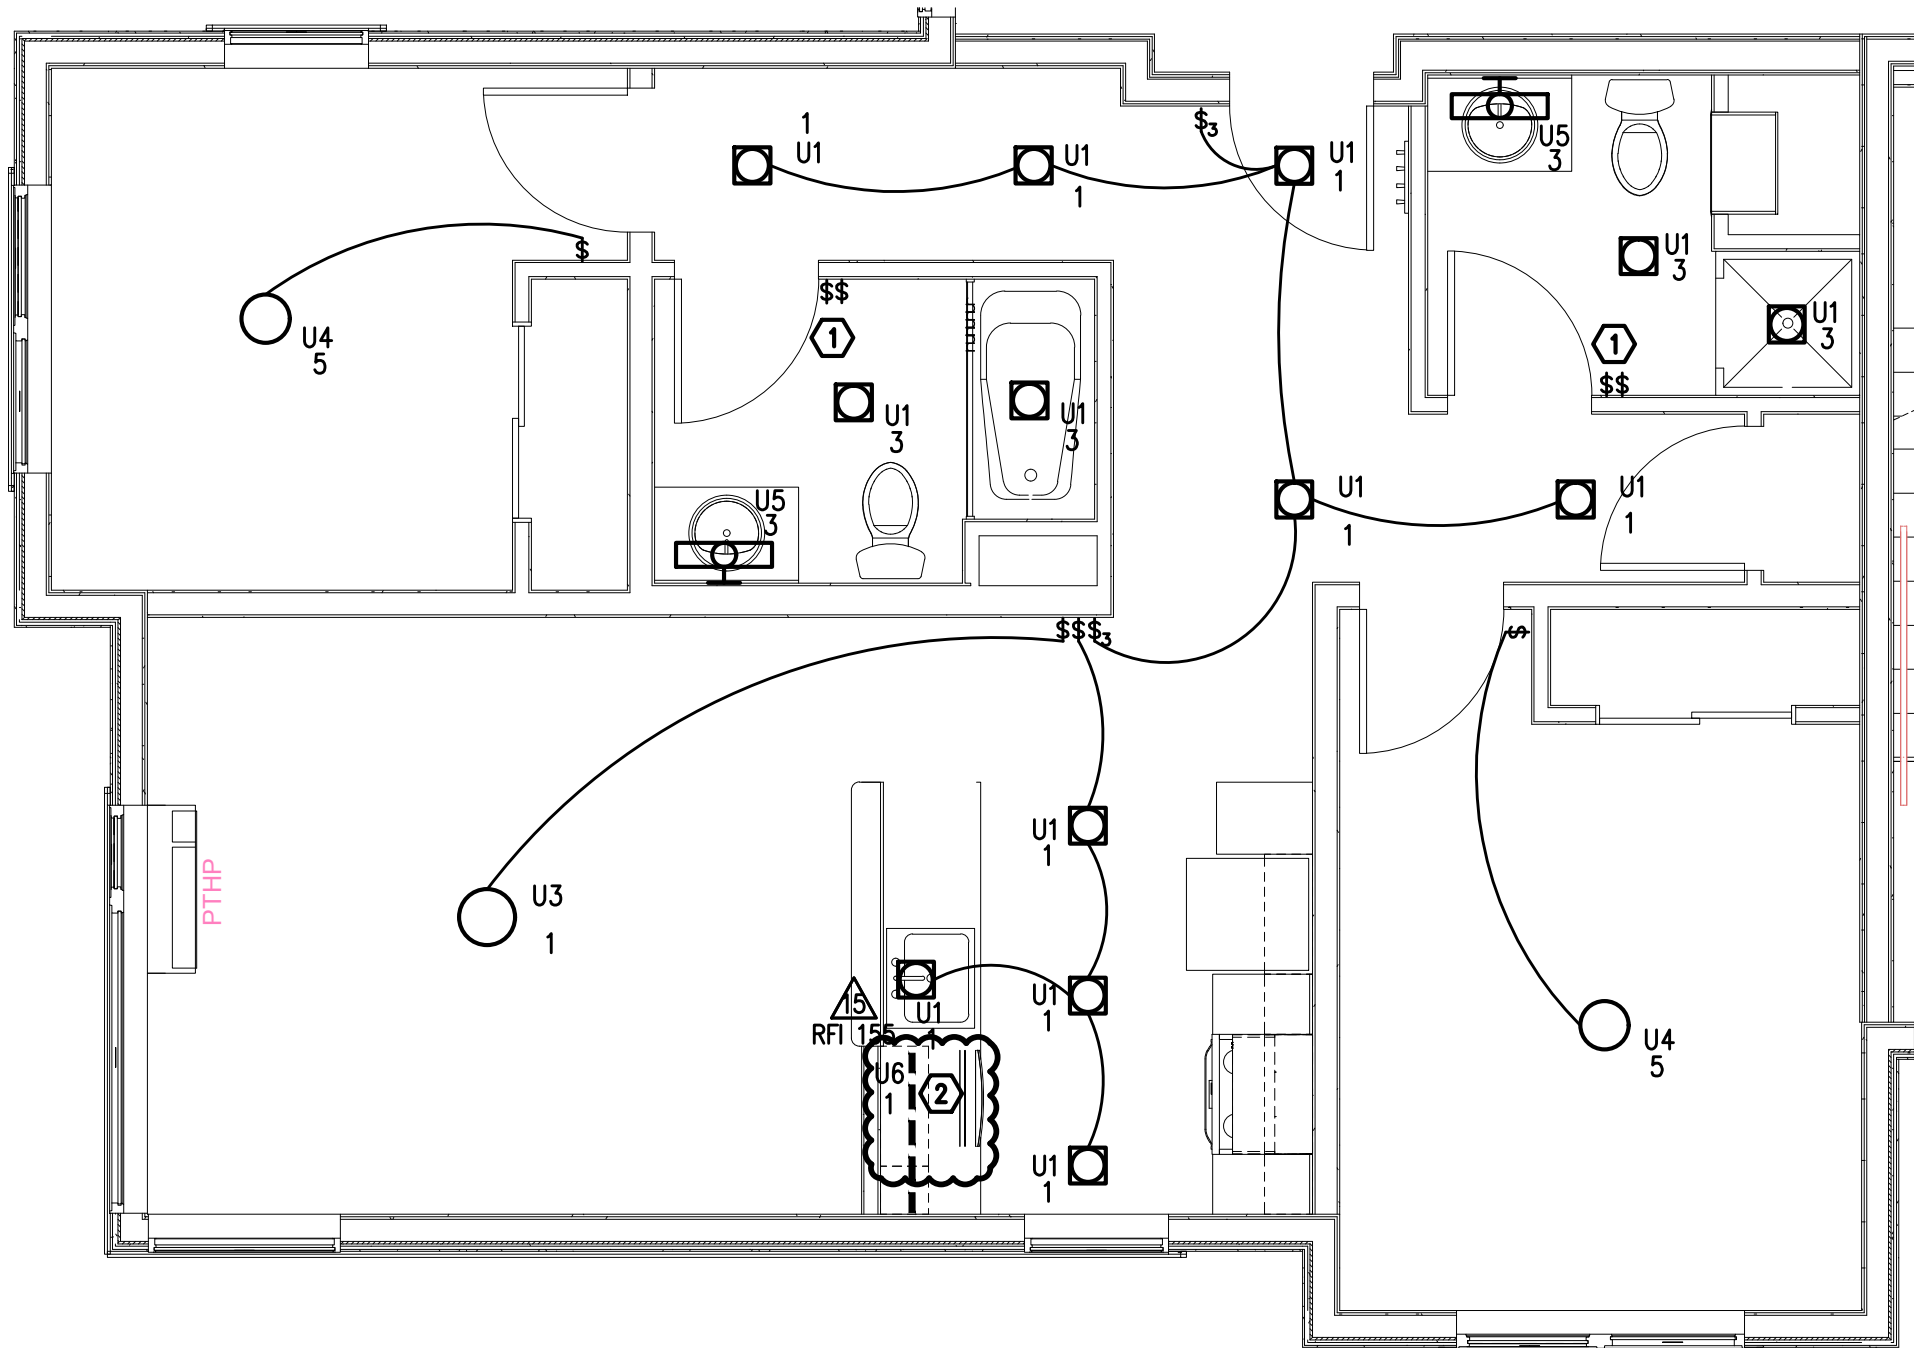

4 TYPICAL UNIT TYPE 2D - LIGHTING PLAN
E4.04 SCALE: 1/4" = 1'-0"
(FLOORS 2-6)

FULLER STATION HOUSING

PERMIT SET
DOCUMENTS

9608 SE Fuller Road
Clackamas County, Oregon, 97086



PERMIT SET

PROJECT #: 1617.00

SHEET ISSUE DATE: 01/31/2020

REVISIONS:

#	DESCRIPTION	DATE
1	COUNTY REVIEW RESPONSES	10.09.2020
2	ADDENDUM #1	10.09.2020
6	ASI #01	03.03.2021
	RFI 60	07.20.2021
	RFI 68	08.10.2021
	RFI 92	09.10.2021
	RFI 42	09.30.2021
15	ASI #10	11.05.2021
	RFI 148	11.18.2021
	RFI 150	11.18.2021
	RFI 154	11.18.2021
	RFI 155	11.18.2021
17	ASI #12	12.04.2021
	RFI 170	12.06.2021

ENLARGE UNIT
LIGHTING PLANS

E4.04