




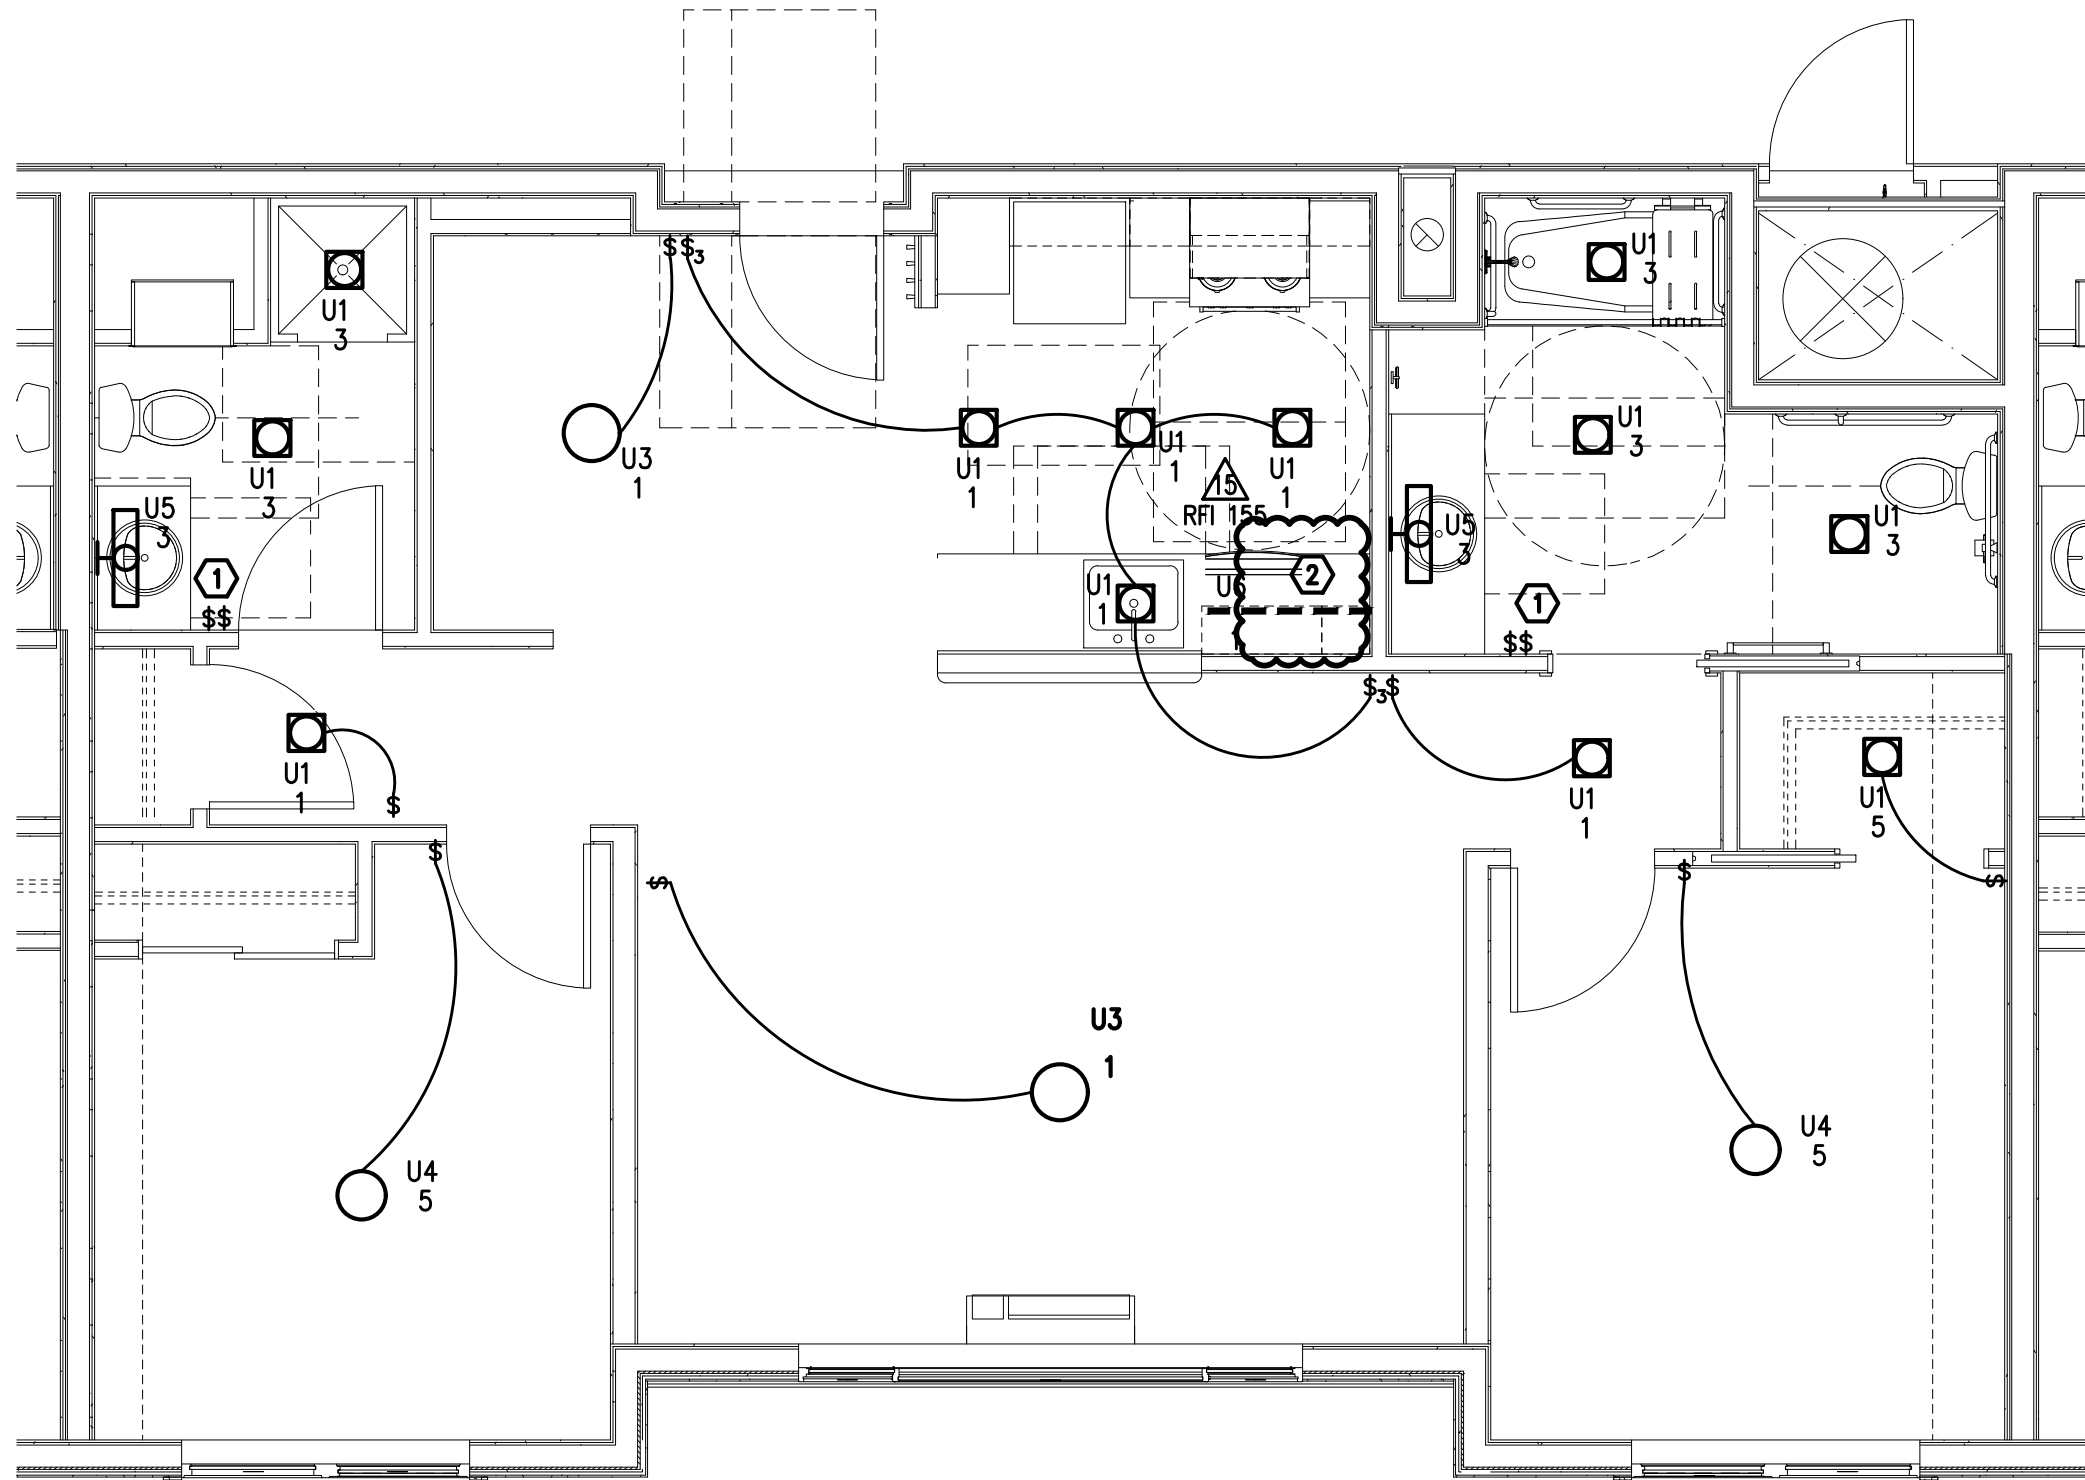

2 TYPICAL UNIT TYPE 2A/ADA - LIGHTING PLAN
SCALE: 1/4" = 1'-0"
(UNITS 411,511,611)

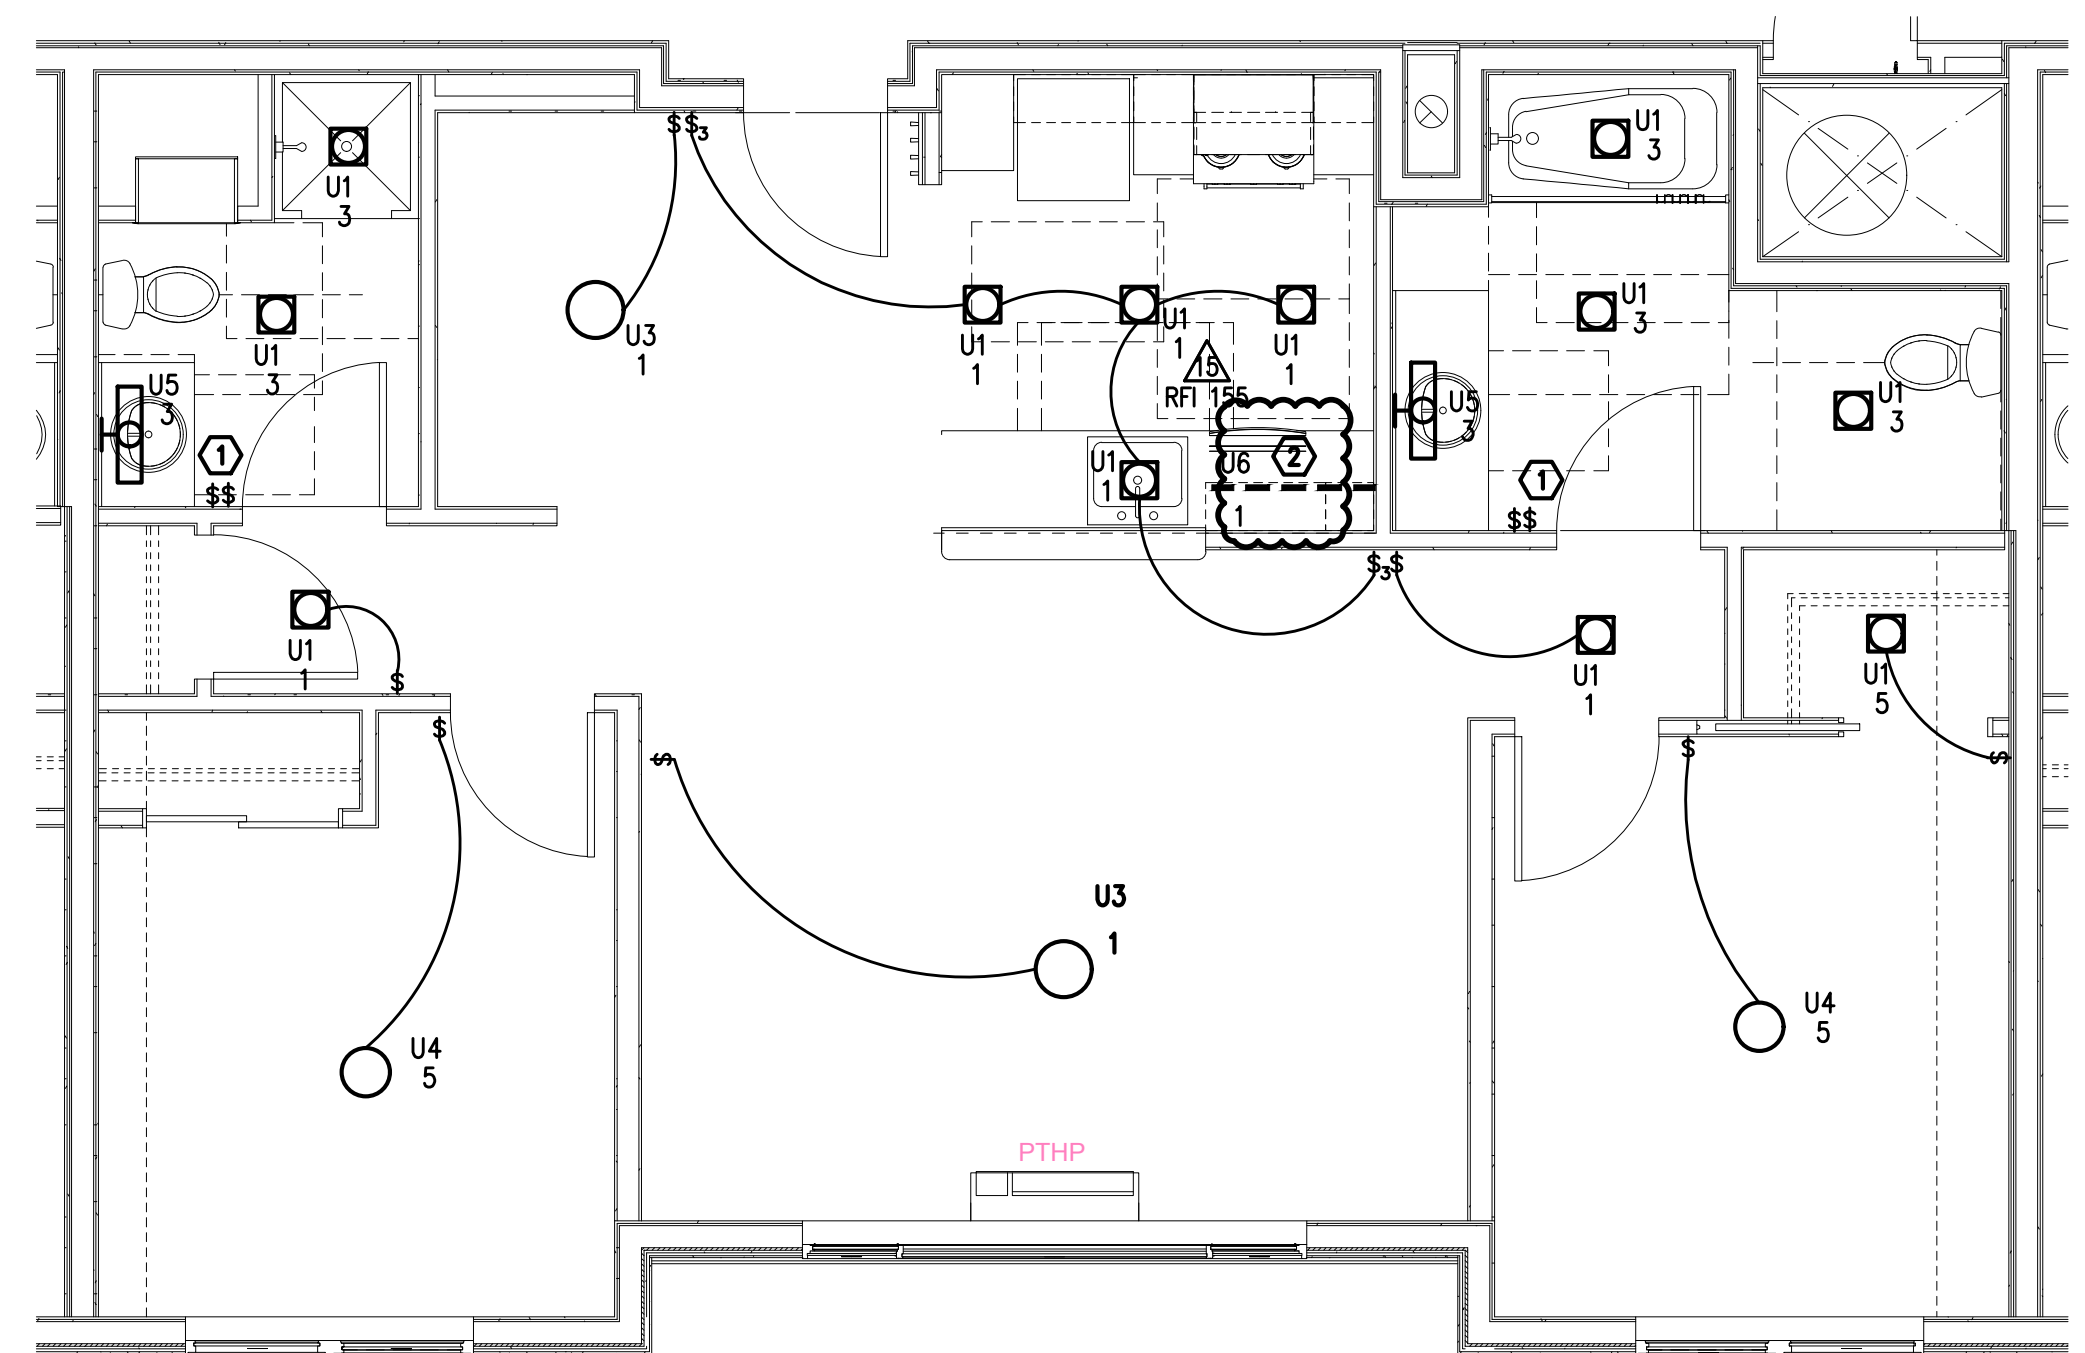

3 TYPICAL UNIT TYPE 2A - LIGHTING PLAN
SCALE: 1/4" = 1'-0"
(UNITS 211,311)

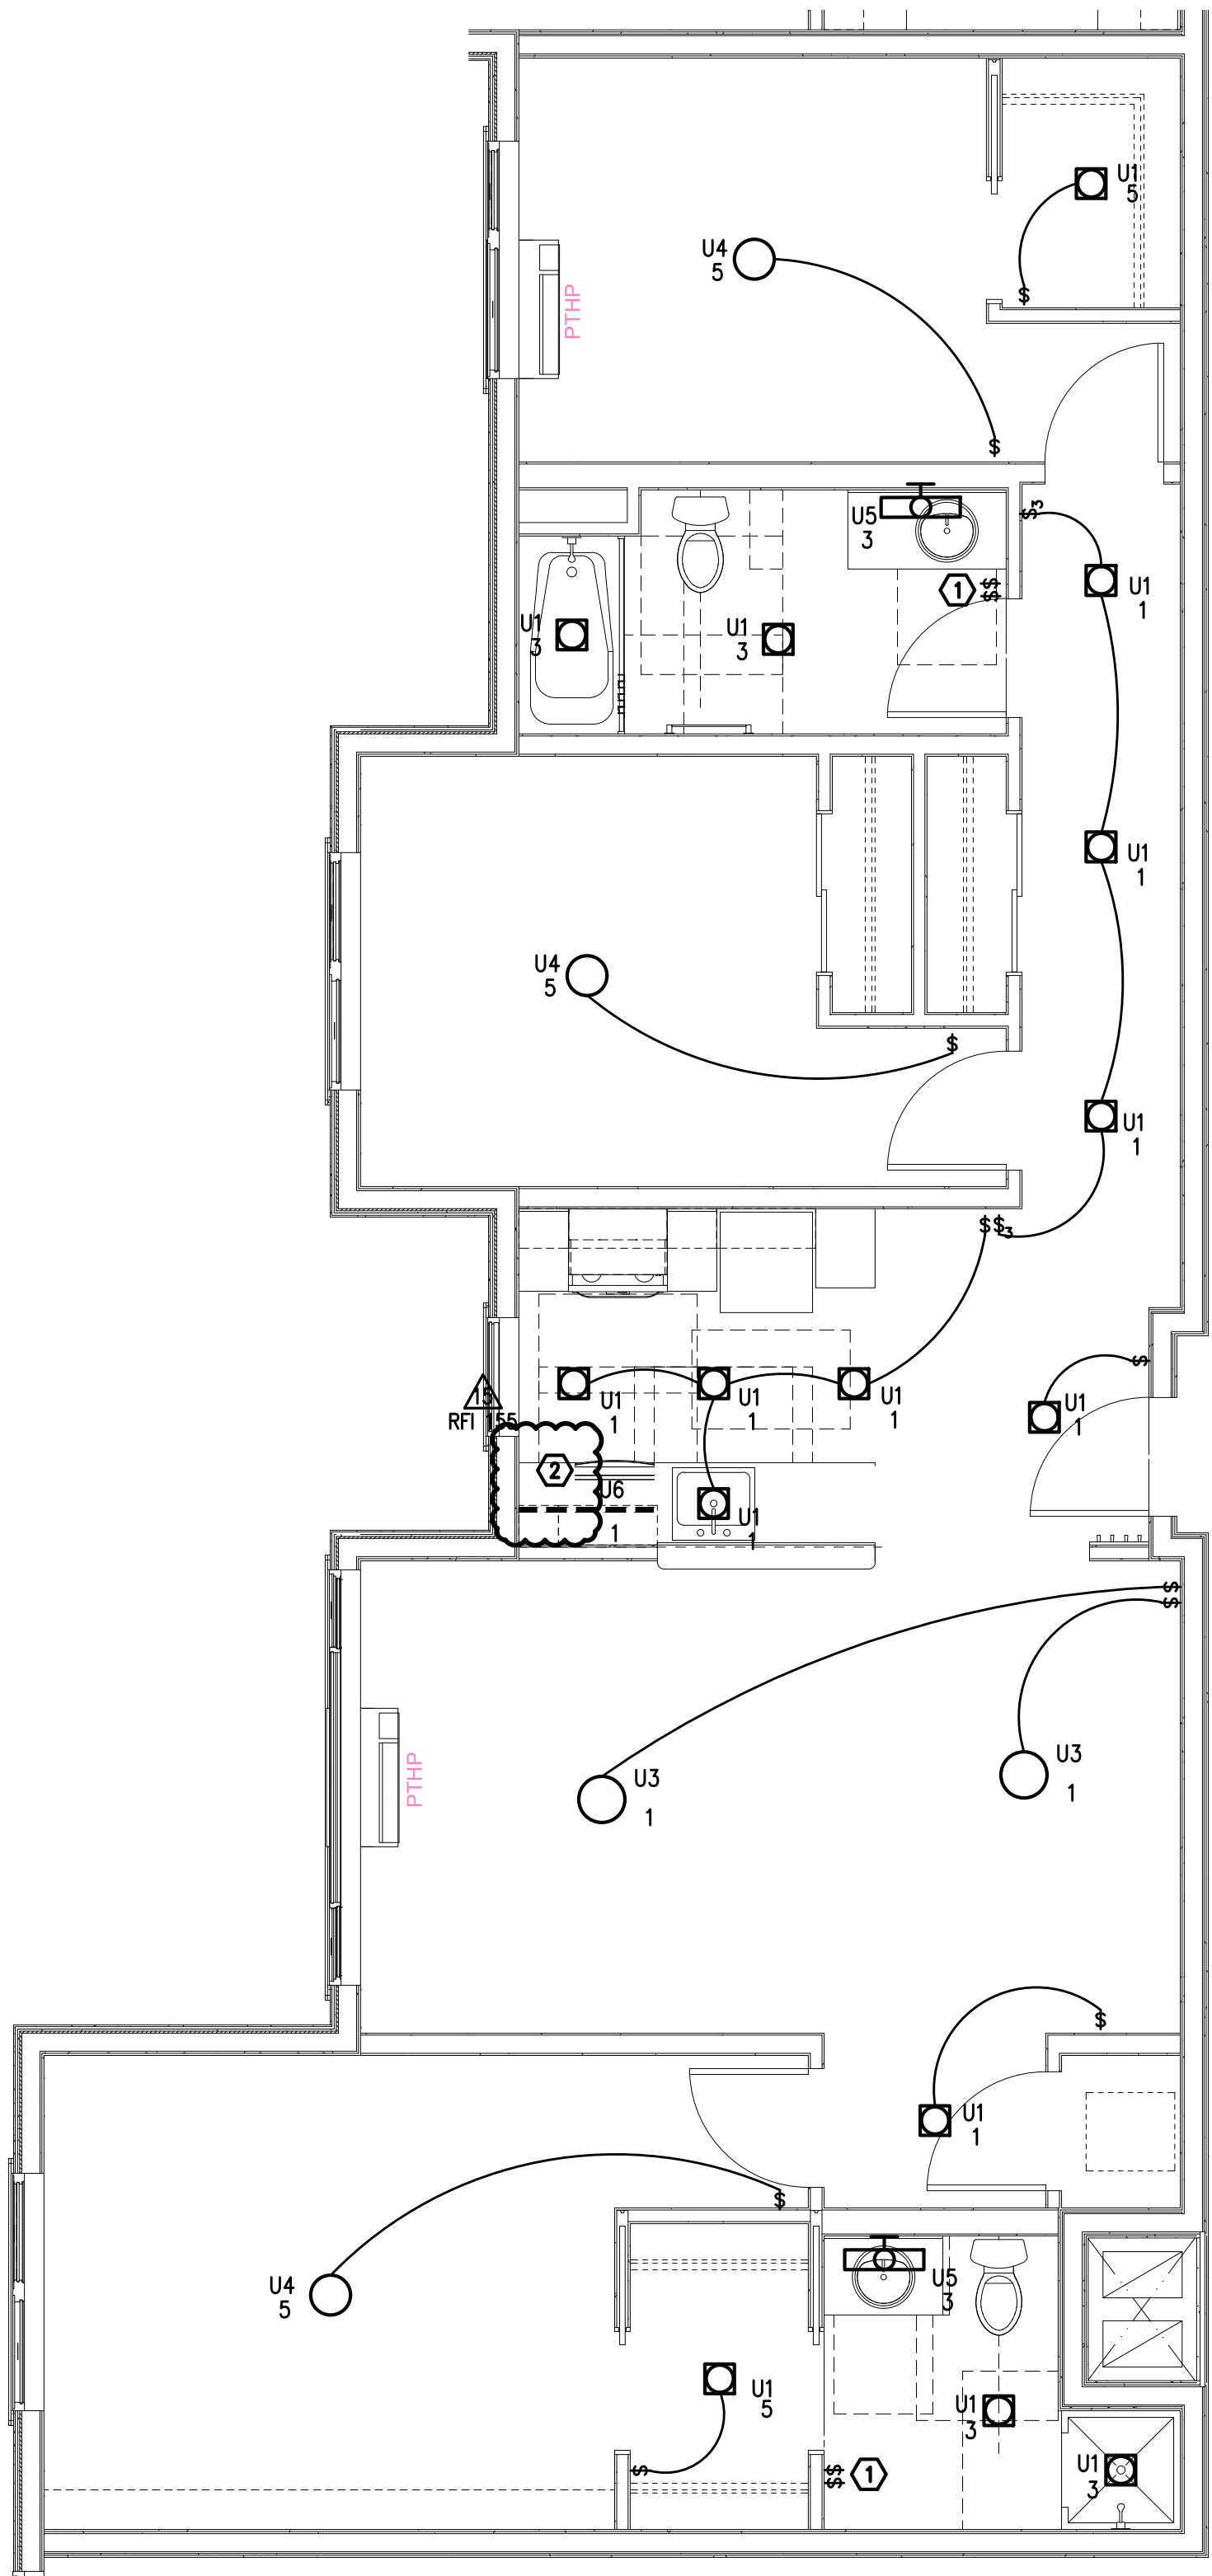

1 TYPICAL UNIT TYPE 3C - LIGHTING PLAN
SCALE: 1/4" = 1'-0"
(FLOORS 2-6)

GENERAL NOTES:

- ALL PLANS ARE DIAGRAMMATICAL. CONSULT ARCHITECTURAL PLANS FOR EXACT LOCATION OF ALL DEVICES AND FIXTURES.
- REFER TO SHEET E1.14 FOR TYPICAL UNIT LOAD CENTER DIRECTORIES.
- ALL LIGHT SWITCHES SHALL BE ROCKER STYLE, SUCH AS LEVITON DECORA, OR APPROVED EQUAL.
- REFER TO SHEETS E4.11 - E4.14 FOR TYPICAL UNIT POWER PLANS.

KEYED NOTES:

- REFER TO E1.22 FOR TYPICAL BATHROOM SWITCHING DIAGRAM.
- REFER TO E4.1 SERIES SHEETS FOR UNDER CABINET LIGHT SWITCH LOCATION.



waterleaf
419 SW 11th Ave
Suite 200
Portland OR 97205
Ph 503 228 7571
Fx 503 273 8891
Consulting Engineers
MHA INC.
P.O. Box 90214
Portland, OR 97214
PH: (503) 234-0548
FAX: (503) 234-0877
WWW.MHA-ENG.COM
CONTACT: DENISE TAYLOR

FULLER STATION HOUSING
PERMIT SET
DOCUMENTS
9608 SE Fuller Road
Clackamas County, Oregon, 97086



PERMIT SET

PROJECT #: 1617.00

SHEET ISSUE DATE: 01/31/2020

REVISIONS:

#	DESCRIPTION	DATE
1	COUNTY REVIEW RESPONSES	10.09.2020
2	ADDENDUM #1	10.09.2020
6	ASI #01	03.03.2021
	RFI 60	07.20.2021
	RFI 68	08.10.2021
	RFI 92	09.10.2021
	RFI 42	09.30.2021
15	ASI #10	11.05.2021
	RFI 148	11.18.2021
	RFI 150	11.18.2021
	RFI 154	11.18.2021
	RFI 155	11.18.2021
17	ASI #12	12.06.2021
	RFI 170	12.06.2021

ENLARGE UNIT
LIGHTING PLANS

E4.06